


EXISTING SITE PLAN
PROPERTY NORTH & EAST OF DIAGONAL IS OWNED BY UPR R28H

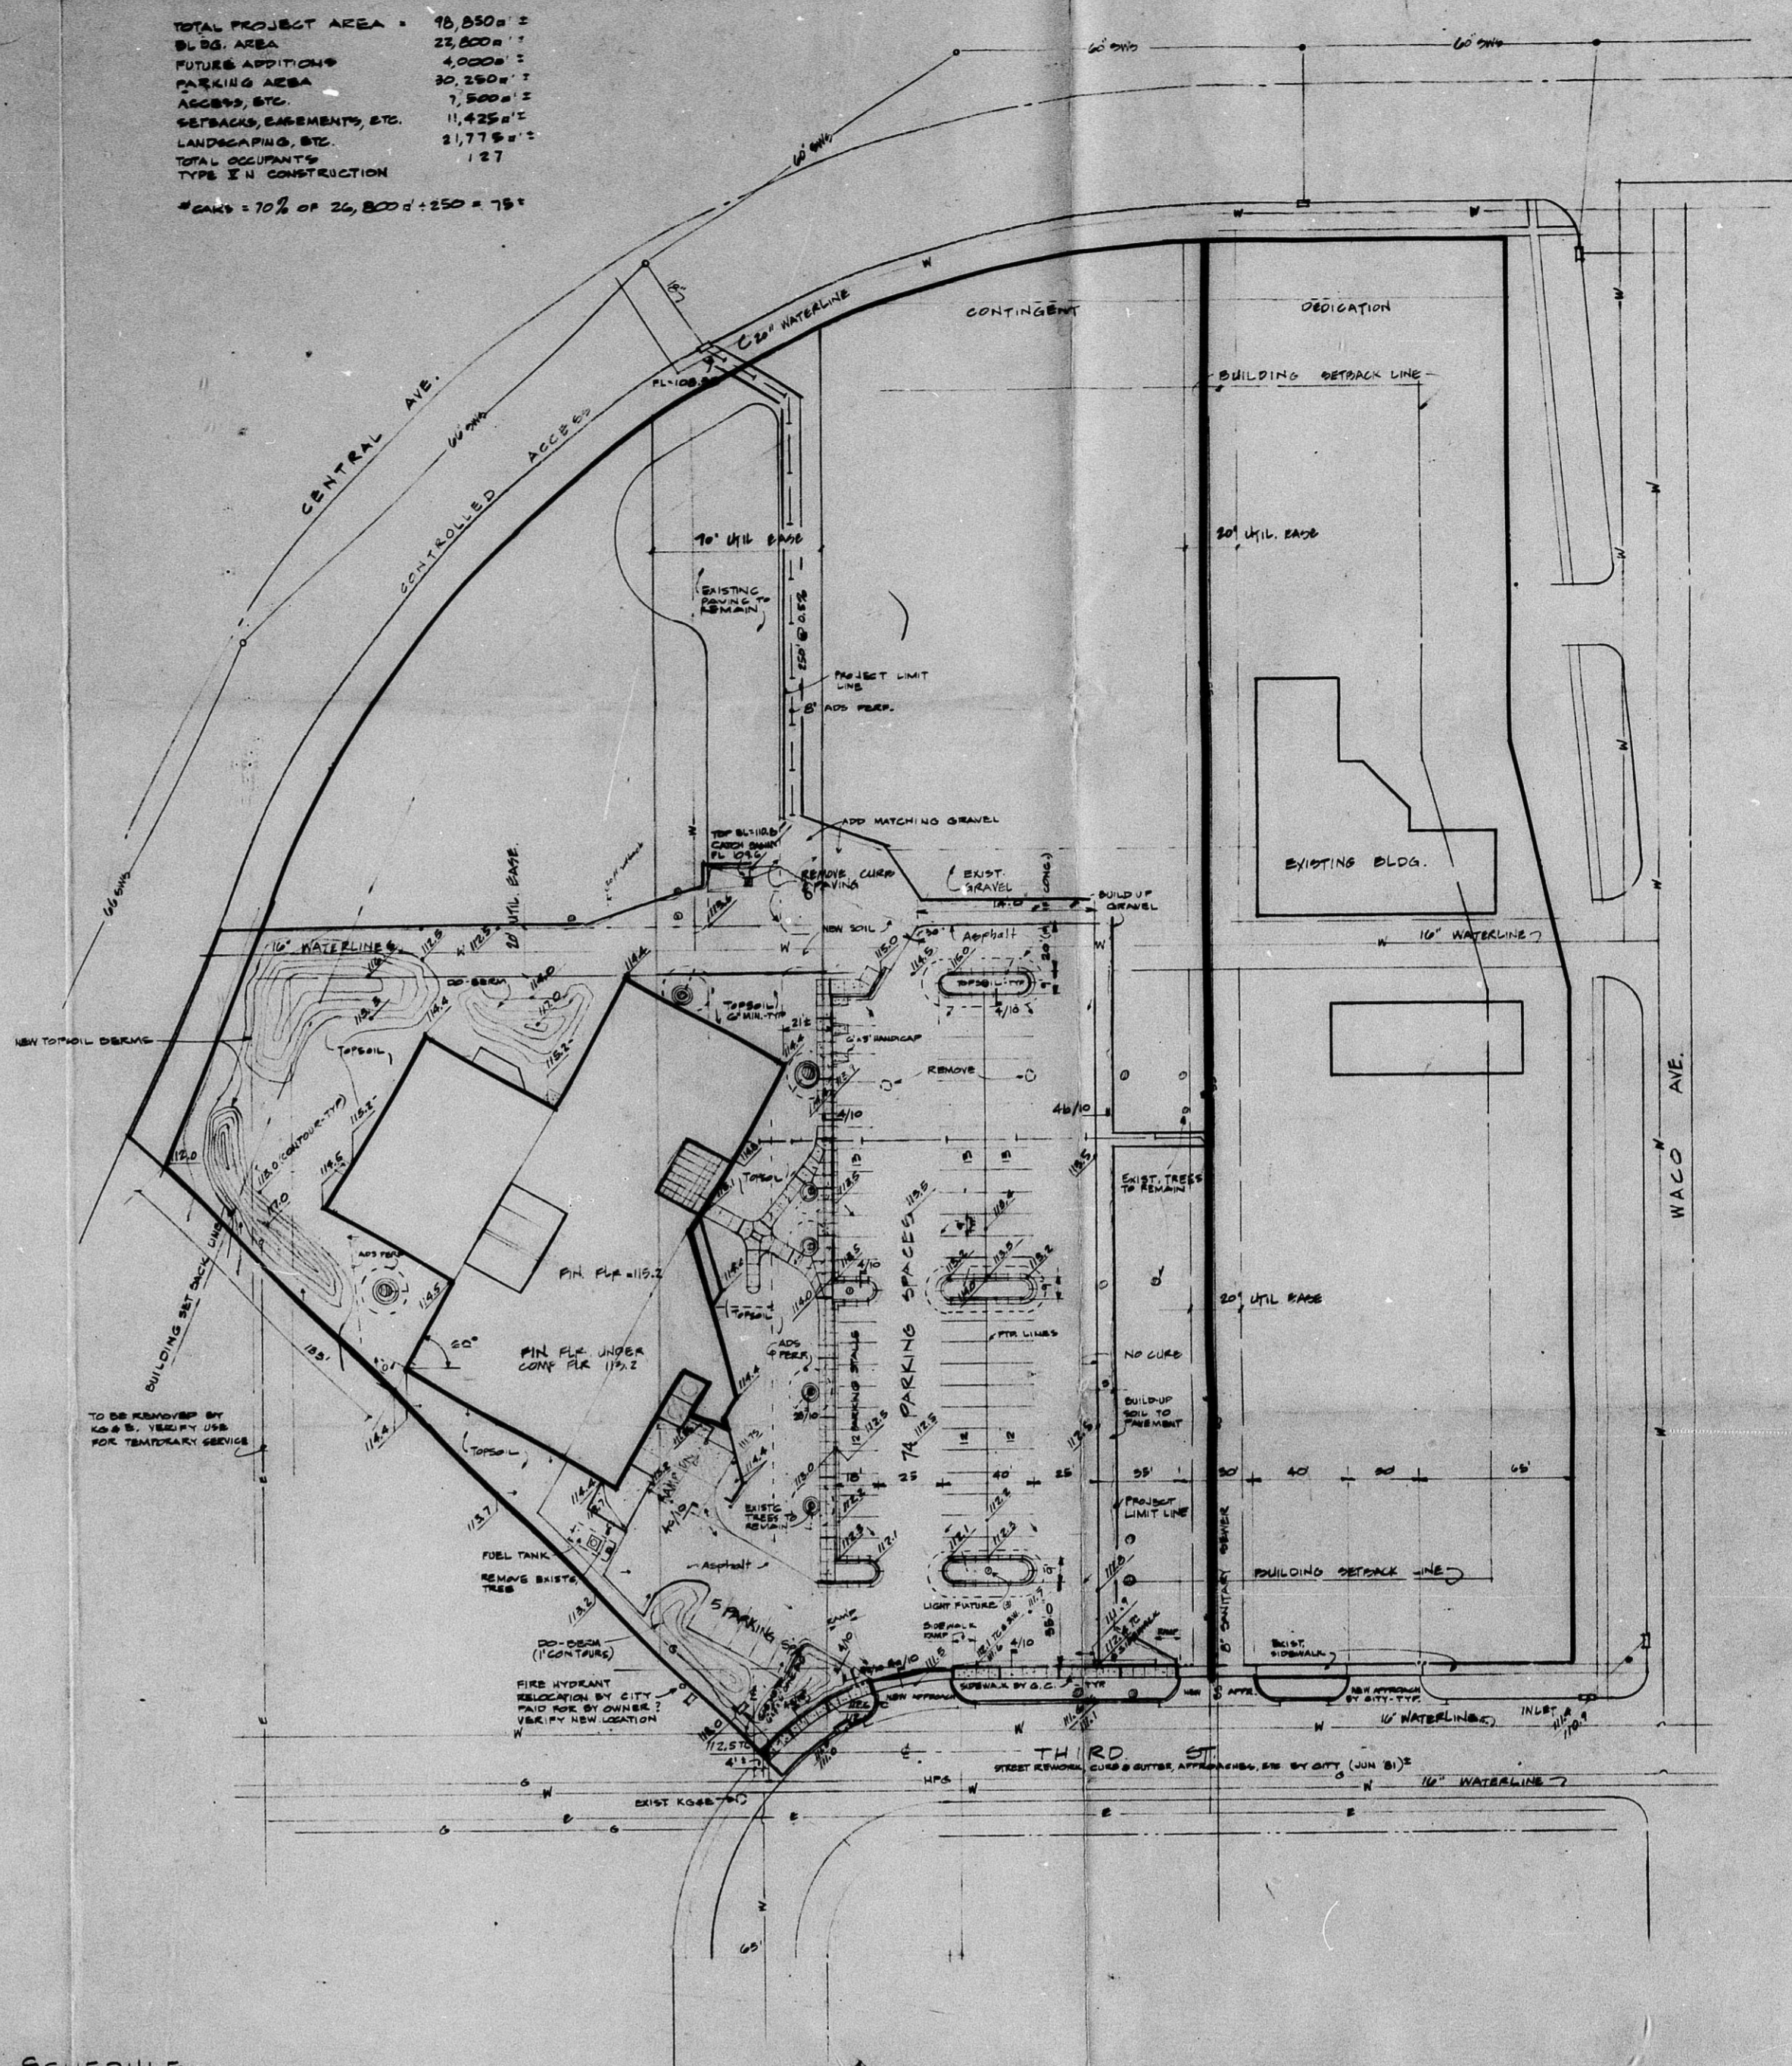

NEW SITE PLAN 1" = 40'-0"

GRADES TO FALL UNIFORMLY & RADIALLY FROM 115.0 HIGH POINT (N 80 PARKING) SHIPING TREE LOCATIONS TO BE VERIFIED FROM AS-BUILT PER OPERATIONS. BEEM LOCATIONS & SHAPES ARE APPROXIMATE.

SOIL LOG

DEPTH (ft)	1	2	3	4	5	6	7
10.0	FILL	TOPSOIL	TOPSOIL	TOPSOIL	TOPSOIL	TOPSOIL	TOPSOIL
11.0		DARK BROWN SILTY CLAY	DARK BROWN SILTY CLAY	DARK BROWN SILTY CLAY	DARK BROWN SILTY CLAY	DARK BROWN SILTY CLAY	DARK BROWN SILTY CLAY
12.0							
13.0							
14.0							
15.0							
16.0							
17.0							
18.0							
19.0							
20.0							
21.0							
22.0							
23.0							
24.0							
25.0							
26.0							
27.0							
28.0							
29.0							
30.0							

NOTE: SOIL BORER REPORT AVAILABLE AT ARCHITECTS OFFICE FOR MORE INFORMATION ON SITE SOILS & THE UNIFIED SOIL CLASSIFICATION SYSTEM.

SHEET SCHEDULES

ARCHITECTURAL

- NO. CONTENT
- 1 EXISTING/NEW SITE PLAN
- 1A PLAT-EMERSON ADDITION
- 1B GRADE PLANS-EMERSON ADDITION
- 2 FLOOR PLAN
- 3 ROOM FINISH SCHEDULES/WALL CONDITIONS
- 4 DOOR SCHEDULES/DOOR DETAILS
- 5 ELEVATIONS
- 6 1/2" BUILDING SECTIONS
- 7 3/4" WALL SECTIONS
- 8 3/4" BUILDING SECTIONS (POST/BEAM/COILING/DIMER)
- 9 3/4" BUILDING SECTIONS (LOBBY/SUPPER GLAZING)
- 10 ROOF PLAN/EXTERIOR SITE DETAILS
- 11 INTERIOR ROOM ELEVATIONS
- 12 LOBBY MILLWORK/PA PARTITIONS
- 13 WDN. DETAIL/MASONRY DETAILS
- 14 REFLECTED CEILING PLAN
- 15 LANDSCAPE PLAN
- 16 LUNN IRRIGATION PLAN

STRUCTURAL

- S-1 FOUNDATION PLAN S-3 DETAILS
- S-2 ROOF FRAMING PLAN

MECHANICAL

- M-1 SITE PLAN
- M-2 MECH. PLAN
- M-3 MECH. PLAN
- M-4 MECH. PLAN
- M-5 MECH. PLAN
- M-6 MECH. PLAN
- M-7 MECH. PLAN
- M-8 MECH. PLAN
- M-9 MECH. PLAN
- M-10 MECH. PLAN
- M-11 MECH. PLAN
- M-12 MECH. PLAN
- M-13 MECH. PLAN
- M-14 MECH. PLAN
- M-15 MECH. PLAN
- M-16 MECH. PLAN
- M-17 MECH. PLAN
- M-18 MECH. PLAN
- M-19 MECH. PLAN
- M-20 MECH. PLAN
- M-21 MECH. PLAN
- M-22 MECH. PLAN
- M-23 MECH. PLAN
- M-24 MECH. PLAN
- M-25 MECH. PLAN
- M-26 MECH. PLAN
- M-27 MECH. PLAN
- M-28 MECH. PLAN
- M-29 MECH. PLAN
- M-30 MECH. PLAN
- M-31 MECH. PLAN
- M-32 MECH. PLAN
- M-33 MECH. PLAN
- M-34 MECH. PLAN
- M-35 MECH. PLAN
- M-36 MECH. PLAN
- M-37 MECH. PLAN
- M-38 MECH. PLAN
- M-39 MECH. PLAN
- M-40 MECH. PLAN
- M-41 MECH. PLAN
- M-42 MECH. PLAN
- M-43 MECH. PLAN
- M-44 MECH. PLAN
- M-45 MECH. PLAN
- M-46 MECH. PLAN
- M-47 MECH. PLAN
- M-48 MECH. PLAN
- M-49 MECH. PLAN
- M-50 MECH. PLAN

ELECTRICAL

- E-1 ELECTRICAL PLAN
- E-2 ELECTRICAL PLAN
- E-3 ELECTRICAL PLAN
- E-4 ELECTRICAL PLAN
- E-5 ELECTRICAL PLAN
- E-6 ELECTRICAL PLAN
- E-7 ELECTRICAL PLAN
- E-8 ELECTRICAL PLAN
- E-9 ELECTRICAL PLAN
- E-10 ELECTRICAL PLAN
- E-11 ELECTRICAL PLAN
- E-12 ELECTRICAL PLAN
- E-13 ELECTRICAL PLAN
- E-14 ELECTRICAL PLAN
- E-15 ELECTRICAL PLAN
- E-16 ELECTRICAL PLAN
- E-17 ELECTRICAL PLAN
- E-18 ELECTRICAL PLAN
- E-19 ELECTRICAL PLAN
- E-20 ELECTRICAL PLAN
- E-21 ELECTRICAL PLAN
- E-22 ELECTRICAL PLAN
- E-23 ELECTRICAL PLAN
- E-24 ELECTRICAL PLAN
- E-25 ELECTRICAL PLAN
- E-26 ELECTRICAL PLAN
- E-27 ELECTRICAL PLAN
- E-28 ELECTRICAL PLAN
- E-29 ELECTRICAL PLAN
- E-30 ELECTRICAL PLAN
- E-31 ELECTRICAL PLAN
- E-32 ELECTRICAL PLAN
- E-33 ELECTRICAL PLAN
- E-34 ELECTRICAL PLAN
- E-35 ELECTRICAL PLAN
- E-36 ELECTRICAL PLAN
- E-37 ELECTRICAL PLAN
- E-38 ELECTRICAL PLAN
- E-39 ELECTRICAL PLAN
- E-40 ELECTRICAL PLAN
- E-41 ELECTRICAL PLAN
- E-42 ELECTRICAL PLAN
- E-43 ELECTRICAL PLAN
- E-44 ELECTRICAL PLAN
- E-45 ELECTRICAL PLAN
- E-46 ELECTRICAL PLAN
- E-47 ELECTRICAL PLAN
- E-48 ELECTRICAL PLAN
- E-49 ELECTRICAL PLAN
- E-50 ELECTRICAL PLAN

LEGENDS

REFERENCING:

- 1 SECTION NO. - BUILDING SECTION
- 2 SHEET NO. - BUILDING SECTION
- 3 SECTION NO. - WALL SECTION
- 4 SHEET NO. - WALL SECTION
- 5 SECTION NO. - PARTIAL BLOC SECTION
- 6 SHEET NO. - PARTIAL BLOC SECTION
- 7 SECTION NO. - DOOR REFERENCE
- 8 WALL NUMBER - WALL REFERENCE
- 9 DETAIL NO. - DETAIL REFERENCE
- 10 SHEET NO. - DETAIL REFERENCE
- 11 ELEV. NO. - ELEVATION REFERENCE
- 12 SHEET NO. - ELEVATION REFERENCE
- 13 SECTION NO. - ROOF REFERENCE
- 14 SHEET NO. - ROOF REFERENCE

BLOG MATLS.

- CONC. MASS UNITS
- FACE BRICK
- PC-PASGAST
- CAST CONC.
- MTL STD. PARTITION
- GYP. DO.
- STEE.
- ALUMINUM
- ROOF INSL.
- BATT INSL.
- PLYWOOD
- ROUGH FRAMING

PARKS & PARKS ARCHITECTS PROCESS CENTER
101 N. CLIFTON WICHITA, KANSAS 67203
DATE: JOB NUMBER: REVISIONS: 02/21/81 81-1

DR 81-2

FILMED FROM THE BEST AVAILABLE COPY