
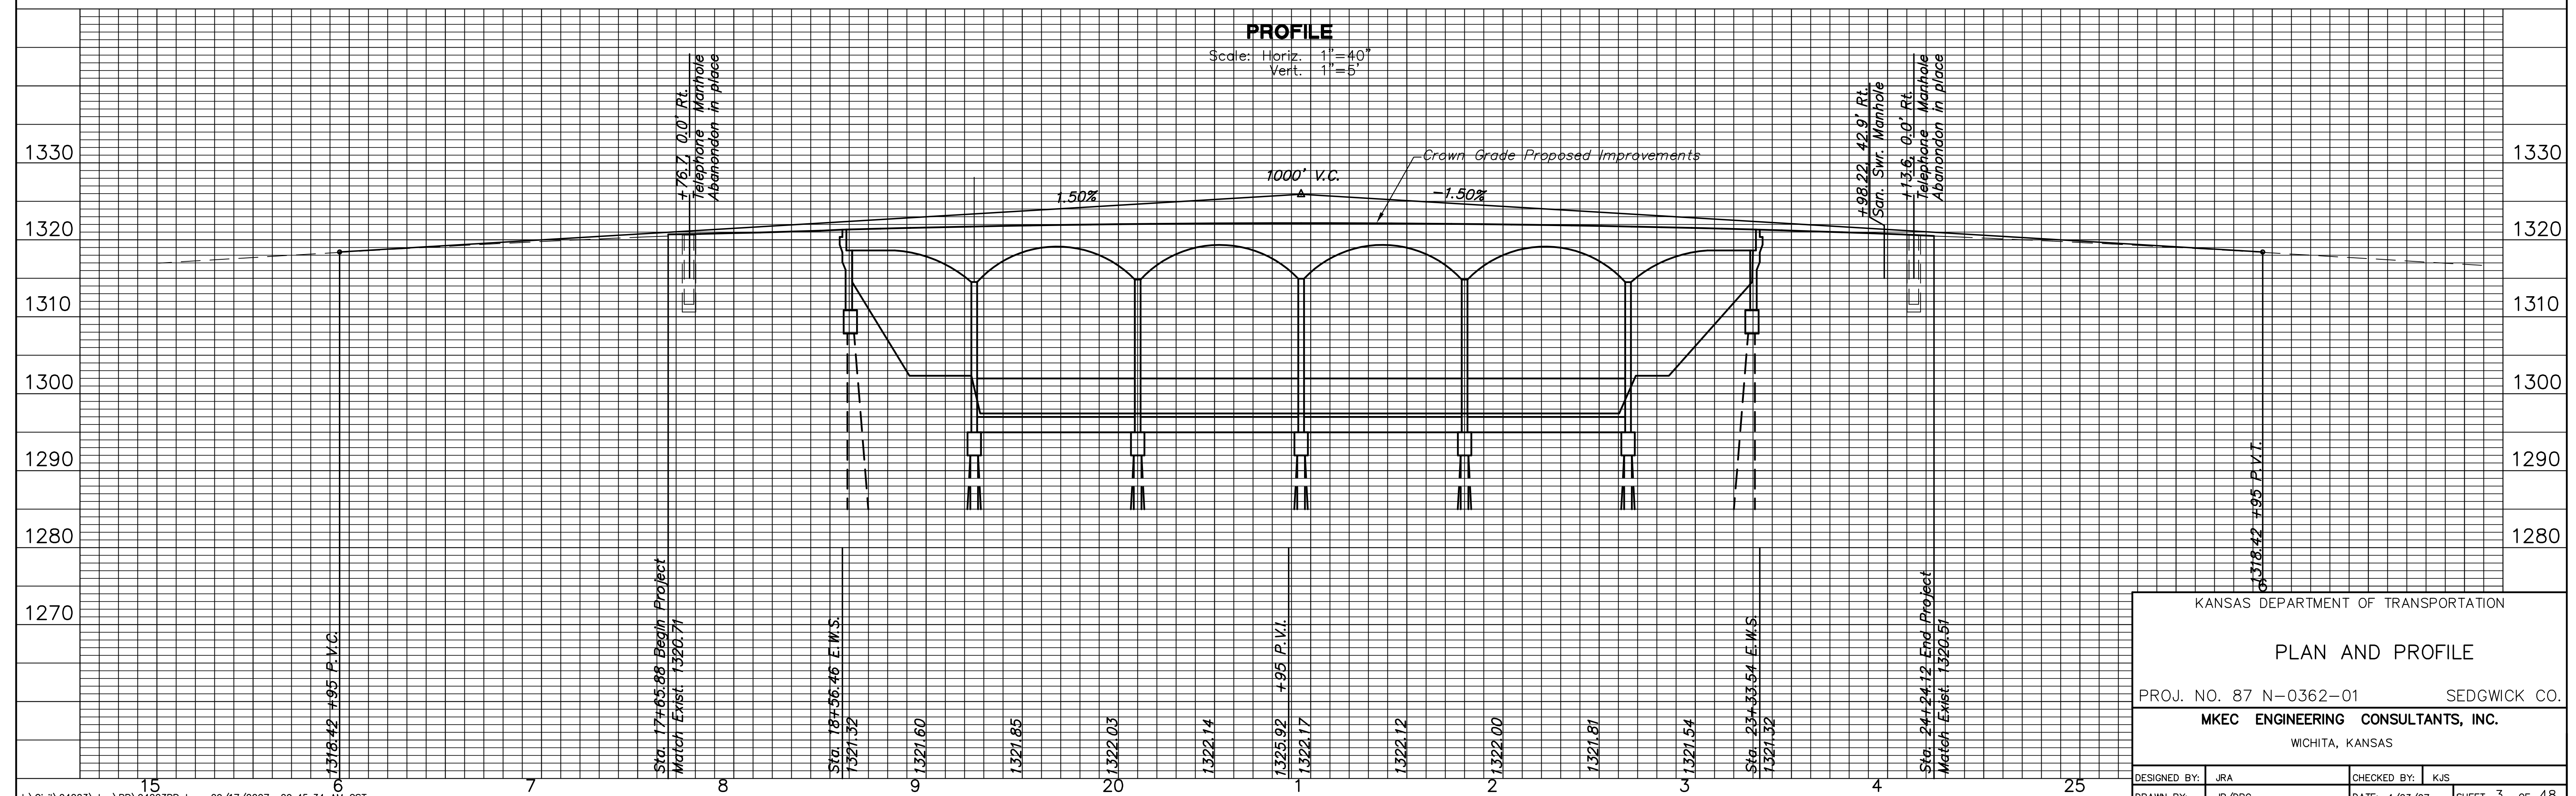


STATE	PROJECT NO.	YEAR	SHEET NO.	TOTAL SHEETS
KANSAS	87 N-0362-01	2007	3	48

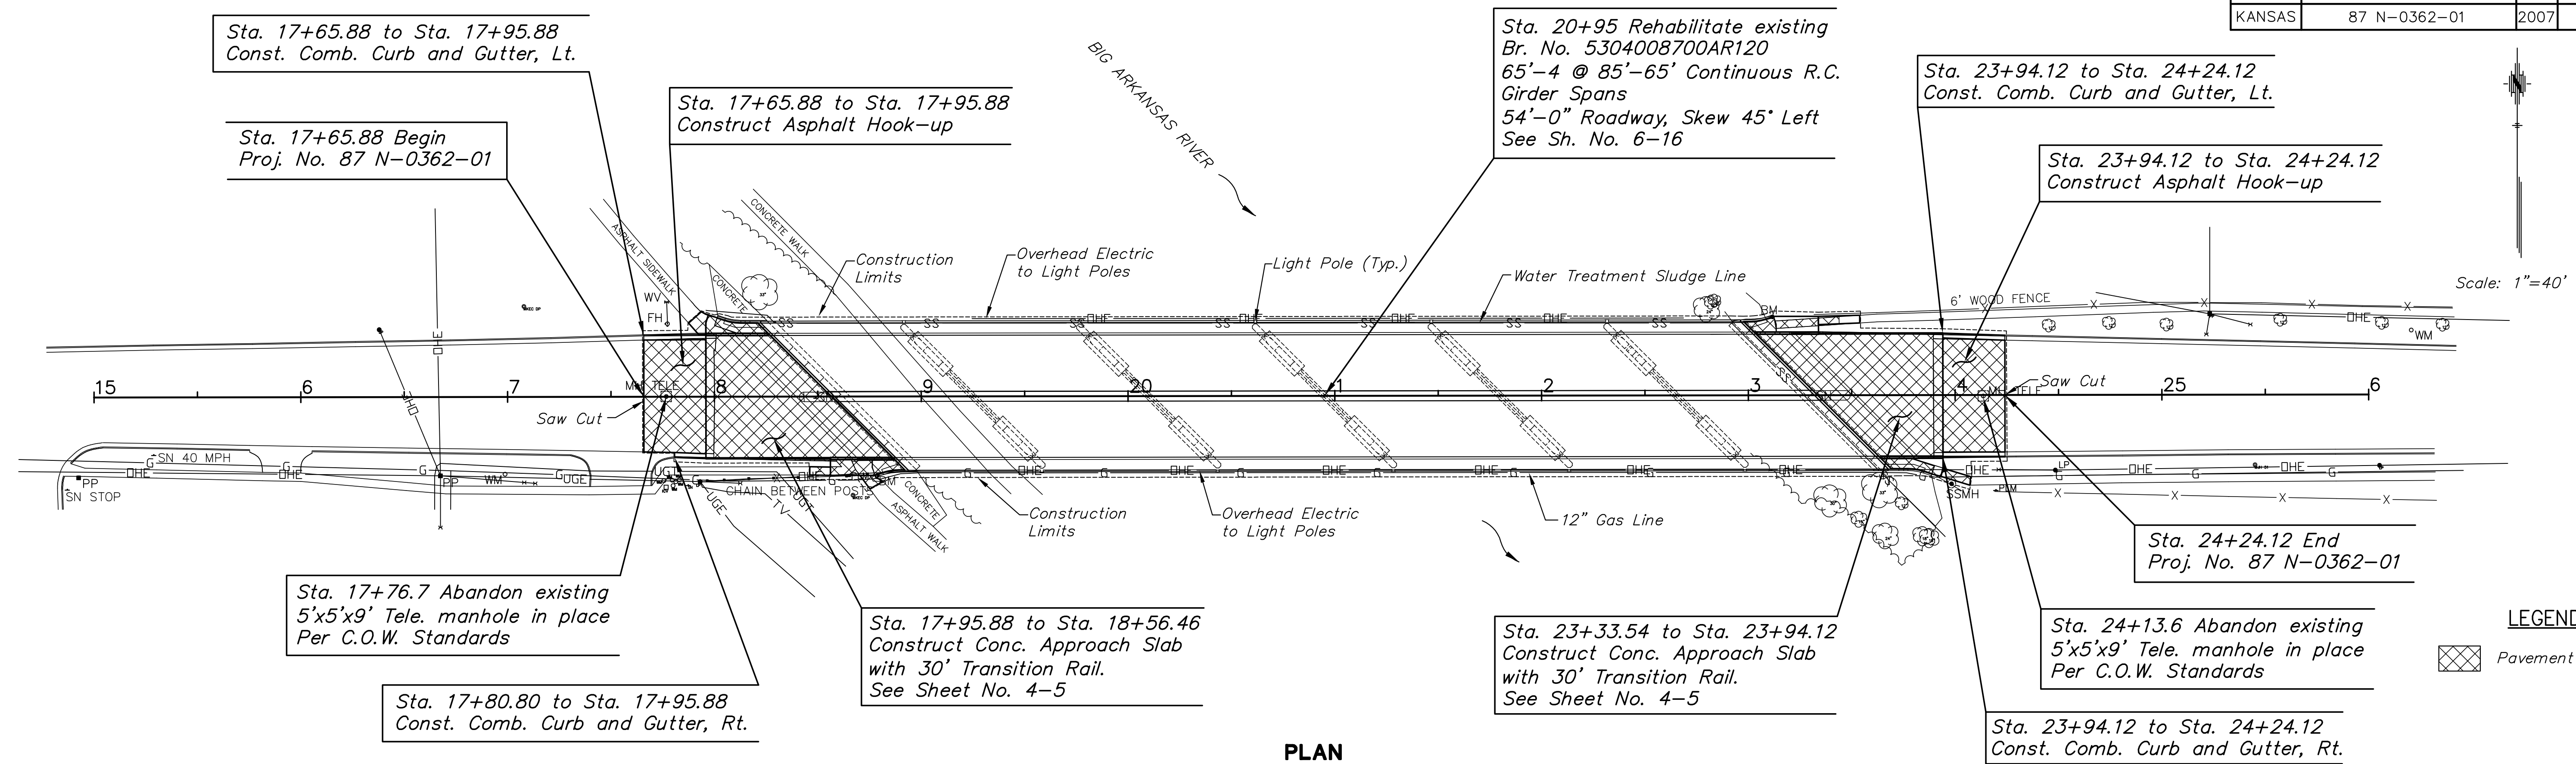

KANSAS DEPARTMENT OF TRANSPORTATION

**PLAN AND PROFILE**

PROJ. NO. 87 N-0362-01 SEDGWICK CO.

**MKEC ENGINEERING CONSULTANTS, INC.**  
 WICHITA, KANSAS

DESIGNED BY: JRA	CHECKED BY: KJS
DRAWN BY: JB/DPG	DATE: 4/23/07

SHEET 3 OF 48