




FCBN
 City Standard in West
 R/W Mon. of 1/2 Sec Line
 Sec. 6 - T26S - R1E
 Elev. 1341.42

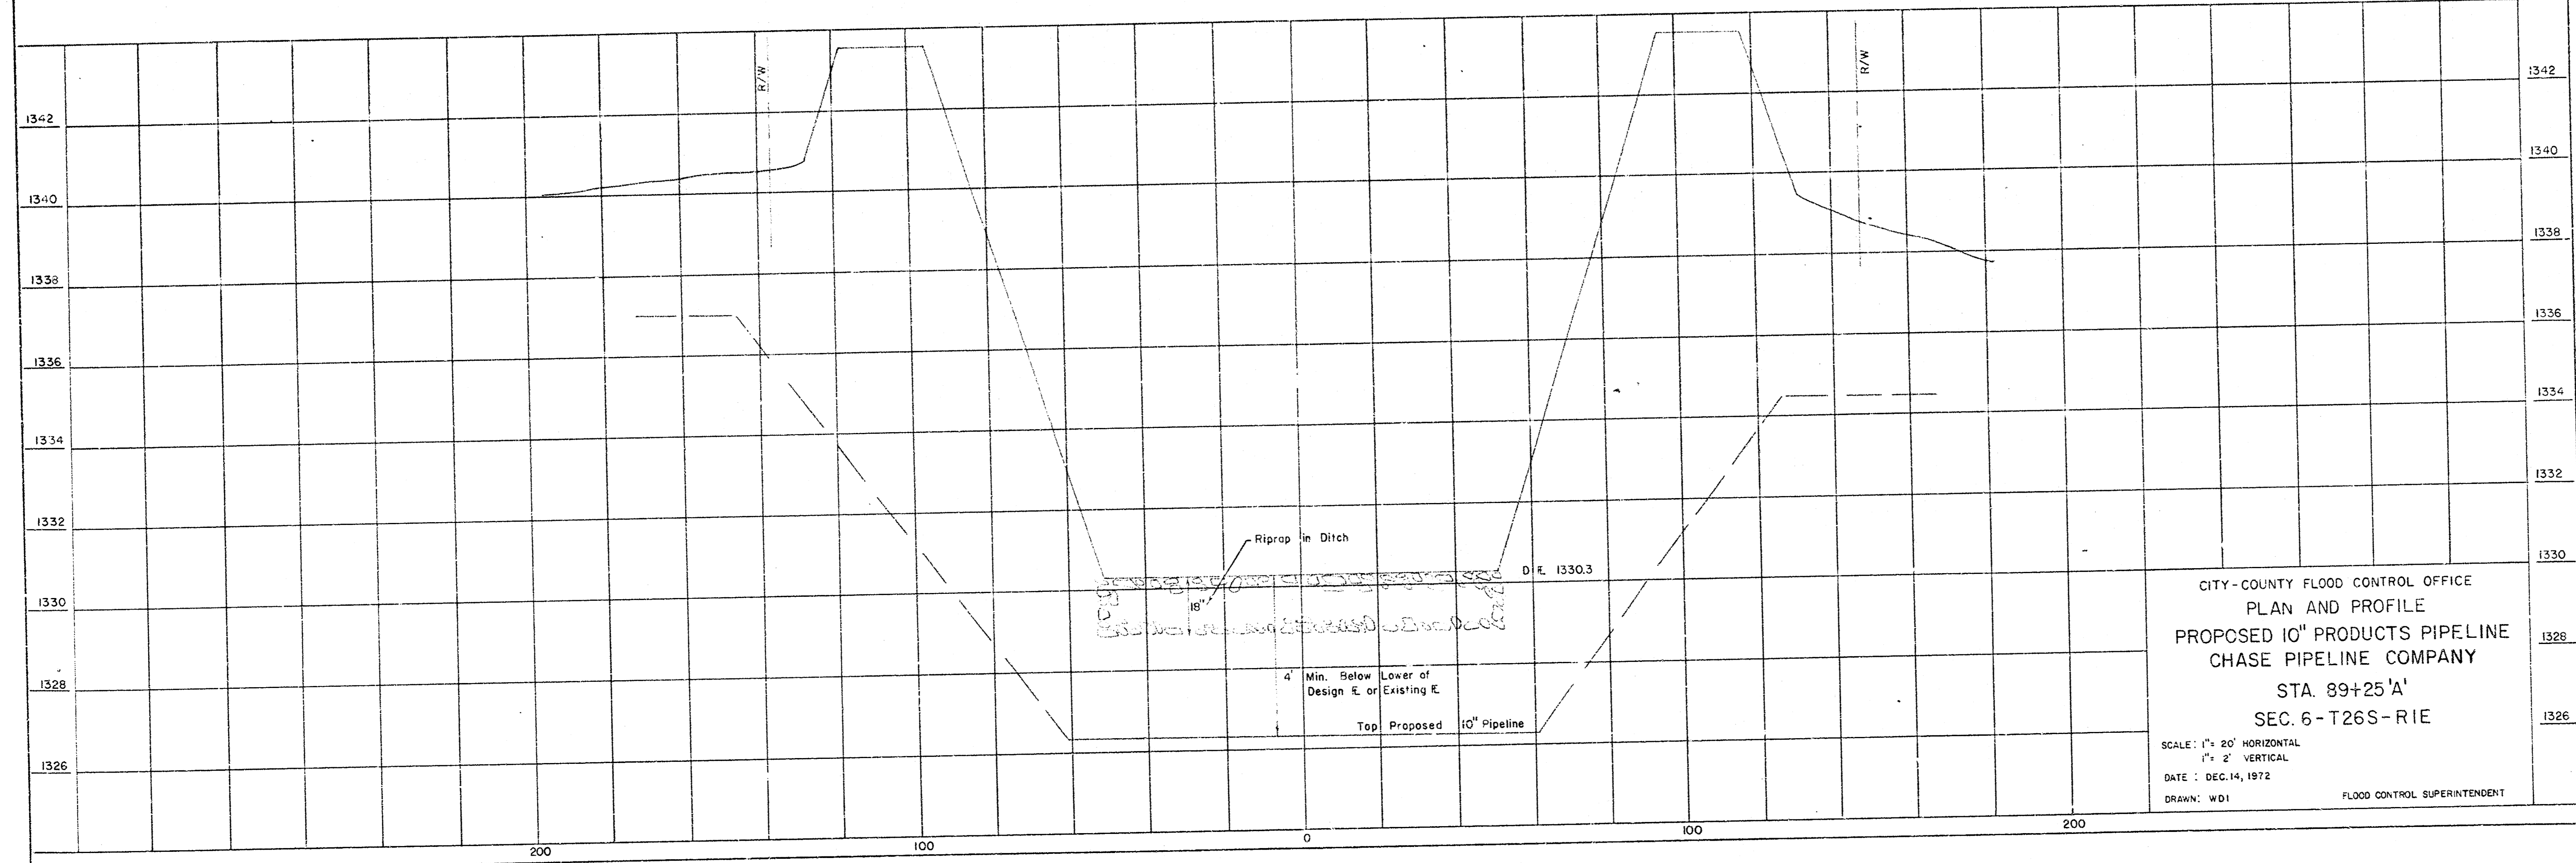

CITY-COUNTY FLOOD CONTROL OFFICE
 PLAN AND PROFILE
 PROPOSED 10" PRODUCTS PIPELINE
 CHASE PIPELINE COMPANY
 STA. 89+25 'A'
 SEC. 6 - T26S - R1E
 SCALE: 1" = 20' HORIZONTAL
 1" = 2' VERTICAL
 DATE: DEC. 14, 1972
 DRAWN: WDI FLOOD CONTROL SUPERINTENDENT