


BENCH MARK:
 R.R. Sp. in 2nd TP north
 of bridge at Seneca St.
 Lateral 'C'.
 Elev. 1348.92

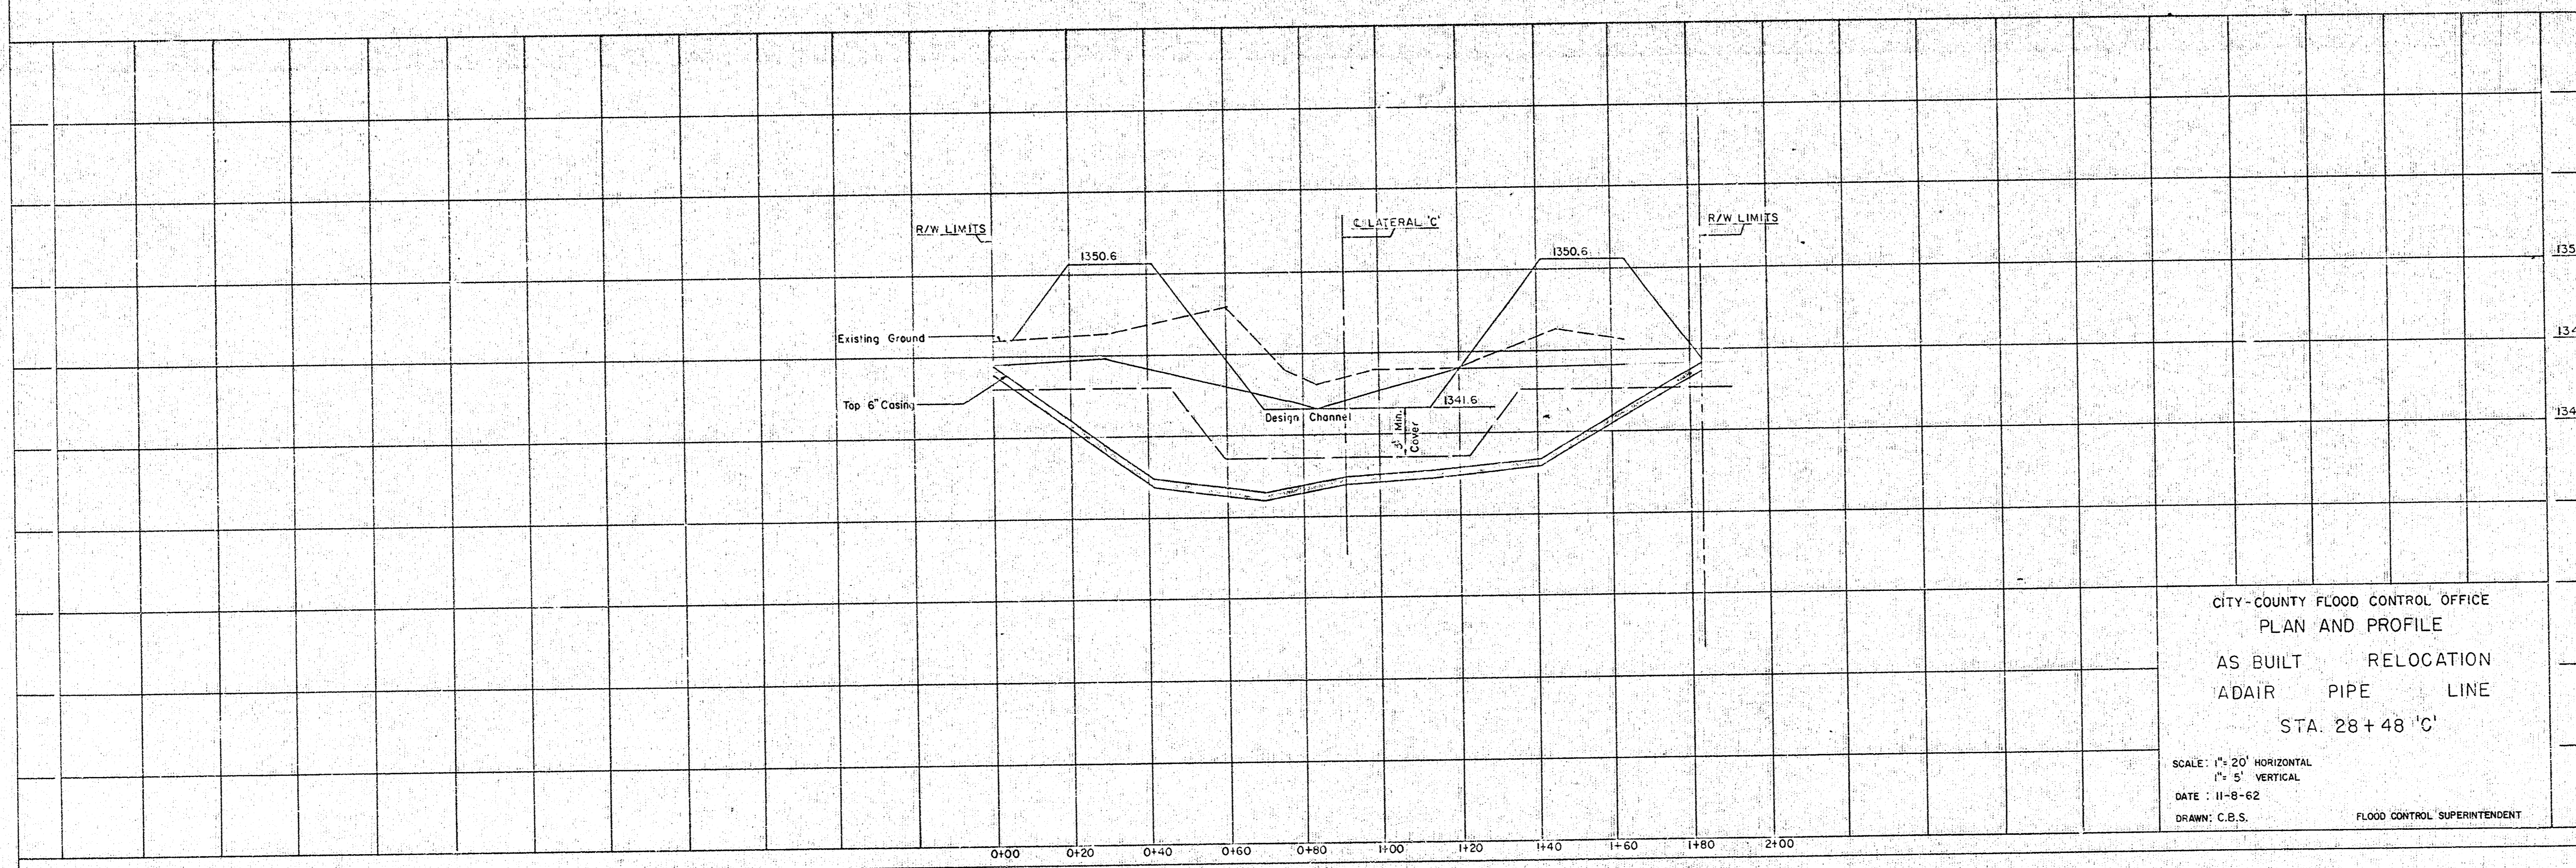

CITY-COUNTY FLOOD CONTROL OFFICE
 PLAN AND PROFILE
 AS BUILT RELOCATION
 ADAIR PIPE LINE
 STA. 28+48 'C'

SCALE: 1" = 20' HORIZONTAL
 1" = 5' VERTICAL
 DATE: 11-8-62
 DRAWN: C.B.S.

FLOOD CONTROL SUPERINTENDENT