



FILE NO. 10-10-59  
 117  
 10-10-59

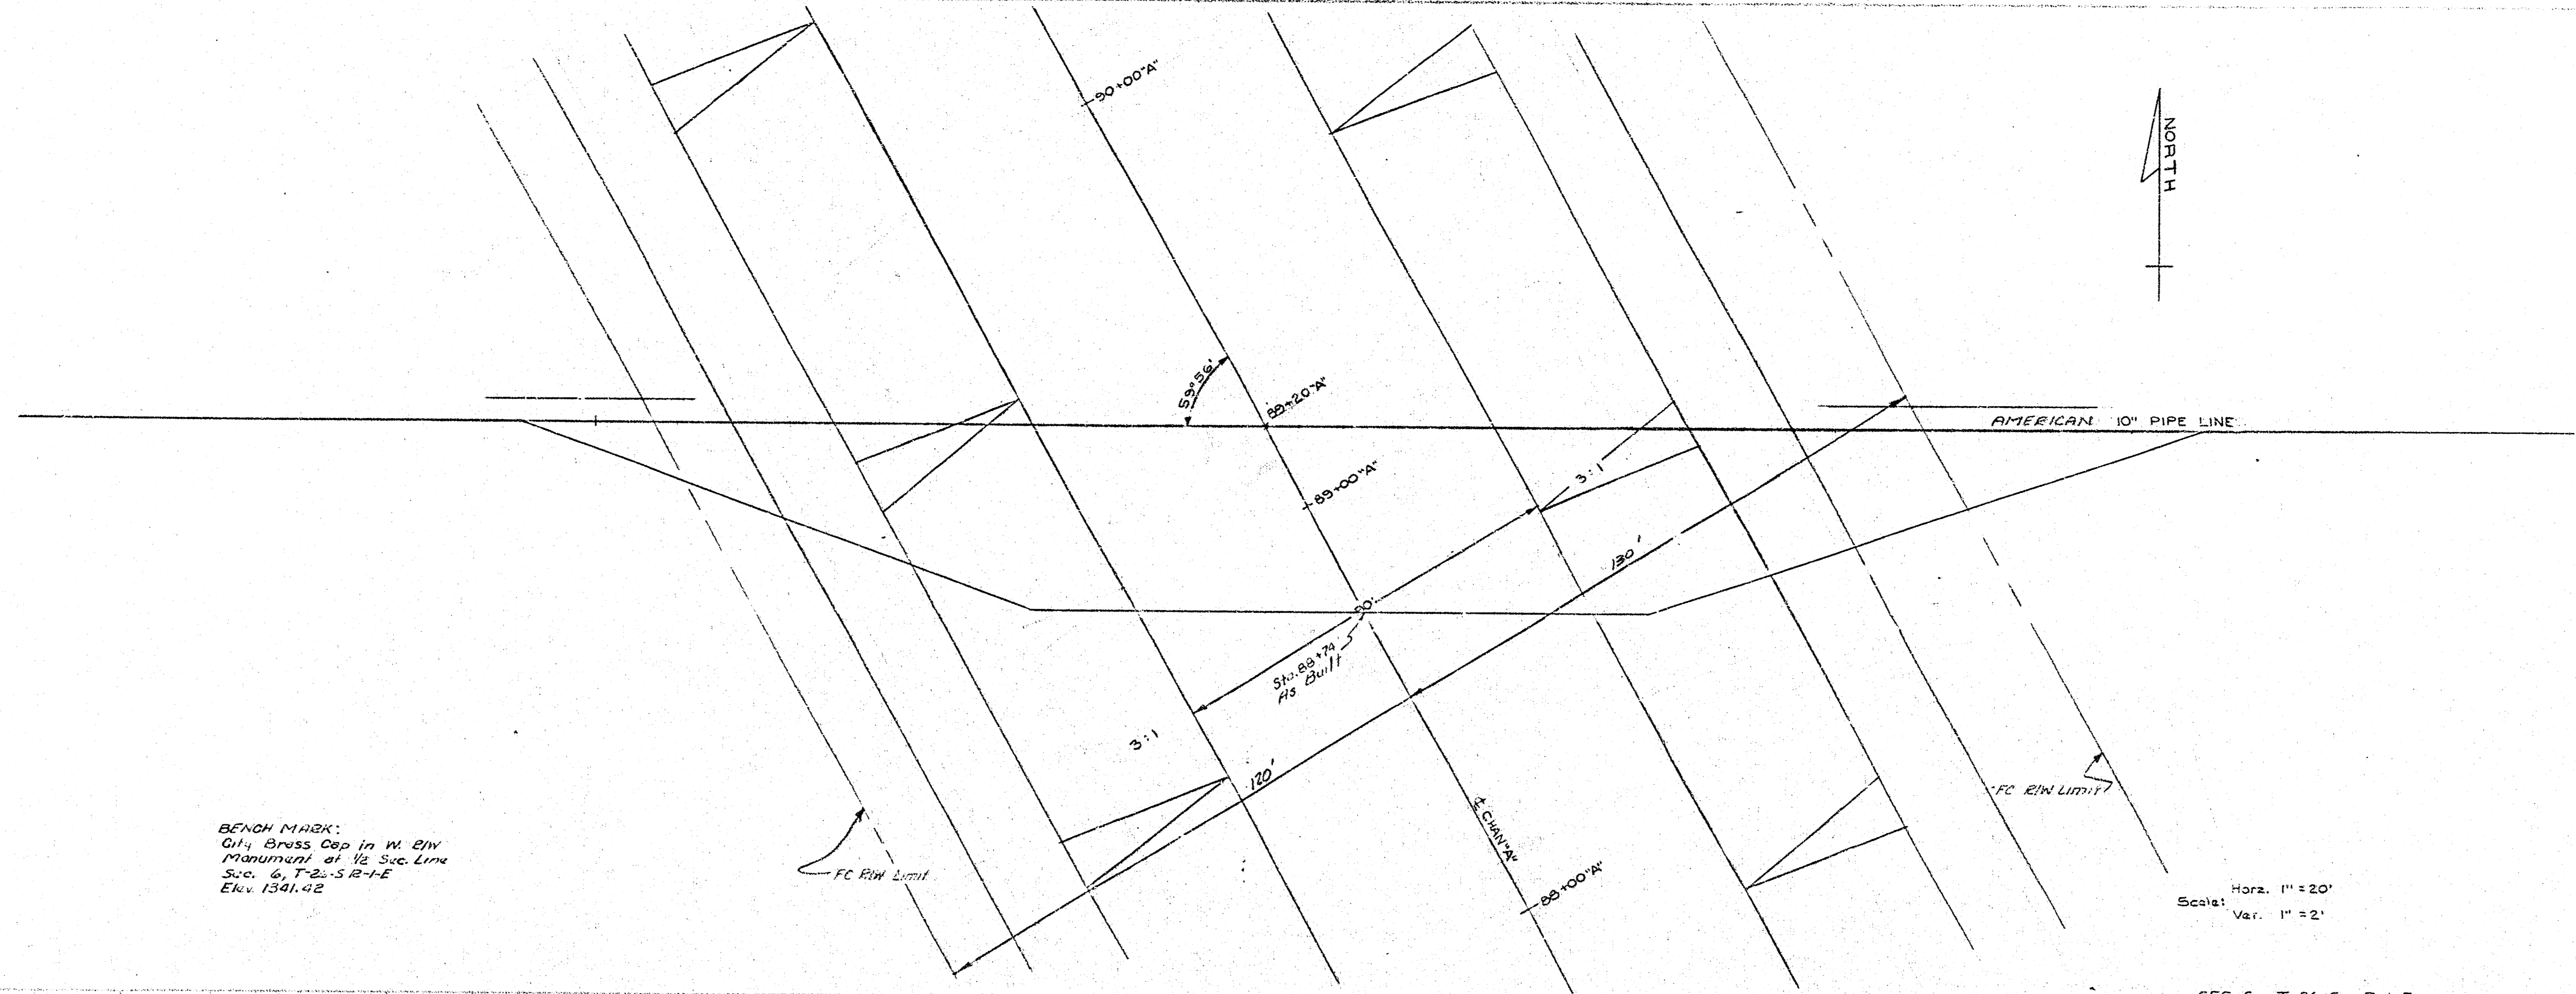


BENCH MARK:  
 6 1/4\"/>

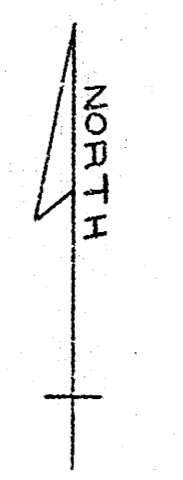

Scale:  
 Horz. 1" = 20'  
 Vert. 1" = 2'

SEC. 6 T-26-S R-1-E

FILE NO. 10-10-59  
 117  
 10-10-59

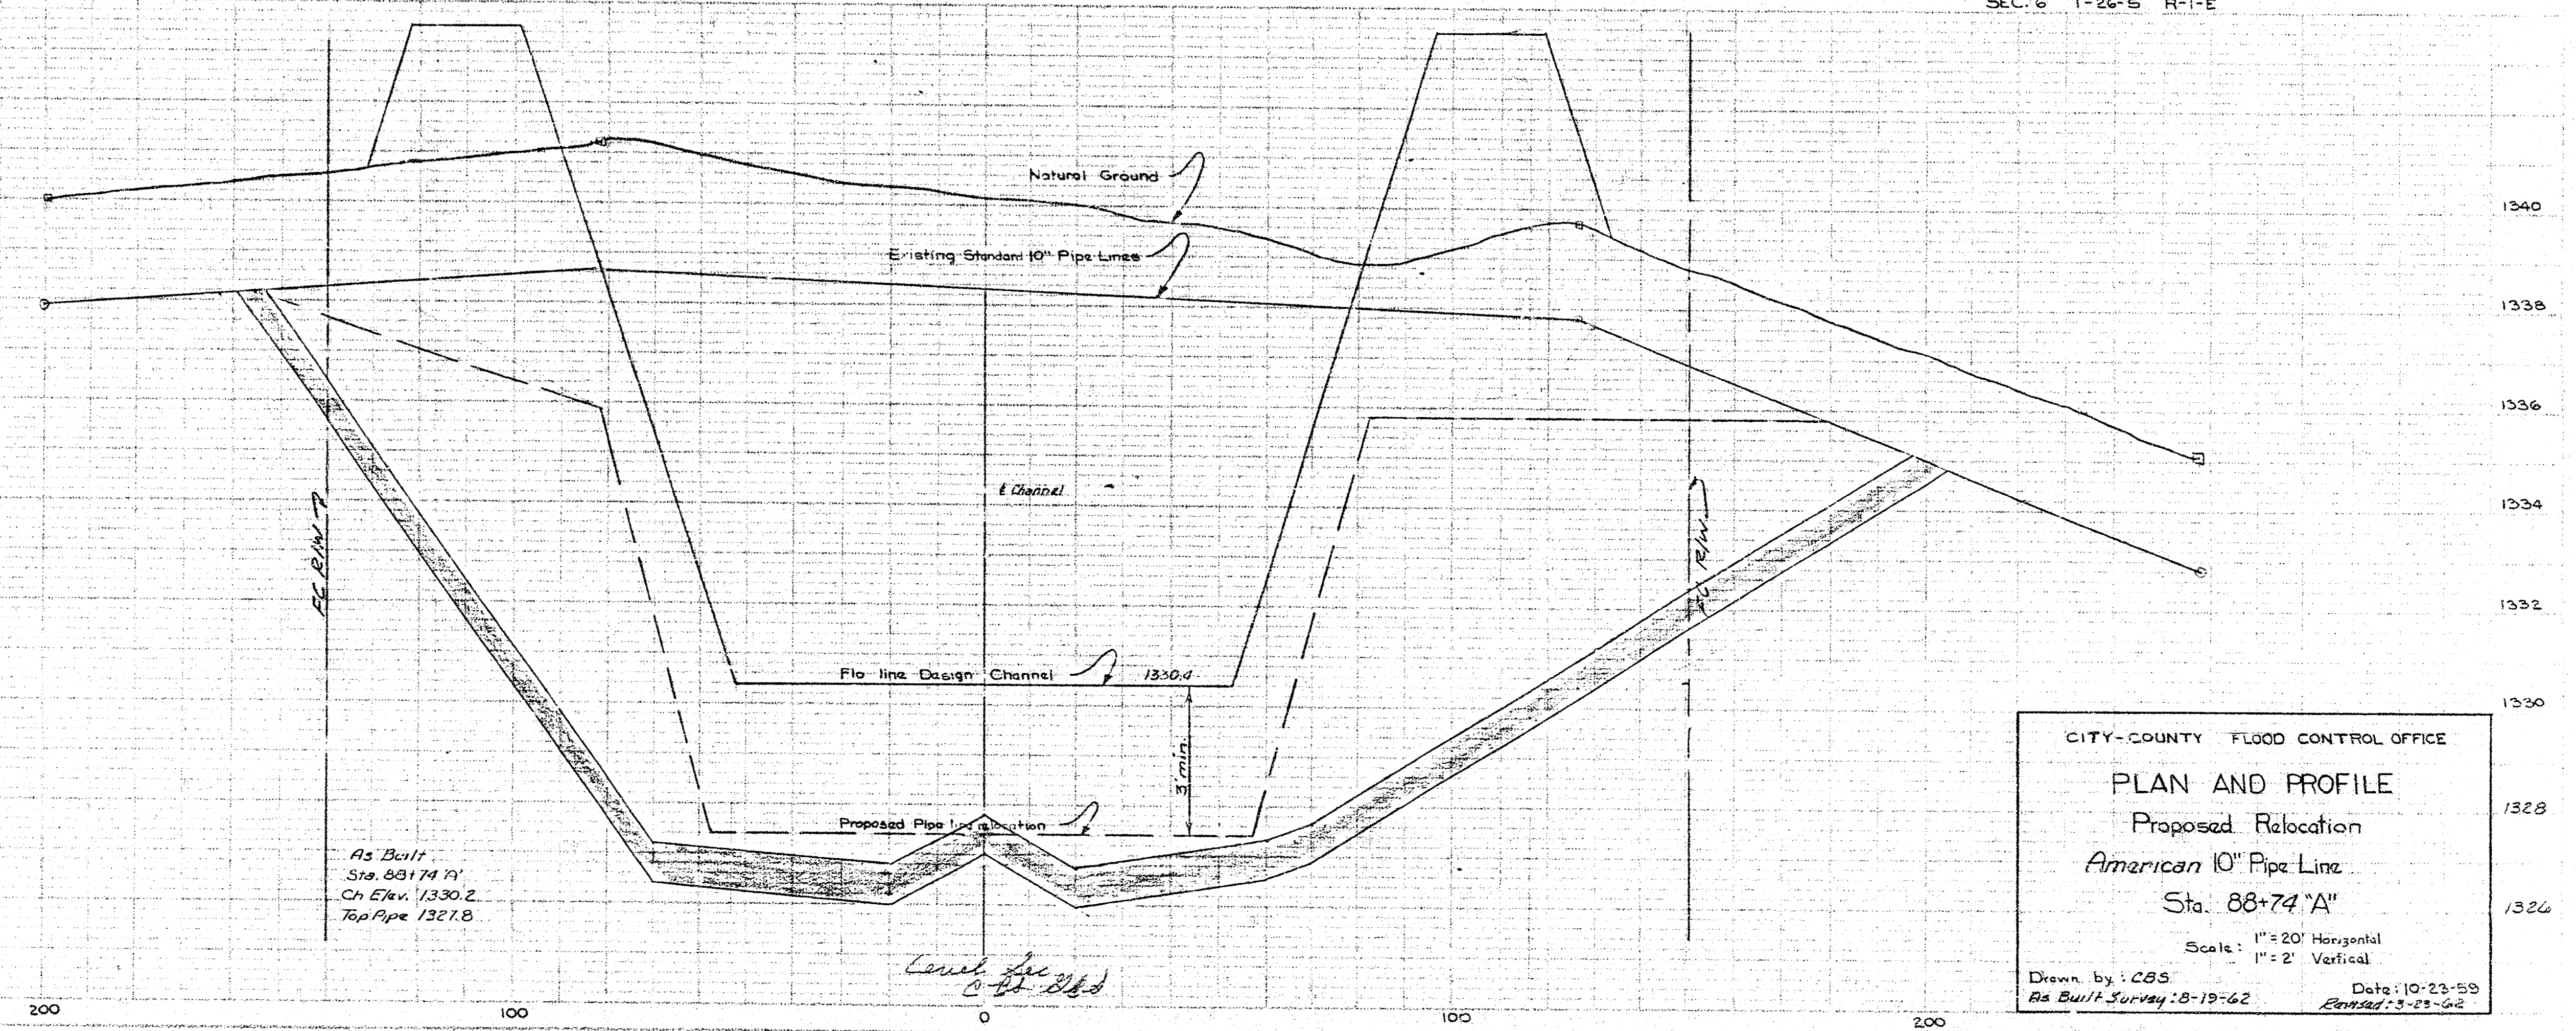

As Built  
 Sta. 88+74.71'  
 Ch. Elev. 1330.2  
 Top Pipe 1321.8

CITY-COUNTY FLOOD CONTROL OFFICE  
**PLAN AND PROFILE**  
 Proposed Relocation  
 American 10" Pipe Line  
 Sta. 88+74 "A"  
 Scale: 1" = 20' Horizontal  
 1" = 2' Vertical  
 Drawn by: C.S.S.  
 Re Built Survey: 8-19-62 Date: 10-22-59  
 Engineer: S-23-62