


FCBM
RR Spk in P112 NE Cor Br
Elev 1380.93

State Hwy BM No 27
D in Conc Cor. 68 Lt. of
Hwy State Libr-Sp. 583137
B 31' W. of SE Cor. Sec. 34
Elev. 1380.00

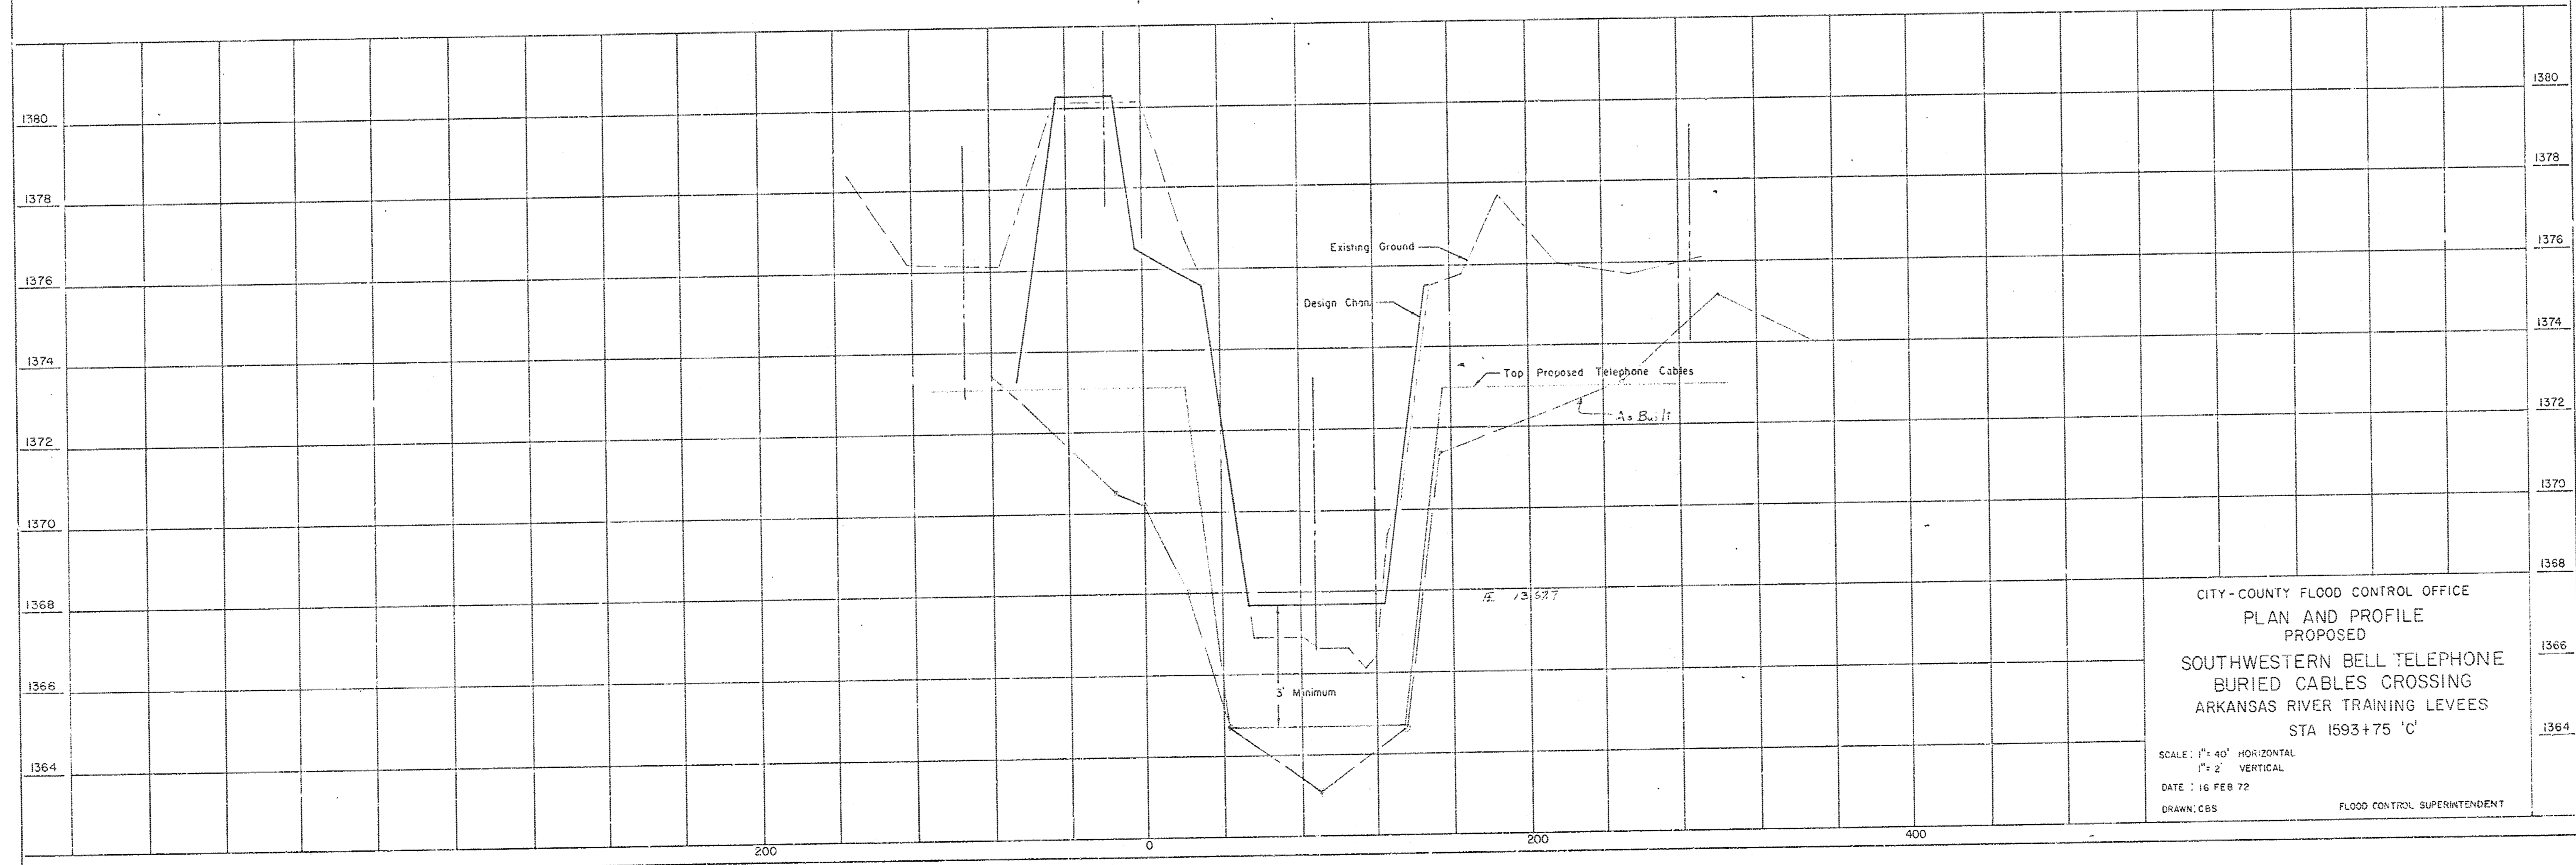

CITY-COUNTY FLOOD CONTROL OFFICE
PLAN AND PROFILE
PROPOSED
SOUTHWESTERN BELL TELEPHONE
BURIED CABLES CROSSING
ARKANSAS RIVER TRAINING LEVEES
STA 1693+75 'C'
SCALE: 1"=40' HORIZONTAL
1"=2' VERTICAL
DATE: 16 FEB 72
DRAWN: CBS FLOOD CONTROL SUPERINTENDENT