
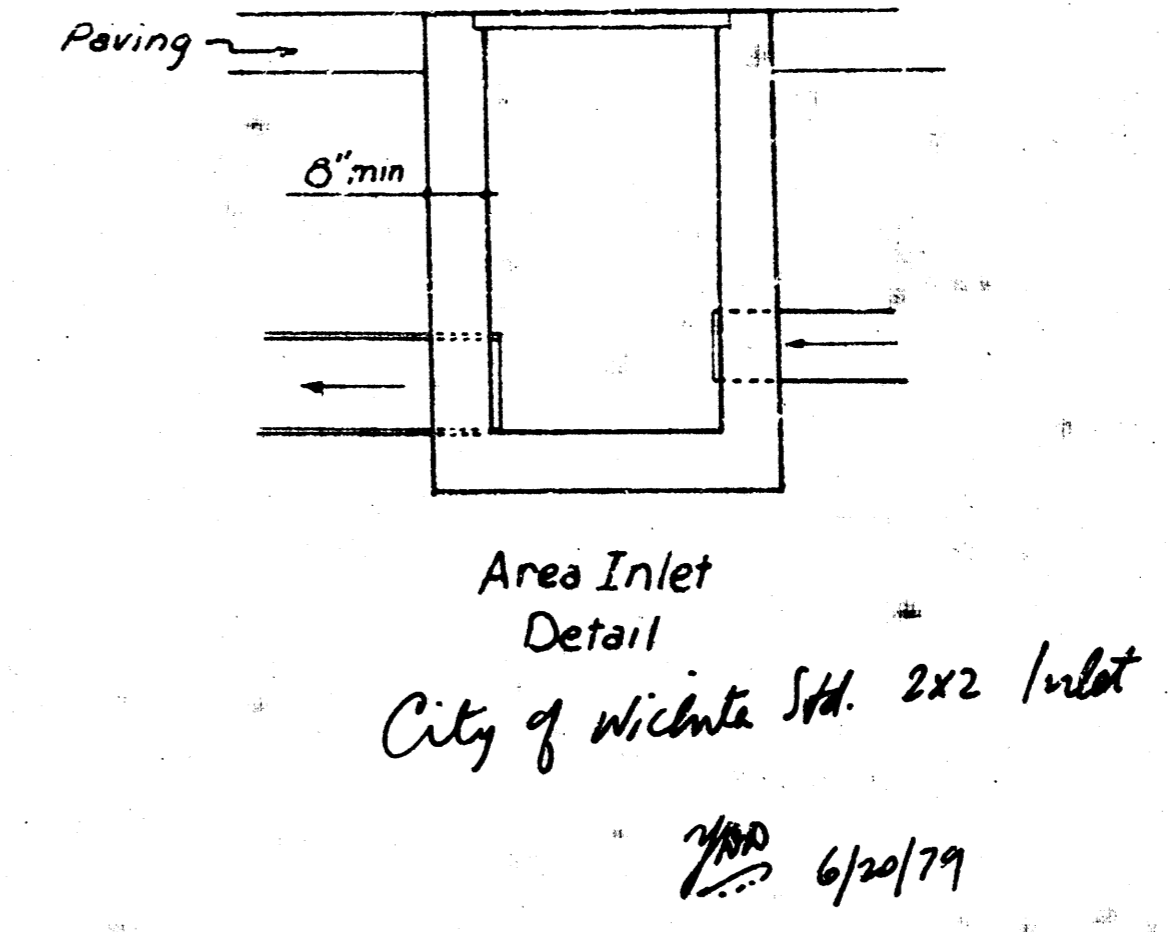


SCALE  
Scale: 1" = 20'

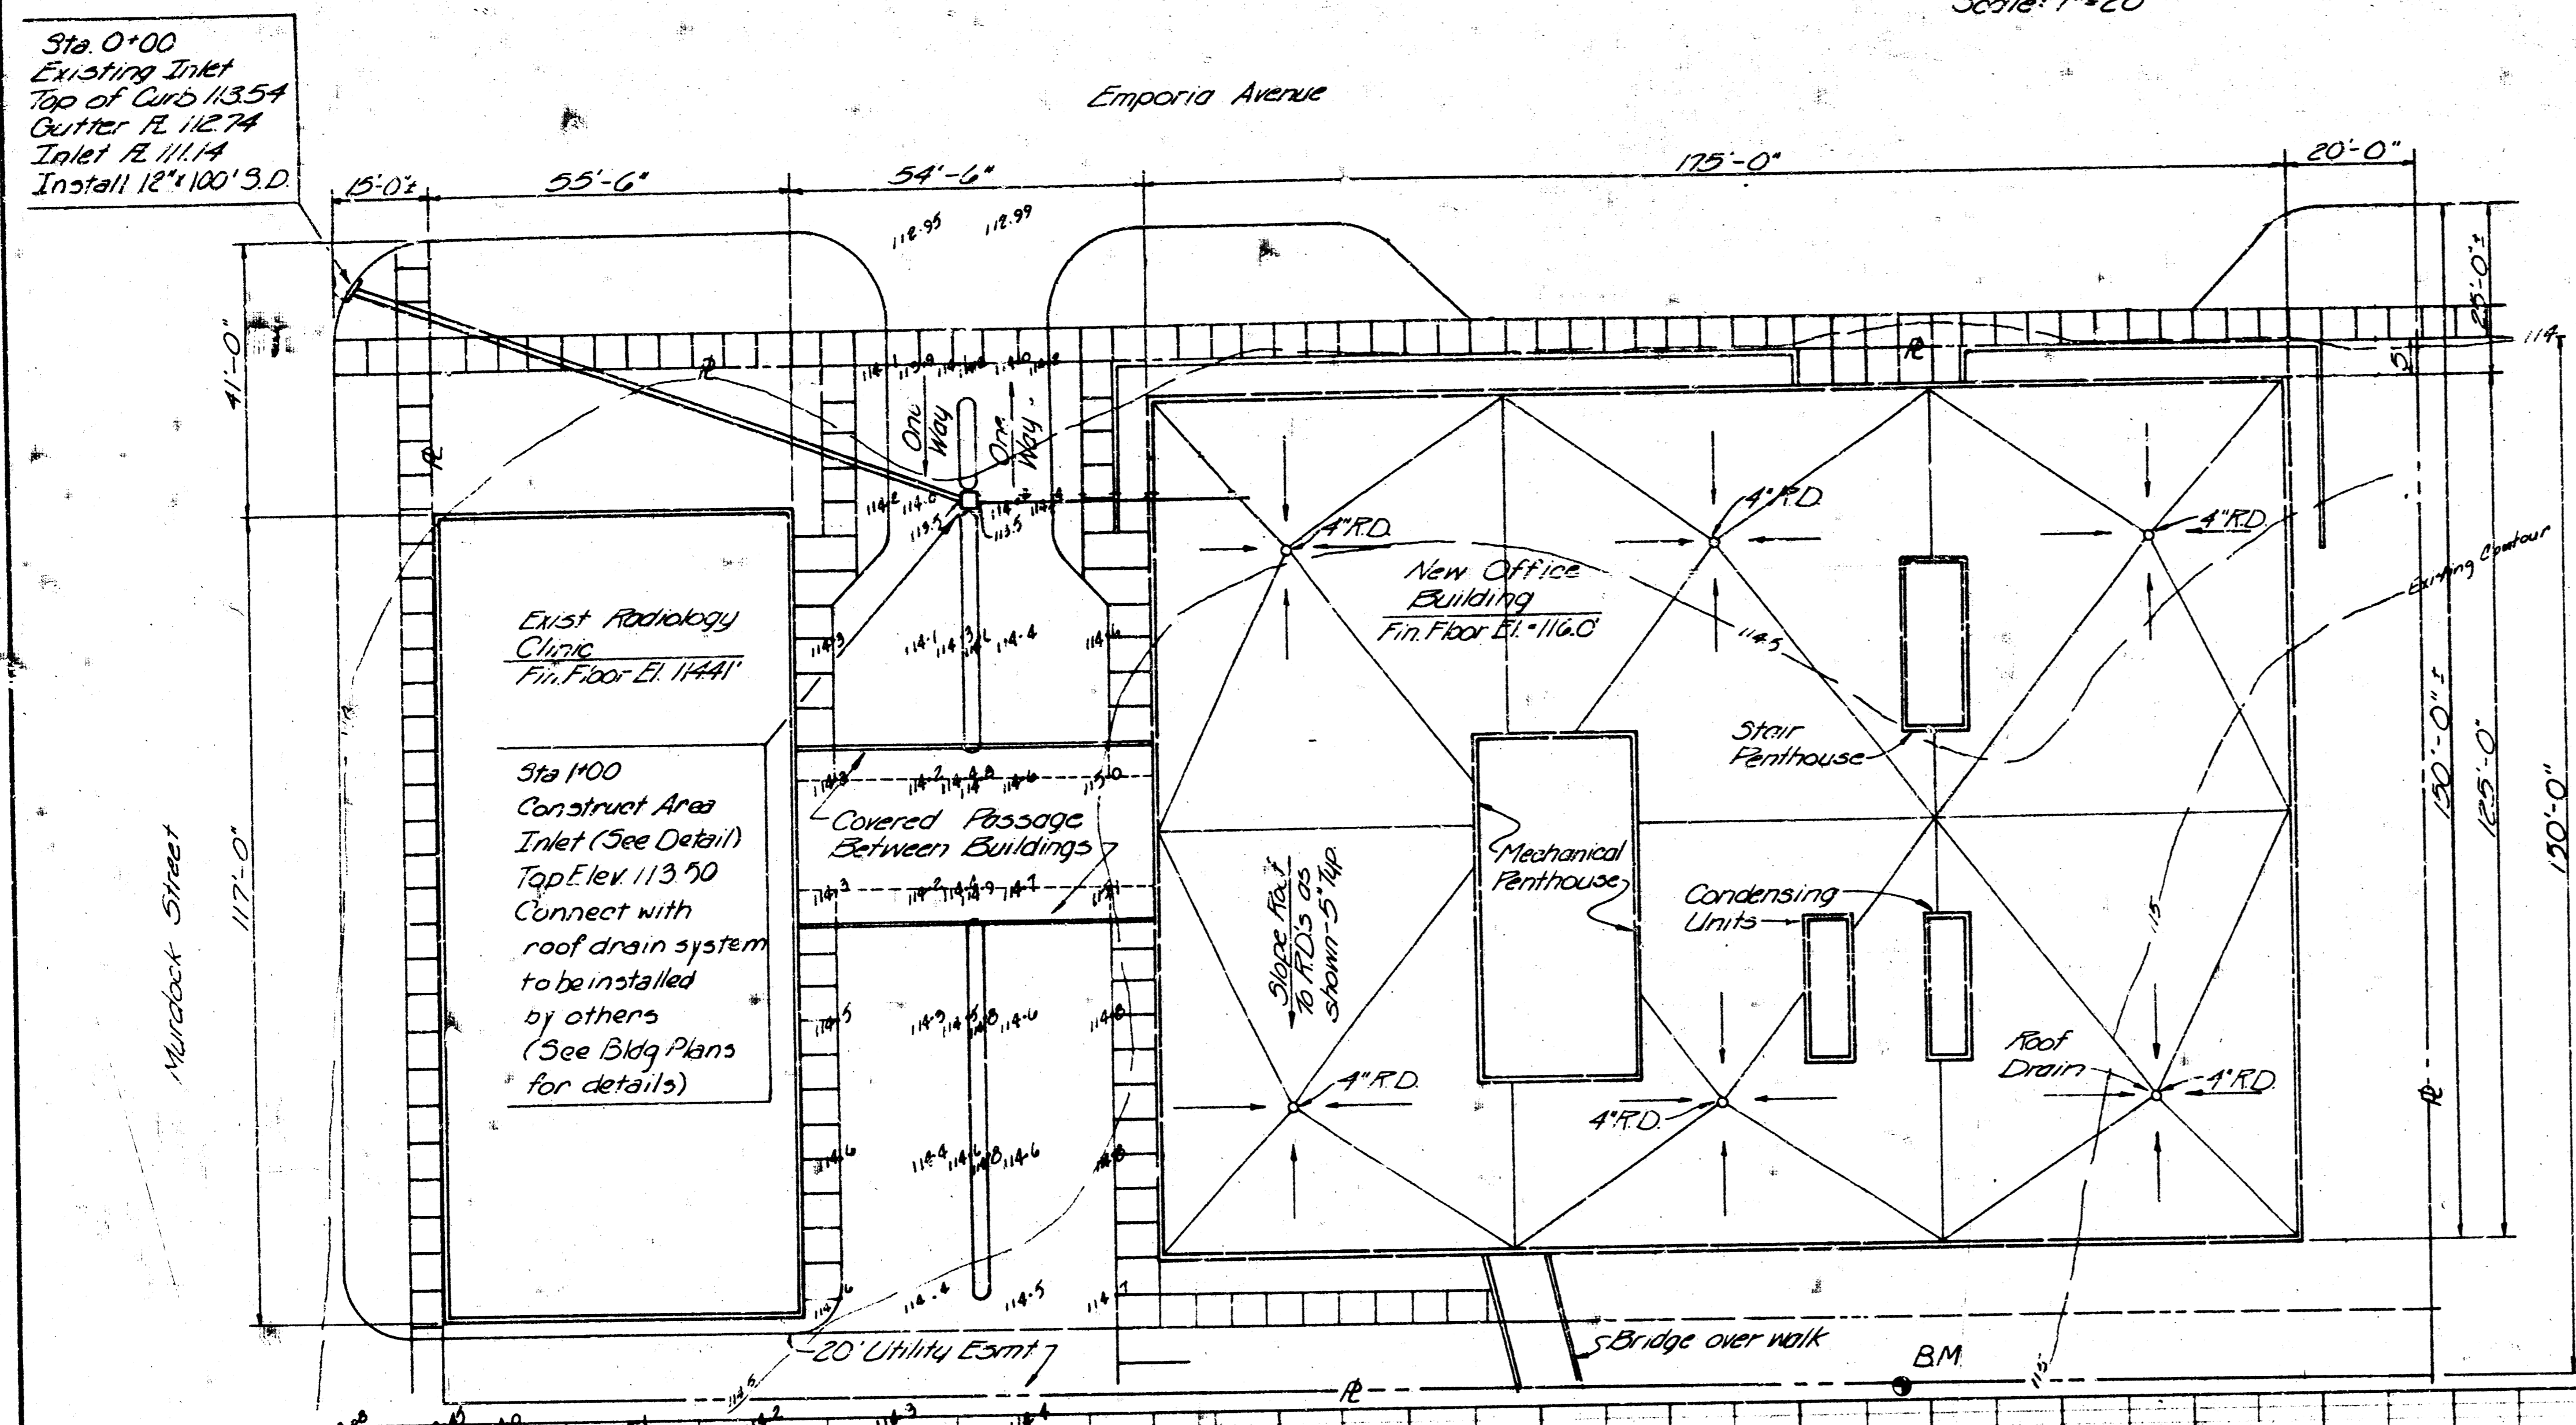


NOTE: SEE ATTACHED FIRST FLOOR PLUMBING PLAN FOR DETAILS OF ROOF DRAIN SYSTEM AND CONNECTION TO STORM SEWER SYSTEM

B.M. San Sewer Manhole 82' S of NE Property Corner  
Top Ring Elev. - 114.08

DATE	
BY	
REVISION	
NOTE BOOK	
NO.	

DATE	
BY	
REVISION	
NOTE BOOK	
NO.	

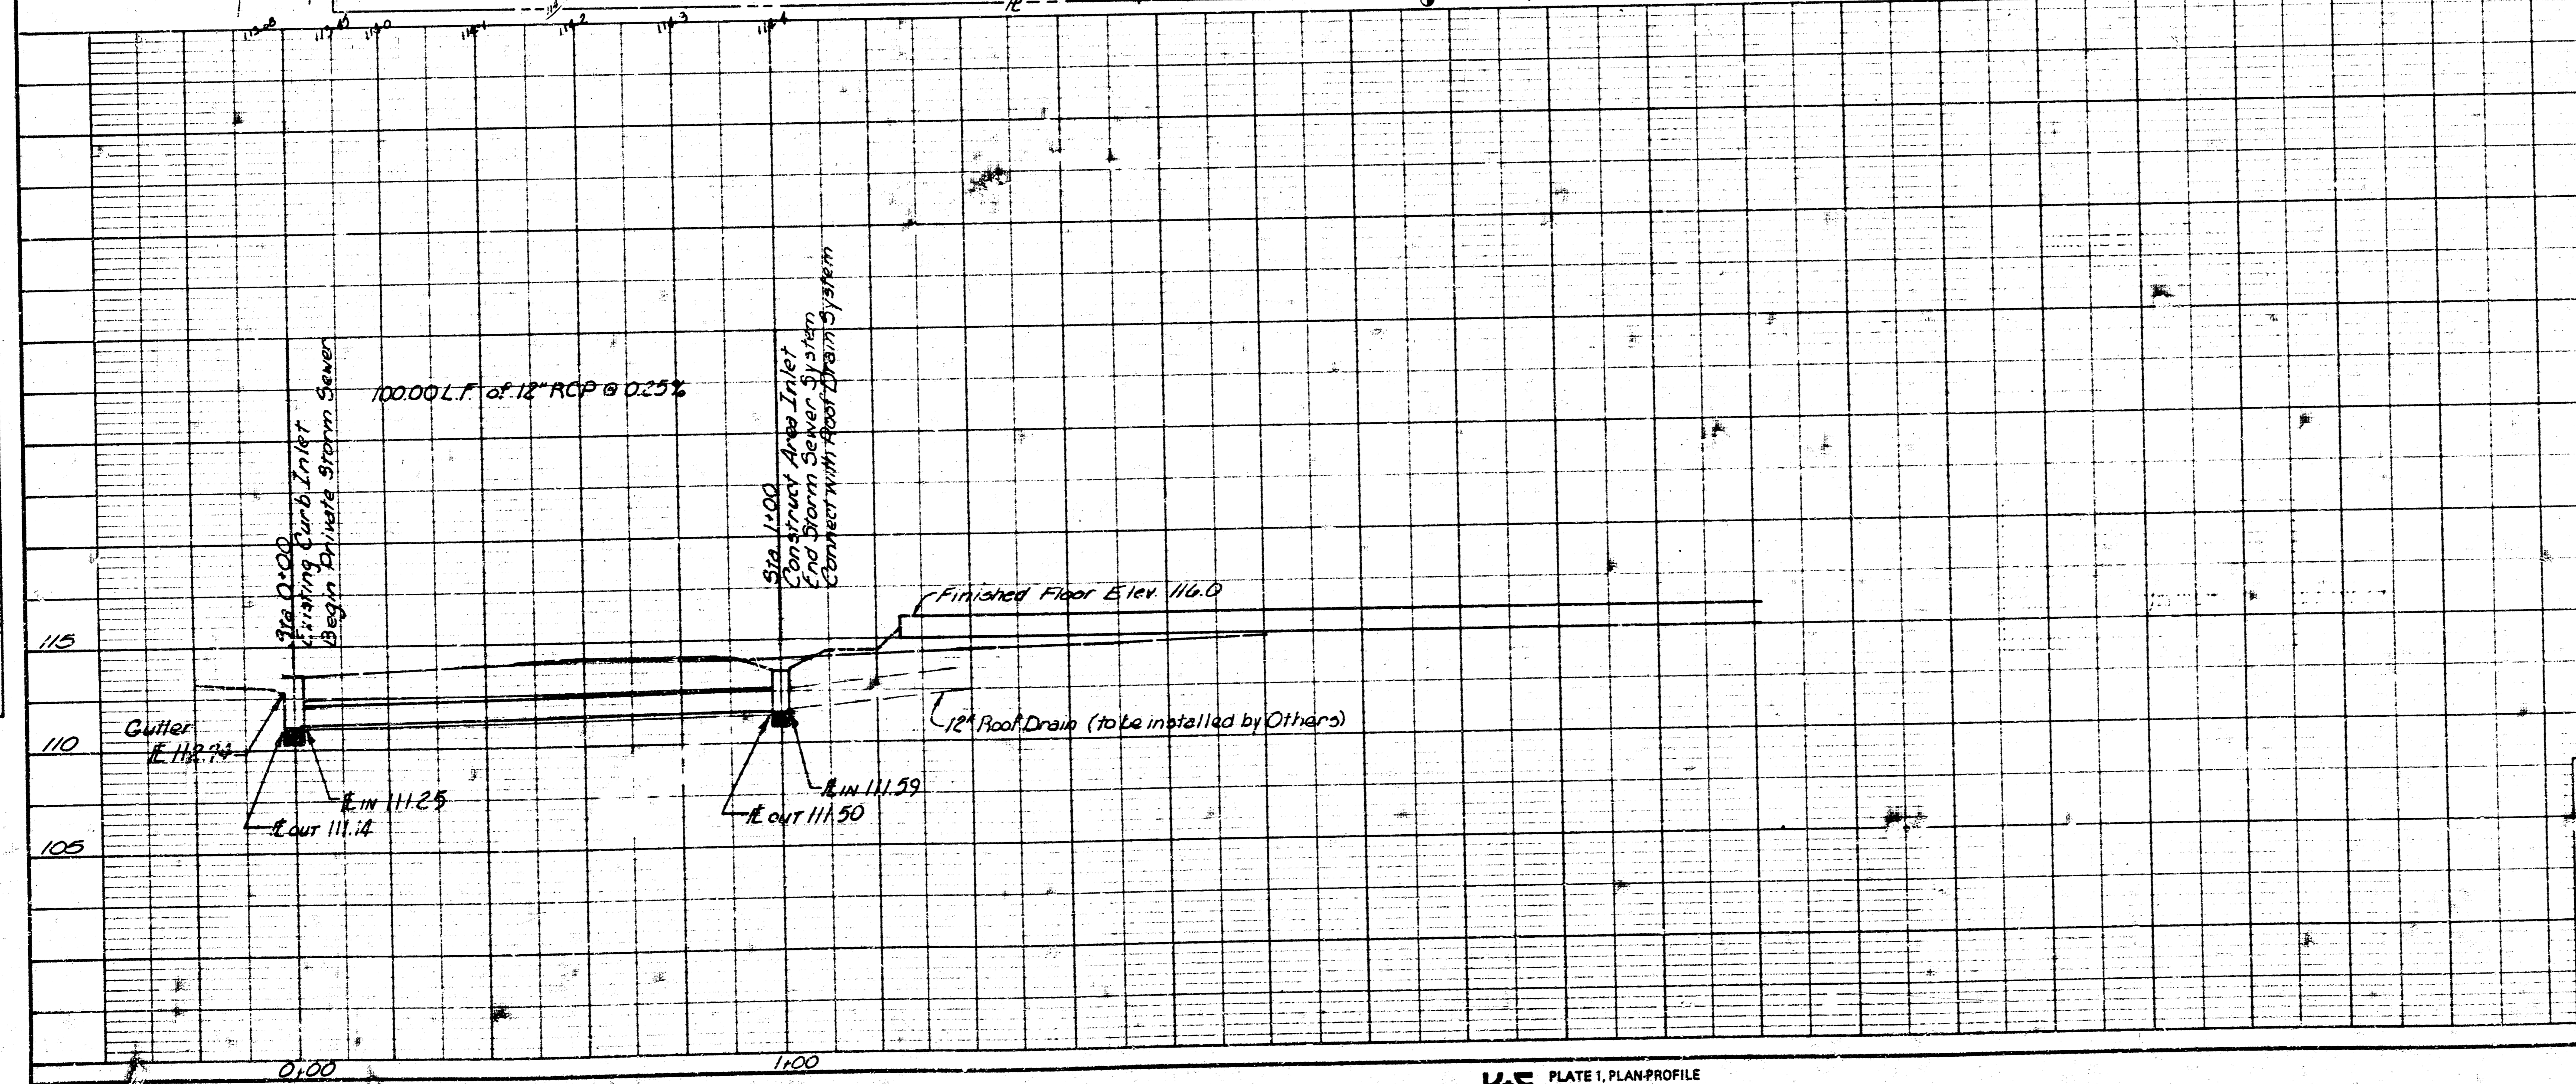

2	Added Note re: Plumbing Plan	4/20/79
1	Added Inlet Detail of B.M.	6/12/79
No.	Revision	By Date
CITY OF WICHITA PRIVATE STORM SEWER NO. 468-245-8075-000-000-008		
<b>EAGLE CENTER STORM SEWER</b> WICHITA, KANSAS		
PROFESSIONAL ENGINEERING CONSULTANTS, P.A.		
ENGINEERS WICHITA, KANSAS		
Designed by	CMB	Job No: 79123-220
Drawn by	BB	Date 4/21/79
		Sht. 1 of 1

FILMED FROM THE BEST

