


THE GATEWAY CENTER 2ND ADDITION

AN ADDITION TO WICHITA, SEDGWICK COUNTY, KANSAS

DRAINAGE PLAN

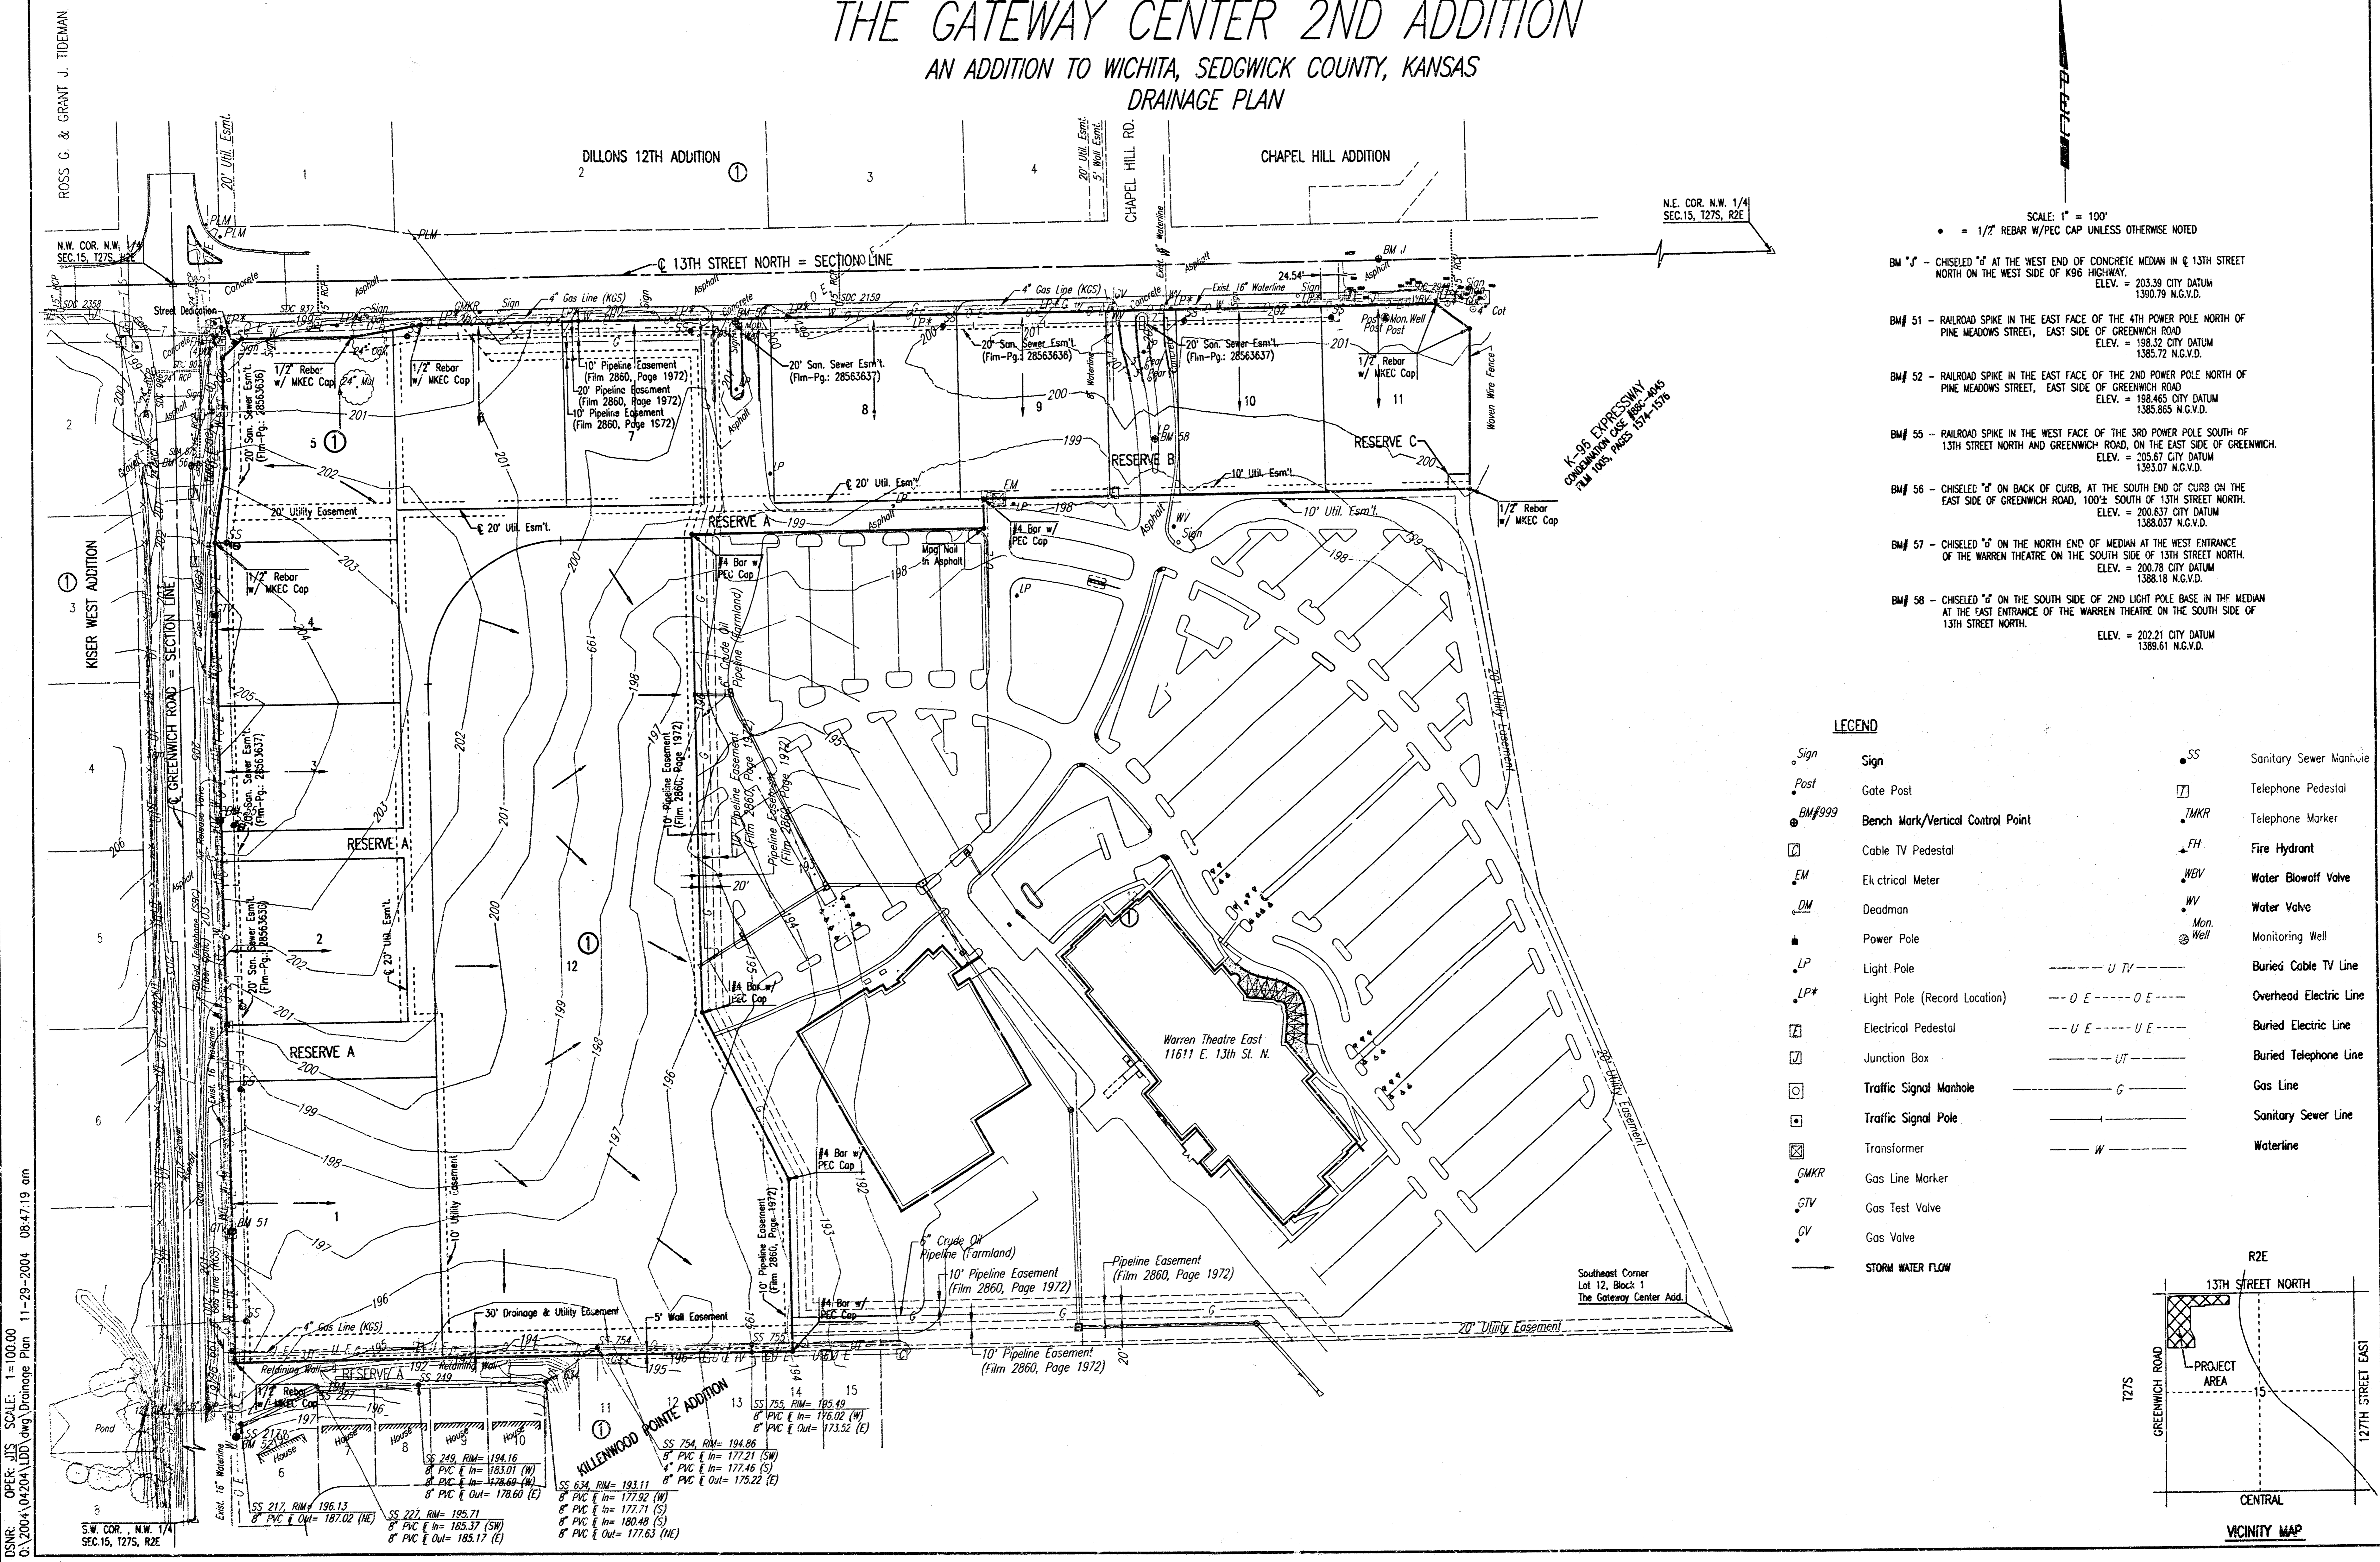


DSNR: OPER: JJS SCALE: 1"=100.00
 C:\2004\04204\LD\DWG\Drainage Plan 11-29-2004 08:47:19 am

SCALE: 1" = 100'

- = 1/2" REBAR W/PEC CAP UNLESS OTHERWISE NOTED
- BM "J" - CHISELED "J" AT THE WEST END OF CONCRETE MEDIAN IN E 13TH STREET NORTH ON THE WEST SIDE OF K96 HIGHWAY. ELEV. = 203.39 CITY DATUM 1390.79 N.G.V.D.
- BM# 51 - RAILROAD SPIKE IN THE EAST FACE OF THE 4TH POWER POLE NORTH OF PINE MEADOWS STREET, EAST SIDE OF GREENWICH ROAD. ELEV. = 198.32 CITY DATUM 1385.72 N.G.V.D.
- BM# 52 - RAILROAD SPIKE IN THE EAST FACE OF THE 2ND POWER POLE NORTH OF PINE MEADOWS STREET, EAST SIDE OF GREENWICH ROAD. ELEV. = 198.465 CITY DATUM 1385.865 N.G.V.D.
- BM# 55 - RAILROAD SPIKE IN THE WEST FACE OF THE 3RD POWER POLE SOUTH OF 13TH STREET NORTH AND GREENWICH ROAD, ON THE EAST SIDE OF GREENWICH. ELEV. = 205.67 CITY DATUM 1389.07 N.G.V.D.
- BM# 56 - CHISELED "J" ON BACK OF CURB, AT THE SOUTH END OF CURB ON THE EAST SIDE OF GREENWICH ROAD, 100'± SOUTH OF 13TH STREET NORTH. ELEV. = 200.637 CITY DATUM 1388.037 N.G.V.D.
- BM# 57 - CHISELED "J" ON THE NORTH END OF MEDIAN AT THE WEST ENTRANCE OF THE WARREN THEATRE ON THE SOUTH SIDE OF 13TH STREET NORTH. ELEV. = 200.78 CITY DATUM 1388.18 N.G.V.D.
- BM# 58 - CHISELED "J" ON THE SOUTH SIDE OF 2ND LIGHT POLE BASE IN THE MEDIAN AT THE EAST ENTRANCE OF THE WARREN THEATRE ON THE SOUTH SIDE OF 13TH STREET NORTH. ELEV. = 202.21 CITY DATUM 1389.61 N.G.V.D.

LEGEND

Sign	Sign	SS	Sanitary Sewer Manhole
Post	Gate Post	TP	Telephone Pedestal
BM#999	Bench Mark/Vertical Control Point	TKR	Telephone Marker
CTV	Cable TV Pedestal	FH	Fire Hydrant
EM	Electrical Meter	WBV	Water Blowoff Valve
DM	Deadman	WV	Water Valve
PP	Power Pole	Mon. Well	Monitoring Well
LP	Light Pole	U TV	Buried Cable TV Line
LP#	Light Pole (Record Location)	O E O E	Buried Electric Line
EP	Electrical Pedestal	U E U E	Buried Telephone Line
JB	Junction Box	UT	Buried Telephone Line
TM	Traffic Signal Manhole	G	Gas Line
TS	Traffic Signal Pole	S	Sanitary Sewer Line
TR	Transformer	W	Waterline
GMKR	Gas Line Marker		
STV	Gas Test Valve		
GV	Gas Valve		
→	STORM WATER FLOW		

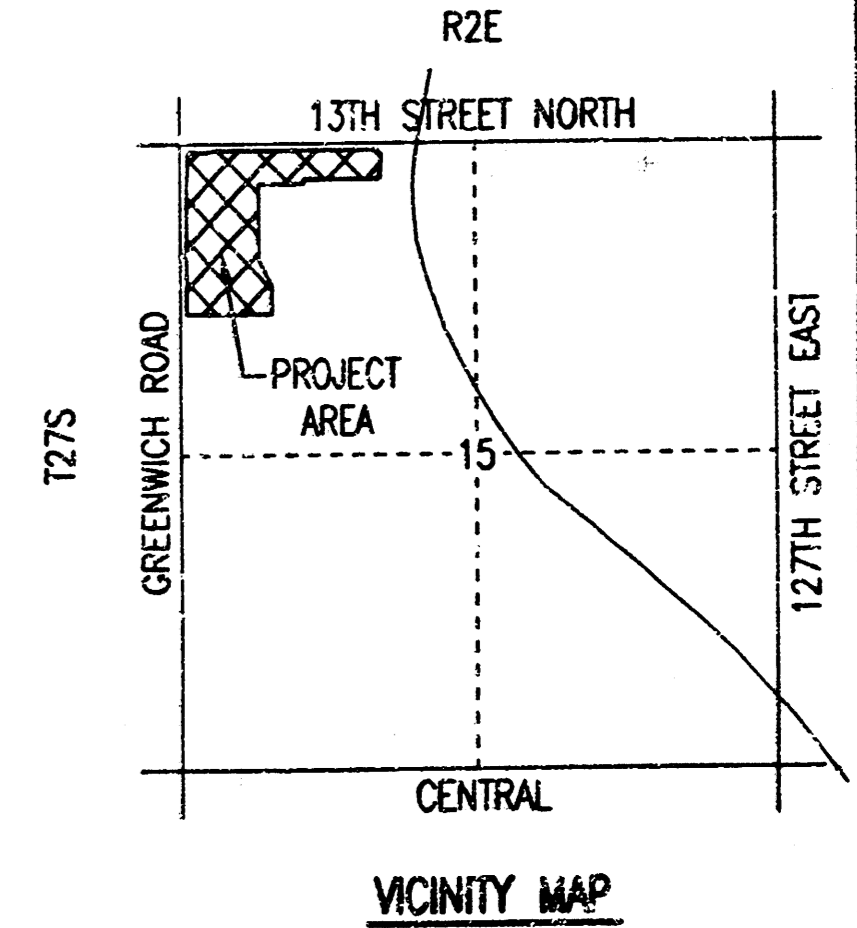

VICINITY MAP