


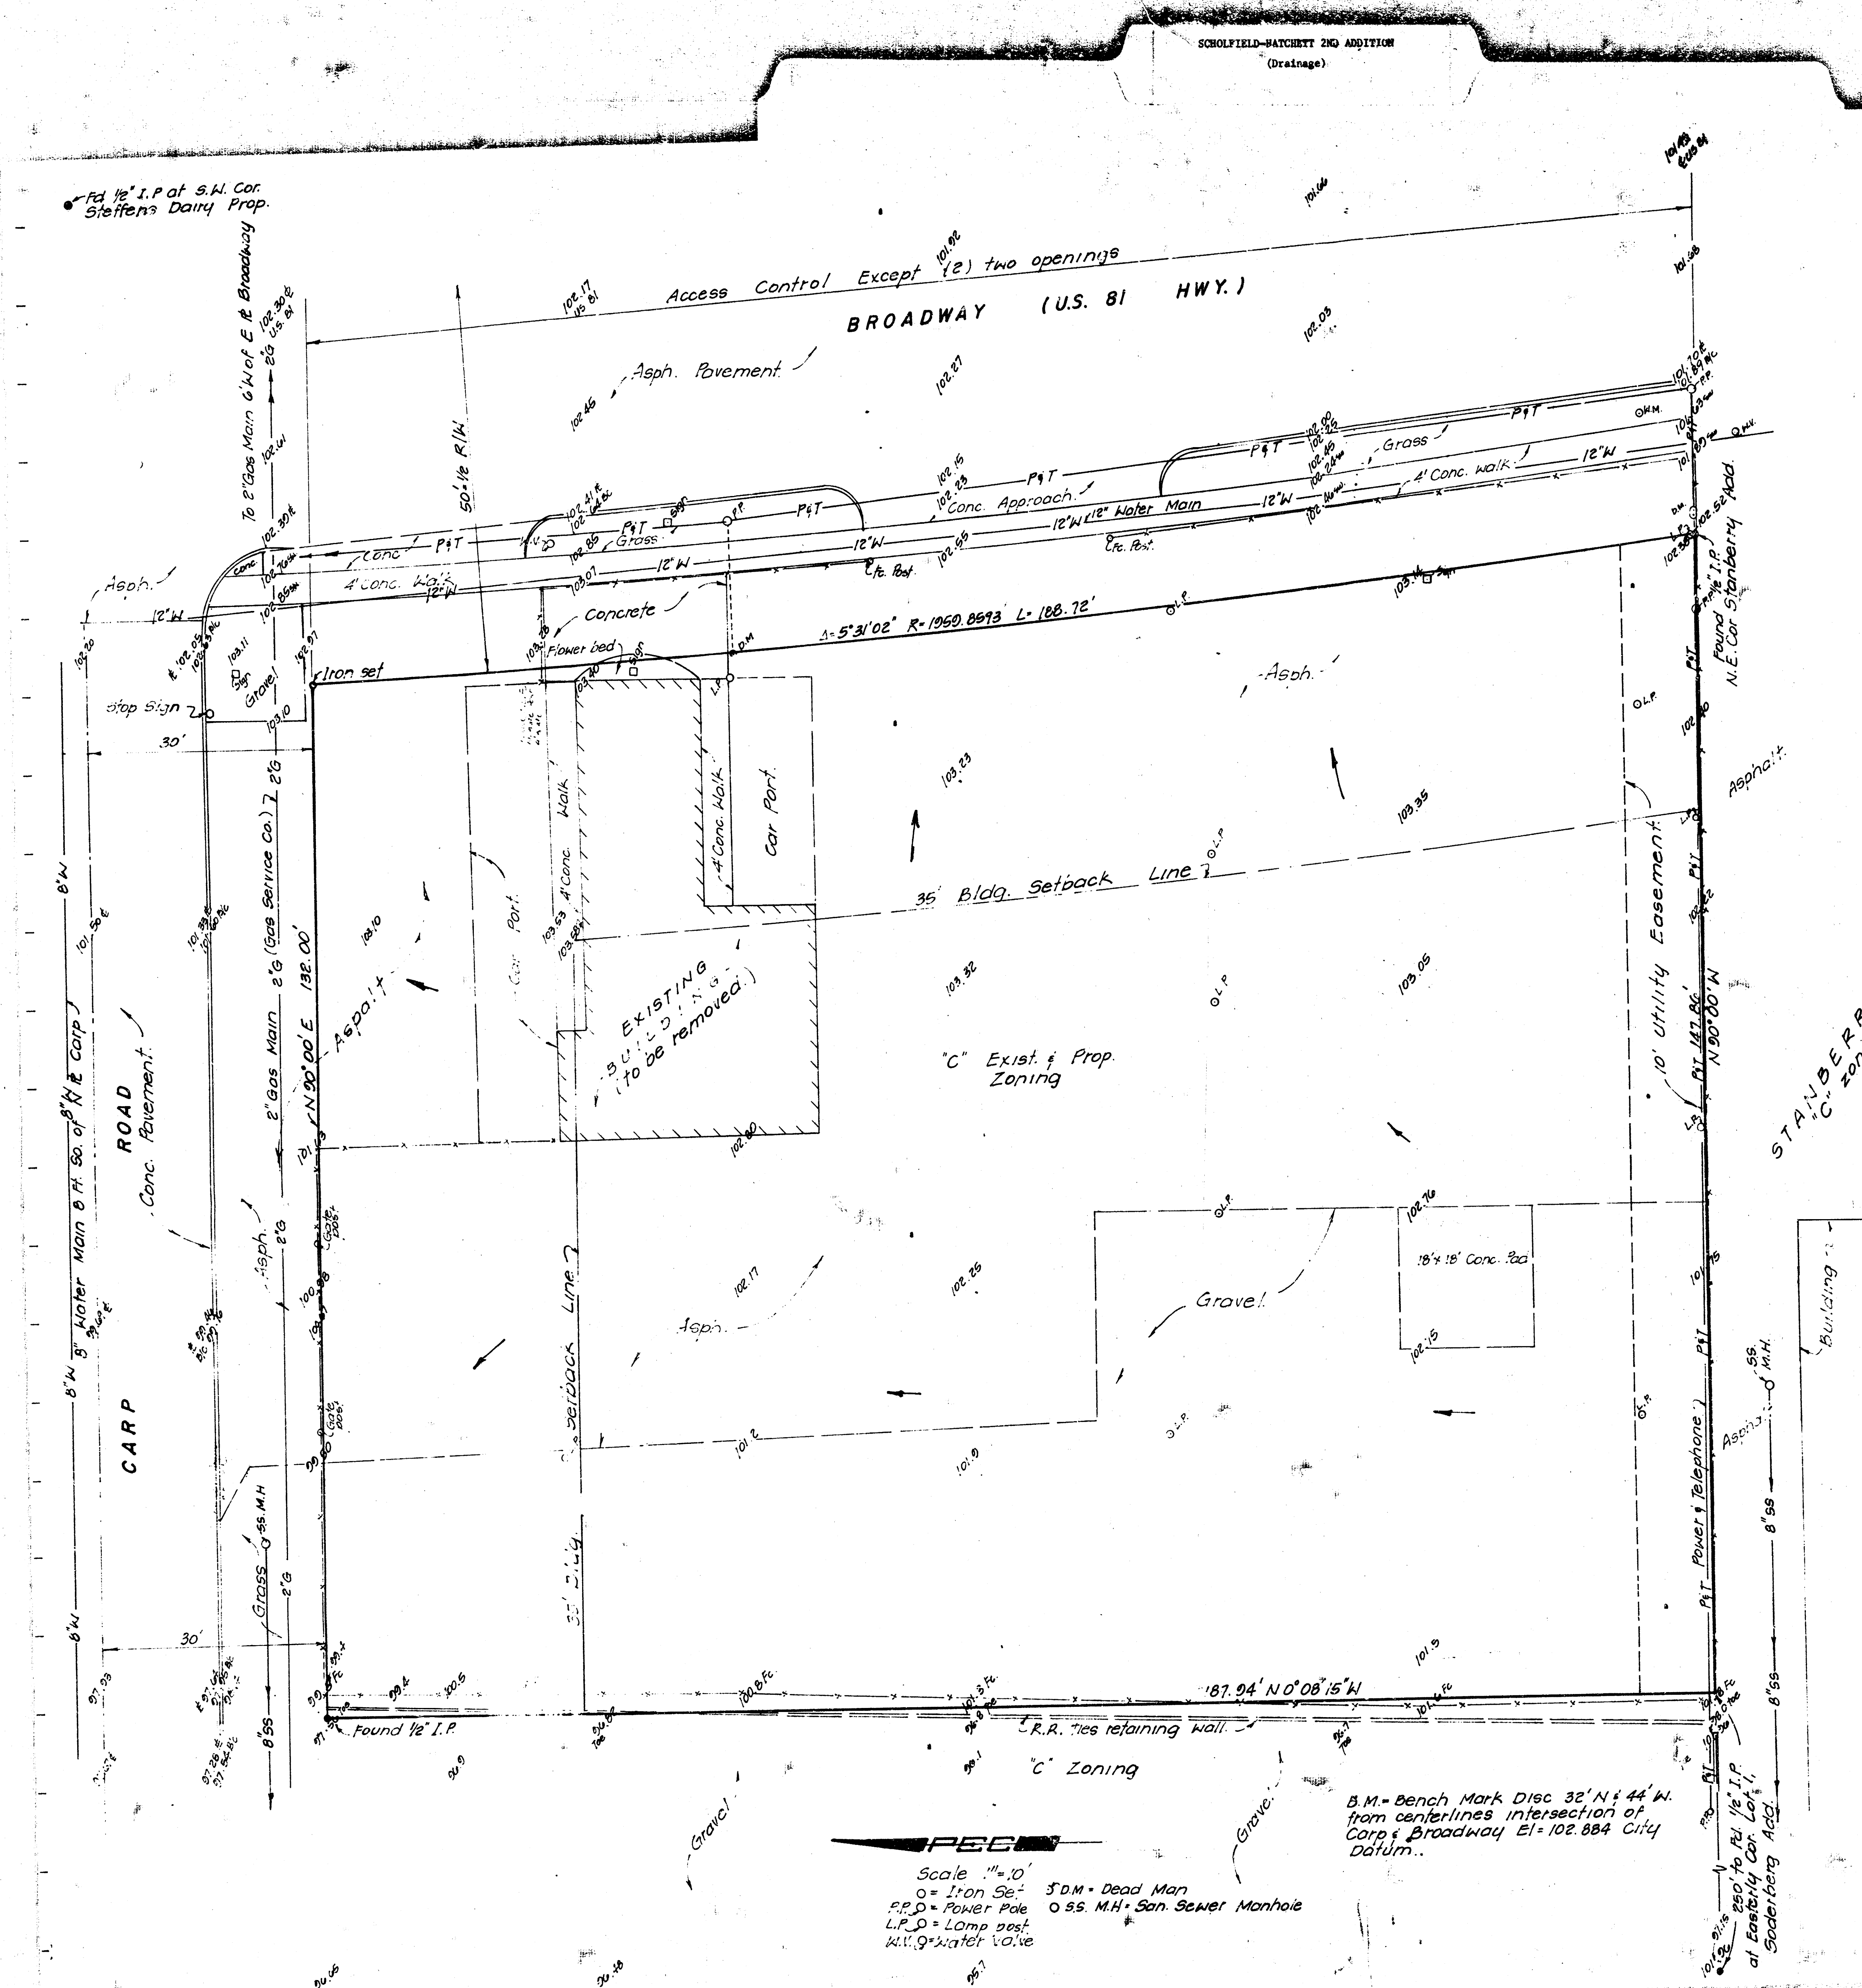


Lot 1 shall be graded to drain to existing streets, gutters, and/or storm water sewer systems via drives, flumes, private storm sewers and/or other approved drainage facilities.

DRAINAGE PLAN of
SCHOLFIELD-HATCHETT PLAT
 WICHITA, SEDGWICK COUNTY, KANSAS.

OWNER: SCHOLFIELD-HATCHETT PARTNERSHIP
 11212 E. KELLOGG, Wichita, Ks. 67207

ENGINEER: P.E.C. P.A.
 1440 ENGLISH, Wichita, Ks. 67211
 JULY, 1986

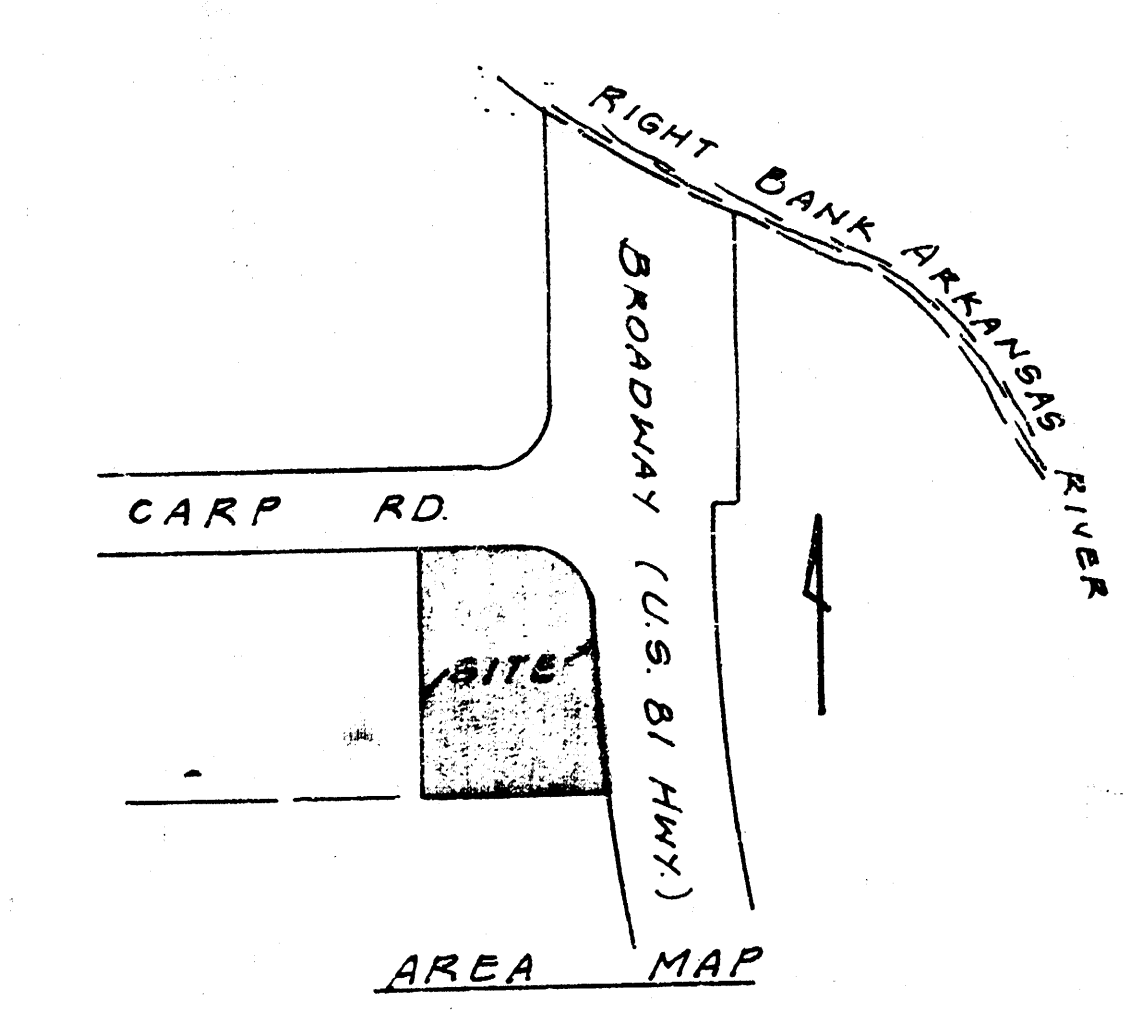

Scale: 1"=10'
 o = Iron Set
 P.P.O. = Power Pole
 L.P.O. = Lamp Post
 M.H. = Manhole

5 D.M. = Dead Man
 O.S.S. M.H. = San. Sewer Manhole

