
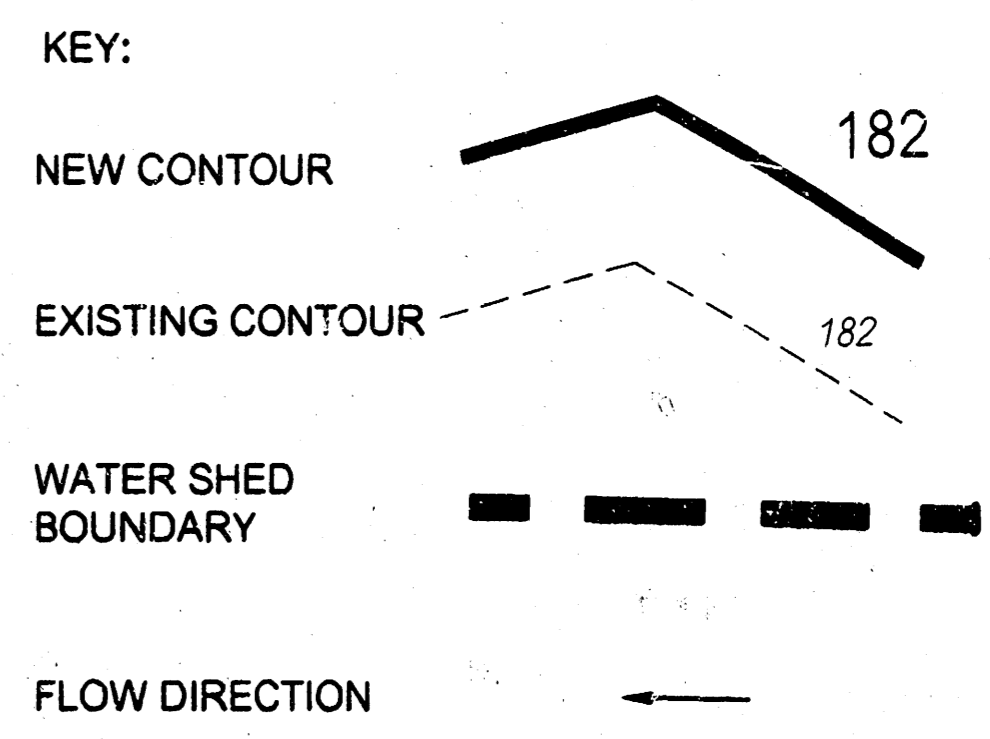


F:\CIVIL\98135.DWG Tue Feb 02 09:36:17 1999

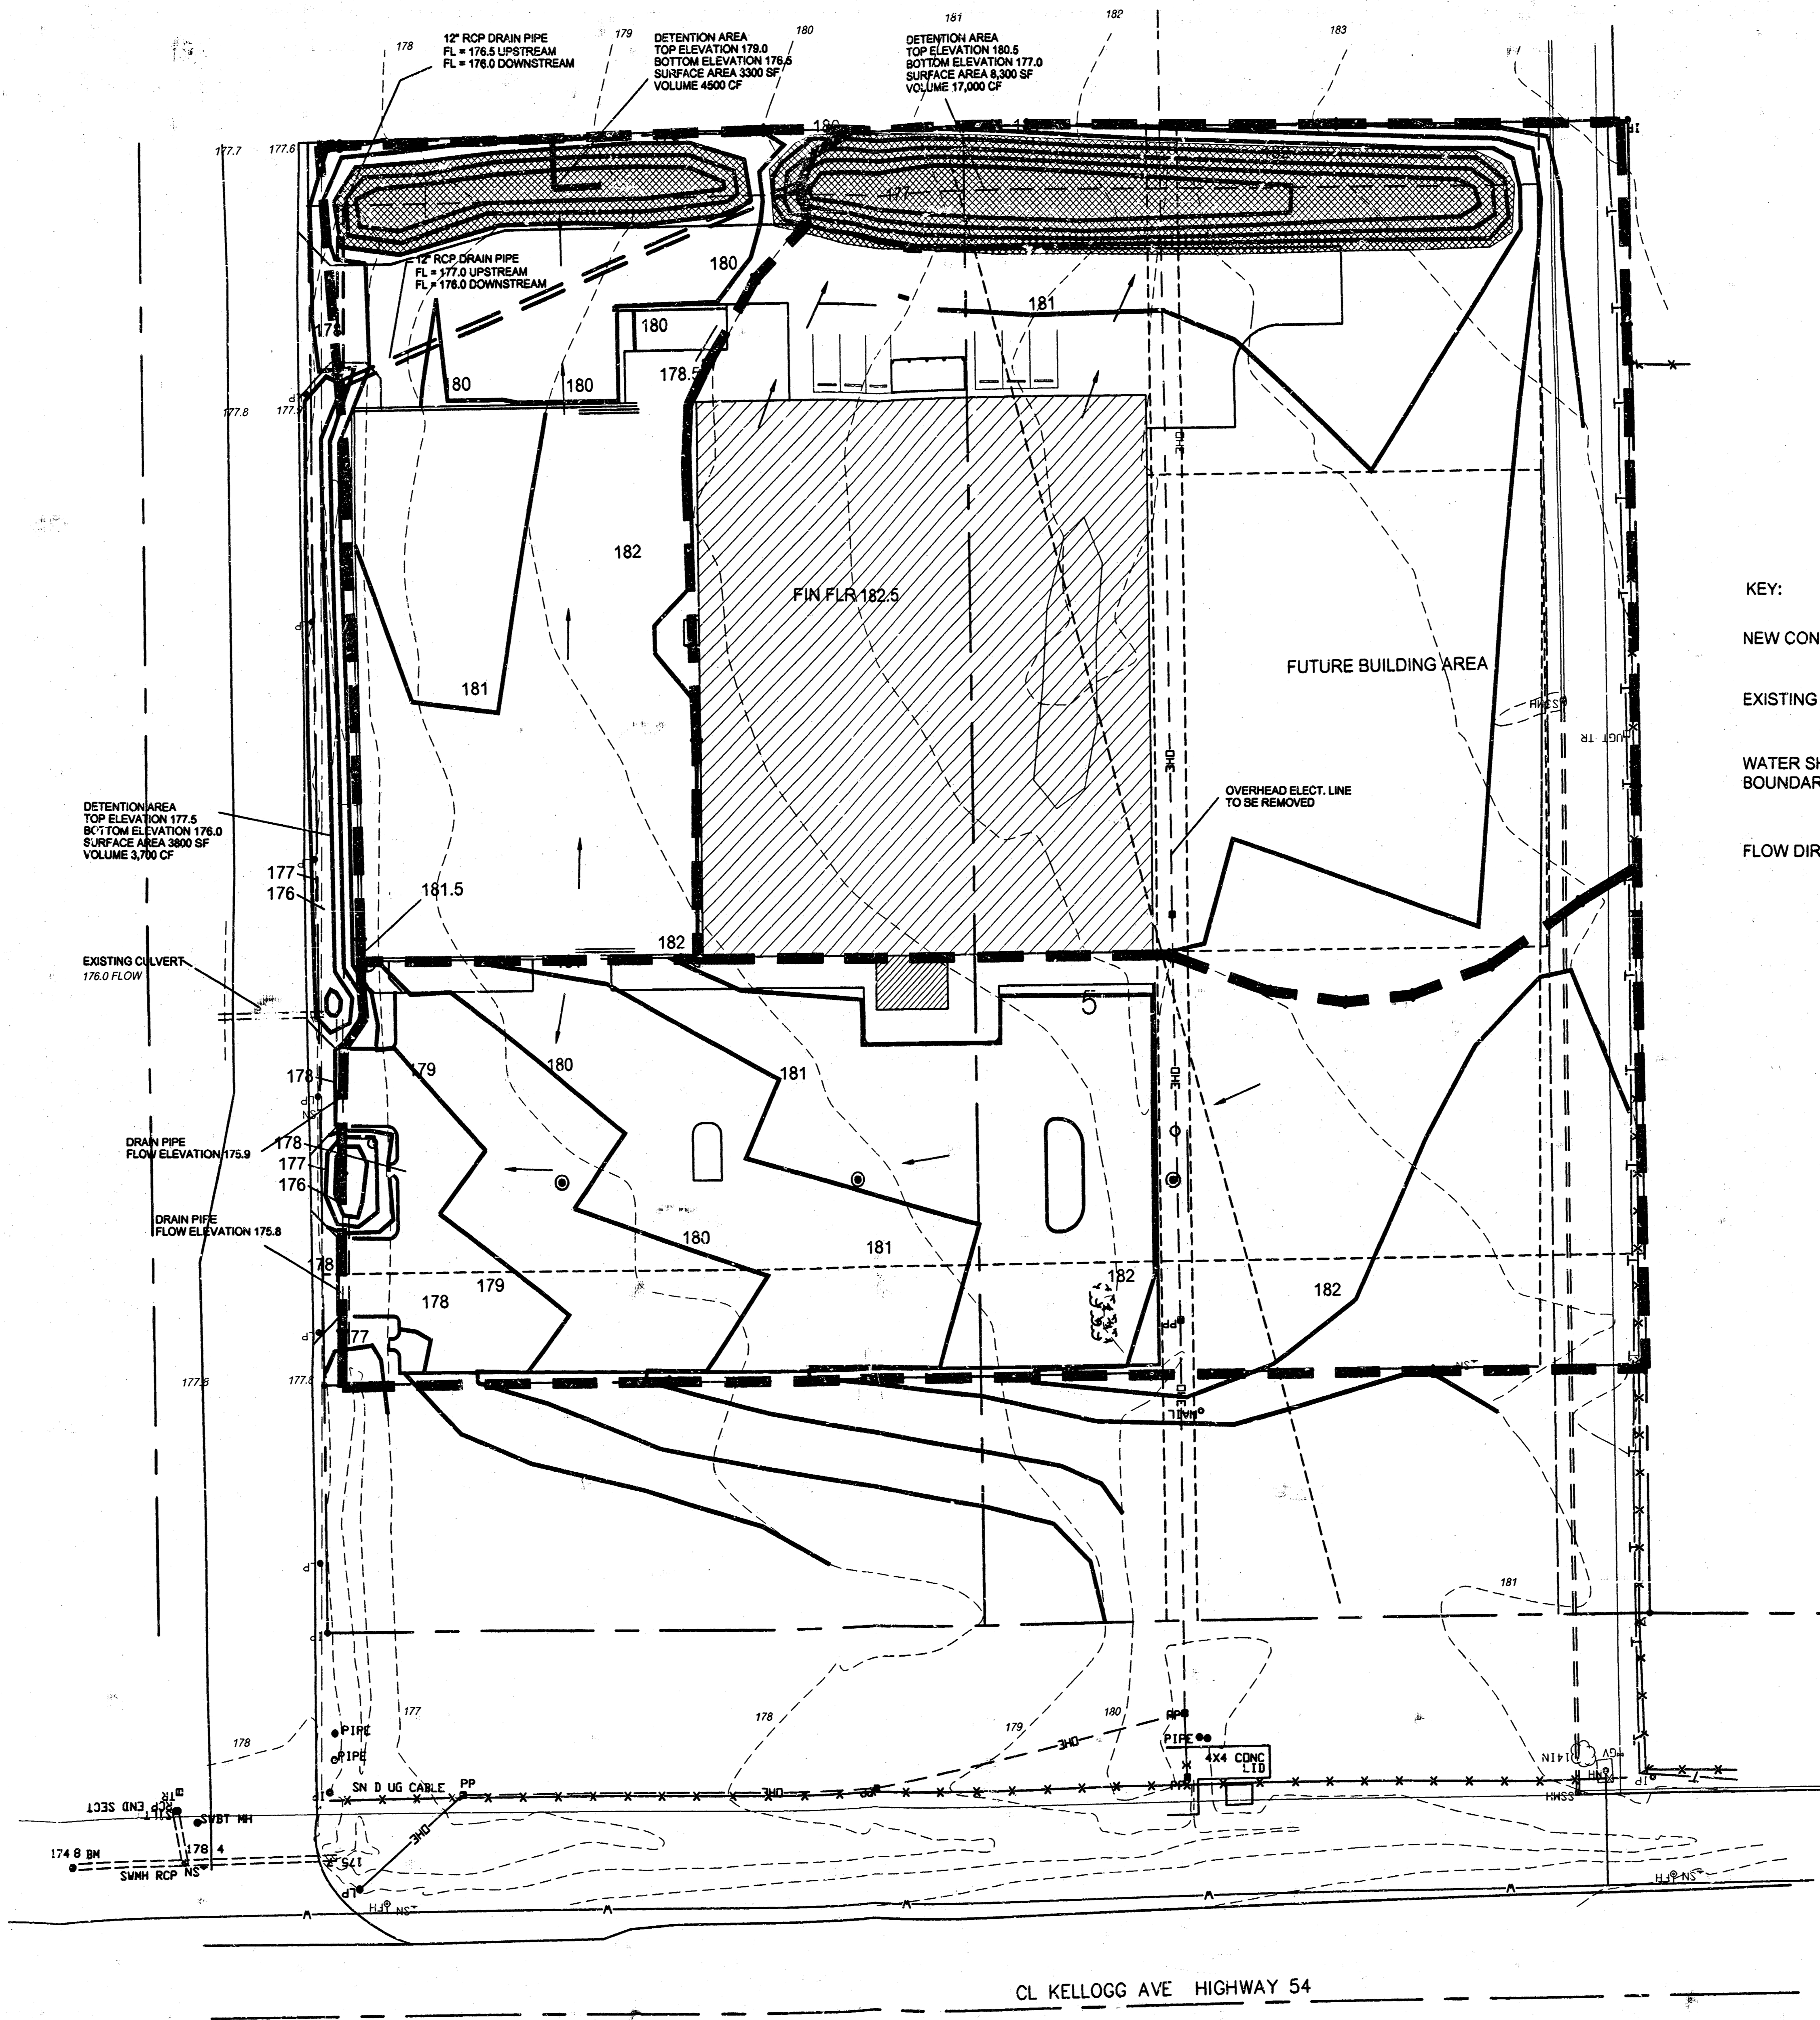

CL KELLOGG AVE HIGHWAY 54

**GRADING & DRAINAGE PLAN**  
SCALE: 1" = 30'

SPANGENBERG • PHILLIPS  
ARCHITECTURE

224 E. Douglas, Fifth Floor Wichita, KS 67202 T 316.267.4002 F 316.267.1509

**TRACTOR SUPPLY COMPANY  
DEVELOPMENT FOR WALTER LEWIS**

KELLOGG AND WEBB ROAD  
WICHITA, KANSAS

TRACTOR SUPPLY COMPANY	
PROJECT NAME	
GRADING & DRAINAGE PLAN	
DESIGN TITLE	
TKM	DAC
DESIGN	DRAWN BY:
TKM	FEB. 1999
CHECKED BY: DATE	
98135	1 / 1
JOB NO.	SHEET/OF
MID-KANSAS ENGINEERING CONSULTANTS, INC.	
411 N WEBB ROAD	
WICHITA, KS 67206	
316-684-9600	

ISSUE	DATE

GRADING PLAN

**SP2**