


FYHA REGION NO.	STATE	PROJECT NO.	YEAR	SHEET NO.	TOTAL SHEETS
7	KS.	87-U-1362-01	199	113	149

SCALE: 1" = 100'

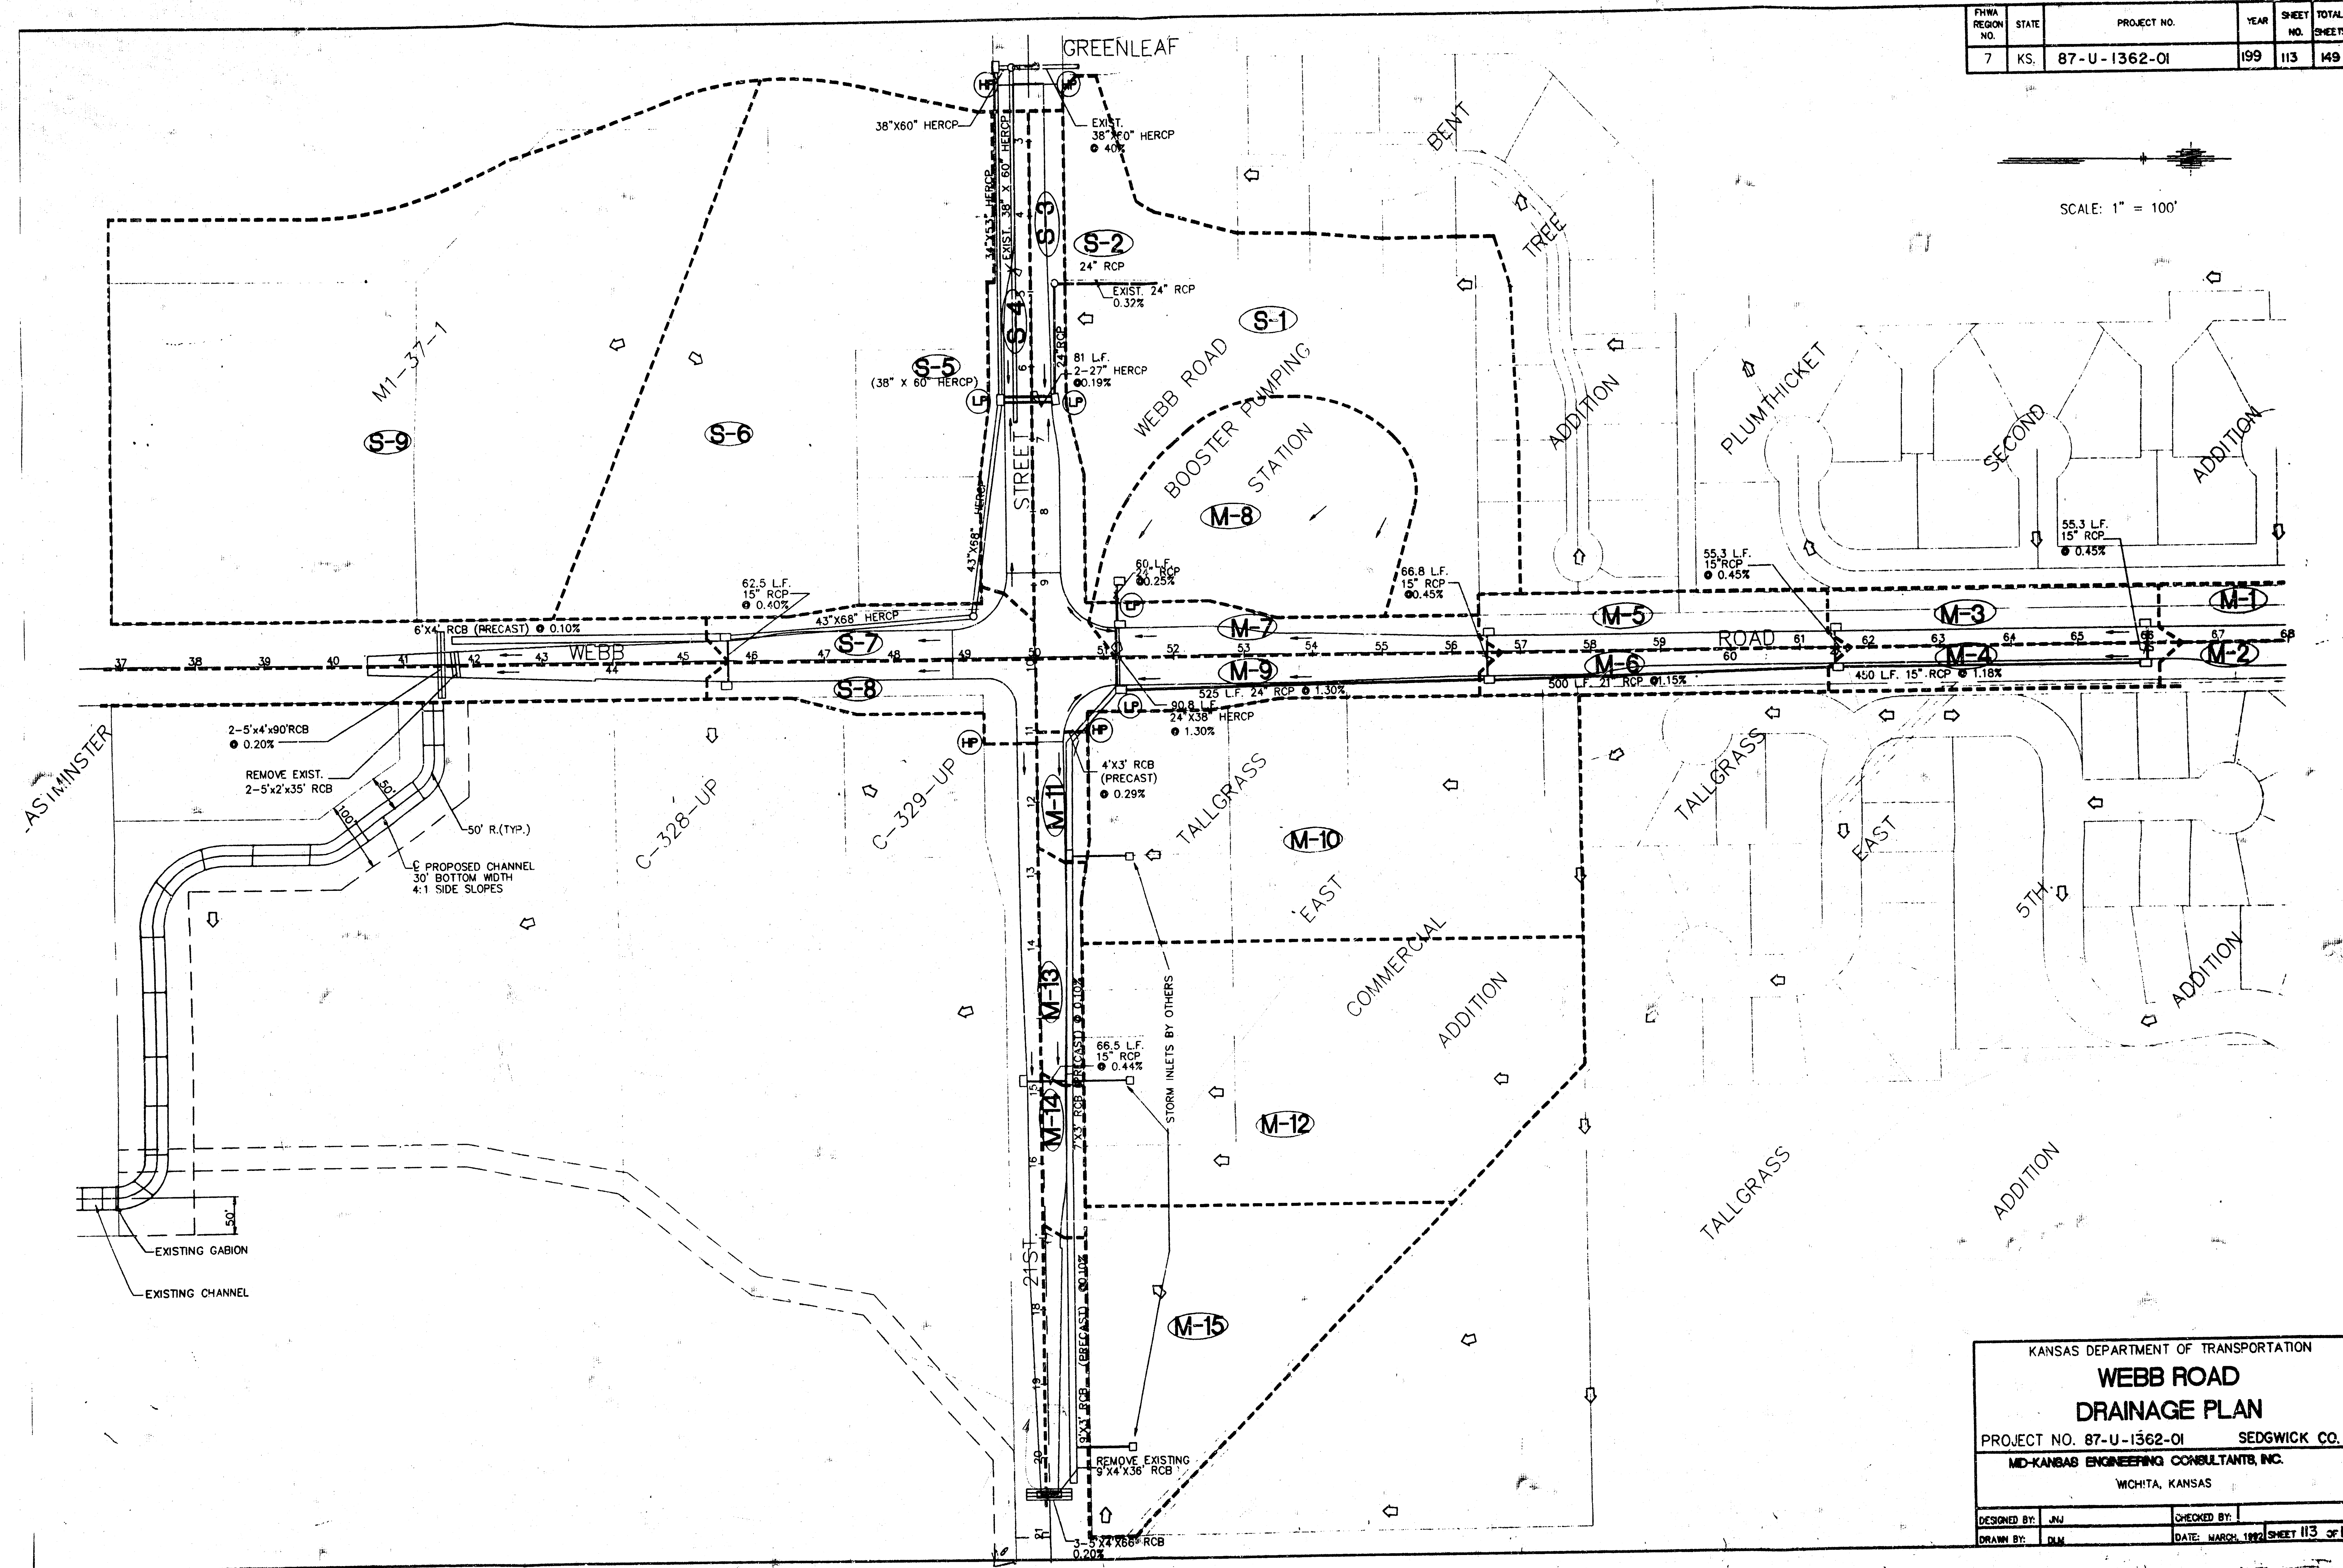

KANSAS DEPARTMENT OF TRANSPORTATION	
WEBB ROAD	
DRAINAGE PLAN	
PROJECT NO. 87-U-1362-01	SEDGWICK CO.
MO-KANSAS ENGINEERING CONSULTANTS, INC.	
WICHITA, KANSAS	
DESIGNED BY: JLN	CHECKED BY:
DRAWN BY: JLN	DATE: MARCH 1992 SHEET 113 OF 149