


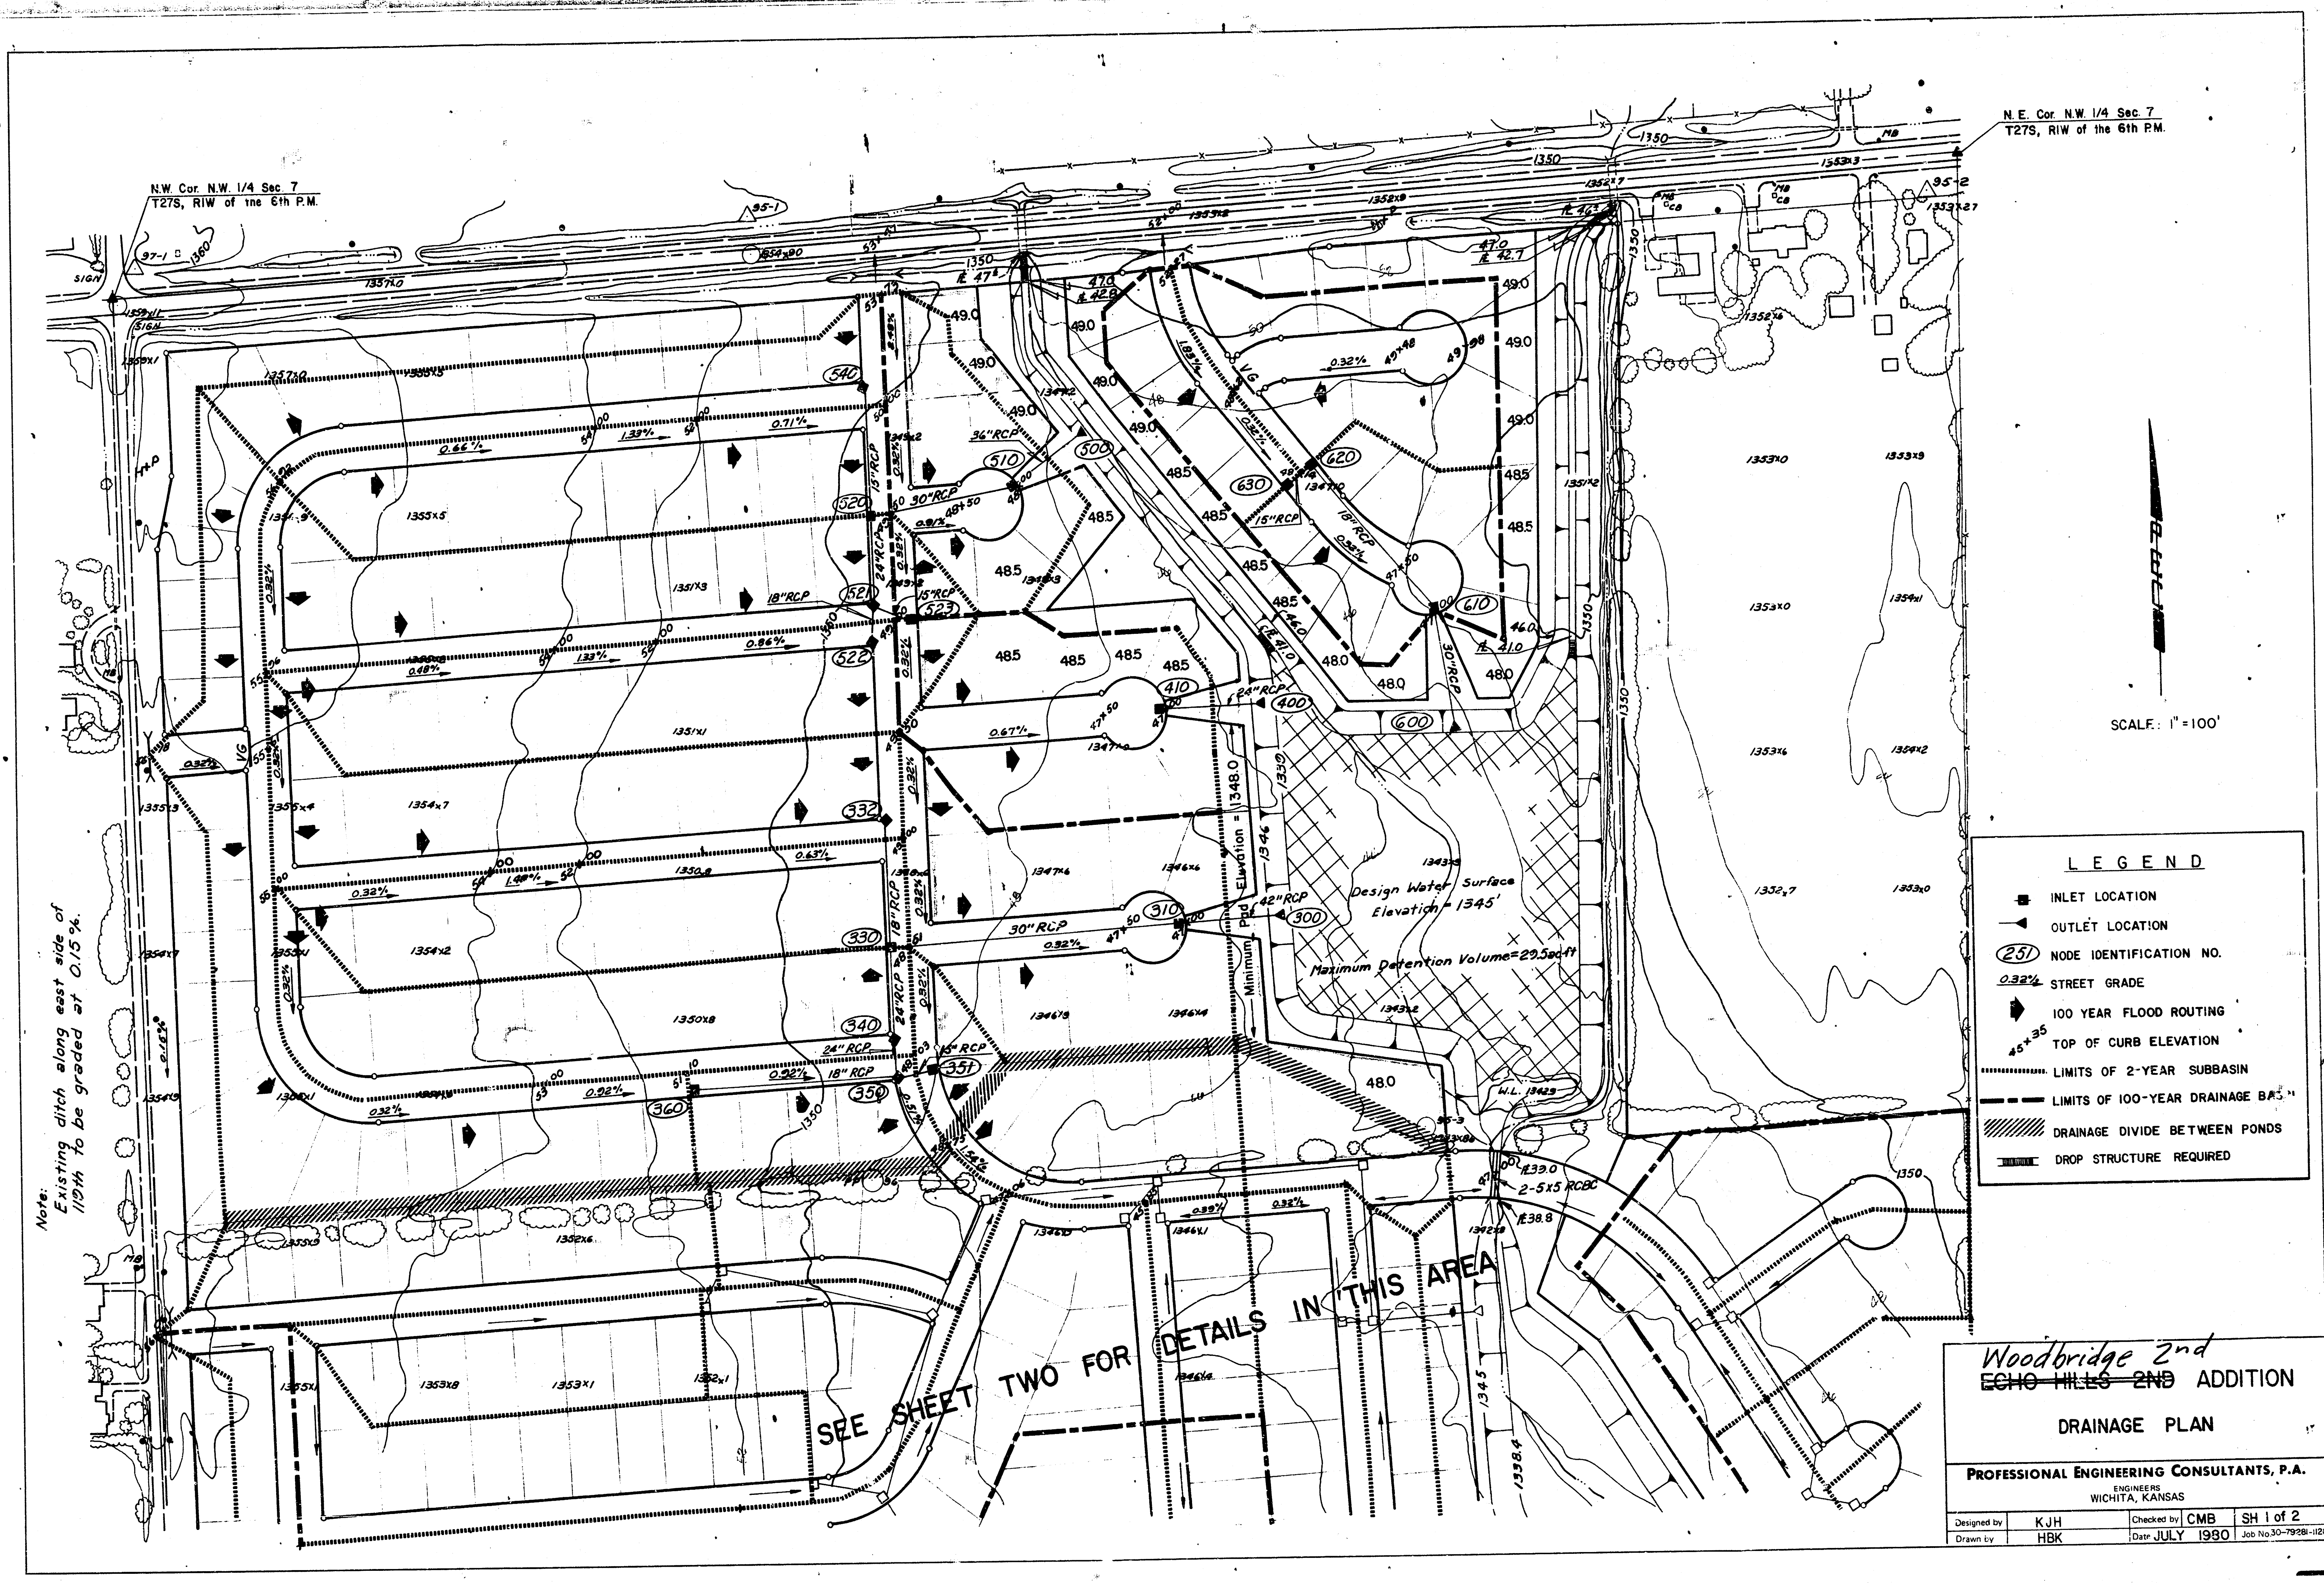

Woodbridge 2nd
ECHO HILLS 2ND ADDITION

DRAINAGE PLAN

PROFESSIONAL ENGINEERING CONSULTANTS, P.A.
ENGINEERS
WICHITA, KANSAS

Designed by	K.J.H.	Checked by	C.M.B.	SH 1 of 2
Drawn by	H.B.K.	Date	JULY 1980	Job No. 30-7958-100