


Install 500 L.F. cut-off trench per detail, sheet 8.

Construct temporary ditching to ensure positive drainage of sump areas. See detail, sheet 7.

Scale: 1" = 60'

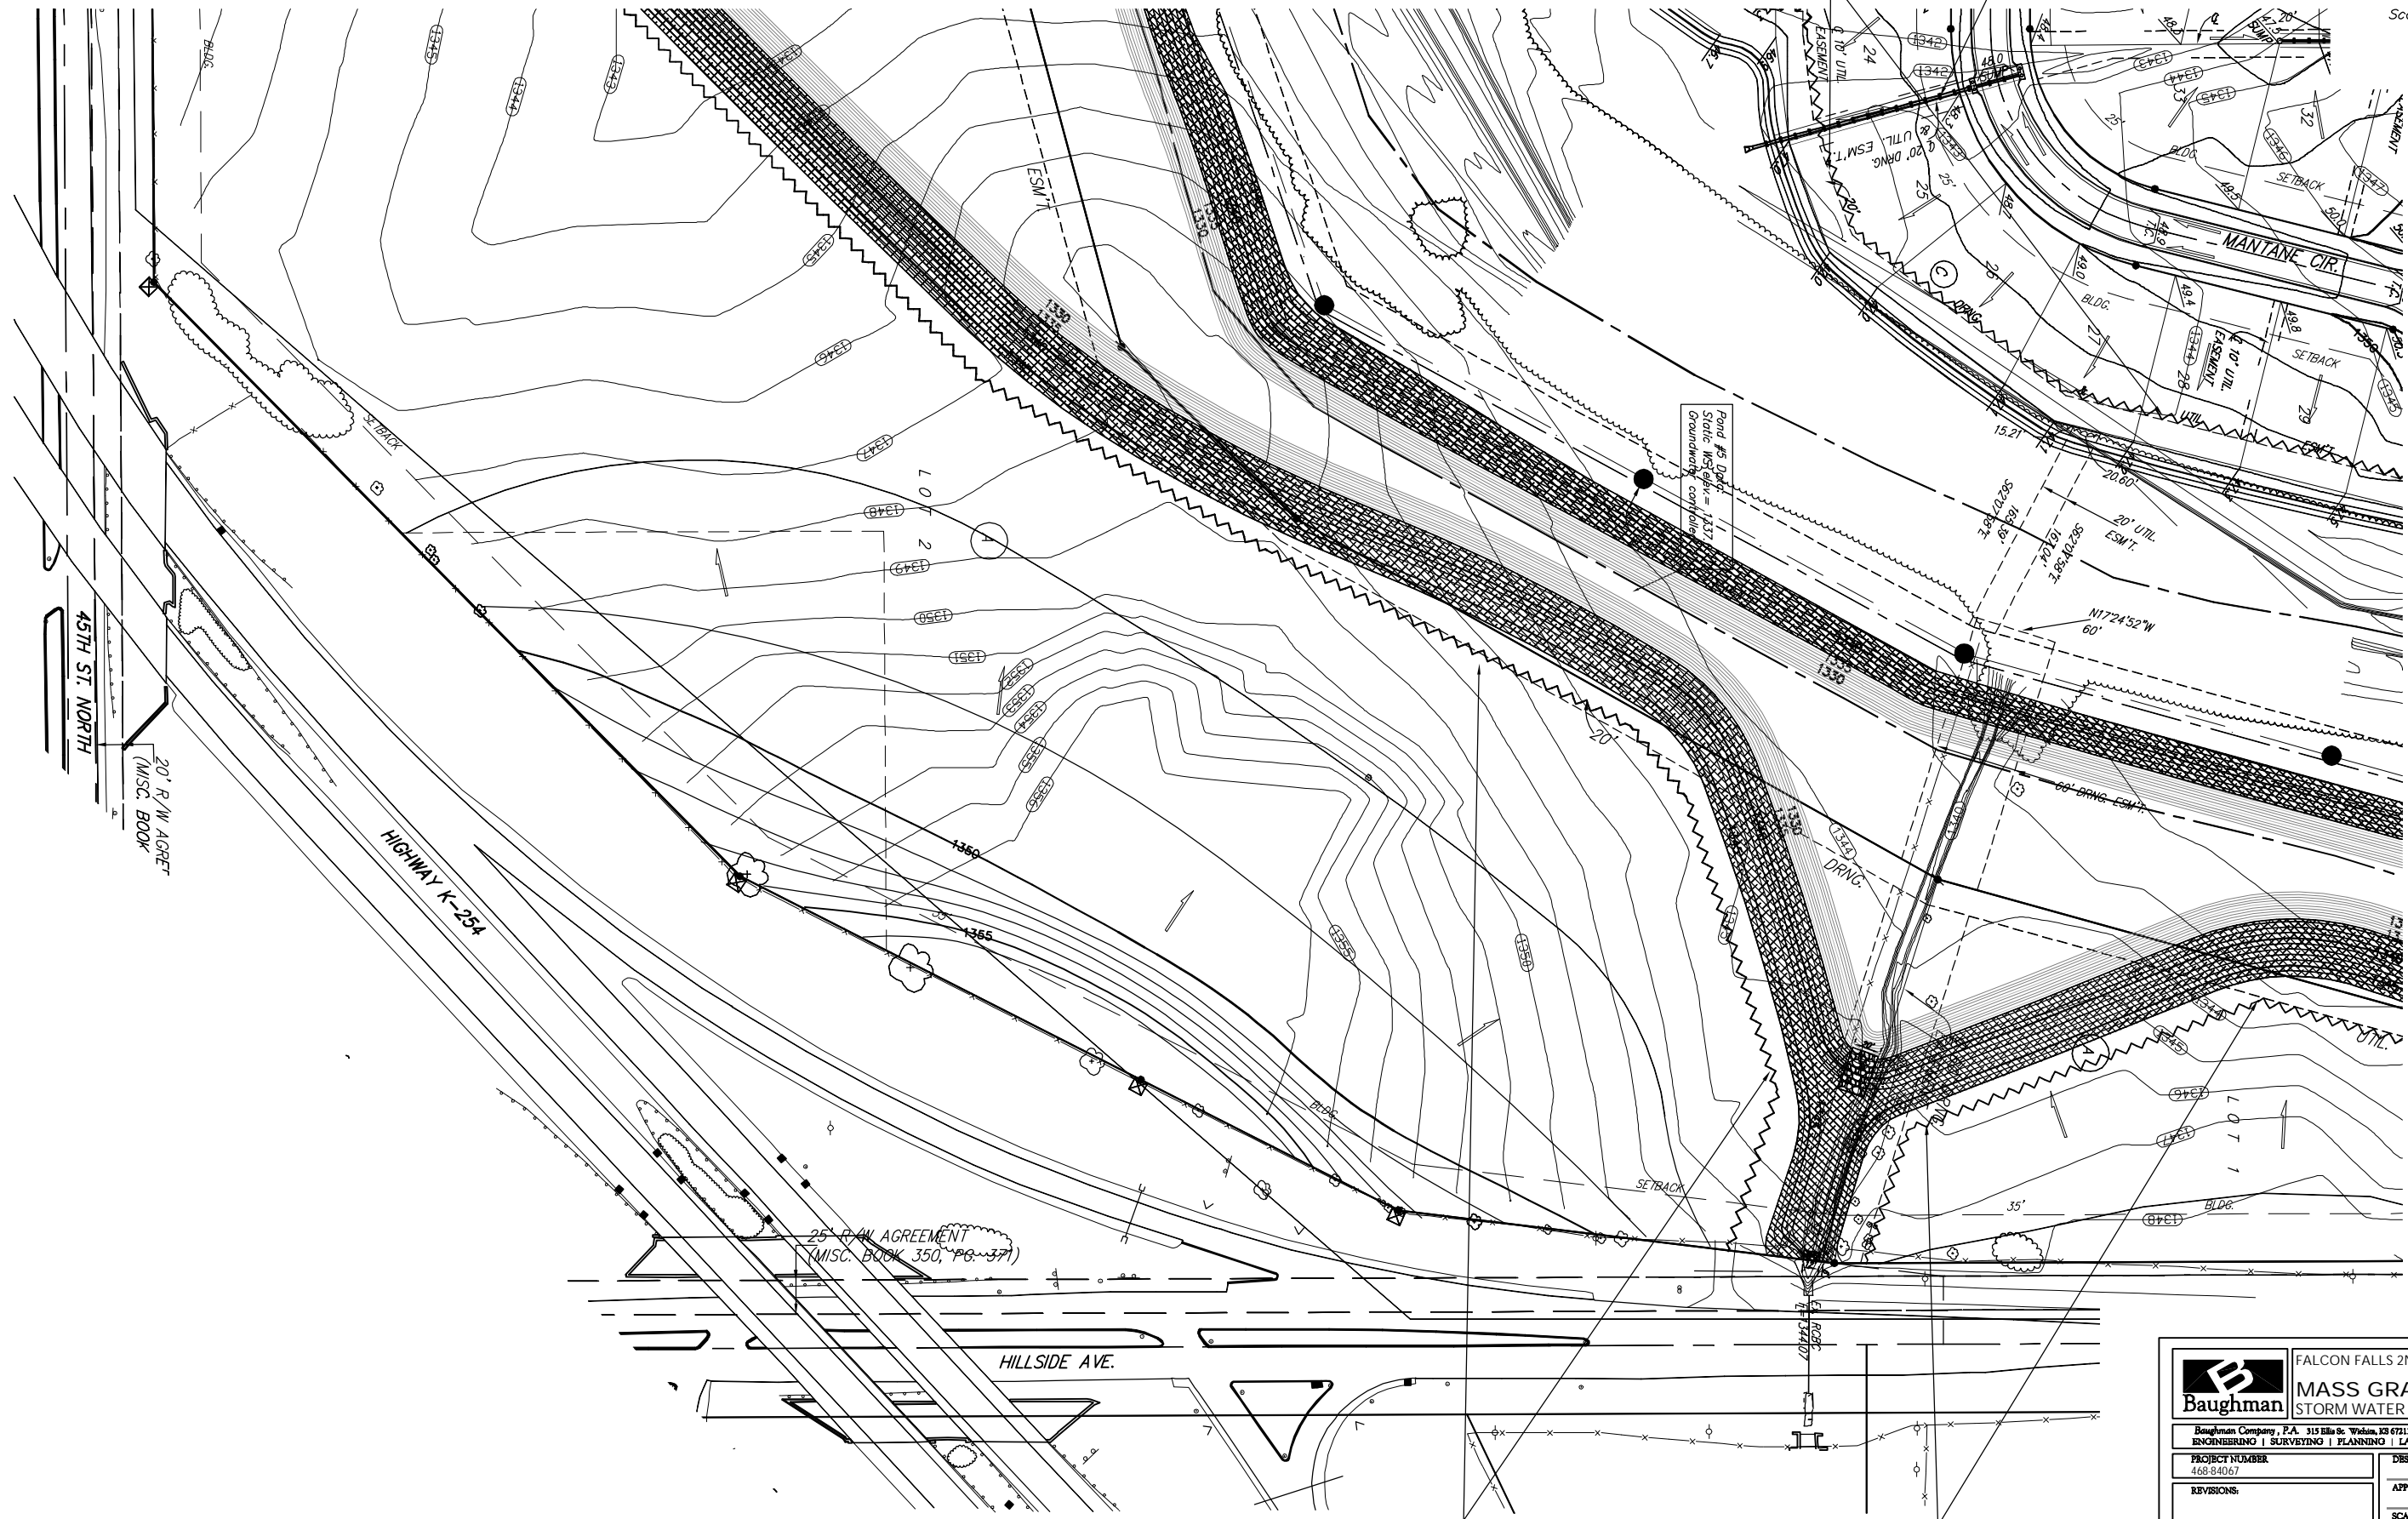

Pond #3 Data:
State WS# 1337
Groundwater conflicts

25' R/W AGREEMENT
(MISC. BOOK 350, PG. 377)

Install 1,283 L.F. cut-off trench per detail, sheet 8.

Install 465 L.F. cut-off trench per detail, sheet 8.

	FALCON FALLS 2ND/3RD/COMM. ADD.	
	MASS GRADING PLAN STORM WATER DRAIN #275	
<small>Baughman Company, P.A. 315 Ellis St. Wichita, KS 67211 F 316-262-7271 F 316-262-0149 ENGINEERING SURVEYING PLANNING LANDSCAPE ARCHITECTURE</small>		
PROJECT NUMBER 468-84067	DESIGN AEG	DRAWN TMS
REVISIONS:	APPROVED	DATE 01/06
	SCALE Noted	SHEET
		6 OF 39