



FEDERAL REGION NO.	STATE	PROJECT NO.	YEAR	SHEET NO.	TOTAL SHEETS
7	KANSAS	(BC) 96-87-K044-1(28)	1978	111	143

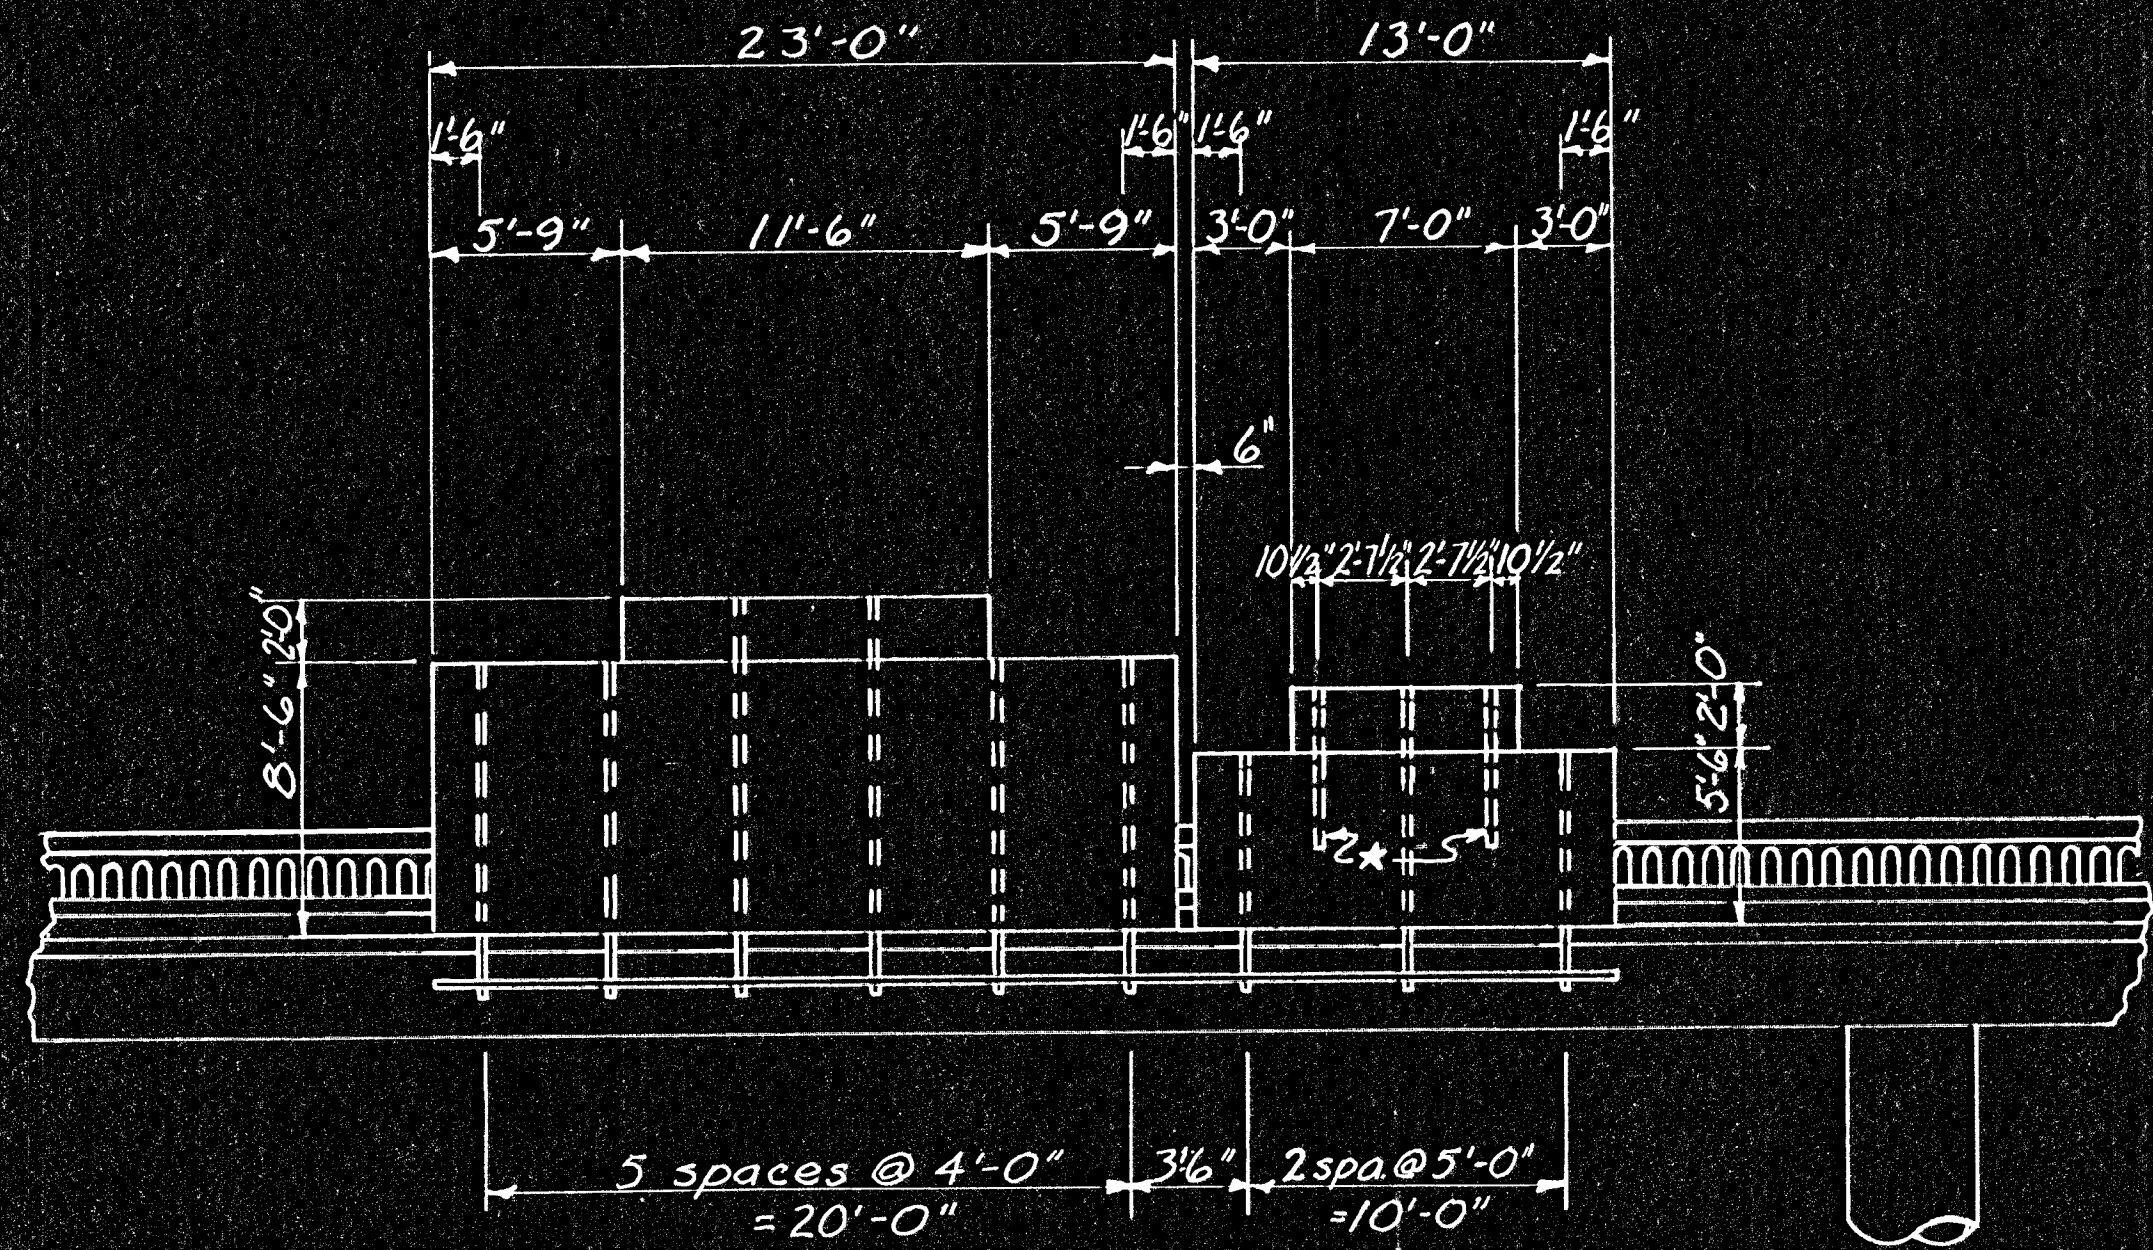

ELEVATION

*Note: Mount the Exit Number sign with two 312.25 x 5'-0" aluminum beams. Refer to the "Mounting of Structural Sign Panel" sheet. These beams shall be included in the linear feet of the bid item "312.25 Aluminum I-Beam."

Note: Bridge Mounted Sign Attachment shall be grounded by means of #6 A.W.G. insulated copper ground wire carried on structure and down pier in 1/2" conduit. Conduit clamps on 6" centers. See "Sign Lighting Fixtures and Electrical Details" sheet.

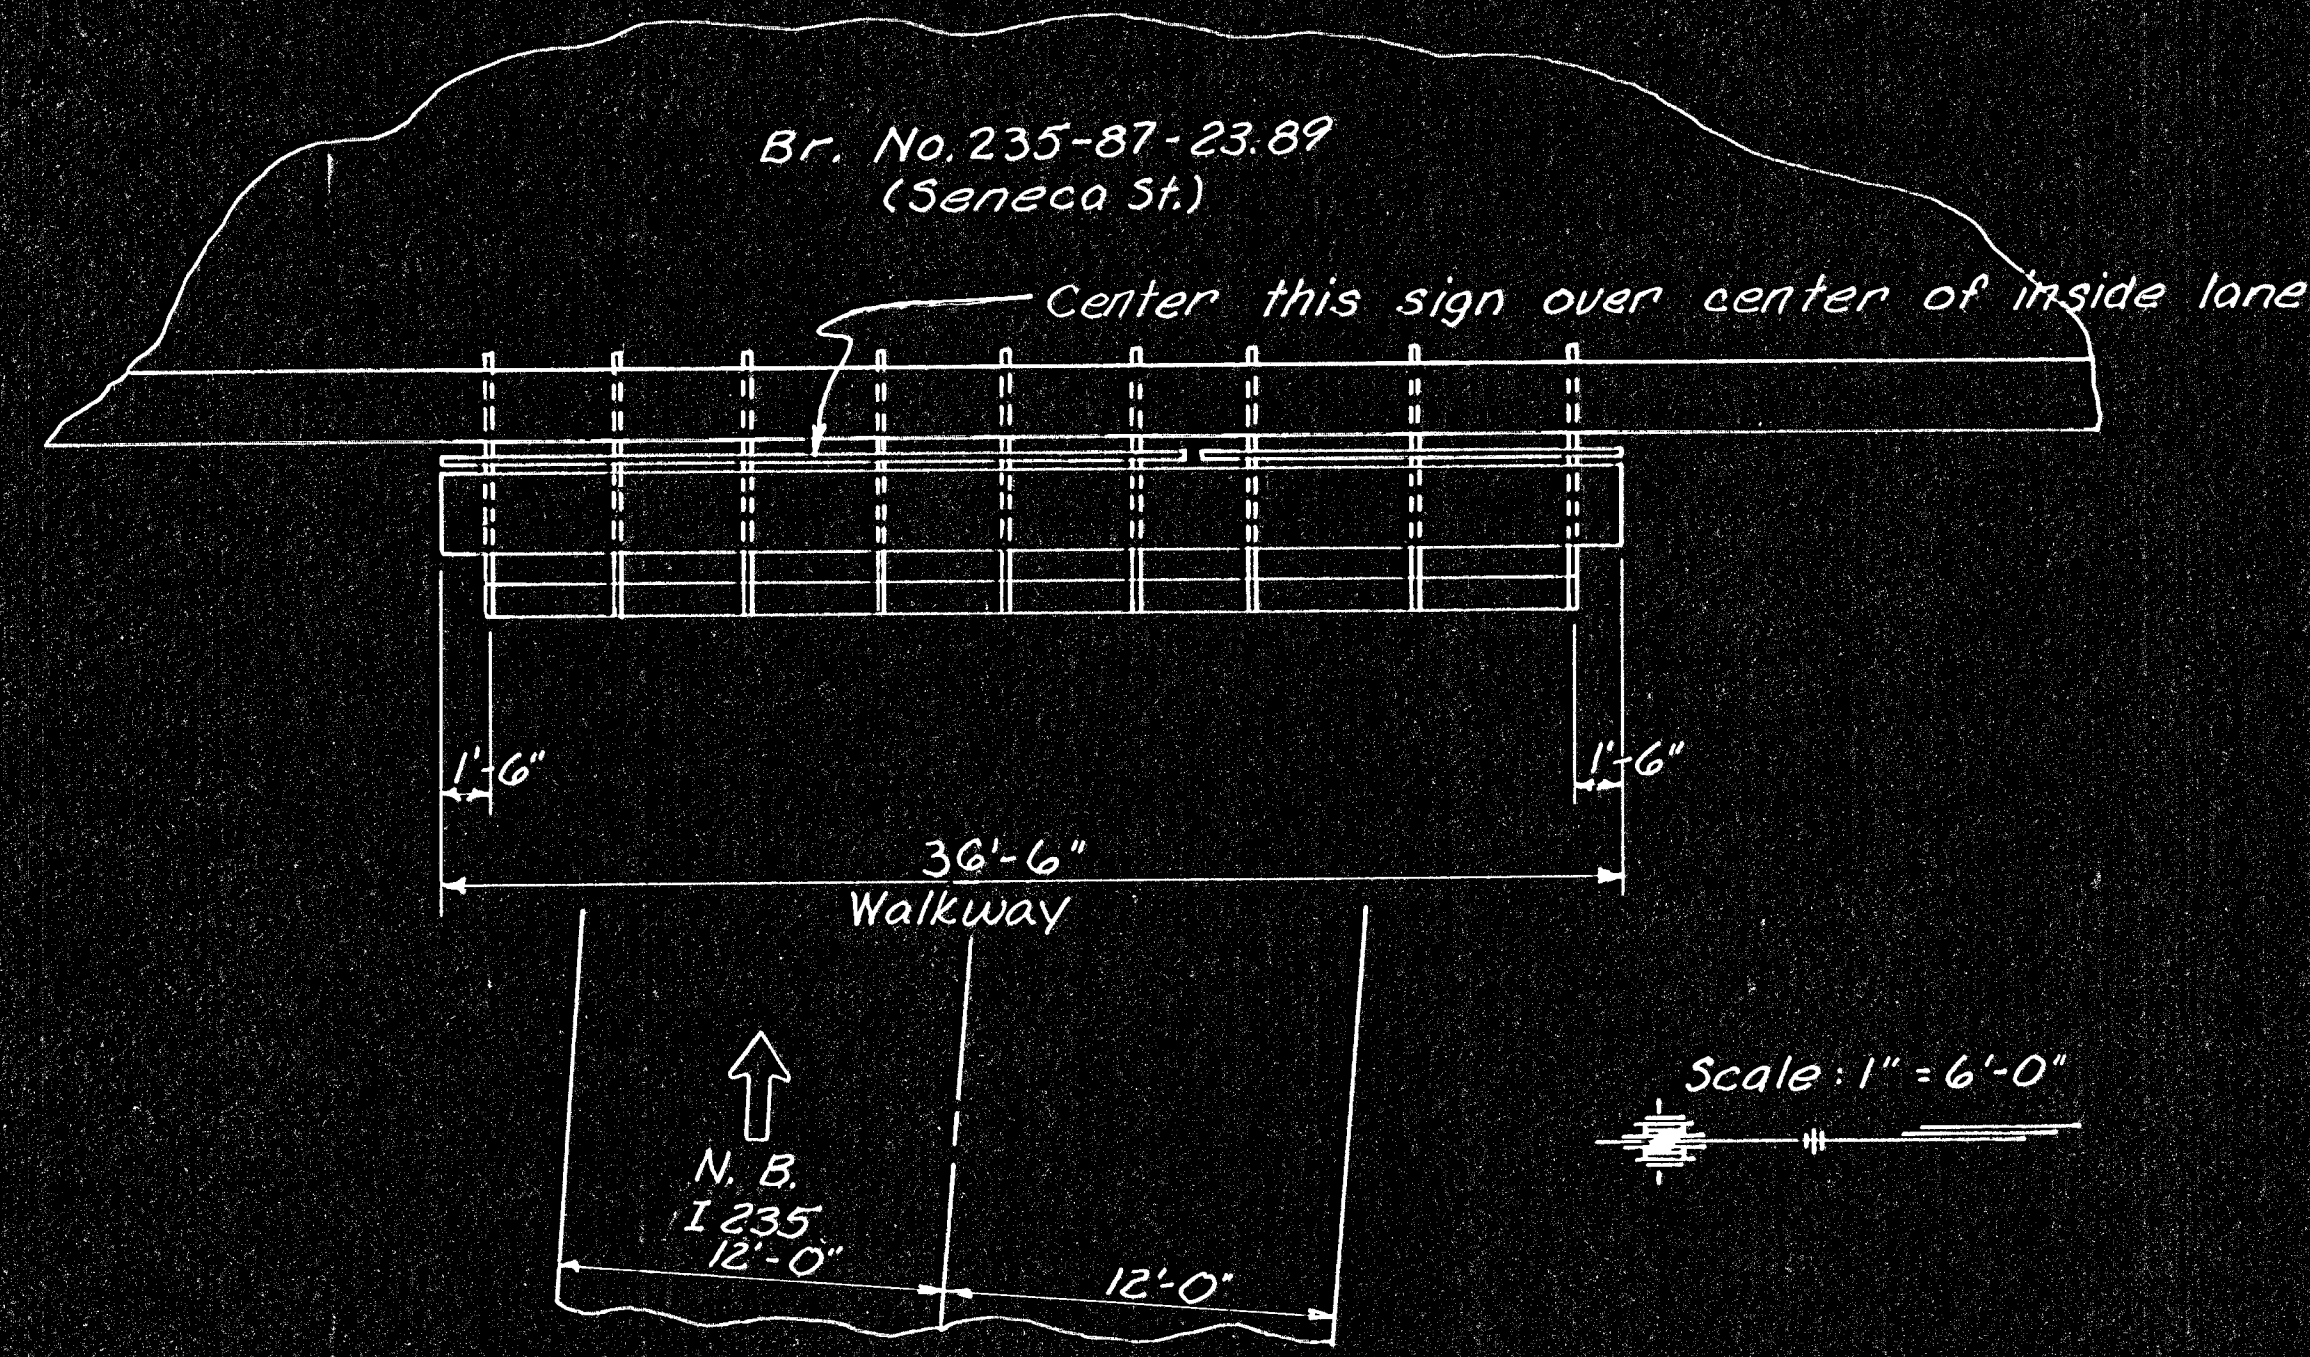

PLAN

Scale: 1" = 6'-0"

3					
2					
1					
NO.	DATE	REVISIONS	BY	APP'D.	
KANSAS DEPARTMENT OF TRANSPORTATION					
N.B. I 235			BR. NO. 235-87-2389		
CONSTRUCTION LAYOUT BRIDGE MOUNTED SIGN ATTACHMENT					
PROJ. NO. (BC) 96-87-K044-1(28) SEDGWICK CO.					
SHEET NO. 111 OF 143	SCALE	APP'D.	QUANTITIES	TRACED	S.D.
DESIGNED L.E.S.	DETAILED L.E.S.	QUAN. CK.	TRACED	S.D.	
DESIGN CK. D.R.E.	DETAIL CK. D.R.E.	QUAN. CK.	TRACED	CK. L.E.S.	