

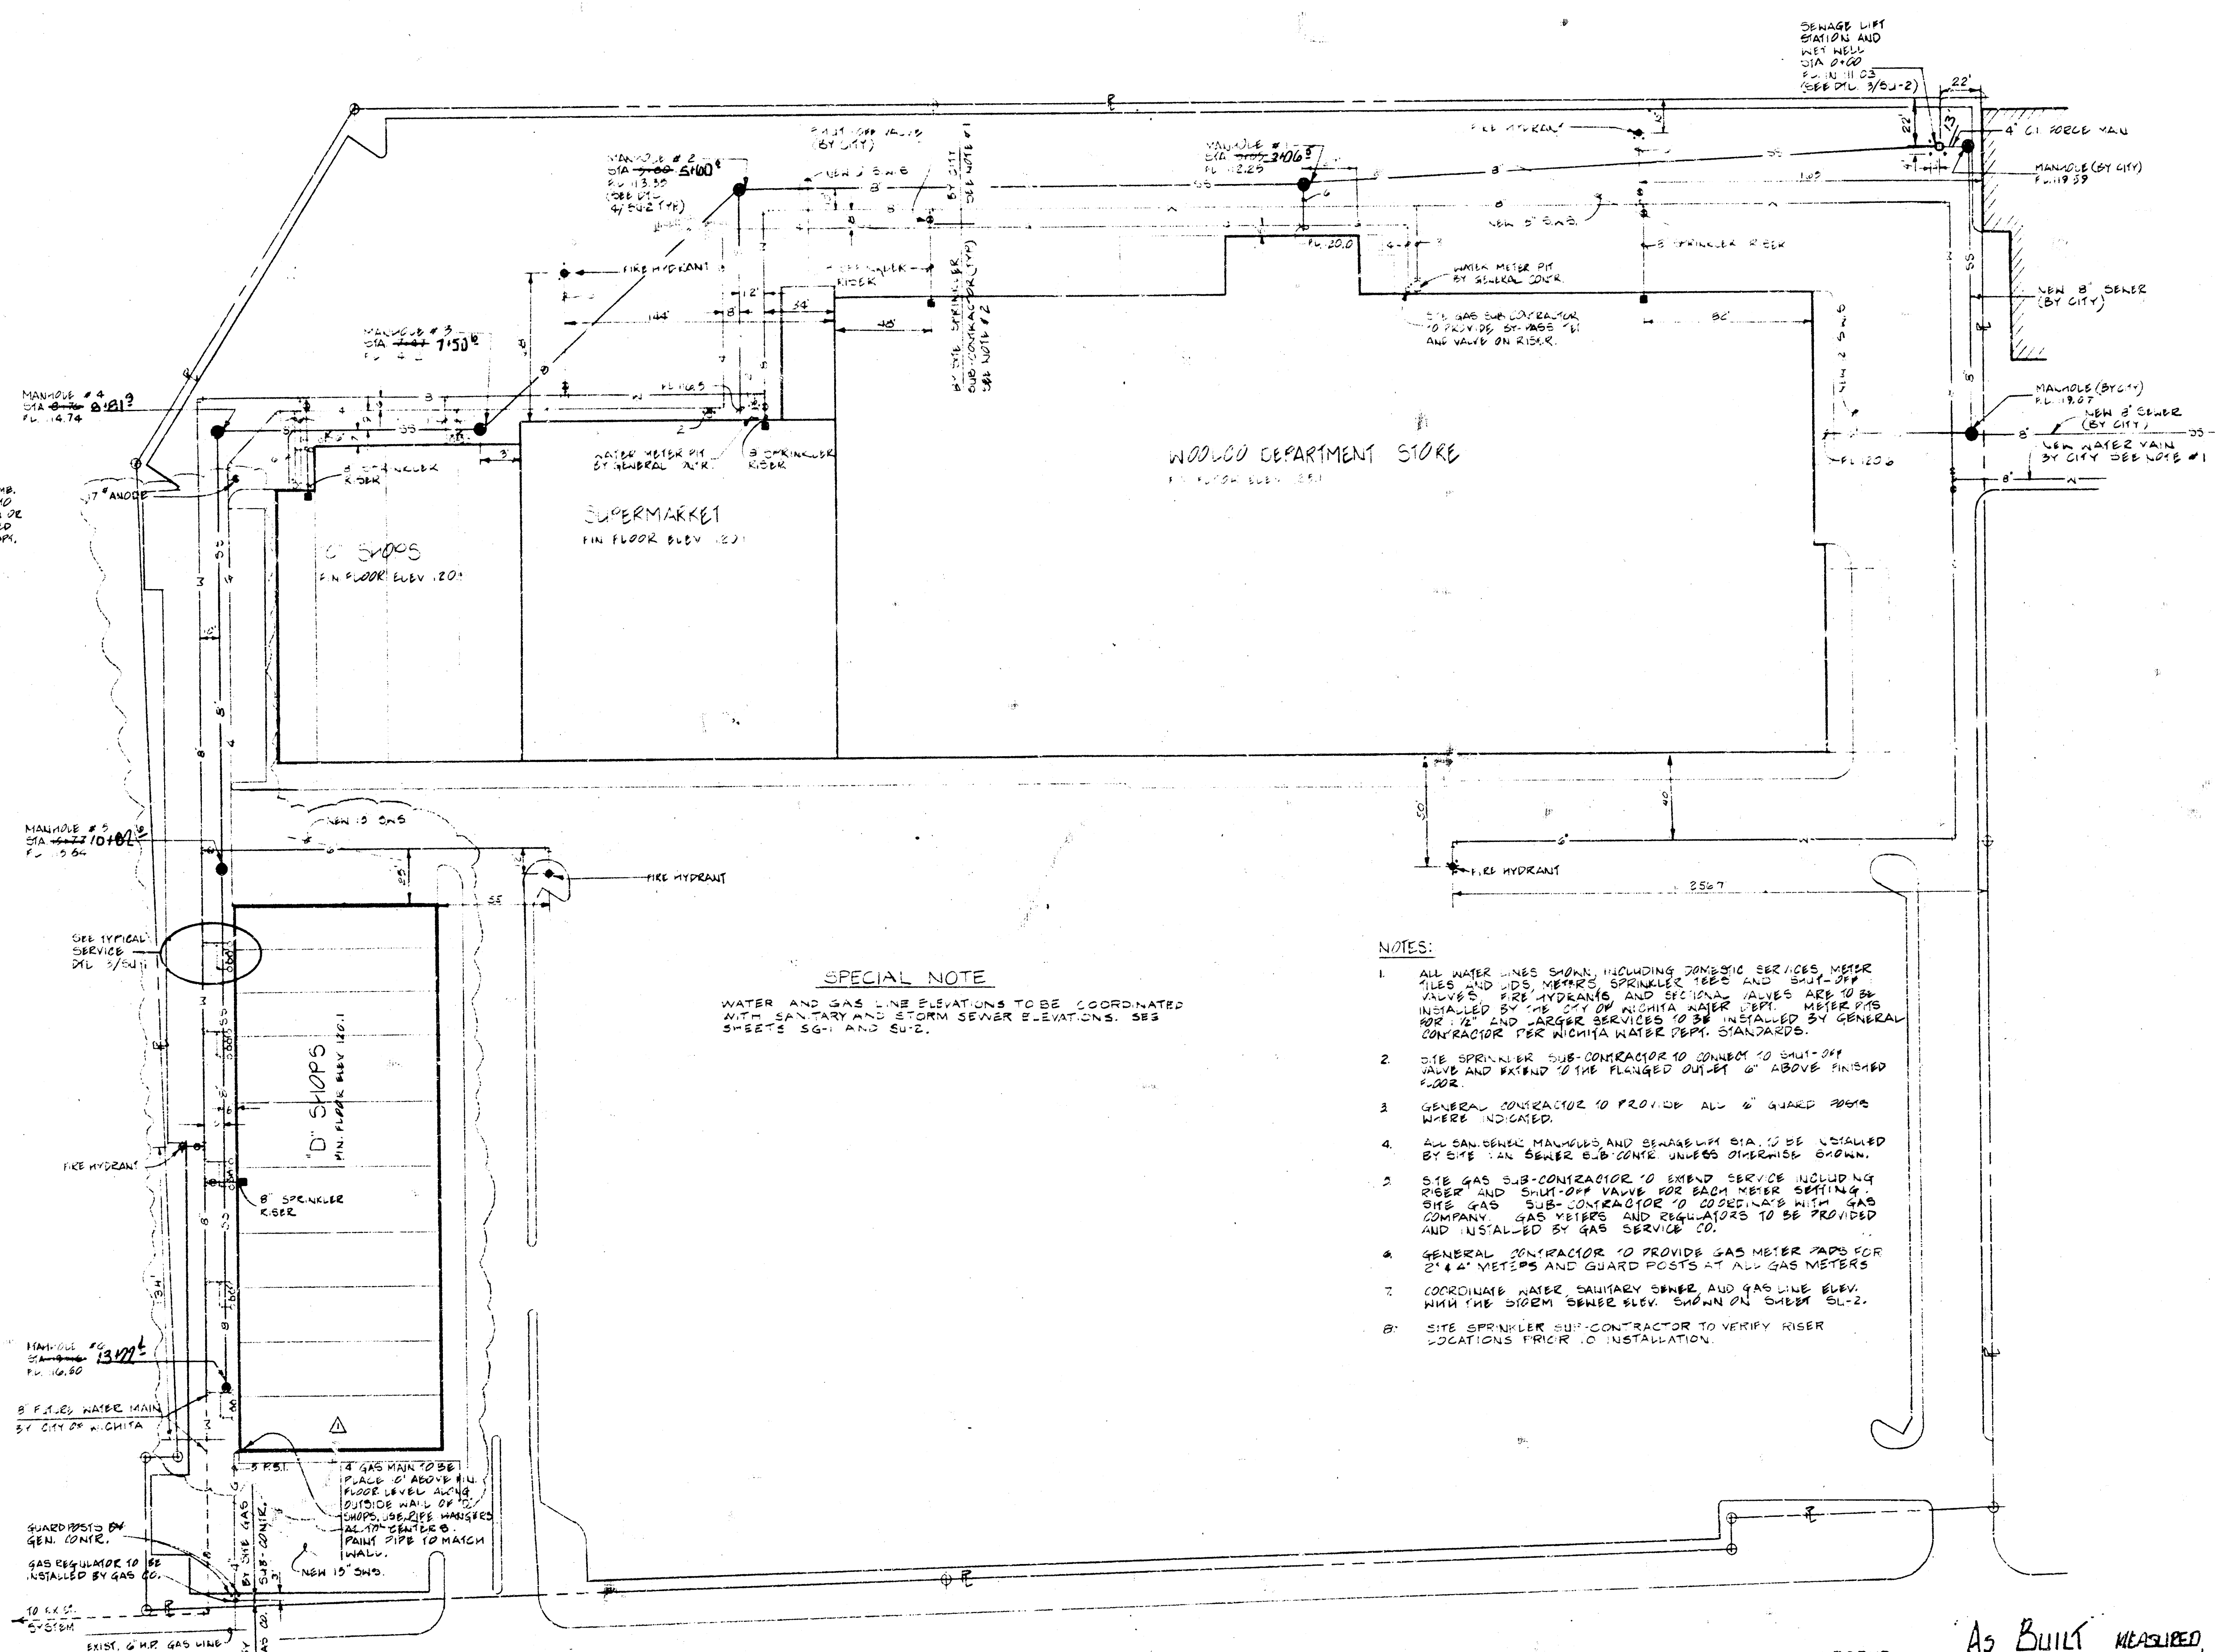
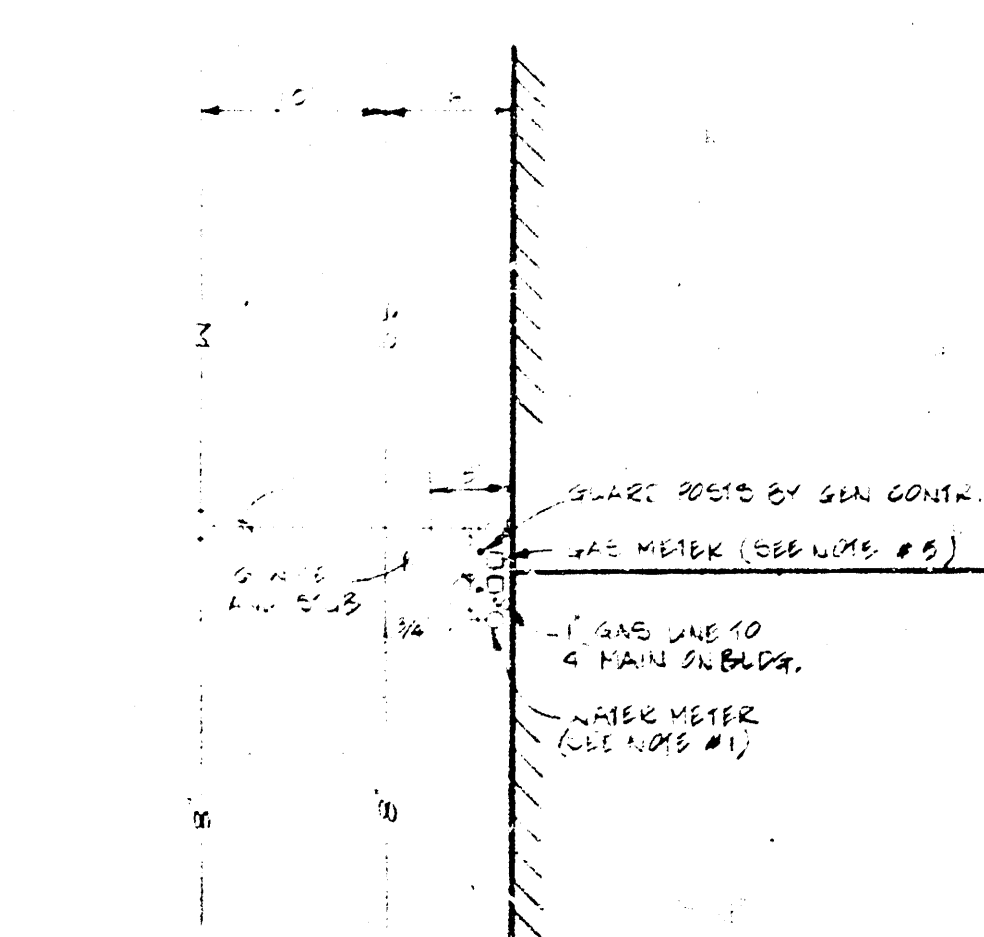
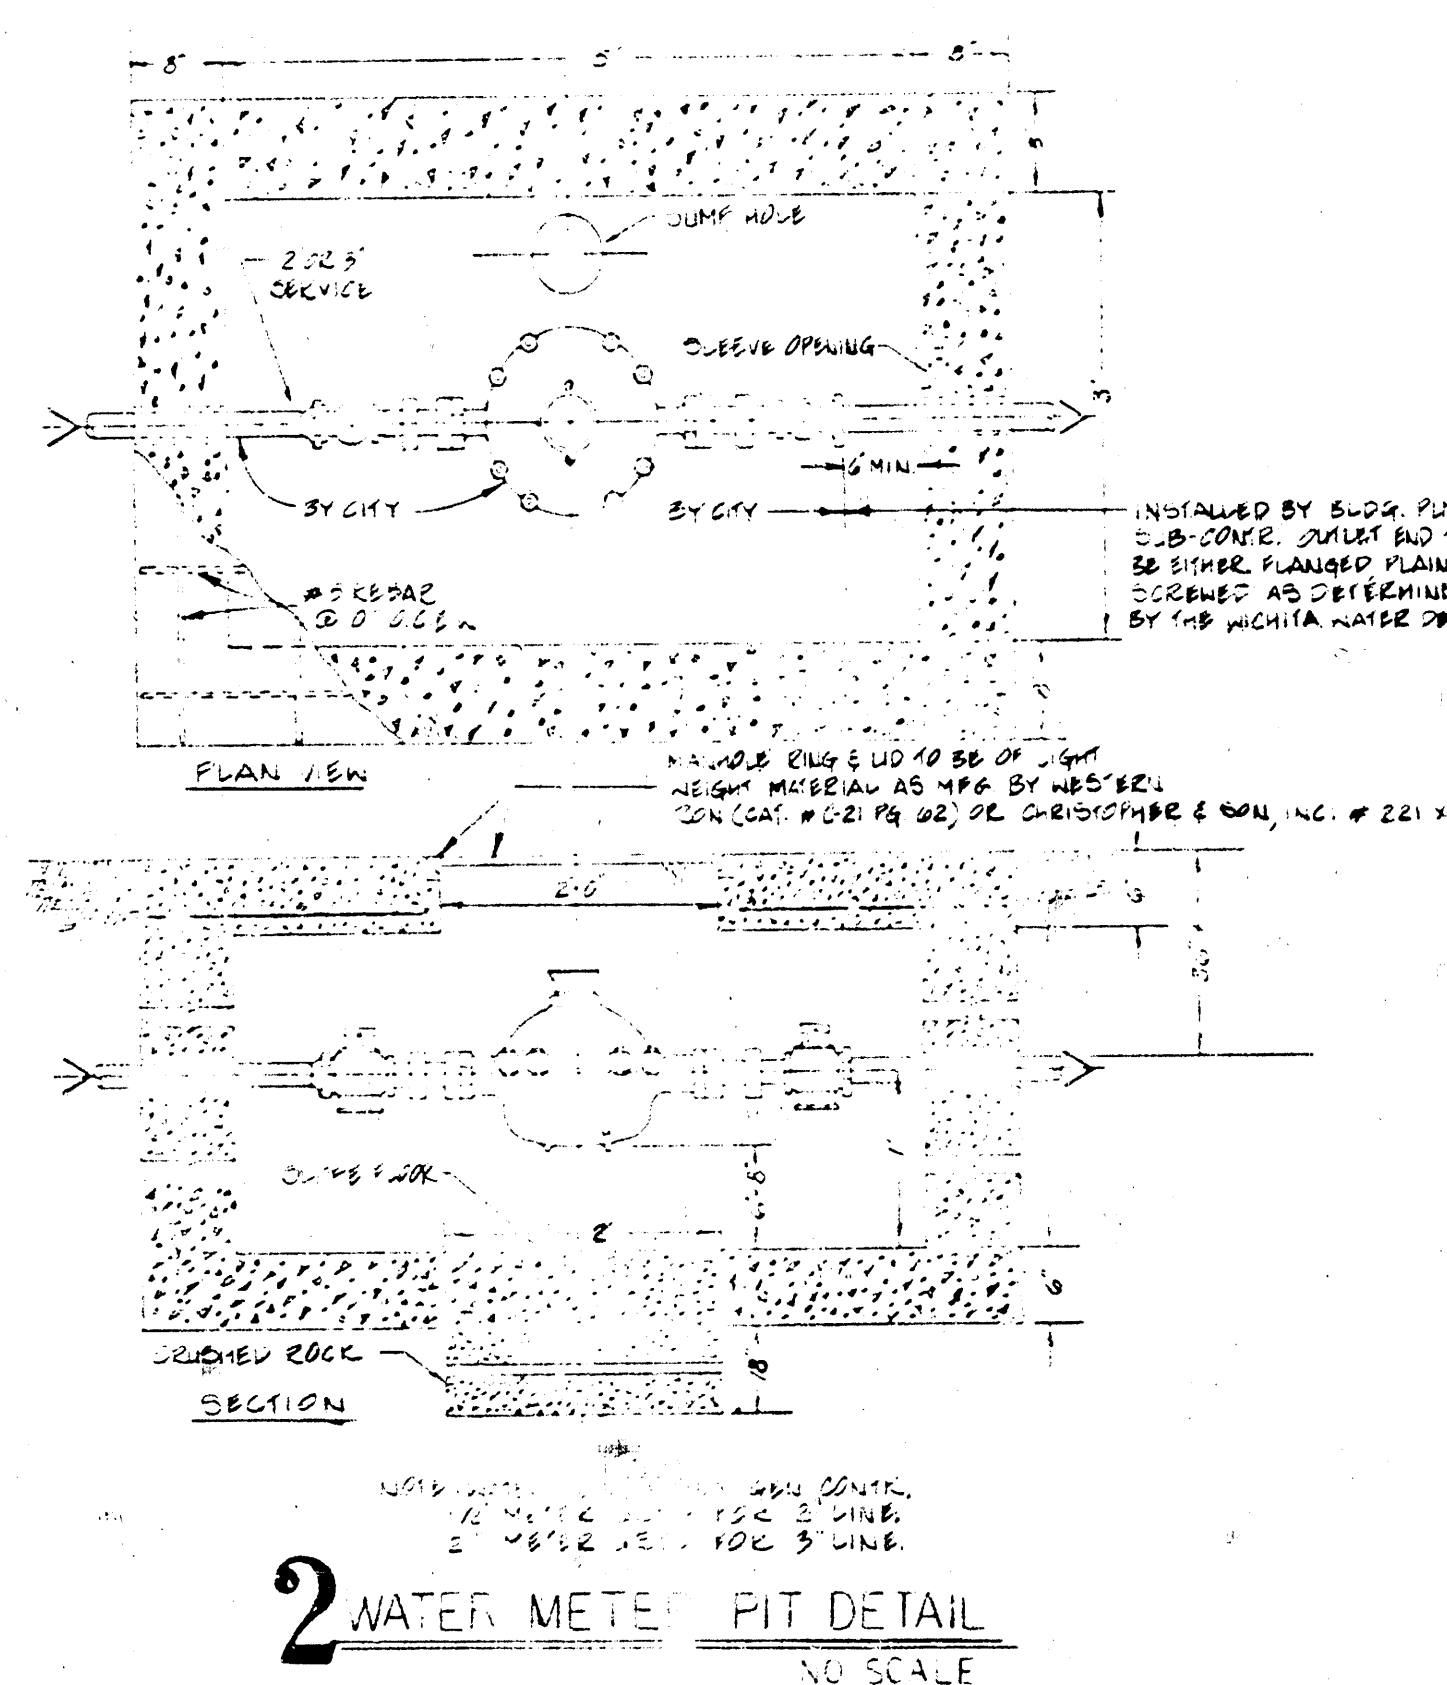


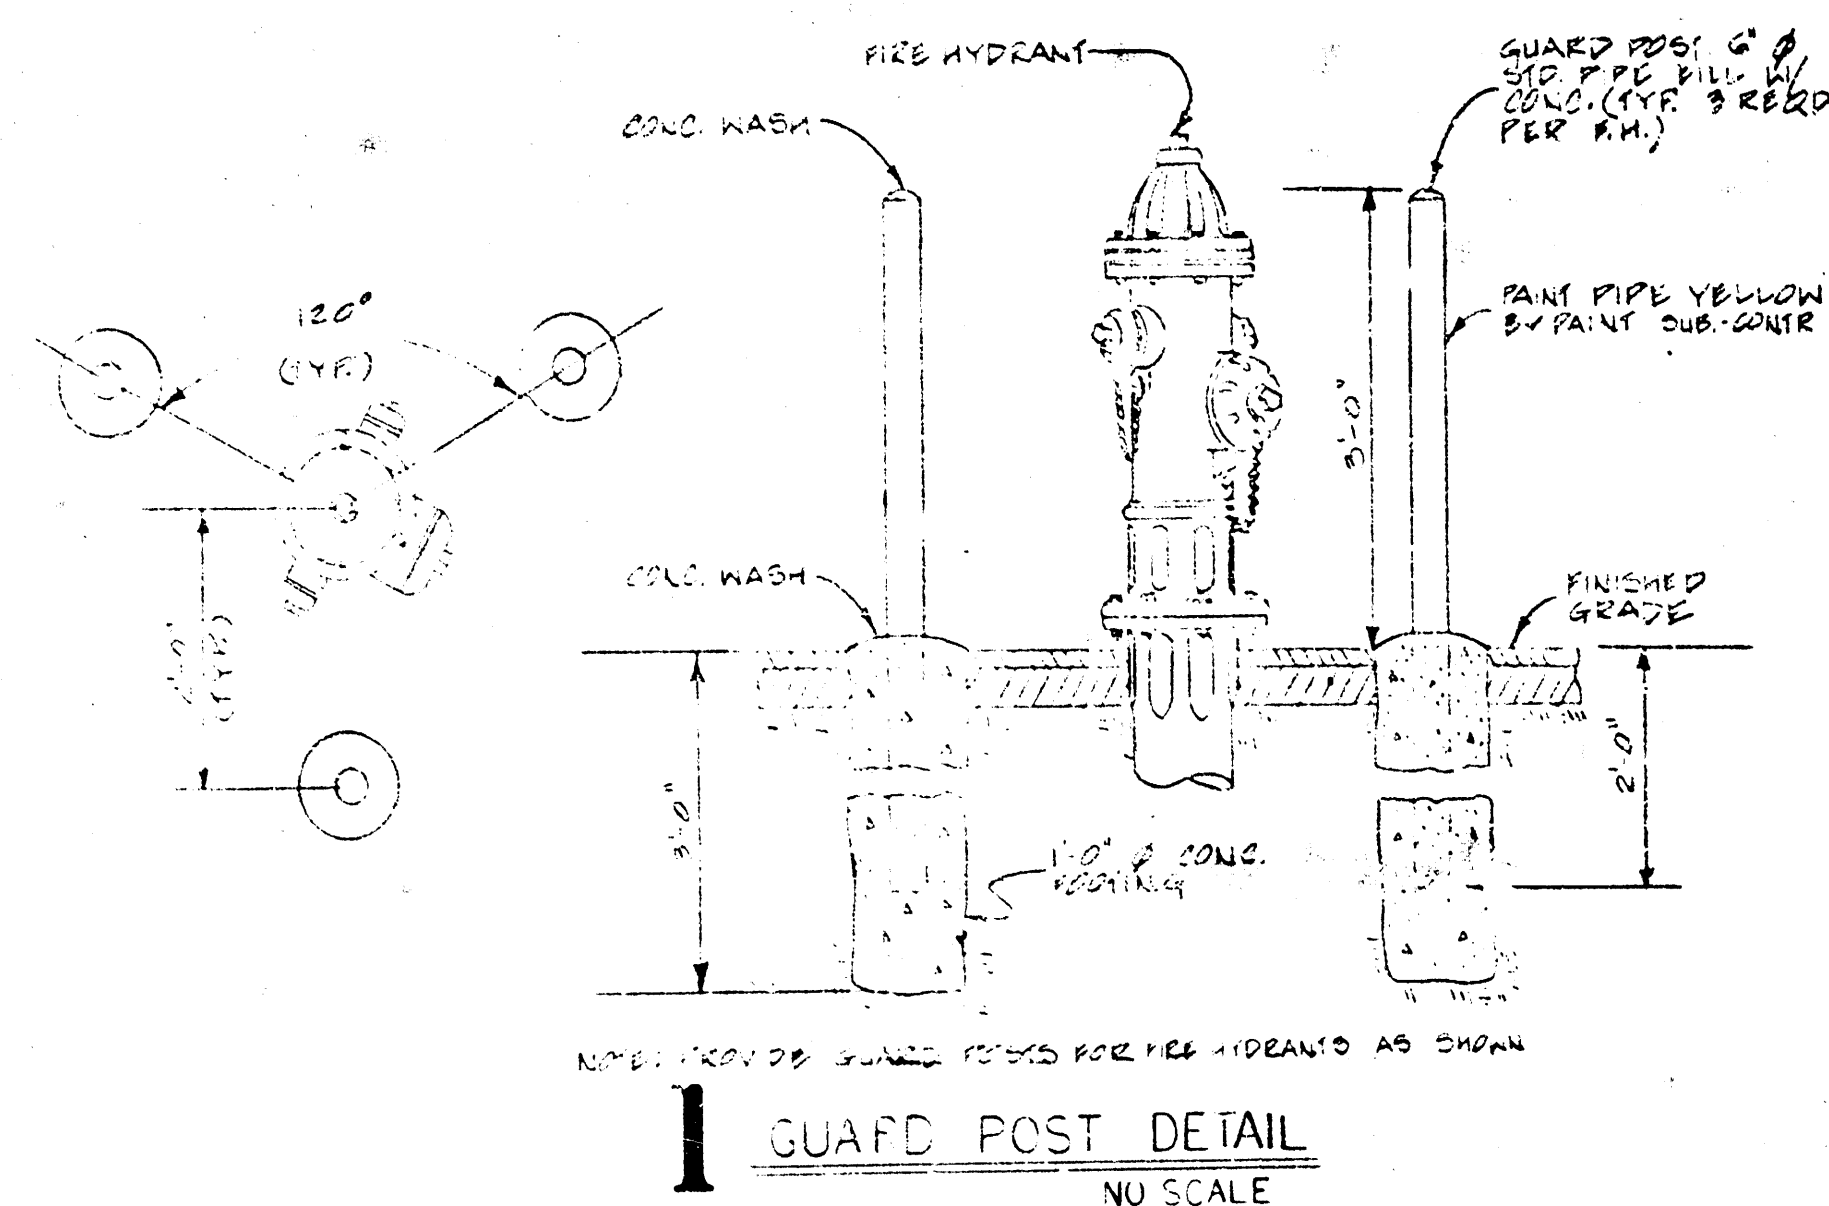

BENCH MARK:
ELEV. 1279.9 CHY. 310
BEARS CAP N.W. CORNER
AMIDON ST. 62.046.

SITE UTILITY PLAN
1"=40'-0"

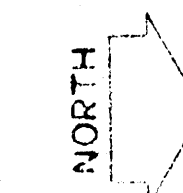

- LEGEND
- CLEAN OUT
 - MANHOLE
 - SANITARY SEWER
 - WATER LINE
 - WATER METER
 - SPRINKLER RISER
 - FIRE HYDRANT
 - VALVE ELEVATION BOX
 - GAS LINE
 - GAS METER
 - GUARD POST

As BUILT MEASURED
BY KRINGER 13/01/22


PRINTS ISSUED		
DATE	PURPOSE	NO.
2-10-72	FOR TENANT INFORMATION	1
3-29-72	FOR CITY APPROVAL	2
5-5-72	FOR CONSTRUCTION	3

FOR CONSTRUCTION: 5-5-72

REVISIONS		
DATE	ITEM	NO.
5-15-72	OVERSEEN BY CITY	1
7-1-72	WATER METER (SEE NOTE #1)	2

THE LAW COMPANY

CALVIN KRONENBERG, P.A.
313 S. MARKET
WICHITA, KANSAS 67201
ARCHITECTS & ENGINEERS

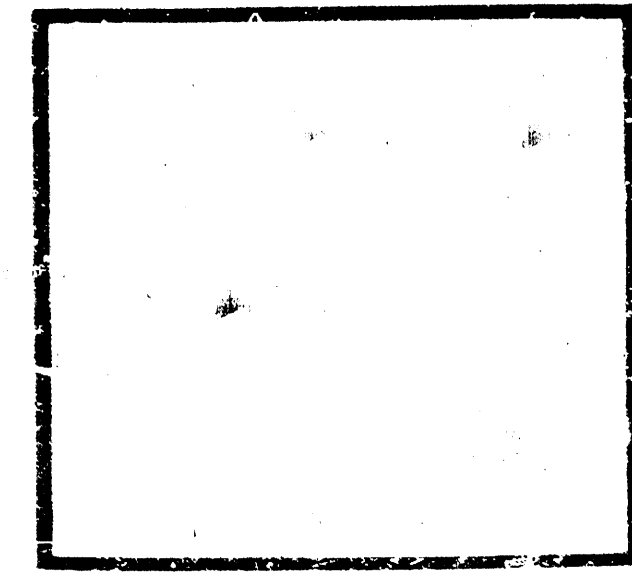

DRAWN	CHECKED
ELTON	ELTON
RELATED DRAWINGS	
SHELL	
DETAILS	
STRUCTURE	
MECHANICAL	
ELECTRICAL	
OTHER	
SEQUENCE NUMBER	
OF	SHEETS



MARINA LAKES SHOPPING CENTER

WICHITA, KANSAS
PROJECT NUMBER 7201



KEY PLAN

SITE UTILITY PLAN


TENANT NUMBER
SHEET TITLE
SHEET NUMBER
SU-1
OF SHEETS

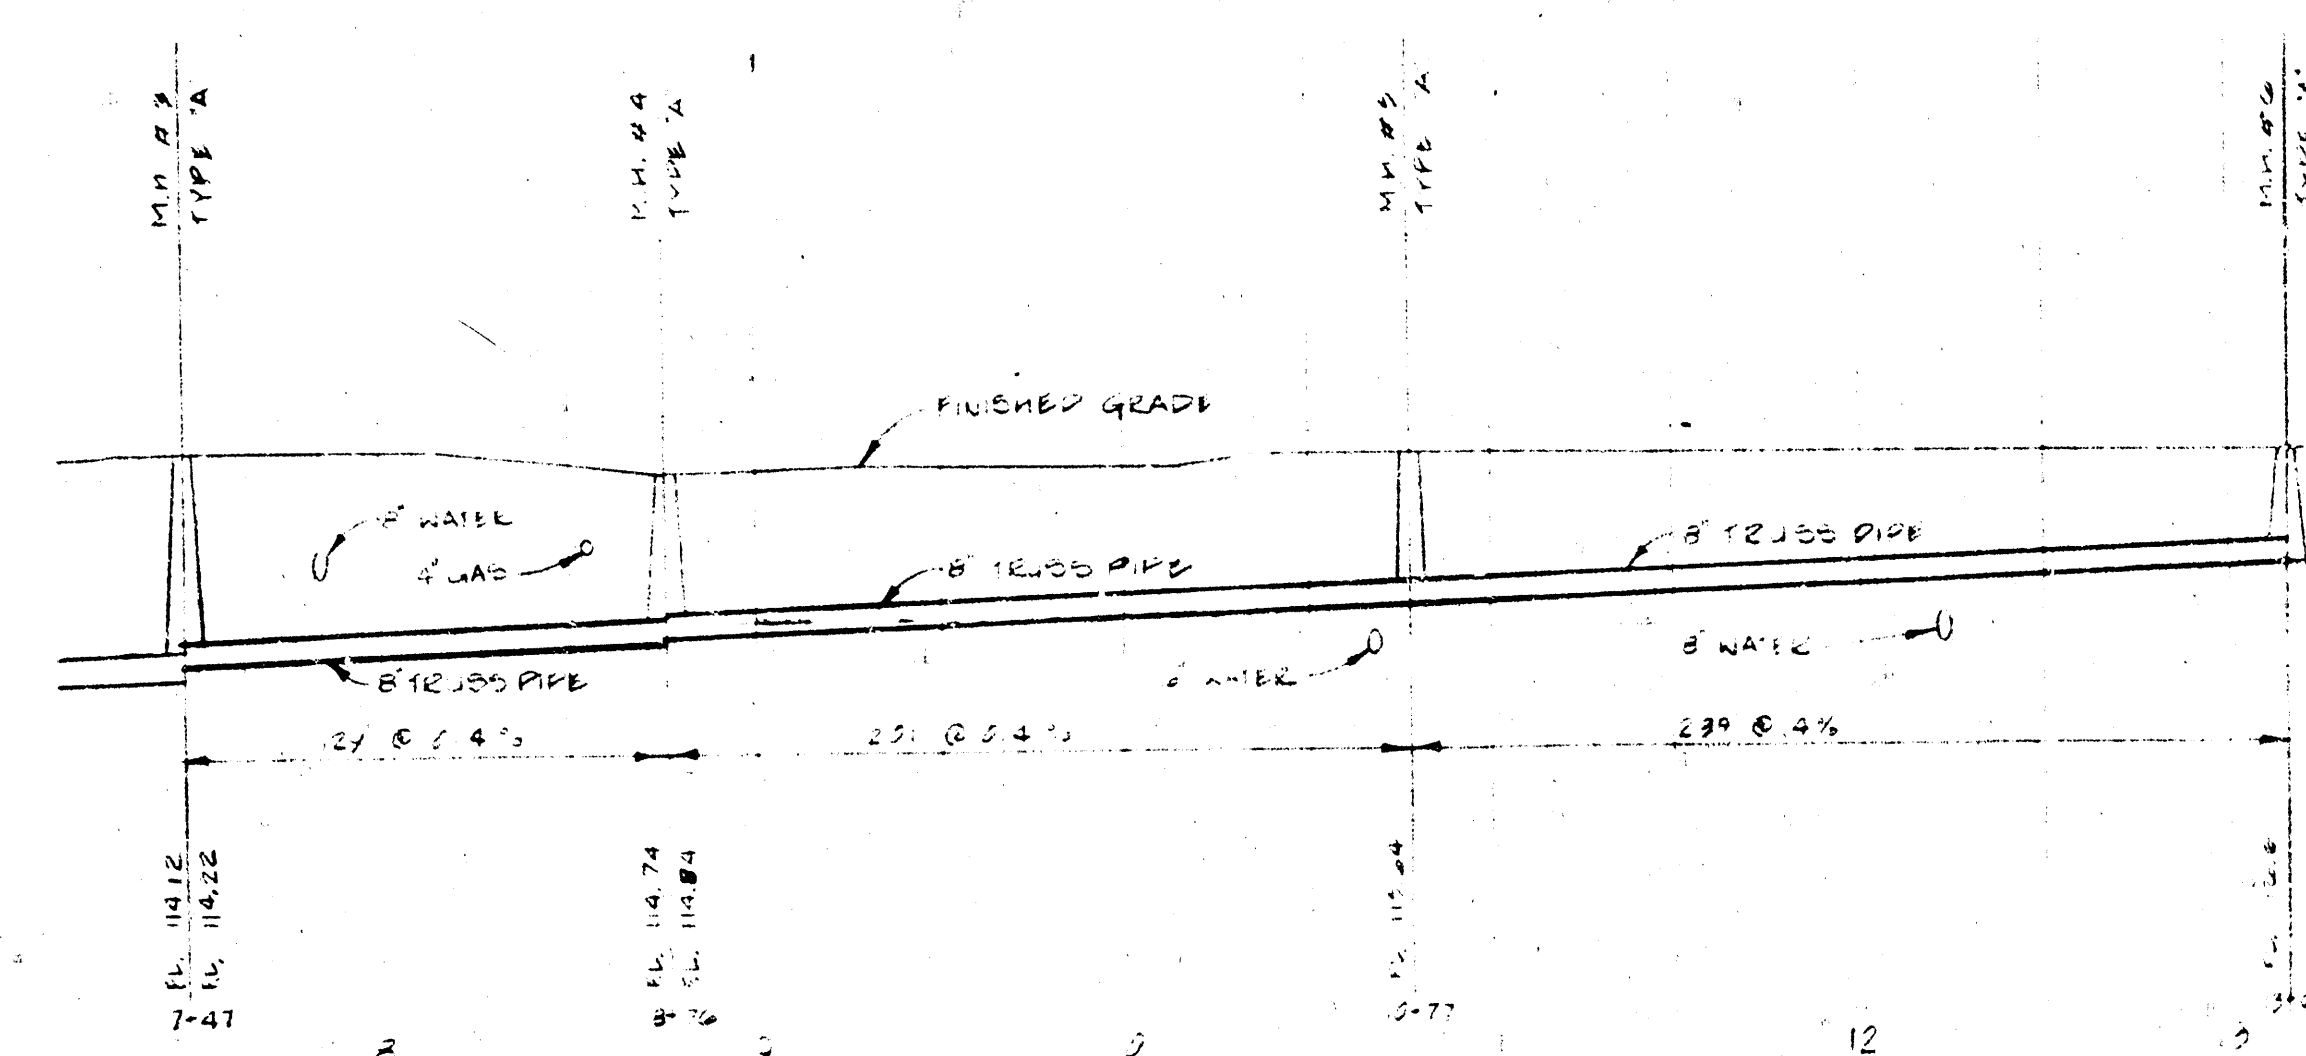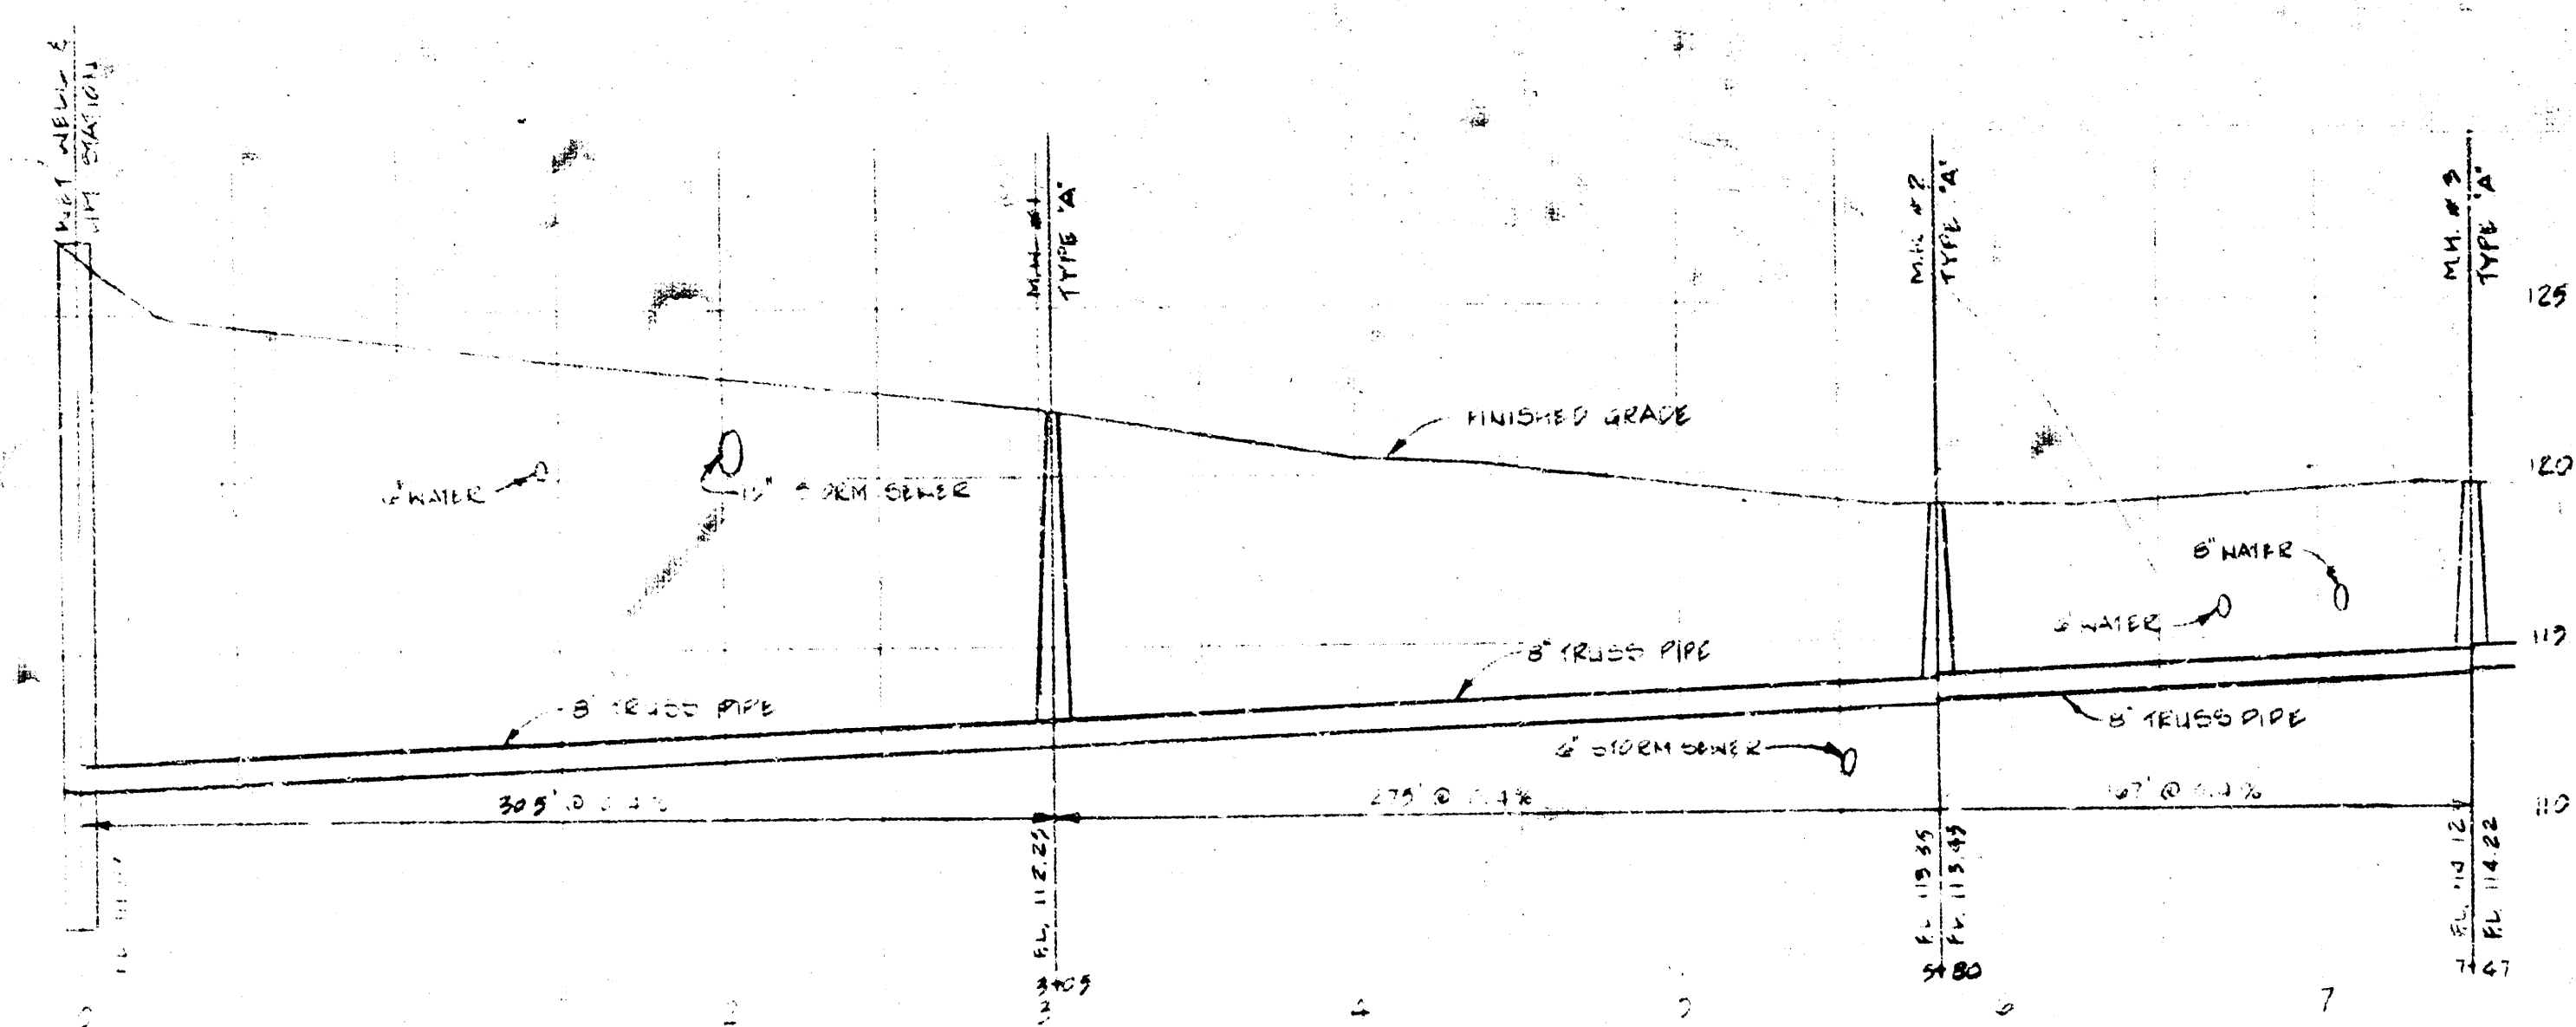


SANITARY SEWER PROFILE

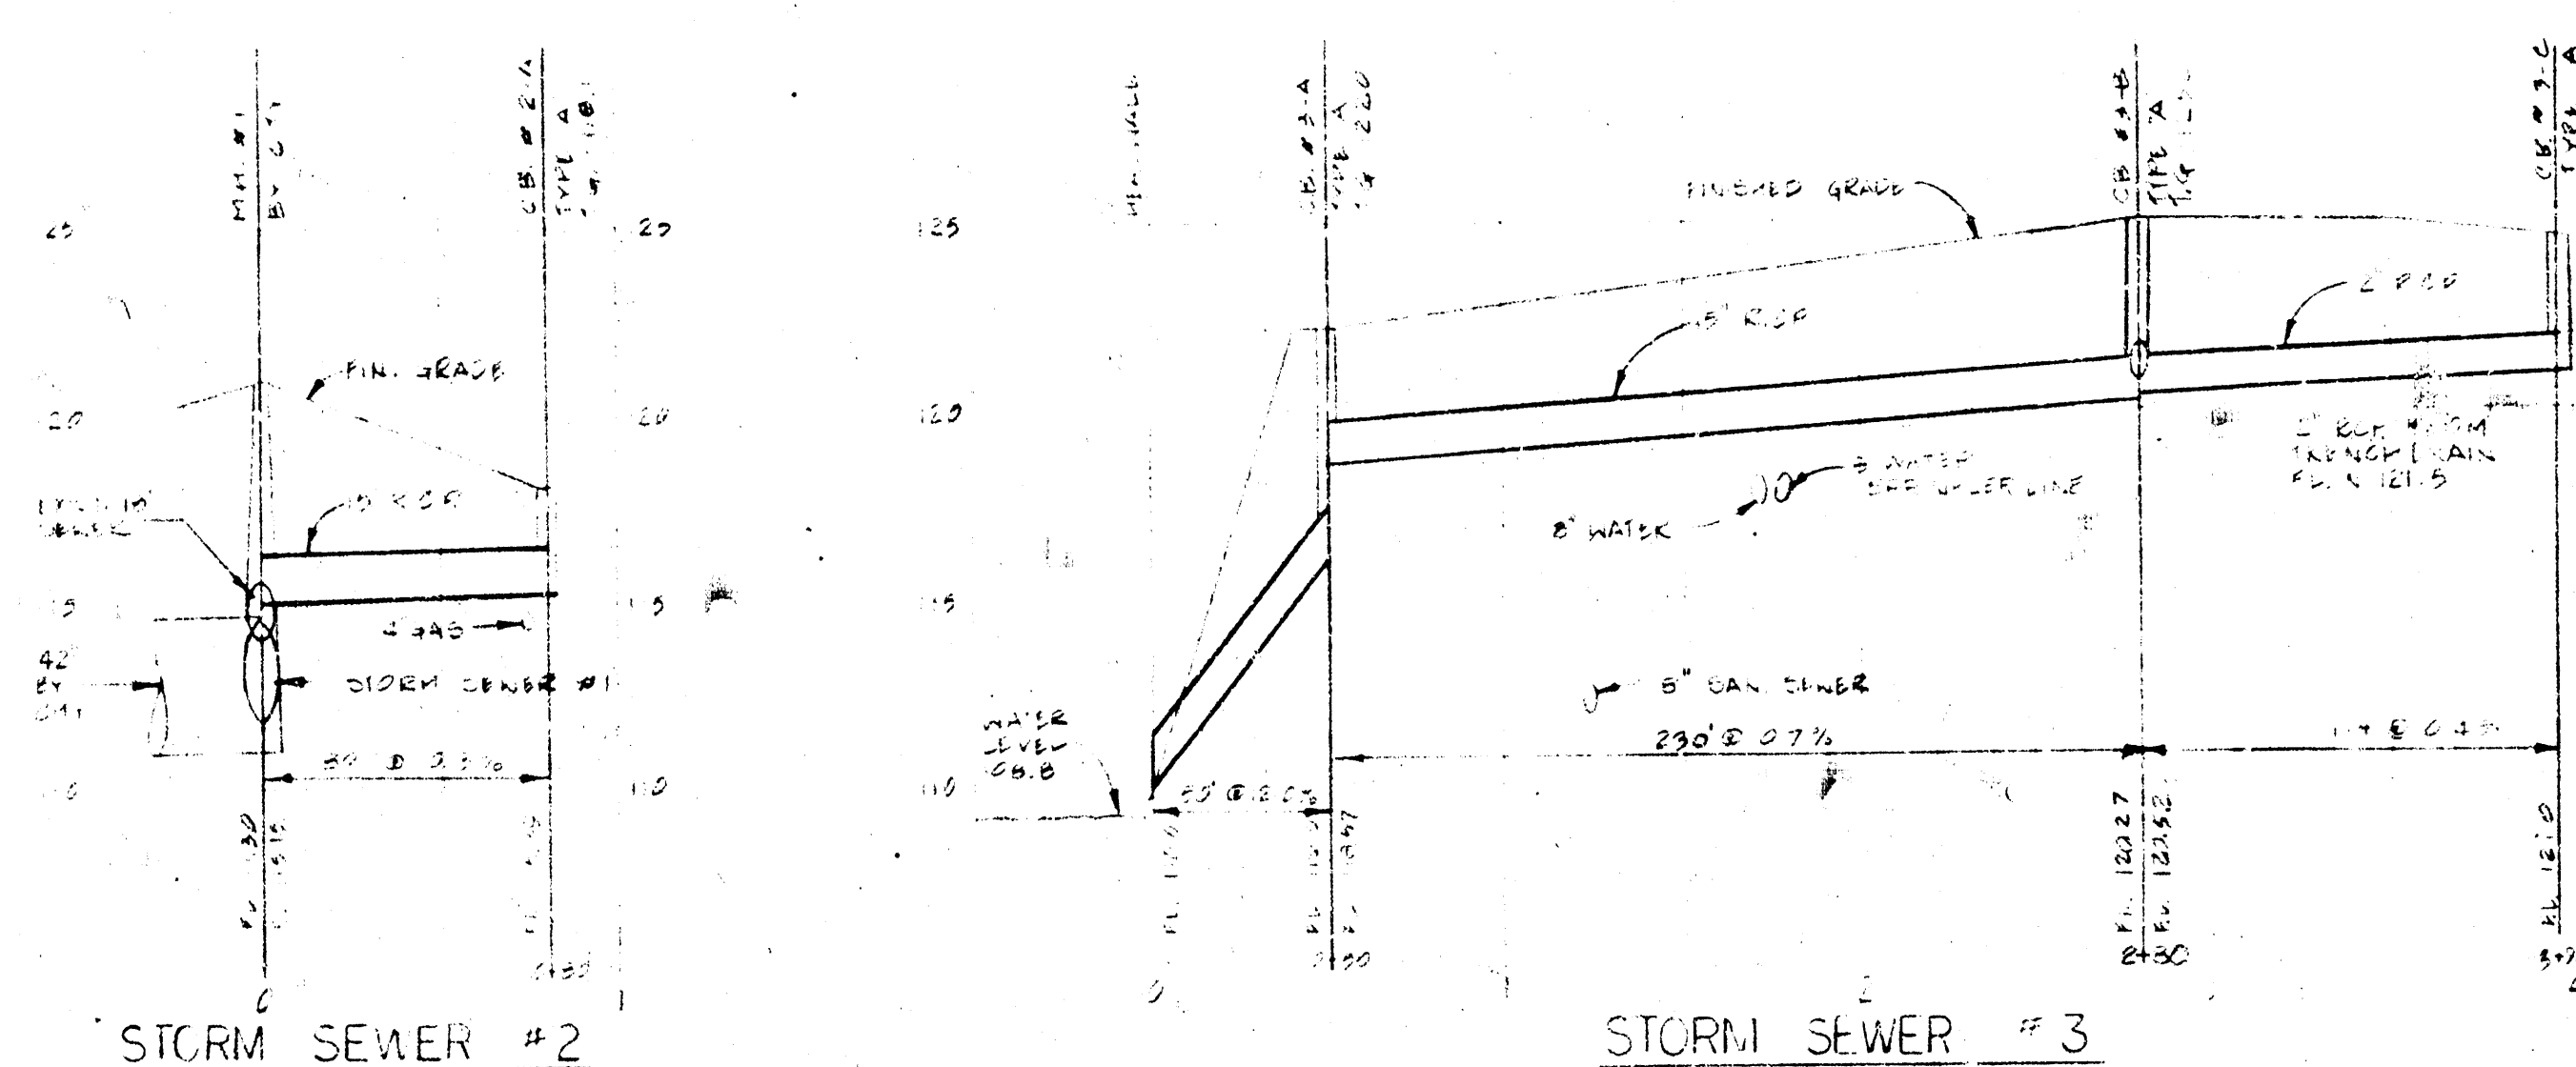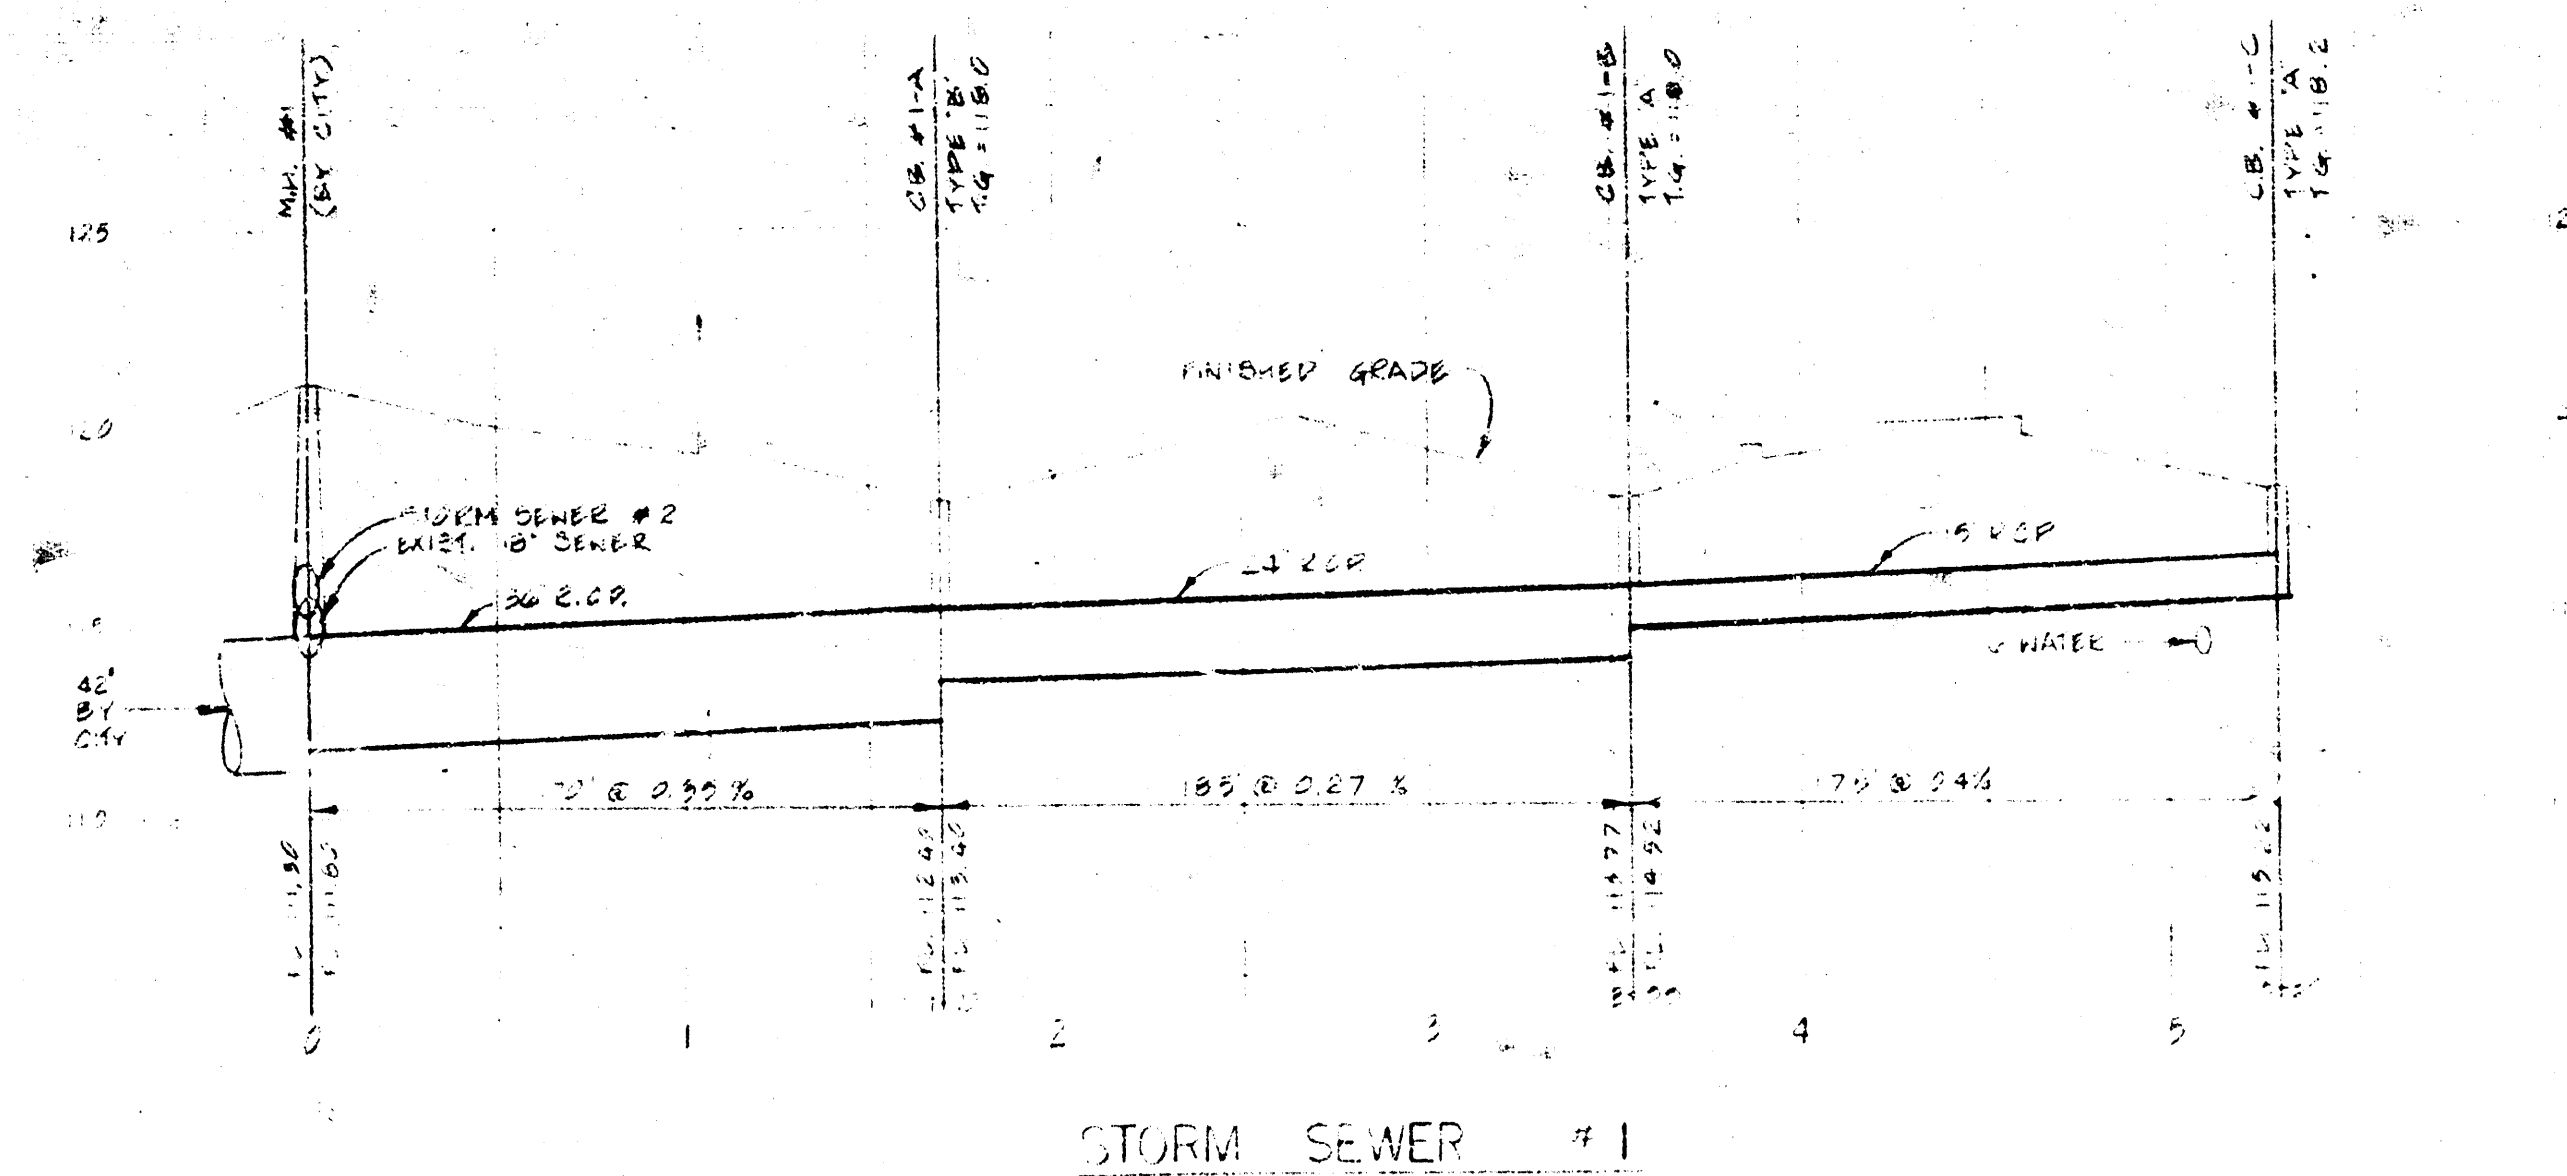


STORM SEWER # 3

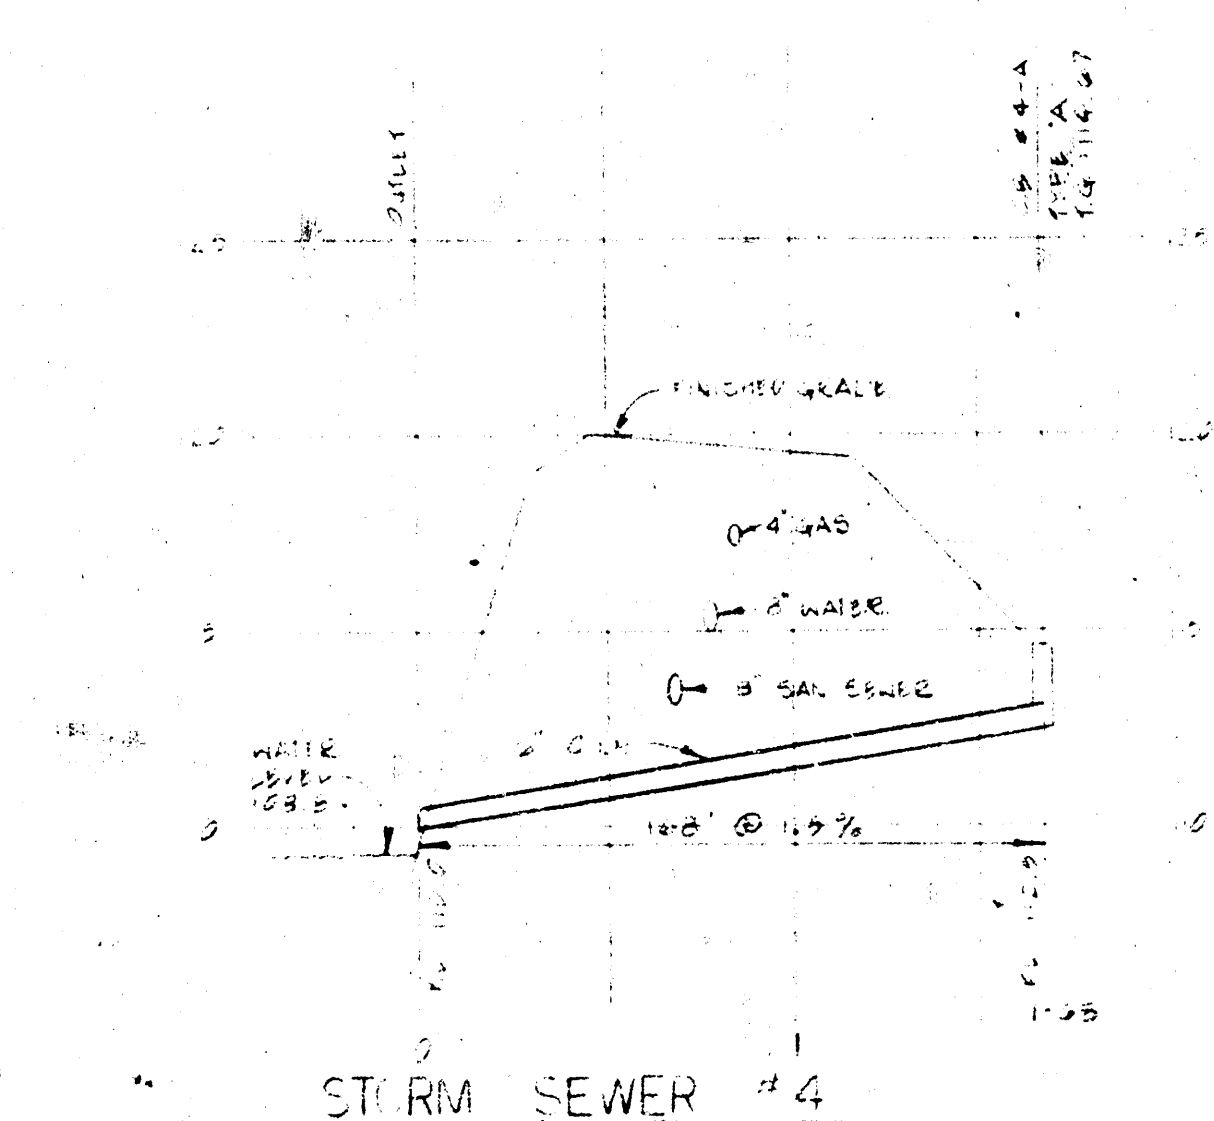

2 STORM SEWER PROFILES

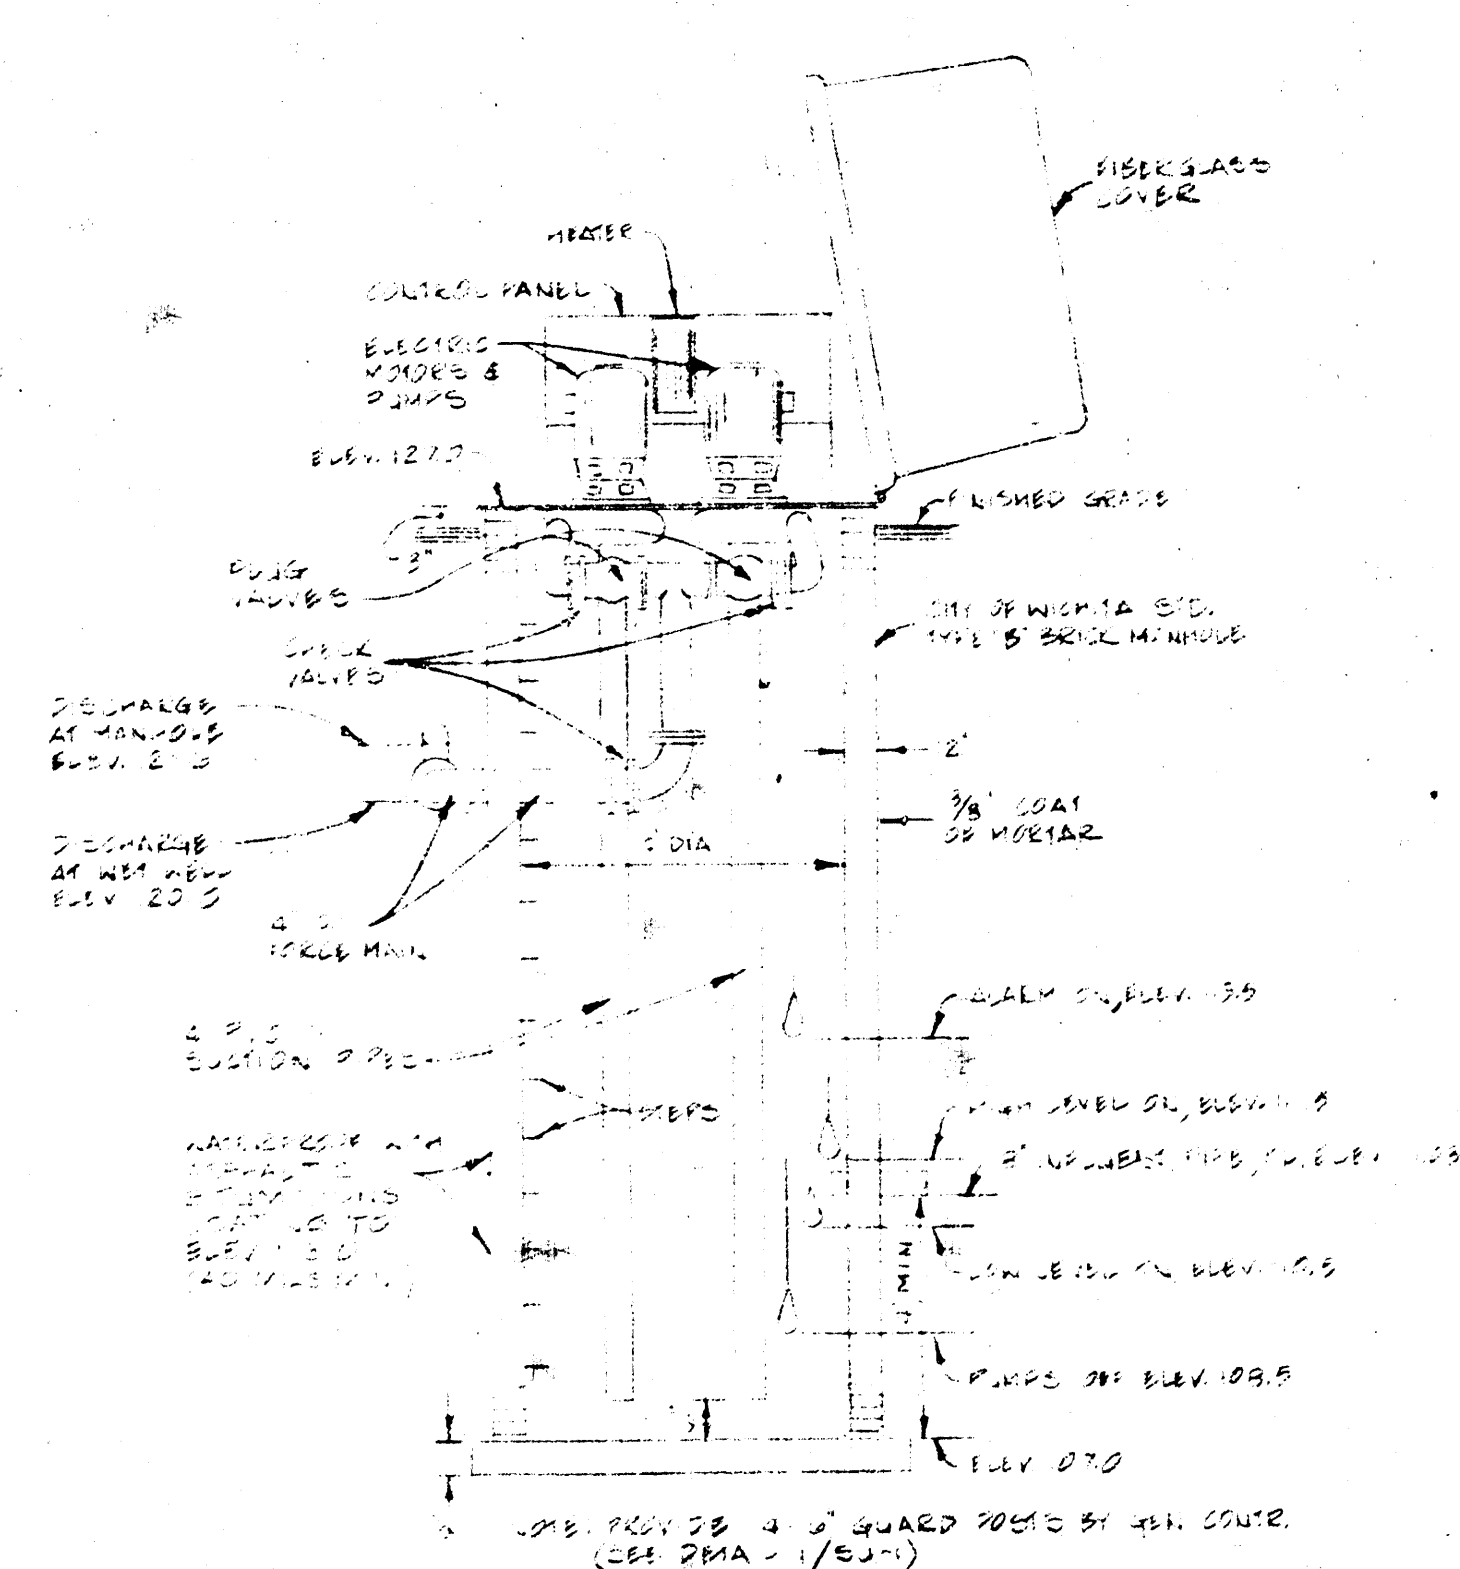


3 SEWAGE LIFT STATION

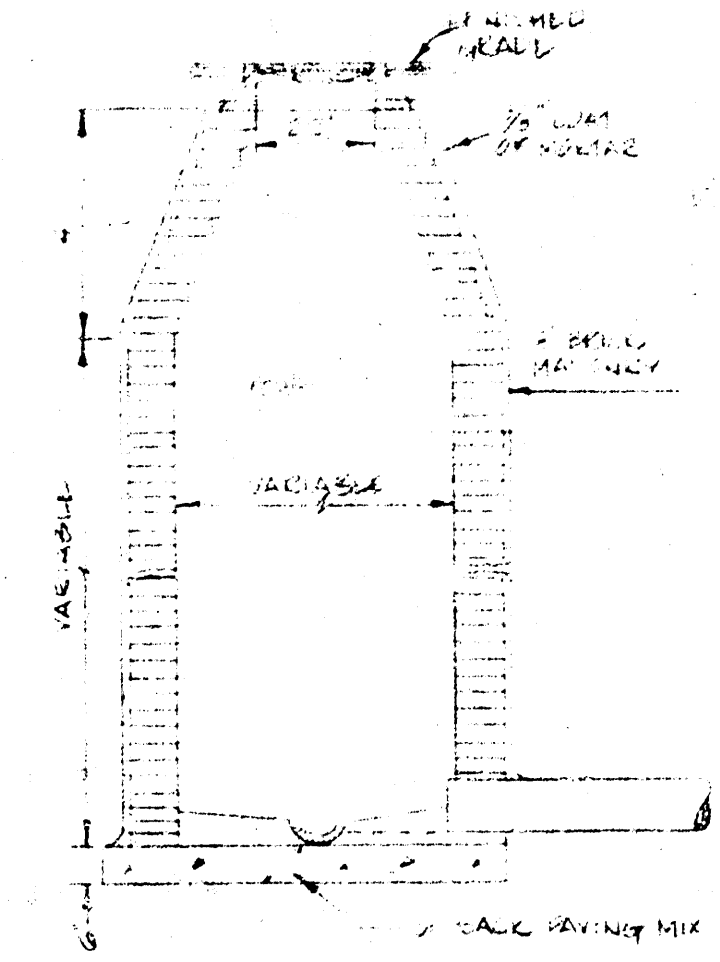

4 TYPE "A" MANHOLE
NO SCALE

[illegible]

FOR CONSTRUCTION: 5-5-72

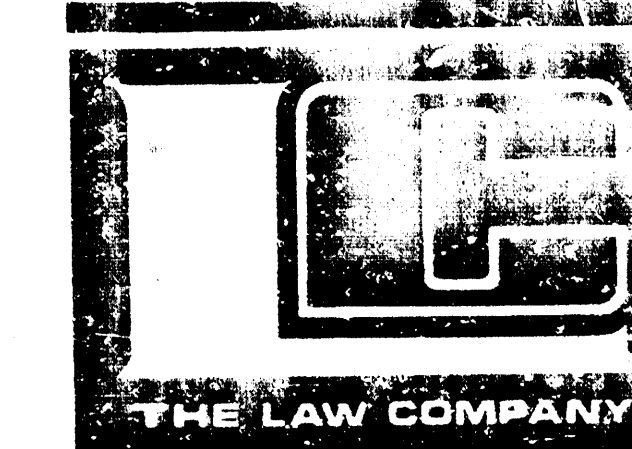[illegible]

CALVIN KINODON BERGER | P.A. 313 S. MARKET WICHITA, KANS. 67202
PHONE (316) 266-8864
ARCHITECTS & ENGINEERS

DRAWN		CHECKED	
DATE		RCF	CELL
RELATED DRAWINGS			
SMELL			
DETAILS			
STRUCTURE			
MECHANICAL			
ELECTRICAL			
OTHER			
SEQUENCE NUMBER			
OF _____ SHEET			

MARINA LAKES SHOPPING CENTER

WICHITA, KANSAS

PROJECT NUMBER 7201

KEY PLAN

TENANT	
SITE DETAILS	
SHEET TITLE	
TENANT NUMBER	SHEET NUMBER
	SU-2
CF	SH