


PILGRIM CONGREGATIONAL CHURCH SANITARY SEWER PROJECT NO. 468-76-245-80001-000-000-074



MICHAEL E. LINDEBAK, CITY ENGINEER

JULY, 1986

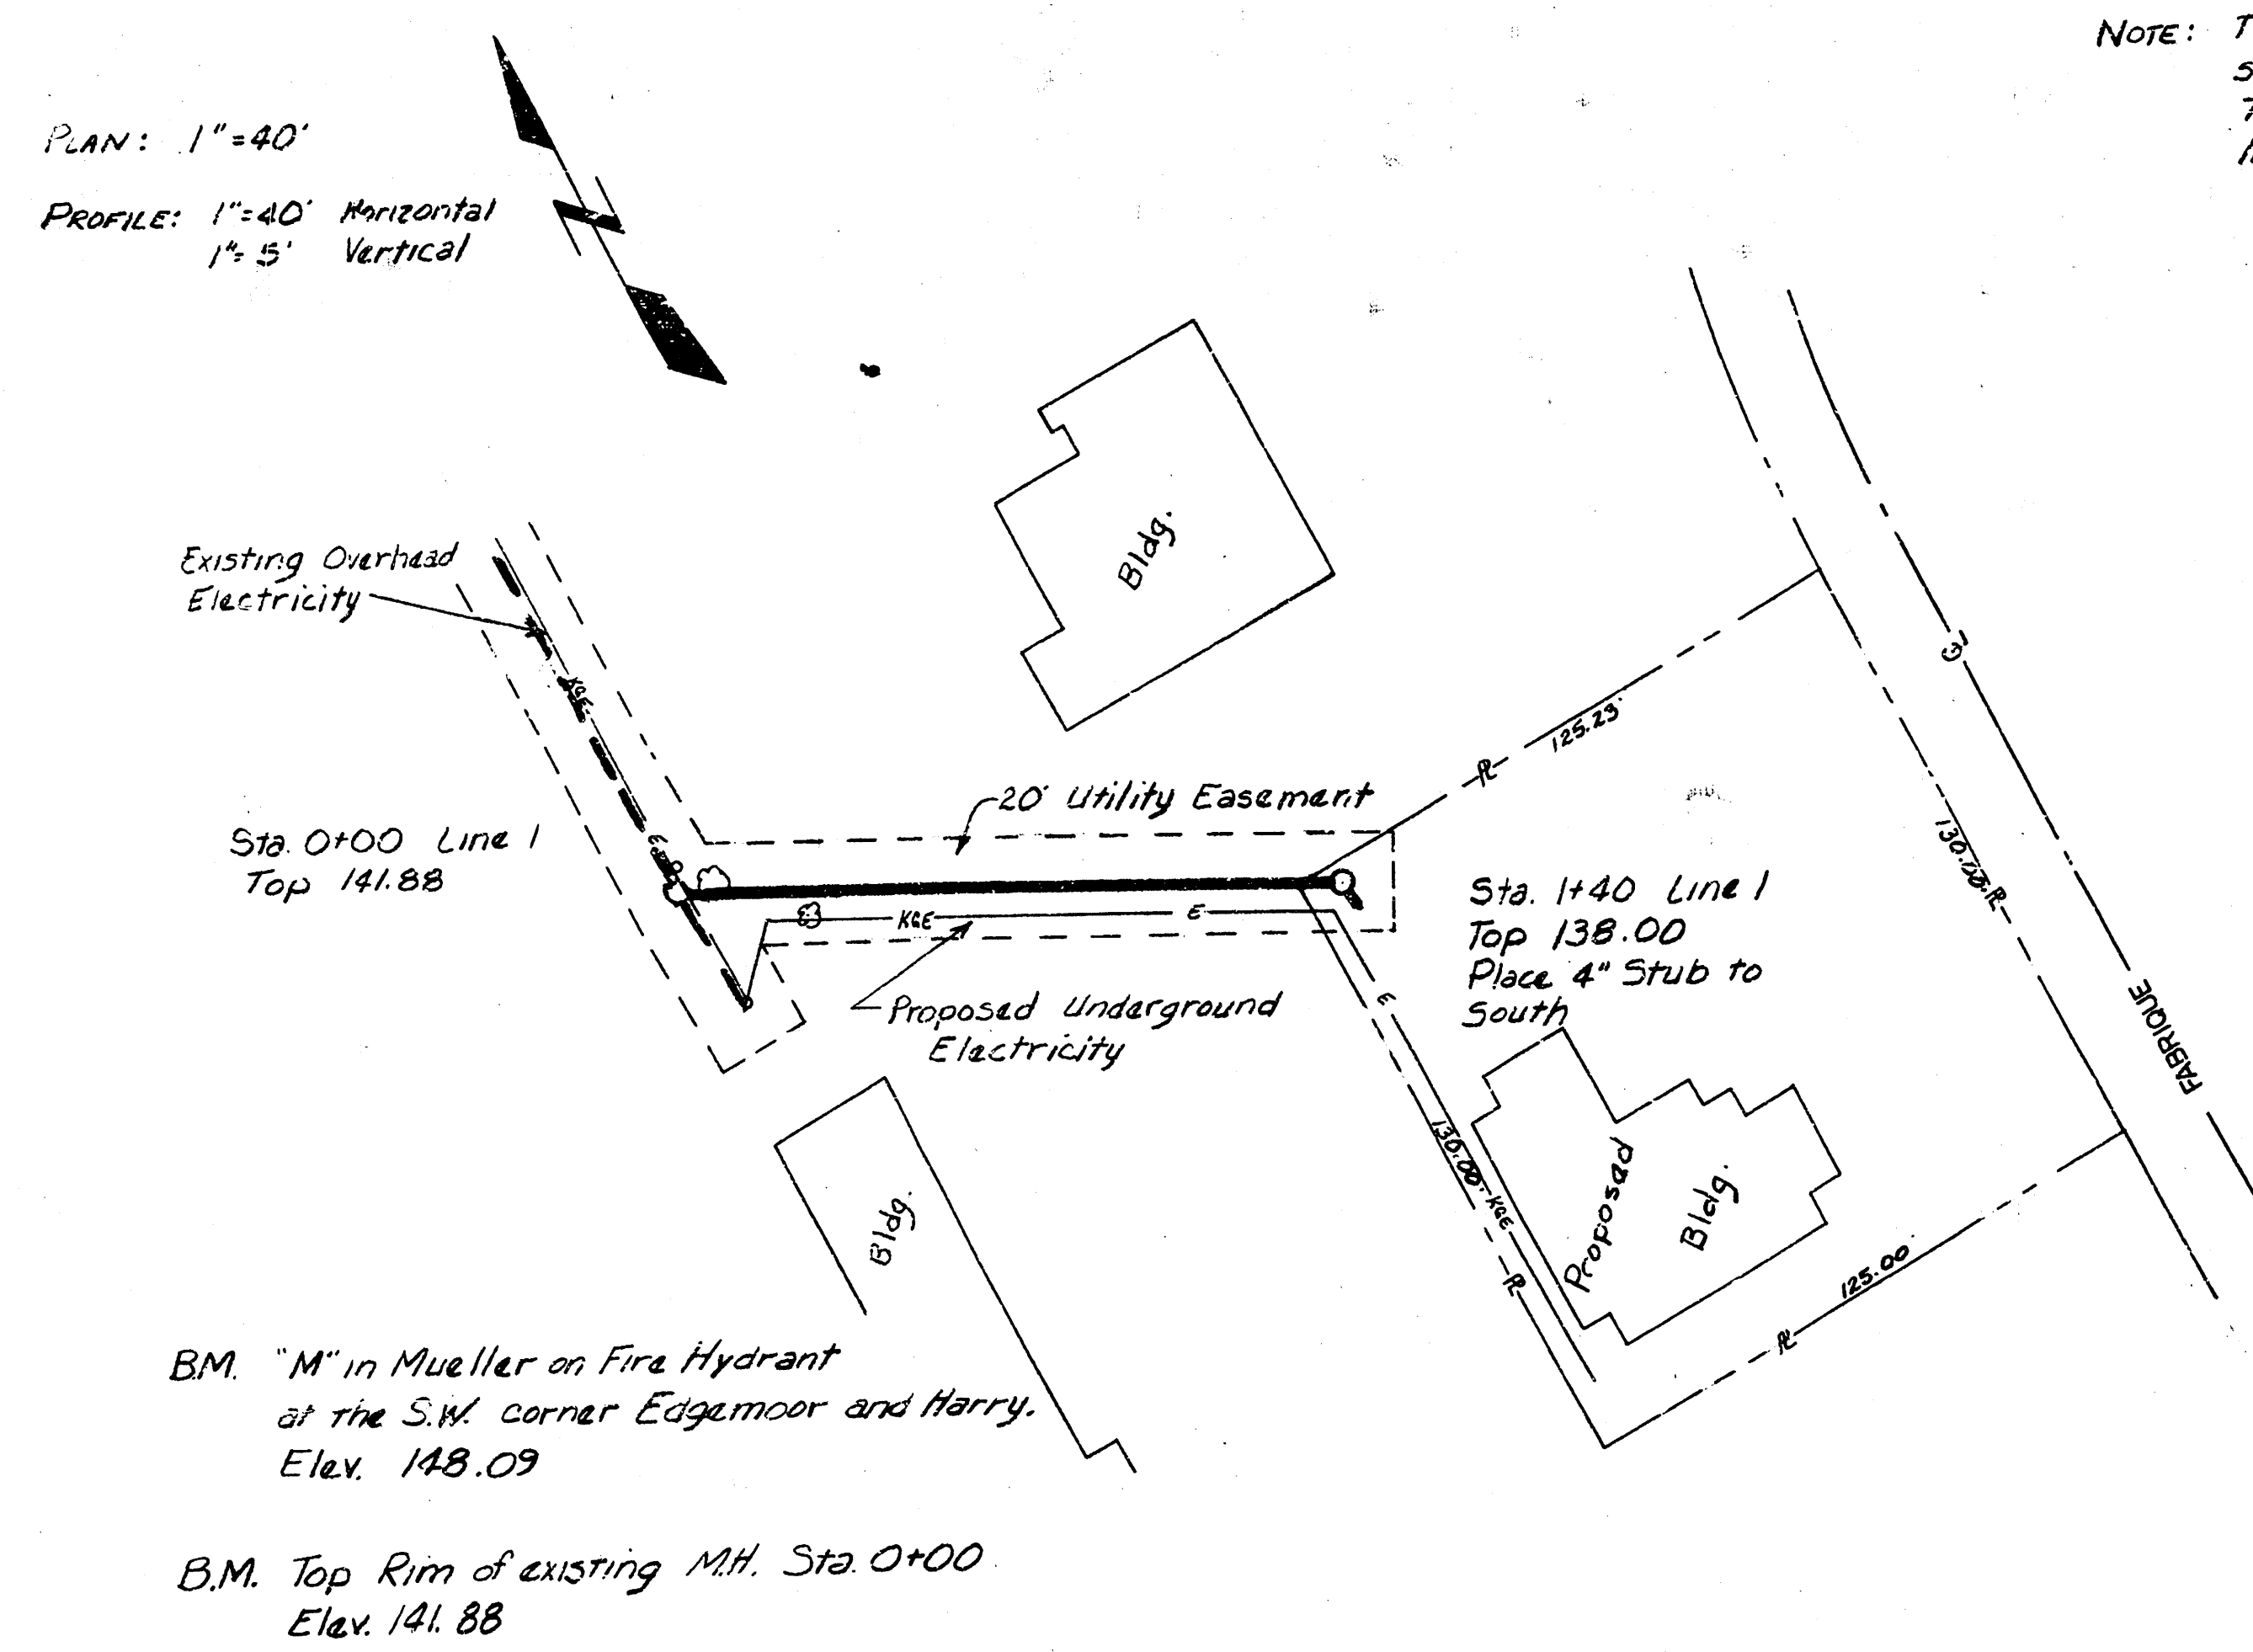

NOTE: The City of Wichita shall Air Test and Telesize the raw line prior to acceptance.

QUANTITIES	
140 L.F.	8" PIPE
1 Ea.	MANHOLE
1 Ea.	CONNECT TO EXISTING MH
1 Ea.	4" STUB OUT
2 Ea.	TREE REMOVAL

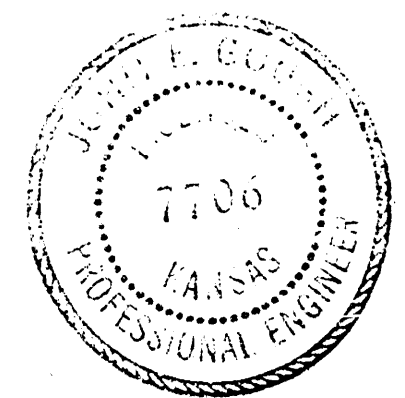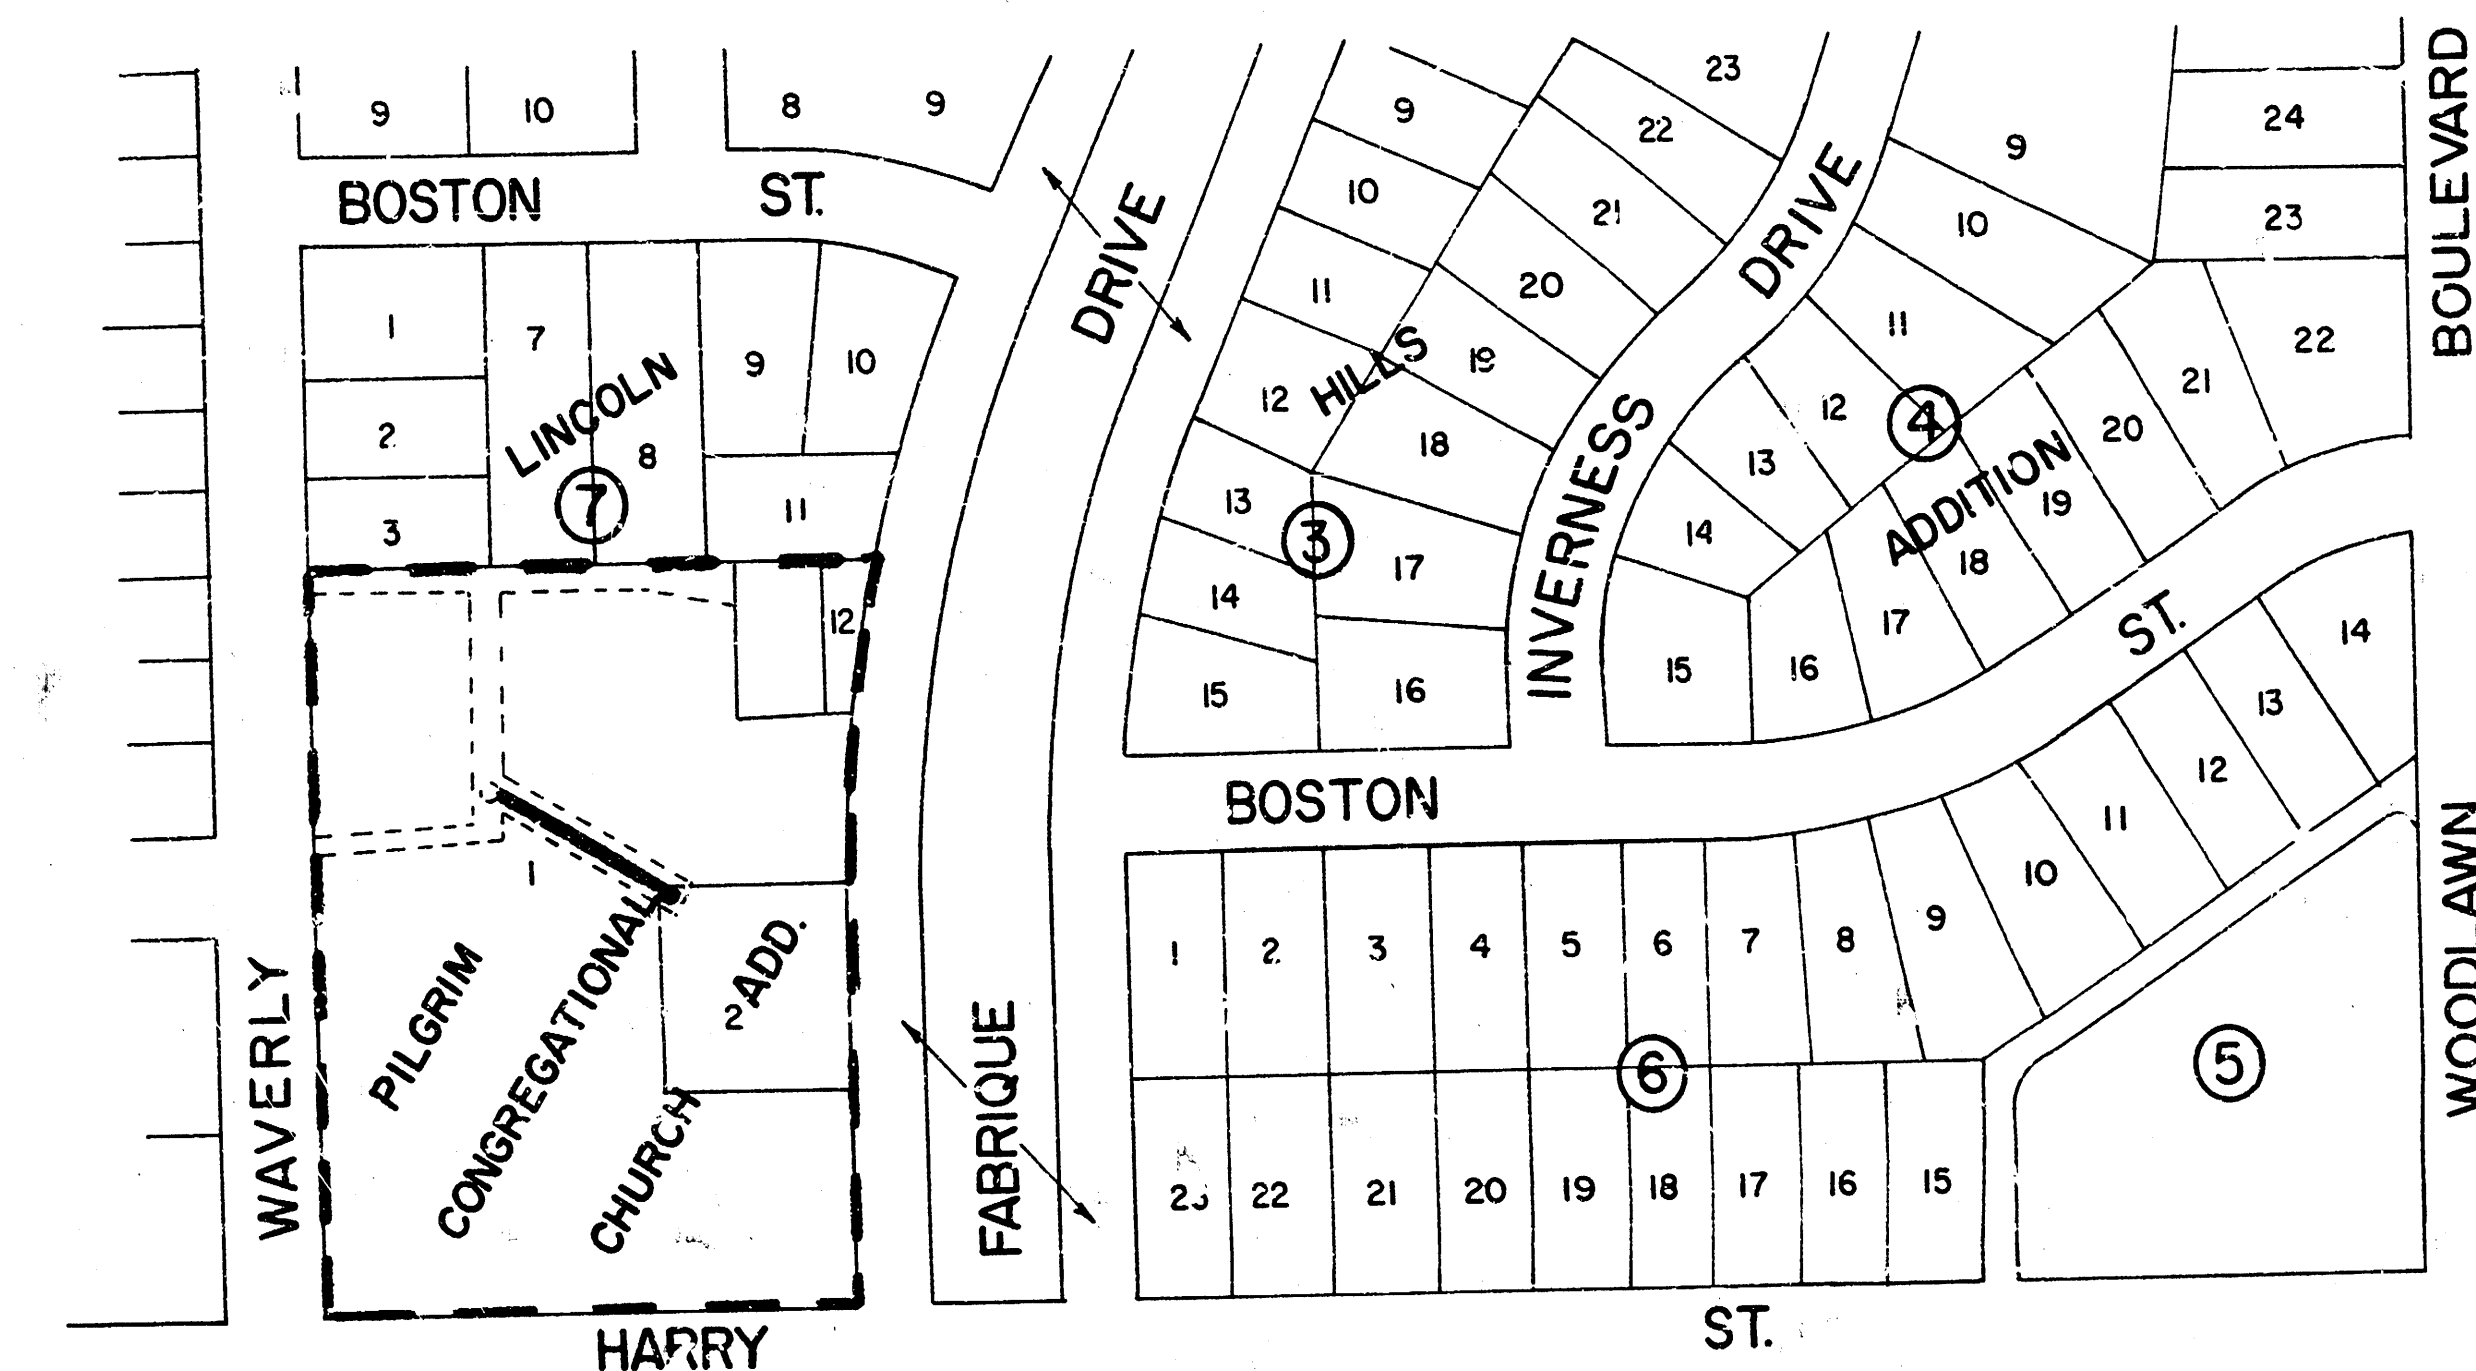


APPROVED AS NOTED
By CITY ENGINEER OF WICHITA
Sanitary Sewers *MLB 7/28/86*
Storm Sewers _____
Driveway Approaches _____
Water Mains _____
Paving _____

NOTE TO CONTRACTOR

This project will be constructed under the supervision of the CITY ENGINEER and conforming to the SPECIFICATIONS of the CITY OF WICHITA. The CONTRACTOR will pay the City of Wichita for all costs of plan review, inspection and booking per contract.

THE CONTRACTOR SHALL BE RESPONSIBLE FOR PRESERVING PROPERTY (TRESS, TREES, ETC.) AND SHALL BE REQUIRED TO RE-ESTABLISH ANY PROPERTY (TRESS, TREES, ETC.) DAMAGED OR DESTROYED BY HIS CONSTRUCTION OPERATIONS. SUCH REPAIRS SHALL BE ESTABLISHED BY A LICENSED LAND SURVEYOR OR A LICENSED PROFESSIONAL ENGINEER IN ACCORDANCE WITH STATE LAWS.

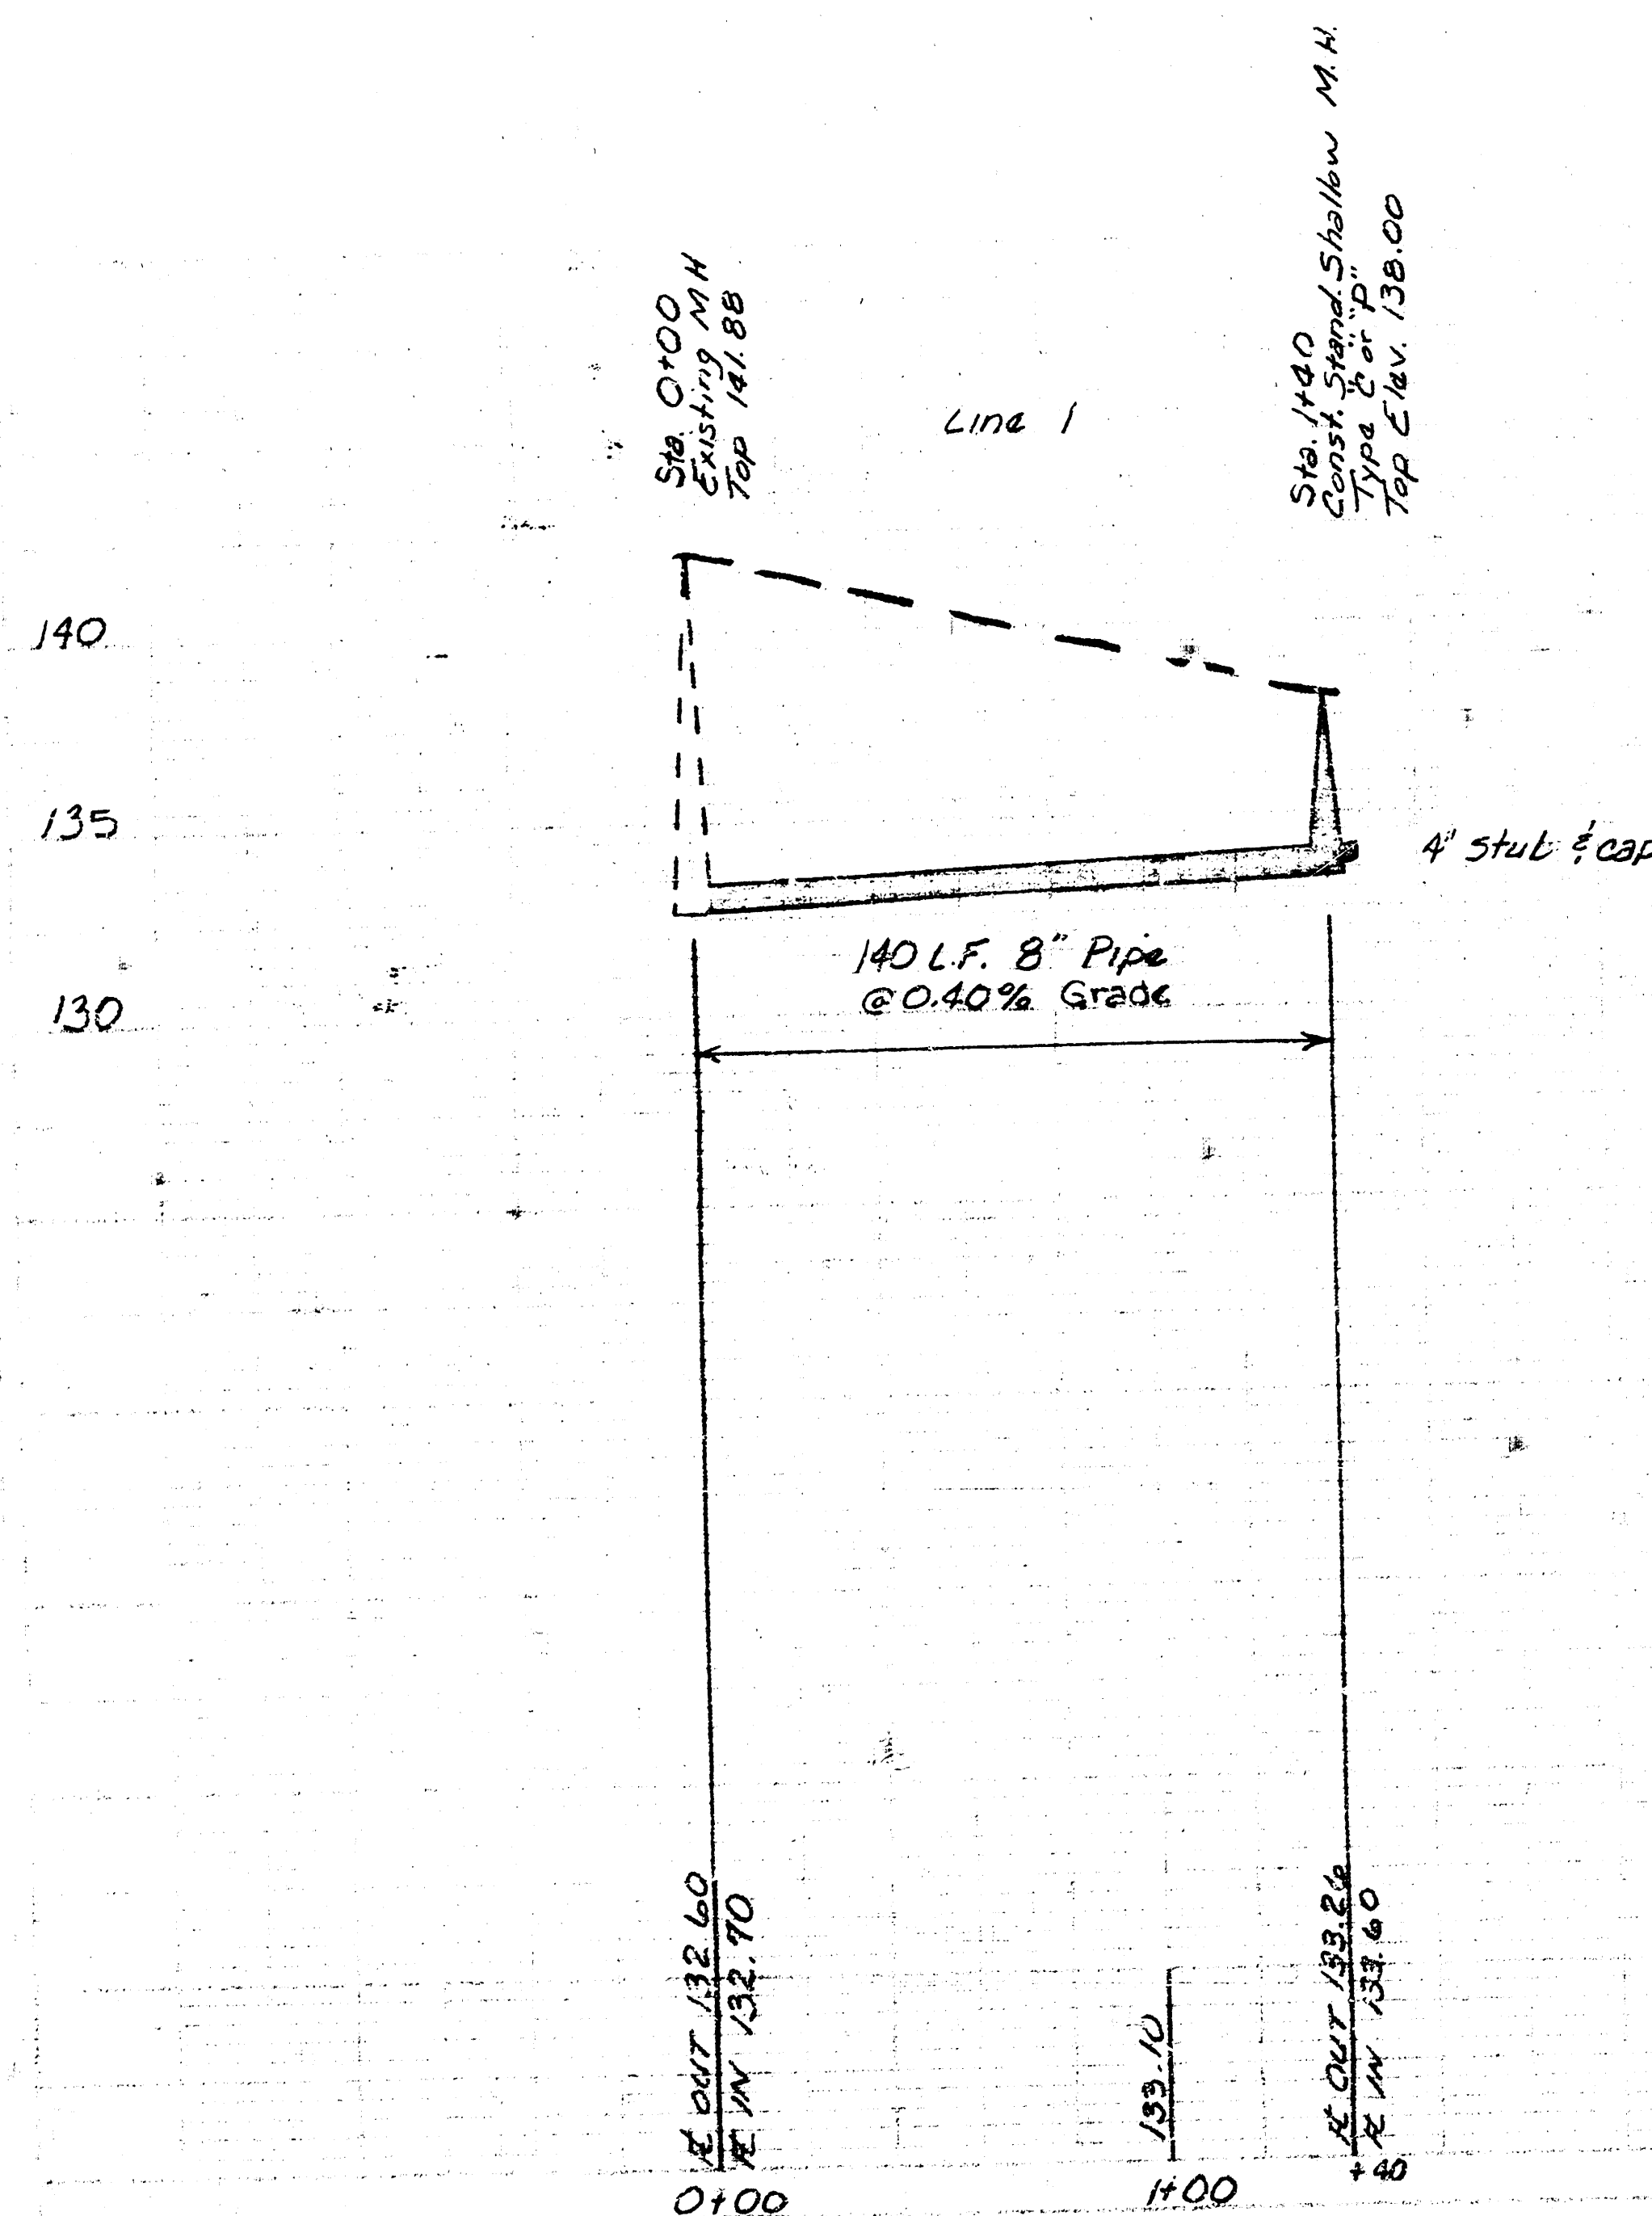

WICHITA, KANSAS			
SANITARY SEWER EXTENSIONS			
PLAN AND PROFILE			
PROJECT NO. 468-76-245-8001-000-000-074			
STA. 0+00 TO STA. 1+40			
	CASTLE & ASSOCIATES ENGINEERS WICHITA, KANSAS	DSG/JMK DR/JMK CH	DWG FILE NO. 8641-D-80,067
	DATE JULY 1986	APP	SHEET NO. / OF /

FILMED FROM THE BEST AVAILABLE COPY