


FOR CONSTRUCTION: 11/1/8



LAW/KINGDON, INC.
ARCHITECTS & ENGINEERS
846 MYLWYNN, WESTLA, LANHAM ST
Phone (312) 292-0250 Copyright © 1988

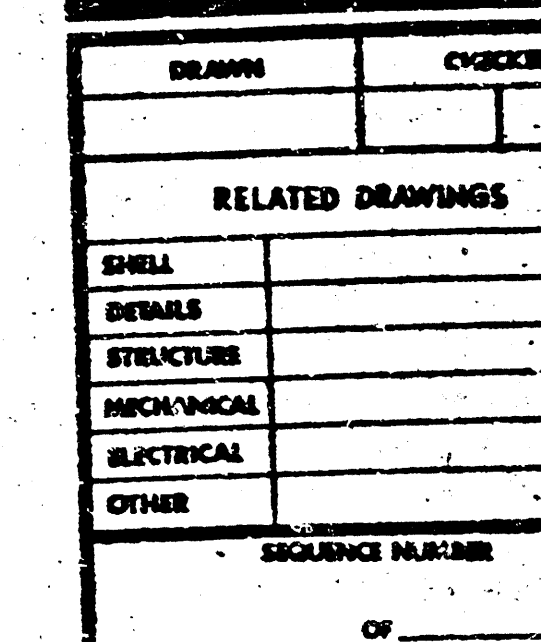


2



SHEET TITLE
SITE UTILITY DET

SHEET NUMBER
SL

OF 2/4

FILMED FROM THE BEST
AVAILABLE COPY


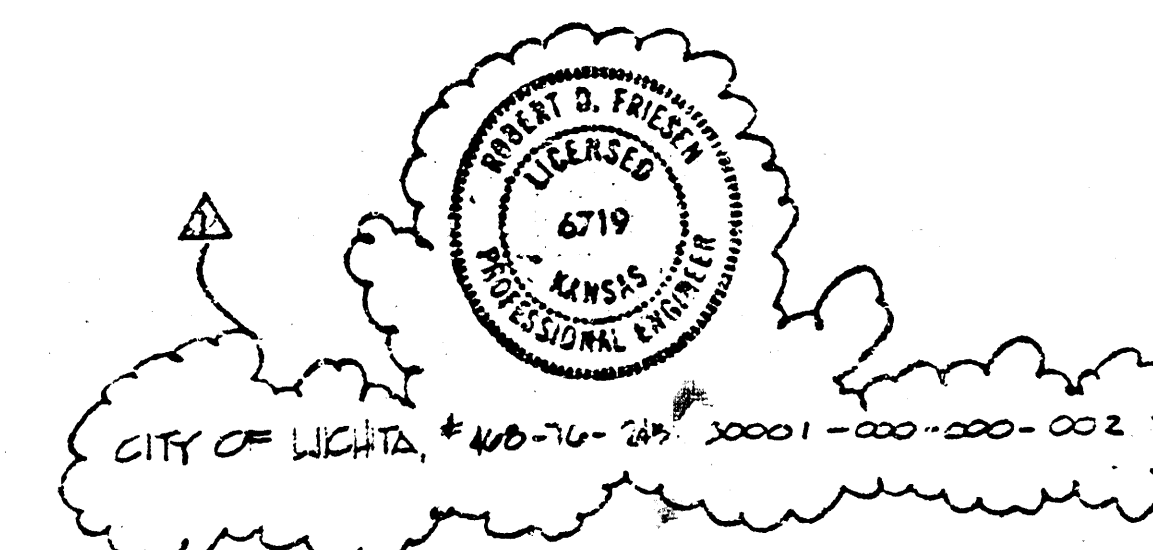


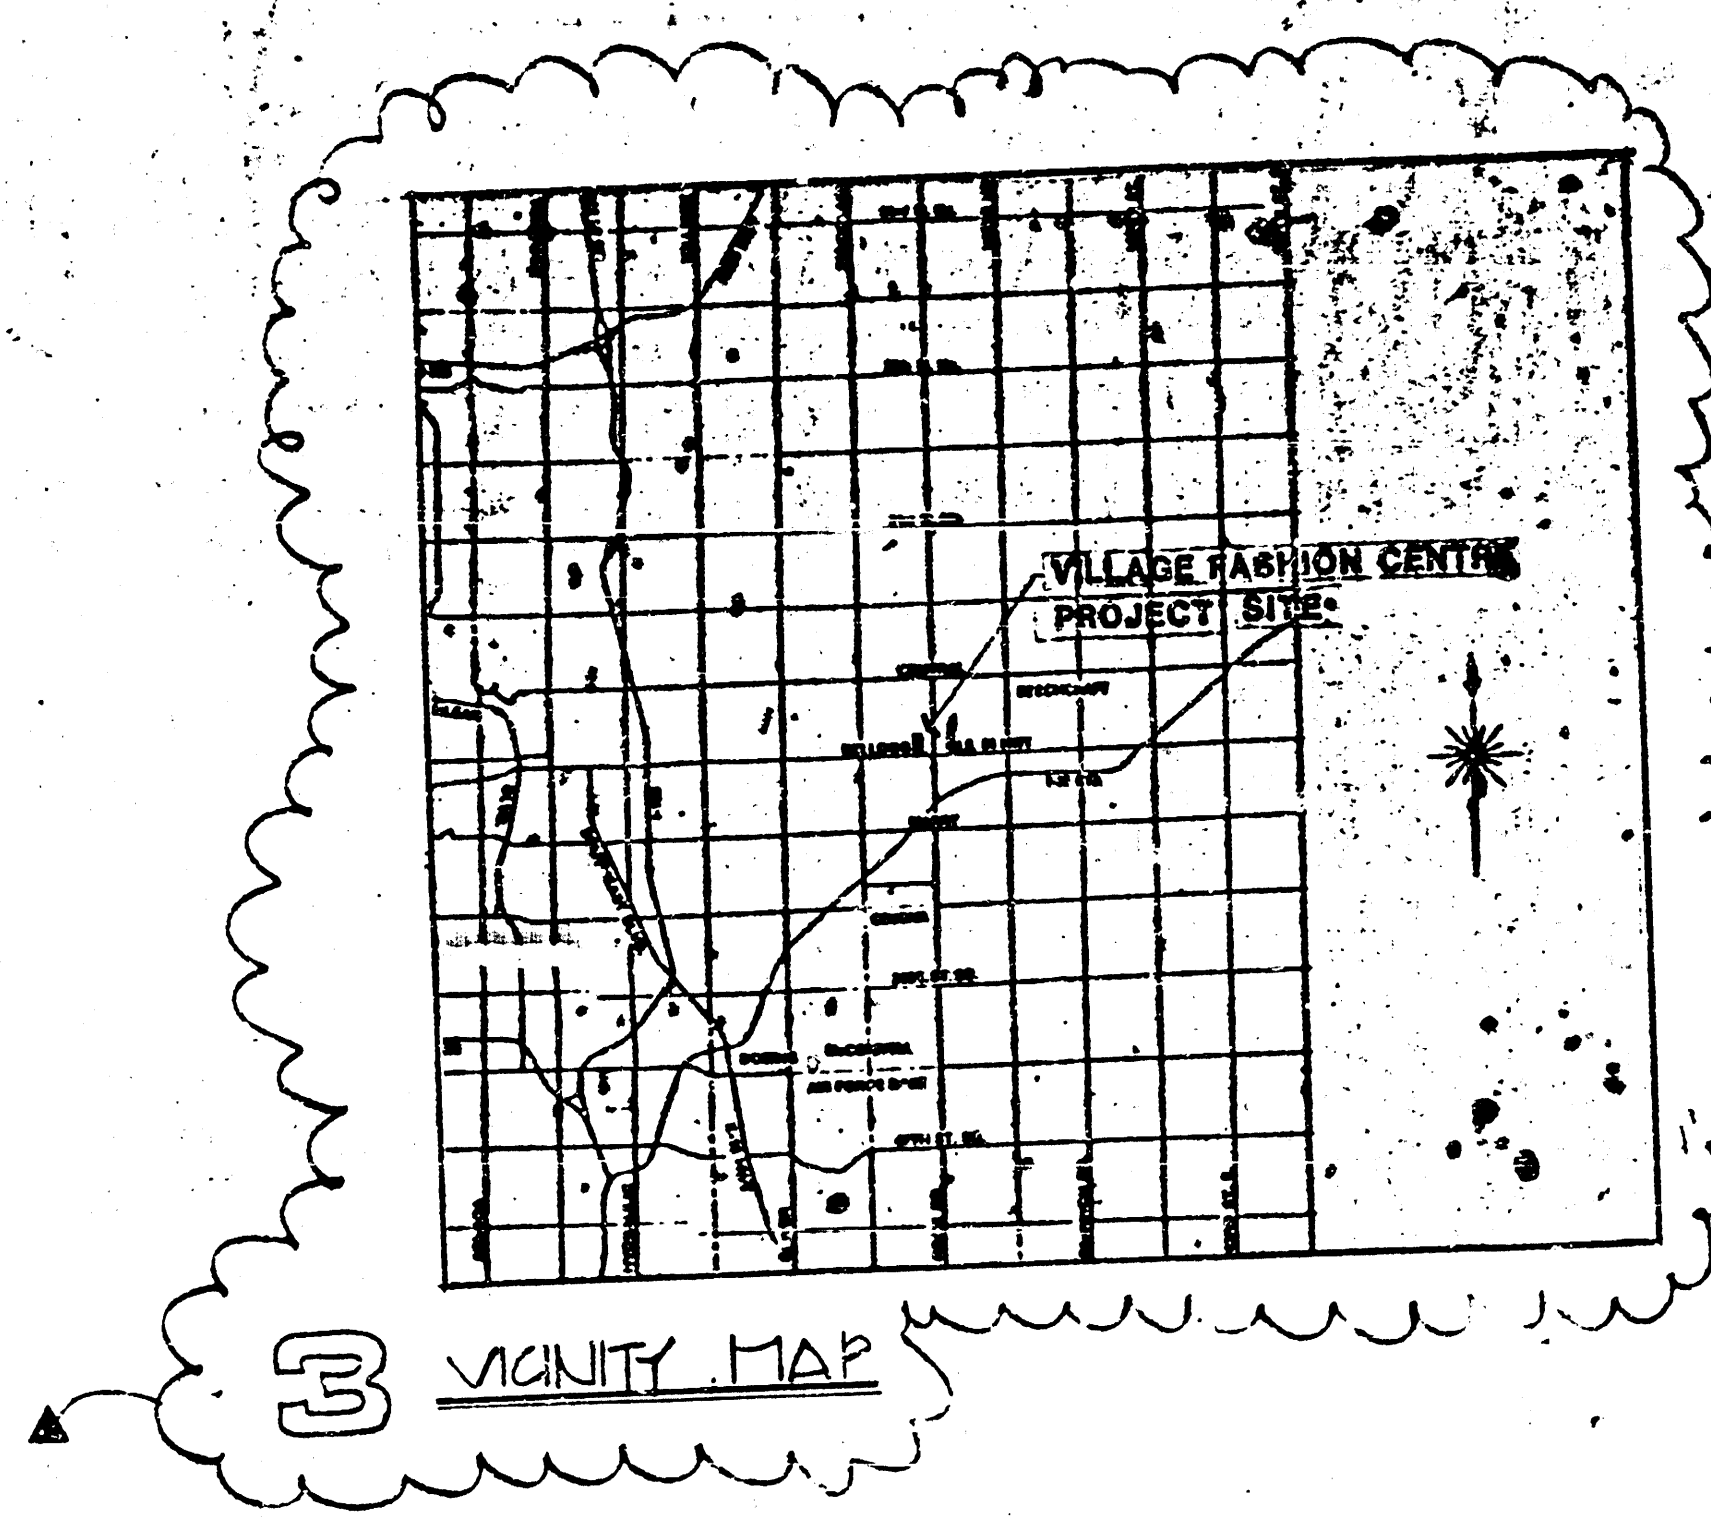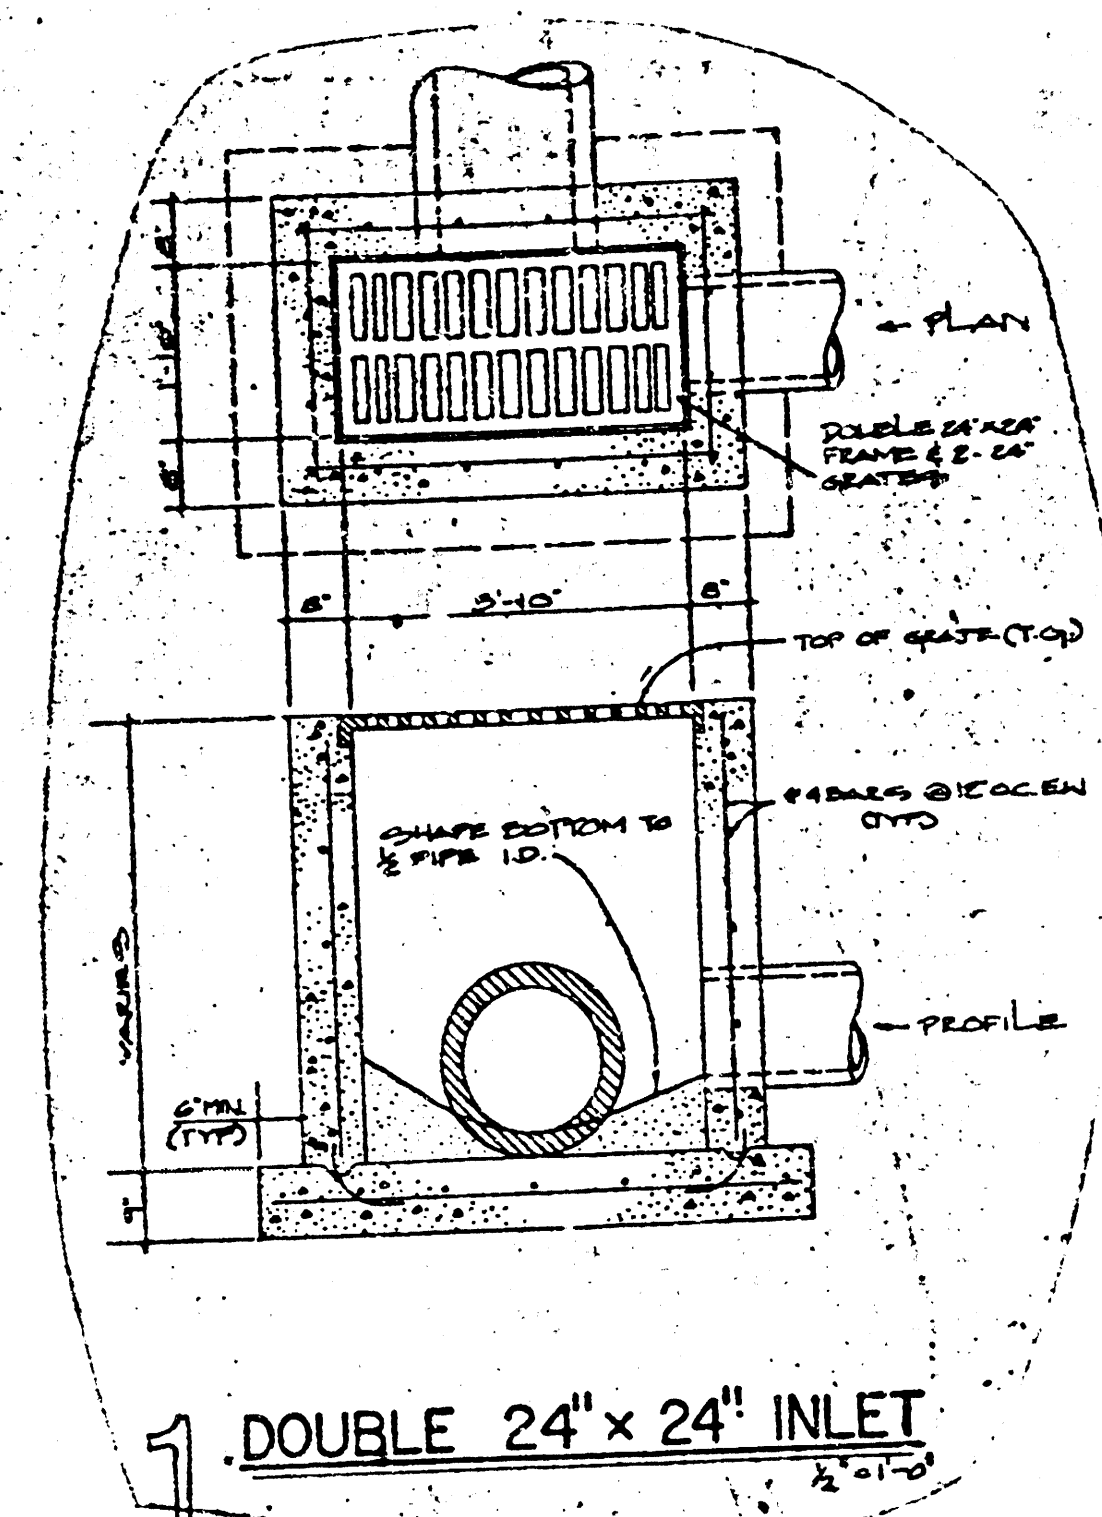

POINT	COORDINATES	DESCRIPTION
1	1818.000 814.000	INLET # A-1
2	1801.000 800.000	INLET # A-2
3	1801.000 800.000	INLET # A-3
4	1800.000 800.000	INLET # A-4
5	1800.000 800.000	INLET # A-5
6	1800.000 800.000	INLET # A-6
7	1800.000 800.000	INLET # A-7
8	1800.000 800.000	INLET # A-8
9	1800.000 800.000	INLET # A-9
10	1800.000 800.000	INLET # A-10
11	1800.000 800.000	INLET # A-11
12	1800.000 800.000	INLET # A-12
13	1800.000 800.000	INLET # A-13
14	1800.000 800.000	INLET # A-14
15	1800.000 800.000	INLET # A-15
16	1800.000 800.000	INLET # A-16
17	1800.000 800.000	INLET # A-17
18	1800.000 800.000	INLET # A-18
19	1800.000 800.000	INLET # A-19
20	1800.000 800.000	INLET # A-20

NOTES

- REFER TO SHEET SA-2 FOR EXACT ELEVATIONS OF SIDEWALKS, SERVICE COURTS, COURTYARDS, ETC. ADJACENT TO BUILDINGS.
- REFER TO PLUMBING PLANS FOR CONTINUATION OF COURTYARD DRAINS, ROOF DRAINS, ETC.
- DO NOT ALLOW HEAVY TRUCKS TO CROSS PIPE WITH LESS THAN 12" COVER. DAMAGED PIPE WILL NEED TO BE REMOVED AND REPLACED PRIOR TO PAVING.

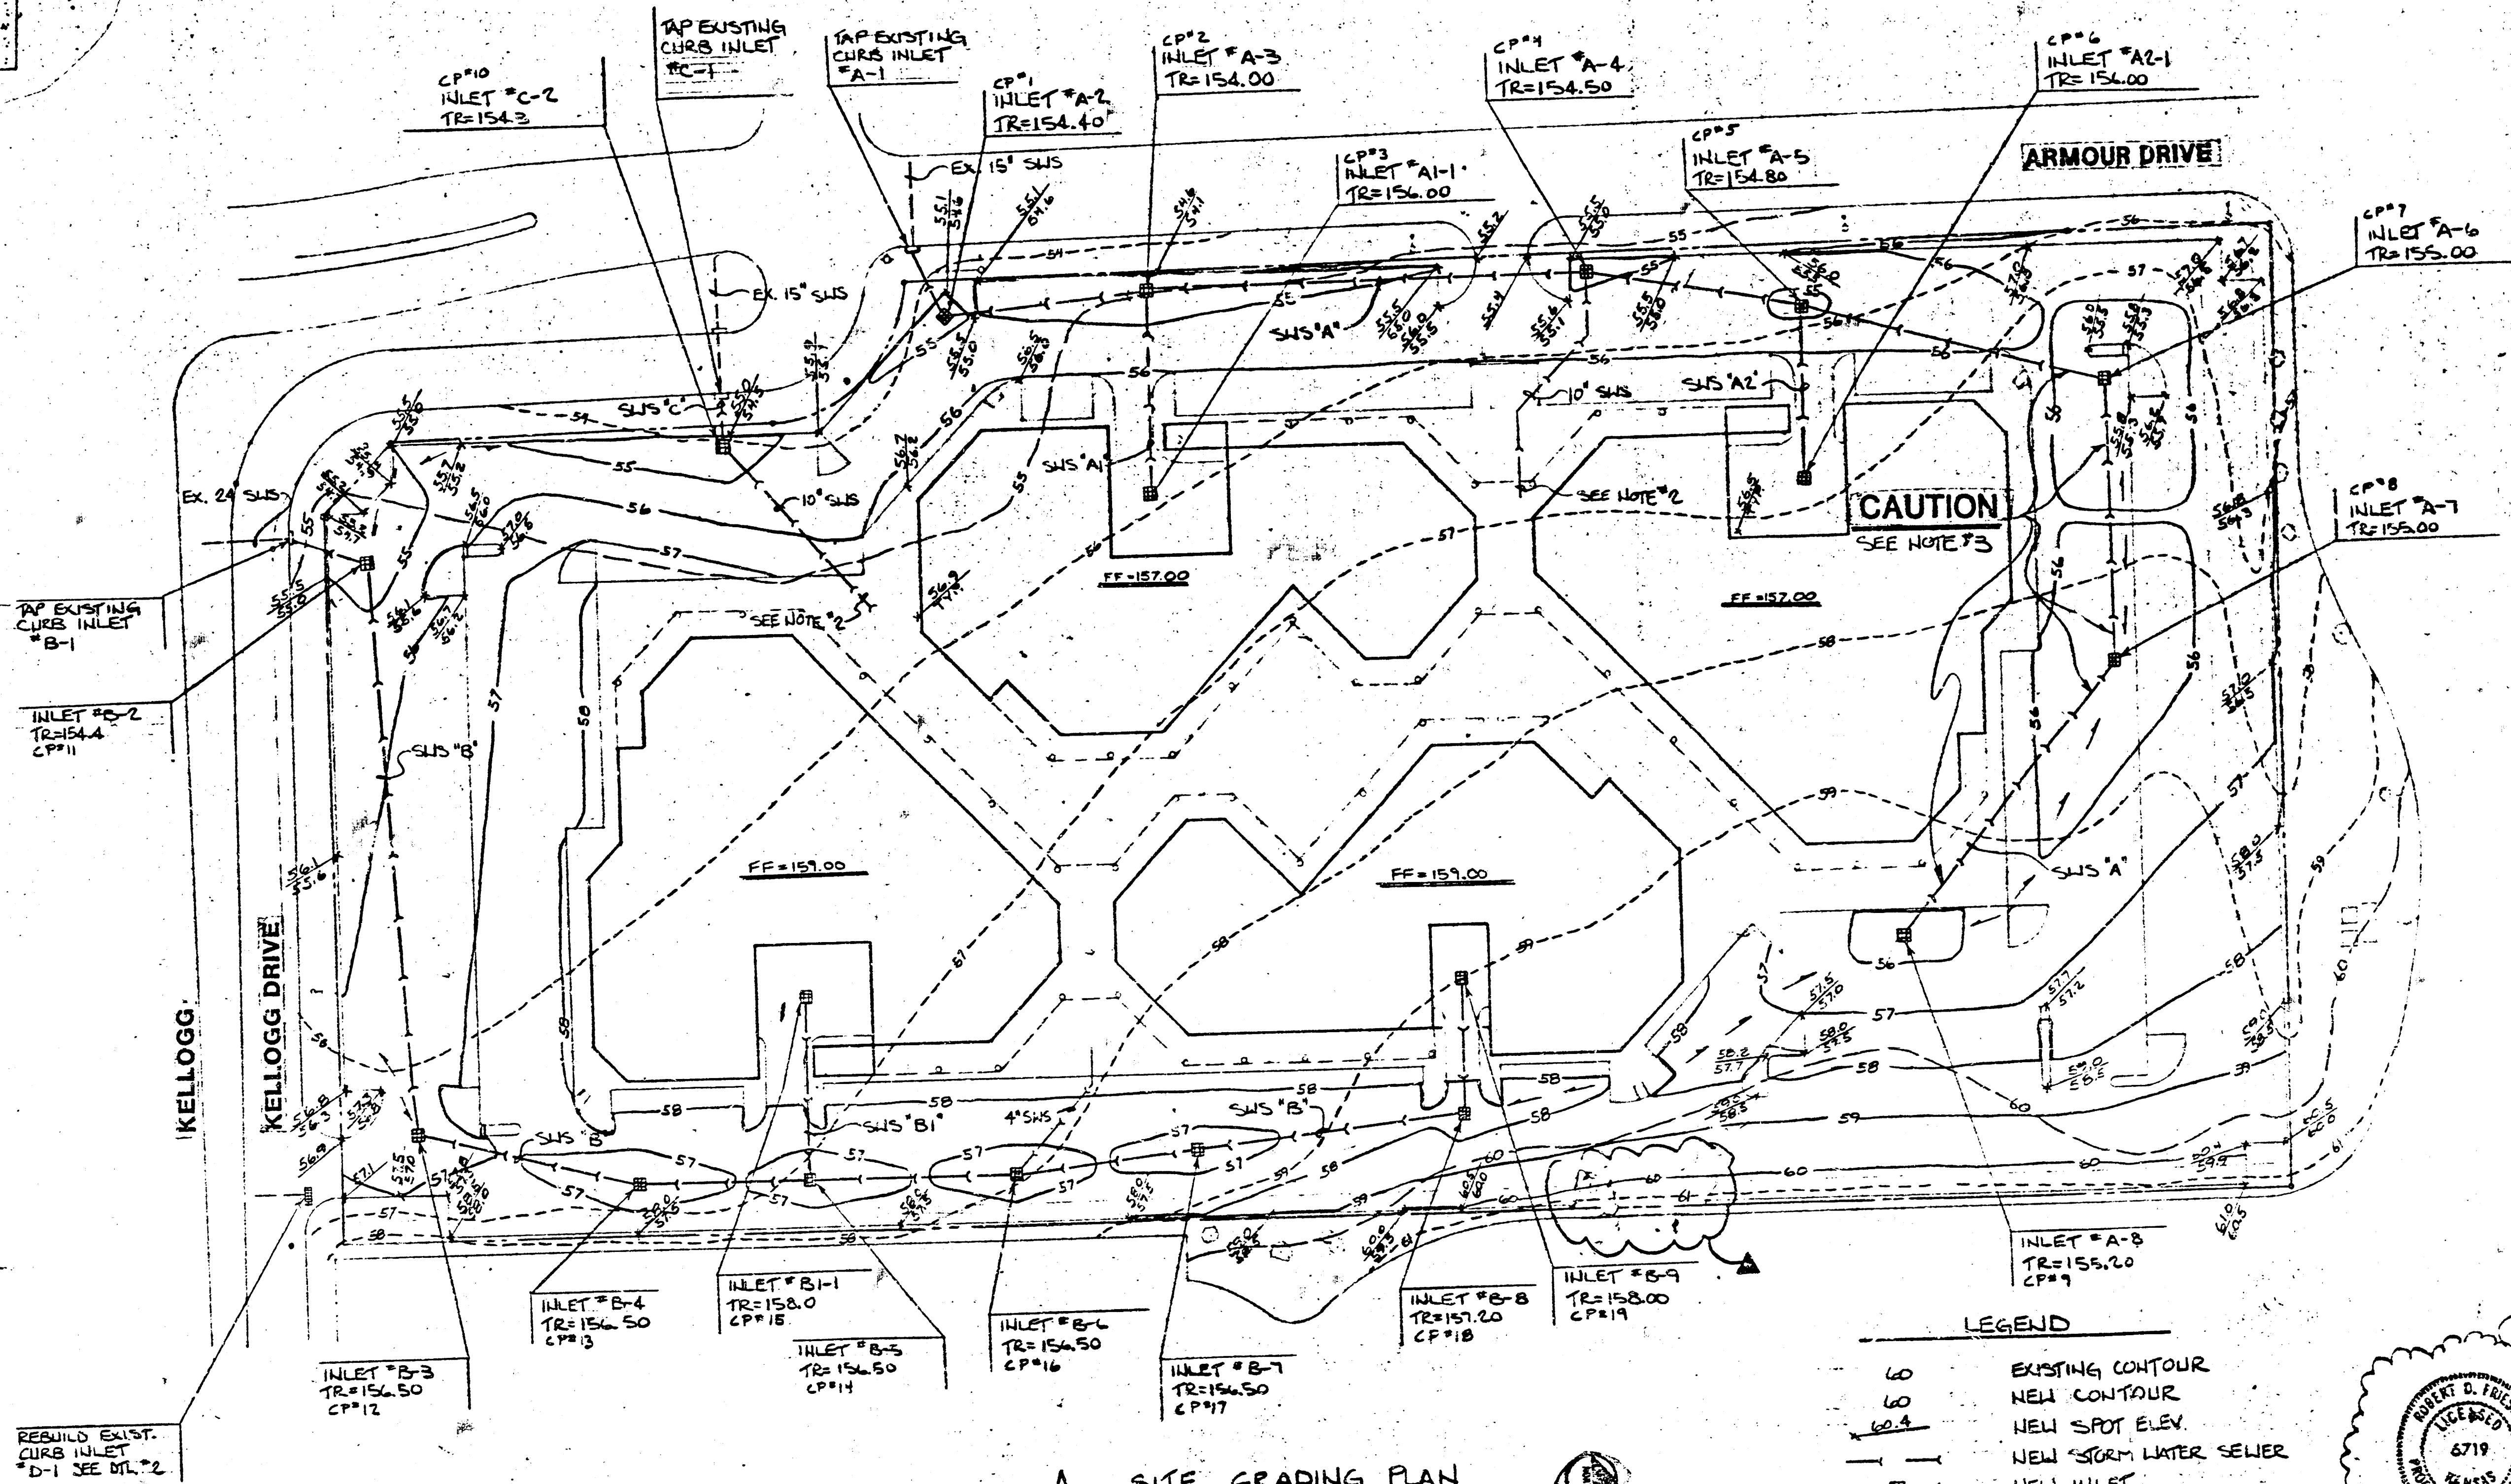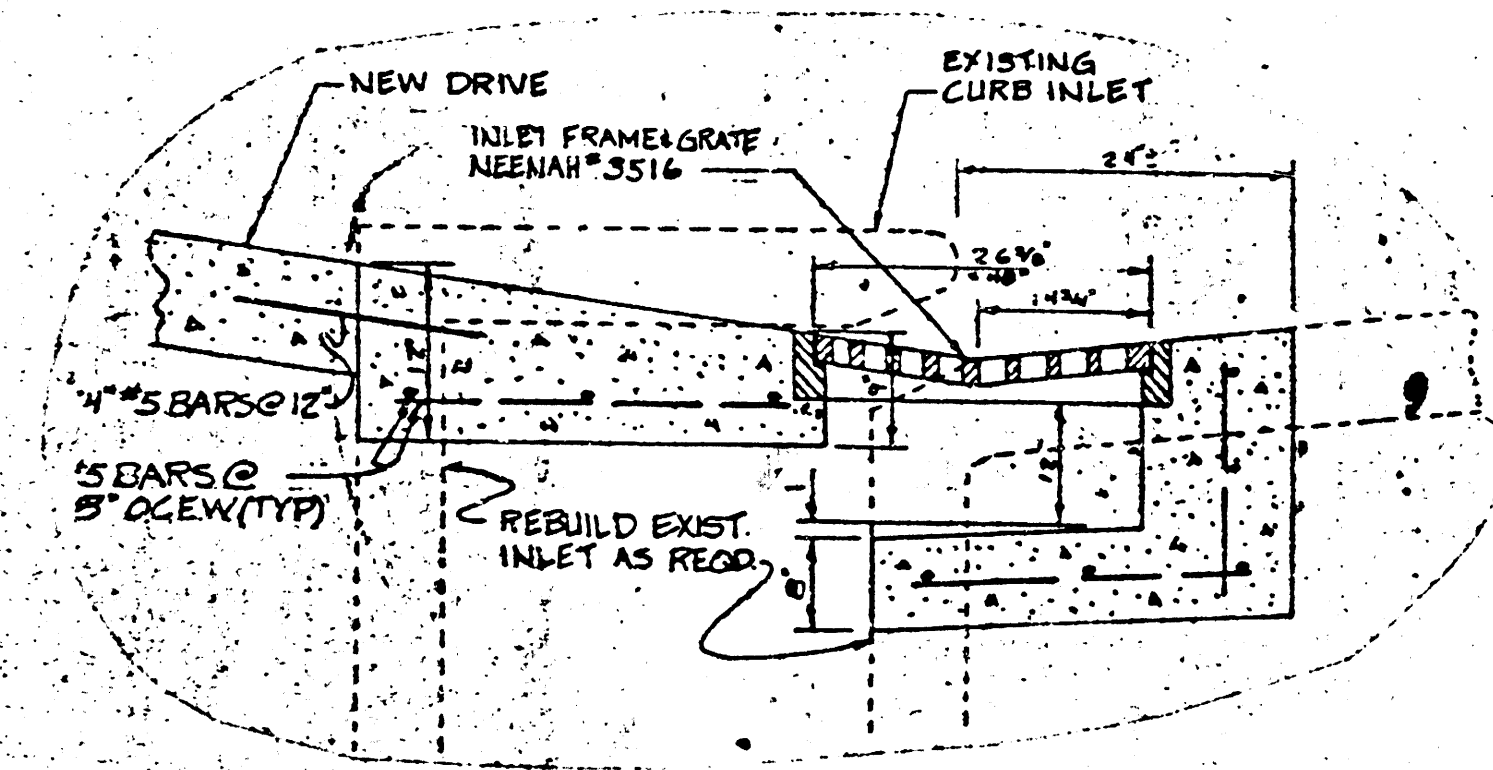

A SITE GRADING PLAN
SCALE: 1" = 40'
HAS BEEN REDUCED TO 1" = 50'

- LEGEND**
- EXISTING CONTOUR
 - - - NEW CONTOUR
 - - - NEW SPOT ELEV.
 - - - NEW STORM WATER SEWER
 - - - NEW INLET
 - - - DRAINAGE


PRINTS ISSUED	
DATE	AMOUNT
11/1/84	FOR CONSTRUCTION
11/1/84	REV. FOR CONSTRUCTION

FOR CONSTRUCTION: 11/1/84

REVISIONS	
DATE	ITEM
11/1/84	DELETED DRIVE
11/1/84	REV. FOR CIV. REVIEW



LAW/KINGDON, INC.
ARCHITECTS & ENGINEERS
540 UNIVERSITY, SUITE 200, KANSAS CITY, MO 64108
PHONE (816) 261-0100

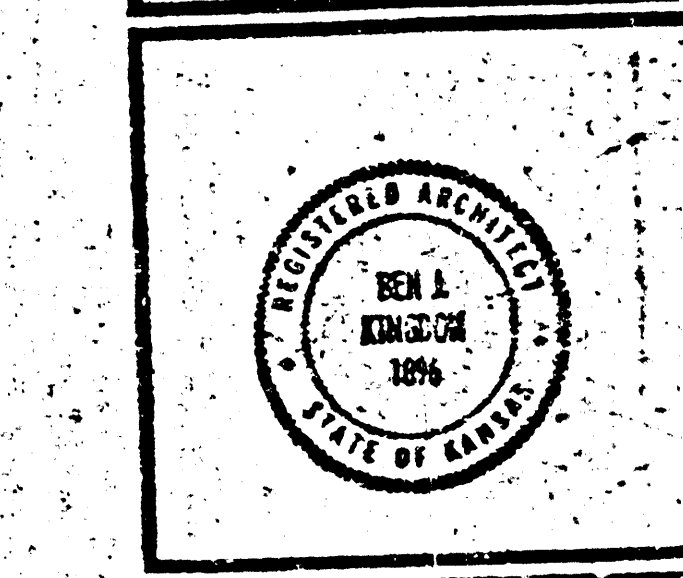



REVISION	CHECKED
1	
2	
3	
4	
5	
6	
7	
8	
9	
10	
11	
12	
13	
14	
15	
16	
17	
18	
19	
20	

Village Fashion Centre
Armour Drive & Kellogg Drive
Wichita, Kansas
PROJECT NUMBER: 7422

KEY PLAN

SITE GRADING PLAN
SHEET TITLE: SG1
SHEET NUMBER: 1 OF 1

FILMED FROM THE BEST AVAILABLE COPY....

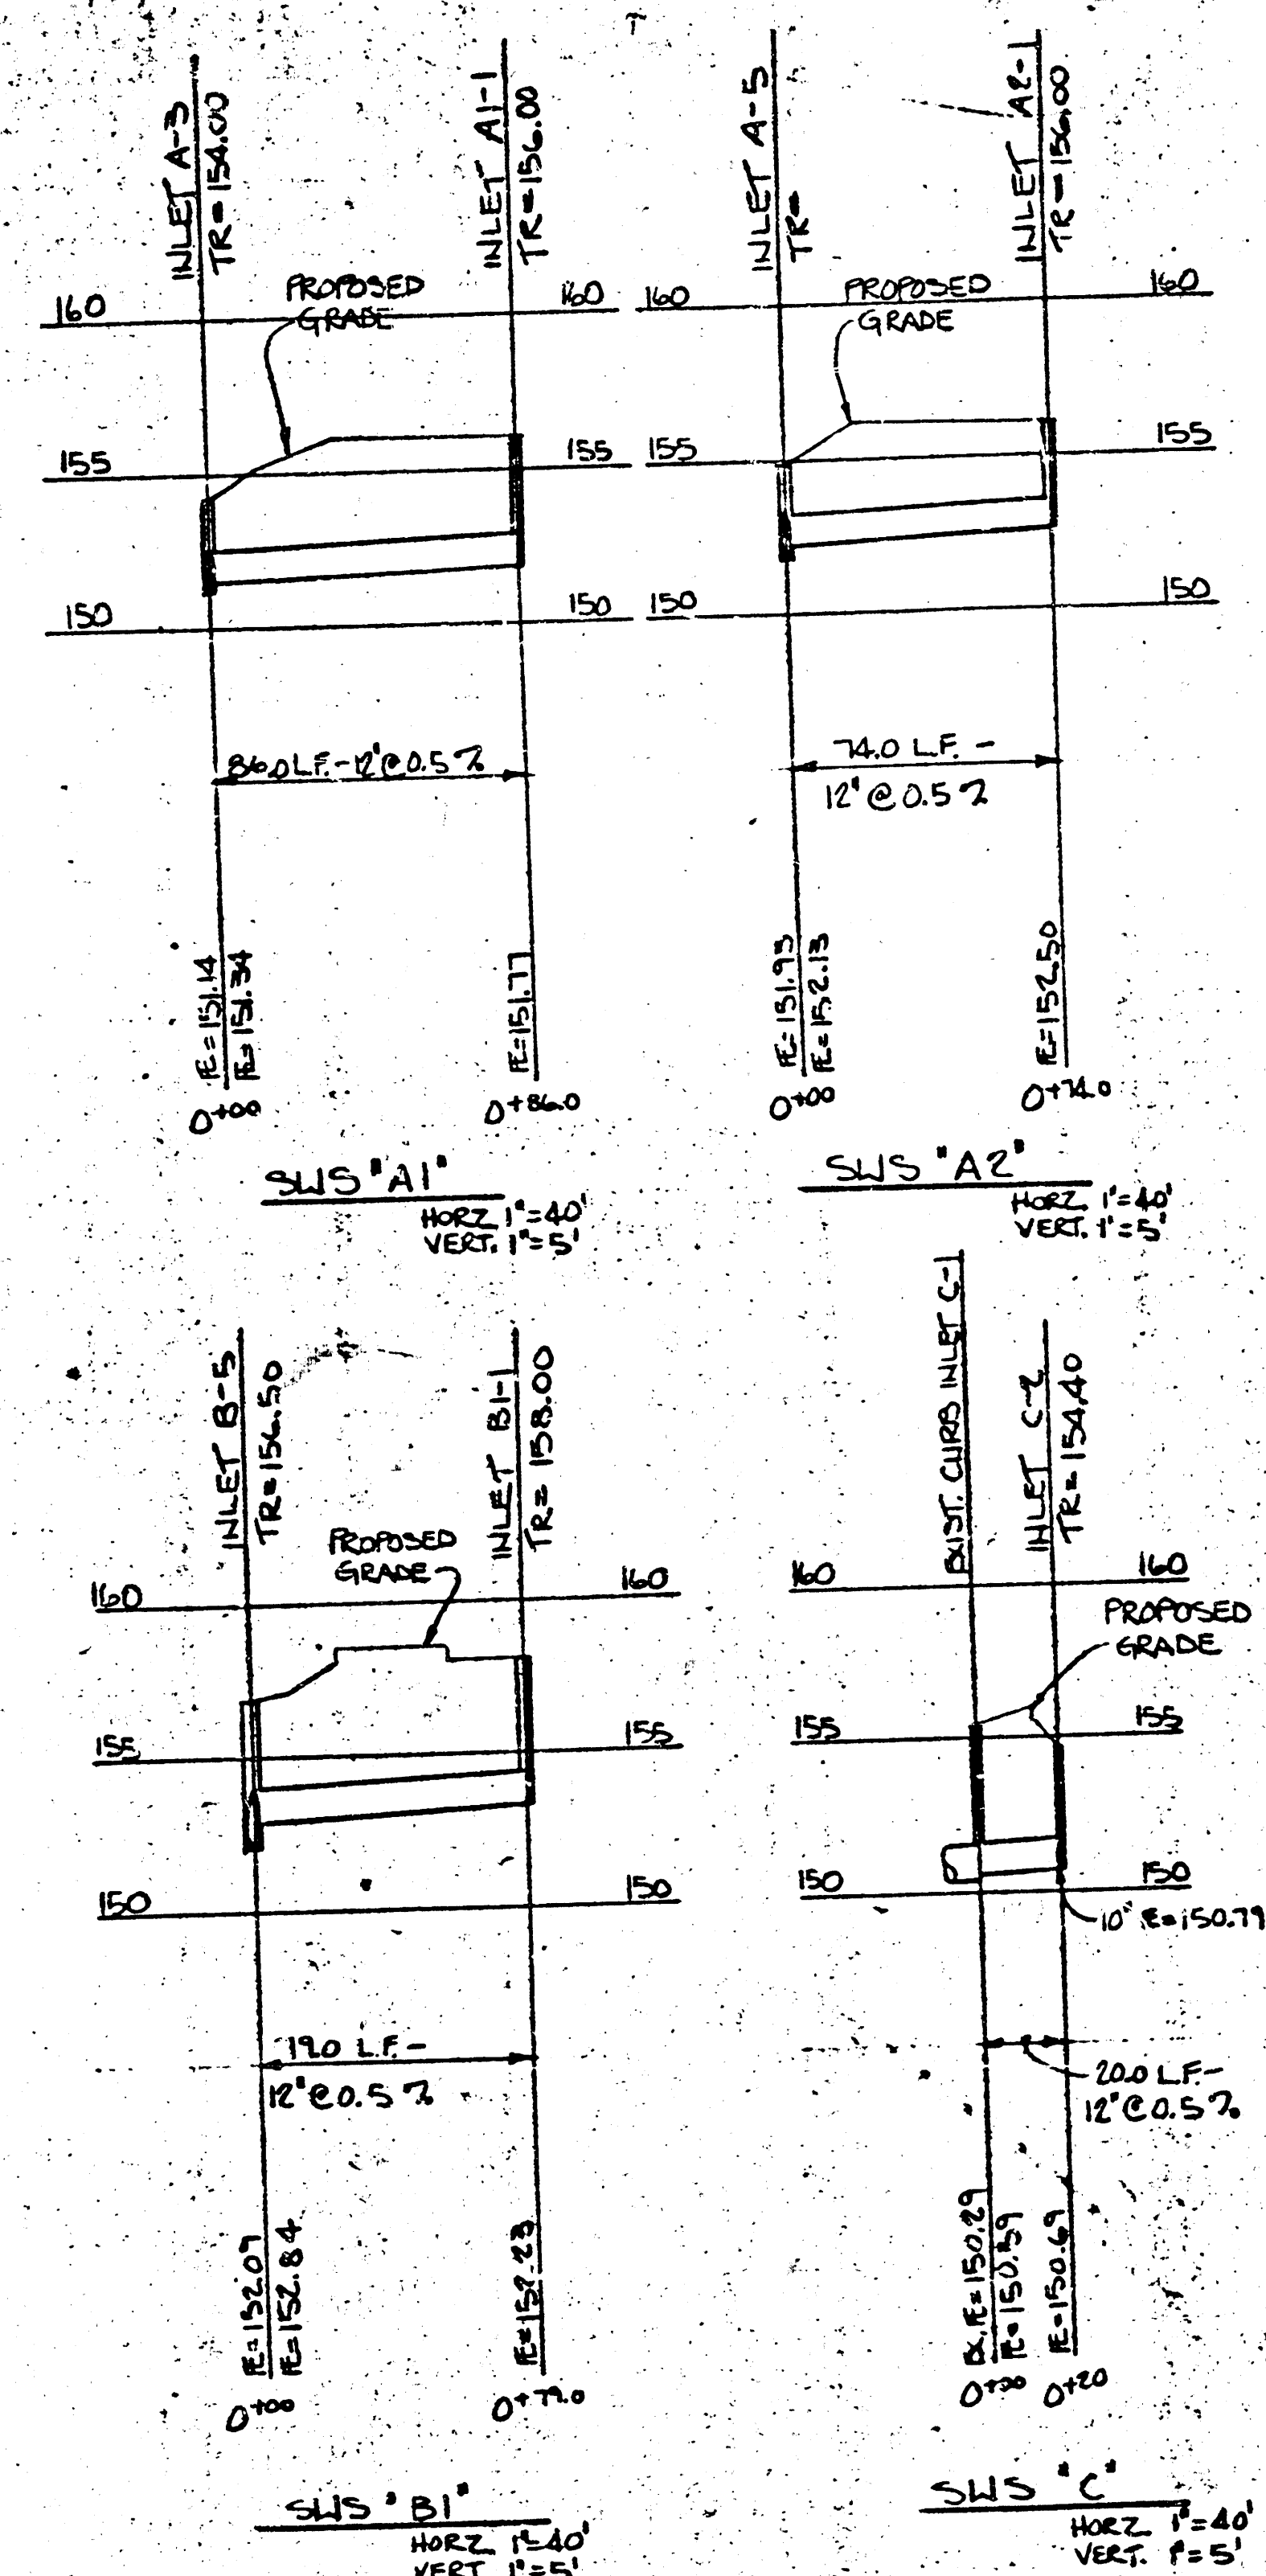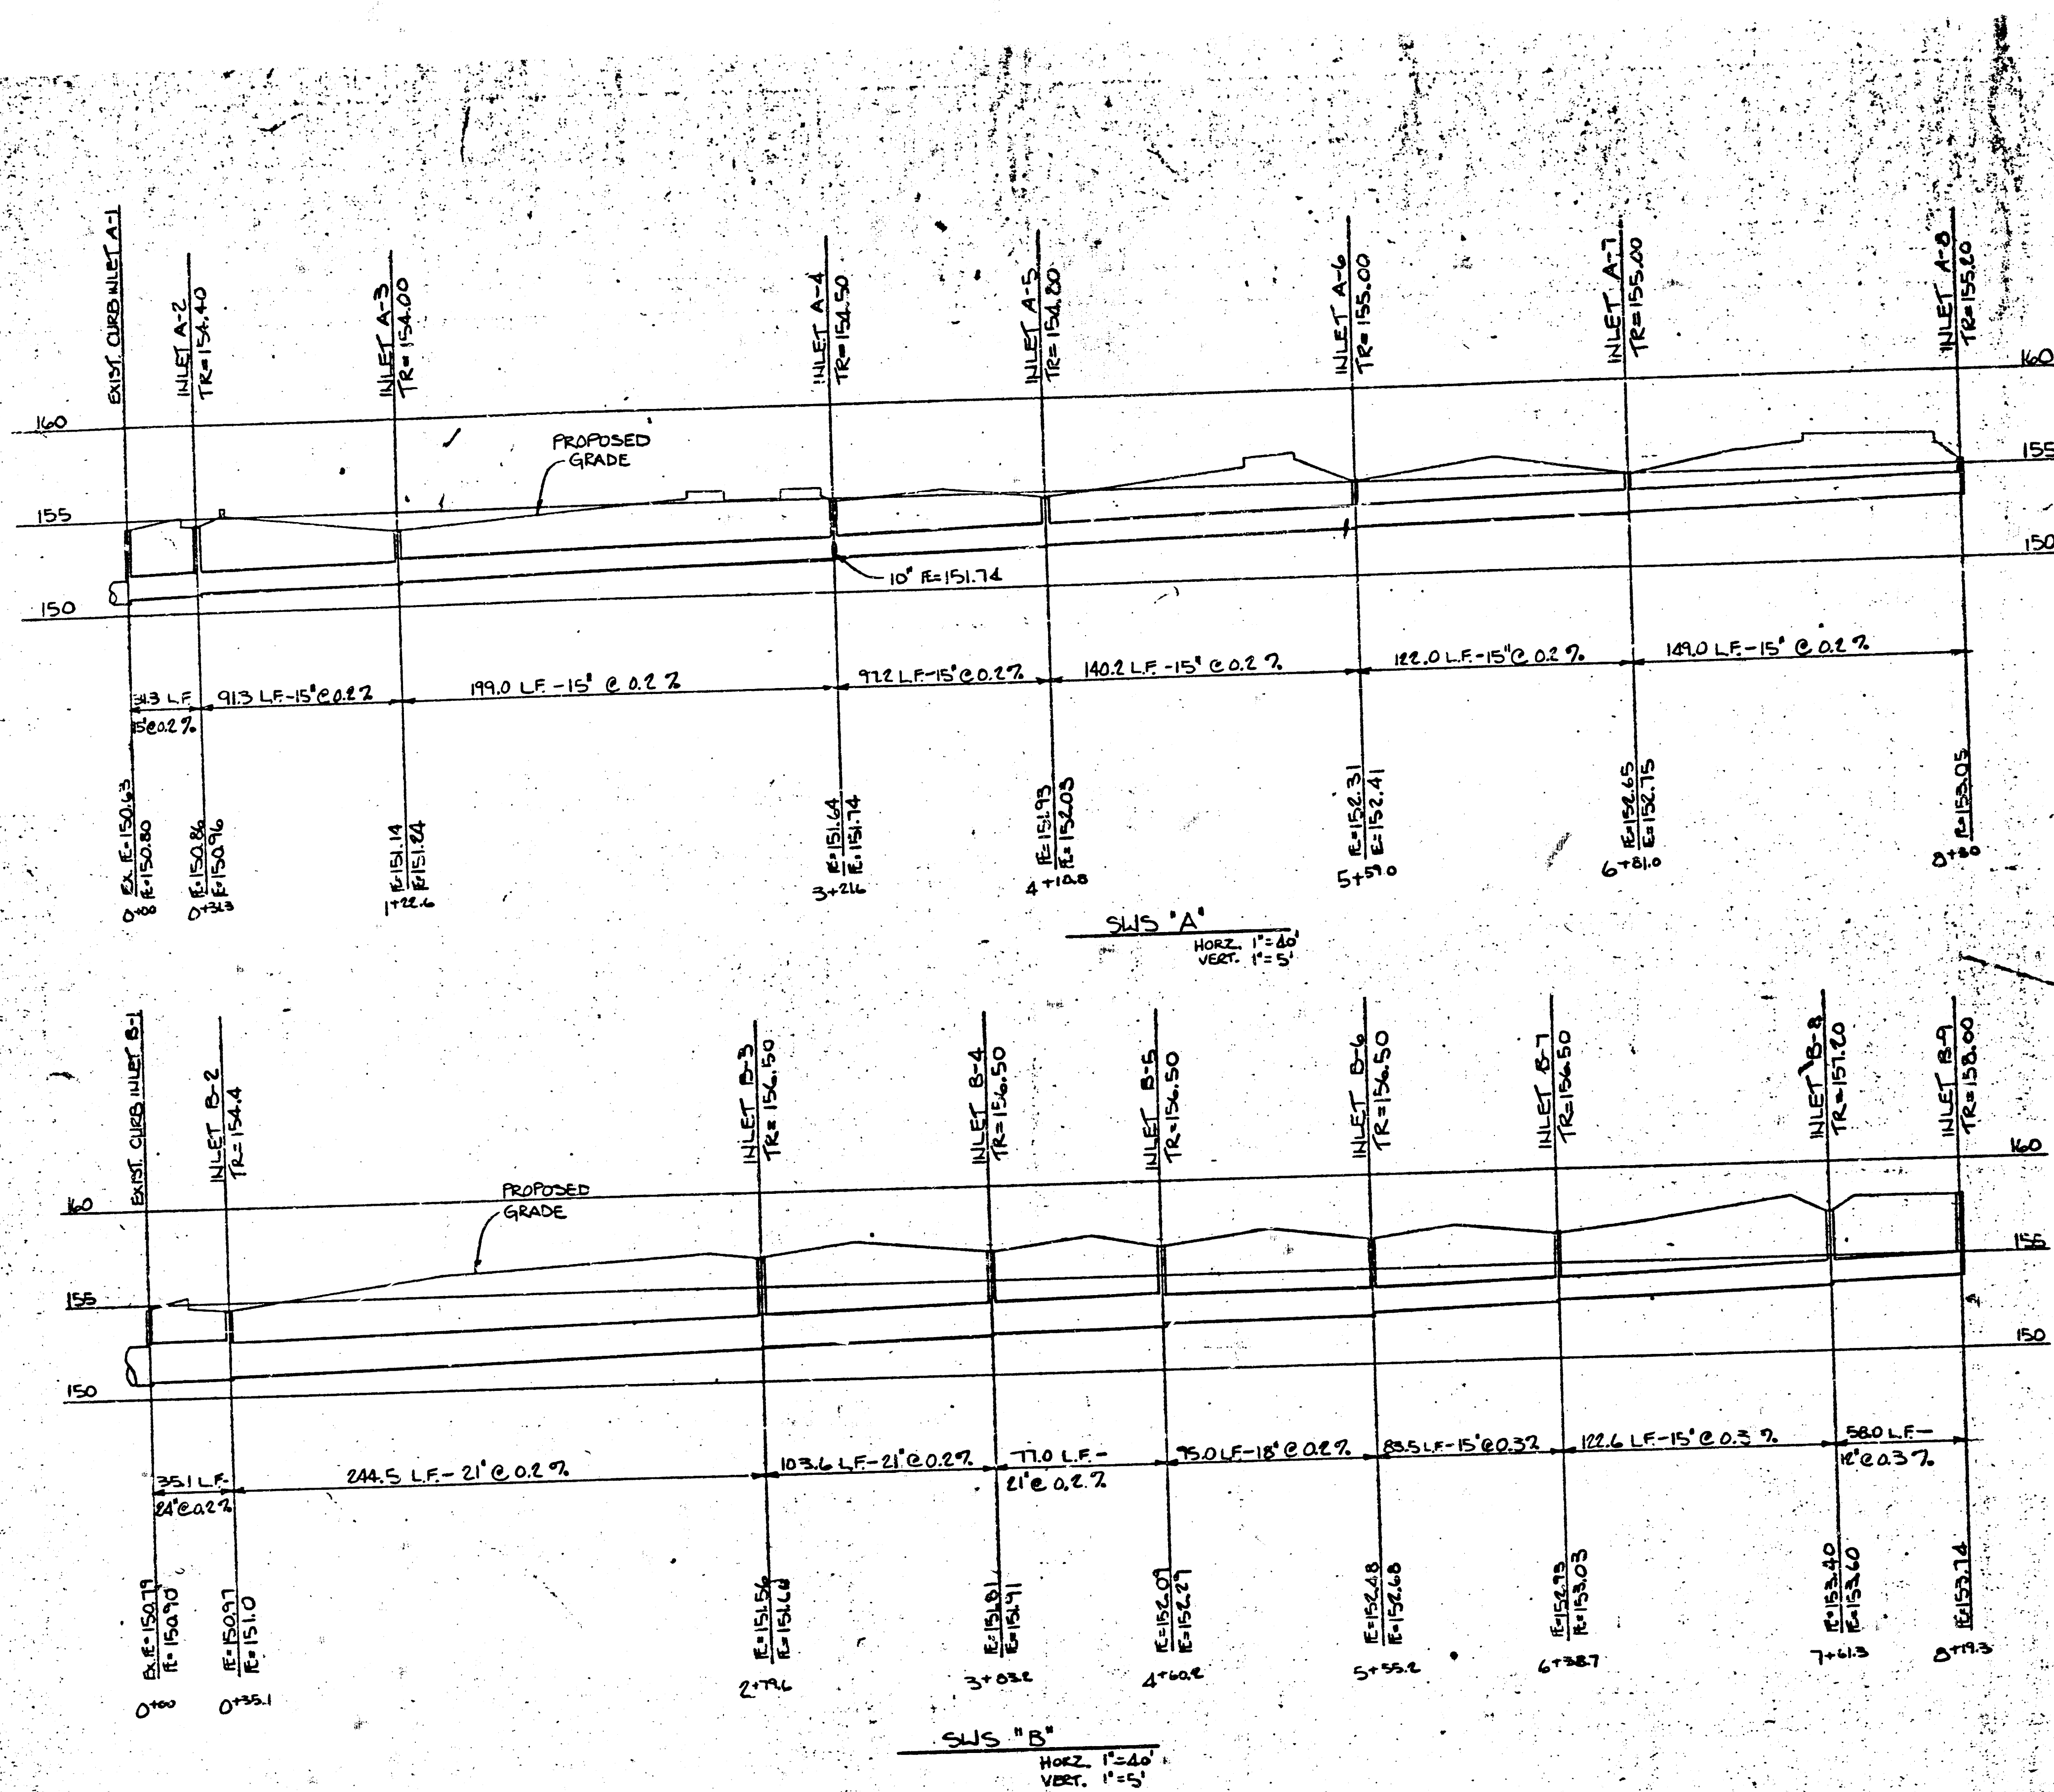

PRINTS ISSUED		
DATE	PURPOSE	NO.
11/1/84	FOR CONSTRUCTION	1
11/1/84	REV. FOR CONSTRUCTION	2

FOR CONSTRUCTION: 11/1/84

REVISIONS		
DATE	ITEM	NO.
11/1/84	REV. FOR CONSTRUCTION	1

LAW/KINGDON, INC.
 ARCHITECTS & ENGINEERS
 301 WEST 10TH AVENUE, SUITE 100
 DENVER, COLORADO 80202
 PHONE (303) 555-0000 FAX (303) 555-0001

REGISTERED ARCHITECT
 LAW/KINGDON
 STATE OF KANSAS

NO.	DESCRIPTION
1	RELAT. DRAWINGS
2	DETAILS
3	STRUCTURE
4	MECHANICAL
5	ELECTRICAL
6	OTHER


SEQUENCE NUMBER: 1 OF 1 SHEETS

Village Fashion Centre
 Armour Drive & Kellogg Drive
 Wichita, Kansas
 PROJECT NUMBER: 1422

KEY PLAN

STORM WATER SEWER PROFILES
 SHEET TITLE: SWS
 SHEET NUMBER: 1422

SG2
 11/1/84

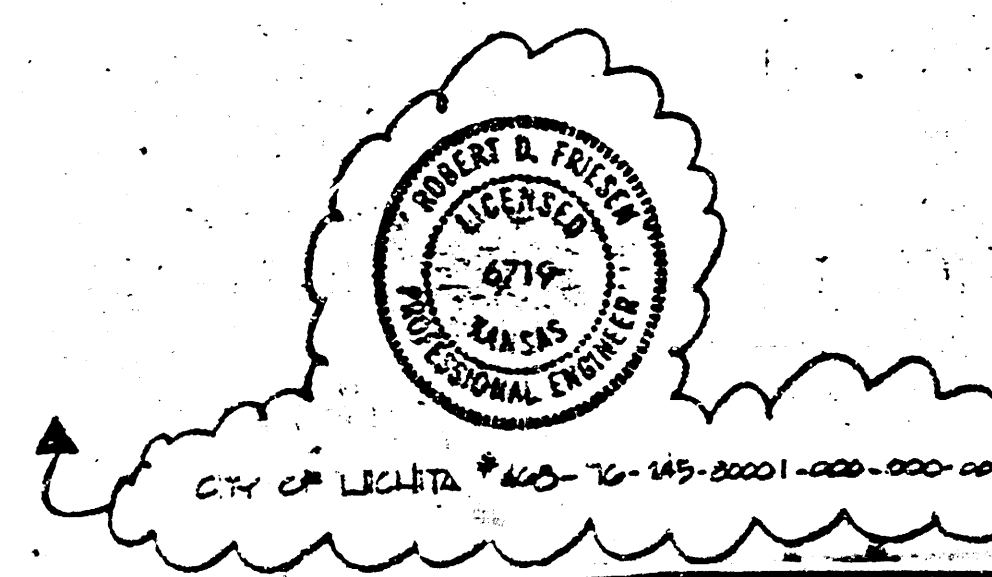

FILMED FROM THE BEST AVAILABLE COPY.....