

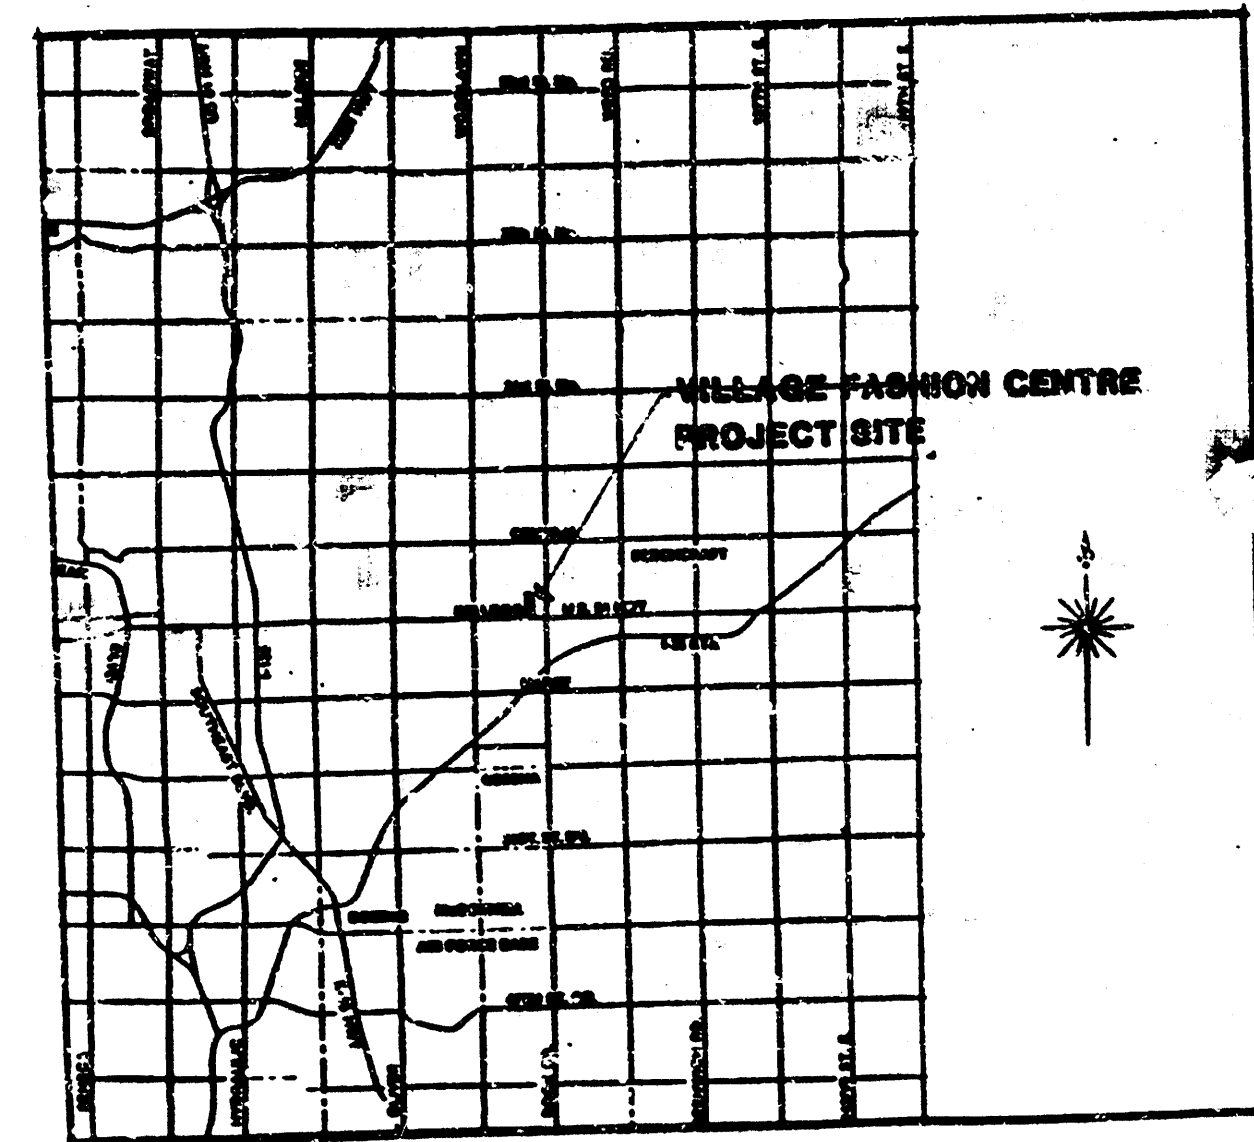


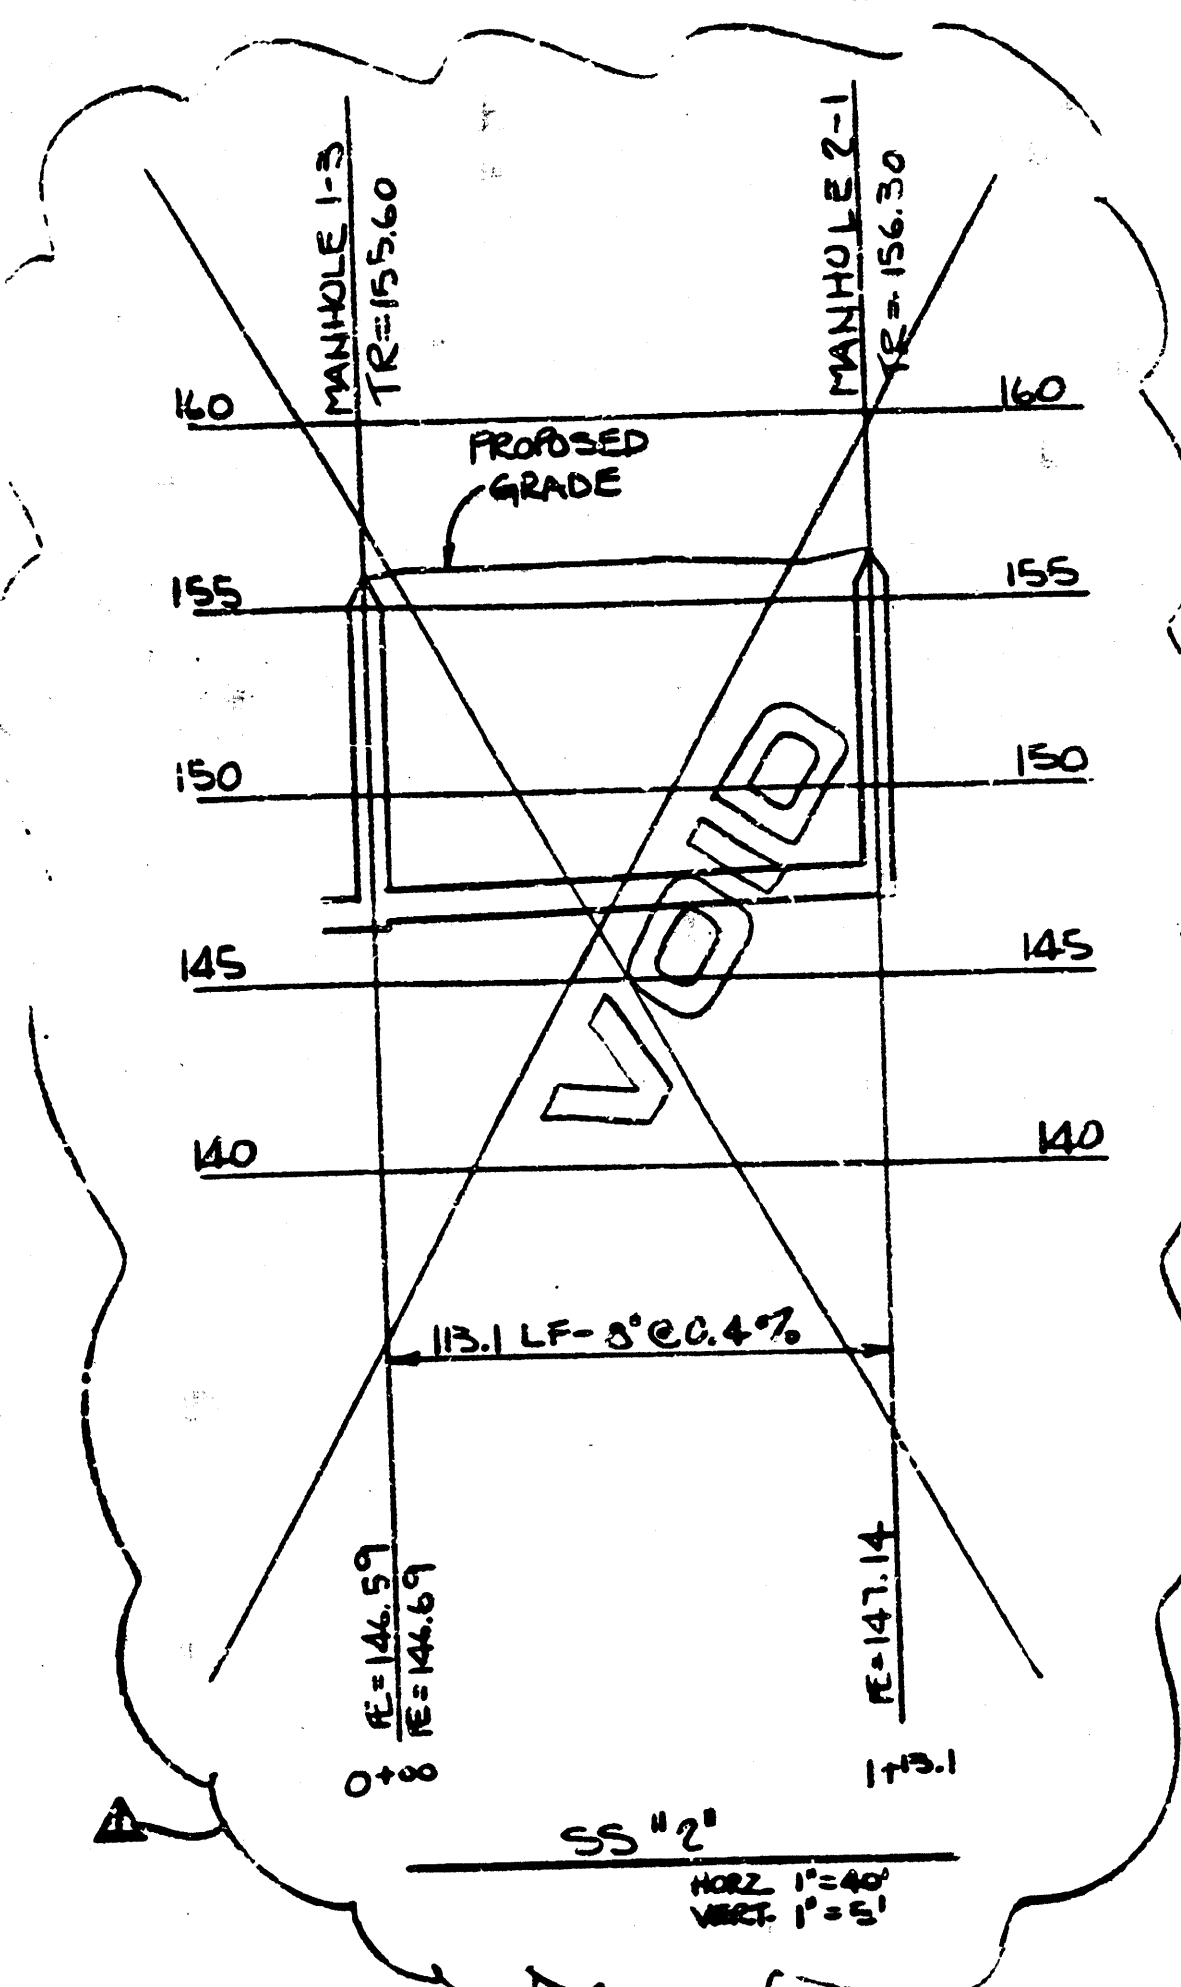

MAP

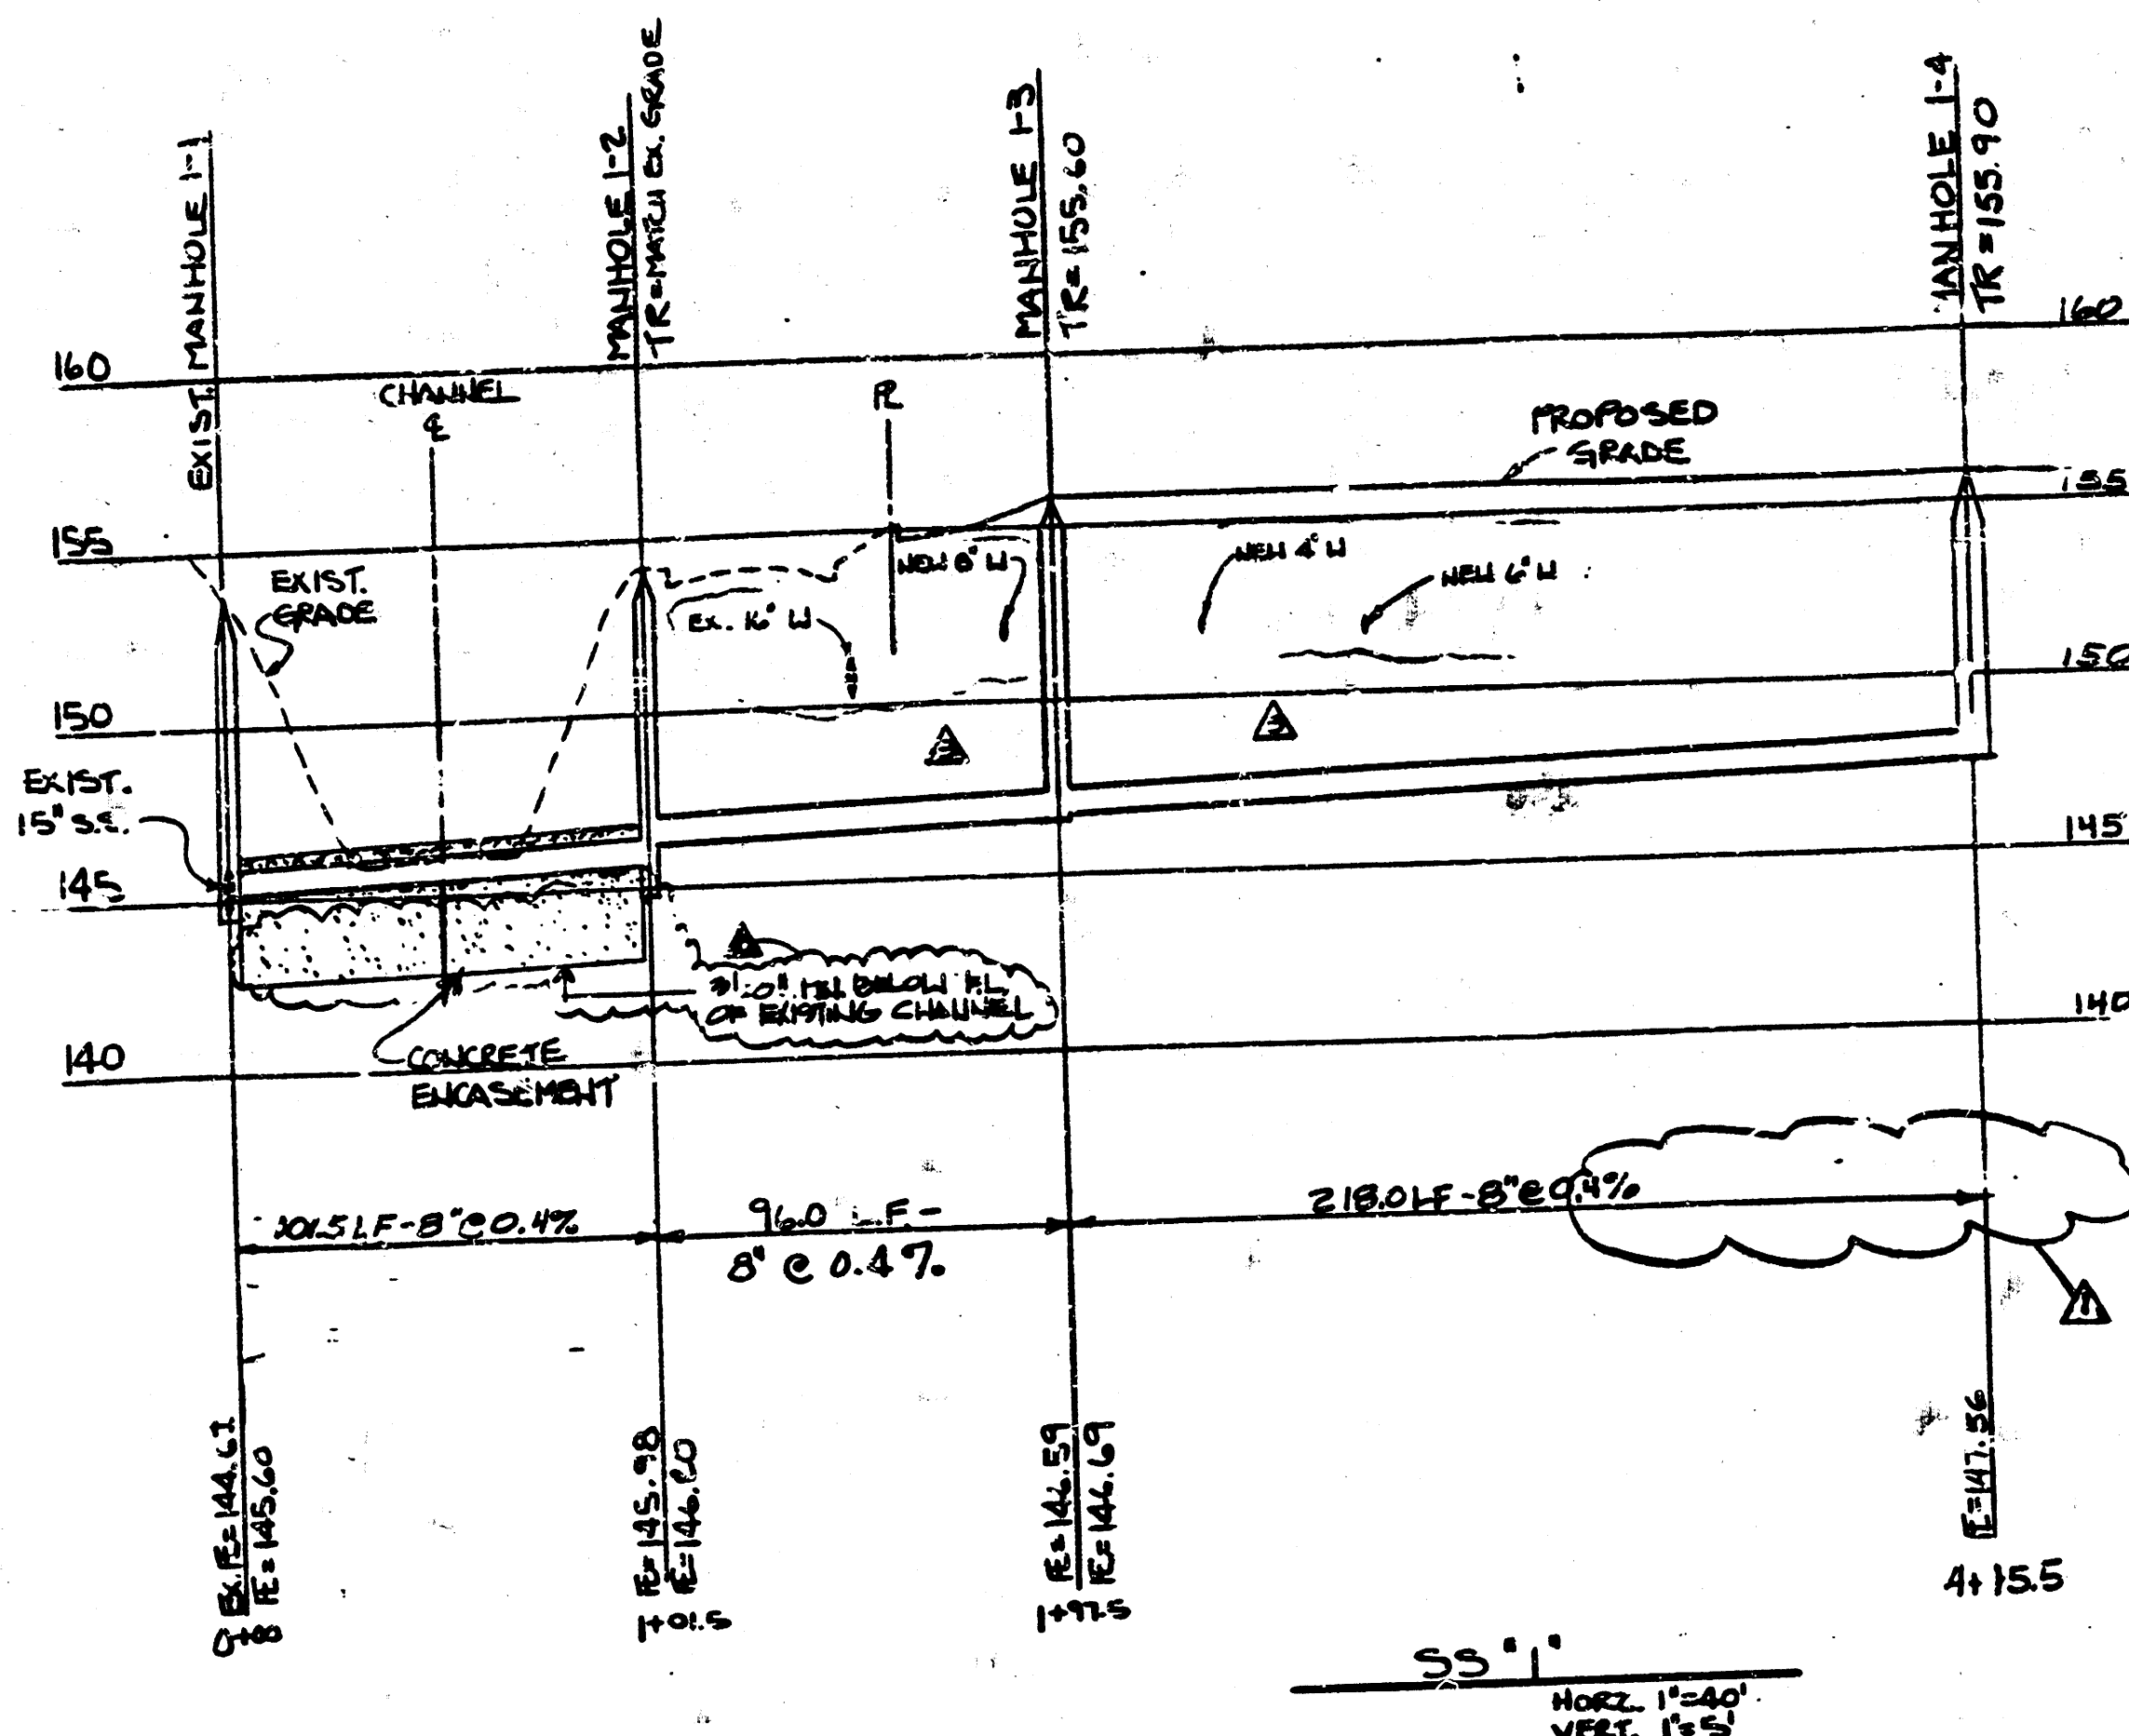


POINT NO.	NORTH	EAST	DESCRIPTION
1	1338.000	538.000	MANHOLE #1-2
2	1338.000	534.000	MANHOLE #1-3
3	1338.000	534.000	MANHOLE #1-4
WATER LINES			
10	1328.000	622.000	TEE
11	1322.000	622.000	45 BEND
12	1327.000	647.000	FIRE HYDRANT
13	1254.000	700.000	45 BEND
14	1125.000	700.000	90 BEND
15	1125.000	553.000	90 BEND
16	1146.000	547.000	FIRE HYDRANT
17	1616.000	548.000	FIRE HYDRANT
18	1630.000	553.000	45 BEND
19	1685.000	500.000	45 BEND
20	1803.000	500.000	90 BEND
21	1825.000	634.000	TEE
22	1738.000	647.000	FIRE HYDRANT

STAKE OUT NOTE
THE CONTRACTOR SHOULD USE THE COORDINATE POINTS TO LOCATE CRITICAL POINTS ON THE SITE. DIMENSION STRINGS AS SHOWN ON SHEET SA-1 SHOULD VERIFY THE COORDINATES HOWEVER ANY DISCREPANCIES SHOULD BE REPORTED TO THE ARCHITECT PRIOR TO PROCEEDING. REFER TO SHEET SA-1 FOR ADDITIONAL COORDINATE INFORMATION.

NOTES

- REFER TO PLUMBING PLANS FOR CONTINUATION OF SANITARY SEWER, DOMESTIC WATER METERS, AND WATER SERVICE LINES FROM THE WATER TO THE BUILDING.
- SITE GAS LINES TO BE DESIGNED AND CONSTRUCTED BY GAS COMPANY AND ARE NOT SHOWN ON THIS PLAN. CONTRACTOR TO COORDINATE LOCATION WITH GAS COMPANY.
- CONTRACTOR TO COORDINATE WATER LINE ELEVATIONS WITH SANITARY AND STORM SEWERS. WATER LINES TO HAVE A MINIMUM OF 36" COVER.
- REFER TO ARCHITECTURAL AND PLUMBING PLANS FOR EXACT LOCATION AND DETAILS OF SPRINKLER RISERS. THE DETAILS OF THE SPRINKLER RISER SHOWN IS FOR GENERAL REFERENCE ONLY AND NOT FOR CONSTRUCTION.
- ALL WATER AND SEWER LINE CONSTRUCTION TO BE IN ACCORDANCE WITH "CITY OF WICHITA" STANDARDS AND SPECIFICATIONS.
- COORDINATION WITH PAVING. IT IS IMPERATIVE THAT THE CONTRACTOR COORDINATE WATER LINE CONSTRUCTION WITH THE PAVING CONTRACTORS. SEE SPECIAL PROVISIONS IN SPECIFICATION #14533.
- ALL WATER MAINS TO HAVE A MIN. OF 1' CLEARANCE BETWEEN BOTTOM OF STORM SEWER PIPE AND TOP OF WATER MAIN.
- NOTIFY THE FOLLOWING COMPANIES PRIOR TO ANY TRENCING.

ARIELA GAS CO.	942-8350
BELL TEL. CO.	1-571-2115
CABLEVISION	266-6817
GAS SERVICE CO.	263-7511
KANSAS CO. & ELECTRIC	261-6248
KANSAS-ONE-CALL	1-800-344-7233
- ALL BLOCK CORNERS AND CONTROL POINTS WILL BE PROTECTED. IF REMOVED DURING CONSTRUCTION, CONTRACTOR WILL HAVE THEM REPLACED BY A LICENSED ENGINEER OR LAND SURVEYOR AT HIS EXPENSE.
- ALL WATER MAINS AND APPURTENANCES SHALL BE INSTALLED IN ACCORDANCE WITH STANDARD SPECIFICATION FOR WATER MAIN INSTALLATIONS, NUMBER 14533.
- SPECIAL NOTE: AS THESE WATER MAINS ARE BEING INSTALLED IN A BASEMENT ON PRIVATE PROPERTY, IT WILL BE THE DEVELOPER'S RESPONSIBILITY FOR LOCATING AND STAKING THE BASEMENT AND ESTABLISHING THE FINISH GRADE OF THE SURFACE OVER THE WATER MAINS AND APPURTENANCES PRIOR TO INSTALLATION OF MAINS. THIS WILL NOT BE DONE BY THE WATER DEPT. UNDER ANY CIRCUMSTANCES.
- THERE IS TO BE NO WORK STARTED BY THE CONTRACTOR PRIOR TO NOTIFICATION AND APPROVAL OF THE CONSTRUCTION ENGINEER OF CONSTRUCTION AND SURVEY DIVISION OF OPERATIONS AND MAINTENANCE AND PRESENCE OF A DEPARTMENT INSPECTOR ON THE SITE. SHOULD CONSTRUCTION BE LIMITED PRIOR TO THESE REQUIREMENTS BEING MET, THE CONTRACTOR WILL BE REQUIRED TO REOPEN THE DITCHES.

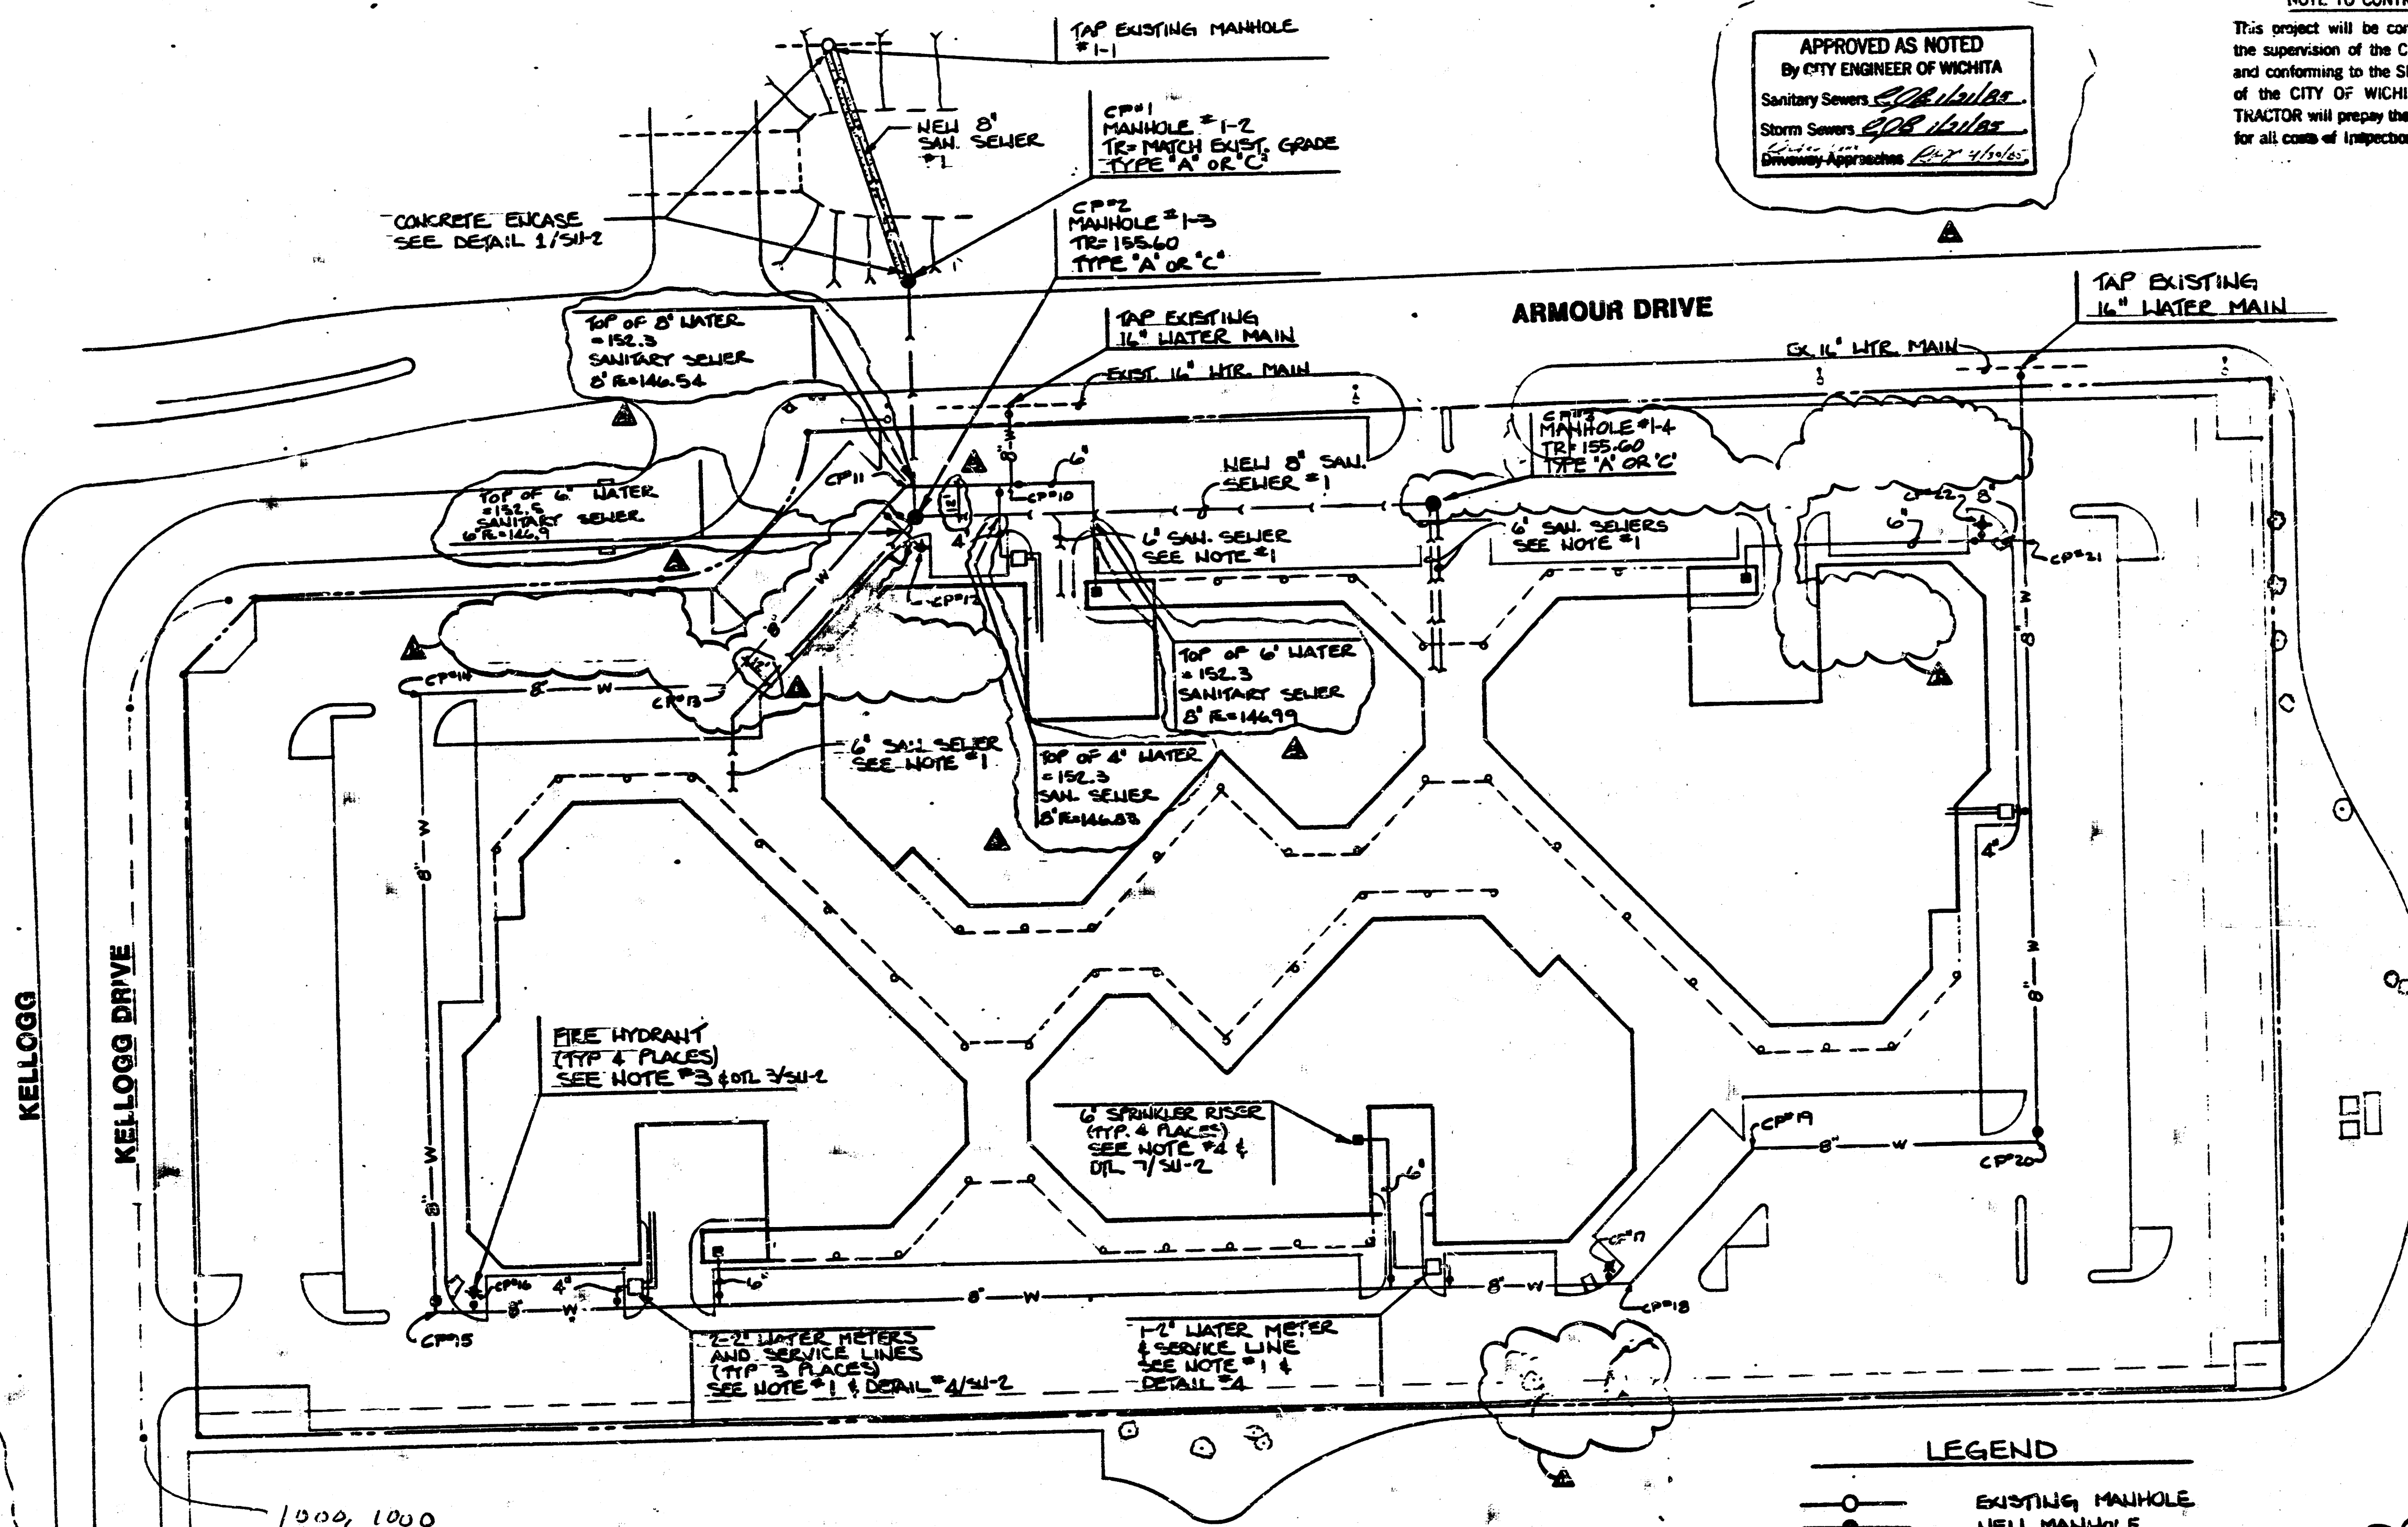

A SITE UTILITY PLAN
SCALE: 1"=40'
50'

- LEGEND**
- EXISTING MANHOLE
 - NEW MANHOLE
 - NEW SAN. SEWER
 - NEW WATER MAIN
 - EXISTING FIRE HYDRANT
 - NEW FIRE HYDRANT
 - NEW WTR. VALVE & BOX




CITY OF WICHITA 446-76-2001-000-000-000
WATERLINE PRIVATE PROJECT 446-76-2001-000-000-000-000


PRINTS ISSUED		
DATE	PERSON	NO.
11/1/84	FOR CONSTRUCTION	20
11/1/84	REV. FOR CONSTRUCTION	21

FOR CONSTRUCTION: 11/1/84


REVISIONS		
DATE	BY	NO.
11/1/84	REV. FOR CONSTRUCTION	20
11/1/84	REV. FOR CONSTRUCTION	21
11/1/84	REV. FOR CONSTRUCTION	22

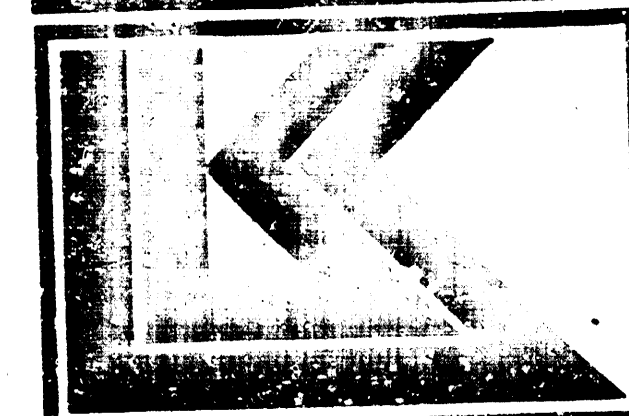

LAW/KENNEDY, INC.
ARCHITECTS & ENGINEERS
800 SOUTH WICHITA, KANSAS 67202
PHONE (913) 263-0000





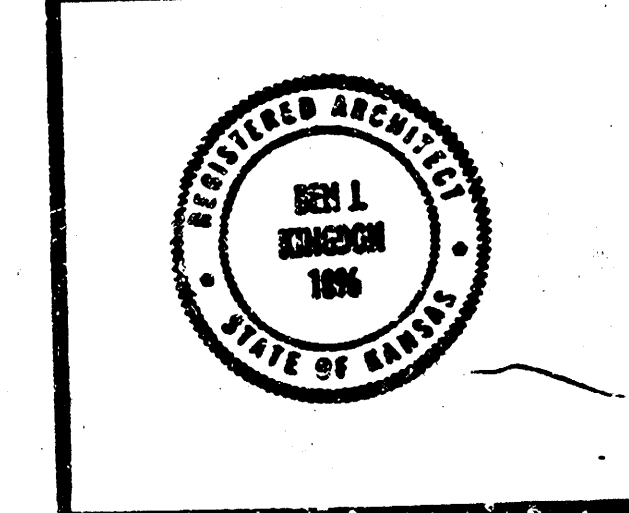


DATE	BY	NO.
11/1/84	REV. FOR CONSTRUCTION	20
11/1/84	REV. FOR CONSTRUCTION	21
11/1/84	REV. FOR CONSTRUCTION	22

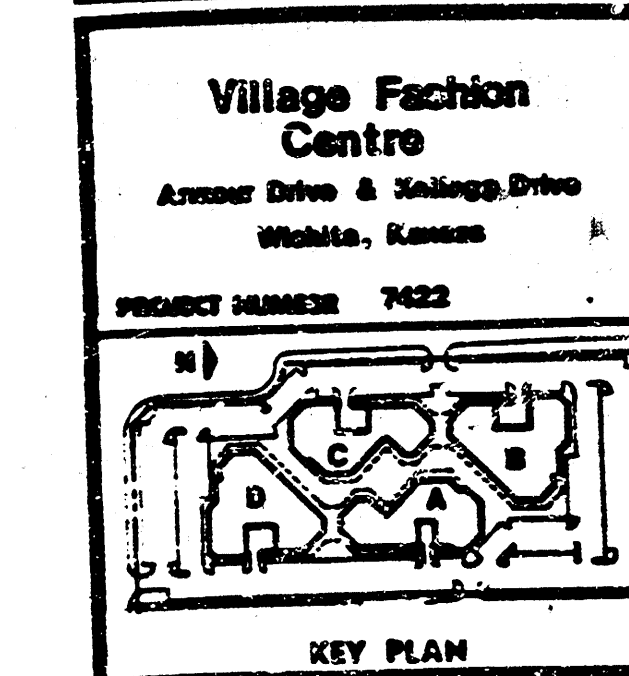

SITE UTILITY PLAN	
SHEET NO.	SHEET TOTAL
1	1

FILMED FROM THE BEST AVAILABLE COPY

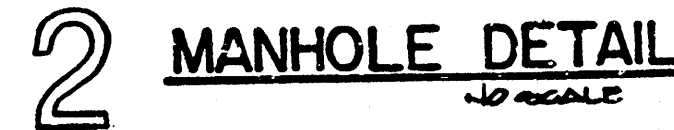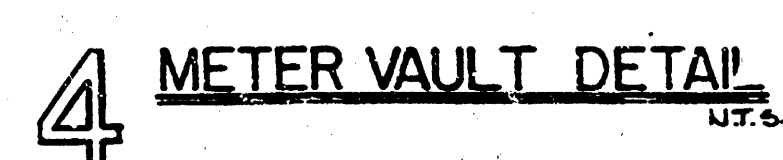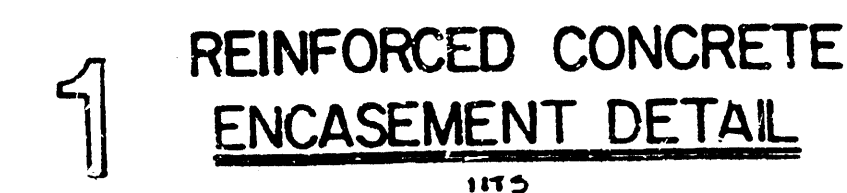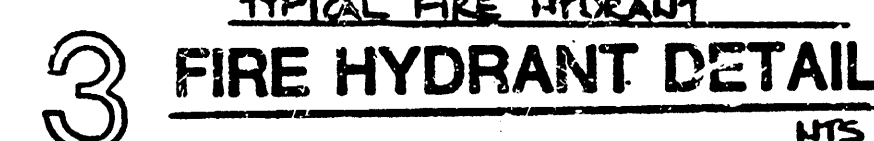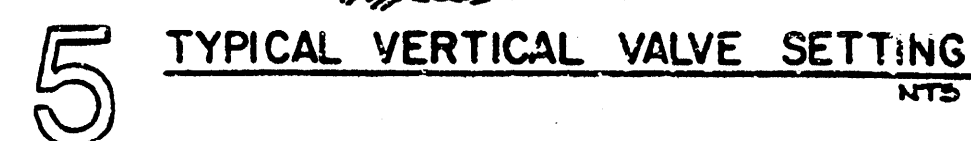

FOR CONSTRUCTION: 11/1/84

A circular professional seal for Ben J. Kingston, a Registered Architect in the State of Kansas. The seal features the text "REGISTERED ARCHITECT" around the top inner edge and "STATE OF KANSAS" around the bottom inner edge. In the center, it reads "BEN J. KINGSTON" and "1896".


**Village Fashion
Centre**
Amour Drive & Kolligs Drive
Winnetka, Kansas




SITE UTILITY DETAIL:

FILMED FROM THE BEST
AVAILABLE COPY

(2/4)

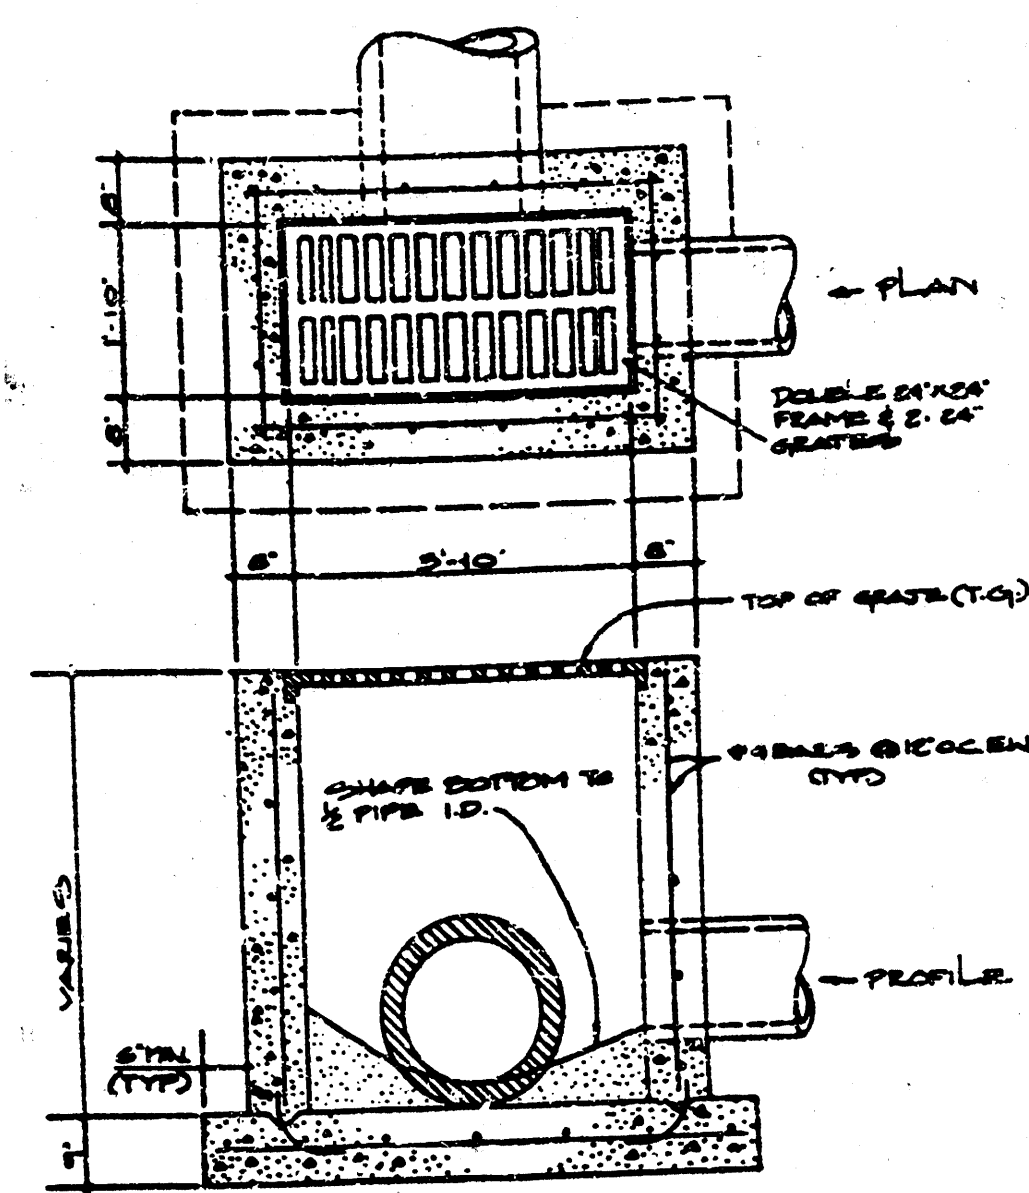

1 DOUBLE 24" x 24" INLET

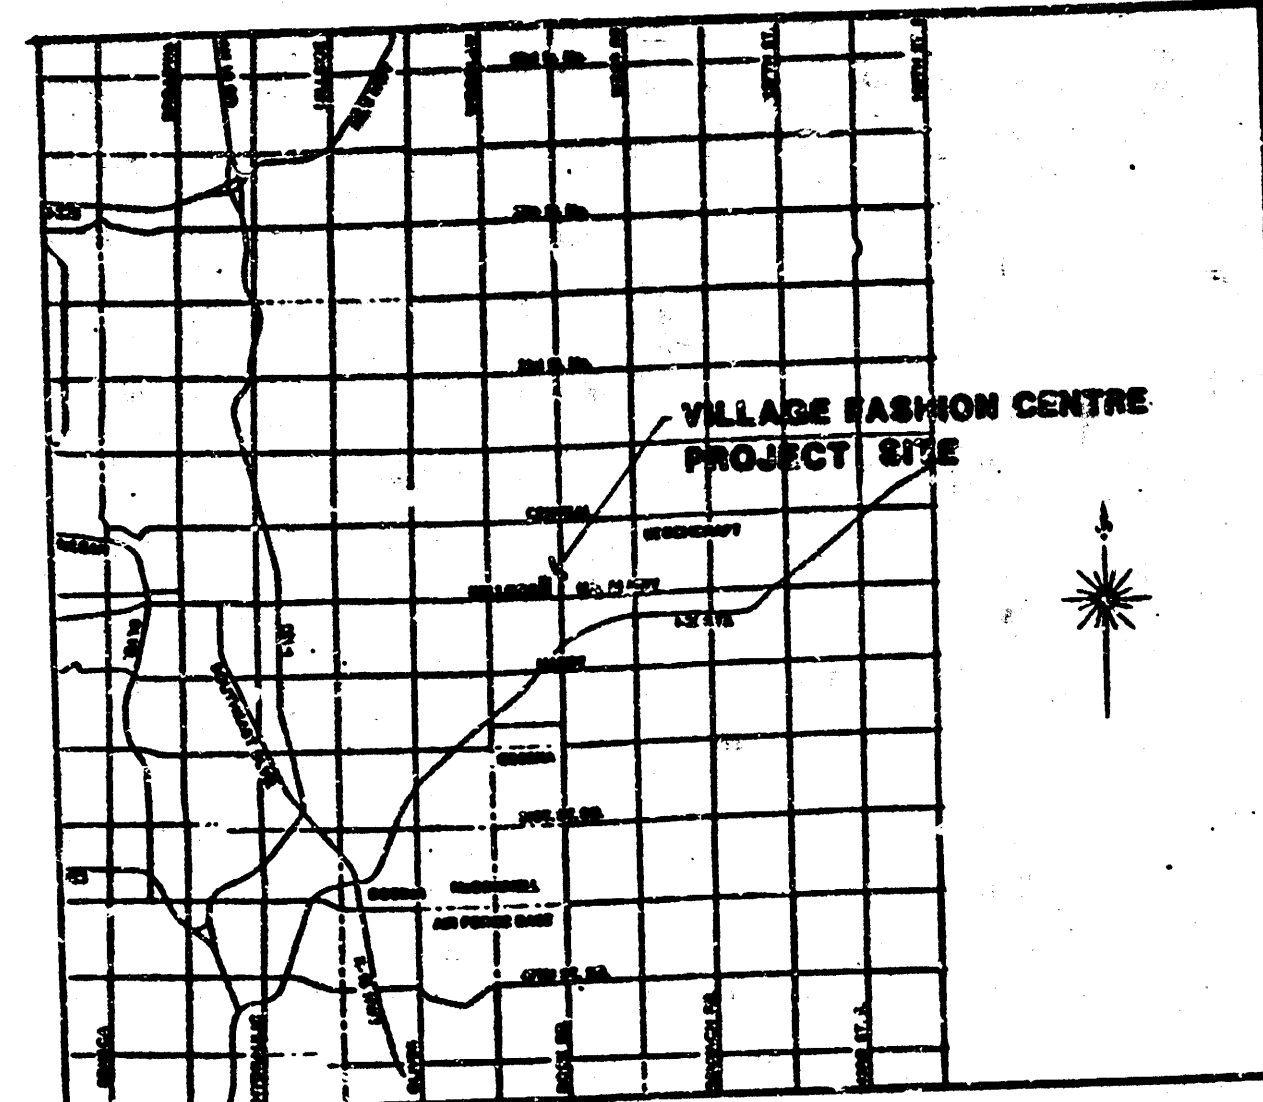


3 VICINITY MAP

SITE COORDINATES		
POINT NO.	COORDINATES	DESCRIPTION OF POINT
1	1919.000 614.000	INLET # A-2
2	1931.000 606.000	INLET # A-3
3	1401.000 692.000	INLET # A-1
4	616.0 603.000	INLET # A-4
5	1696.000 618.000	INLET # A-5
6	1696.000 692.000	INLET # A-2-1
7	1832.000 652.000	INLET # A-6
8	1832.000 774.000	INLET # A-7
9	1736.000 686.000	INLET # A-8
10	1207.000 667.000	INLET # C-2
11	1043.000 712.000	INLET # B-2
12	1058.000 696.000	INLET # B-3
13	1159.000 679.000	INLET # B-4
14	1236.000 679.000	INLET # B-5
15	1236.000 900.000	INLET # B-1-1
16	1331.000 679.000	INLET # B-6
17	1414.000 676.000	INLET # B-7
18	1556.000 655.000	INLET # B-8
19	1556.000 900.000	INLET # B-9


STAKE OUT NOTE
THE CONTRACTOR SHOULD USE THE COORDINATE POINTS TO LOCATE CRITICAL POINTS ON THE SITE. DIMENSION STRINGS AS SHOWN ON SHEET SA-1 SHOULD VERIFY THE COORDINATES HOWEVER ANY DISCREPANCIES SHOULD BE REPORTED TO THE ARCHITECT PRIOR TO PROCEEDING. REFER TO SHEET SA-1 FOR ADDITIONAL COORDINATE INFORMATION.

NOTES

- REFER TO SHEET SA-2 FOR EXACT ELEVATIONS OF SIDEWALKS, SERVICE COURTS, COURTYARDS, ETC. ADJACENT TO BUILDINGS.
- REFER TO PLUMBING PLANS FOR CONTINUATION OF COURTYARD DRAINS, ROOF DRAINS, ETC.
- DUE TO THE MINIMUM COVER AVAILABLE THE CONTRACTOR IS REQUIRED TO USE EXTRA CAUTION TO PROTECT STORM WATER SEWER FROM DAMAGE UNTIL PAYMENT IS IN PLACE. DO NOT ALLOW HEAVY TRUCKS TO CROSS PIPE WITH LESS THAN 12" COVER. DAMAGED PIPE WILL NEED TO BE REMOVED AND REPLACED PRIOR TO PAVING.

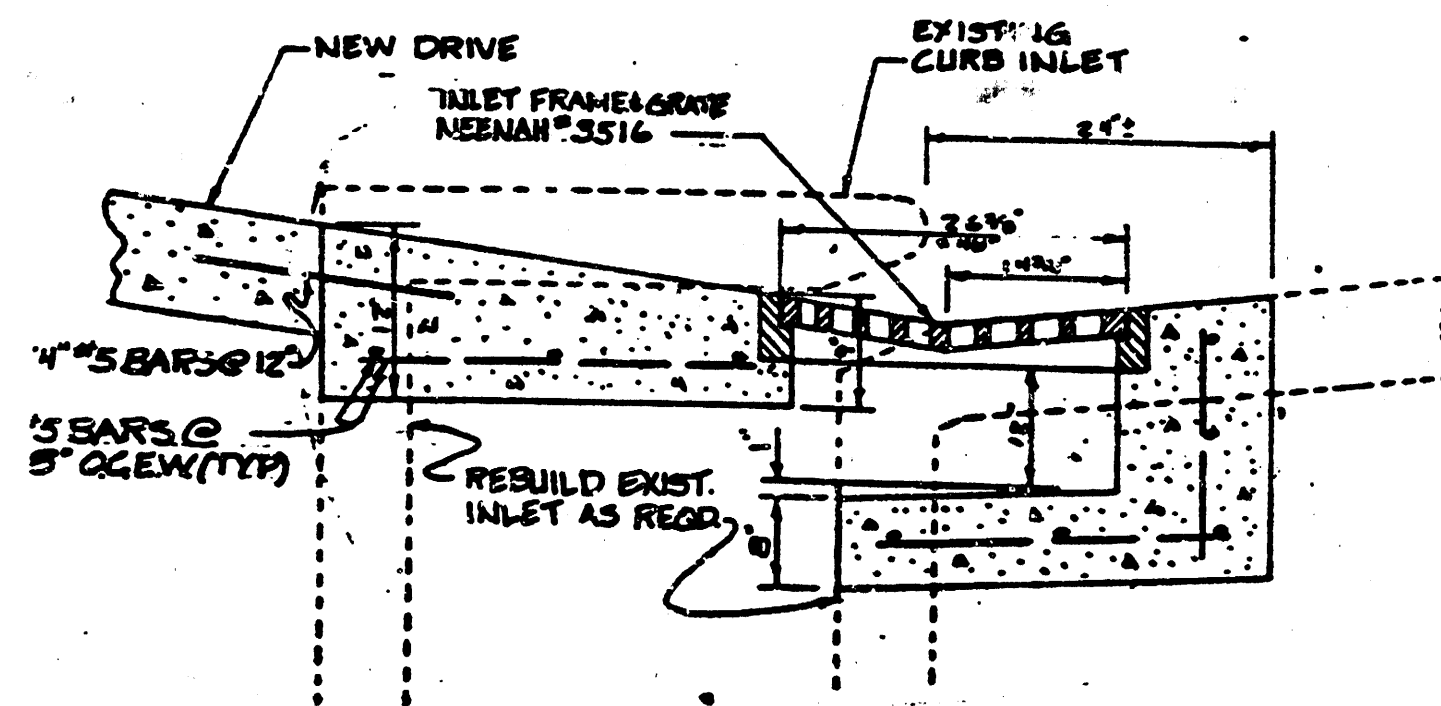

2 REBUILT CURB INLET

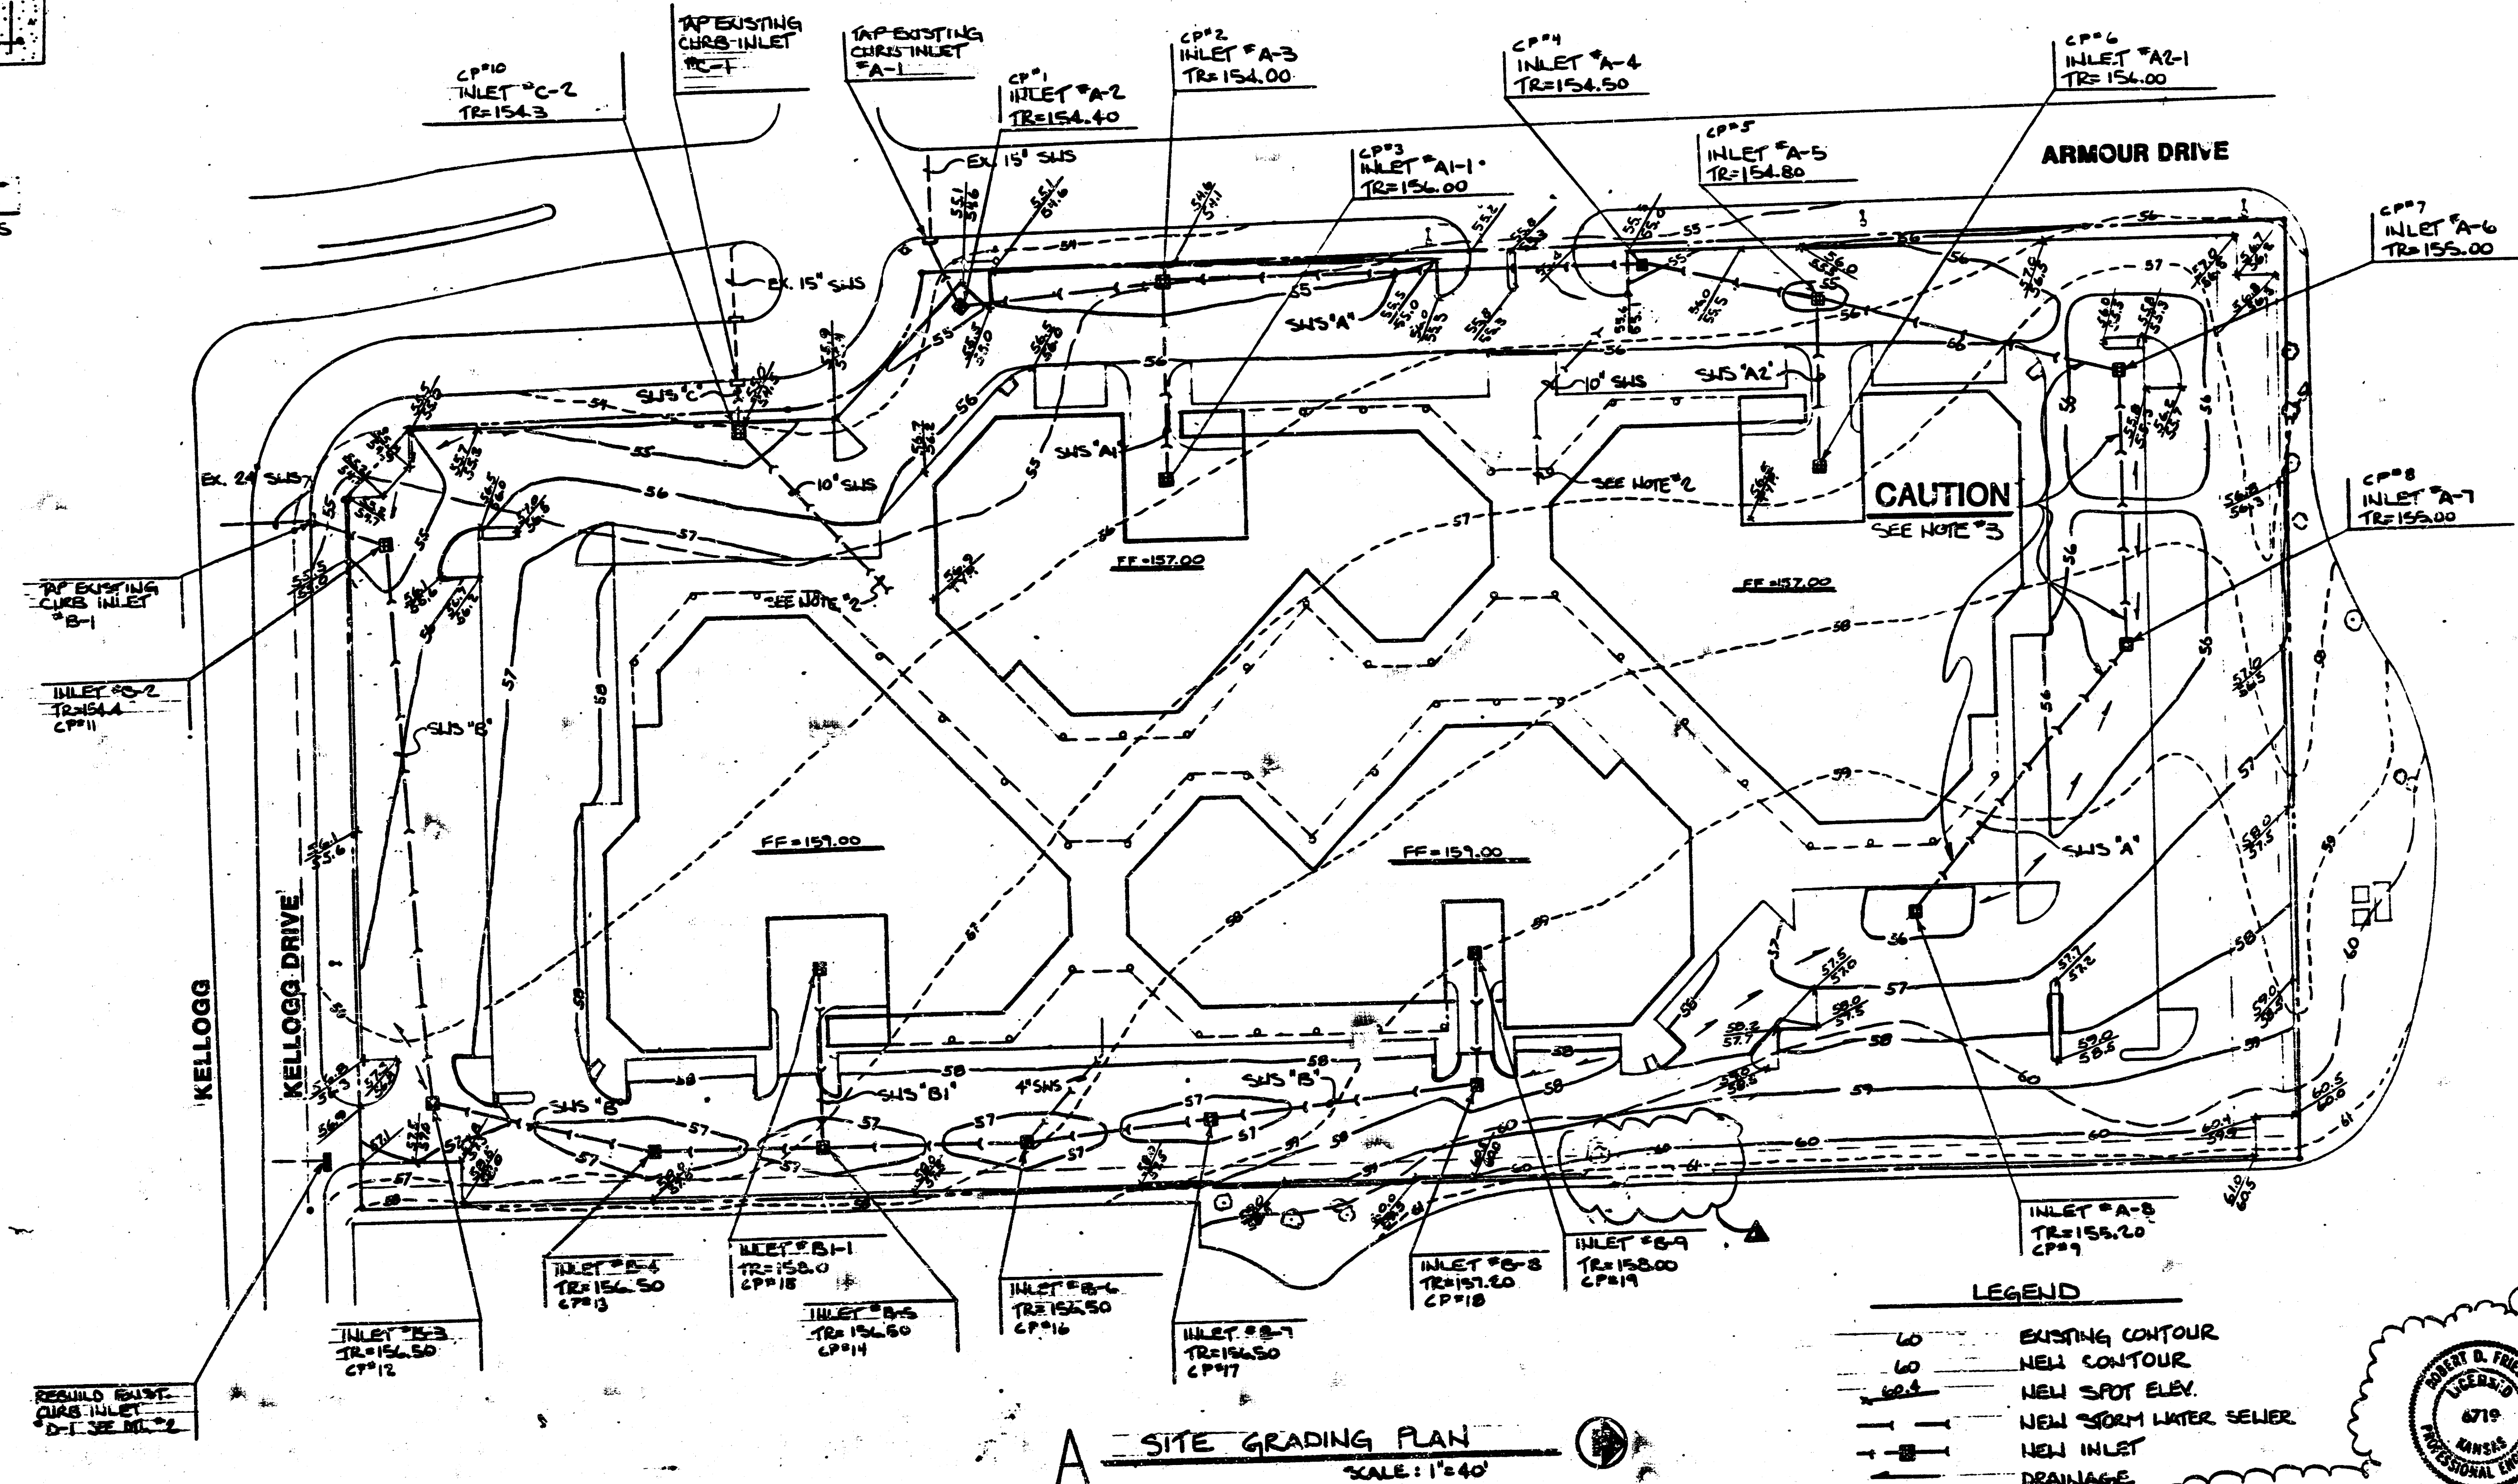

A SITE GRADING PLAN

SCALE: 1"=40'


PRINTS ISSUED		
DATE	PURPOSE	NO.
11/1/84	FOR CONSTRUCTION	23
12/1/84	REV. FOR CONSTRUCTION	24

FOR CONSTRUCTION: 11/1/84


REVISIONS		
DATE	ITEM	NO.
11/1/84	CREATED DRIVE	1
12/1/84	REV. FOR CITY PERMITS	2



K&K ENGINEERING, INC.
ARCHITECTS & ENGINEERS
2000 W. 10TH AVE., SUITE 200
CHICAGO, ILLINOIS 60640


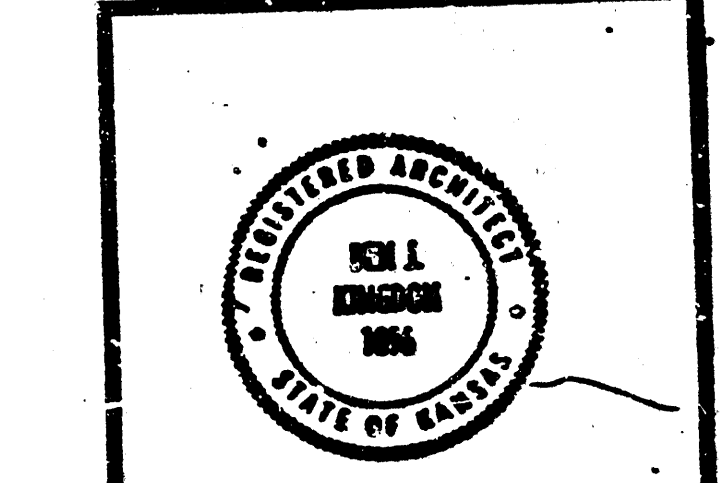


REVISION	DATE
RELATED DRAWINGS	
SHEET	
DETAILS	
STRUCTURE	
MECHANICAL	
ELECTRICAL	
OTHER	
REVISION NUMBER	
OF SHEETS	

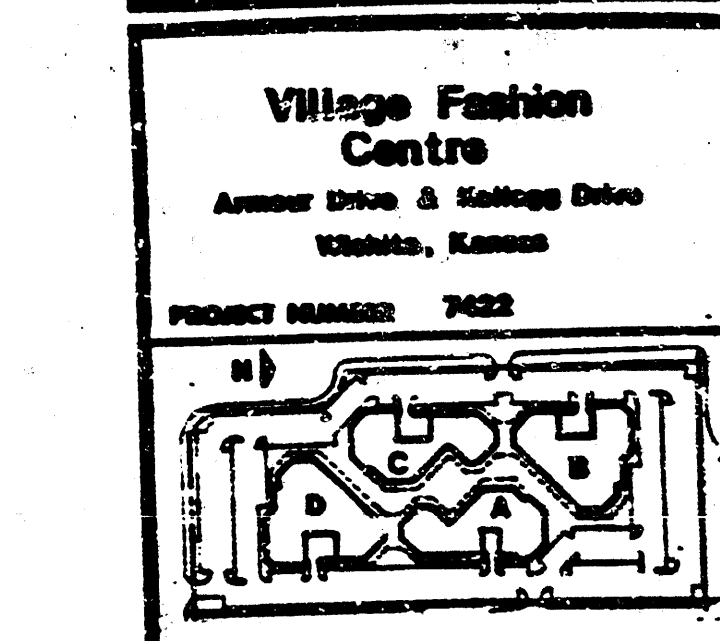

Village Fashion Centre	
Armour Drive & Kellogg Drive	
Chicago, Illinois	
PROJECT NUMBER: 7422	
KEY PLAN	
SITE GRADING PLAN	
SHEET TITLE	
SHEET NUMBER	
SG1	

FILMED FROM THE BEST AVAILABLE COPY

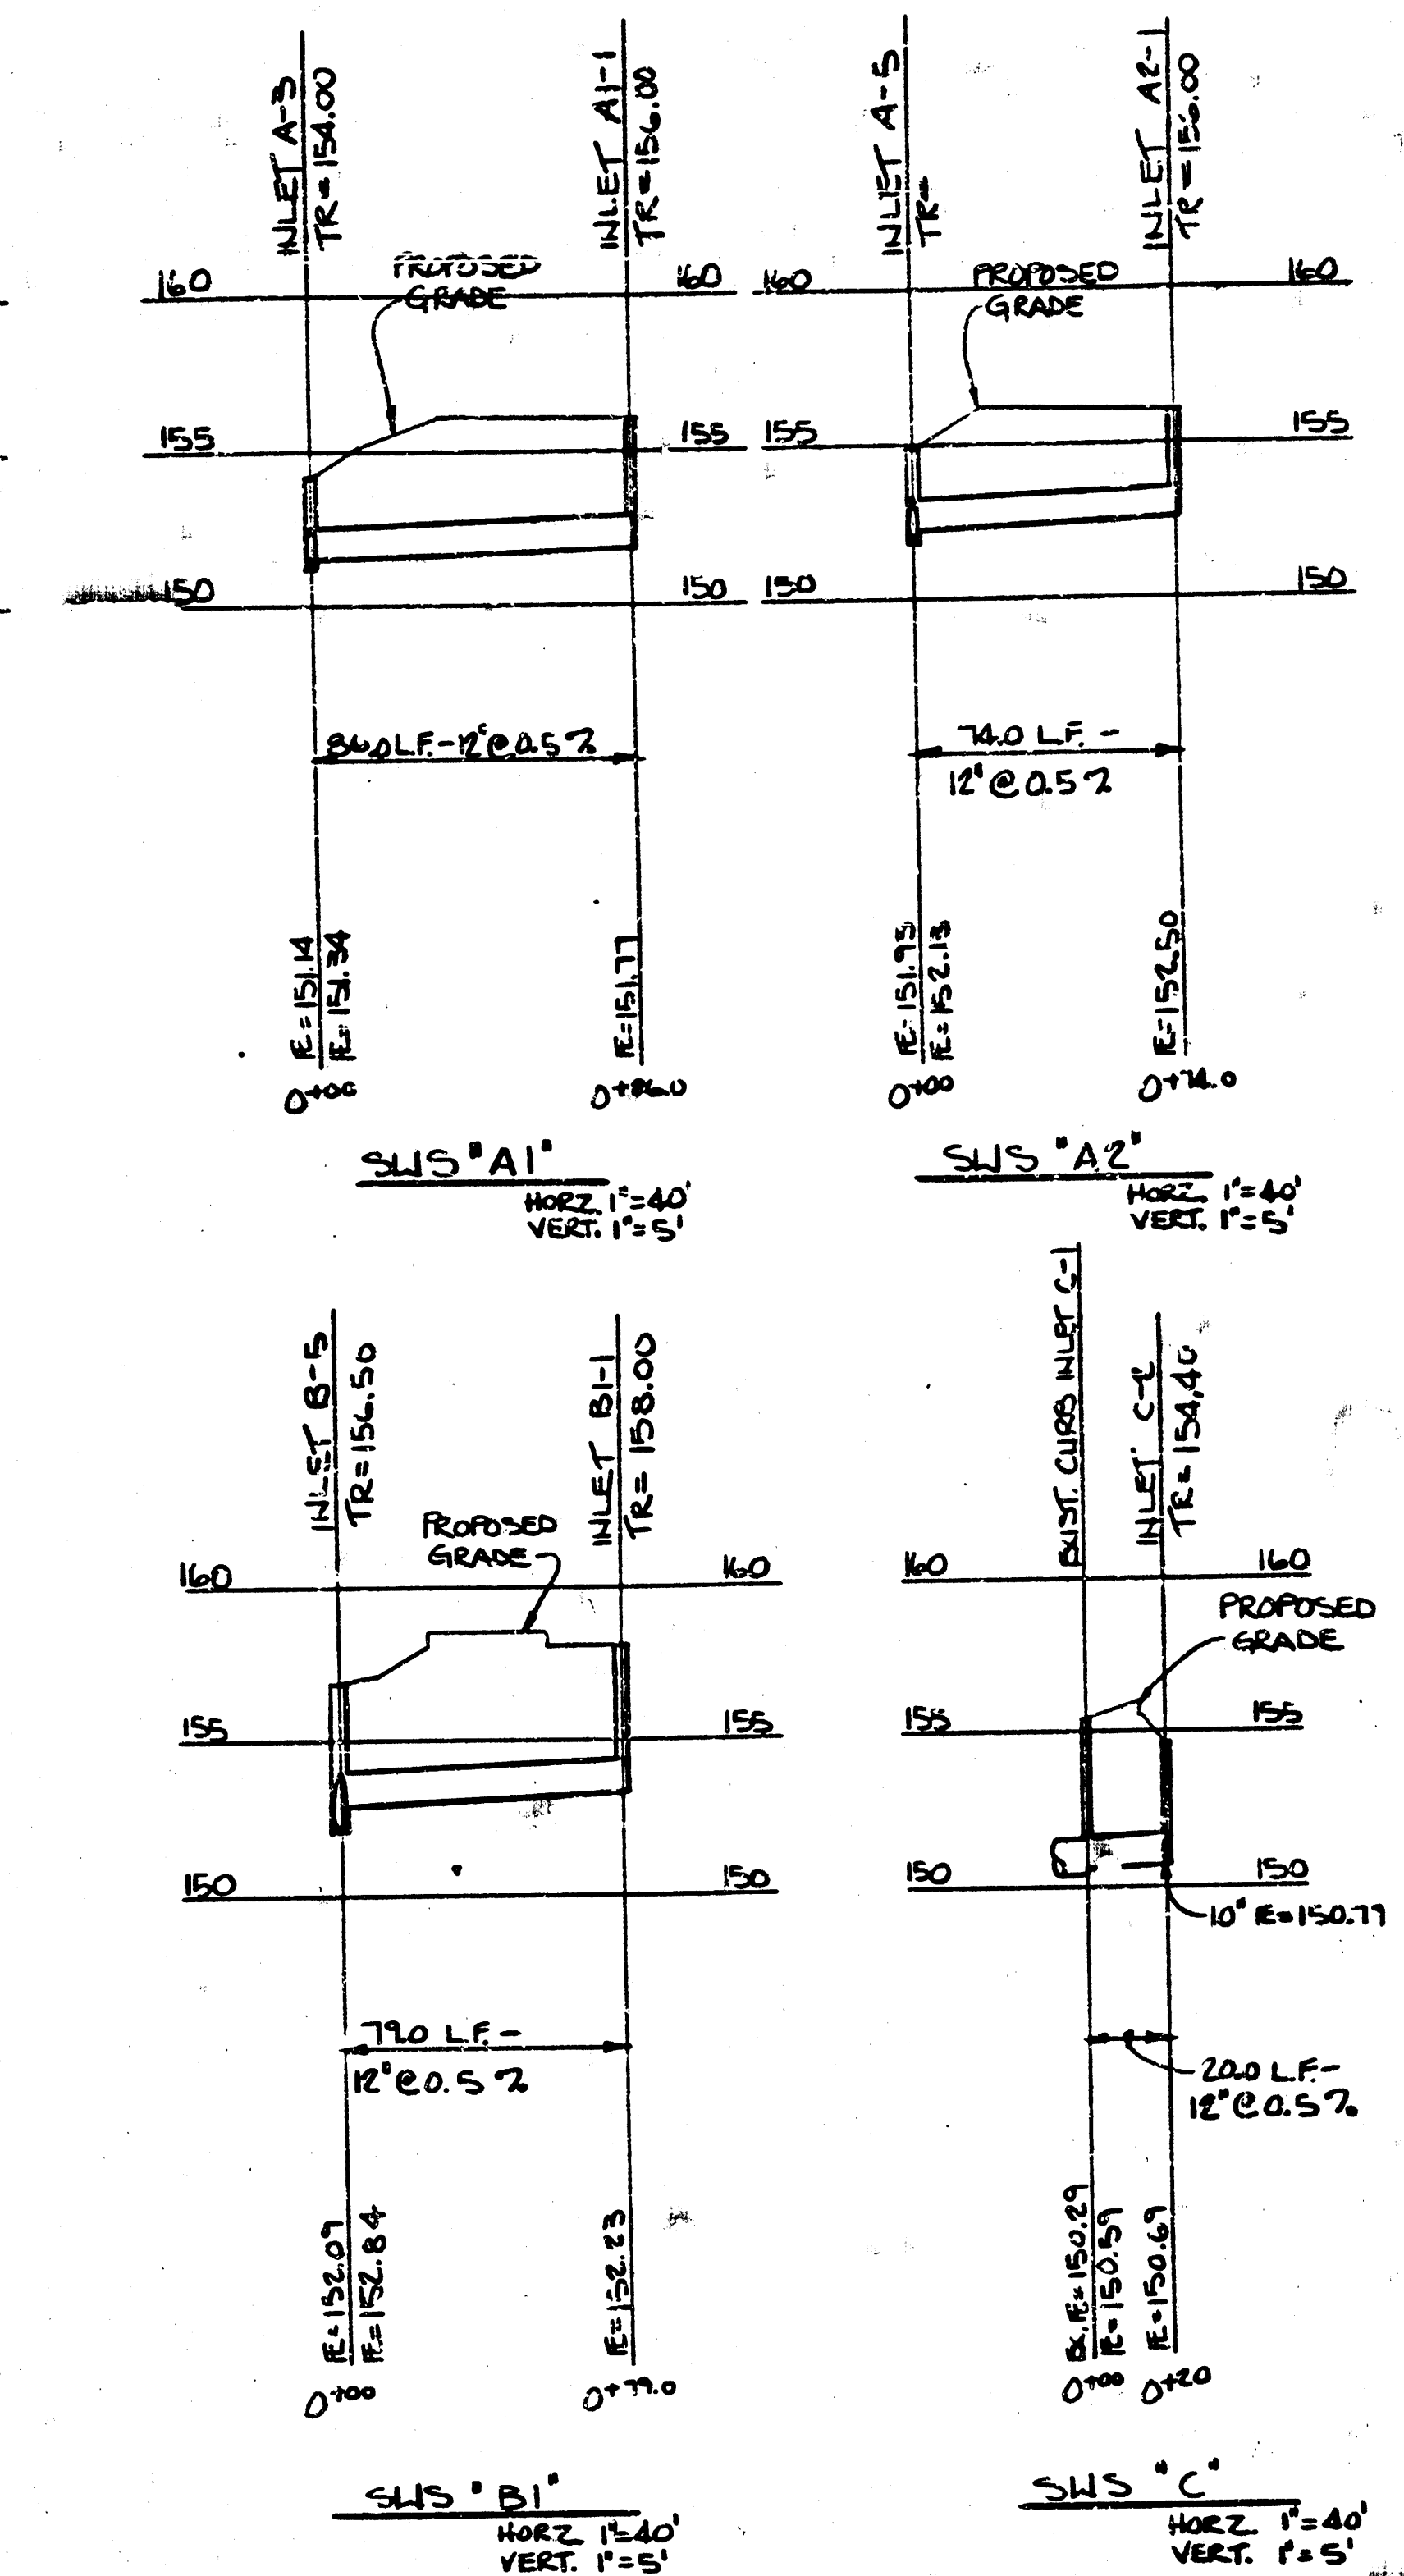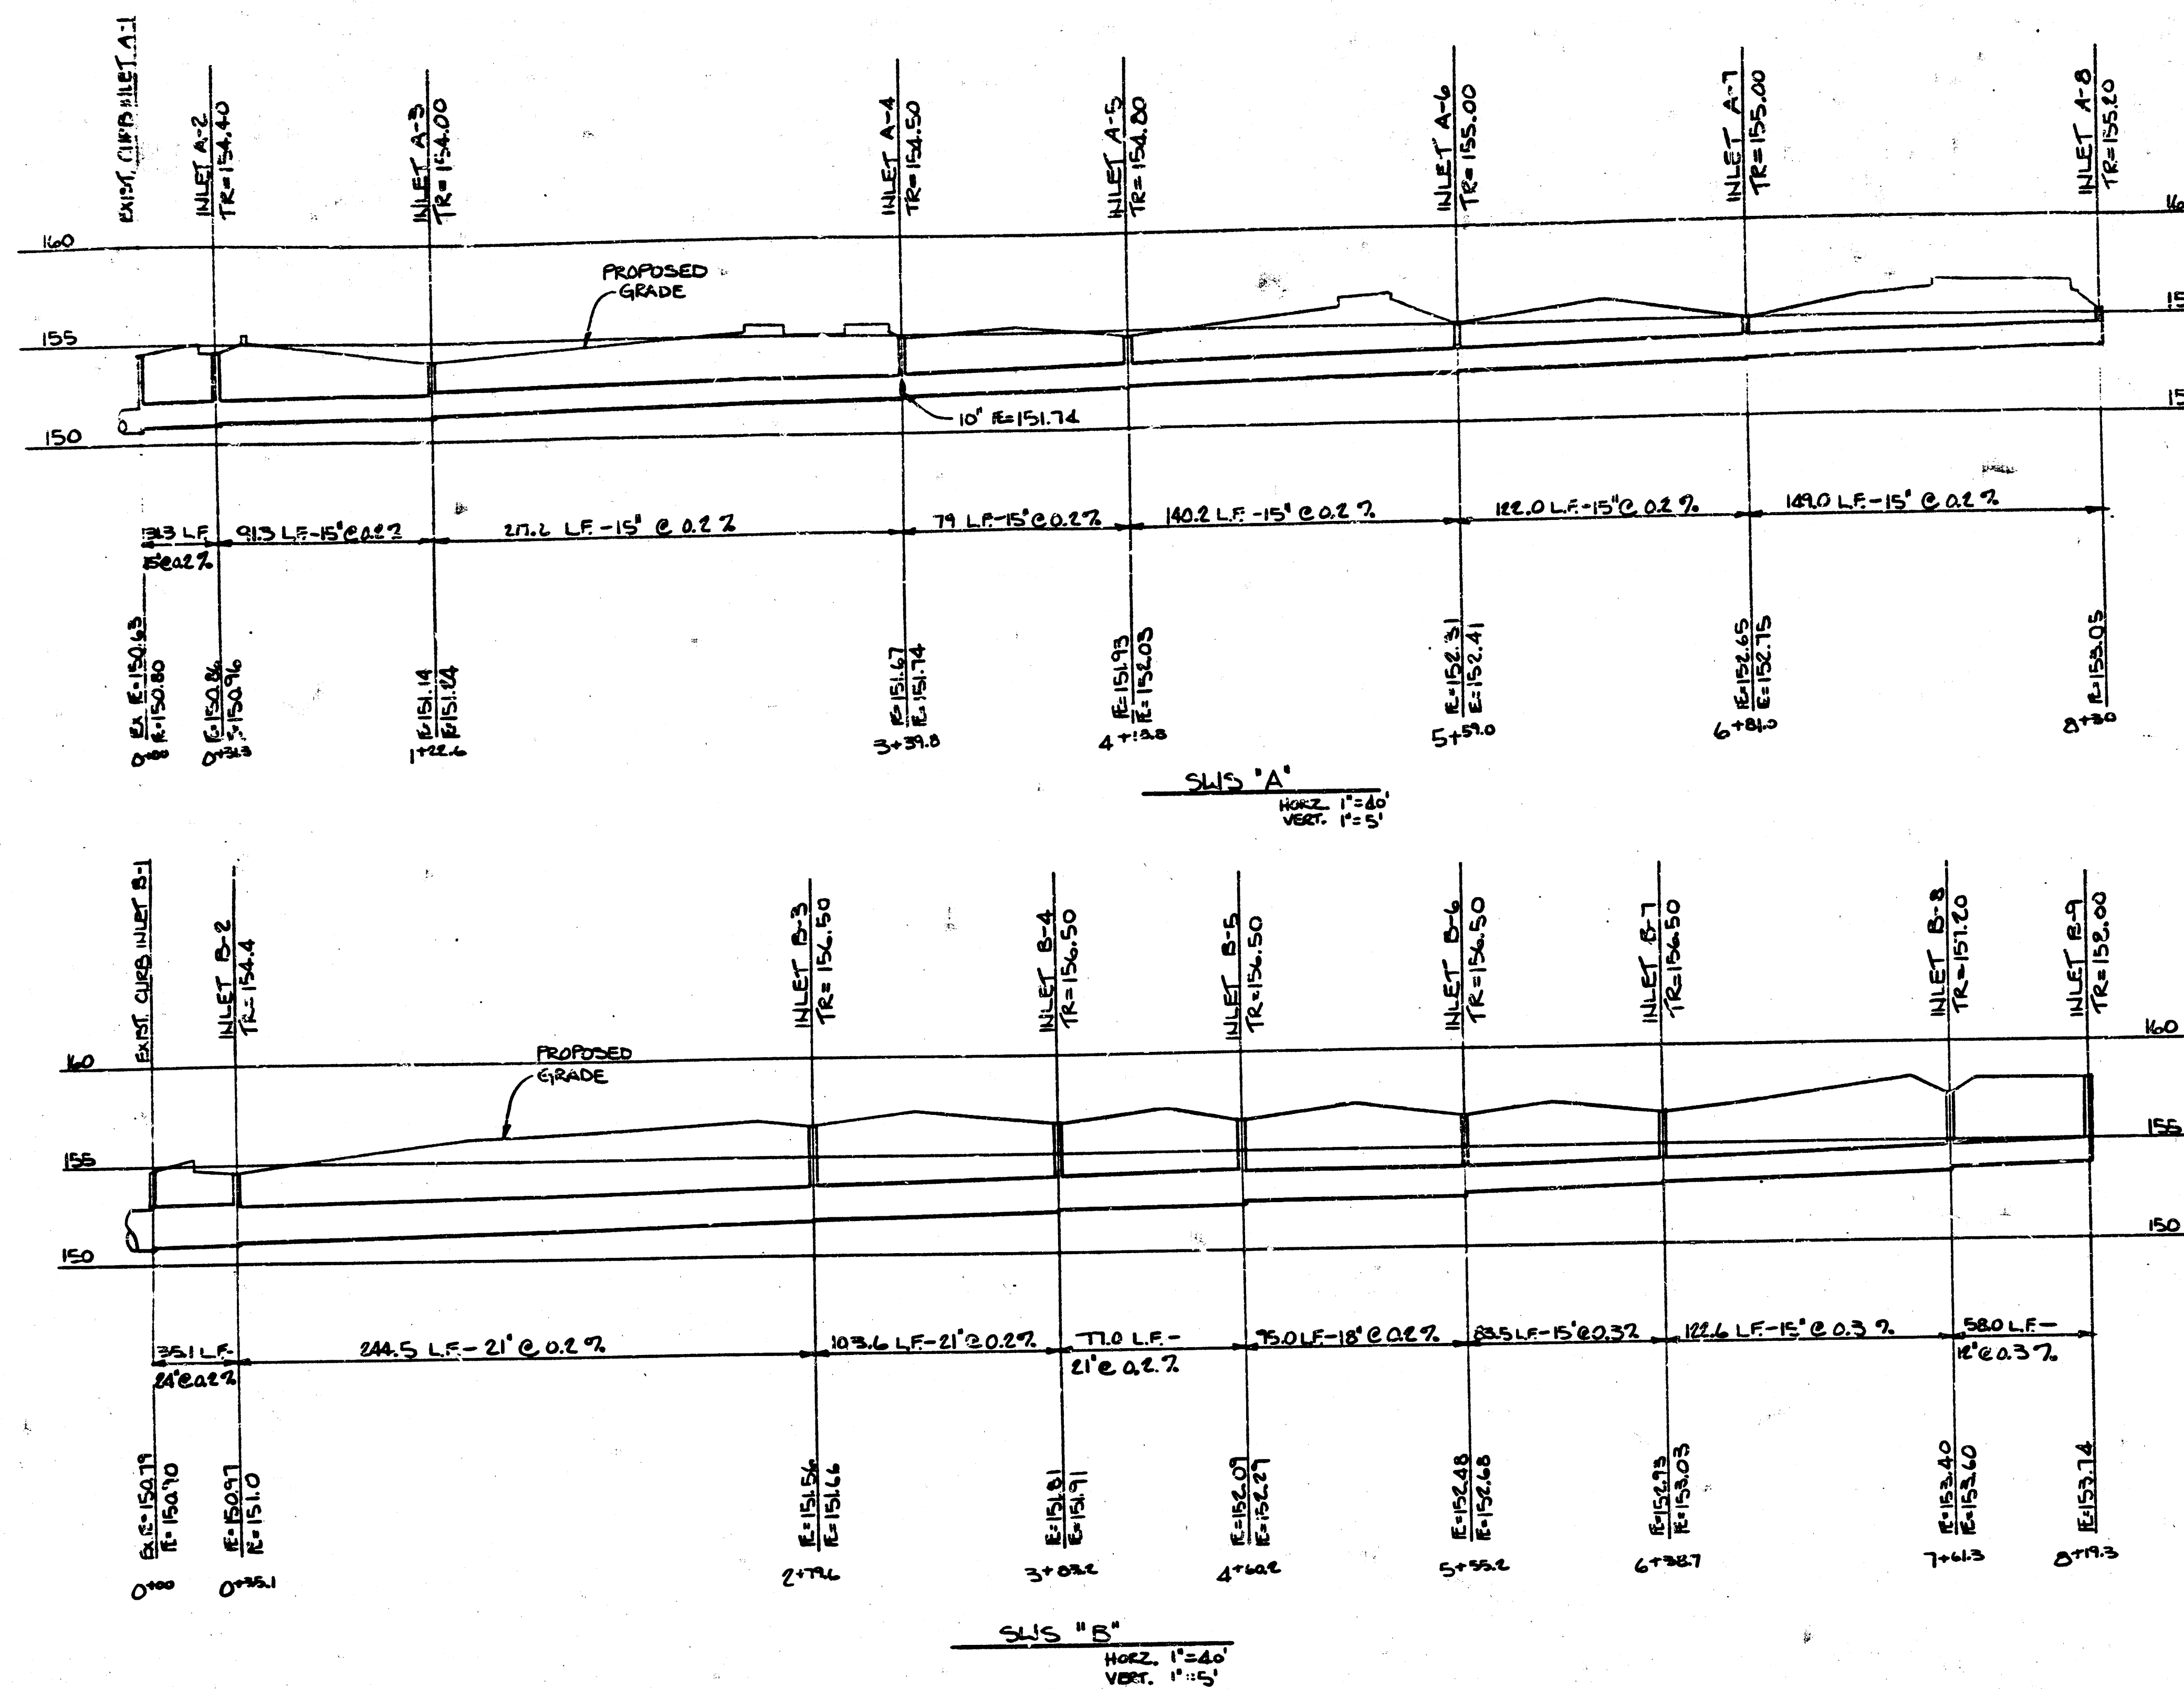


PRINTS ISSUED	
DATE	PURPOSE
11/1/84	FOR CONSTRUCTION

REVISIONS	
DATE	REVISION
11/1/84	REV. FOR CITY REVIEW




LAW/KINGDON, INC.
ARCHITECTS & ENGINEERS
240 WEST 10TH AVENUE, SUITE 200
DENVER, COLORADO 80202
PHONE 333-5555

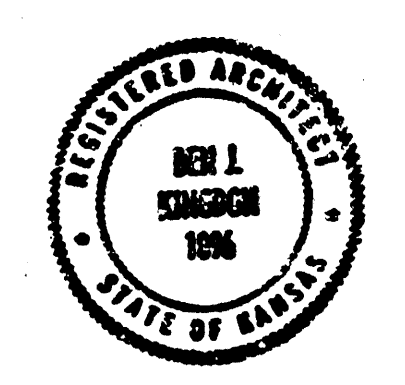


KEN L. KINGDON
STATE OF ILLINOIS

DATE	DESCRIPTION
11/1/84	FOR CONSTRUCTION


DATE	DESCRIPTION
11/1/84	FOR CONSTRUCTION

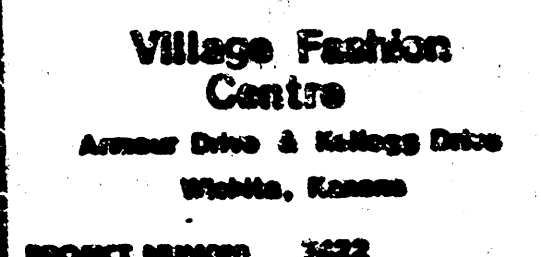


Village Fashion Centre
Archer Drive & Village Drive
Whitby, Ontario

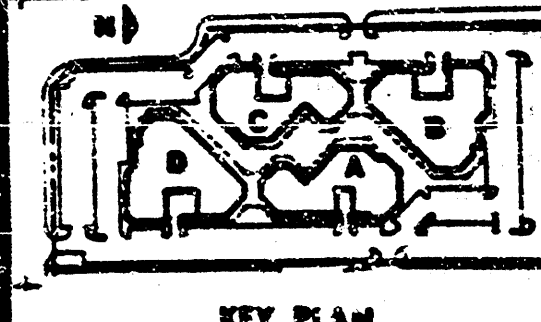

KEY PLAN

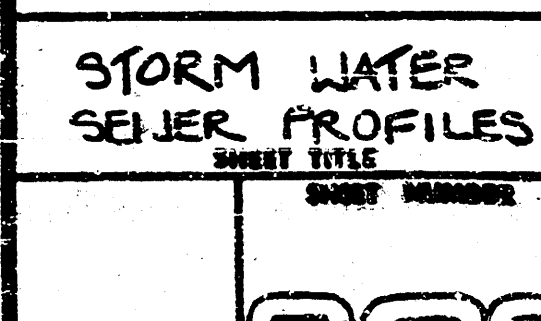

STORM WATER SEWER PROFILES

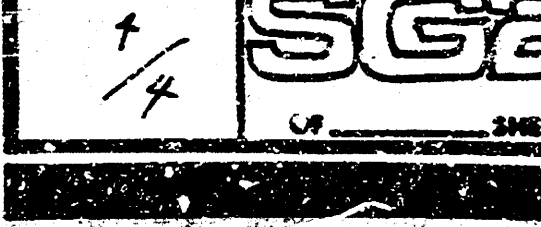

SG2


 ROBERT E. FISHER
 LICENSED PROFESSIONAL ENGINEER
 STATE OF ILLINOIS
 NO. 5719
 CITY OF WHITBY, ONTARIO

FILMED FROM THE BEST AVAILABLE COPY