



**PAVING AND INCIDENTAL DRAINAGE PLANS FOR
FOLIAGE CENTER ADDITION
13th STREET LEFT TURN LANES**

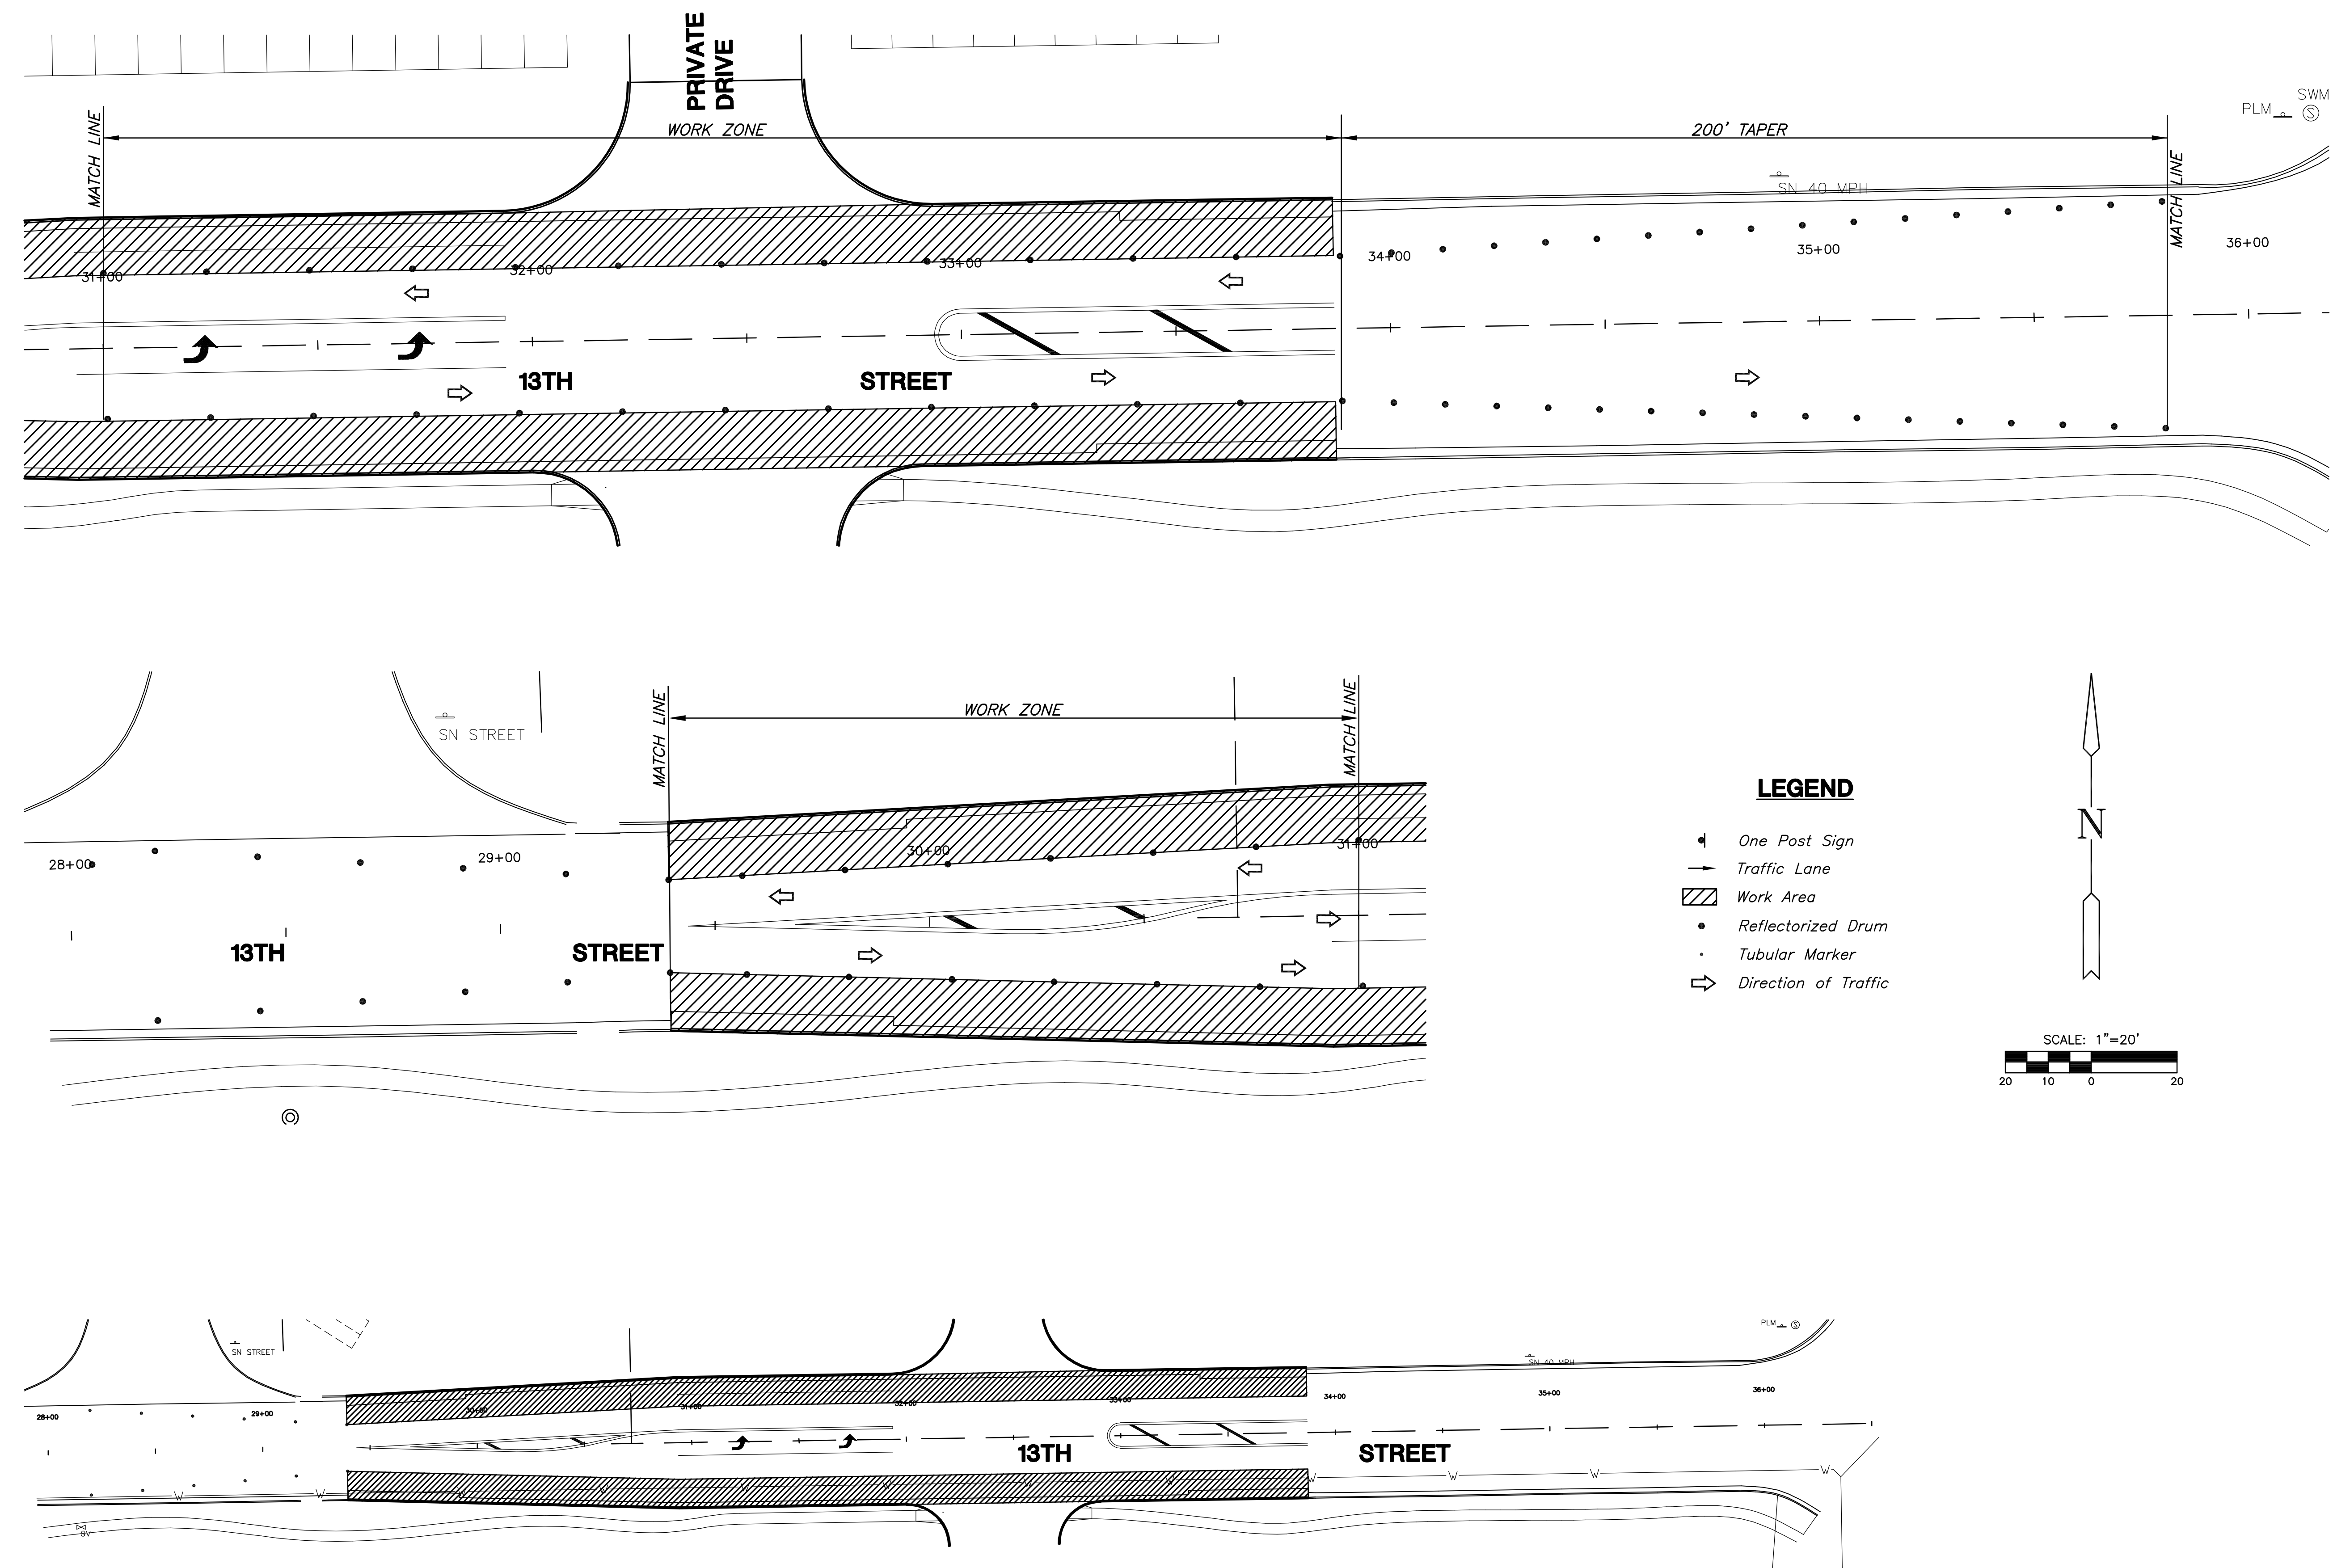

- LEGEND**
- One Post Sign
 - Traffic Lane
 - Work Area
 - Reflectorized Drum
 - Tubular Marker
 - Direction of Traffic

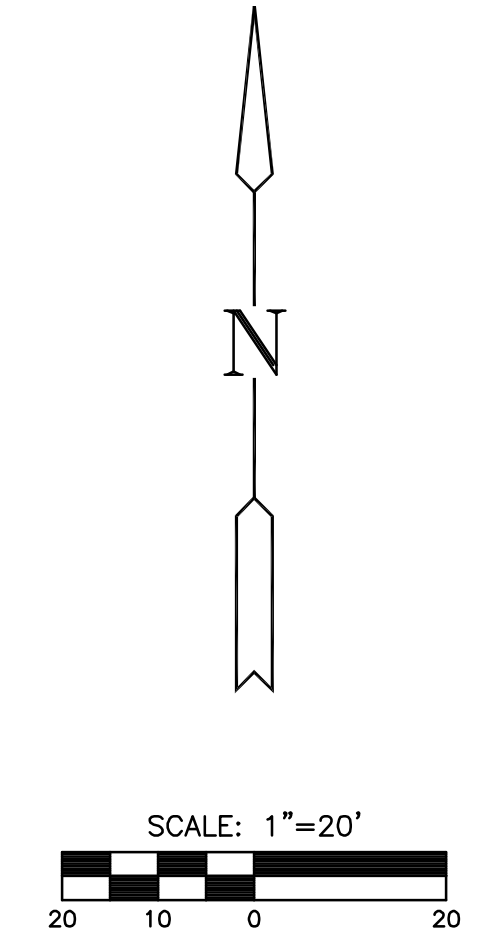

PLOTTED: Monday, June 02, 2008 @ 04:09PM

J:\CIVIL\04274\DWG\PAV\RESIDENTIAL\TURN LANES\13TH STREET\04274_TC.DWG

TRAFFIC CONTROL PLAN
SHEET TITLE
04274
PROJECT NUMBER

DESIGN BY: SRS
DRAWN BY: TKL
CHECKED BY: DFL

ISSUED: May 2008
REVISED:

SHEET NO.
13 of 23