
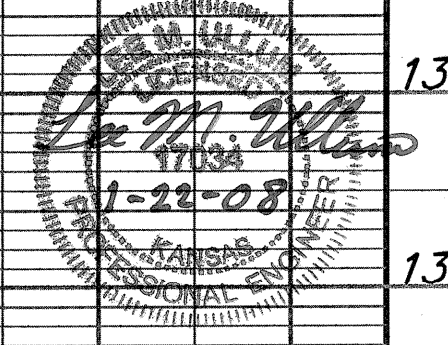


Contractor To Use Extreme Caution When Excavating Near Utility Lines. Contractor To Hand Dig To Expose All Utility Lines Prior To Construction. Verify Depth To Determine Conflict If Any.

Contractor Shall Follow All Applicable Best Management Practices (BMP) For Erosion Control.

SCALE:
1" = 20' HORIZONTAL
1" = 5' VERTICAL

BENCHMARK
"□" Chiseled on top of curb, west side of Gouverneur and approximately 90' south of the south curb of 29th Street North.
Elev. = 1370.86 (NGVD29)

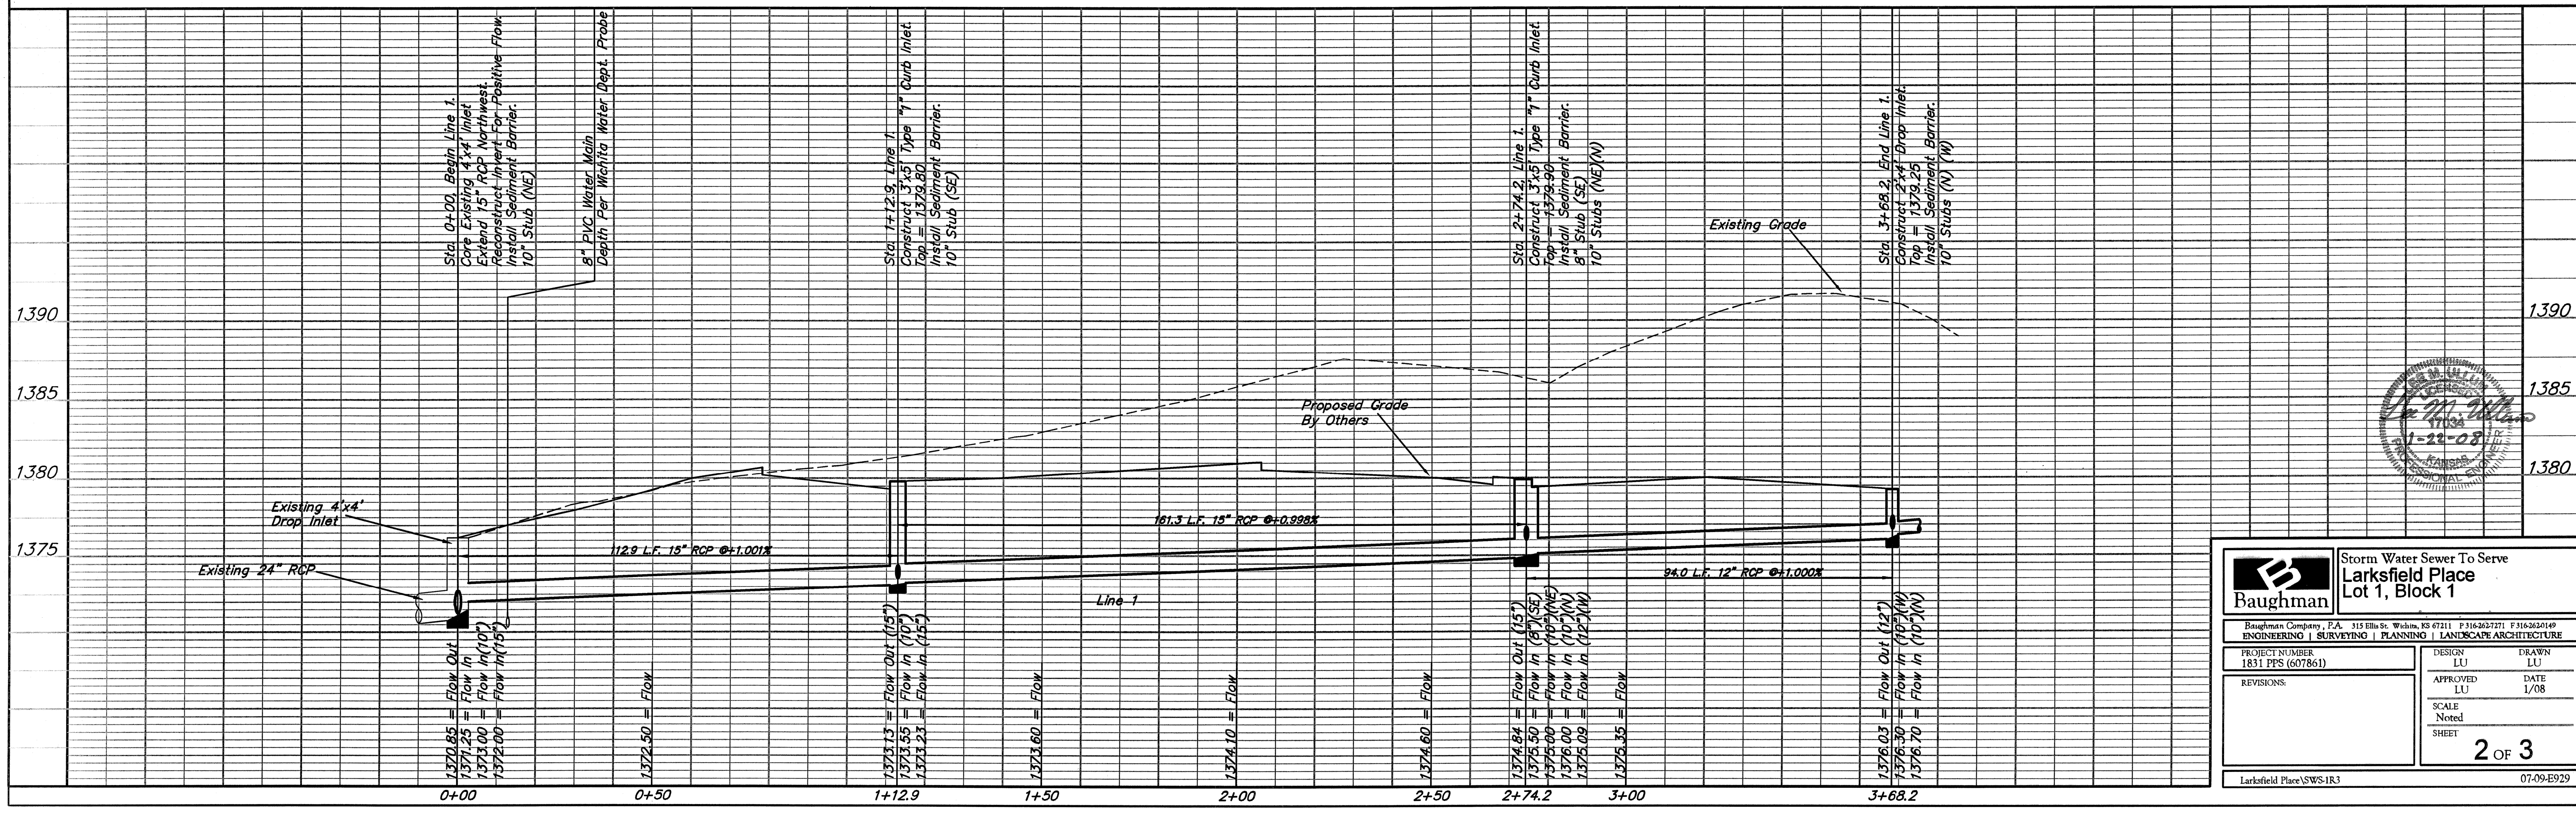

Baughman		Storm Water Sewer To Serve Larksfeld Place Lot 1, Block 1	
Baughman Company, P.A. 315 Ellis St. Wisc. 53101 P 316-2627271 F 316-2620149			
ENGINEERING SURVEYING PLANNING LANDSCAPE ARCHITECTURE			
PROJECT NUMBER: 1831 PPS (607861)	DESIGN: LU	DATE: 1/08	DRAWN: LU
REVISIONS:	APPROVED: LU	SCALE: Noted	SHEET: 2 OF 3
Larksfeld Place/SWS-1R3		07.09.E929	