



B SITE UTILITY PLAN 1" = 50'-0"

NOTE:
 1) STREET CROSSING PER OF WICHITA REQUIREMENTS.
 2) REFER TO MECHANICAL AND PLUMBING FLOOR PLANS SHEET
 101 FOR EXACT LOCATIONS OF UTILITY LINES AT THE BLDG.

APPROVED AS NOTED
 BY CITY ENGINEER OF WICHITA
 7-19-77
 [Signature]

NOTE TO CONTRACTOR
 THIS PROJECT WILL BE CONSTRUCTED UNDER
 THE SUPERVISION OF THE CITY ENGINEER
 AND CONFORMING TO THE SPECIFICATIONS
 OF THE CITY OF WICHITA. THE CON-
 TRACTOR WILL REIMBURSE THE CITY OF
 WICHITA FOR ALL COST OF INSPECTION.

A SITE GRADING PLAN 1" = 20'-0" Sanitary Sewer for Boston Park 468-76-245-80805-000-000-008

PRINTS ISSUED		
DATE	PURPOSE	NO.
		1

FOR CONSTRUCTION		
DATE	ITEM	NO.
		1

L&K

LAW KINGDON, P.A.
 110 N. MARKET WICHITA, KANSAS 67202
 PHONE (316) 261-1111
 TELEX 150000 L&K WICHITA

Copyright © 1978 Law/Kingdon, P.A.

DRAWN	CHECKED

RELATED DRAWINGS	
SHELL	
DETAILS	
STRUCTURE	
MECHANICAL	
ELECTRICAL	
OTHER	


SEQUENCE NUMBER	OF SHEETS

**Boston Park
 Swimming Pool
 & Bathhouse
 Wichita, Kansas**



PROJECT NUMBER 7810

KEY PLAN

TENANT
**SITE UTILITY AND
 GRADING**
 SHEET TITLE
 TENANT NUMBER SHEET NUMBER
SG-1
 OF 2 SHEETS

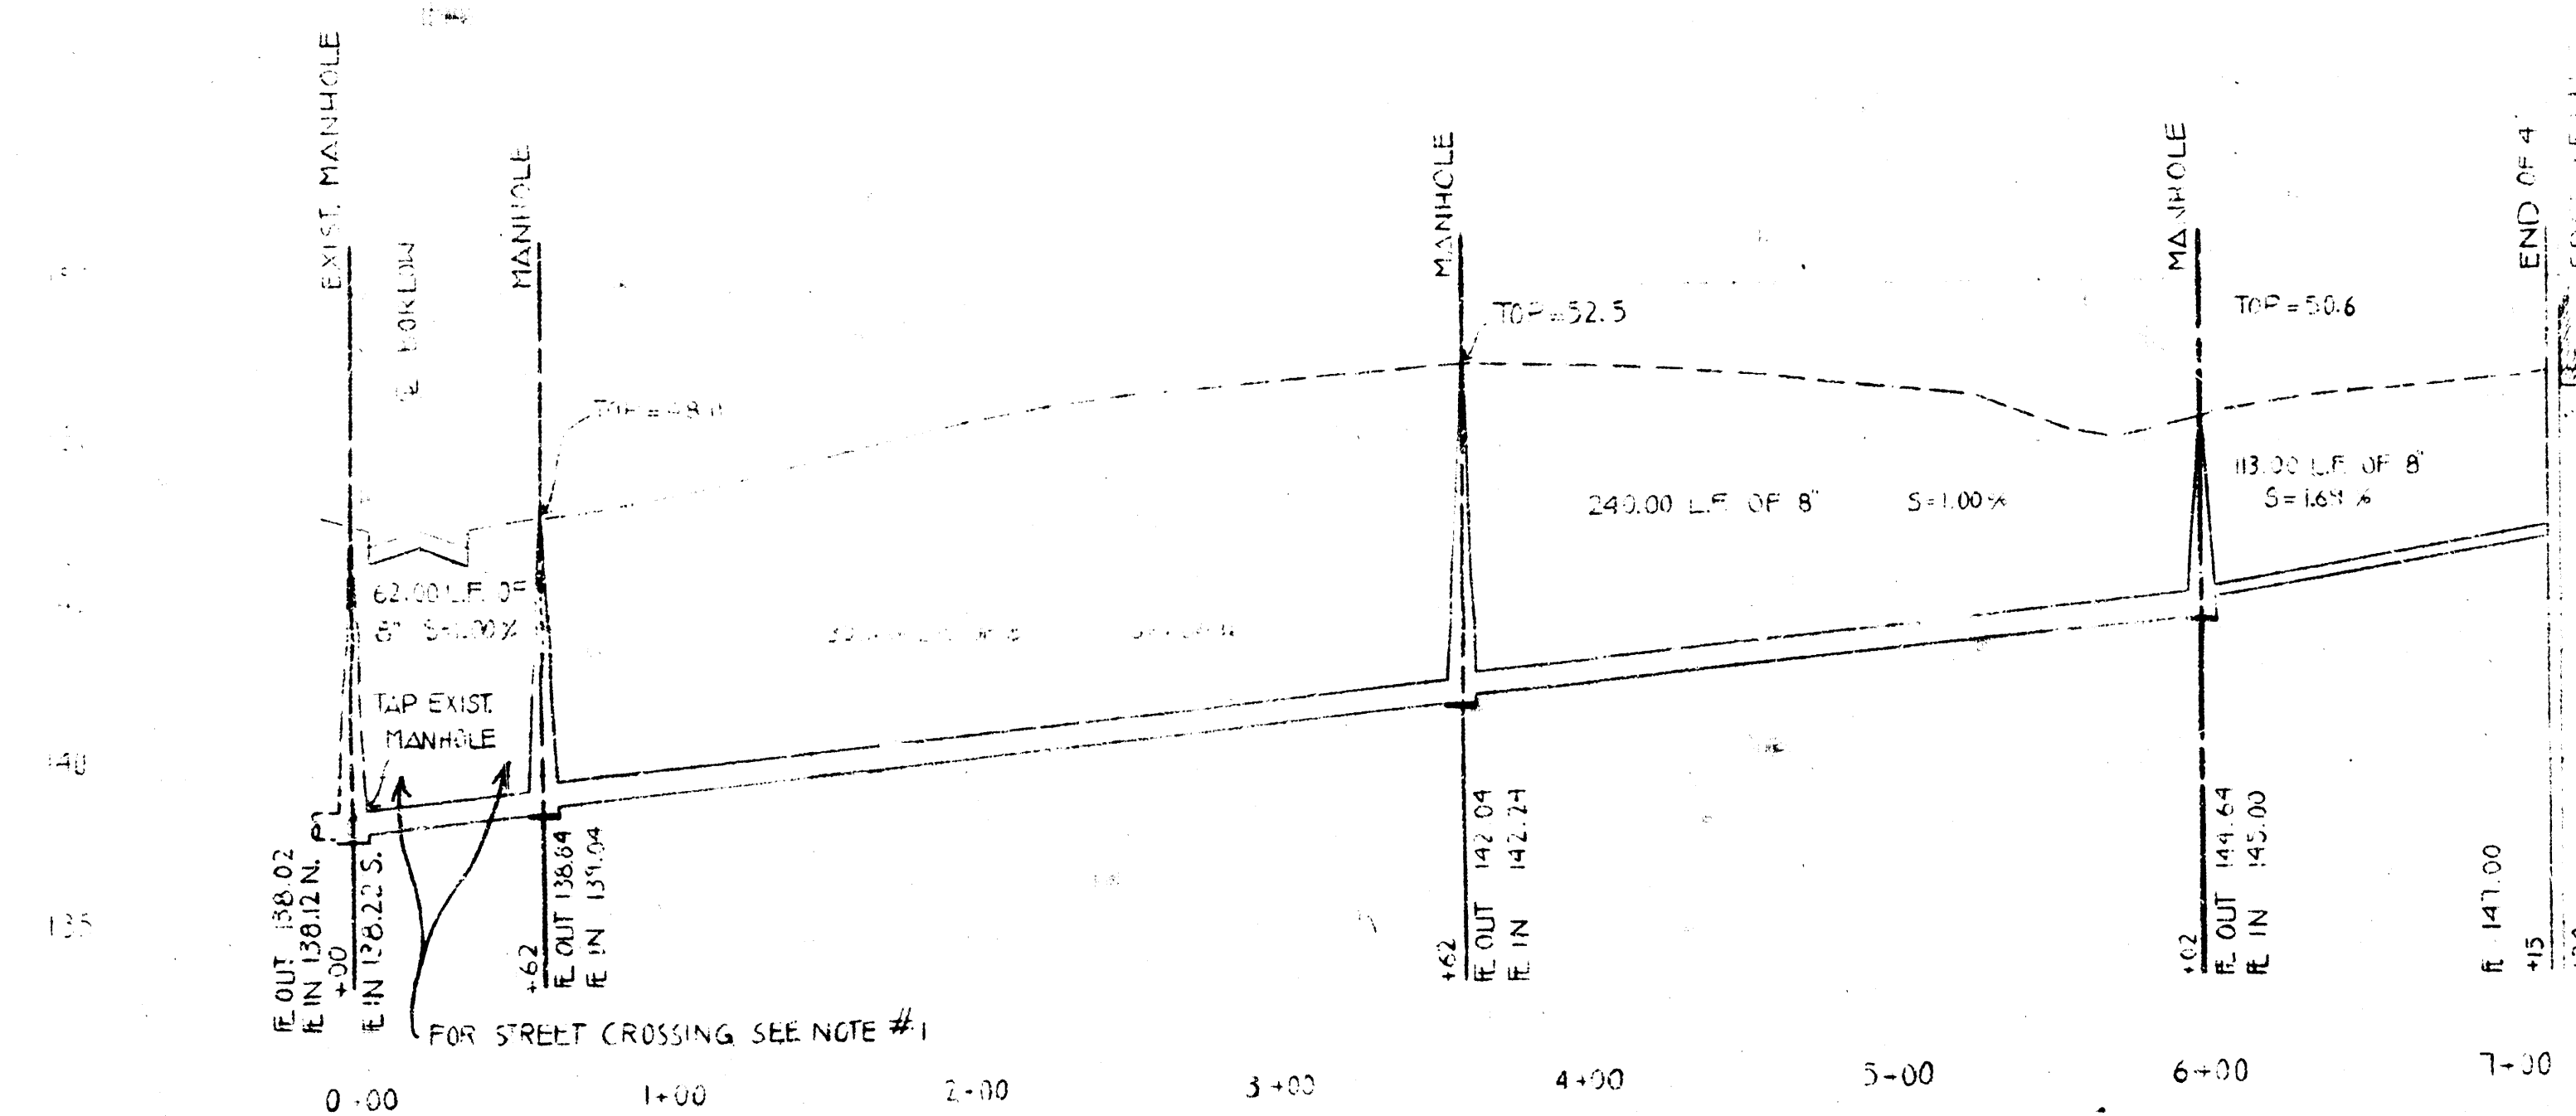

SANITARY SEWER PROFILE

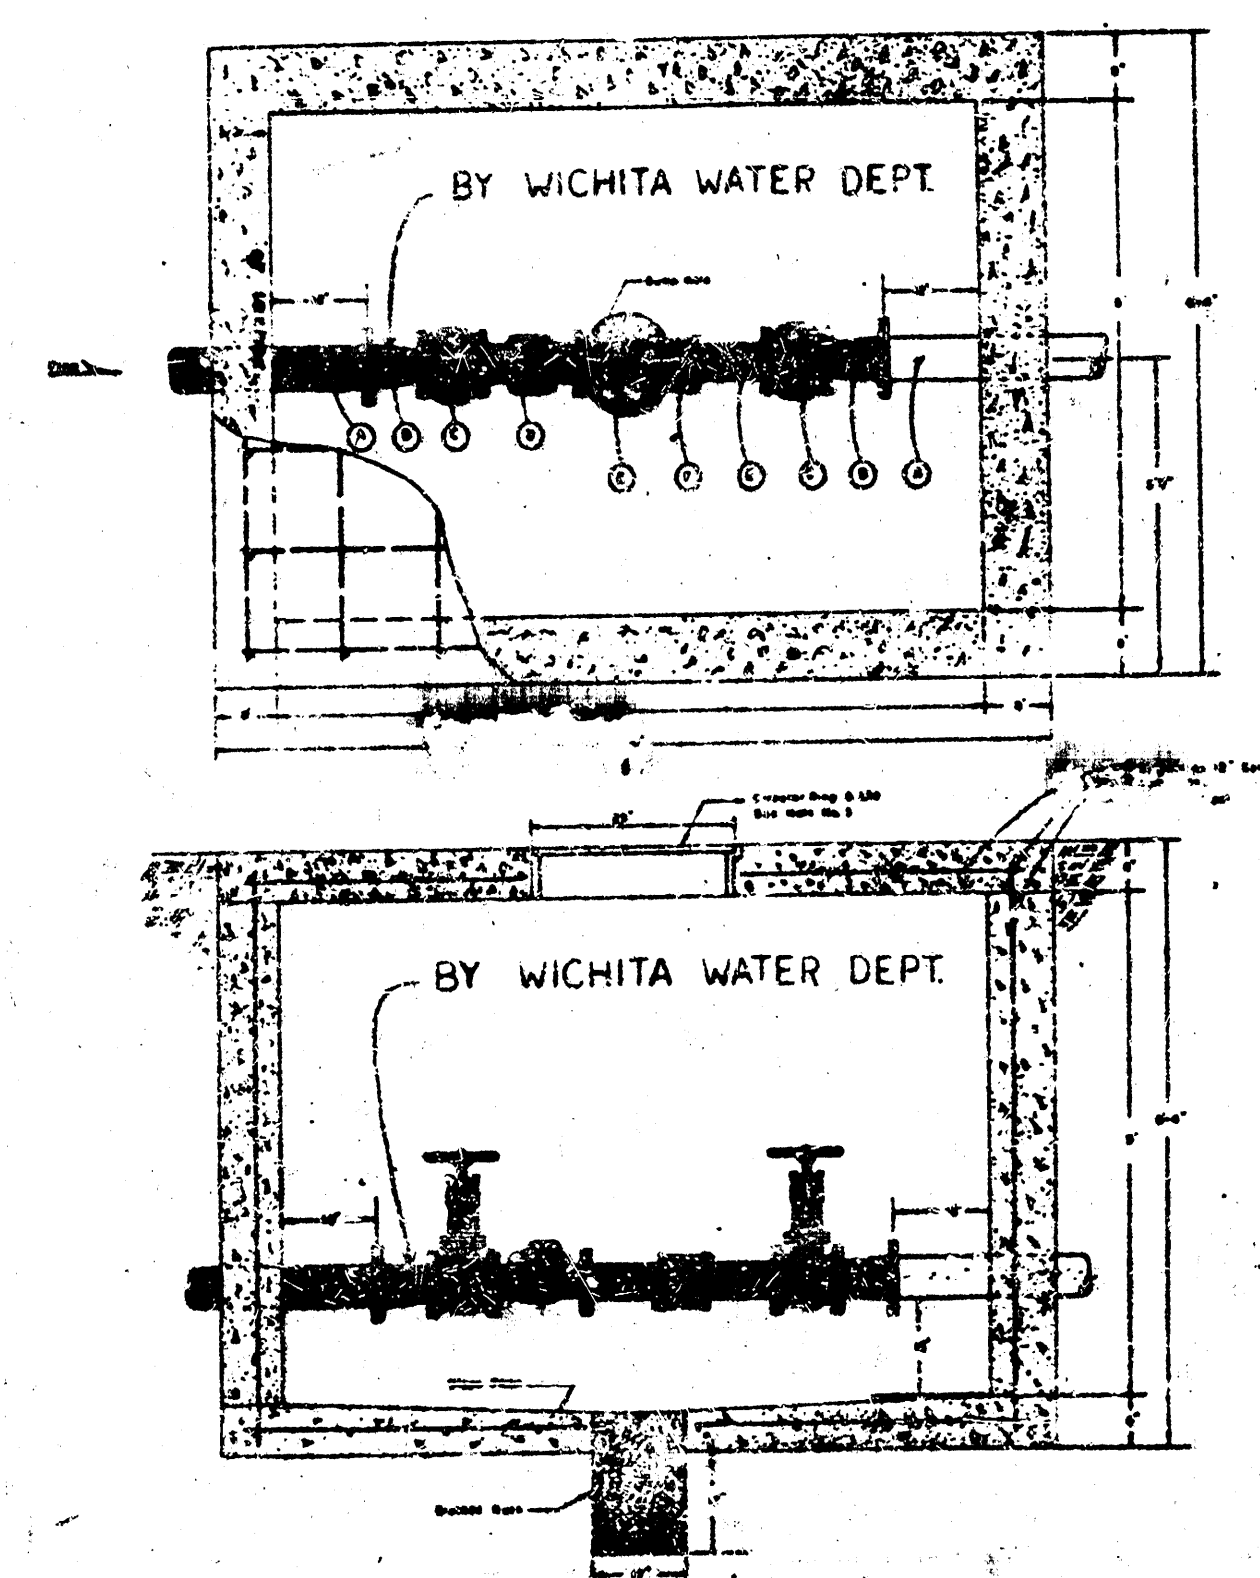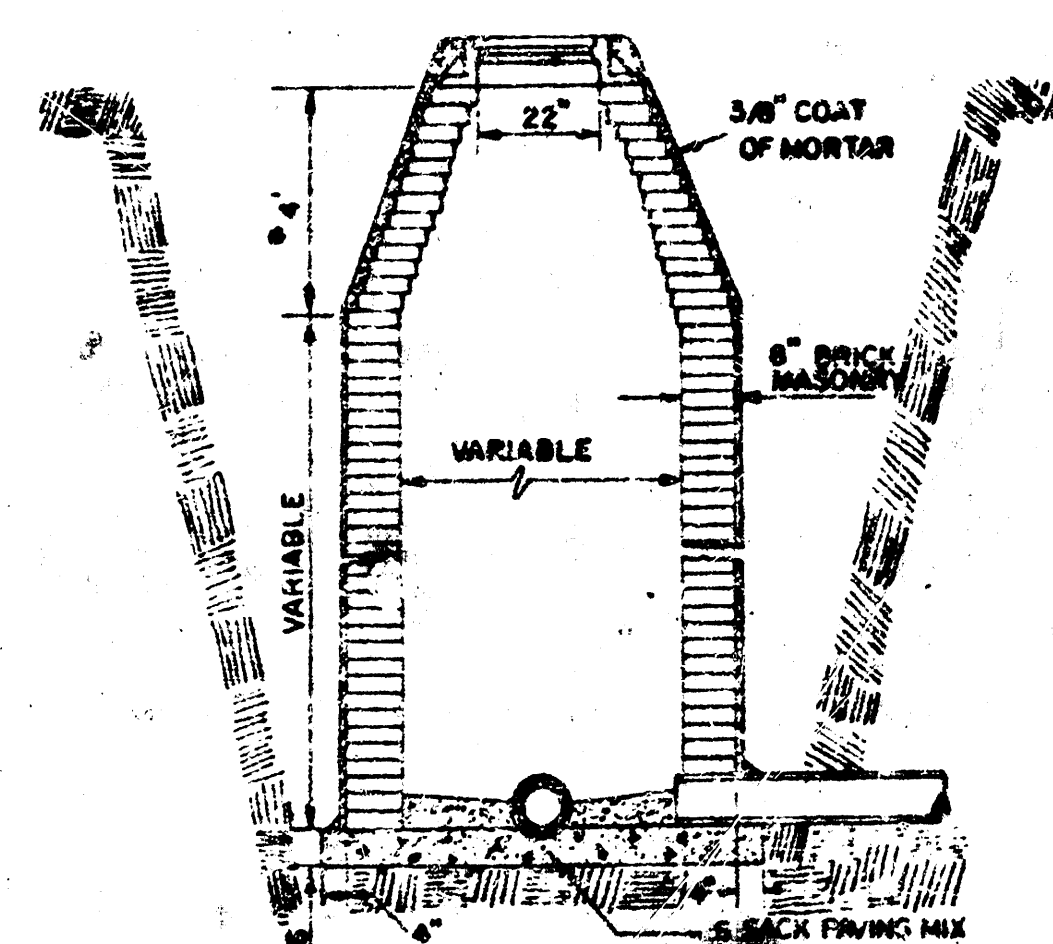


- [illegible]

NOTES:

[illegible]

FOR CONSTRUCTION:

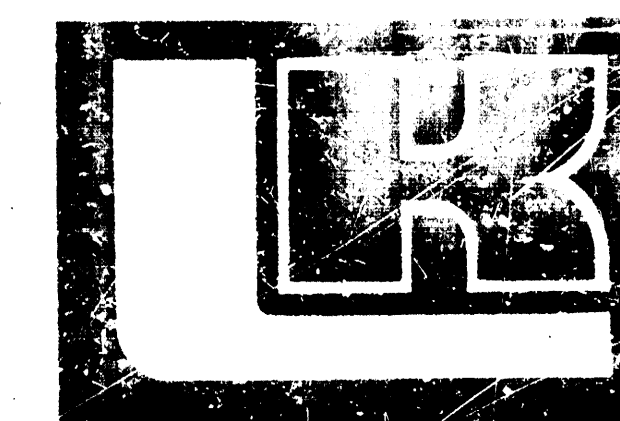
[illegible]

LAW KINGDON, P.A.
313 P. MARKET WICHITA, KANSAS 67202
PHONE (316) 245-8884
ARCHITECTS & ENGINEERS

Copyright © 1978 Law, Kingdon, P.A.

DRAWN		CHECKED	
B-D			
RELATED DRAWINGS			
SEE			
DESIGN			
STRUCTURE			
Mechanical			
ELECTRICAL			
OTHER			
SEQUENCE NUMBER			
OF		SHEET	

**Boston Park
Swimming Pool
& Bathhouse
Wichita, Kansas**

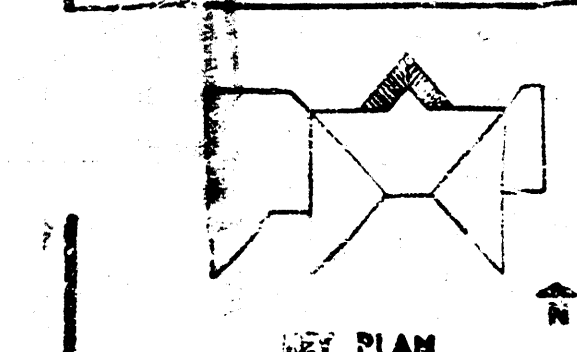

TENANT	
SANITARY SEWER PROFILES AND DETAILS	
SHEET TITLE	
TENANT NUMBER	SHEET NUMBER
	63
CH	SHEET