

WATER DISTRIBUTION SYSTEM IMPROVEMENTS

TO SERVE

WICHITA ANIMAL CARE CAMPUS


PRIVATE PROJECT NO. 1386 PPW (607853)

CITY OF WICHITA, KANSAS

JAMES L. ARMOUR, P.E. - CITY ENGINEER

INDEX OF SHEETS

SHEET NO. CV3.1	TITLE SHEET
SHEET NO. CV3.2	KEY MAP AND GENERAL NOTES
SHEET NO. CV3.3	STANDARD WATER ASSEMBLY DETAILS
SHEET NO. CV3.4-CV3.5	WATERLINE PLAN AND PROFILES
SHEET NO. CV4.1-CV4.4	SOIL EROSION BMP DETAILS
SHEET NO. CV5.1	PLAT

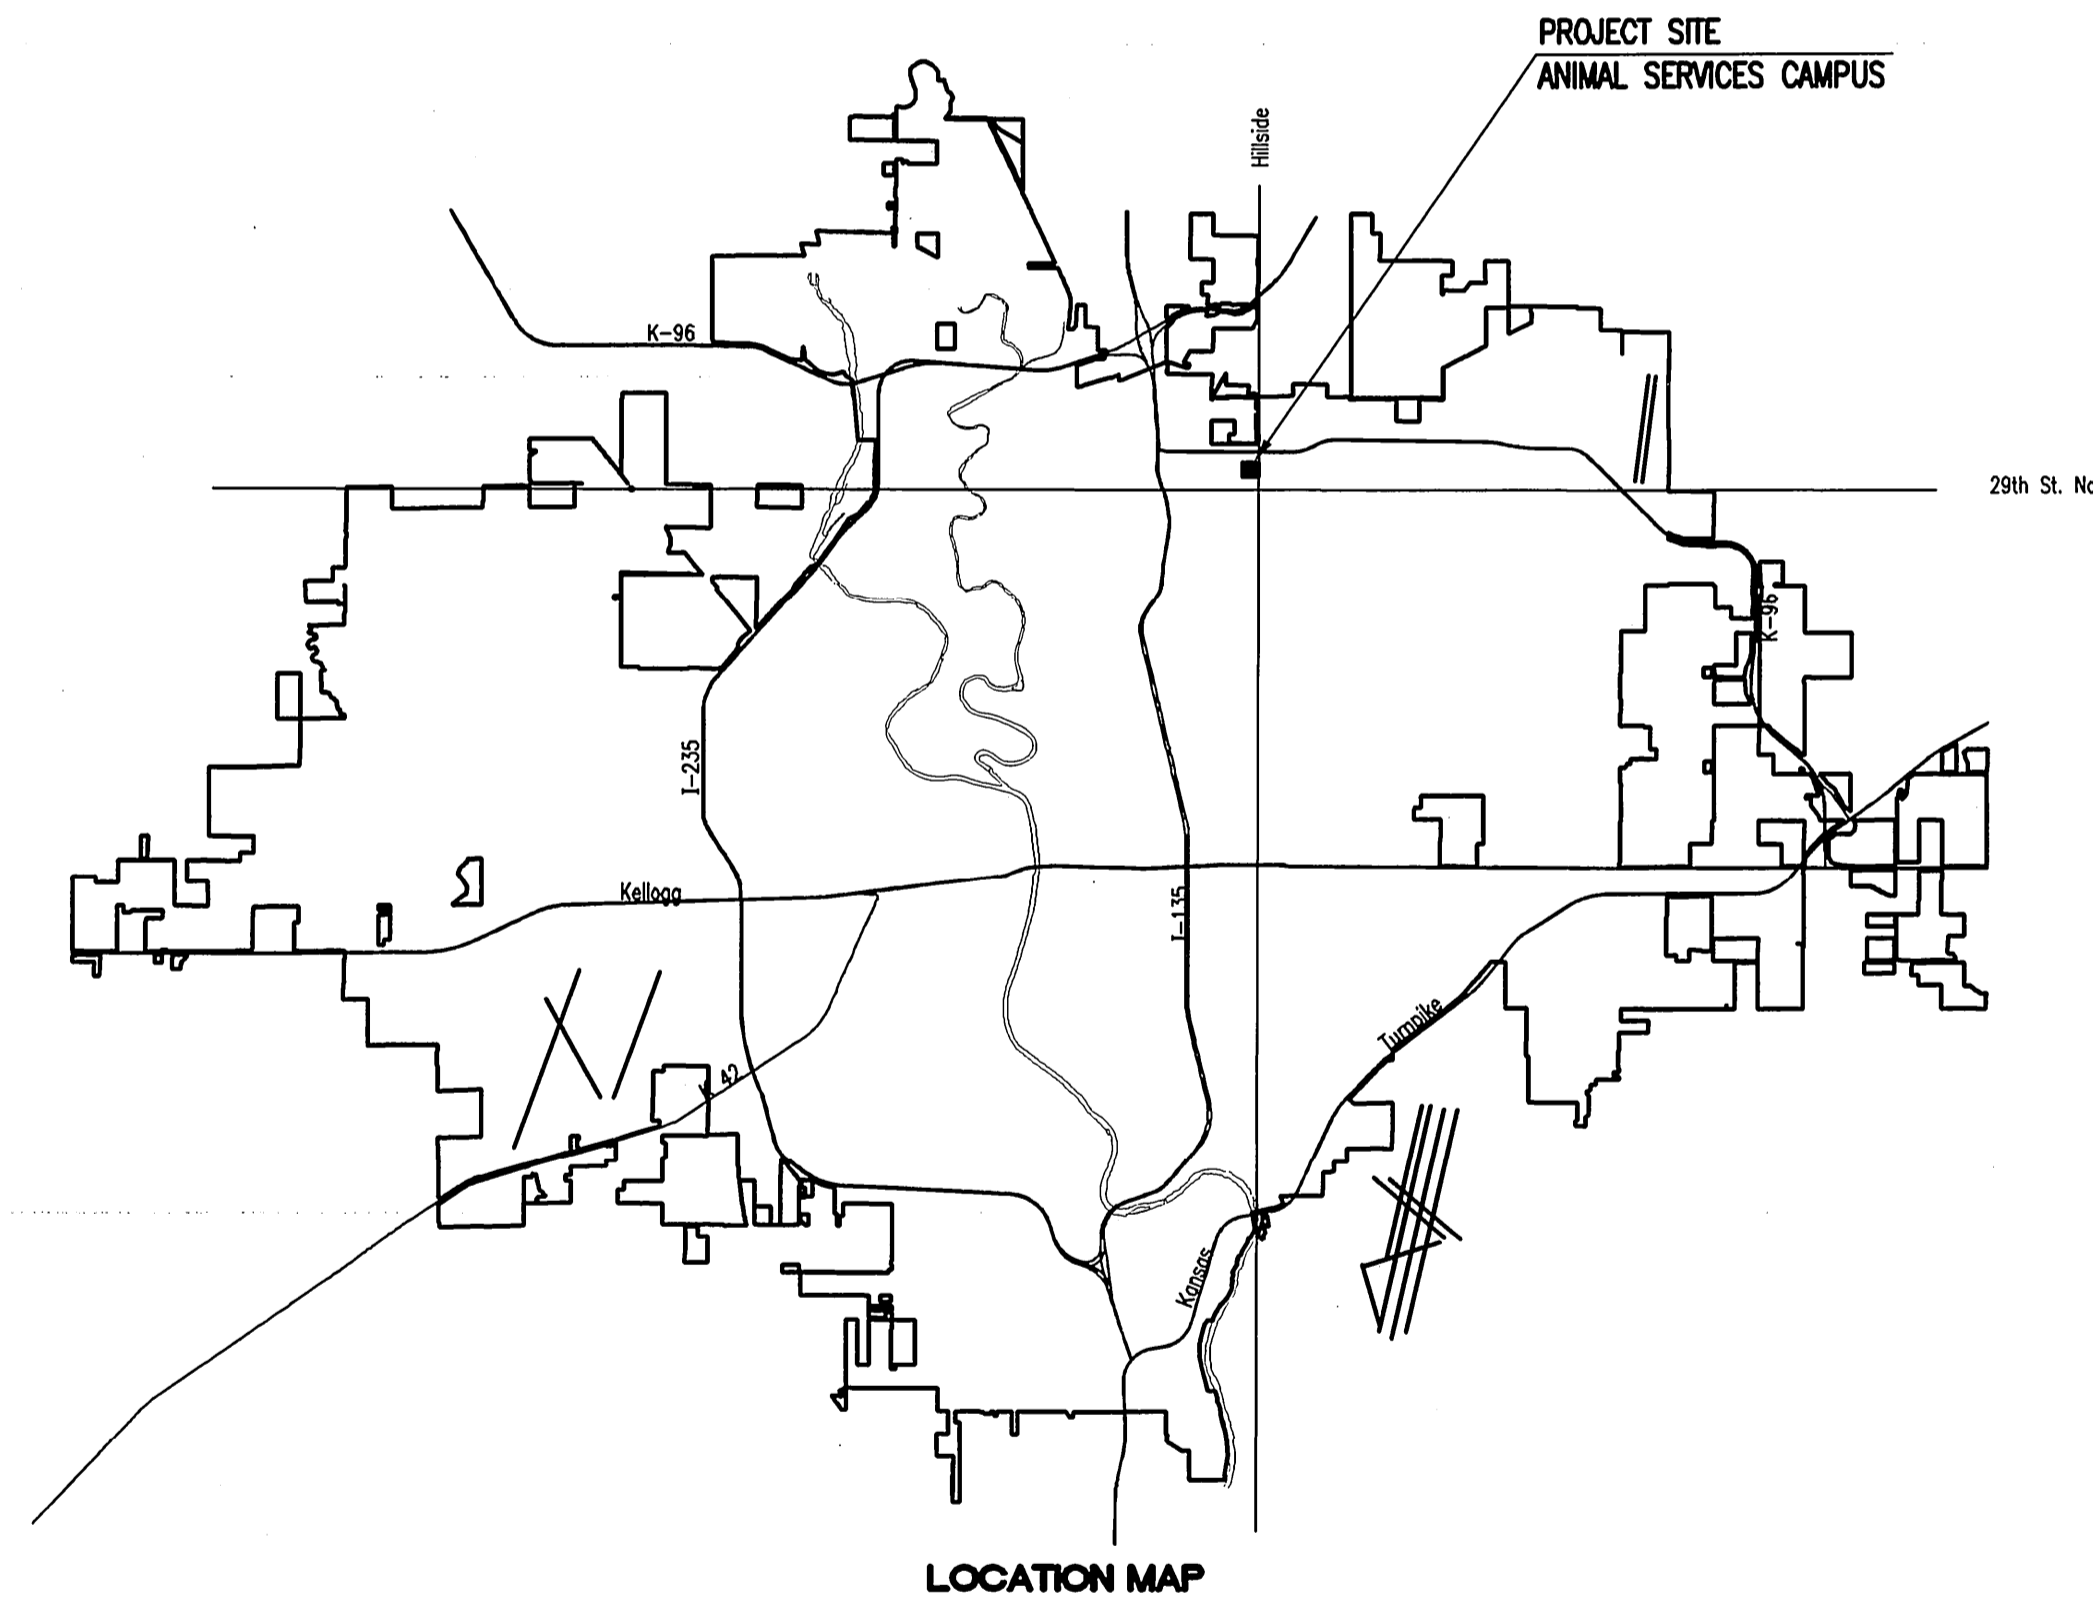

APPROVED AS NOTED
BY CITY ENGINEER OF WICHITA,
BY WICHITA WATER & SEWER DEPARTMENT,
& BY ~~ANDOVER~~ FIRE DEPARTMENT
WICHITA

Water Mains (Public Works) *Jan Jany* 02/11/08

Water Mains (Water and Sewer Dept.) *Jan Jany* 2-4-08

Fire Prot. Line (~~Andover~~ Fire Dept.) *WFD/BCE* 2-11-08

NOTE TO CONTRACTORS

PUBLIC PROPERTY:
Inspection and testing for the waterline is to be provided by a Licensed Consulting Engineering Firm under contract with the Owner/Developer. Said inspection to be in accordance with the City of Wichita standard construction engineering practices and certified by a Licensed Professional Engineer licensed in the State of Kansas. No work shall be performed in dedicated easements or public right-of-way by the Contractor without such inspection nor shall any work be commenced without written authorization by the City Engineer. All Construction and Materials shall comply with the City of Wichita Specifications and Standards (on file and available in the City Engineer's Office).

PRIVATE PROPERTY:
Installation and testing for the fire protection line is to be performed by a City of ~~Andover~~ licensed fire protection contractor in accordance with the fire codes as adopted by the City of ~~Andover~~. All materials and construction practices for the fire protection line shall comply with the fire codes as adopted by the City of ~~Andover~~ (available from the City of ~~Andover~~ Fire Department). The Contractor shall not commence work without notification and approval of the ~~Andover~~ Fire Department.
Inspection of the fire protection line is to be provided by the City of ~~Andover~~ Fire Department and by a licensed Consulting Engineering Firm under contract with the Owner/Developer.
The contractor shall not start work until the project inspector is assigned to the project and present on the site. Any work done without inspection will be required to be uncovered for inspection.



FEBRUARY 2008

PLANS PREPARED BY
PROFESSIONAL ENGINEERING CONSULTANTS, P.A.
ENGINEERS
WICHITA, KANSAS

As Built:
Contractor: Mies Construction
Inspector: Pat Hayes, CED
pdf's by: JDT, CED, 7-22-08

Printed 02-08-2008 05:50 PM by JLC
Plot Size: 11.00 x 17.00
02-08-2008 7:58:26 PM
02-08-2008 05:02:04 PM 05028-004-CV3.1-Waterline Title Sheet