


STA. 24+22.49, LINE 1=
 8" DIMU 45° BEND
 8" DIMU 11.25° BEND
 DEFLECT PIPE (1704'16")
 N 13086.52 E 12204.36

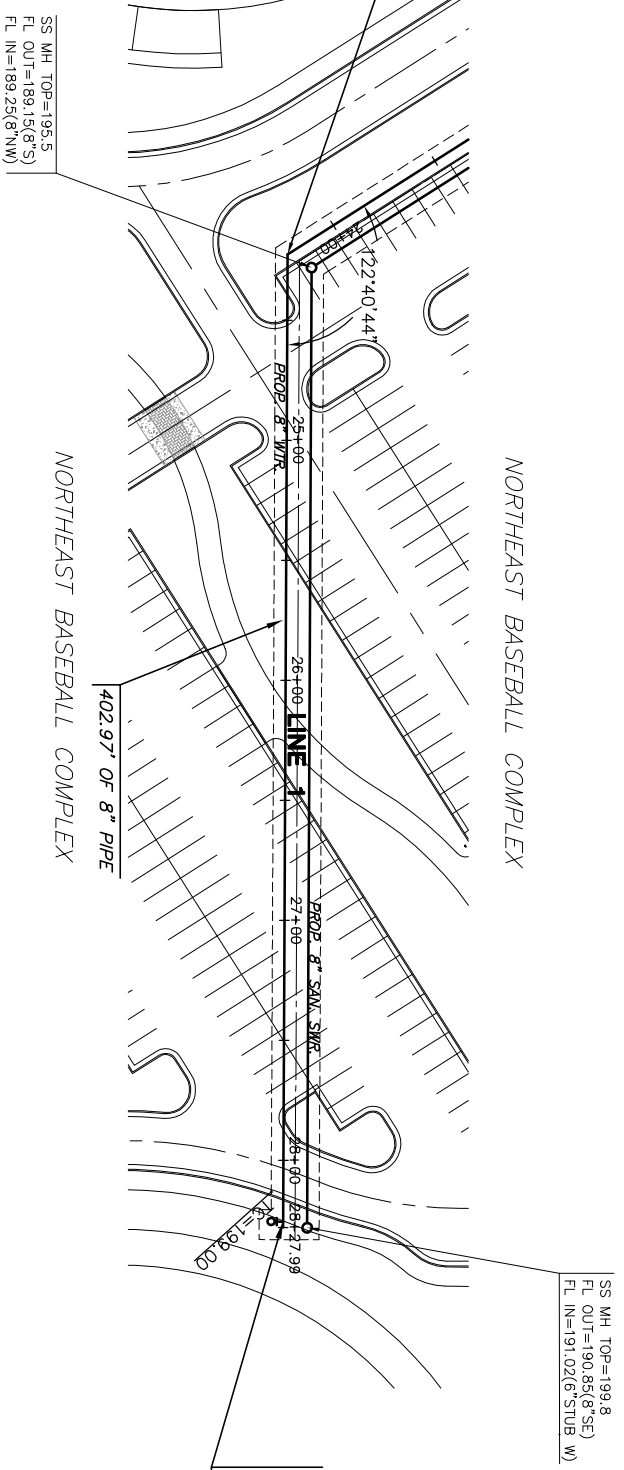

STA. 28+25.46, LINE 1
 1-FIRE HYDT. ASSY.
 L=3.5'
 1-8" MJ PLUG
 N 13307.56 E 11867.43


SS MH TOP=199.8
 FL OUT=190.85(8°SE)
 FL IN=191.02(6°STUB W)

PLAN LINE 1

AS-BUILT AUGUST 2008

PROFILE LINE 1

SCALE: HORIZ 1"=20'
 SCALE: VERT 1"=5'

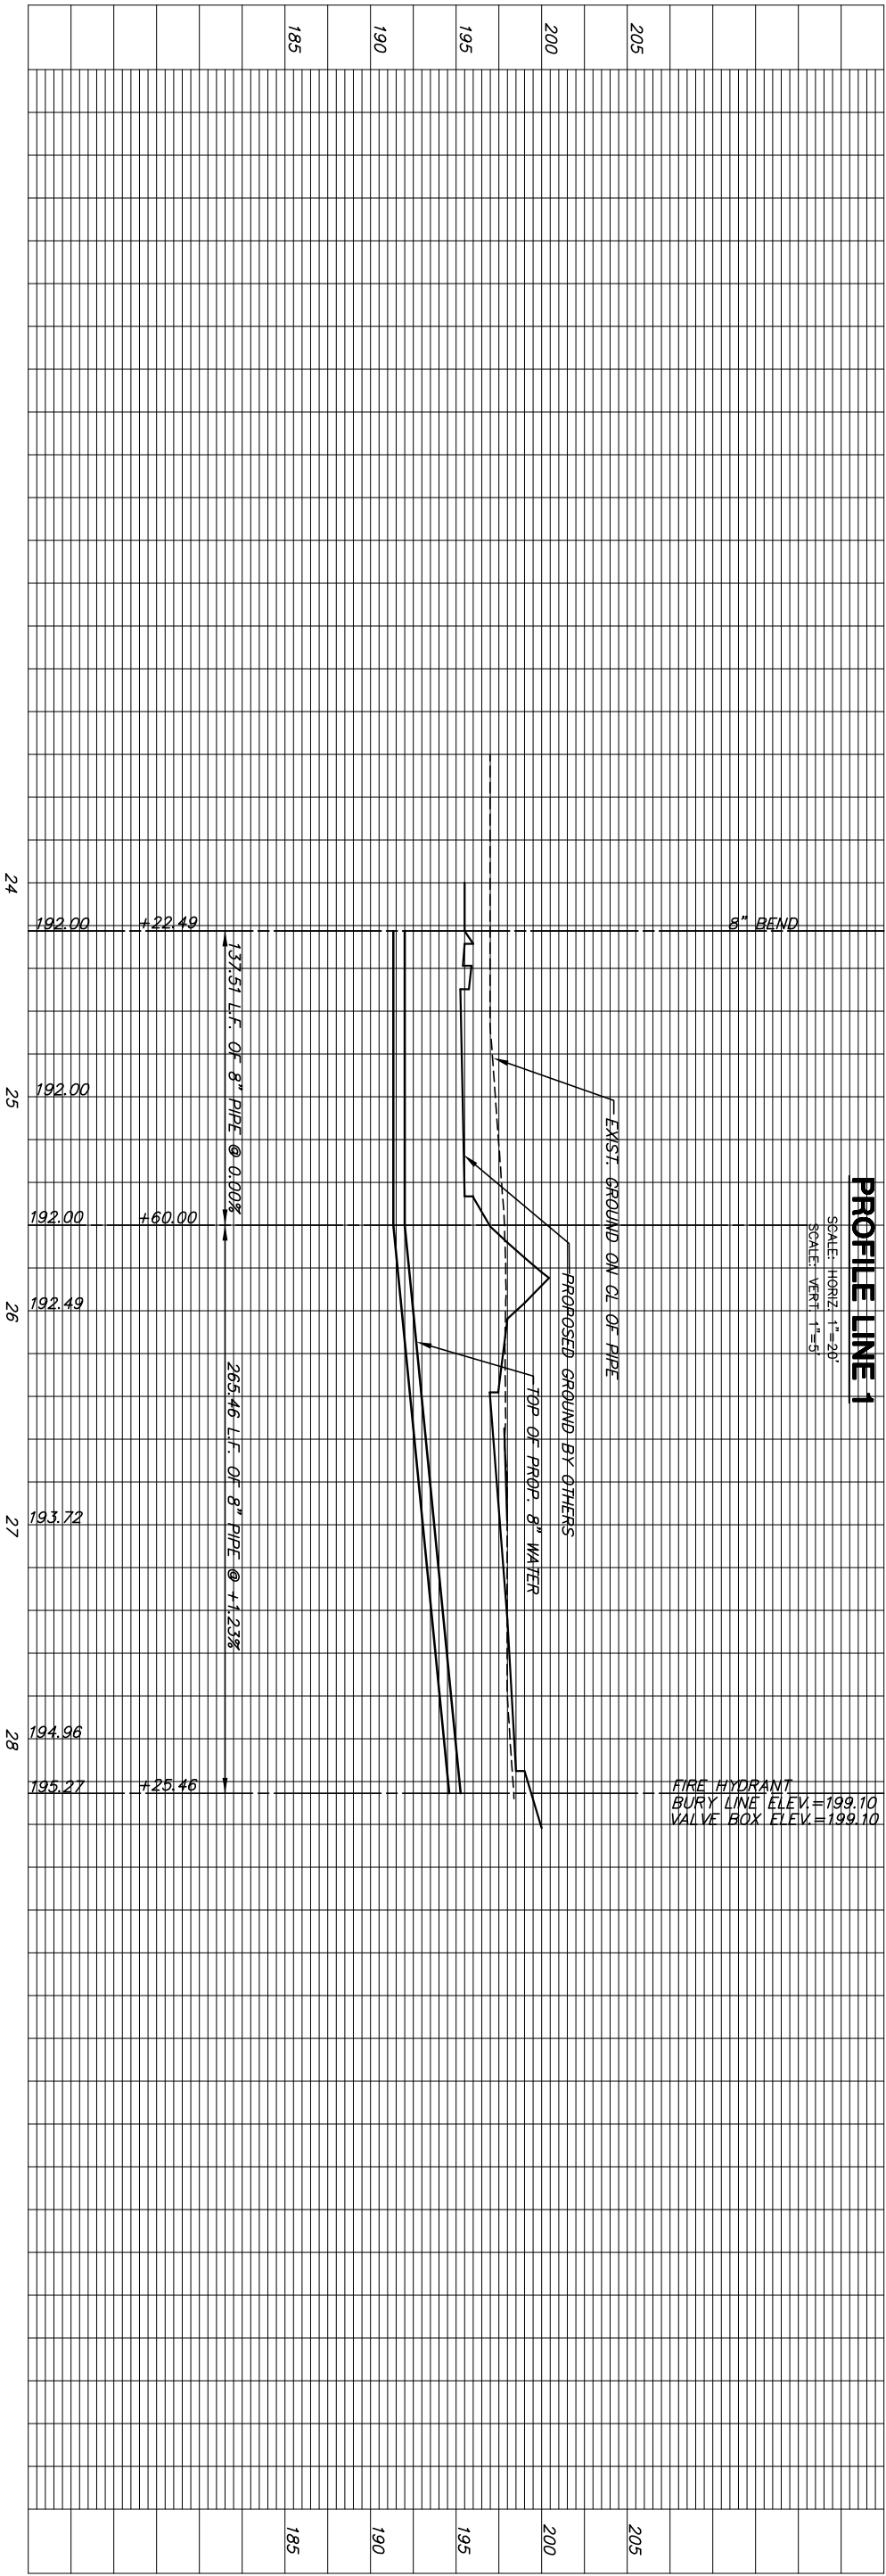

FIRE HYDRANT
 BURY LINE ELEV.=199.10
 VALVE BOX ELEV.=199.10

MKREC
 ENGINEERING
 CONSULTANTS, INC.
 411 N. WEBB ROAD
 WICHITA, KS 67208
 316-684-9600

**WATER PLANS FOR
 NORTHEAST BASEBALL COMPLEX**

STREET TITLE
LINE 1
 PROJECT NUMBER
 1332PPW

JTC / DDC / GJA
 DESIGNED / DRAWN / CHECKED

ISSUED
 AUGUST 2007
 REVISED
 DECEMBER 2007

SHEET NO.
5 OF 6