
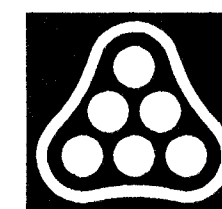
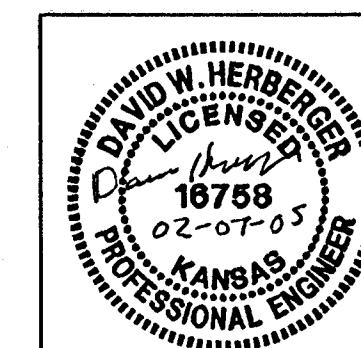
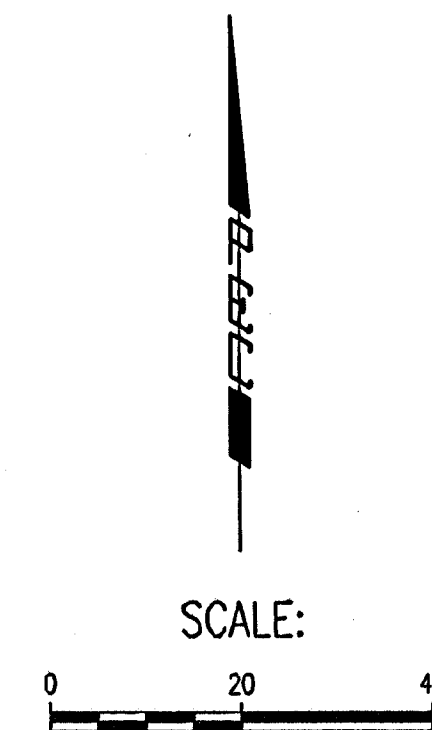


DSNR: DMH OPER: SAW SCALE: 1"=20.00
Q:\2004\04549\000\PPP\04549-000-C-Grading Plan 02-07-2005 03:25:09 pm

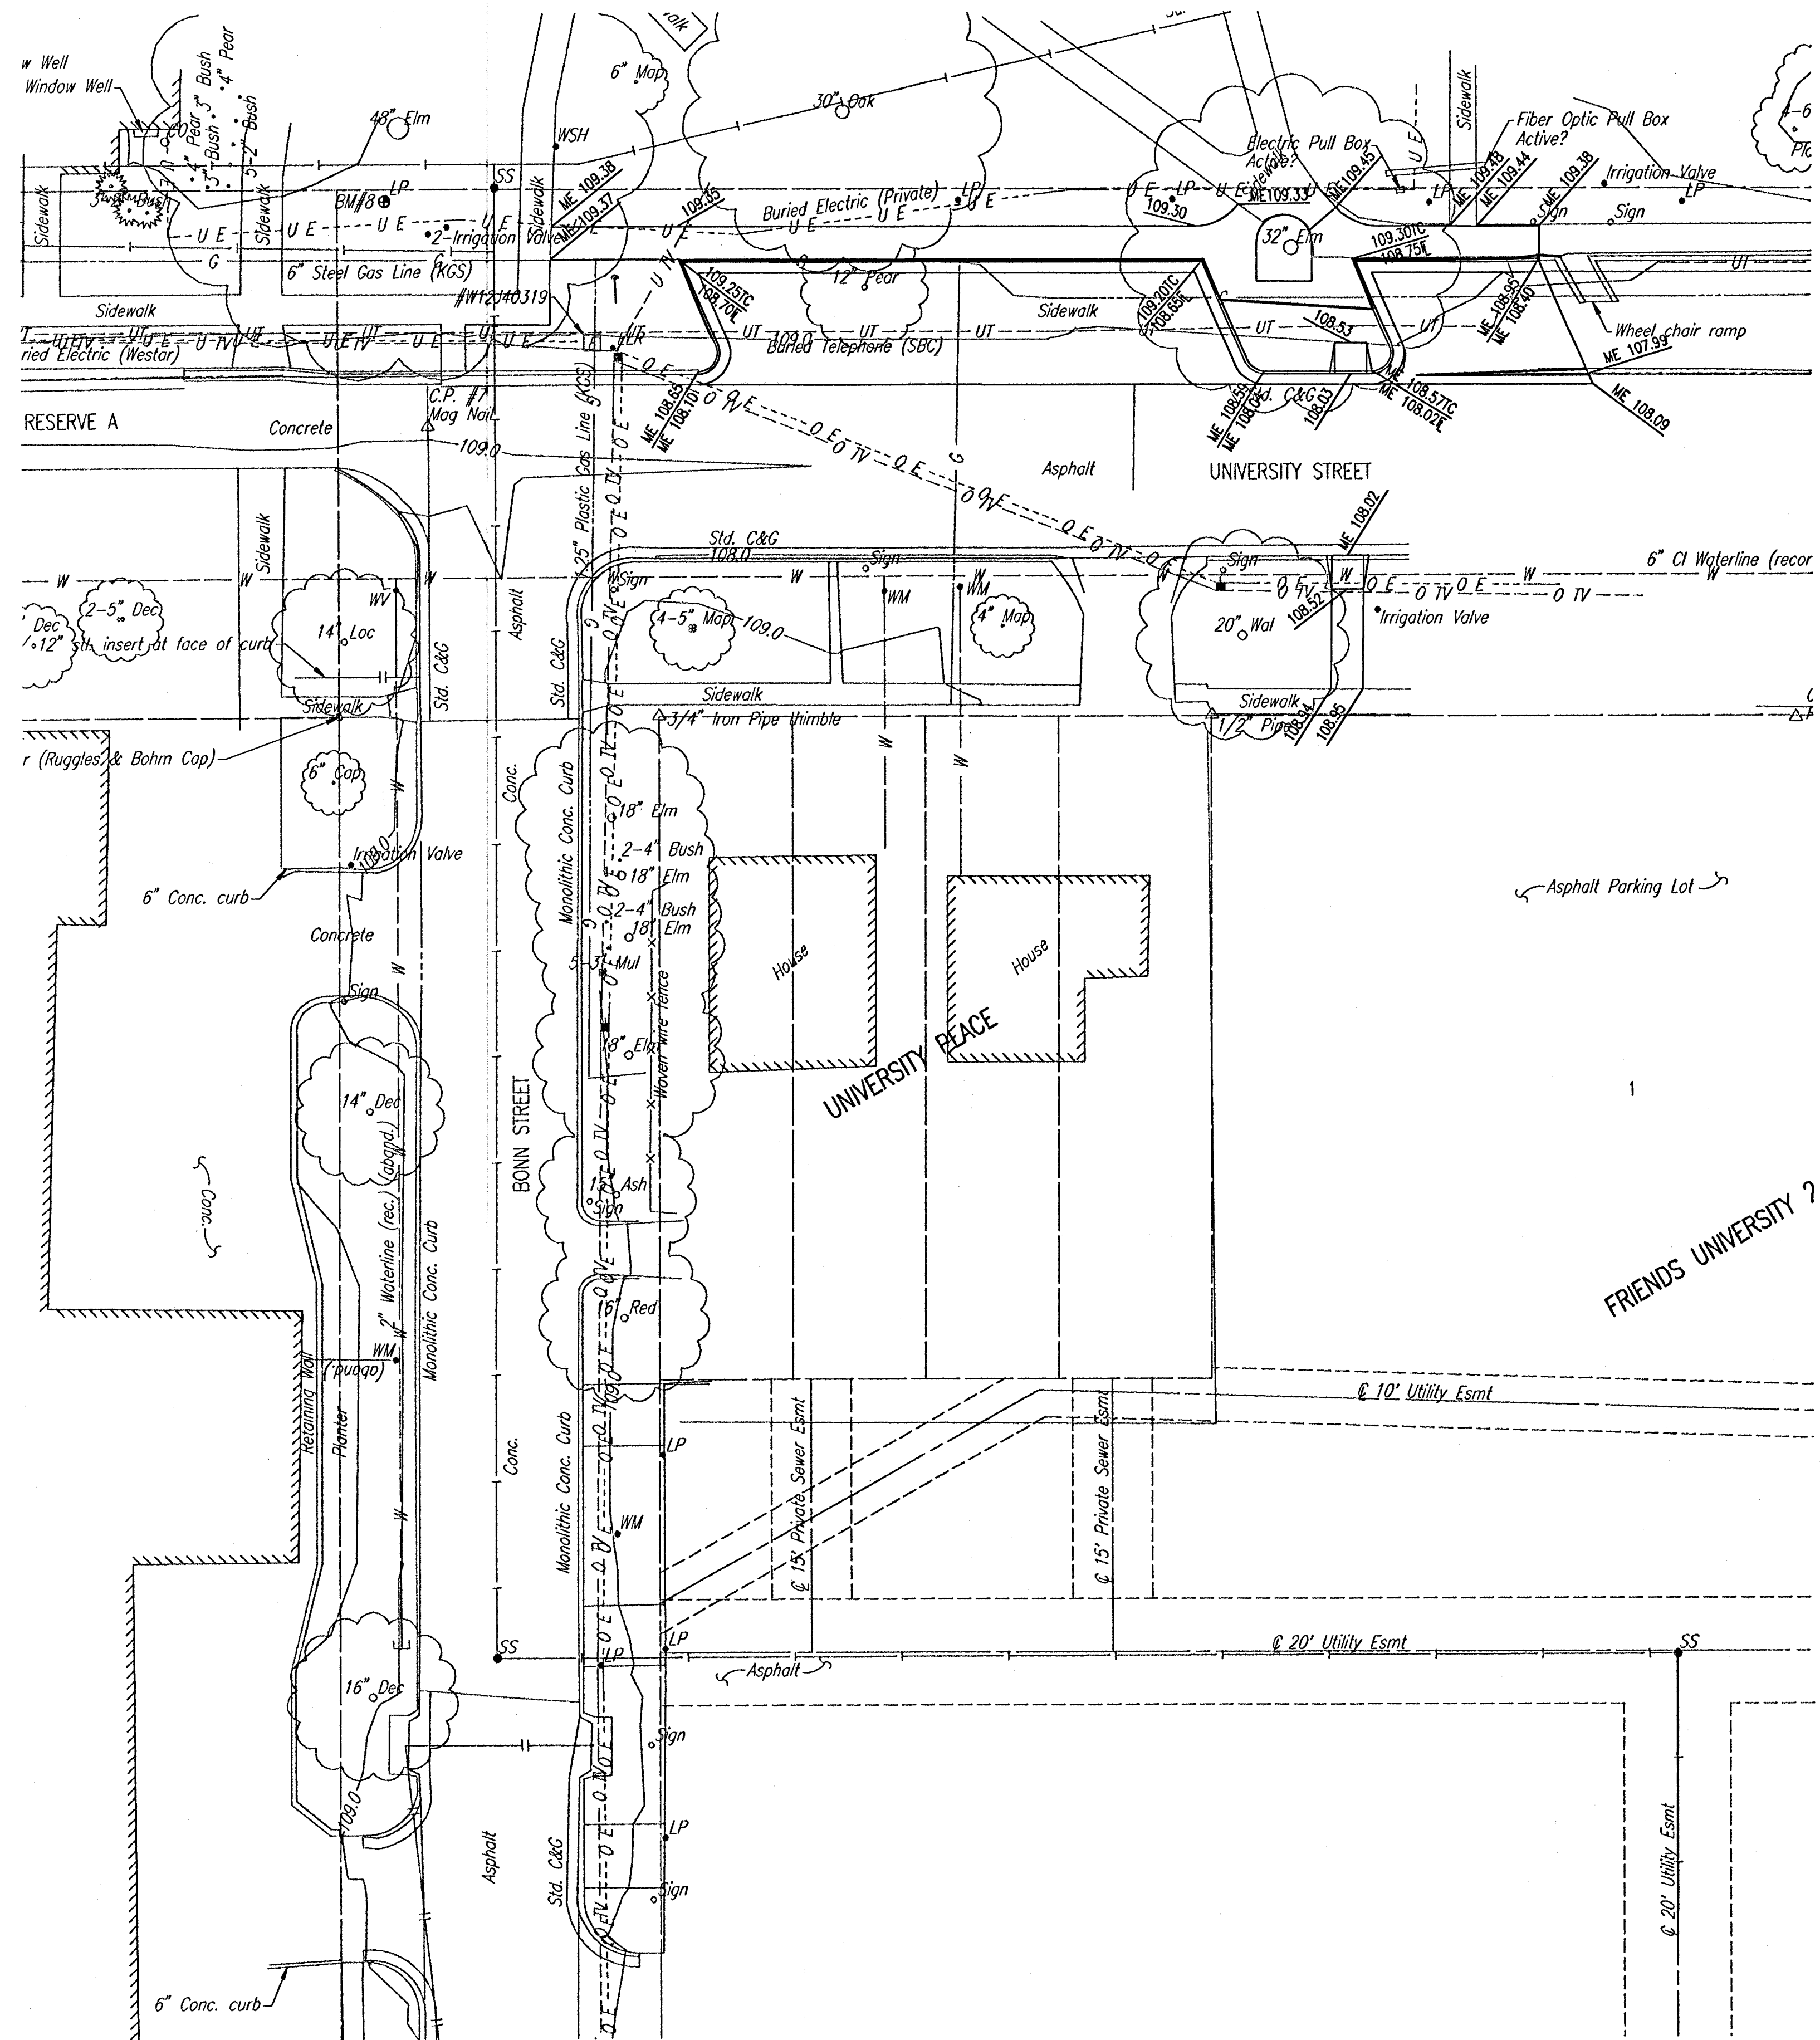

No.		Revision	By	Date
CITY OF WICHITA, KANSAS JAMES L. ARMOUR, P.E.-ACTING CITY ENGINEER FRIENDS UNIVERSITY-WOOLMAN REPLACEMENT GRADING PLAN PRIVATE PROJECT NO. 164PPP (607879) Professional Engineering Consultants, P.A. 303 S. TOPEKA • WICHITA, KANSAS 67202 316-262-2691 • FAX 316-262-3003				
Designed by	DIWH	Job No.	35-04549-0259	Sht. 6 of 12
Drawn by	SAW	Date	FEBRUARY 2005	