

STATE OF KANSAS
DEPARTMENT OF TRANSPORTATION

PLAN AND PROFILE OF PROPOSED

**MIDTOWN
BIKEPATH/GREENWAY**

FROM CENTRAL AVE. AND WICHITA ST.
TO 15TH STREET AND BROADWAY

FEDERAL AID PROJECT

CITY OF WICHITA PROJECT NO. 472 84008

INDEX CODE:

WICHITA, SEDGWICK COUNTY

K.D.O.T. PROJECT NO. TE 0234 01


FEDERAL PROJECT NO. TEA-T023(401)

FHWA REGION NO.	STATE	PROJECT NUMBER	FISCAL YEAR	SHEET NUMBER	TOTAL SHEETS
	KANSAS				70

**GRADING
SURFACING
PAVEMENT MARKINGS
SEEDING
LANDSCAPING
LIGHTING**

INDEX OF SHEETS

- 1 TITLE SHEET
- 2 GENERAL NOTES/HORIZONTAL CONTROL
- 3 TYPICAL SECTIONS
- 4-20 BIKEPATH PLAN AND PROFILE
- 21 ENLARGED GRADING PLANS
- 22 STANDARD DRIVE ENTRANCES
- 23 STORM SEWER PLAN & PROFILE
- 24-27 PAVEMENT MARKING & SIGNING PLANS
- 28 2'x2' INLET DETAIL
- 29 DRIVEWAY GRATE DETAIL
- 30 DETAILED SPECIFICATIONS FOR REINF. SIGN PANELS
- 31 TRAFFIC CONTROL SIGNS
- 32 SIGNING DETAILS & QUANTITIES
- 33 EROSION CONTROL SEEDING-SODDING SUMMARY OF SEEDING QUANTITIES
- 34 TEMPORARY EROSION AND POLLUTION CONTROL
- 35 TEMPORARY EROSION AND POLLUTION CONTROL
- 36 TEMPORARY EROSION AND POLLUTION CONTROL
- 37 TEMPORARY EROSION AND POLLUTION CONTROL
- 38 SIDEWALK AND STEPS
- 39 AUXILIARY DETAILS FOR SIDEWALK & STEPS
- 40 GENERAL TRAFFIC CONTROL
- 41 CHANNELIZING DEVICES
- 42 TYPE III BARRICADE (FIXED) W/ RII-2 SIGN
- 43 SUMMARY OF QUANTITIES
- 44 ENLARGED LANDSCAPE PLANS
- 45 ENLARGED LANDSCAPE PLANS
- 46 LANDSCAPING SITE DETAILS
- 47 LANDSCAPING SITE DETAILS
- 48 LANDSCAPING SITE DETAILS
- 49 LANDSCAPE PLANTING PLAN
- 50 LANDSCAPE PLANTING PLAN
- 51 LANDSCAPE PLANTING PLAN
- 52 LANDSCAPE PLANTING PLAN
- 53 LANDSCAPE PLANTING PLAN
- 54 LANDSCAPE PLANTING PLAN
- 55 LANDSCAPE PLANTING PLAN
- 56 LANDSCAPE PLANTING PLAN
- 57 LANDSCAPE PLANTING PLAN
- 58 LANDSCAPE PLANTING PLAN
- 59 LANDSCAPE PLANTING PLAN
- 60 LANDSCAPE PLANTING PLAN
- 61 LANDSCAPE PLANTING PLAN
- 62 LANDSCAPE PLANTING PLAN
- 63 LANDSCAPE PLANTING PLAN
- 64 RAIN GARDEN PLANTING PLAN
- 65 RAIN GARDEN PLANTING PLAN
- 66 PLANTING NOTES & SCHEDULE
- 67 PLANTING DETAILS
- E1 LIGHTING PLANS
- E2 LIGHTING PLANS
- E3 LIGHTING PLANS

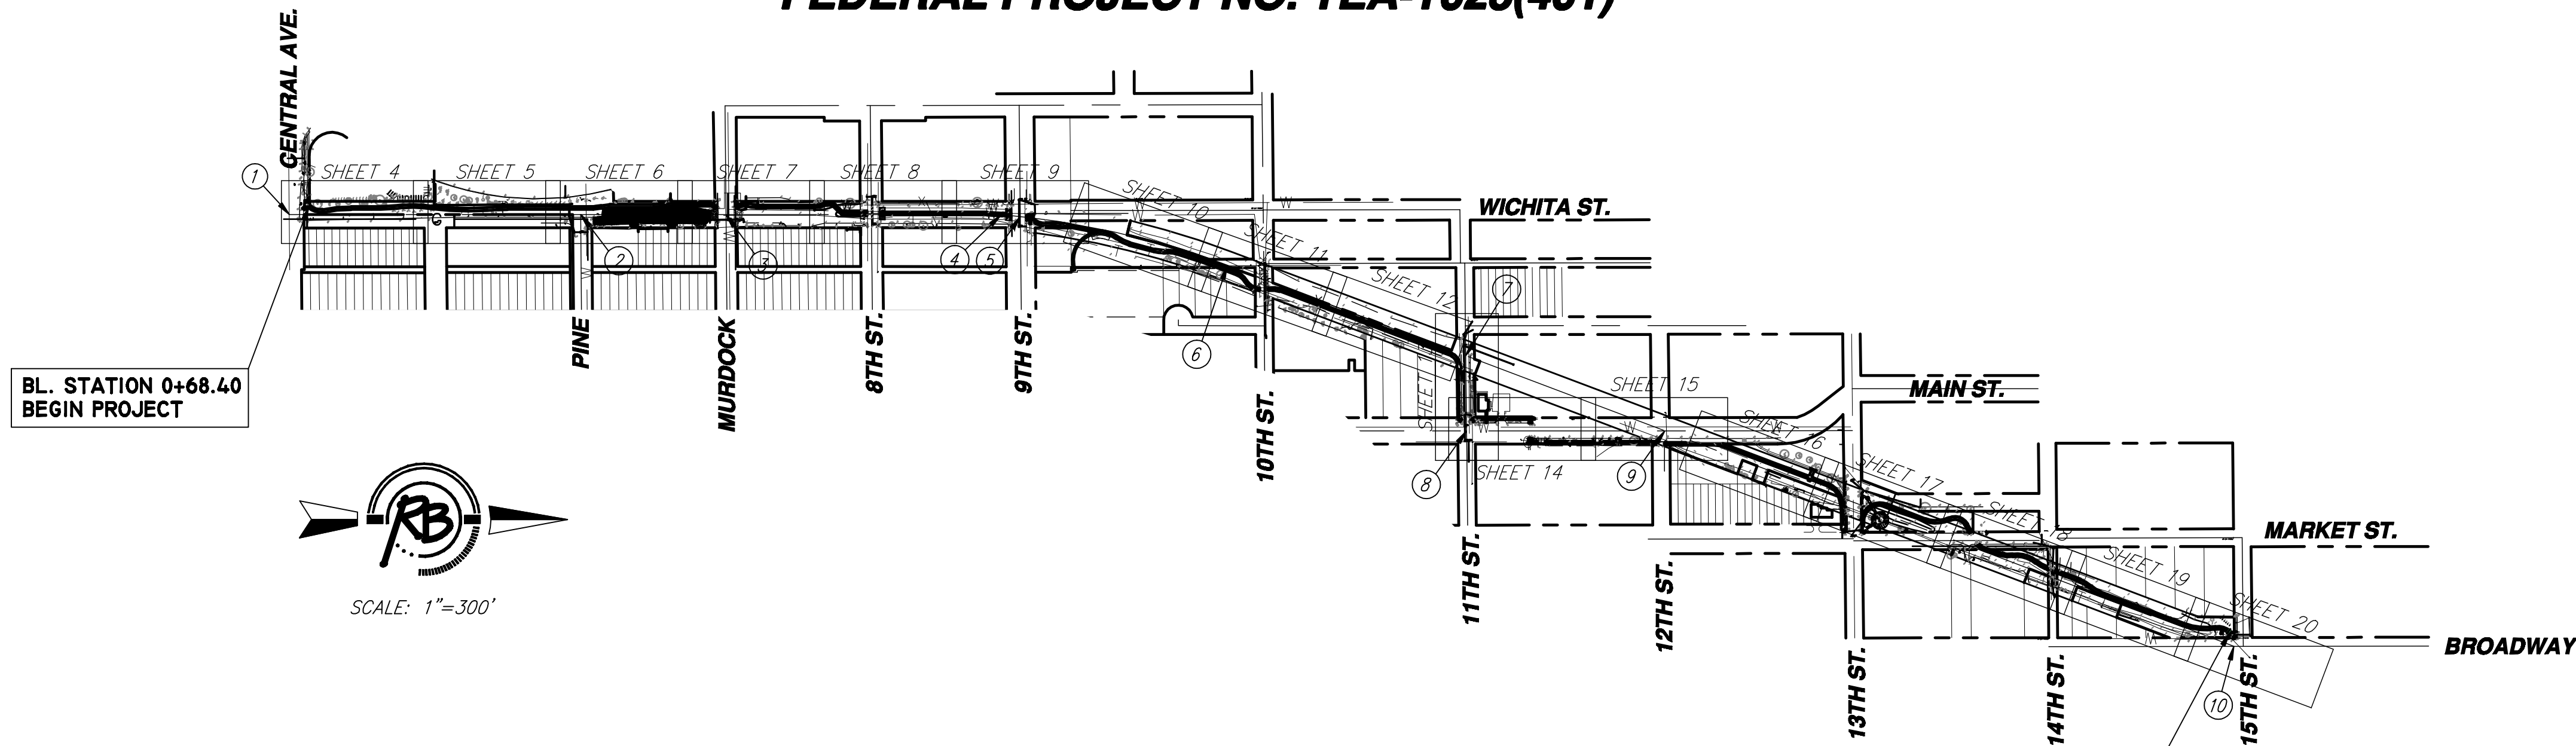

DESIGN DESIGNATION

FOR BICYCLES
V = 20 MPH
CLEAR ZONE = 3 FEET

COORDINATE CONTROL TABLE

CONTROL NO.	DESCRIPTION	NORTHING	EASTING
①	BASELINE STA. 0+00 (CENTRAL & WICHITA)	19004.36	19630.54
②	BASELINE STA. 9+92.26 (PINE & WICHITA)	19996.62	19630.84
③	BASELINE STA. 14+86.98 (MURDOCK & WICHITA)	20491.34	19630.99
④	BASELINE STA. 32+24.29 (P.C. @ RAILROAD)	21428.65	19631.27
⑤	BASELINE STA. 24+89.90 (9TH & WICHITA)	21493.96	19637.53
⑥	BASELINE STA. 32+16.00 (P.T. @ RAILROAD)	22198.52	19805.34
⑦	BASELINE STA. 40+84.15 (@ RAILROAD & 11TH)	23010.82	20111.38
⑧	BASELINE STA. 43+40.13 (11TH & MAIN)	23013.59	20367.34
⑨	BASELINE STA. 50+15.20 (@ RAILROAD & MAIN)	23688.66	20367.16
⑩	BASELINE STA. 70+88.08 (@ RAILROAD & BROADWAY)	25627.33	21100.91


SEE SHEET 2 FOR ADDITIONAL COORDINATE CONTROL

GROSS LENGTH OF PROJECT	7,062 FT.	
EXCEPTIONS	FT.	
ADDITIONS	FT.	
NET LENGTH OF PROJECT	FT.	MILES
NET LENGTH OF BRIDGES	FT.	MILES
NET LENGTH OF ROADS	FT.	MILES

BL. STATION 70+61.11
END PROJECT

UTILITIES LEGEND

WATER	---	W
SANITARY SEWER	---	SS
AT&T	---	T
WESTAR	---	UGE
STORM WATER SEWER	---	
KANSAS GAS SERVICE	---	G

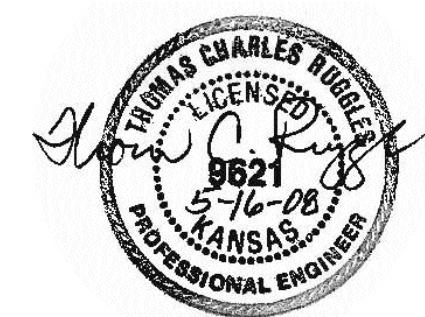

ALL ELEVATIONS ARE IN FEET. (NGVD 29 DATUM)

APPROVED - DATE _____
JAMES L. ARMOUR, P.E., CITY ENGINEER
WICHITA, KANSAS
PROJ. NO. 472 84008



Ruggles & Bohm, P.A.
Engineering, Surveying, Land Planning
924 North Main
Wichita, Kansas 67203
www.rbkansas.com
(316) 284-8008
(316) 284-4821 fax
E-mail: info@rbkansas.com