
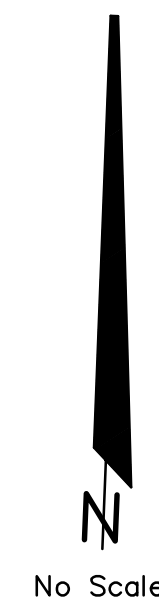


CONSTRUCTION PLANS FOR WATER DISTRIBUTION SYSTEM IMPROVEMENTS


TO SERVE

HIGH POINT WEST ADDITION THE CITY OF WICHITA, KANSAS SEDGWICK COUNTY, KANSAS

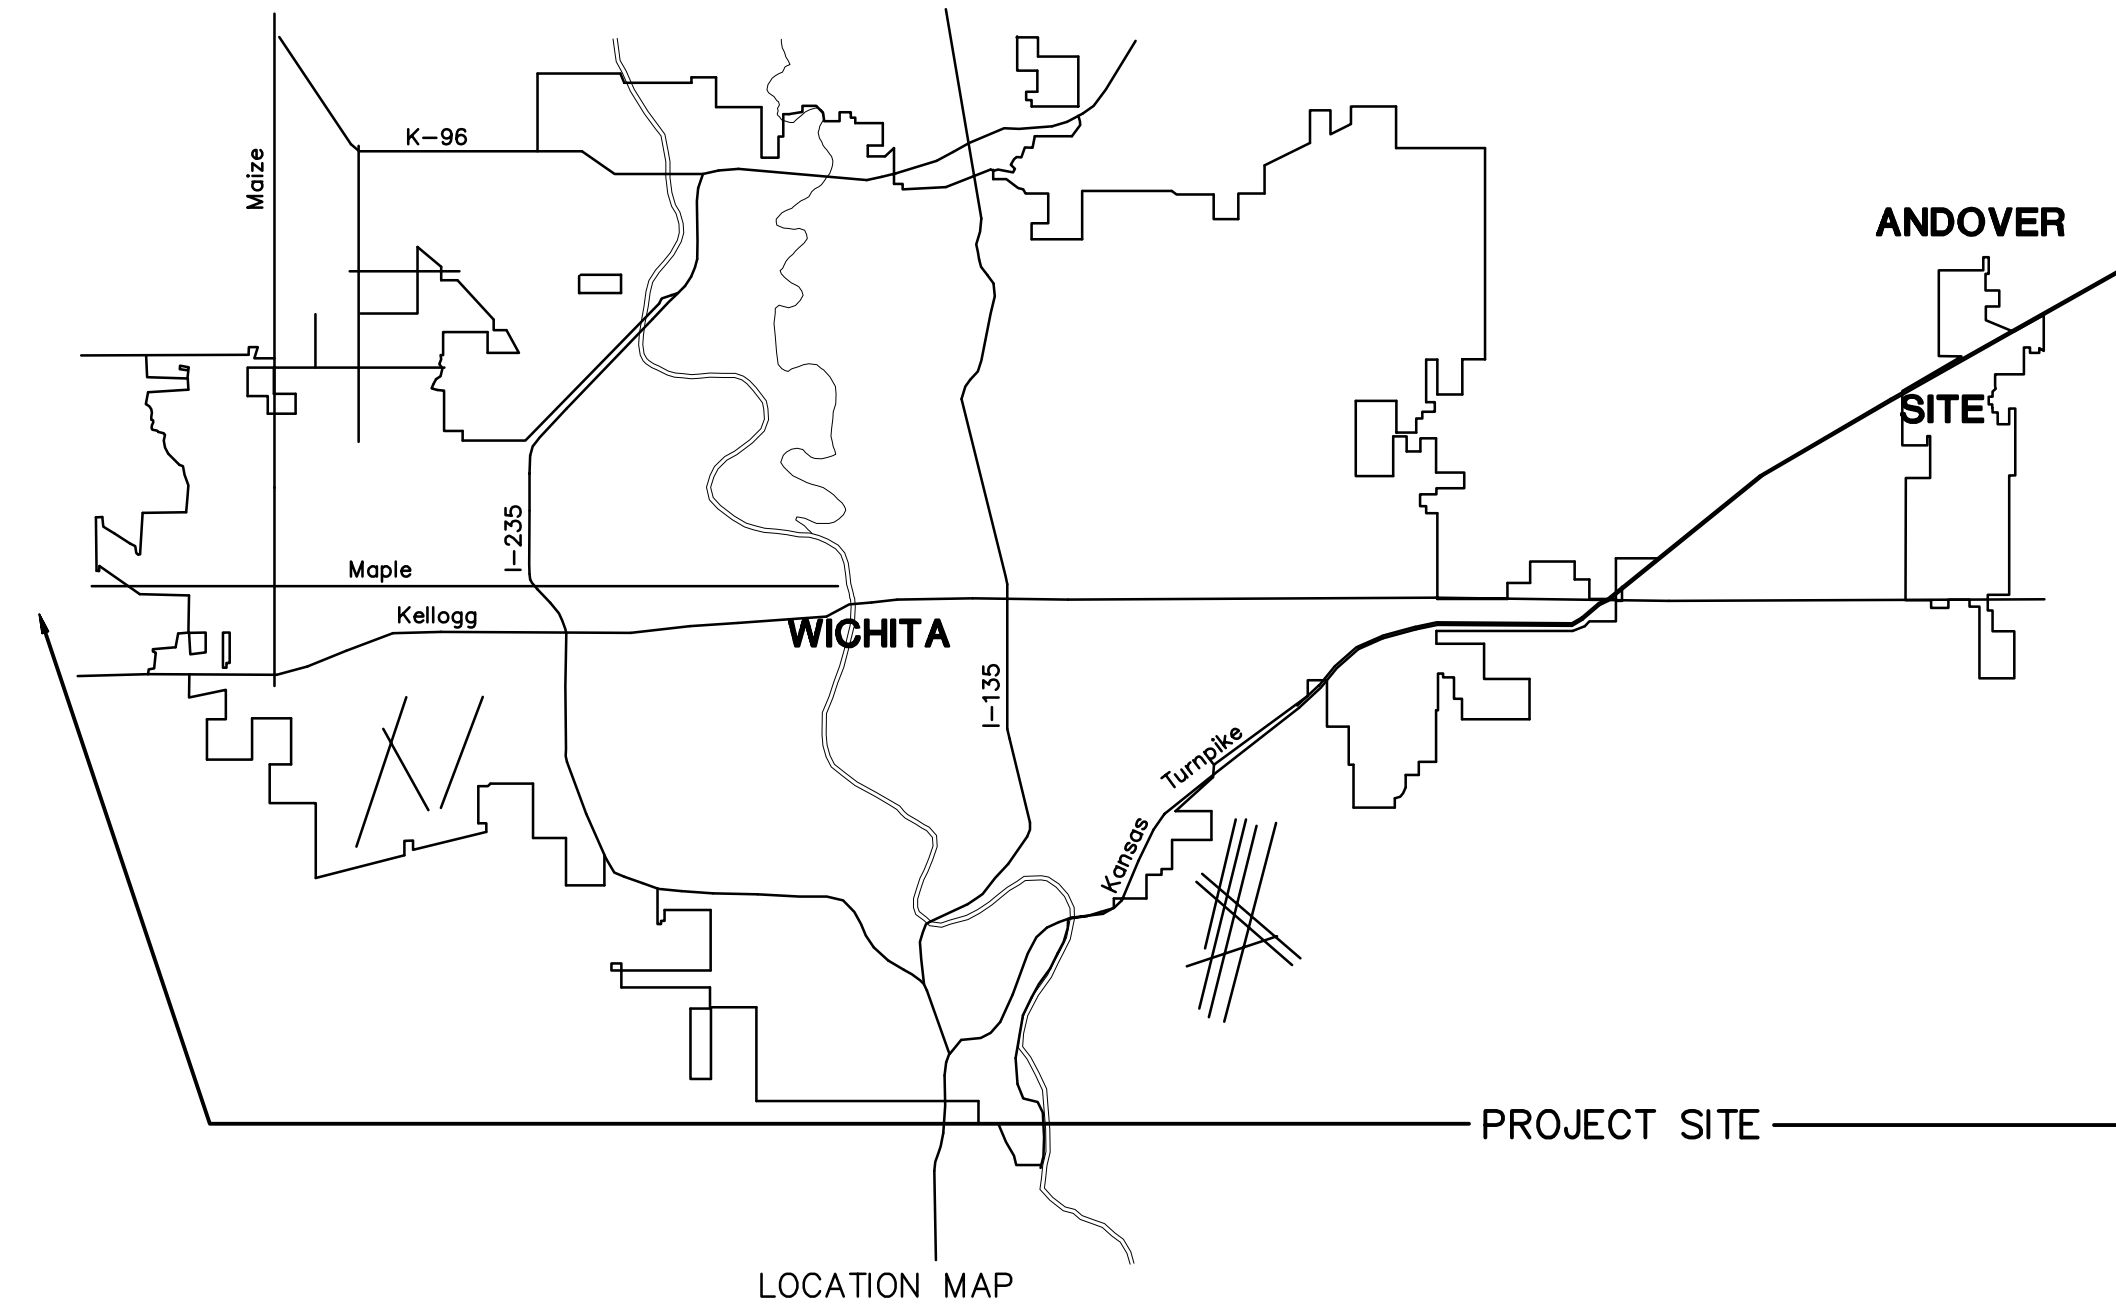


INDEX OF SHEETS

SHEET NO. 1	TITLE SHEET
SHEET NO. 2	KEY MAP
SHEET NO. 3	STANDARD DETAILS
SHEET NO. 4-5	PLAN PROFILE
SHEET NO. 6-10	EROSION CONTROL DETAILS
SHEET NO. 11-14	TRAFFIC CONTROL DETAILS
SHEET NO. 15	COORDINATE POINTS LIST
SHEET NO. 16	PLAT

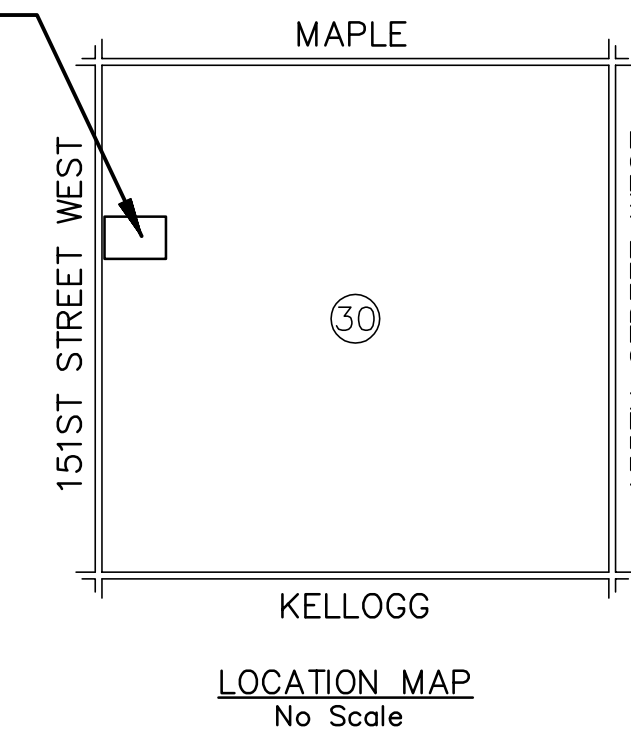

OCA NO. 735422
CITY OF WICHITA PROJECT NO. 448-90377
OCTOBER 2008
PLANS PREPARED BY

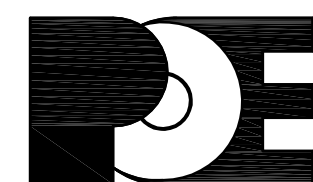

POE & ASSOCIATES, INC.
CONSULTING ENGINEERS
5940 E. Central, Suite 200 ■ Wichita, KS 67208-4242
Phone 316/685-4114 ■ FAX 316/685-4444

