




STATE	PROJECT NO.	YEAR	SHEET NO.	SHEETS
KANSAS	87 N-0357-01	2008	70	185

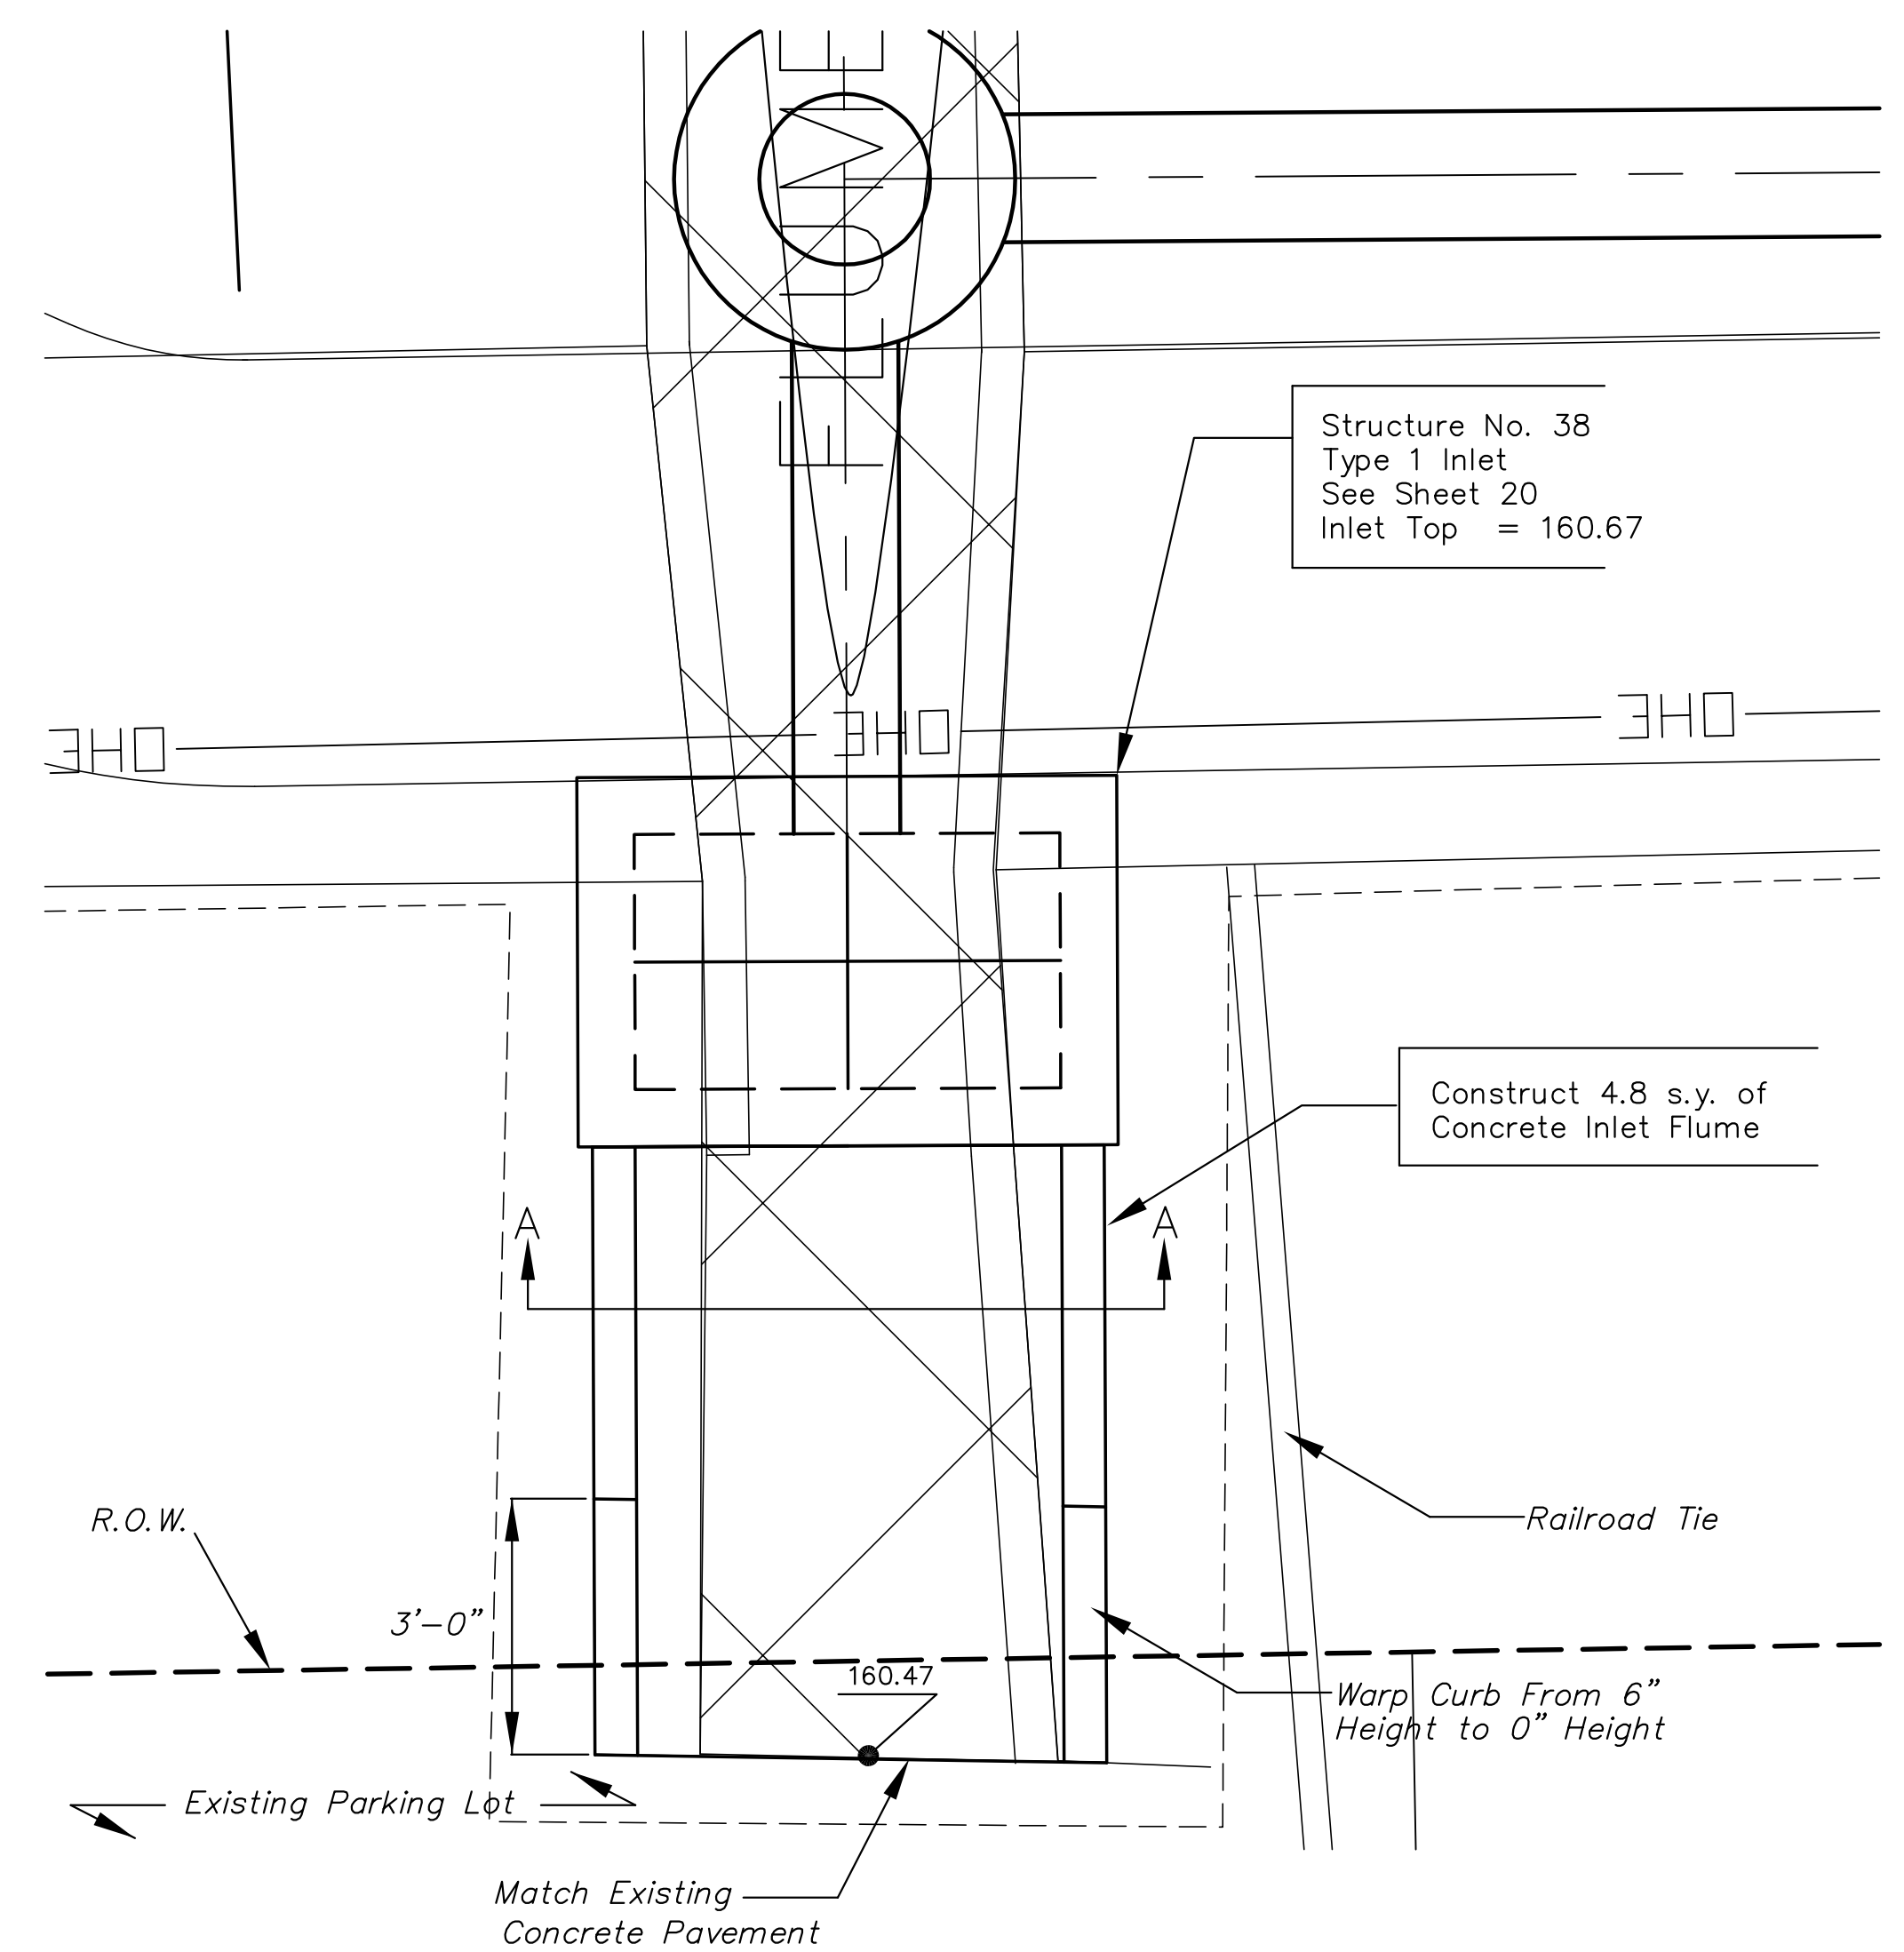


INLET FLUME DETAIL
(Sta. 40+50.95)

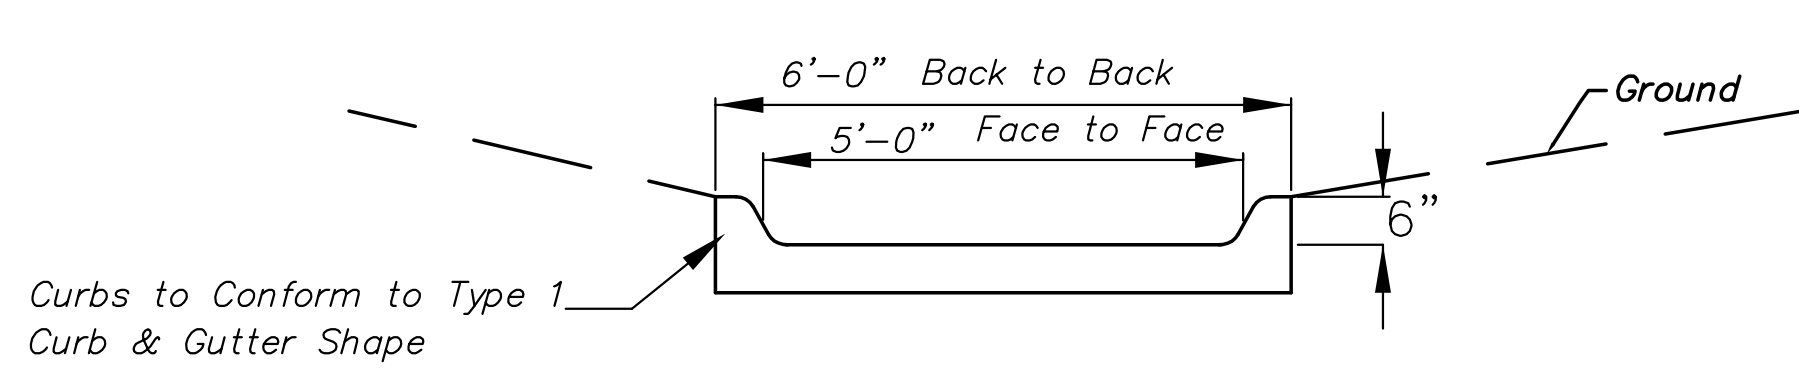

SECTION A-A INLET FLUME DETAIL
N.T.S.

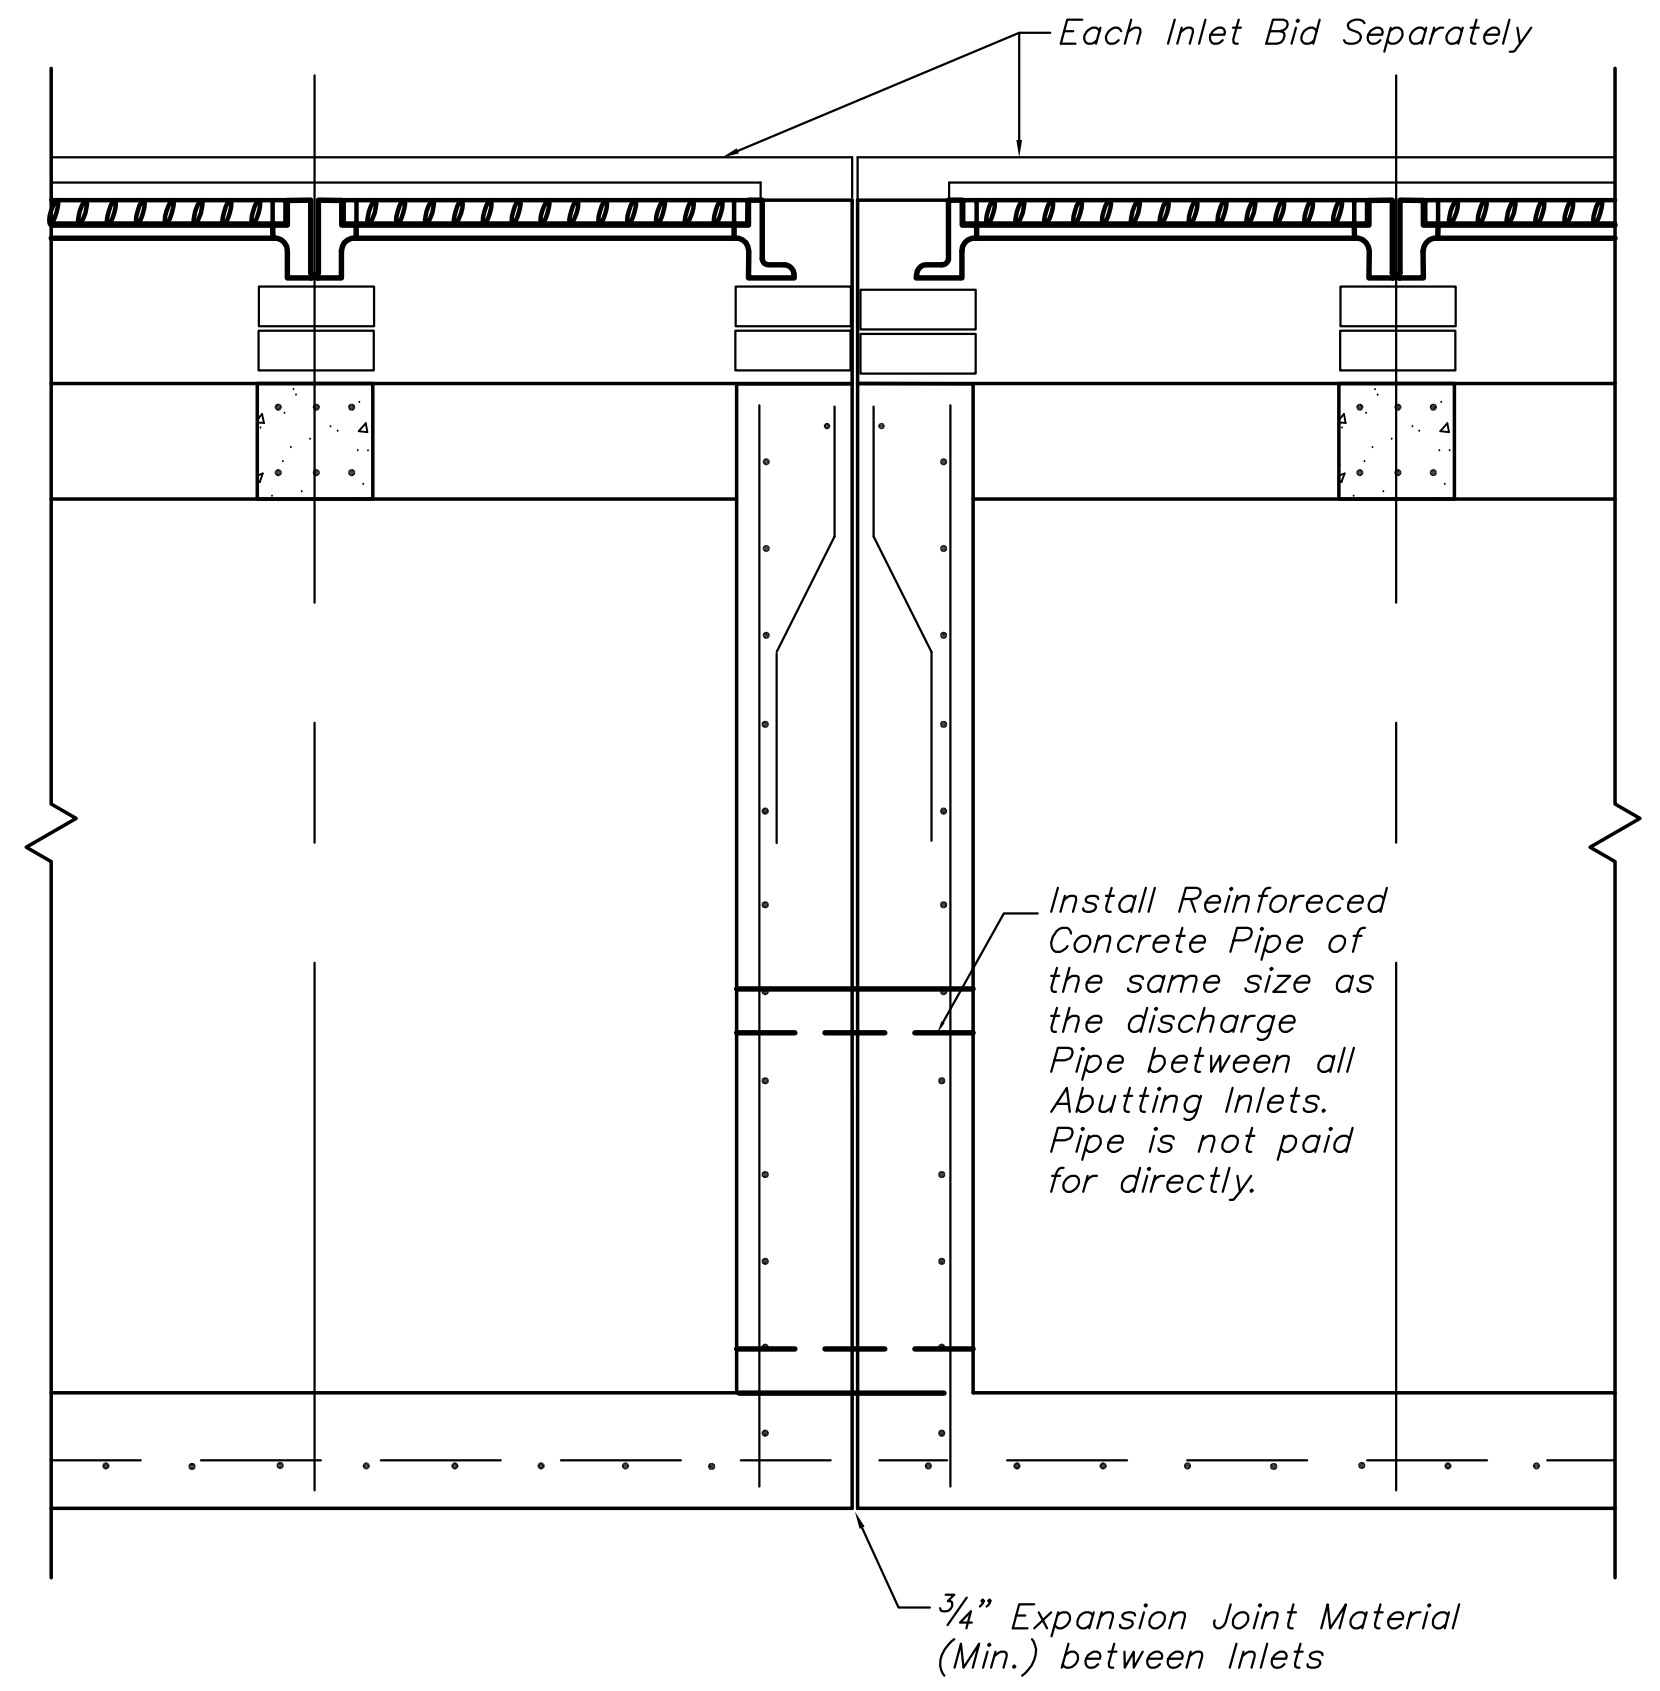


ABUTTING INLET CONNECTION DETAIL

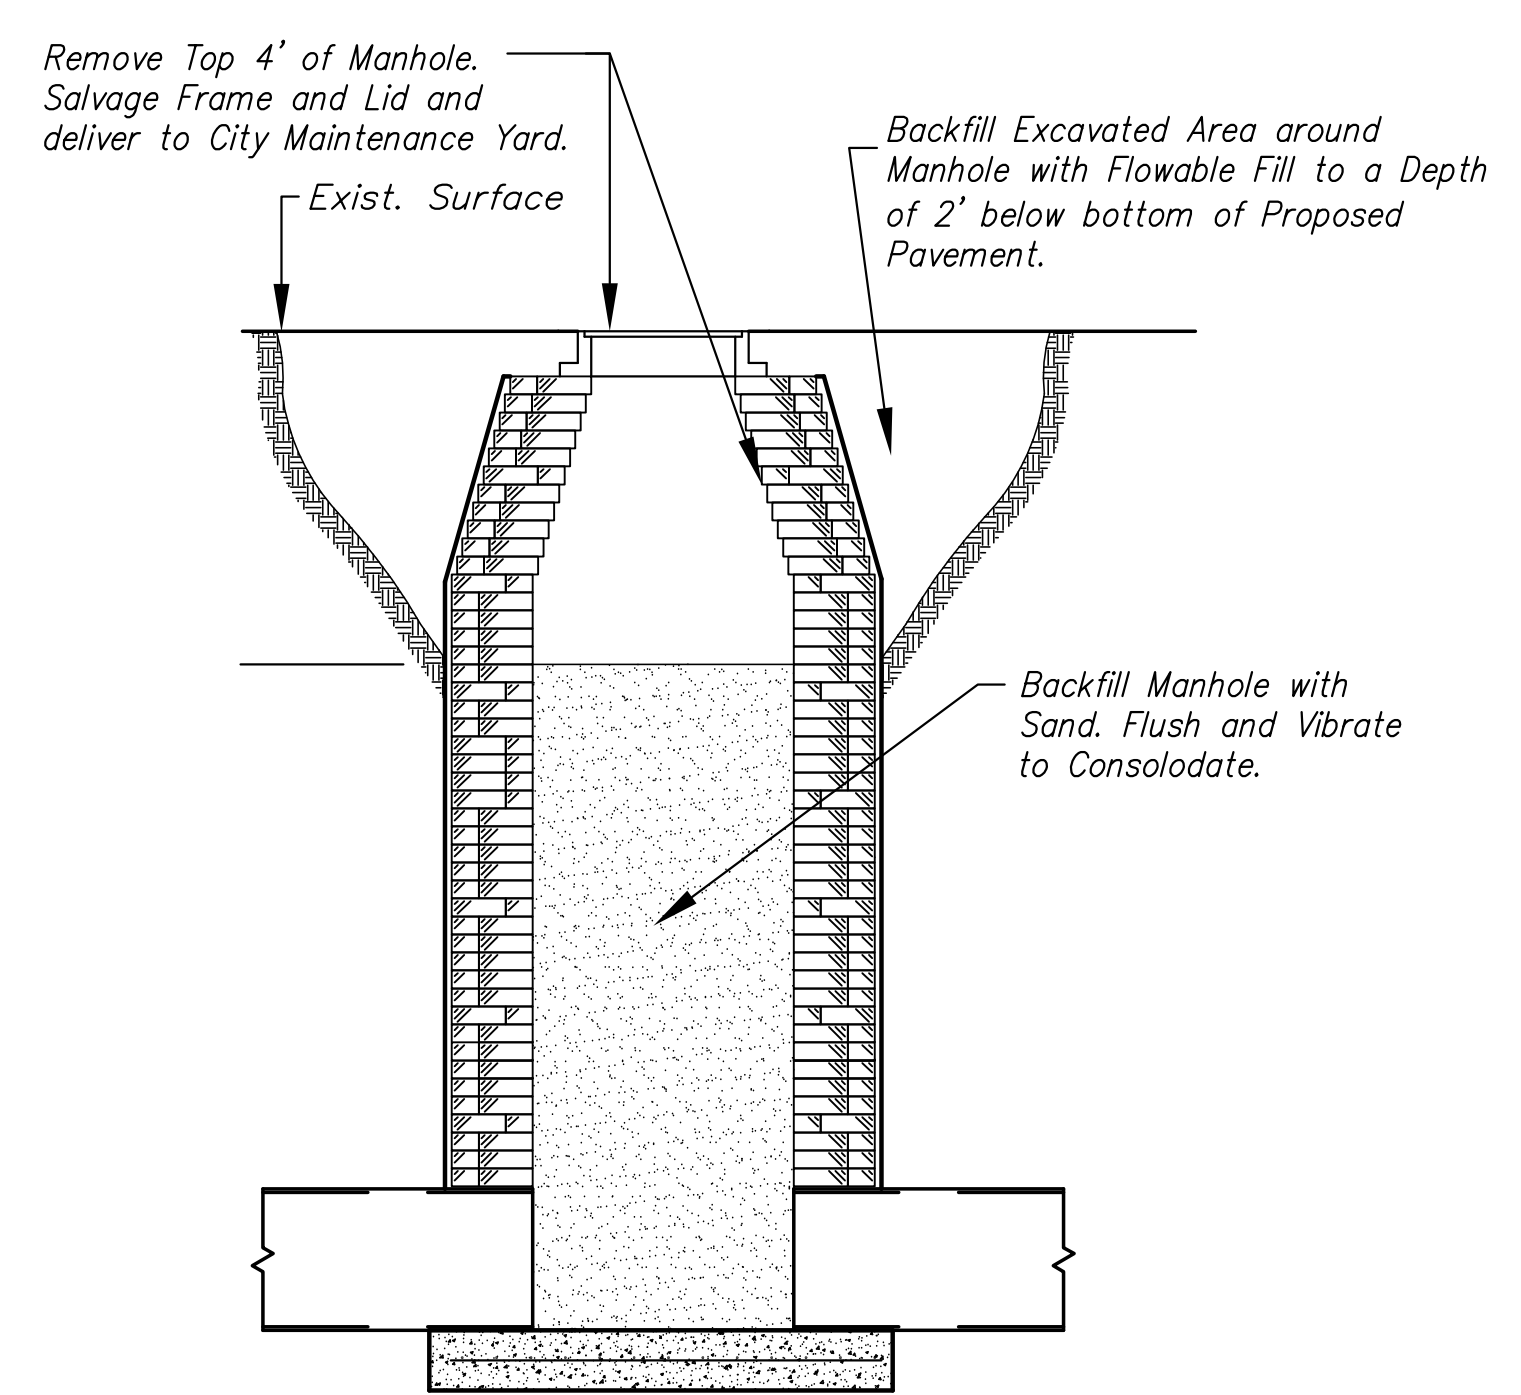


MANHOLE ABANDON DETAIL

Note: Contractor May Completely Remove Manhole At No Additional Cost To Owner.
Contractor Shall Plug Open Ends Of Pipe To Be Abandoned When Cut Or Broken During Construction Activities.

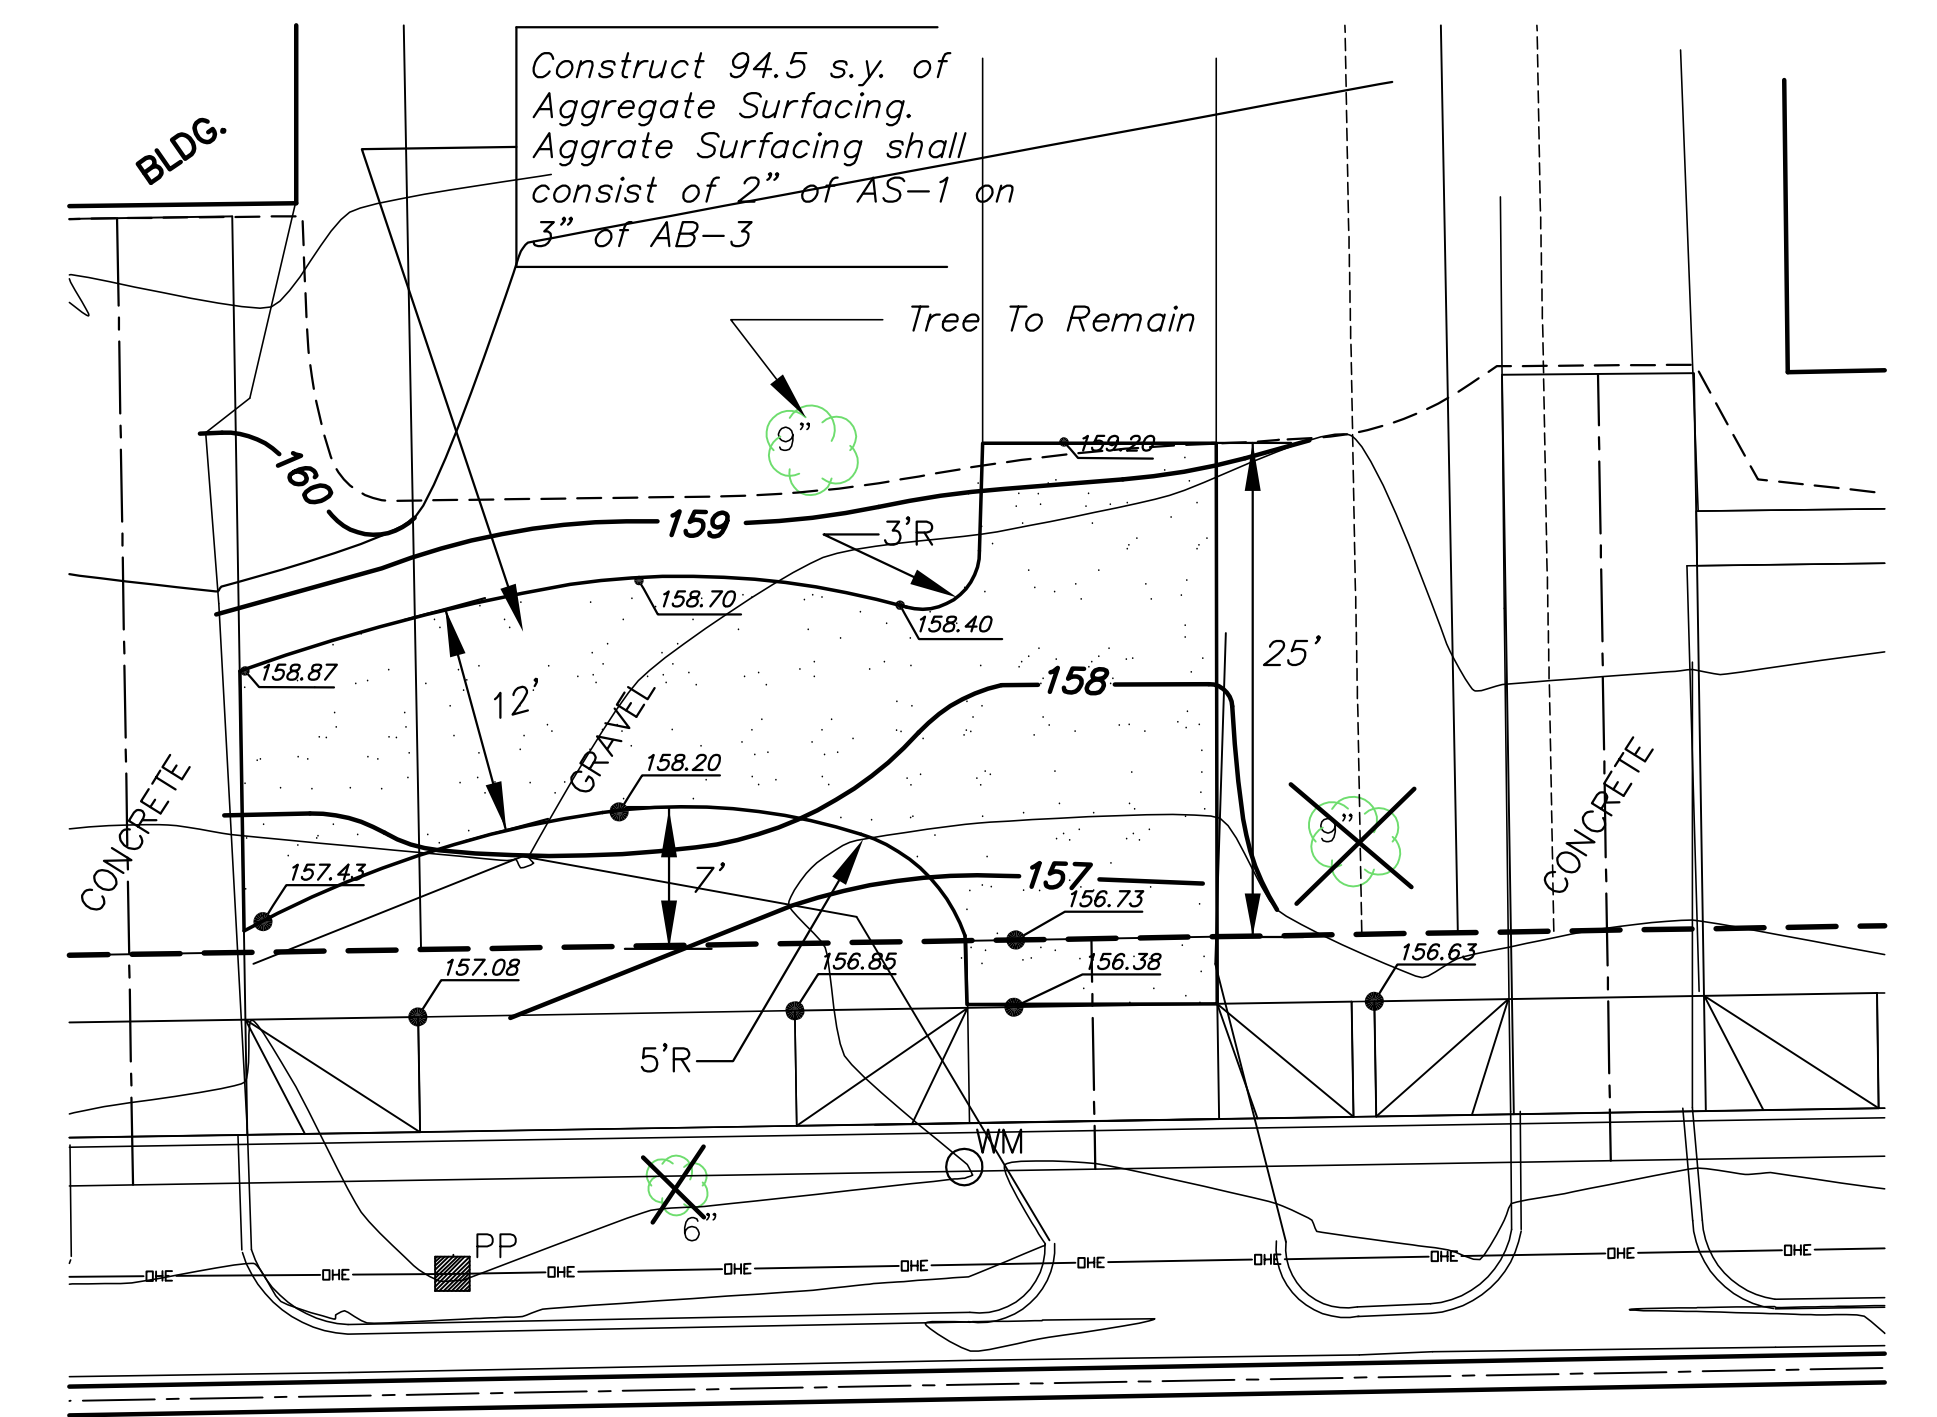

46+00

SPECIAL GRADING PLAN
SCALE 1"=10'

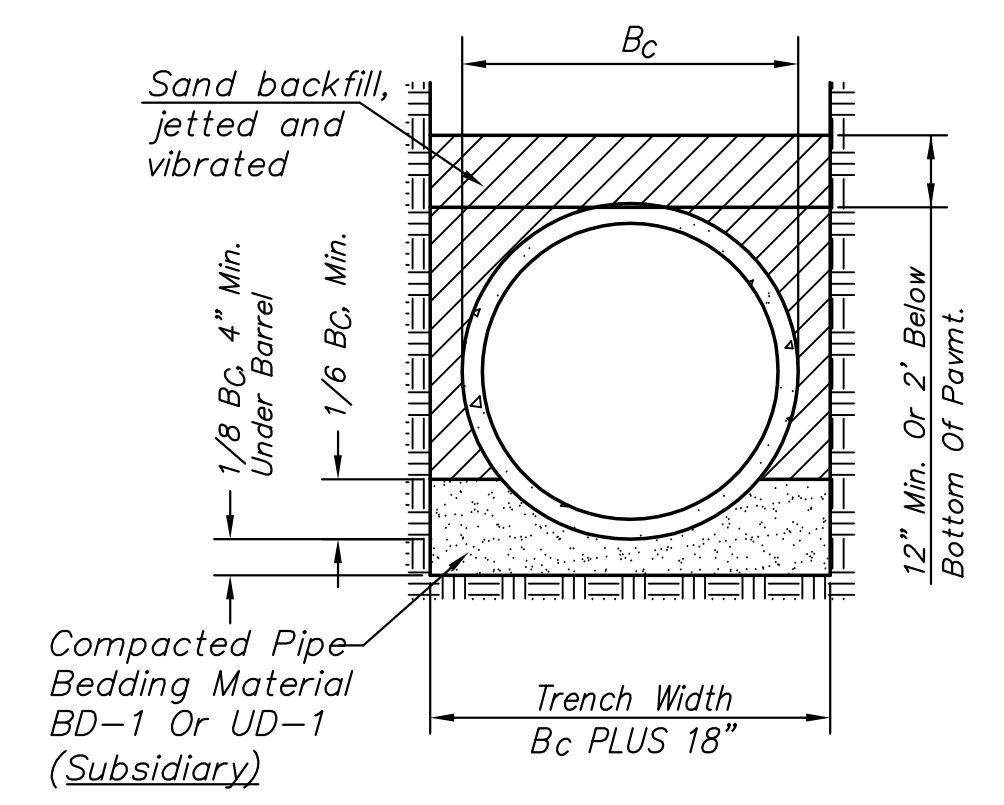

STORM SEWER TRENCH DETAIL
(Storm Sewer Pipe)

KANSAS DEPARTMENT OF TRANSPORTATION			
MICELLANEOUS DRAINAGE DETAILS			
PROJECT NO. 87 N-0357-01		SEDGWICK CO.	
MKEC ENGINEERING CONSULTANTS, INC.			
WICHITA, KANSAS			
DESIGNED BY: JRA	CHECKED BY: JRA	DATE: DEC. 05	SHEET 70 OF 185
DRAWN BY: JSM			