


FCBM  
 □ on Walk of NE Cor Bridge  
 Arkansas R. at Harry St  
 M.S.L. Etox 1294.49  
 City Datum 107.09

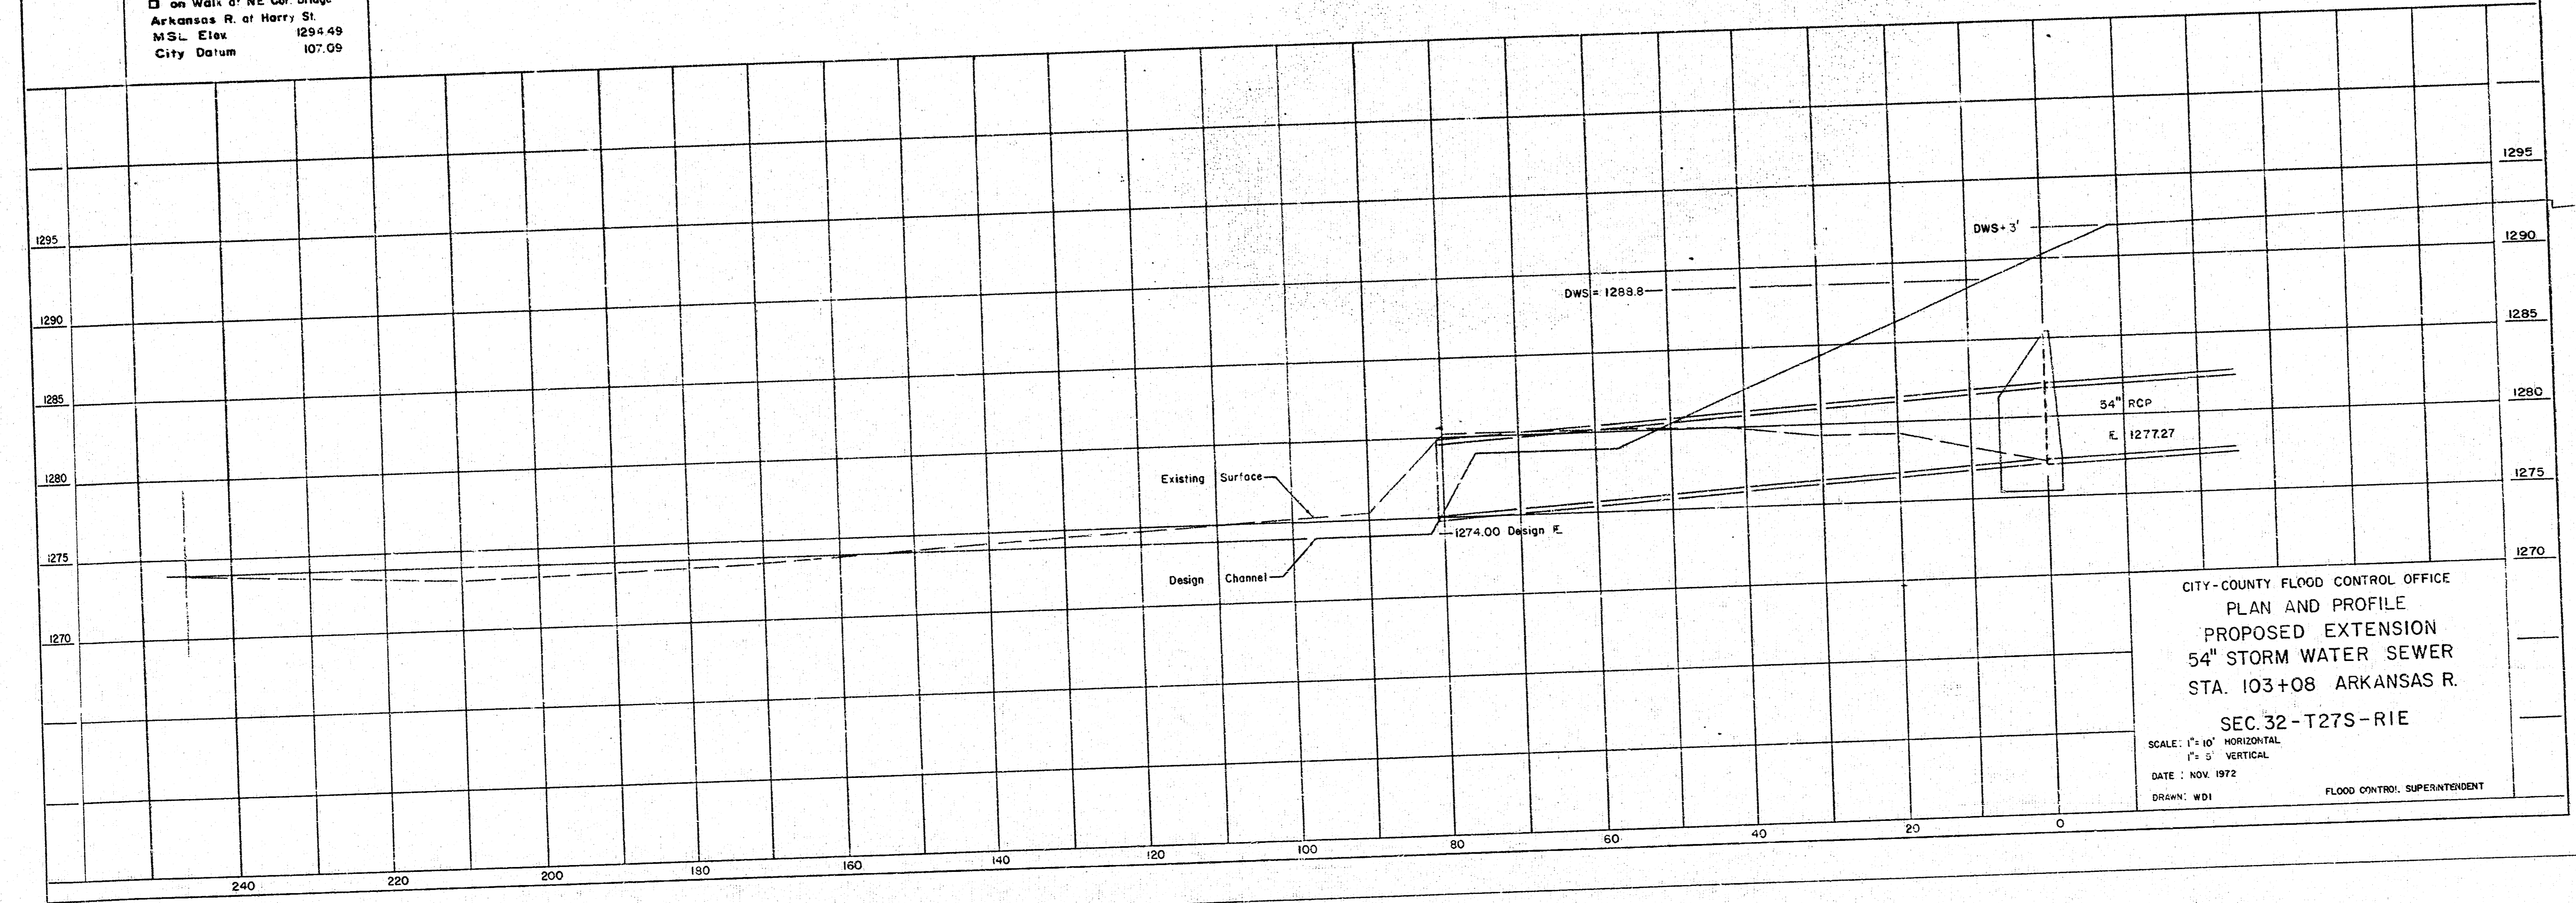

CITY-COUNTY FLOOD CONTROL OFFICE  
 PLAN AND PROFILE  
 PROPOSED EXTENSION  
 54" STORM WATER SEWER  
 STA. 103+08 ARKANSAS R.  
 SEC. 32 - T27S - R1E  
 SCALE: 1" = 10' HORIZONTAL  
 1" = 5' VERTICAL  
 DATE: NOV. 1972  
 DRAWN: WDI  
 FLOOD CONTROL SUPERINTENDENT