


FHWA REGION NO.	STATE	PROJECT NUMBER	FISCAL YEAR	SHEET NUMBER	TOTAL SHEETS
7	KANSAS				

REFERENCES NOTED	DATE
REFERENCES CHECKED	

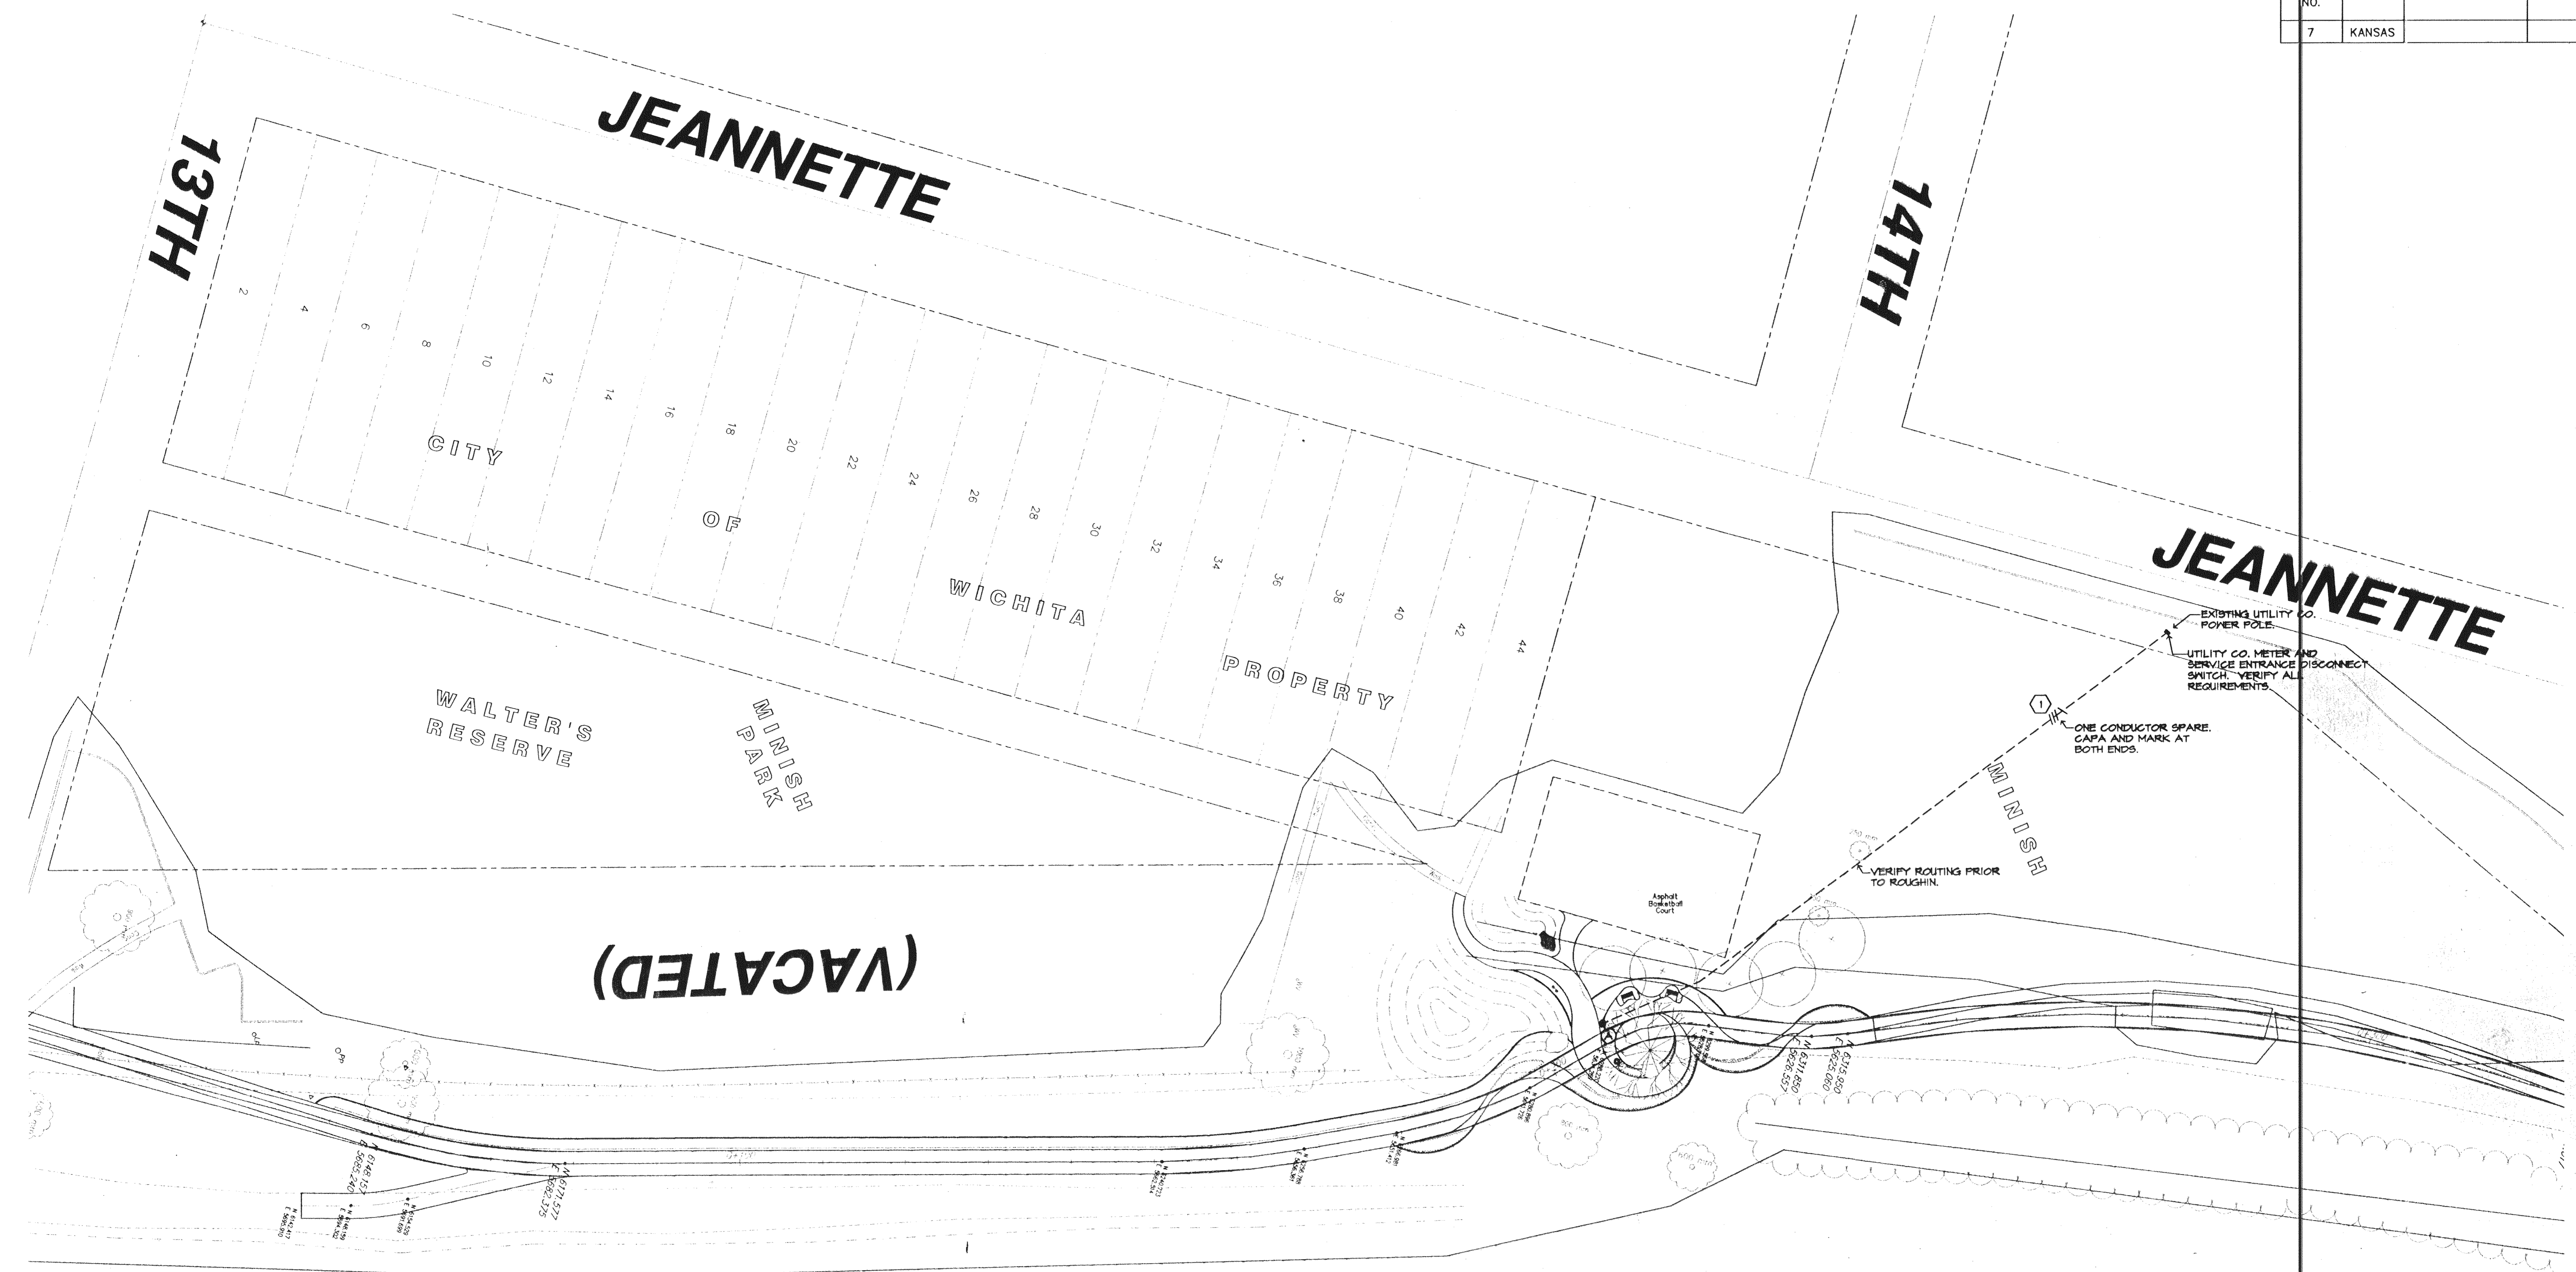


DESIGN	DRAWN	REVIEW
SIA	SIA	SIA
UTILITY	DATE	REVISION
	JUN. 20, 2003	

PROJECT NUMBER: 472-83436 (7/08831)
 DRAWING FILE: 2140E02.DWG

ELECTRICAL PLAN
LITTLE ARKANSAS RIVER
BICYCLE / PEDESTRIAN PATH



Stefan, Hergert & Associates, Inc.
 Electrical Engineering and Design
 349 S. Highland
 Wichita, KS 67211-1604
 (316) 264-3044
 FAX: (316) 264-3342

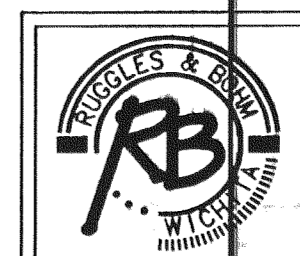

Ruggles & Bohm, P.A.
 Engineering, Surveying, Land Planning
 924 North Main
 Wichita, Kansas 67203
 www.rbkansas.com
 (316) 264-8008
 (316) 264-4821 fax
 E-mail: info@rbkansas.com

RB JOB: 2088T
 SHEET: 02
 OF: 03