



FHWA REGION NO.	STATE	PROJECT NUMBER	FISCAL YEAR	SHEET NUMBER	TOTAL SHEETS
7	KANSAS				

REFERENCES NOTED	BY	DATE
REFERENCES CHECKED		

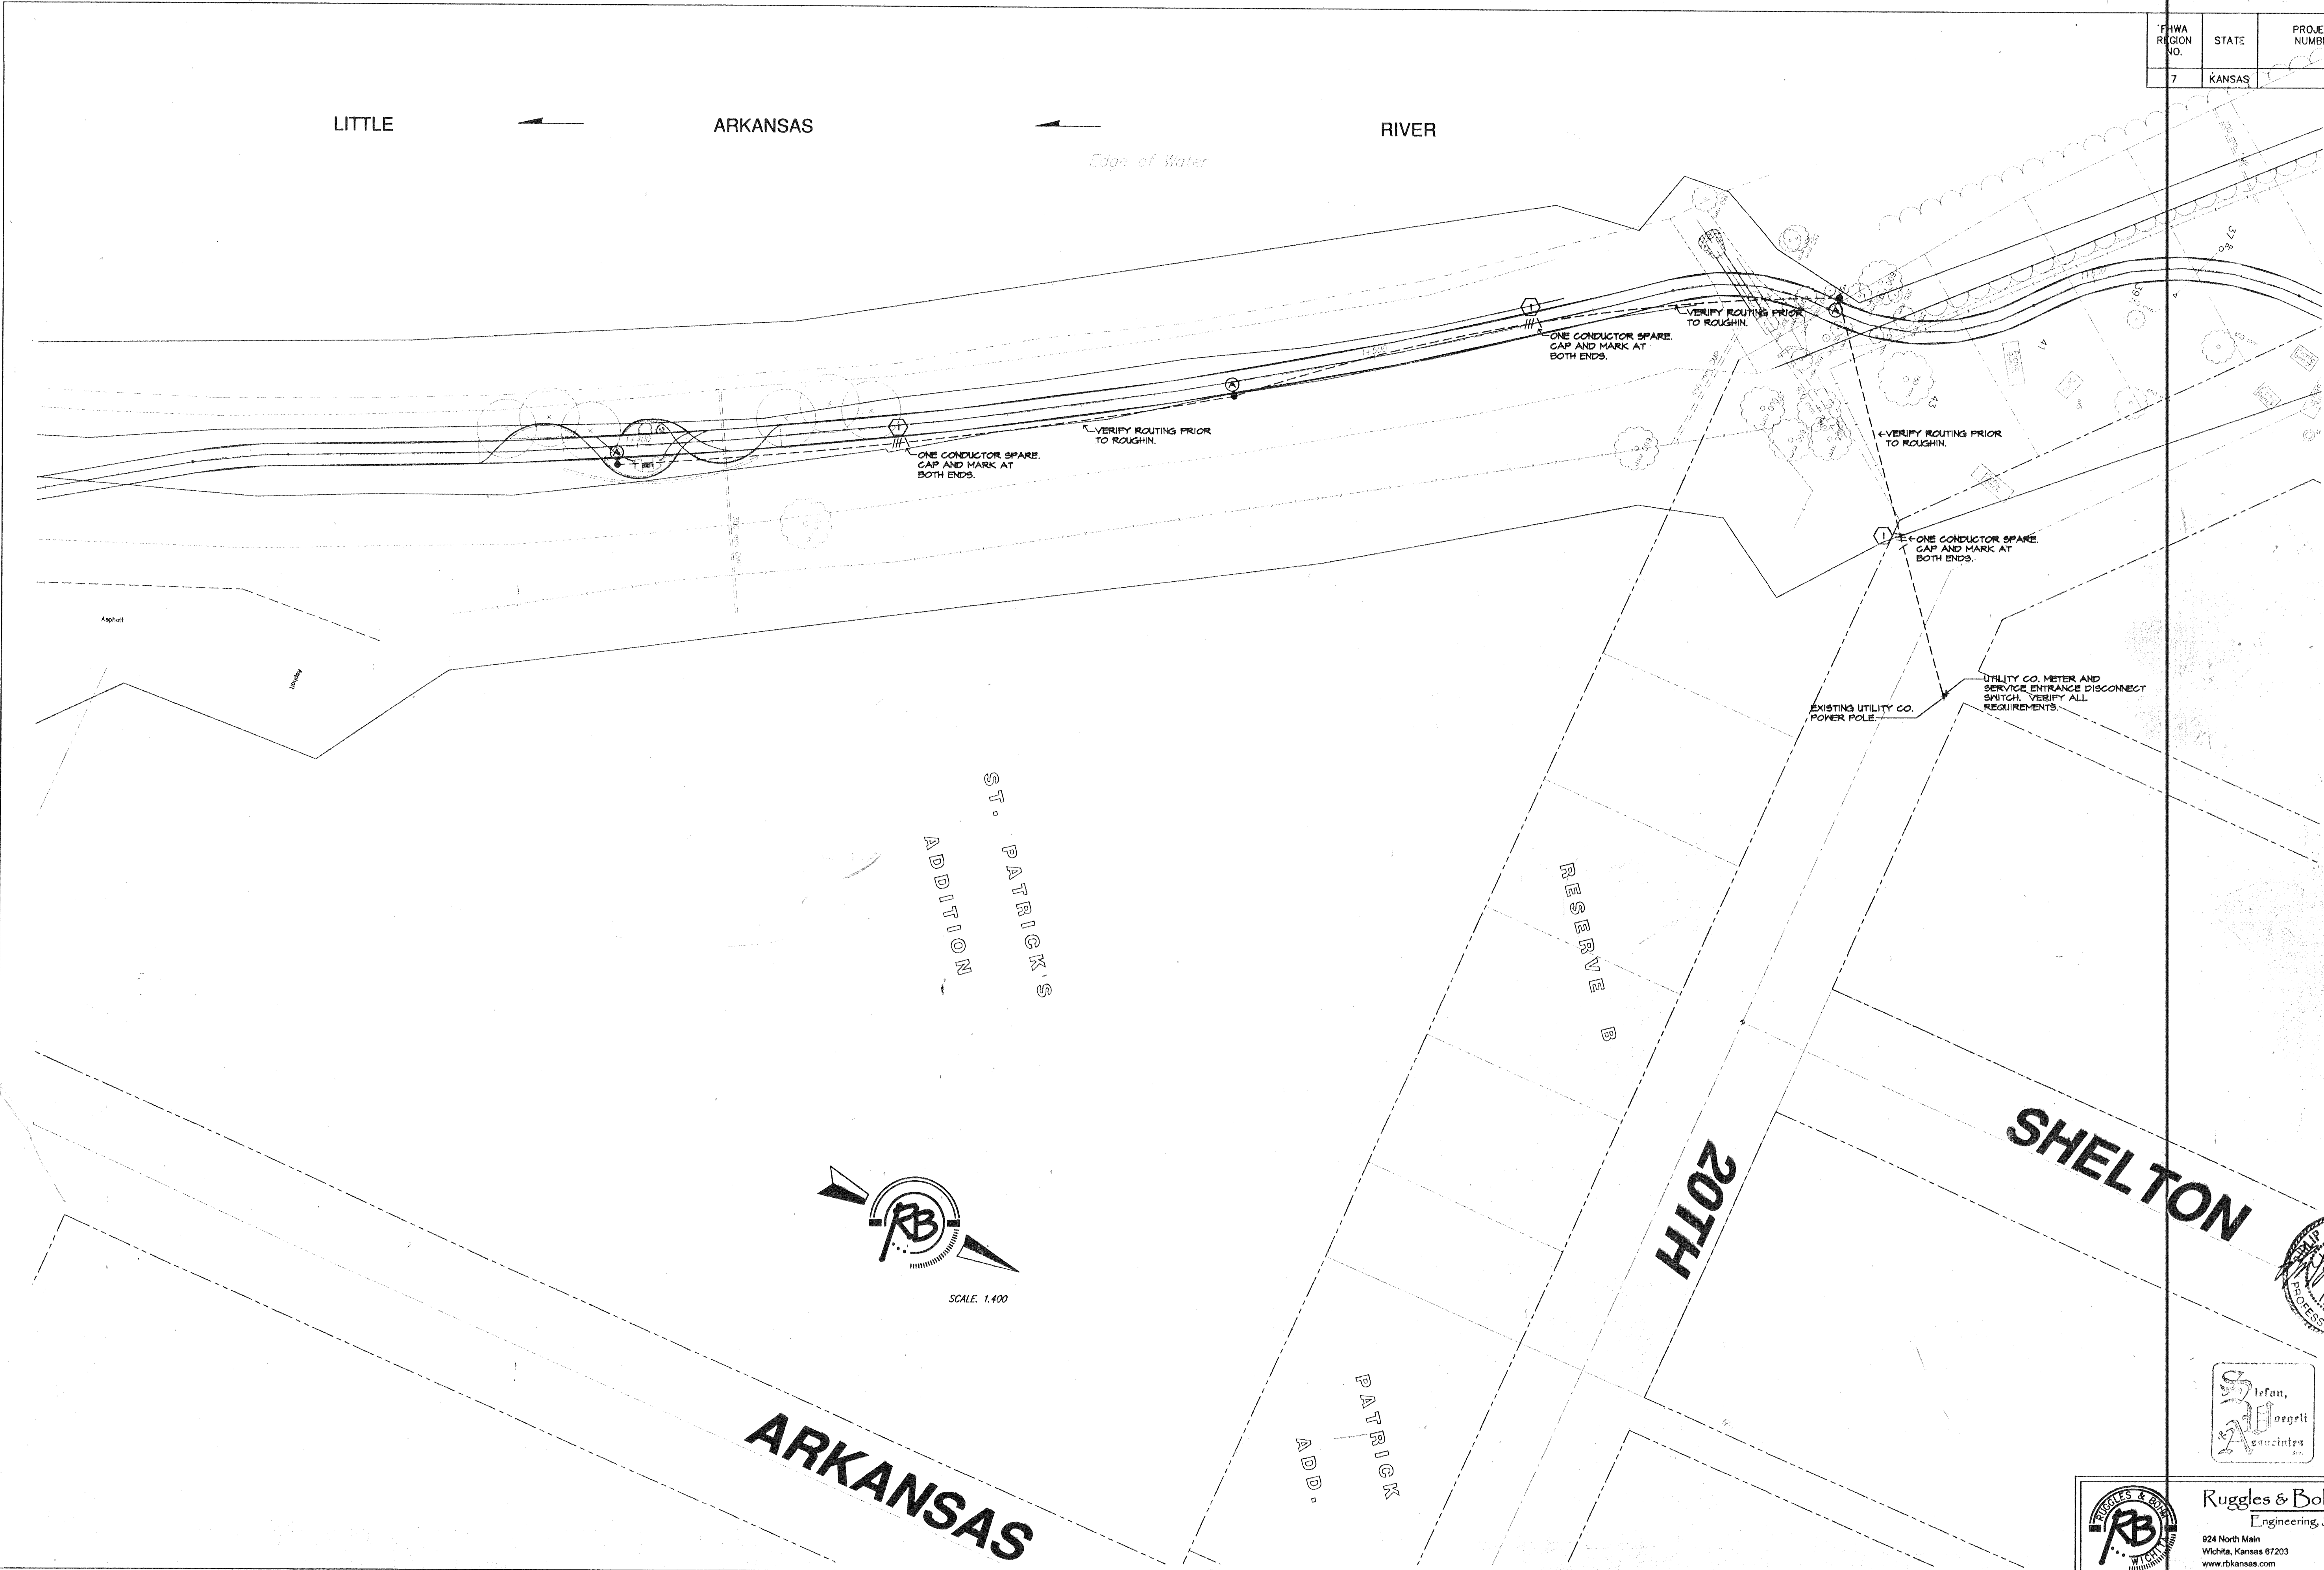

ELECTRICAL PLAN			
LITTLE ARKANSAS RIVER			
BICYCLE / PEDESTRIAN PATH			
PROJECT NUMBER	DESIGN	DRAWN	REVIEW
472-83436 (706531)	S/A	S/A	S/A
DRAWING FILE	UTILITY	DATE	REVISED
214003.DWG		JAN. 20, 2003	

ELECTRICAL PLAN
LITTLE ARKANSAS RIVER
BICYCLE / PEDESTRIAN PATH

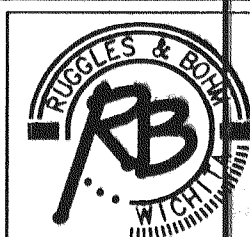

Ruggles & Bohm, P.A.
Engineering, Surveying, Land Planning
924 North Main
Wichita, Kansas 67203
www.rbkansas.com
(316) 264-8008
(316) 264-4621 fax
E-mail: info@rbkansas.com

RB JOB
2088T
SHEET
63
OF
63
02140-041