

CONSTRUCTION PLANS FOR WATER DISTRIBUTION SYSTEM IMPROVEMENTS

TO SERVE

SERENDIPITY ESTATES ADDITION THE CITY OF ANDOVER, KANSAS BUTLER COUNTY, KANSAS

APPROVED AS NOTED
BY CITY ENGINEER OF WICHITA,
BY WICHITA WATER & SEWER DEPARTMENT,
& BY WICHITA FIRE DEPARTMENT

Water Mains (Pub Wks) _____

Water Mains (W & S) _____


NOTE TO CONTRACTORS

Public Property

Inspection and testing for the waterline is to be provided by a Licensed Consulting Engineering Firm under contact with the Owner/Developer. Said inspection to be in accordance with the City of Wichita standard construction engineering practices and certified by a Professional Engineer Licensed in the state of Kansas. No work shall be performed in dedicated easements or public right-of-way by the Contractor without such inspection nor shall any work be commenced without written authorization by the City Engineer. All Construction and Materials shall comply with the City of Wichita Specifications and Standards (on file and available in the City Engineer's Office).


Private Property

Installation and testing for the fire protection line is to be performed by a City of Wichita licensed fire protection contractor in accordance with the fire codes as adopted by the City of Wichita. All materials and construction practices for the fire protection line shall comply with the fire codes as adopted by the City of Wichita (available from the City of Wichita Fire Department). The Contractor shall not commence work without notification and approval of the Wichita Fire Department. Inspection of the fire protection line is to be provided by a licensed Engineering Firm under contract with the Owner/Developer and the Fire Department. The Contractor shall not start work until the project inspector is assigned to the project and present on the site. Any work done without inspection will be required to be uncovered for inspection.

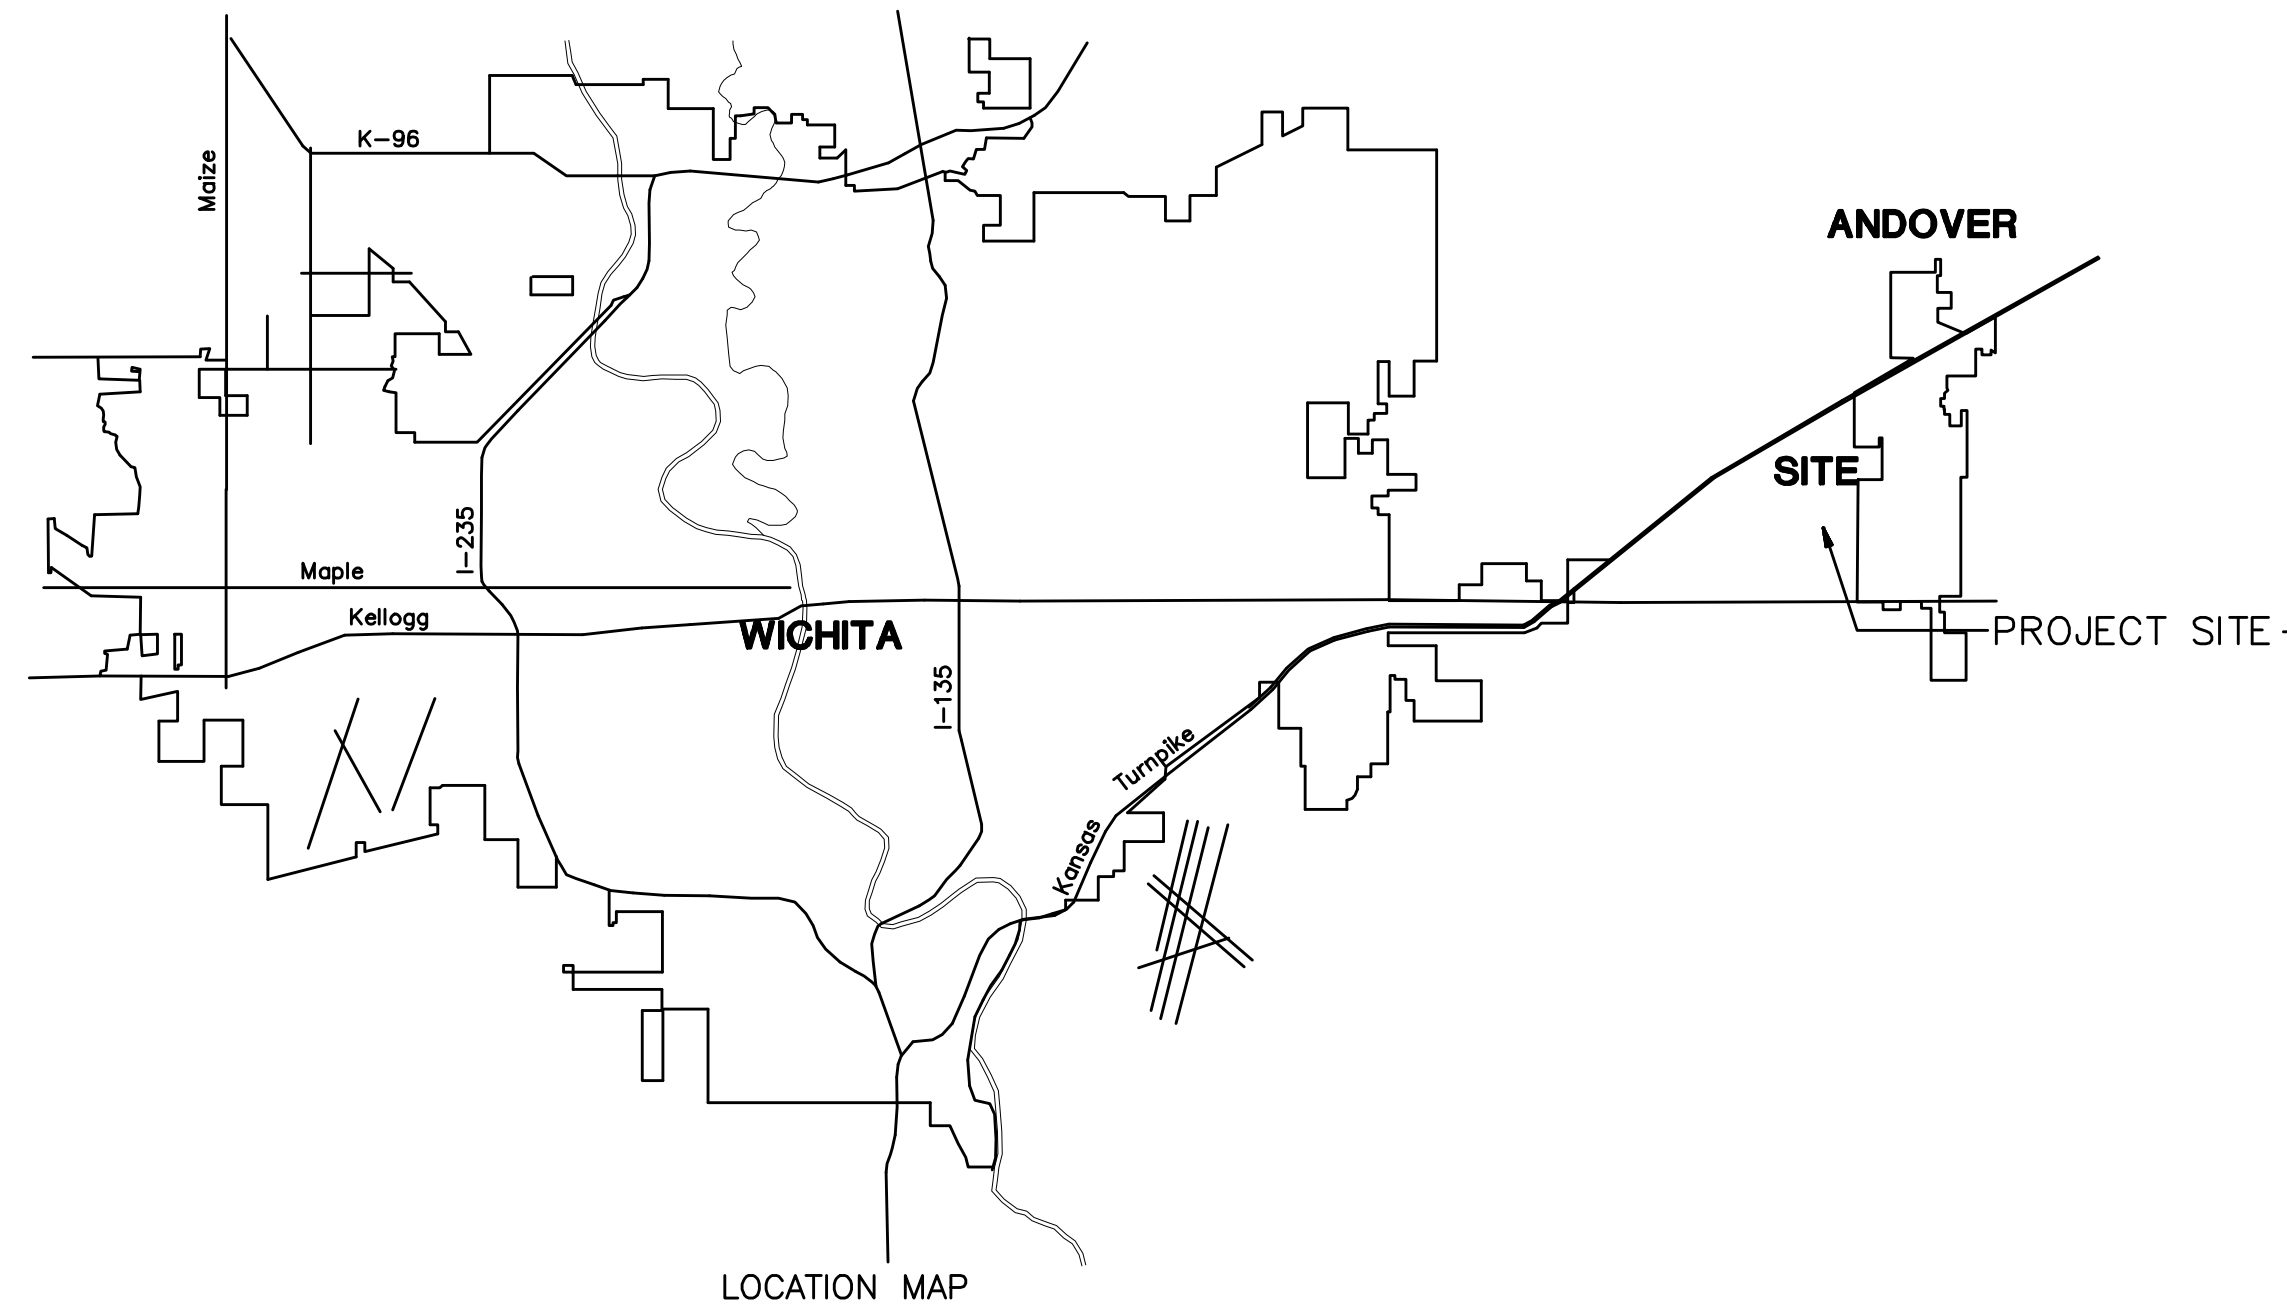

INDEX OF SHEETS


SHEET NO. 1	TITLE SHEET
SHEET NO. 2	KEY MAP
SHEET NO. 3	STANDARD DETAILS
SHEET NO. 4	PLAN PROFILE
SHEET NO. 5-9	EROSION CONTROL DETAILS
SHEET NO. 10-13	TRAFFIC CONTROL DETAILS
SHEET NO. 14	COORDINATE POINTS LIST
SHEET NO. 15	PLAT

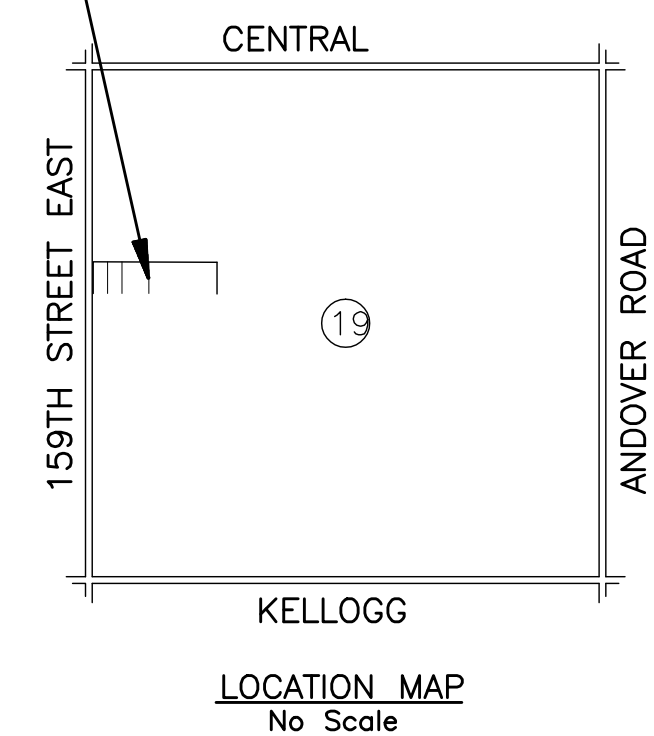

INDEX CODE 607853
CITY OF WICHITA PROJECT NO. 1358-PPW
NOVEMBER 2007
PLANS PREPARED BY



POE & ASSOCIATES, INC.
CONSULTING ENGINEERS
5940 E. Central, Suite 200 • Wichita, KS 67206-4242
Phone 316/685-4114 • FAX 316/685-4444

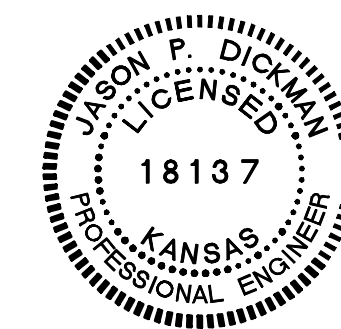

RECORD DRAWING
Contractor: Mies Construction
Inspector: J. Dunn
.pdf by: POE & ASSOCIATES, INC. 5-8-09