


GRADING AND DRAINAGE PLANS
SUMMIT CROSSING
WICHITA, KANSAS

GRADING PLANS
SHEET TITLE
08542
PROJECT NUMBER



MKEC
DESIGN BY
RKO
DRAWN BY
GJA
CHECKED BY

ISSUED
March 2010
REVISED

SHEET NO.
3 of 15

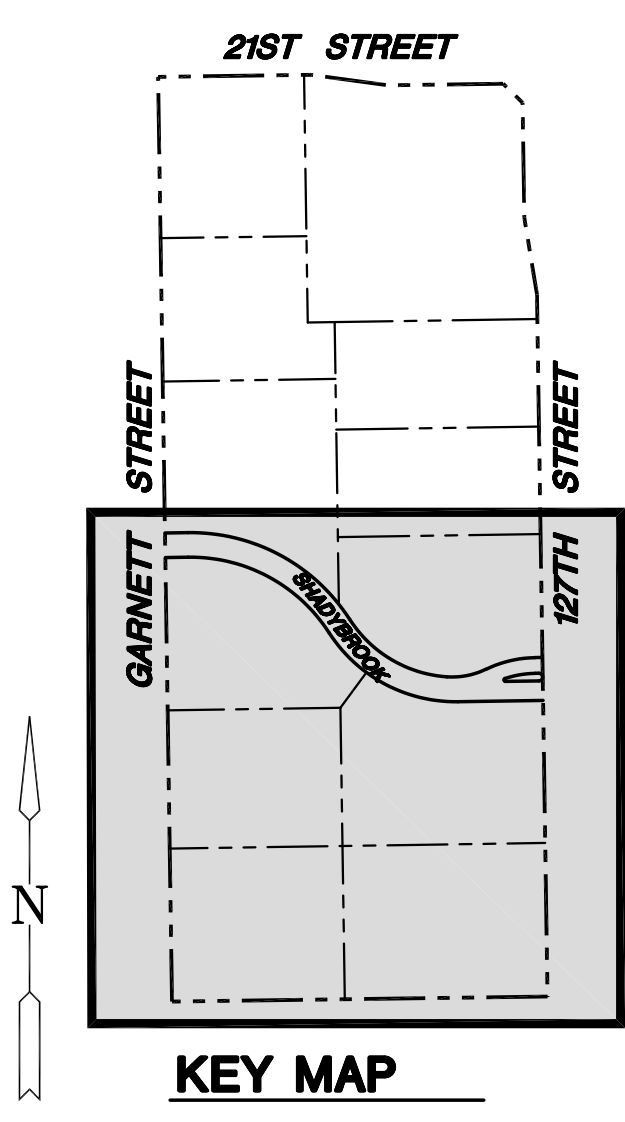

- LEGEND**
- 1373 — - EXISTING CONTOUR
 - 1375 — - PROPOSED CONTOUR
 - - - - - LIMITS OF GRADING
 - +1371.5 - SPOT ELEVATION
 - OHE — - OVERHEAD ELECTRIC
 - UGE — - UNDERGROUND ELECTRIC
 - UGT — - UNDERGROUND TELEPHONE
 - G — - GAS LINE
 - W — - WATER LINE
 - - - - - SANITARY SEWER

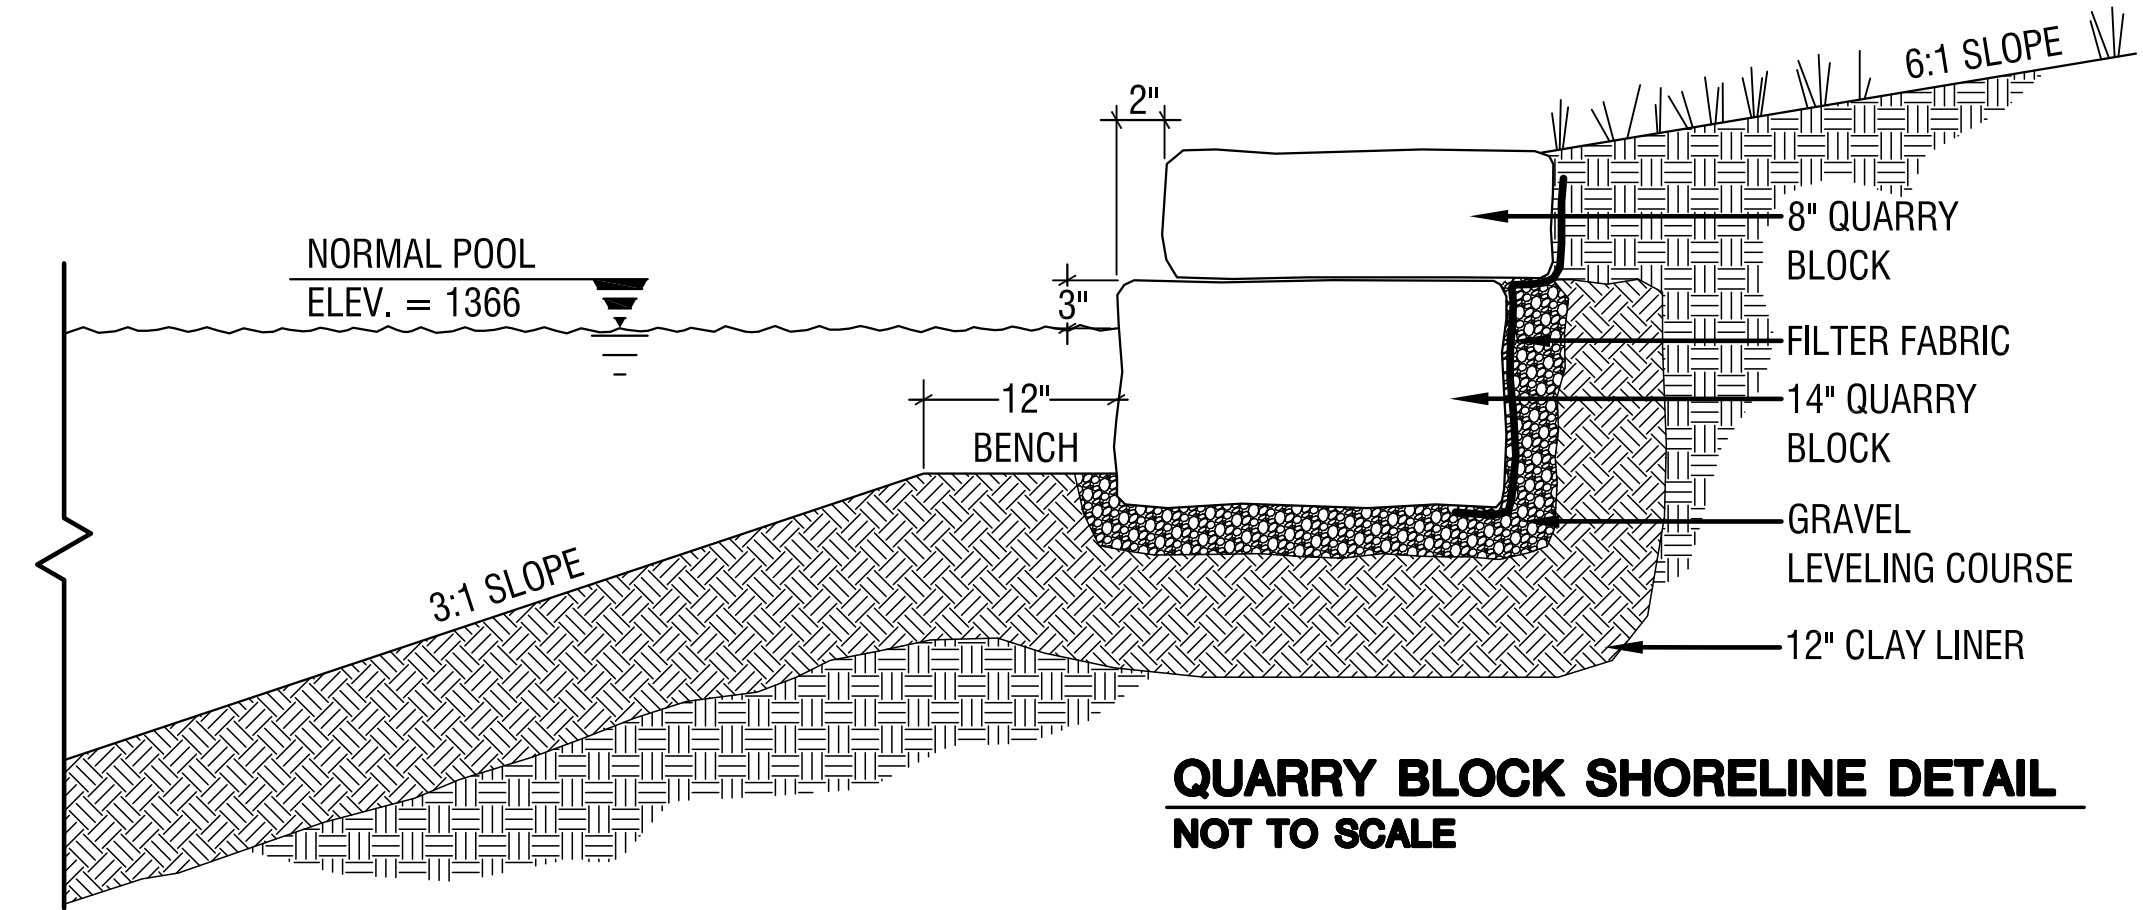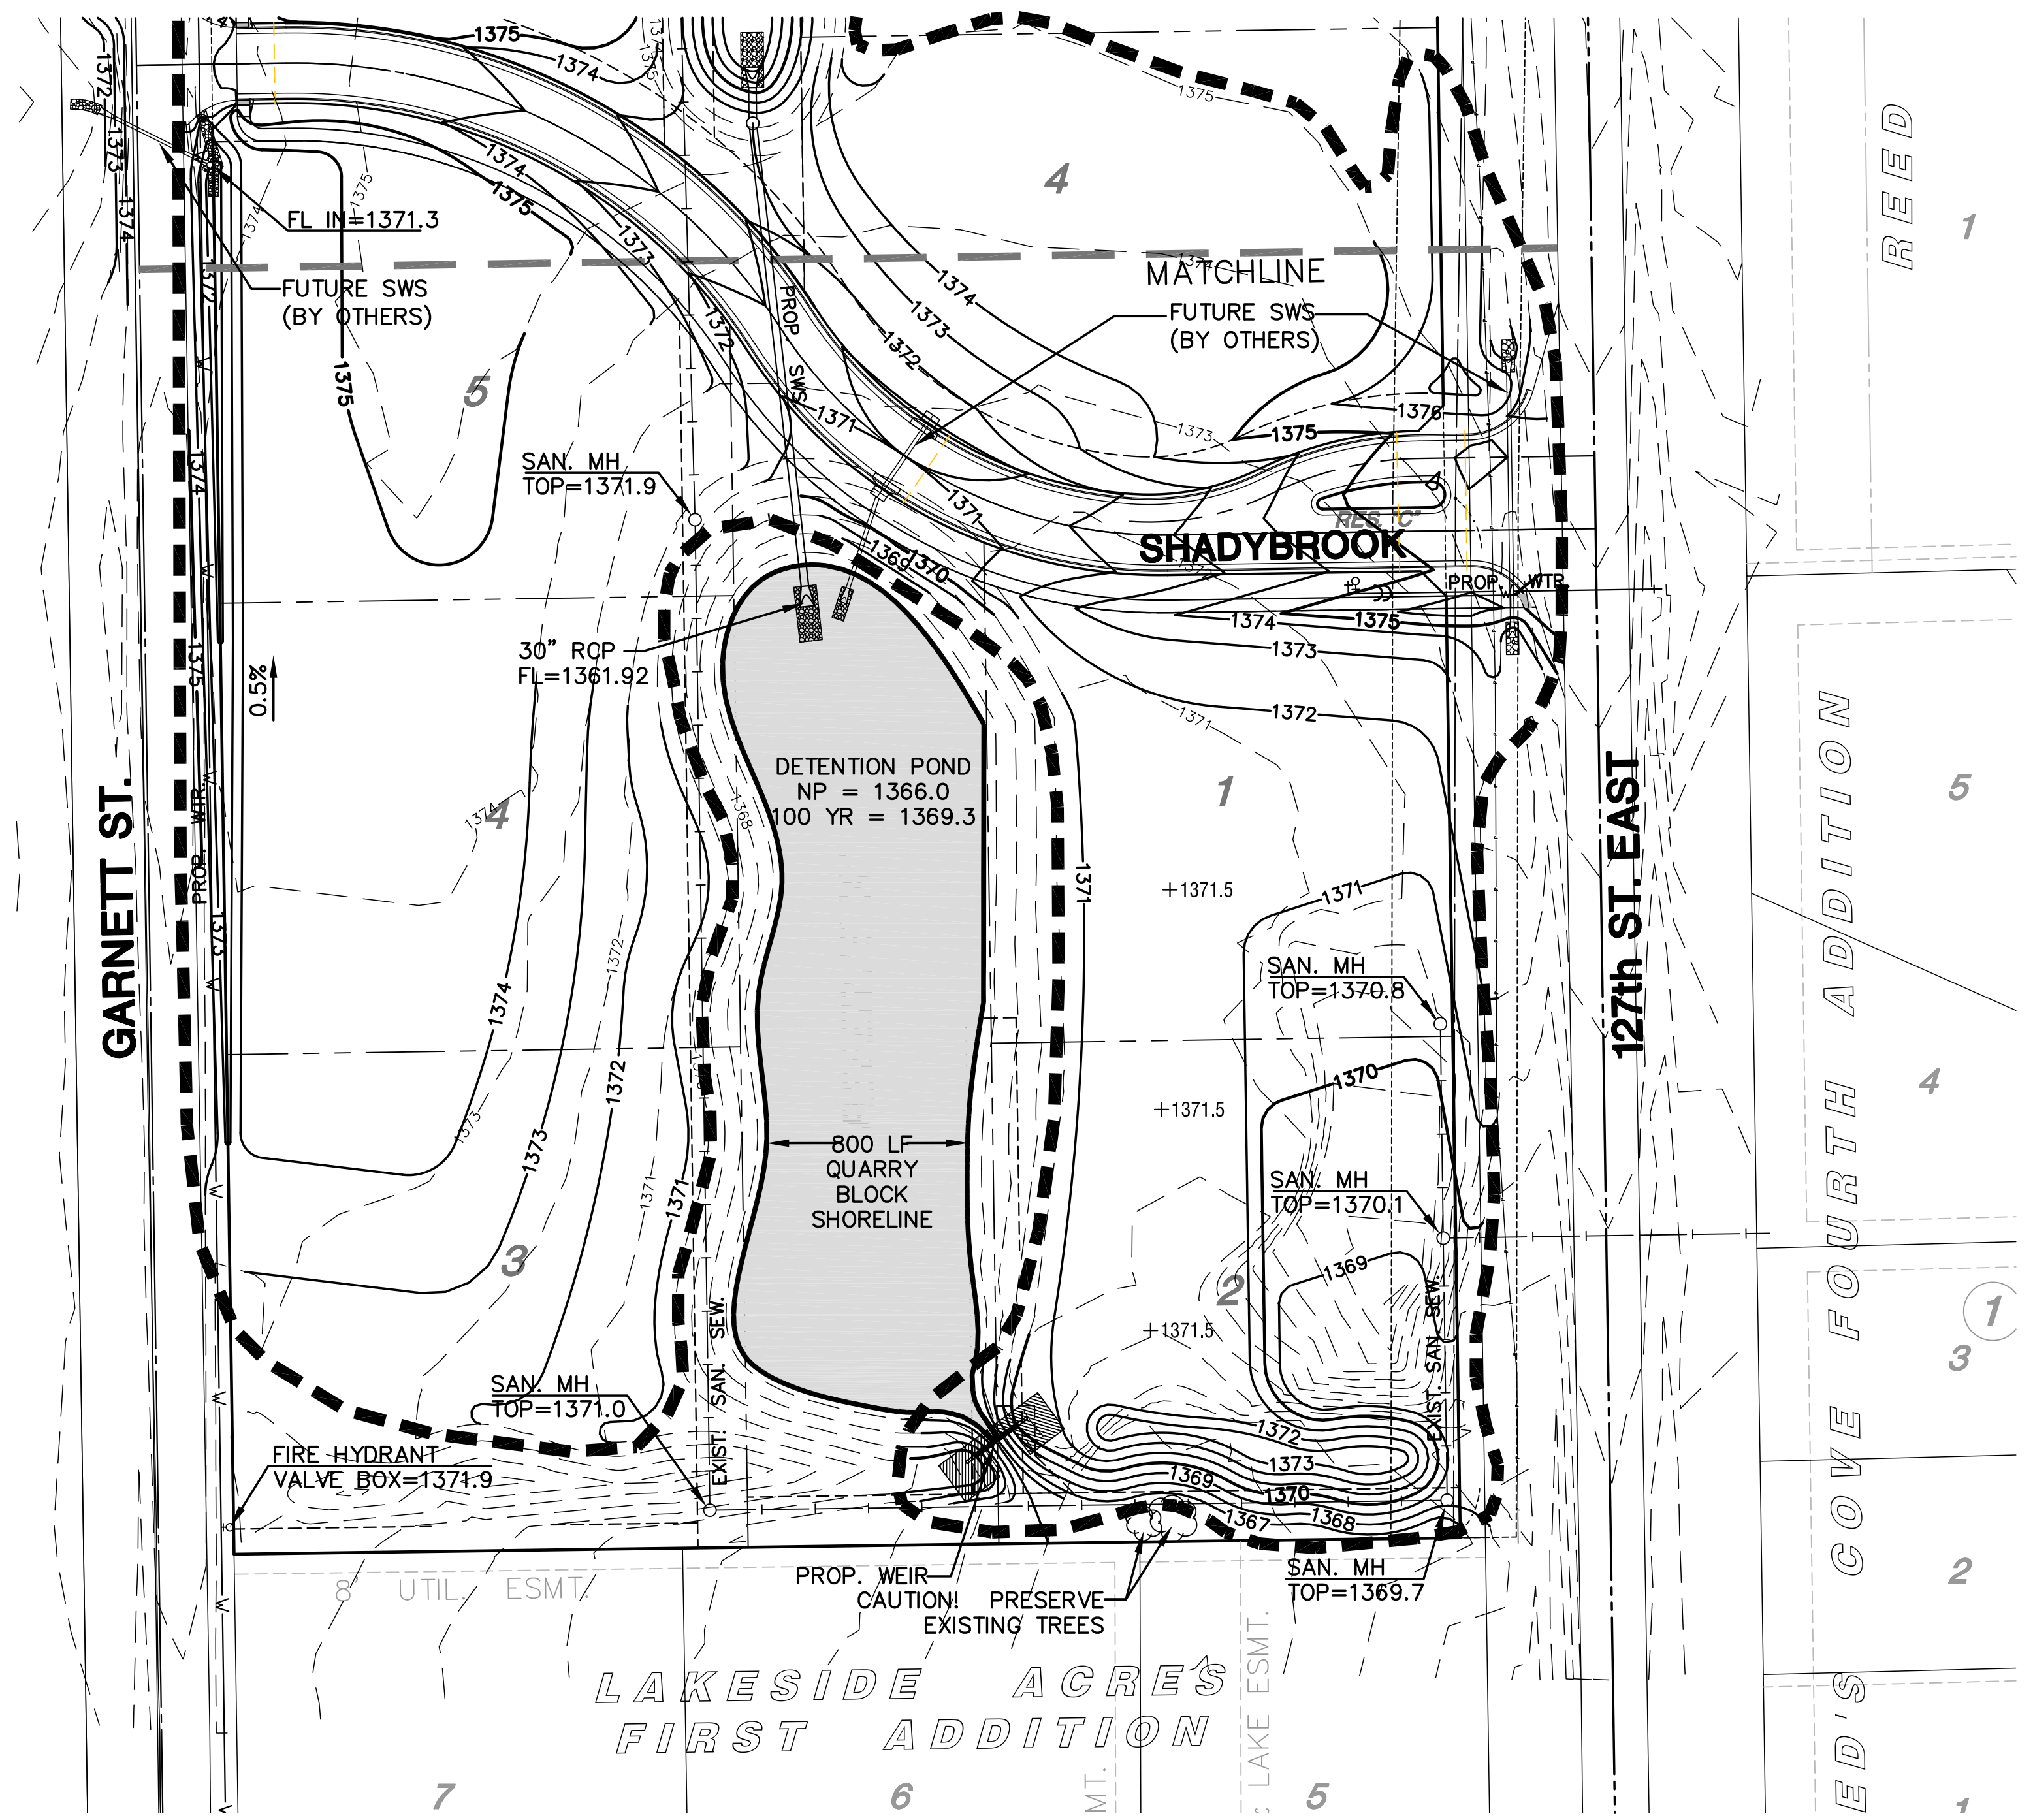

GRADING PLAN
SCALE: 1" = 50'-0"

