



ARKAN

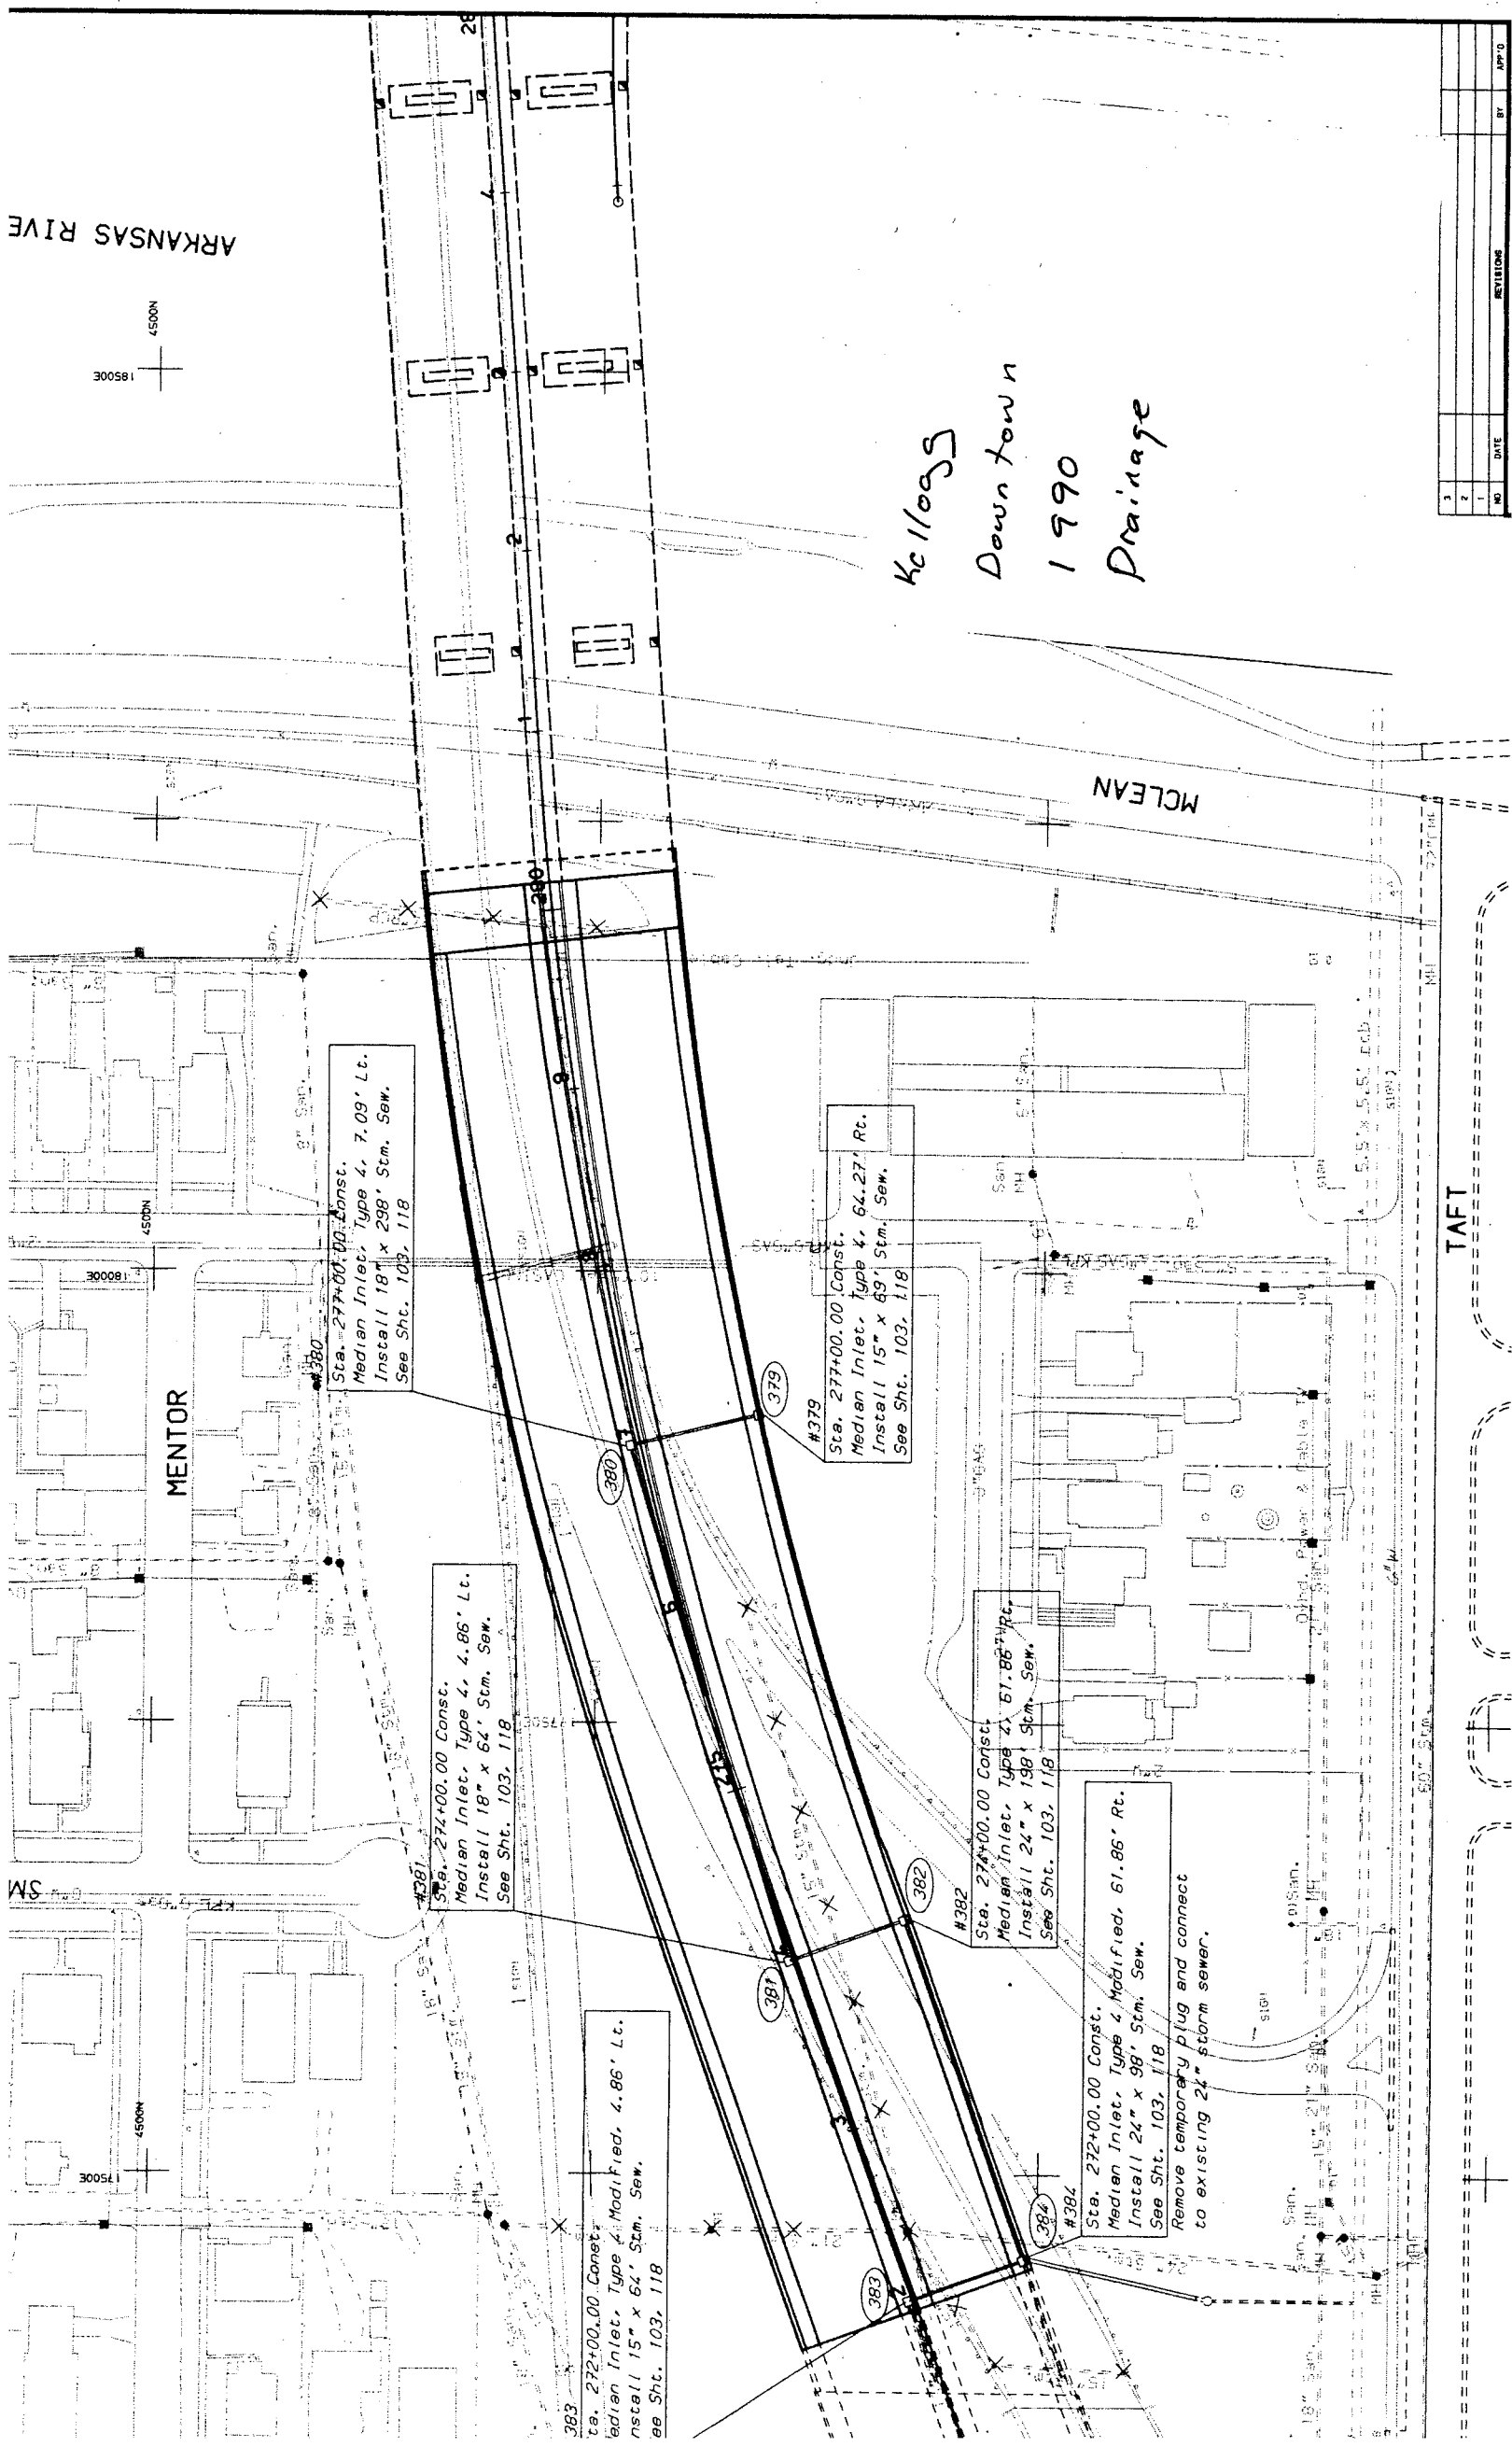

Sheet No.	Scale	Project No.	Year	Sheet
1	AS SHOWN	193082	760	

ARKANSAS RIVER

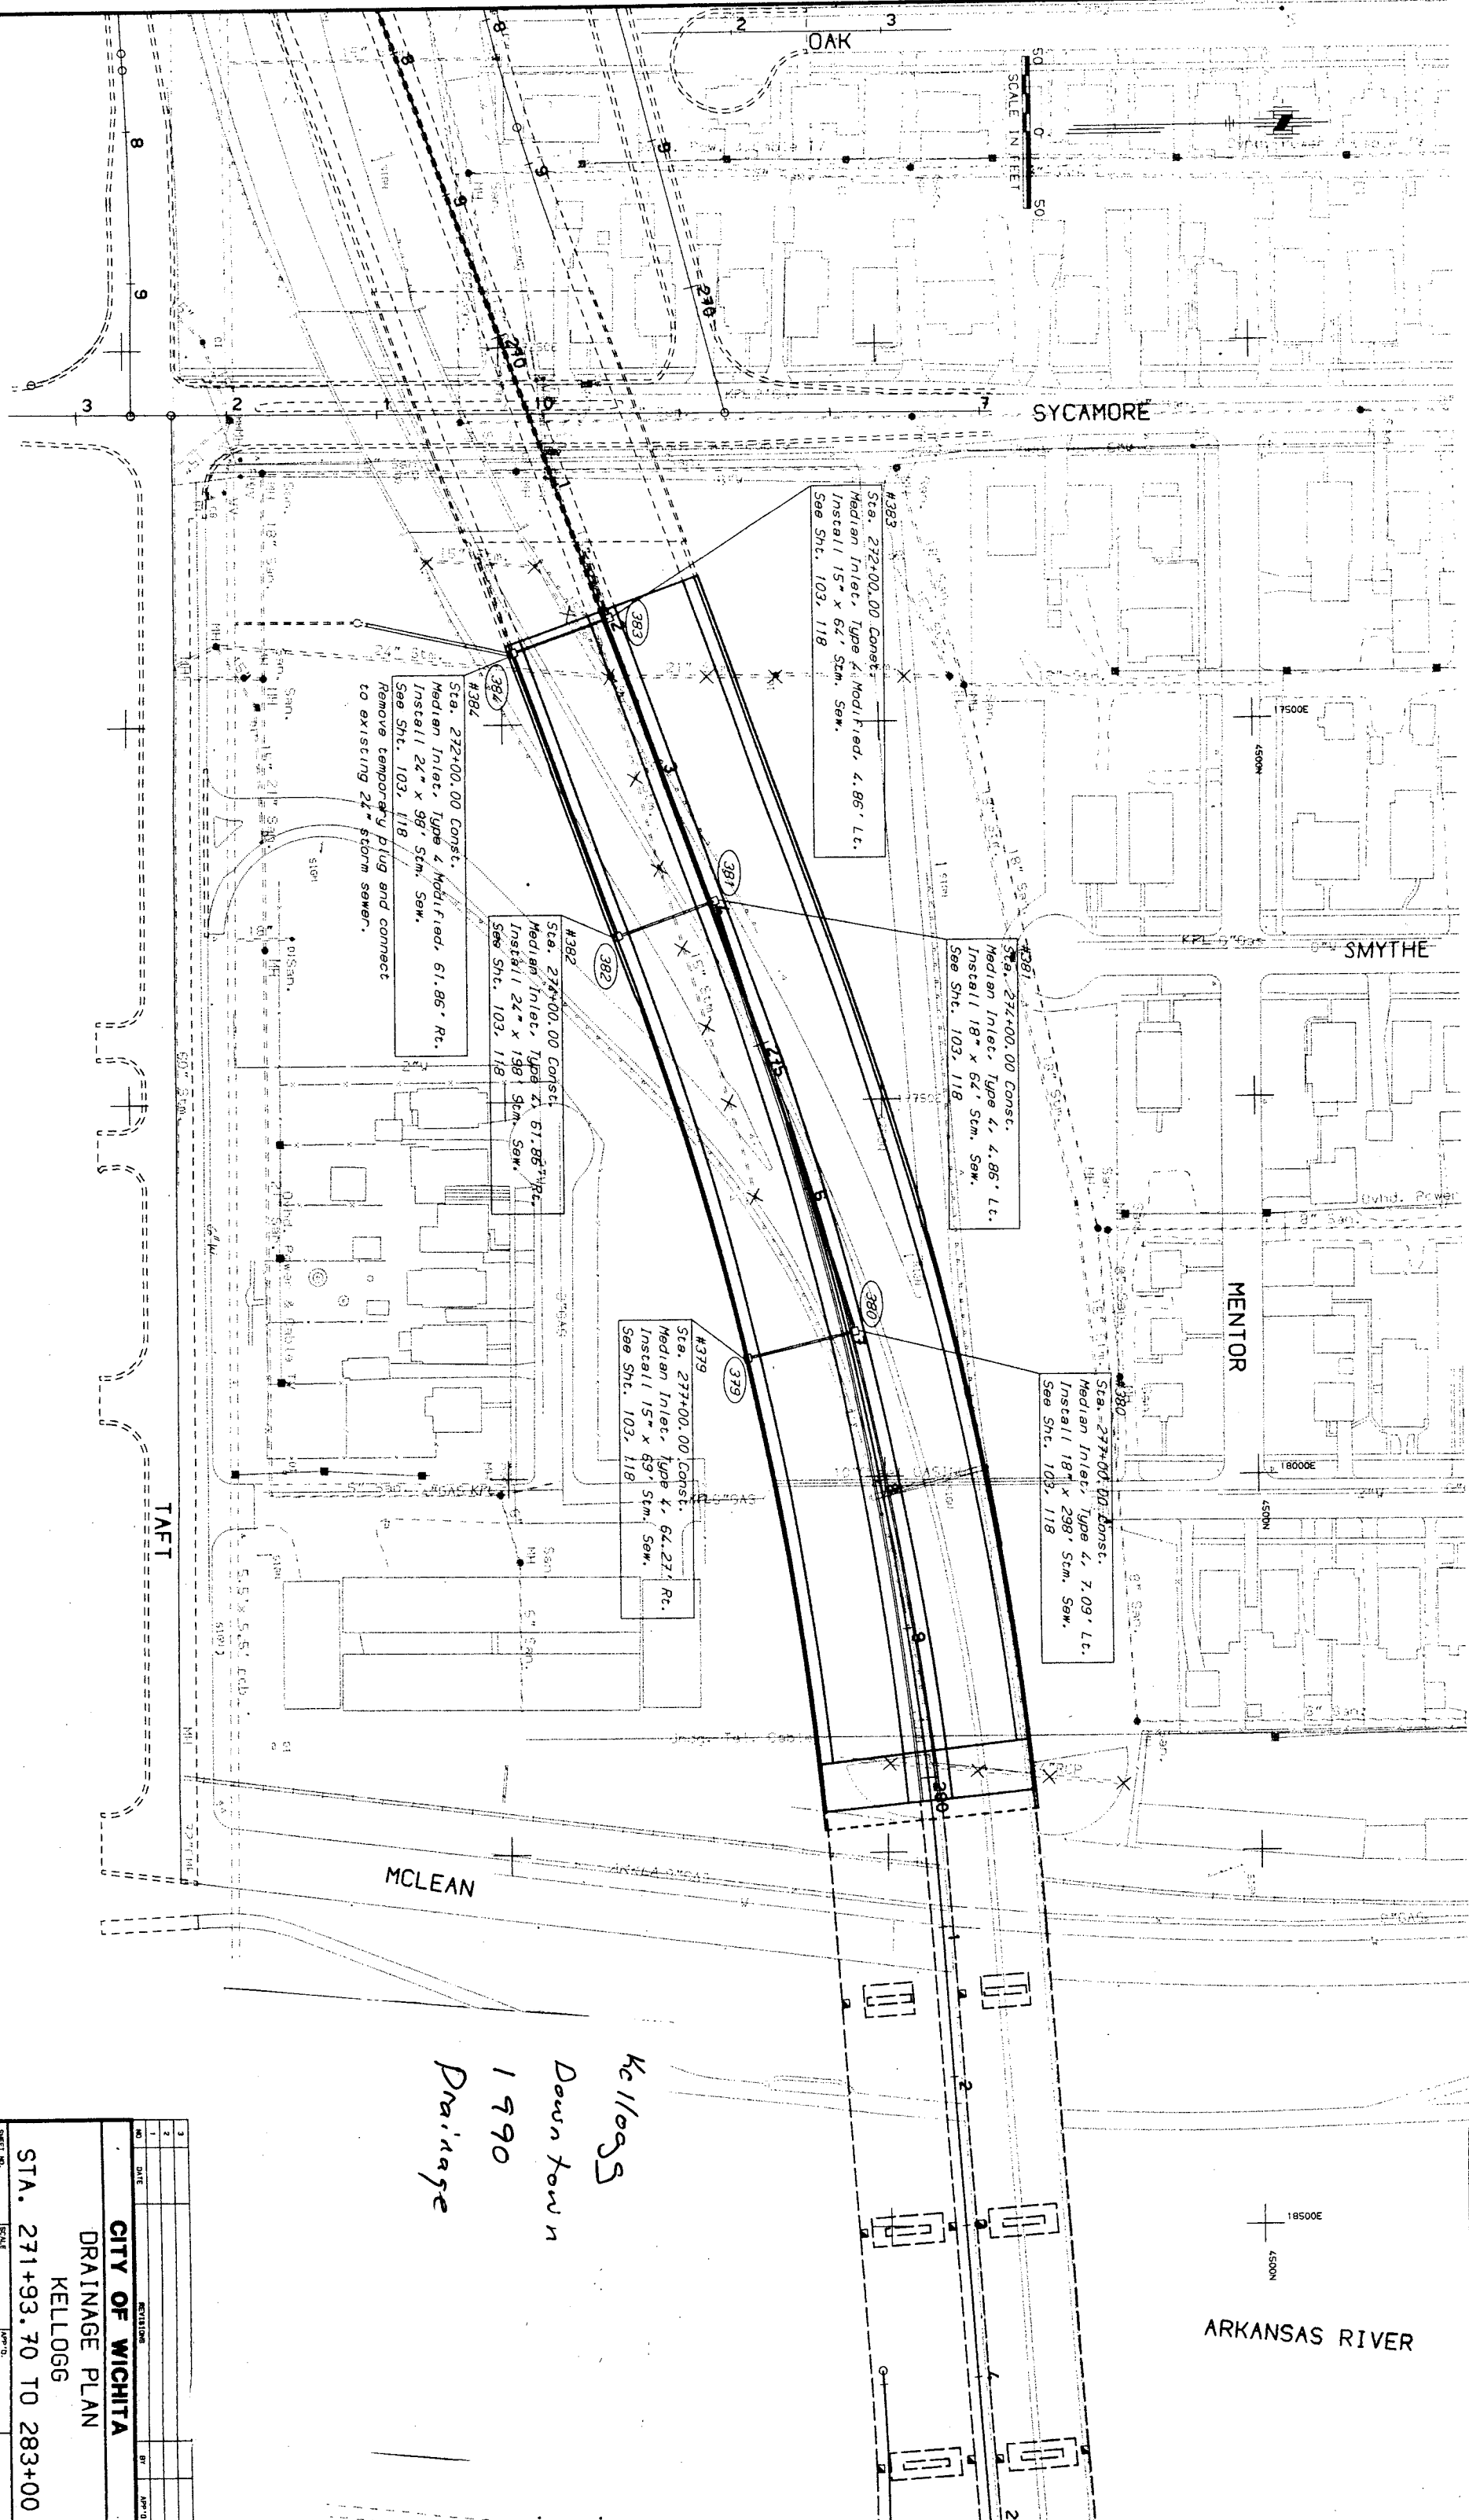

Ke 11095
Down town
1990
Drainage

Sheet No.	Scale	Project No.	Year	Sheet
1	AS SHOWN	193082	760	


DATE	REVISION	BY	APP'D

CITY OF WICHITA			
DRAINAGE PLAN			
KELLOGG			
STA. 271+93.70 TO 283+00			

DATE	SCALE	REVISION	BY	APP'D
10/10/93	AS SHOWN			


HNTB
HOWARD NEEDLES TAMM & BERENSON
ARCHITECTS ENGINEERS PLANNERS

NO.	DATE	BY	CHKD.	APP'D.	REVISION
1					
2					
3					
388					
3					

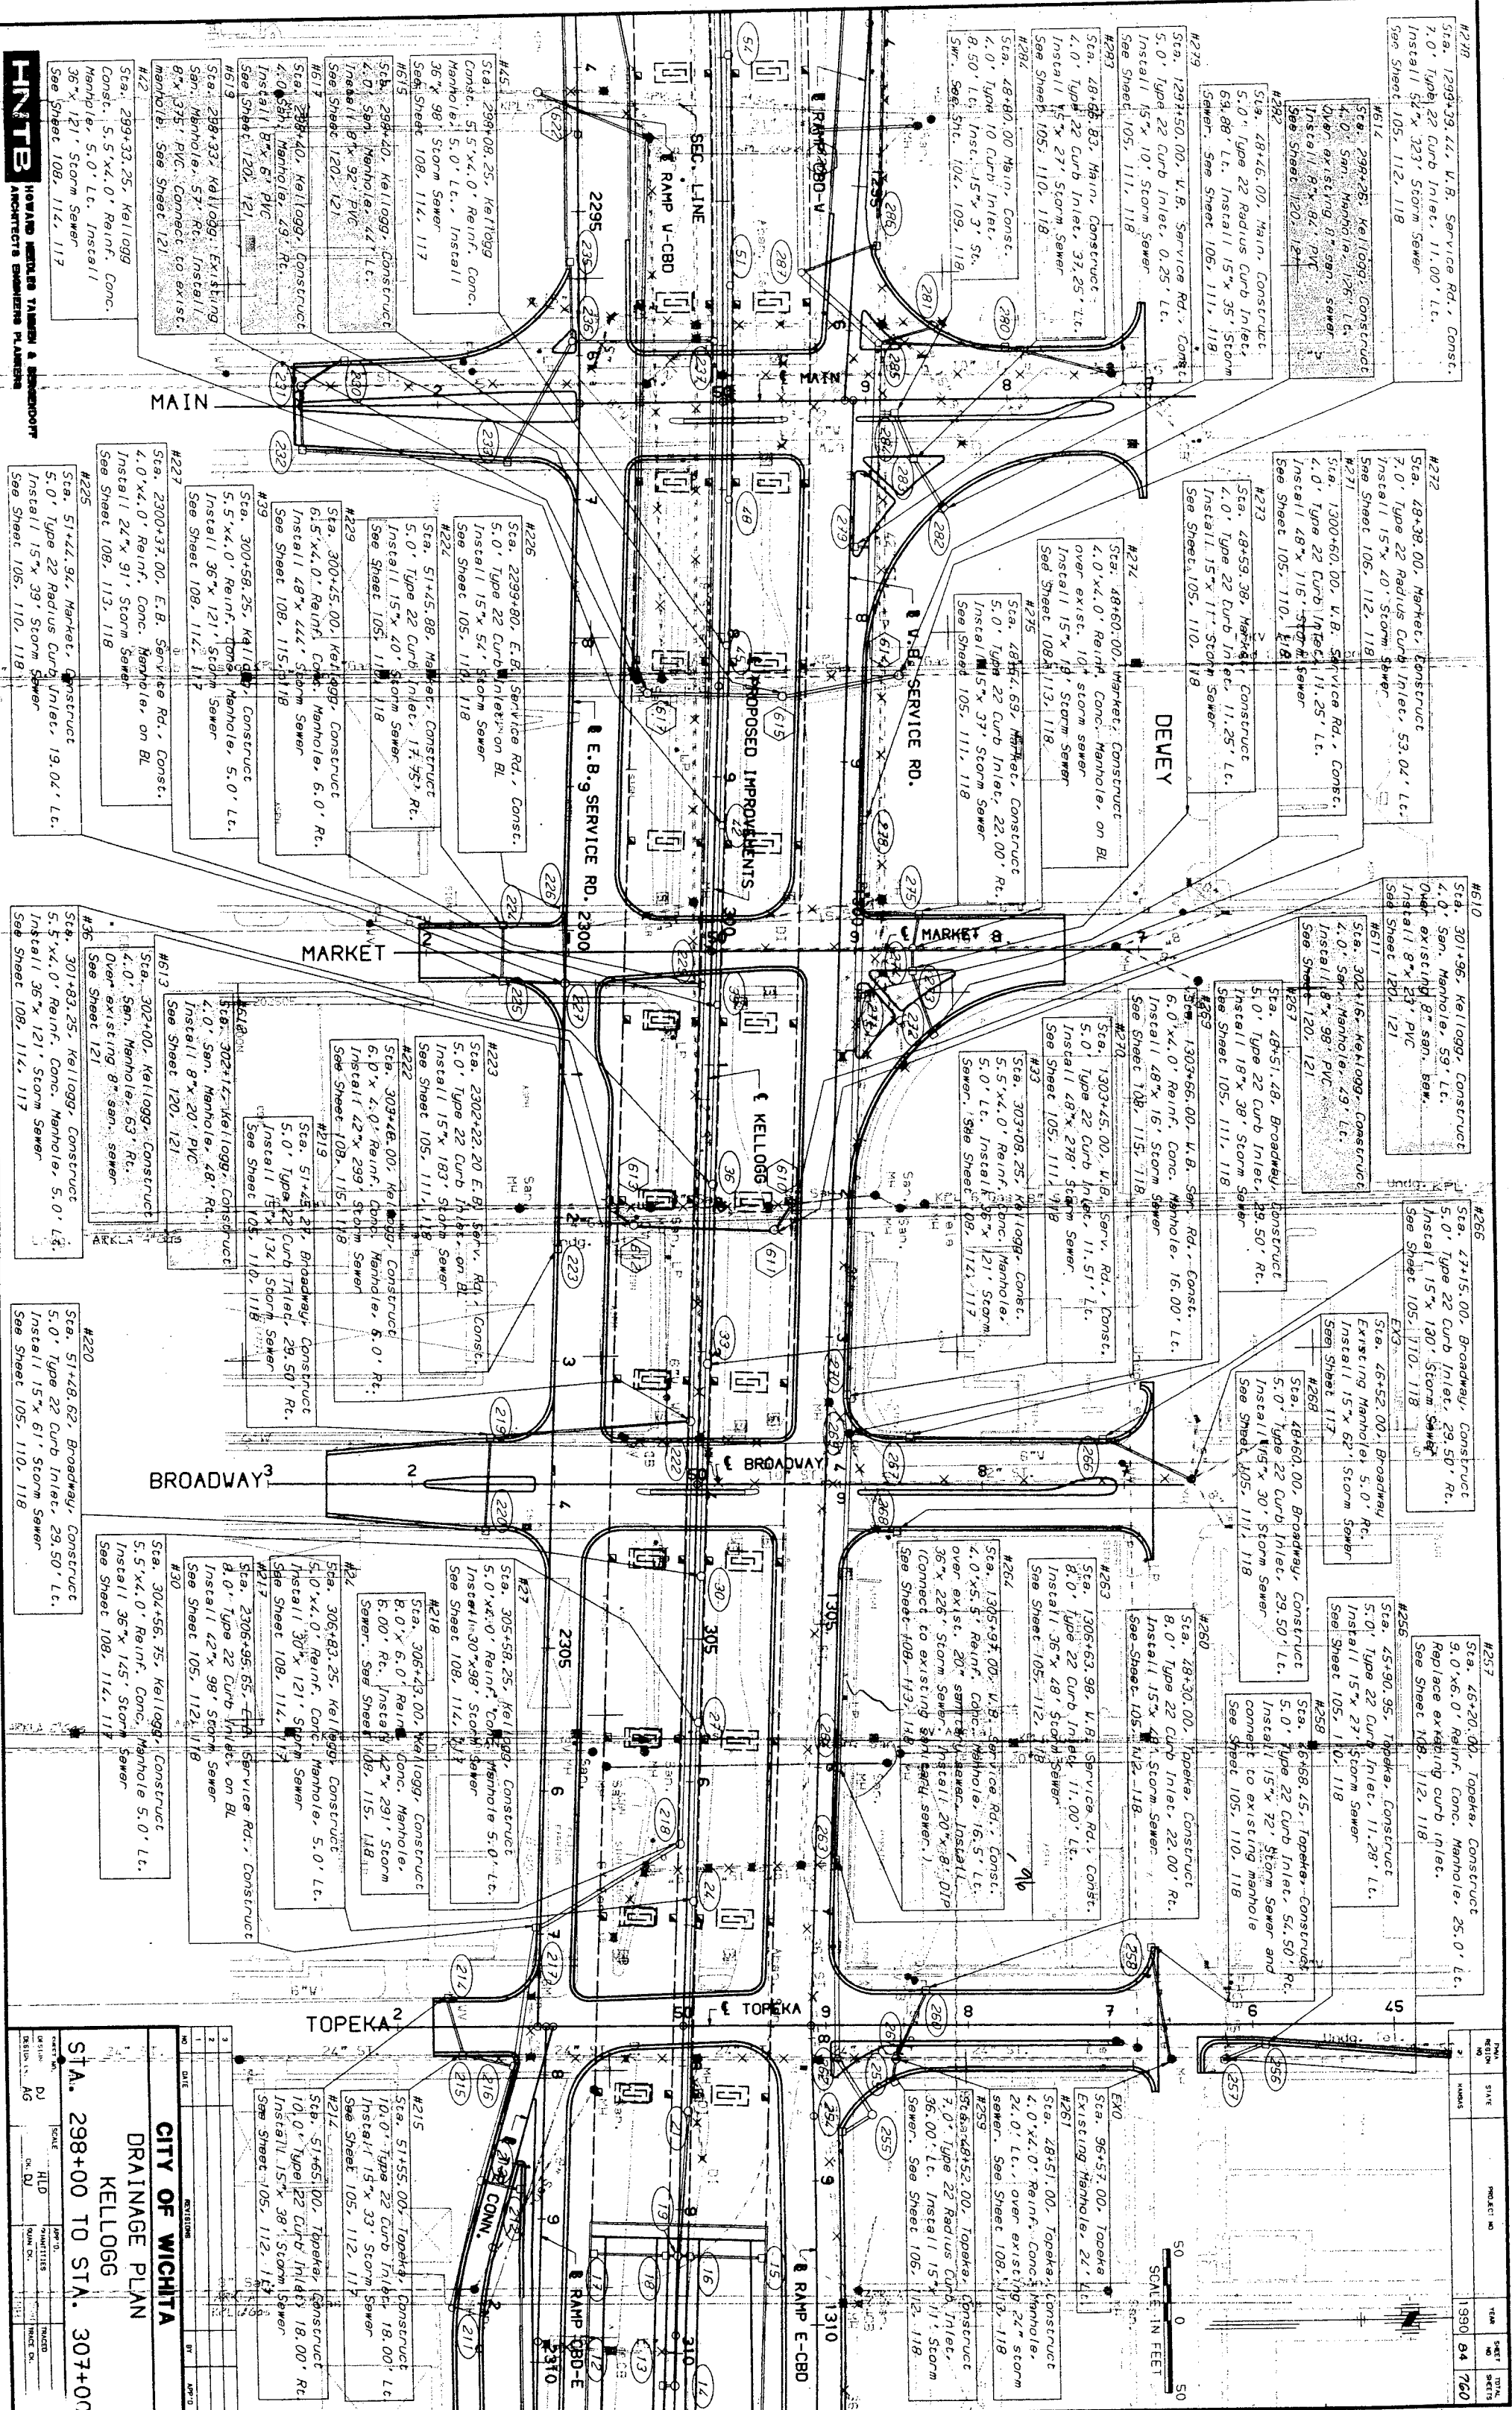
CITY OF WICHITA
DRAINAGE PLAN

Sta. 298+00 TO Sta. 307+00

DESIGN	DJ	ALD	QUIN DX.	WACE DX.
DESIGN IN.	AG	DX. DJ		

 

1	DATE	INITIALS	REMARKS
2			
3			
4			
100			

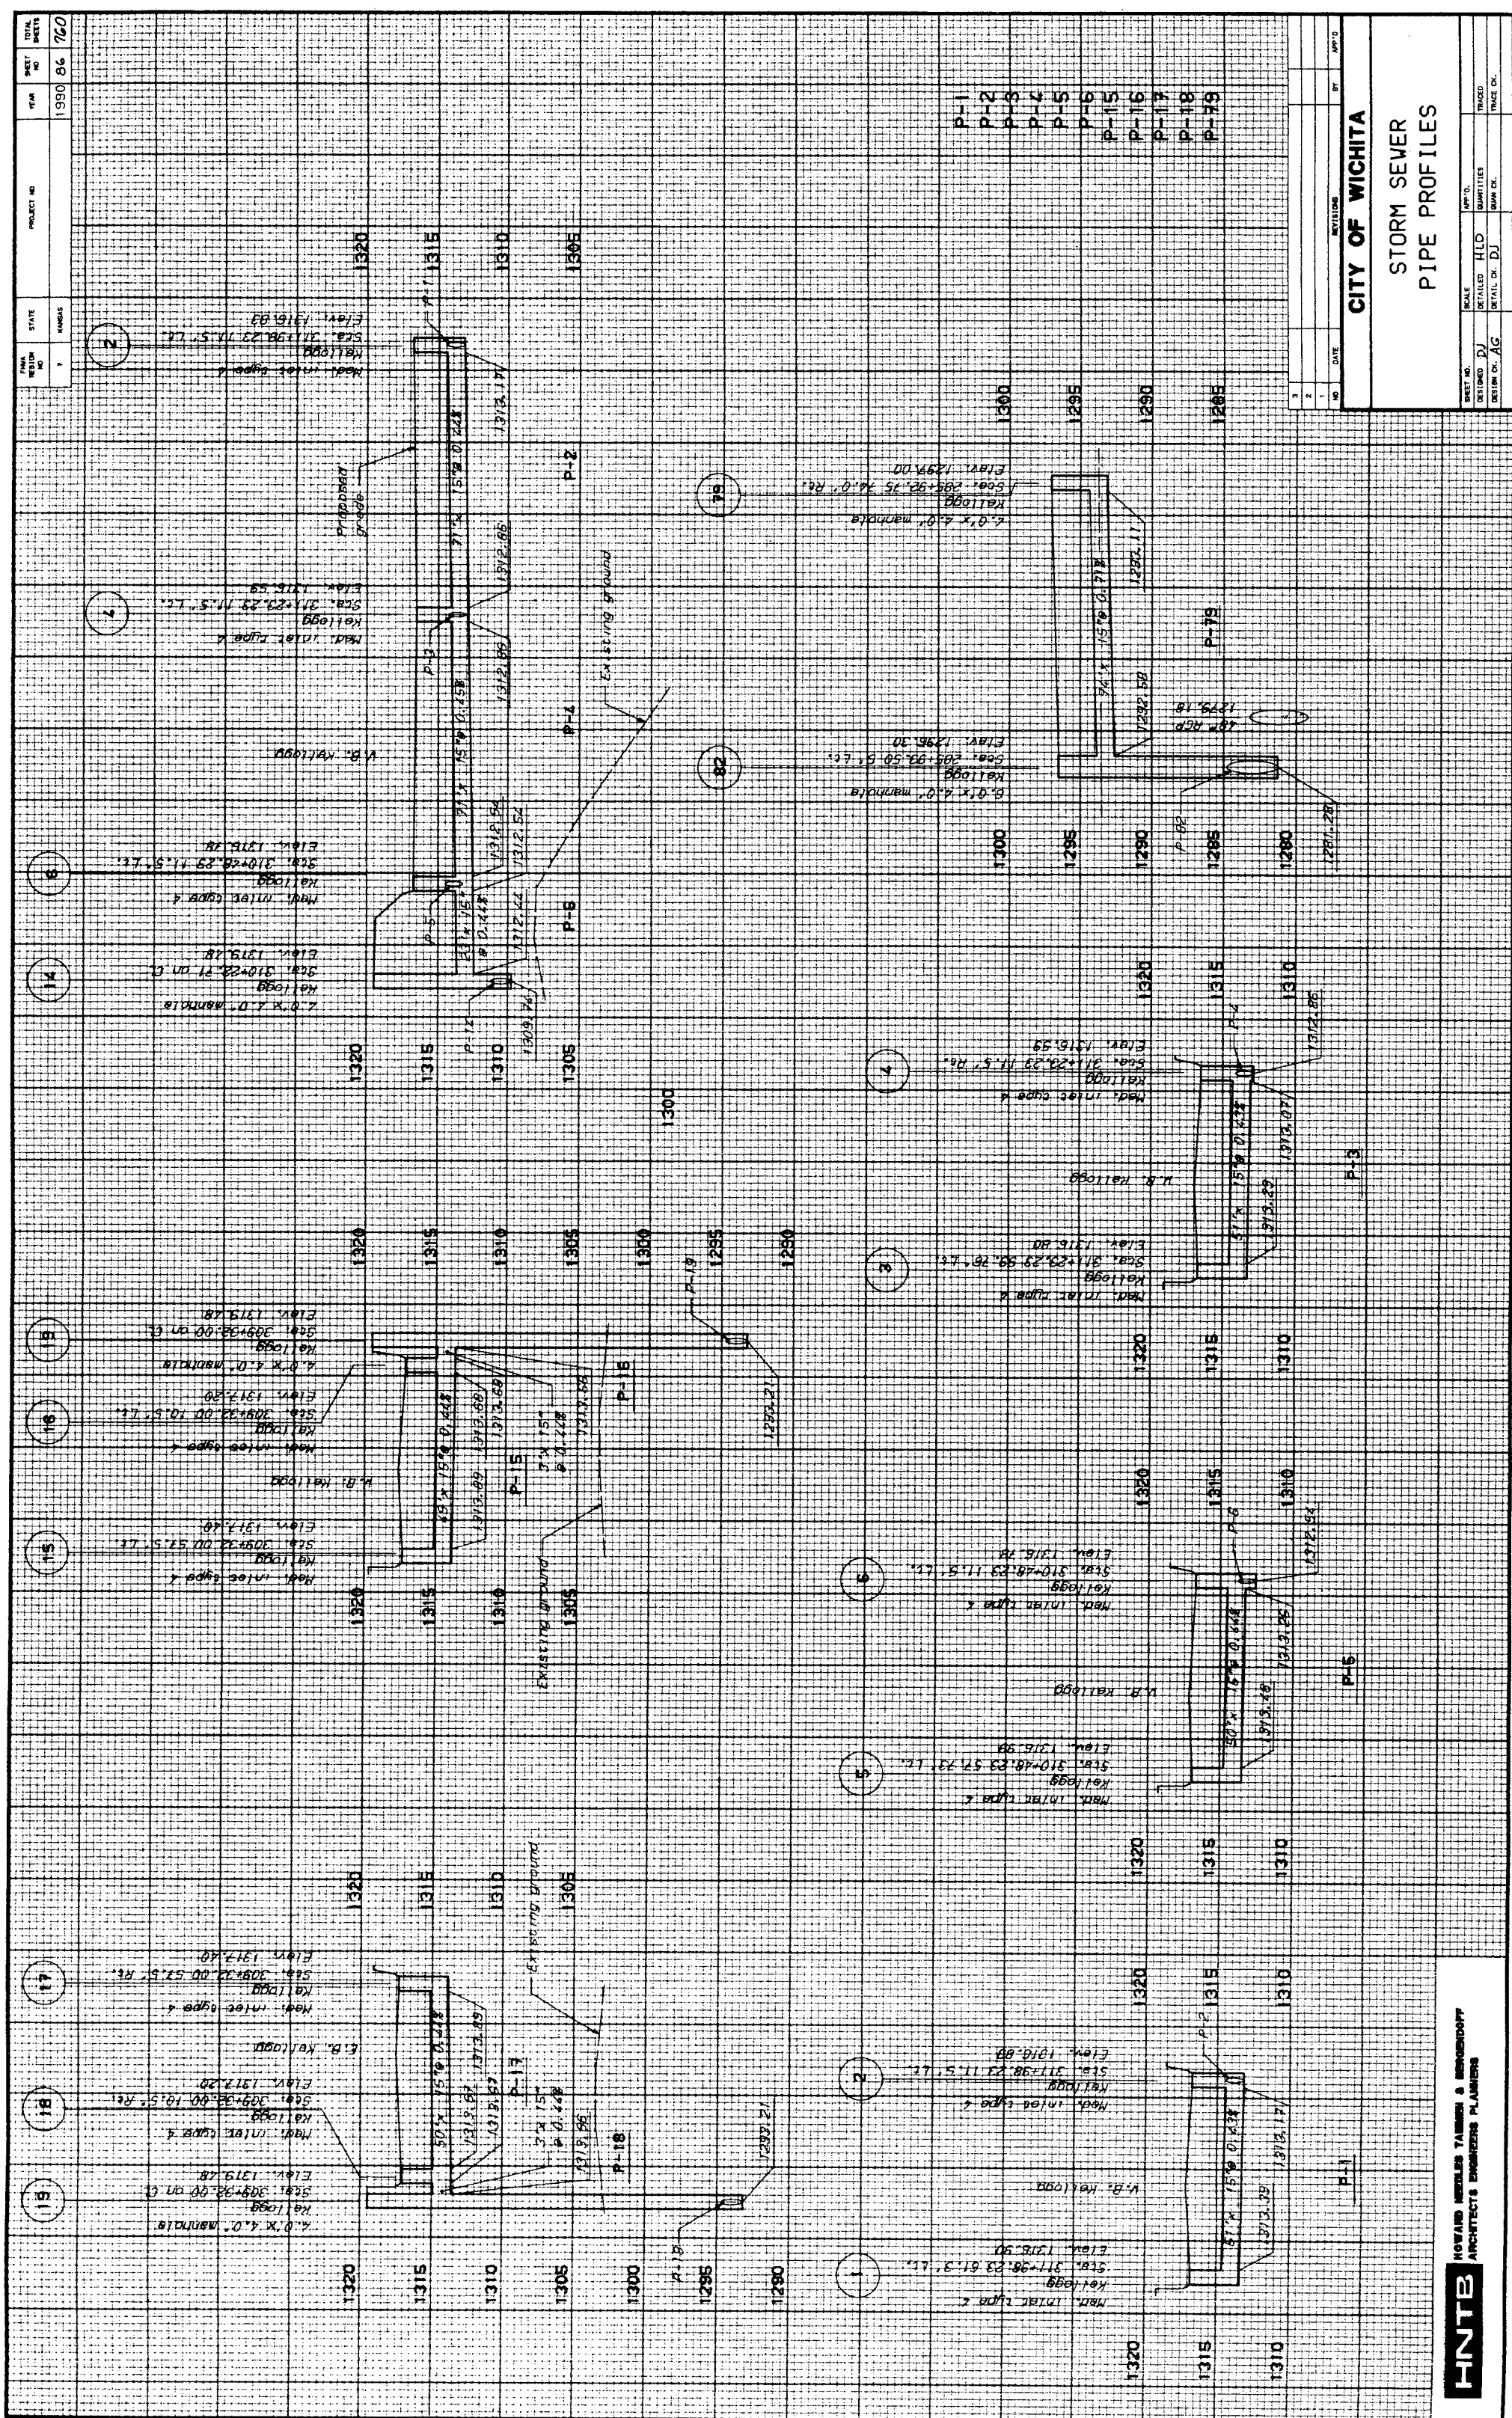


HNTB HOWARD NEEDLES TAMMEN & BERNDORFF
ARCHITECTS ENGINEERS PLANNERS

CITY OF WICHITA

**STORM SEWER
PIPE PROFILES**


SHEET NO.		DATE		BY	
1	1	1	1	1	1
SHEET NO. <td data-kind="ghost"></td> <td data-cs="2" data-kind="parent">DATE</td> <td data-kind="ghost"></td> <td data-cs="2" data-kind="parent">BY</td> <td data-kind="ghost"></td>		DATE		BY	
2	2	2	2	2	2
SHEET NO. <td data-kind="ghost"></td> <td data-cs="2" data-kind="parent">DATE</td> <td data-kind="ghost"></td> <td data-cs="2" data-kind="parent">BY</td> <td data-kind="ghost"></td>		DATE		BY	
3	3	3	3	3	3

SHEET NO.		SCALE		APP'D.	
DESIGNED DJ	DETAILED HLD			TRADED	
DESIGN CH. AG	DETAIL CH. DJ			TRACE CH.	

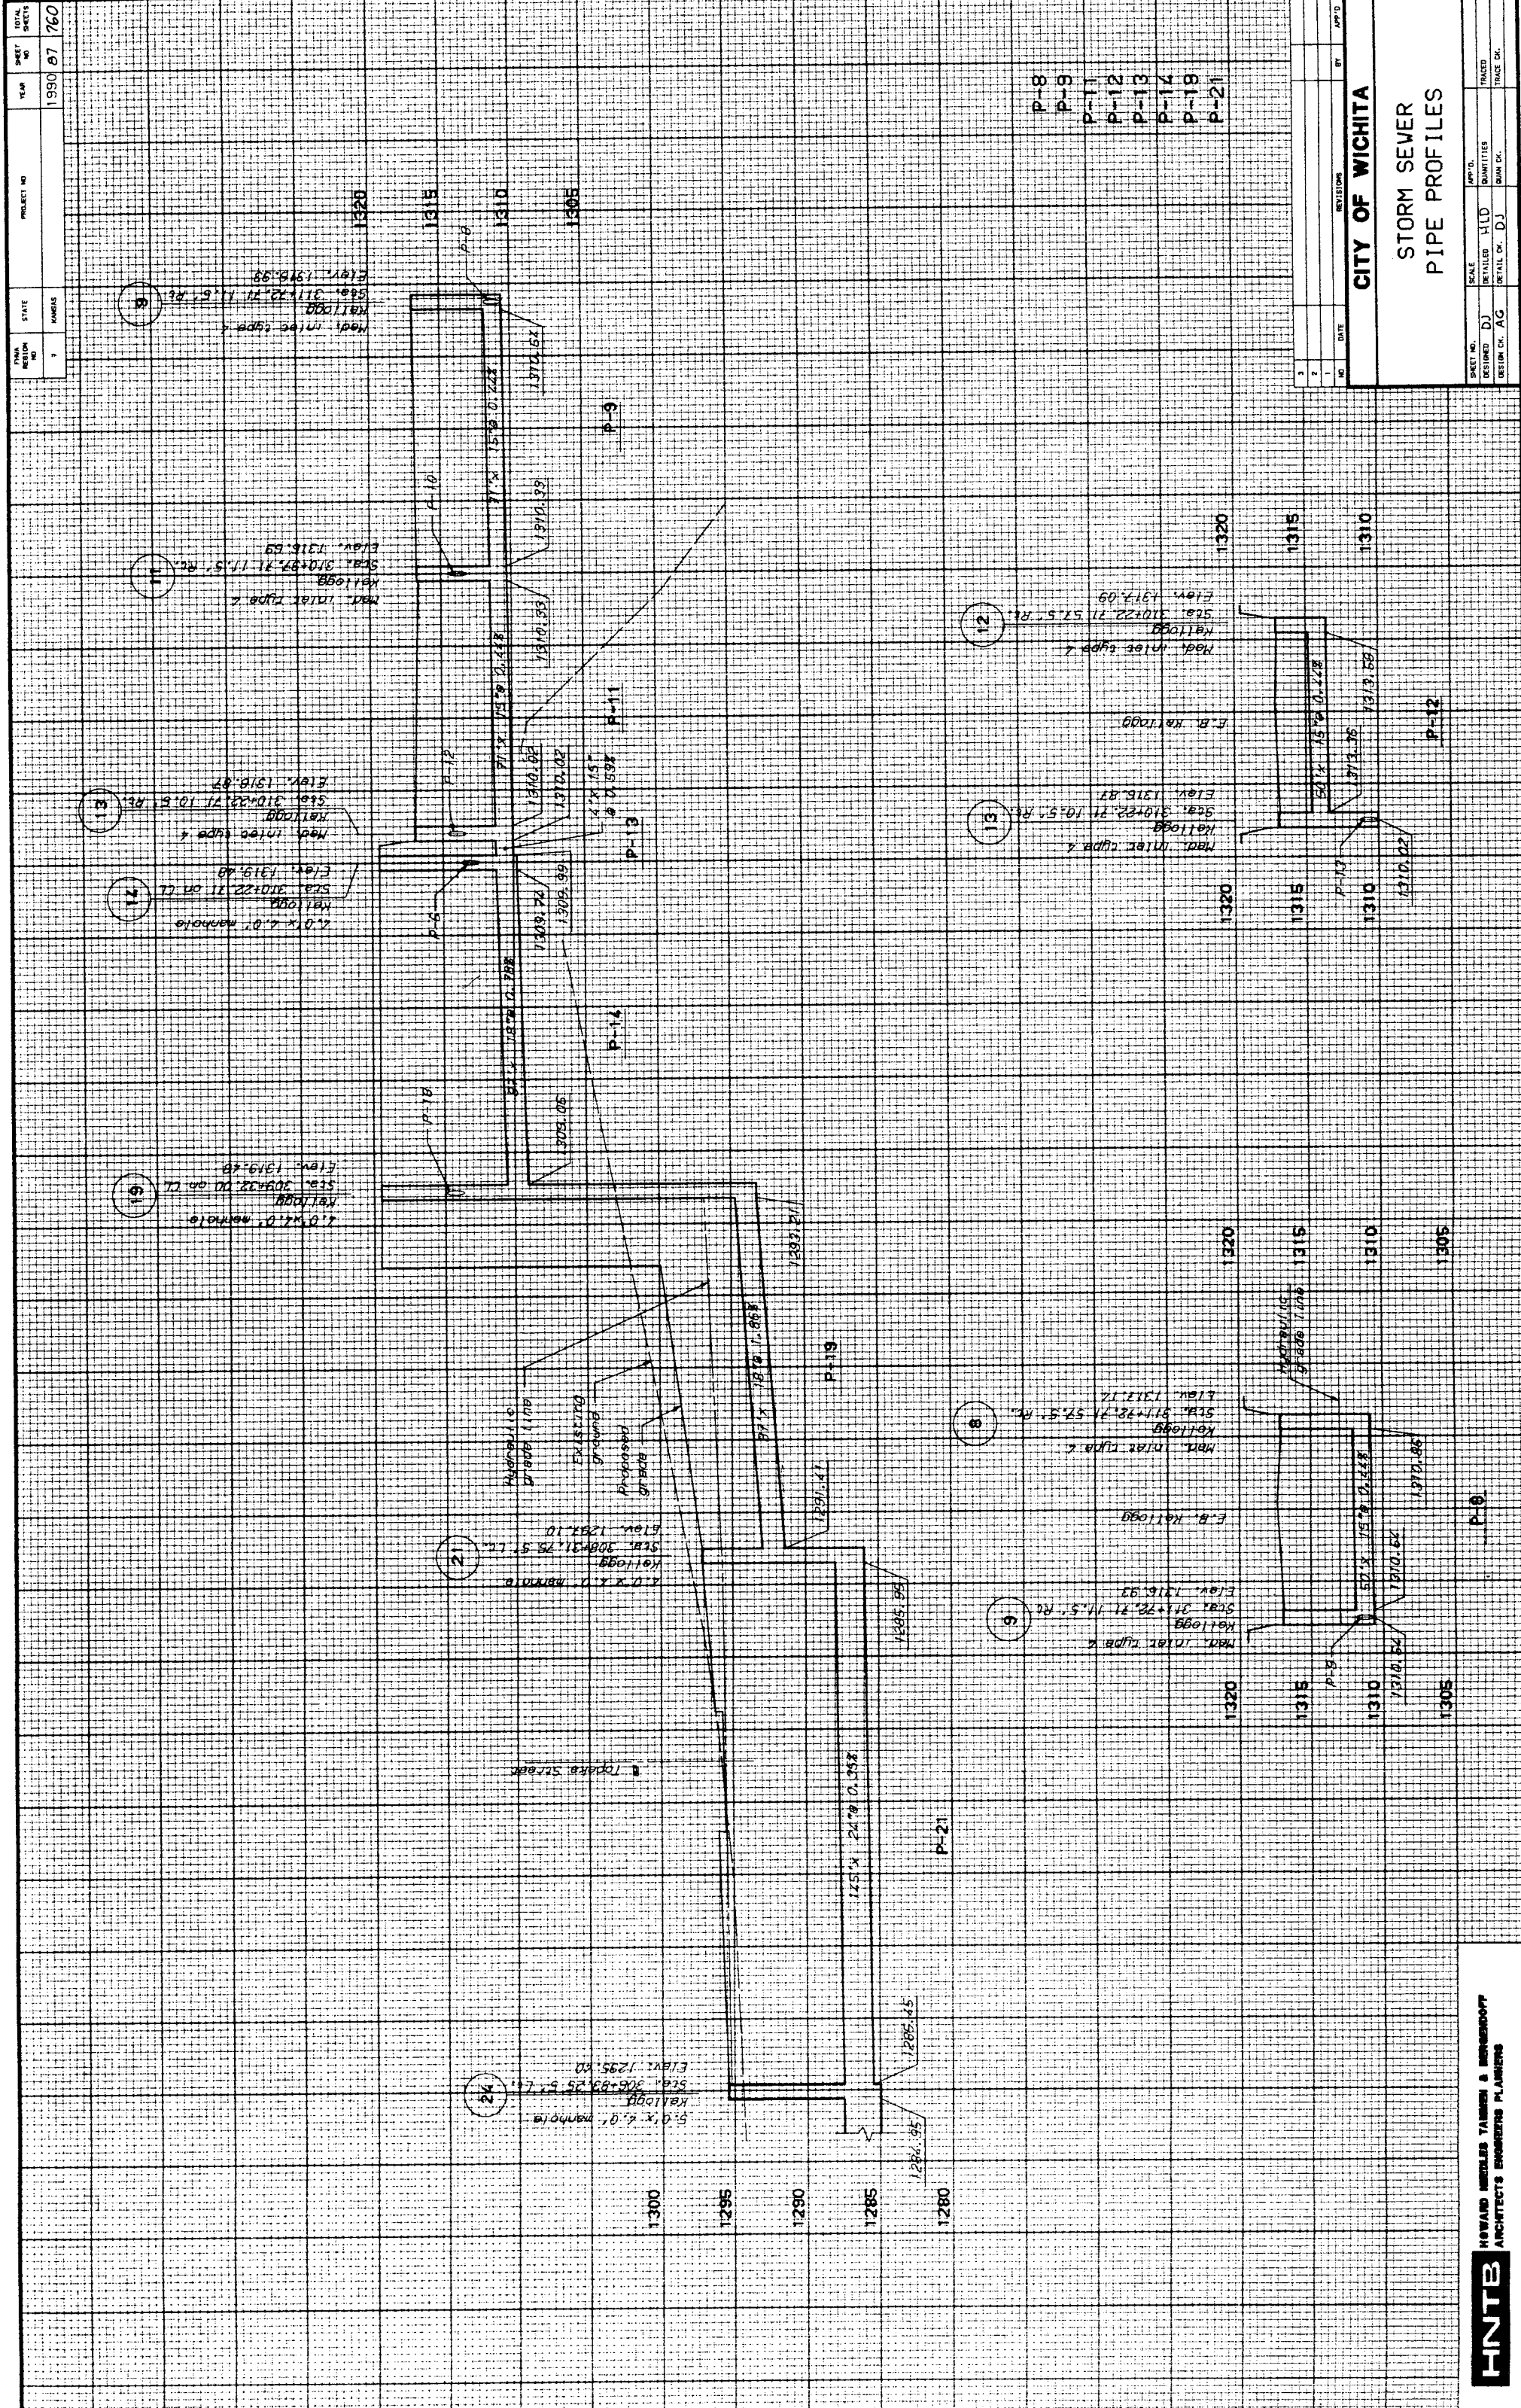

CITY OF WICHITA	
STORM SEWER	
PIPE PROFILES	
SHEET NO. 1	
DATE 10/10/01	
BY JMD	
CHECKED BY JMD	
APPROVED BY JMD	
SCALE 1"=10'	
PROJECT NO. 1998 67 160	
STATE KANSAS	
COUNTY SEDGWICK	
TOWNSHIP 10N	
RANGE 10E	
SECTION 10	

HNTB HOWARD NEEDLES TAMM & BERENSON
ARCHITECTS ENGINEERS PLANNERS

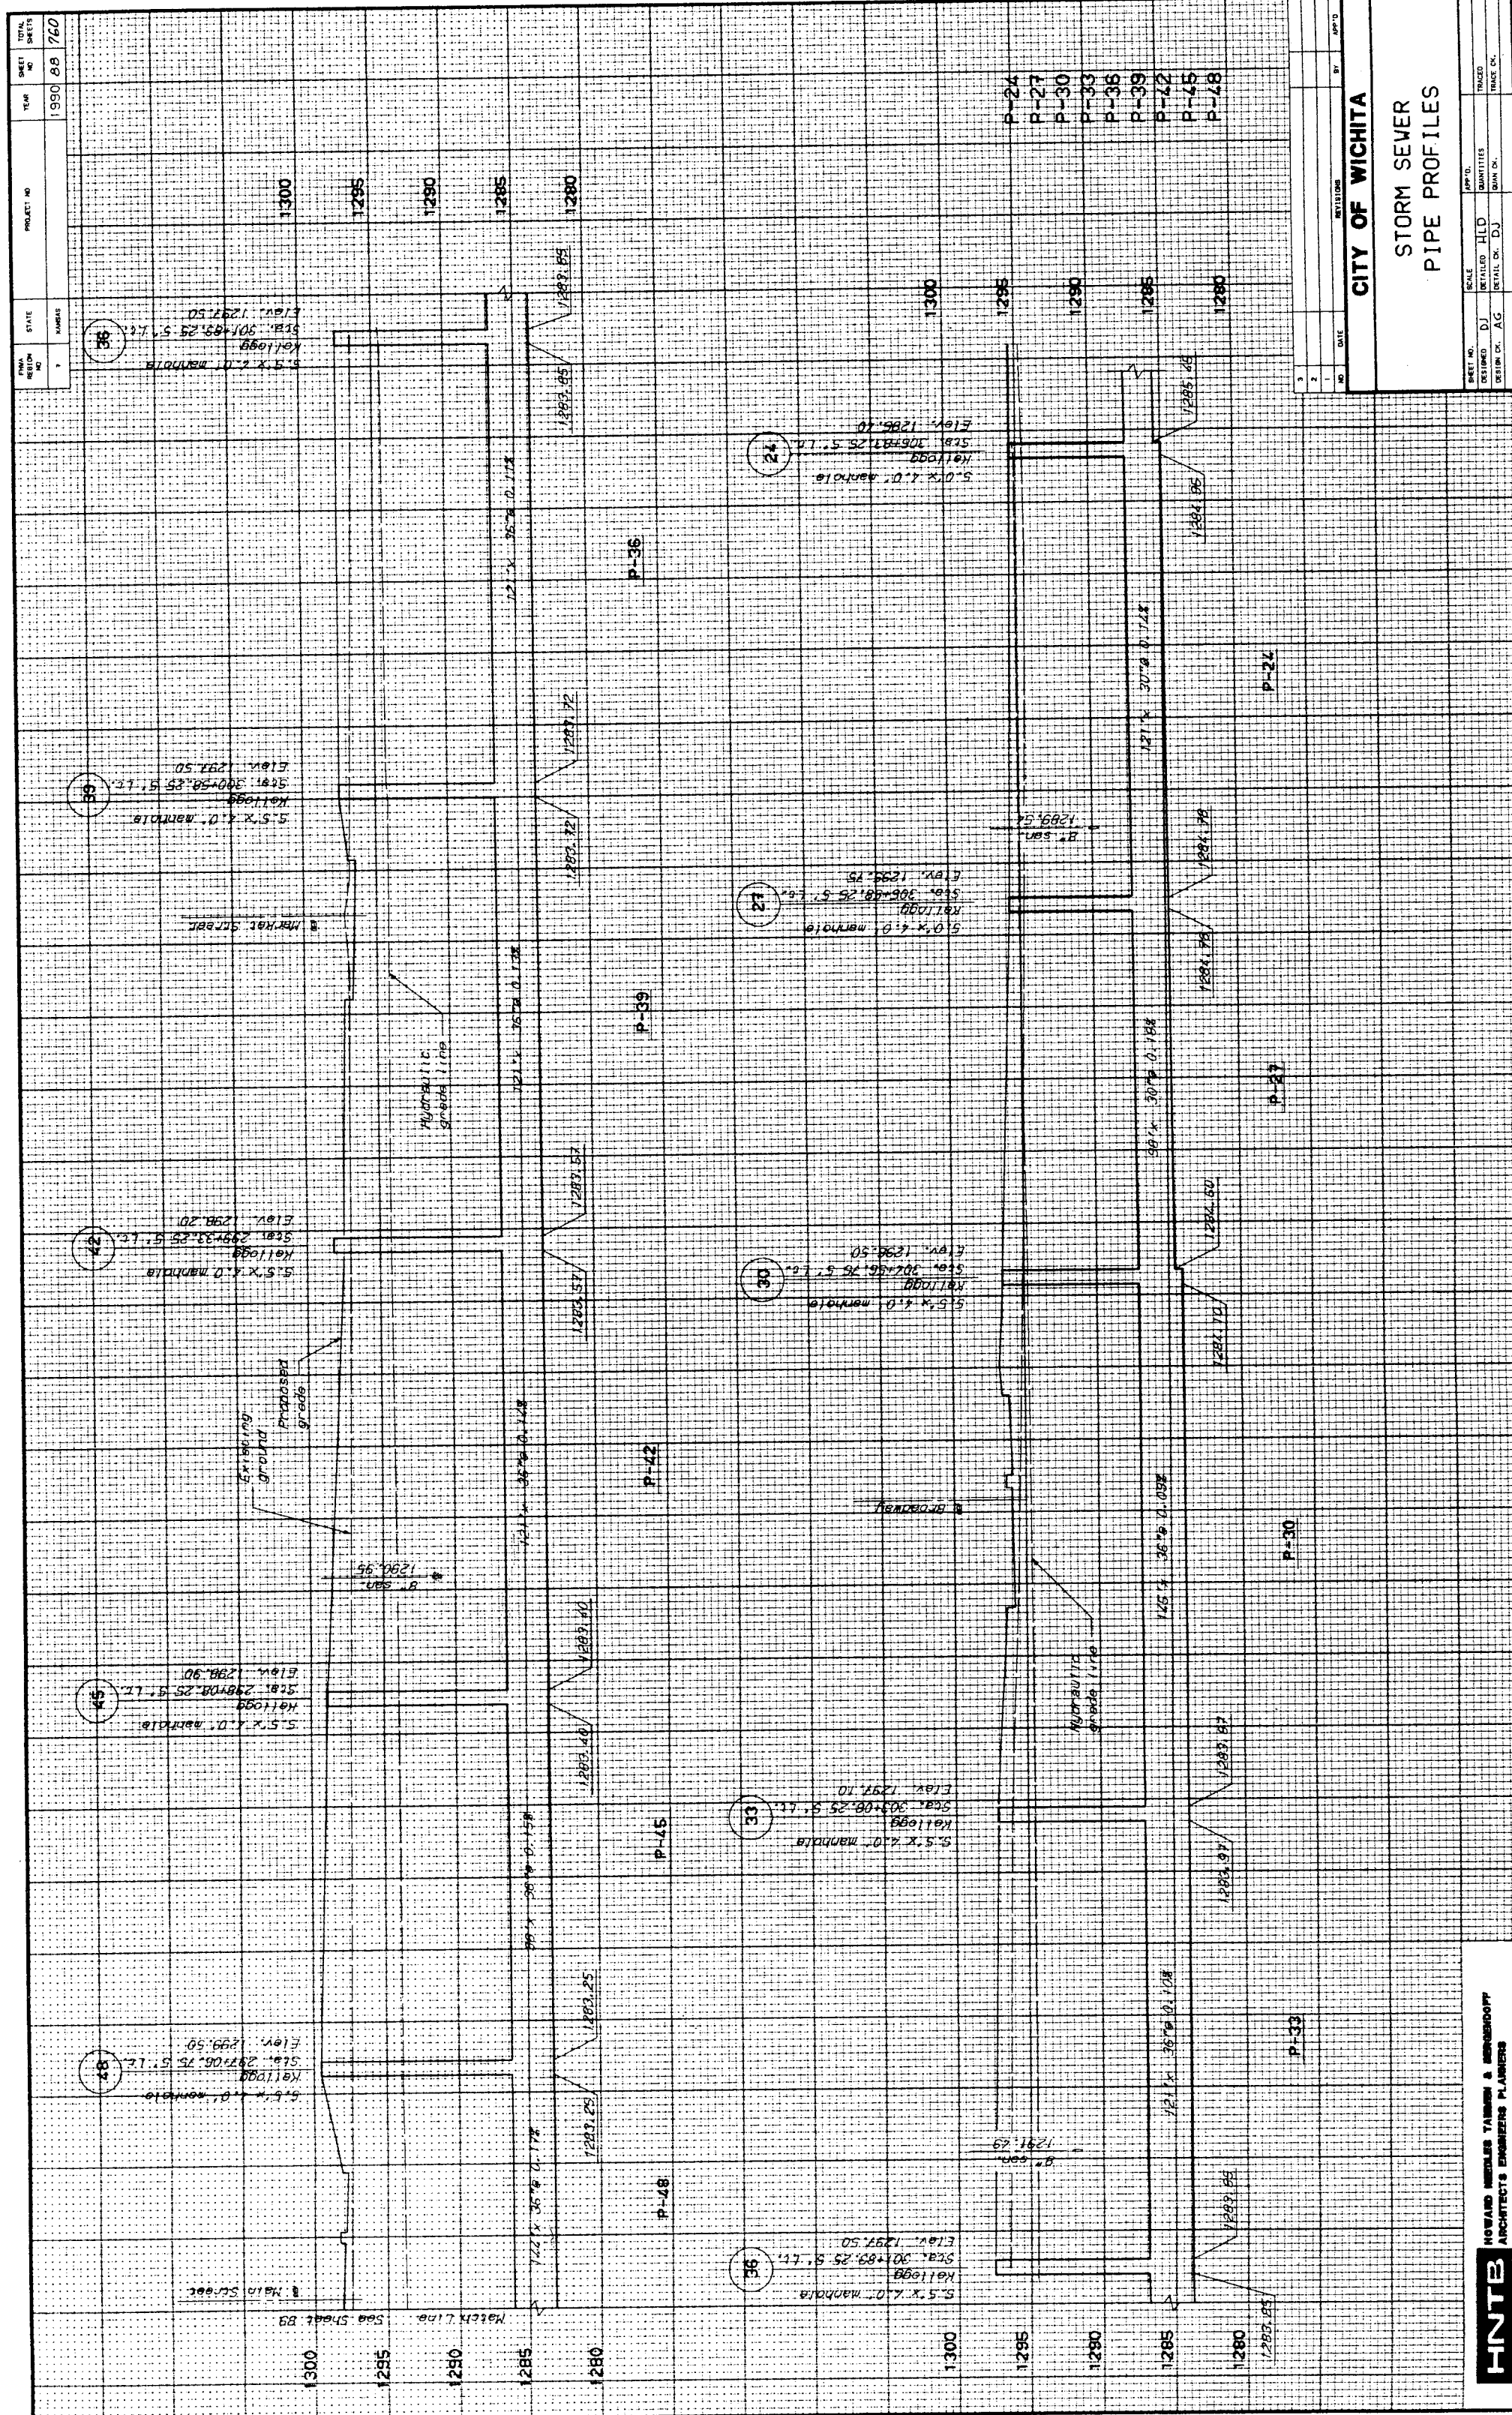


HNTB
HOWARD METER TANKER & ENGINEERING
ARCHITECTS ENGINEERS PLANNERS

CITY OF WICHITA

STORM SEWER
PIPE PROFILES

SHEET NO.	SCALE	DATE	BY	CHKD.
89	1" = 40'	1990	89	160
EXTENSION	DATE	BY	CHKD.	

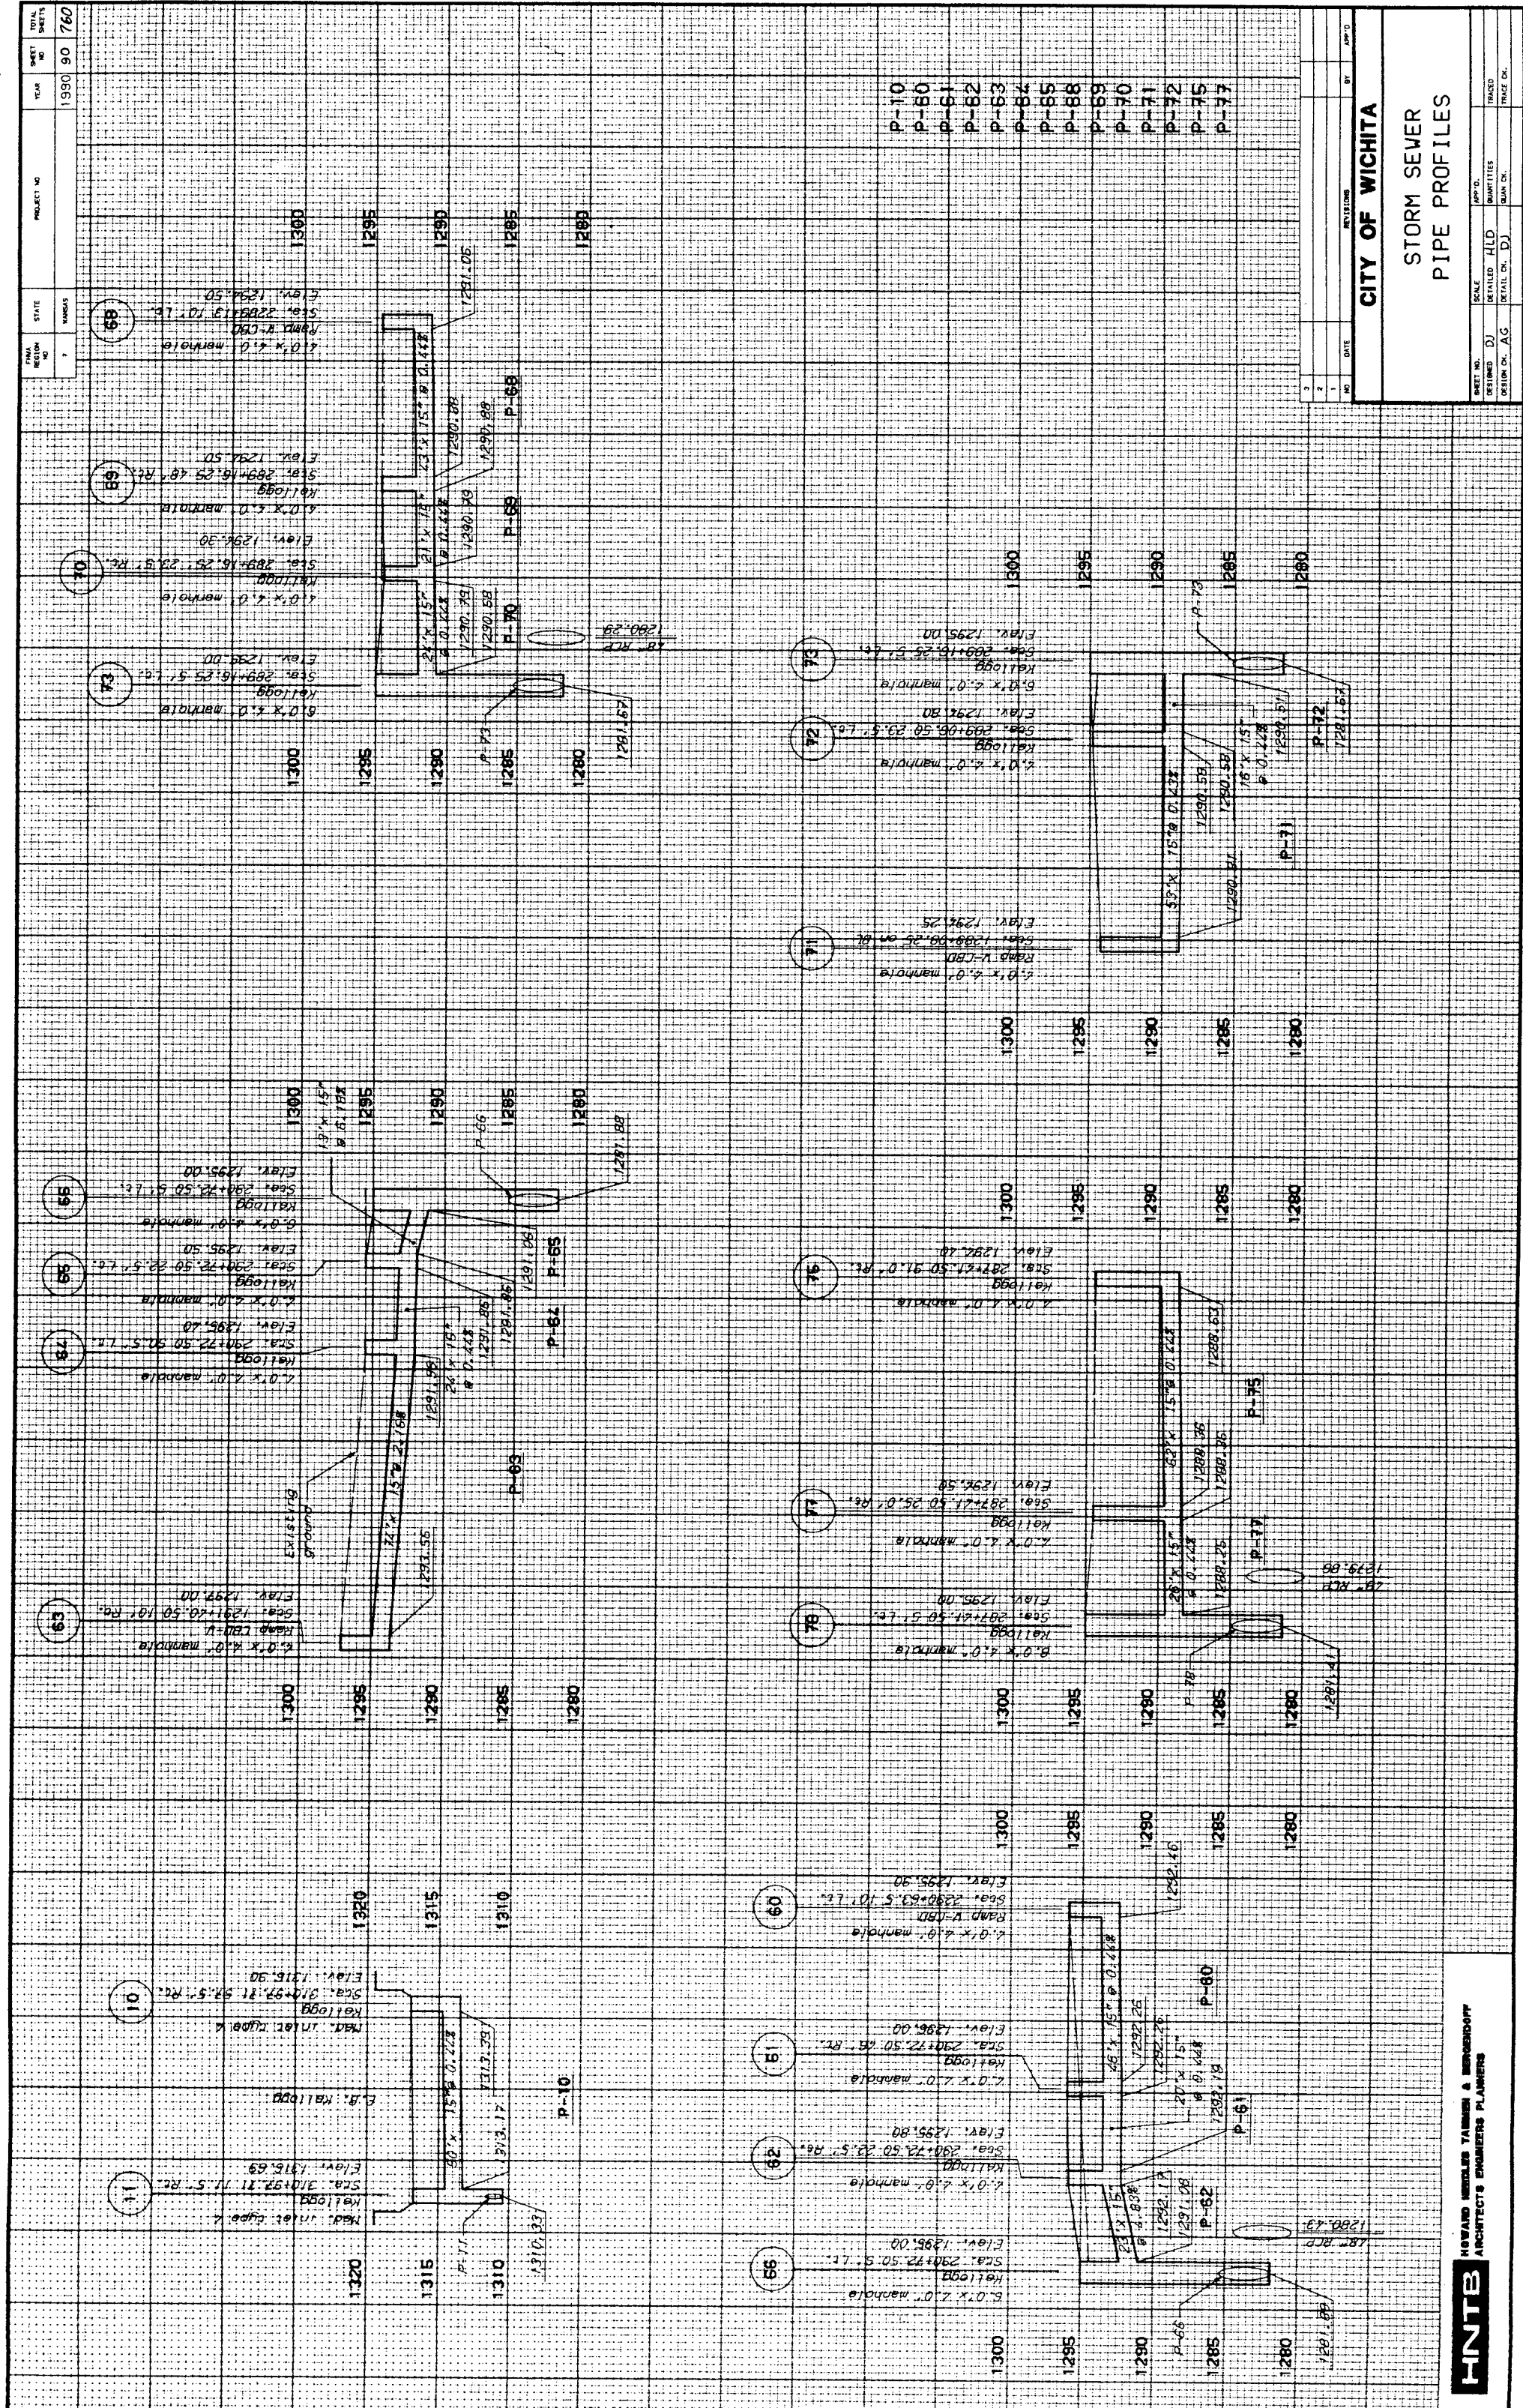



CITY OF WICHITA

STORM SEWER
PIPE PROFILES

SHEET NO.	SCALE	DATE	BY
STATION	DATE	DATE	DATE
STATION	DATE	DATE	DATE

INTEC
ARCHITECTS ENGINEERS PLANNERS

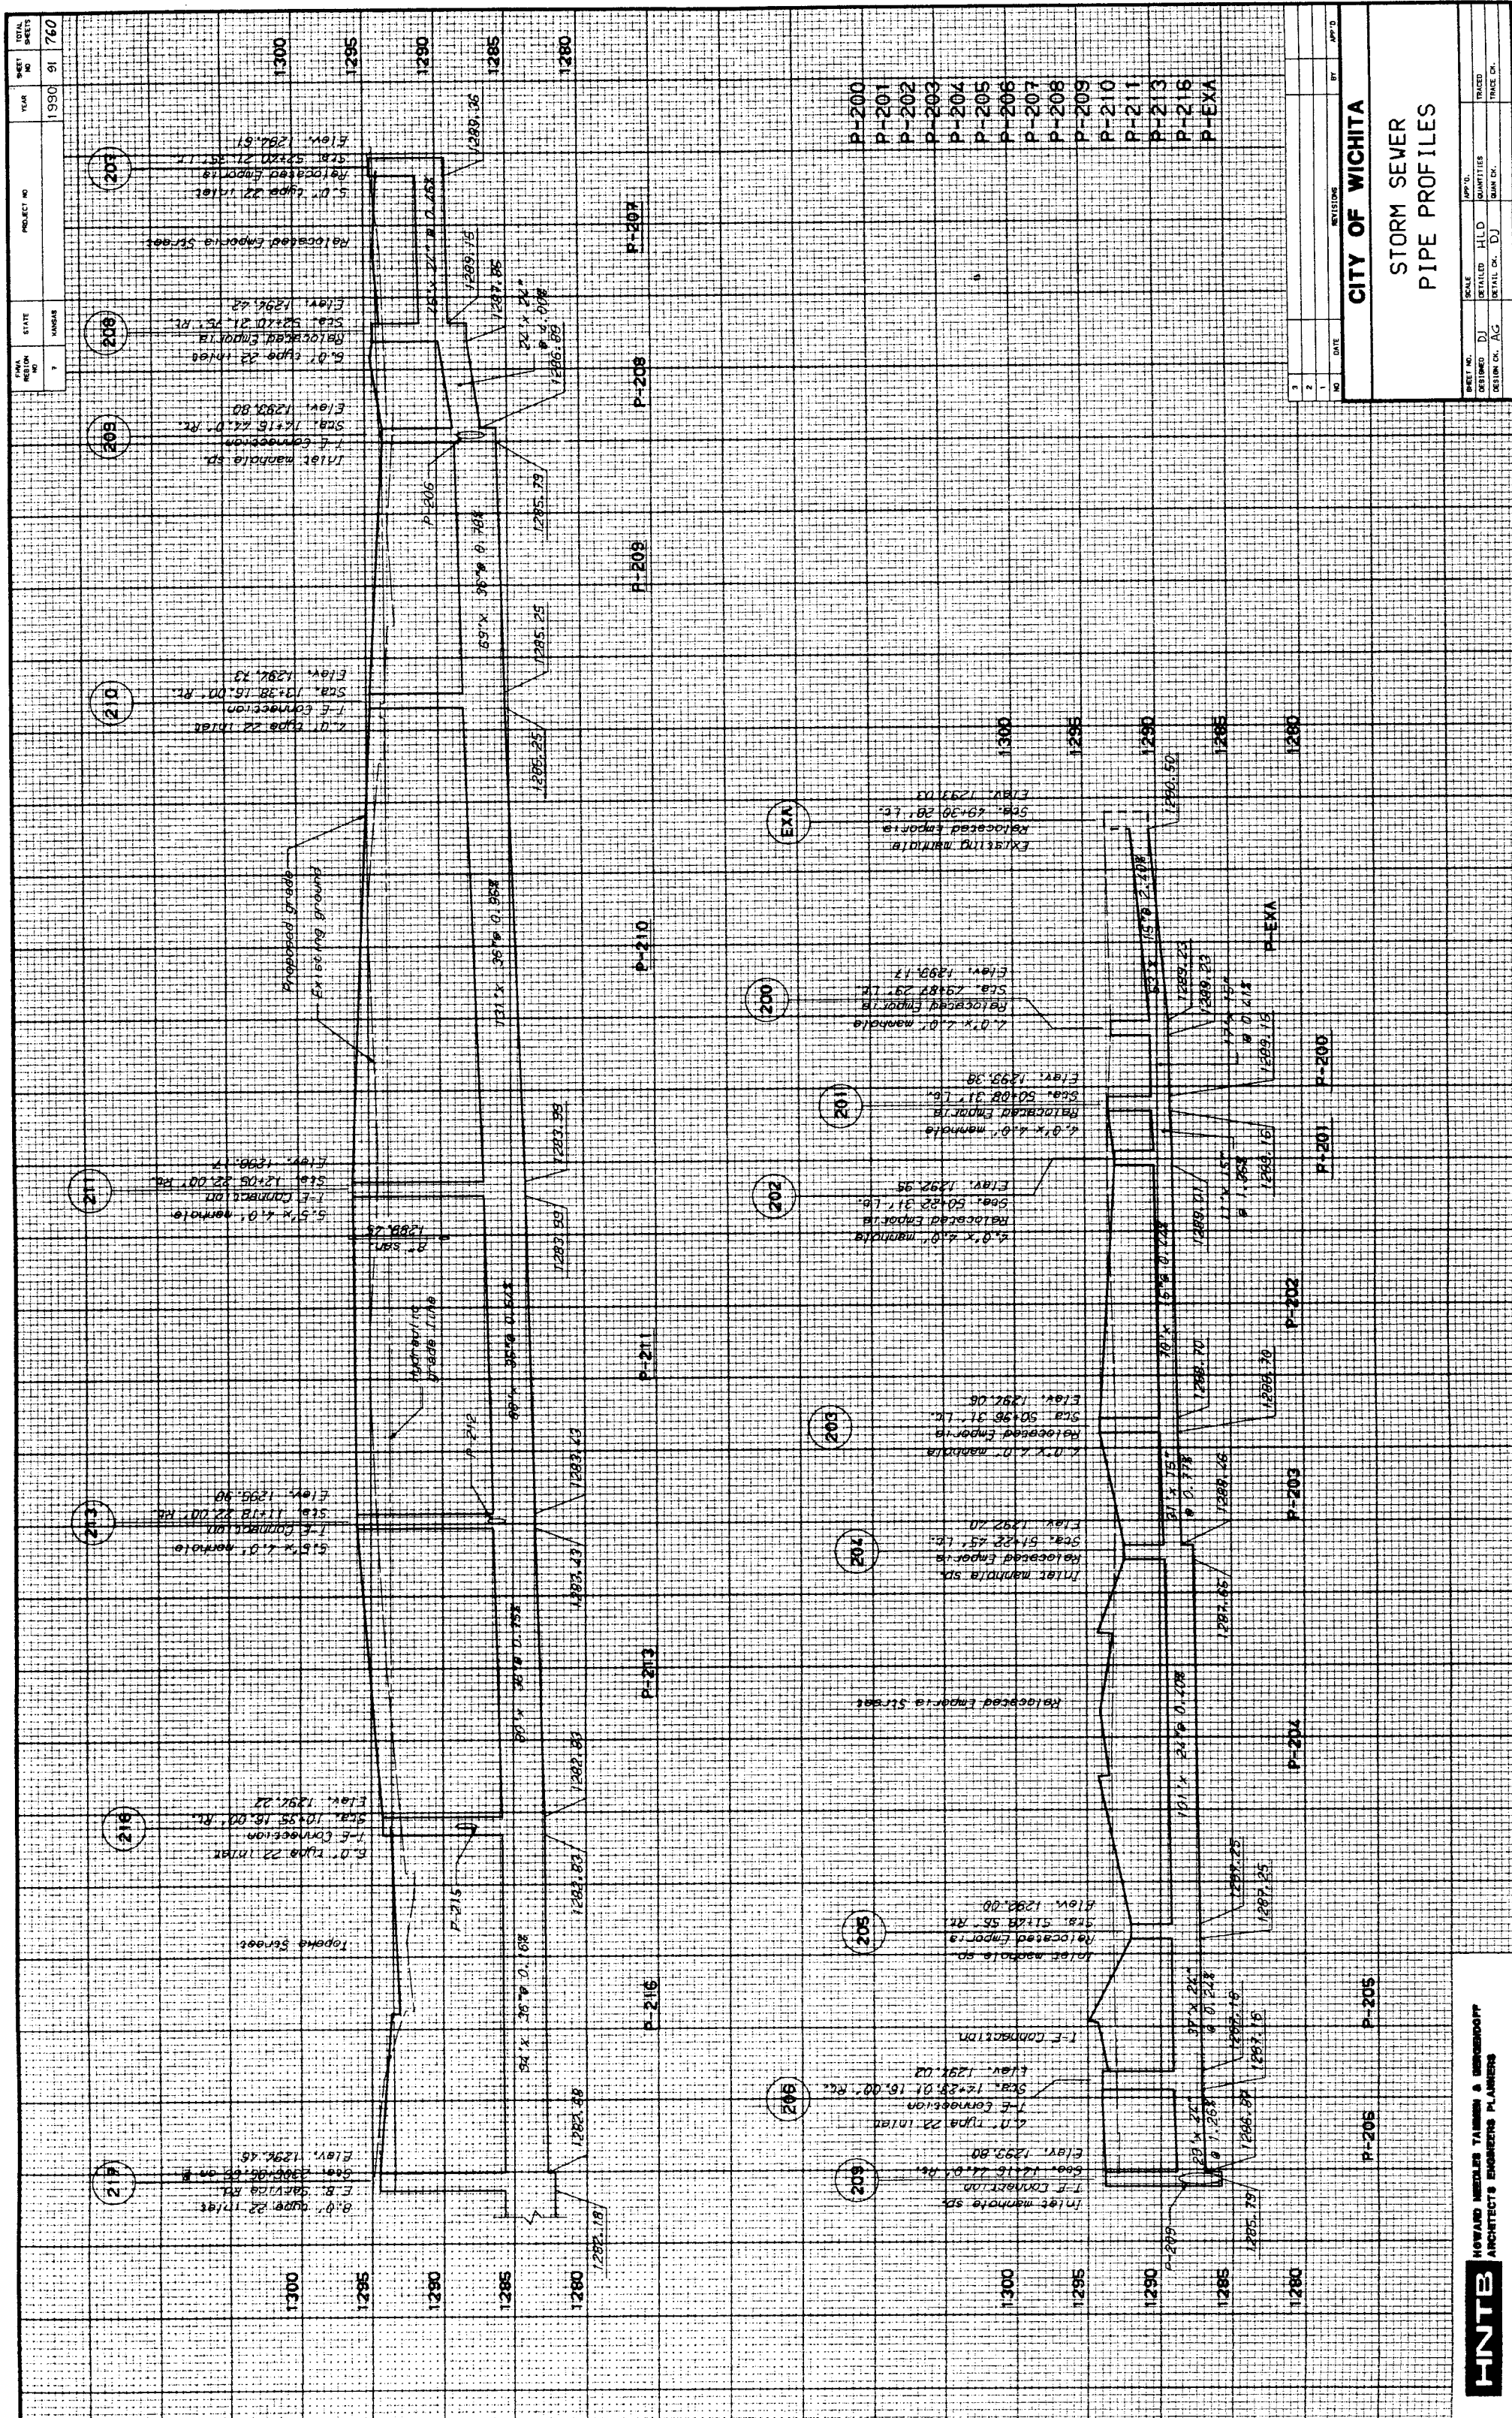


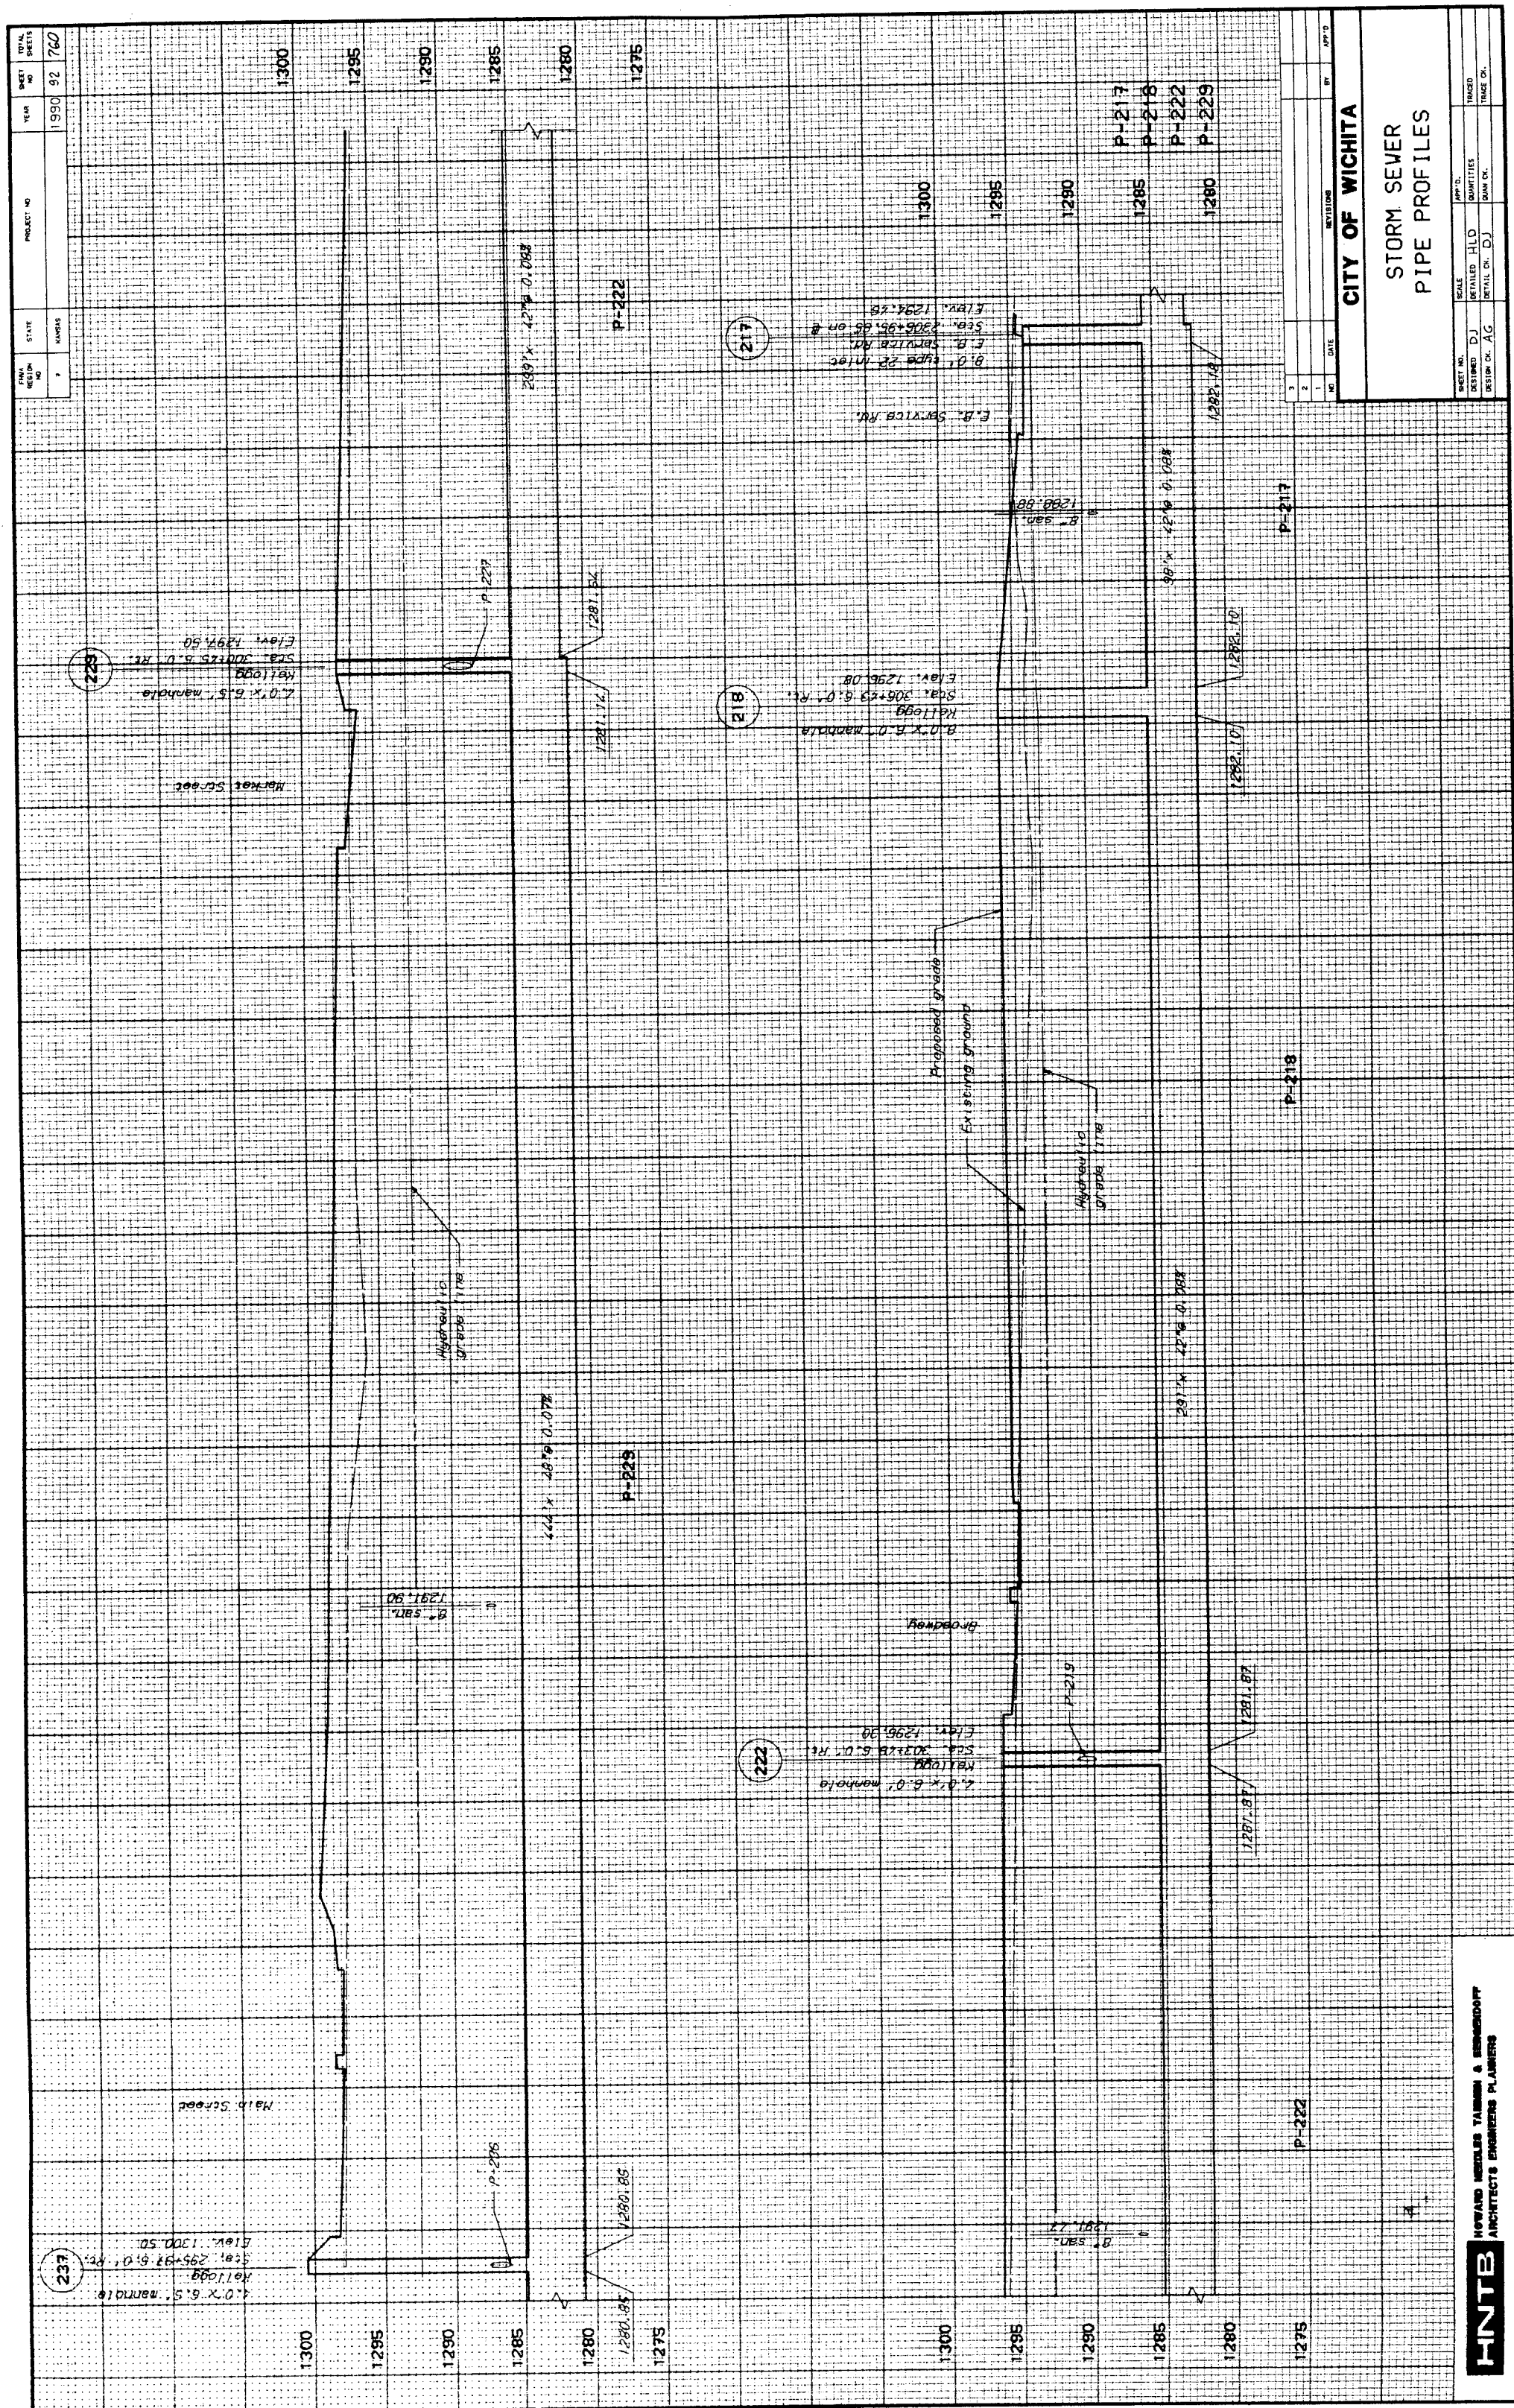

HNTB HOWARD NEEDLES TAMM & BERENSON
ARCHITECTS ENGINEERS PLANNERS

CITY OF WICHITA			
STORM SEWER PIPE PROFILES			
SHEET NO.	SCALE	DATE	BY
EXTENDED	DETAILS	FILE	REVISIONS
EXTEND	EXTEND	EXTEND	EXTEND

DATE	BY	PROJECT NO.	SHEET NO.
1990	92	760	1

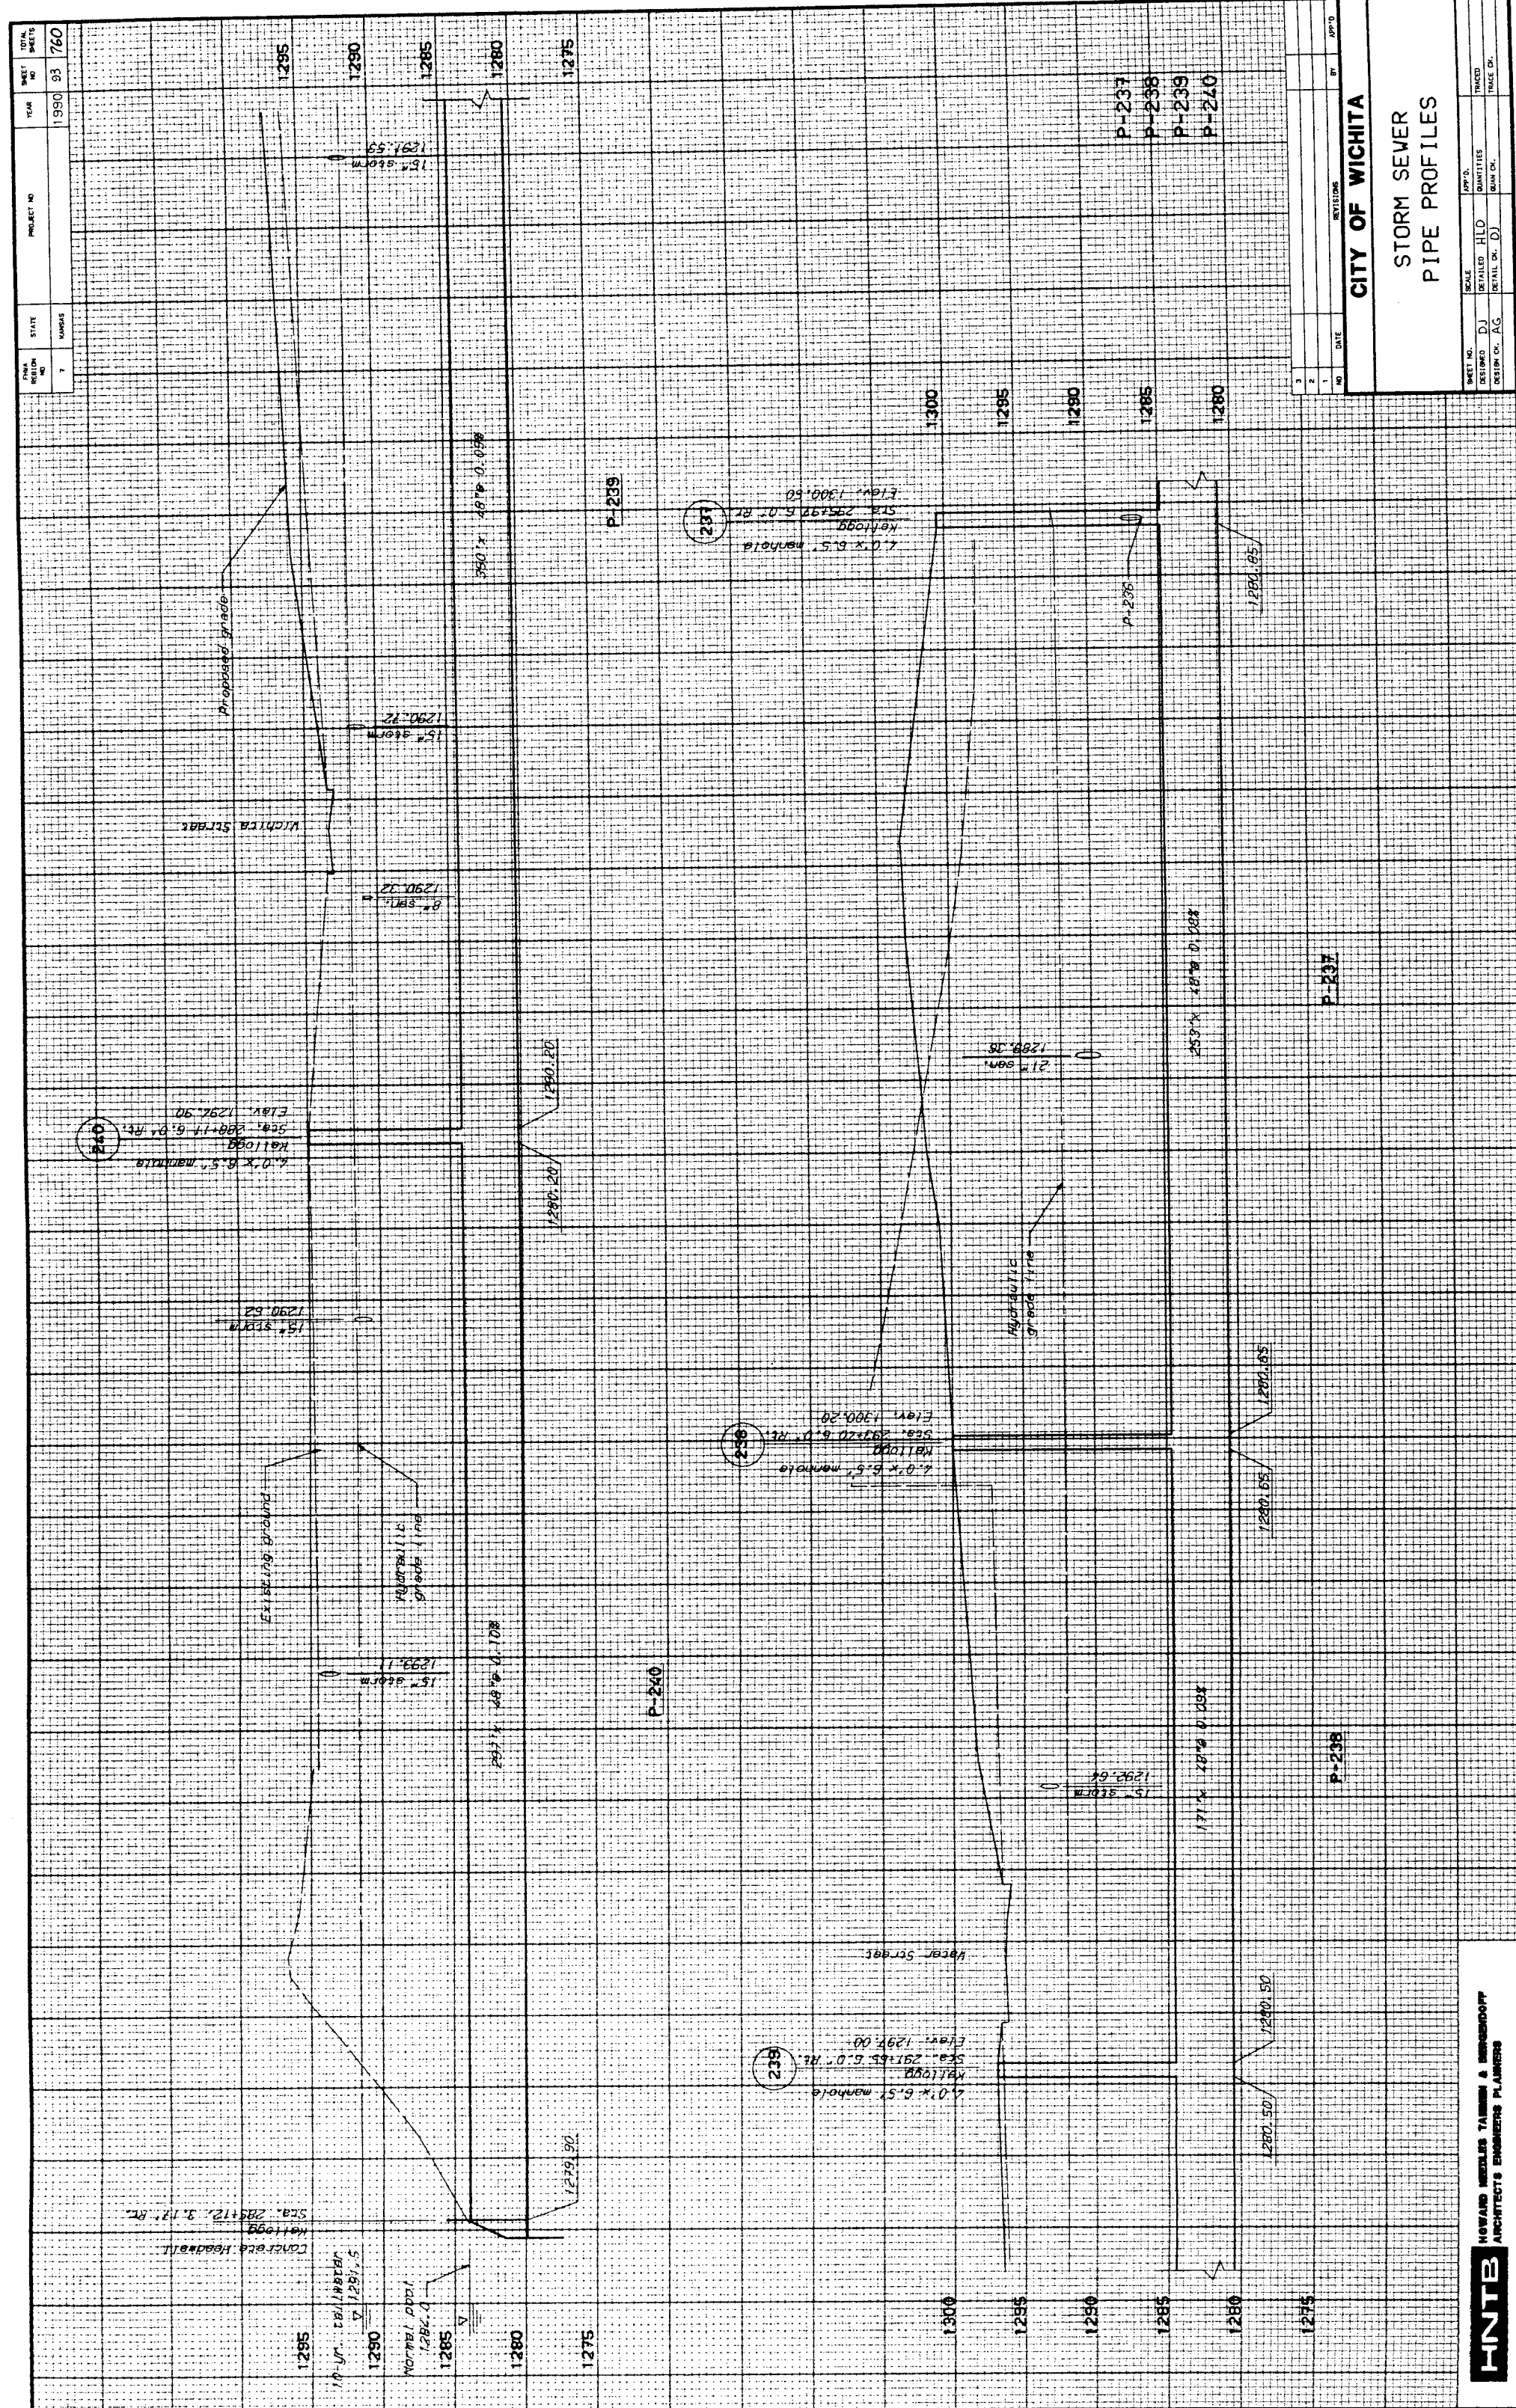


HNTB
HOWARD NEEDLES TAMMEN & BERGENCOFF
ARCHITECTS ENGINEERS PLANNERS

CITY OF WICHITA

STORM SEWER
PIPE PROFILES

NO	DATE	INVESTIGATOR	BY	DATE
1				
2				
3				
100				

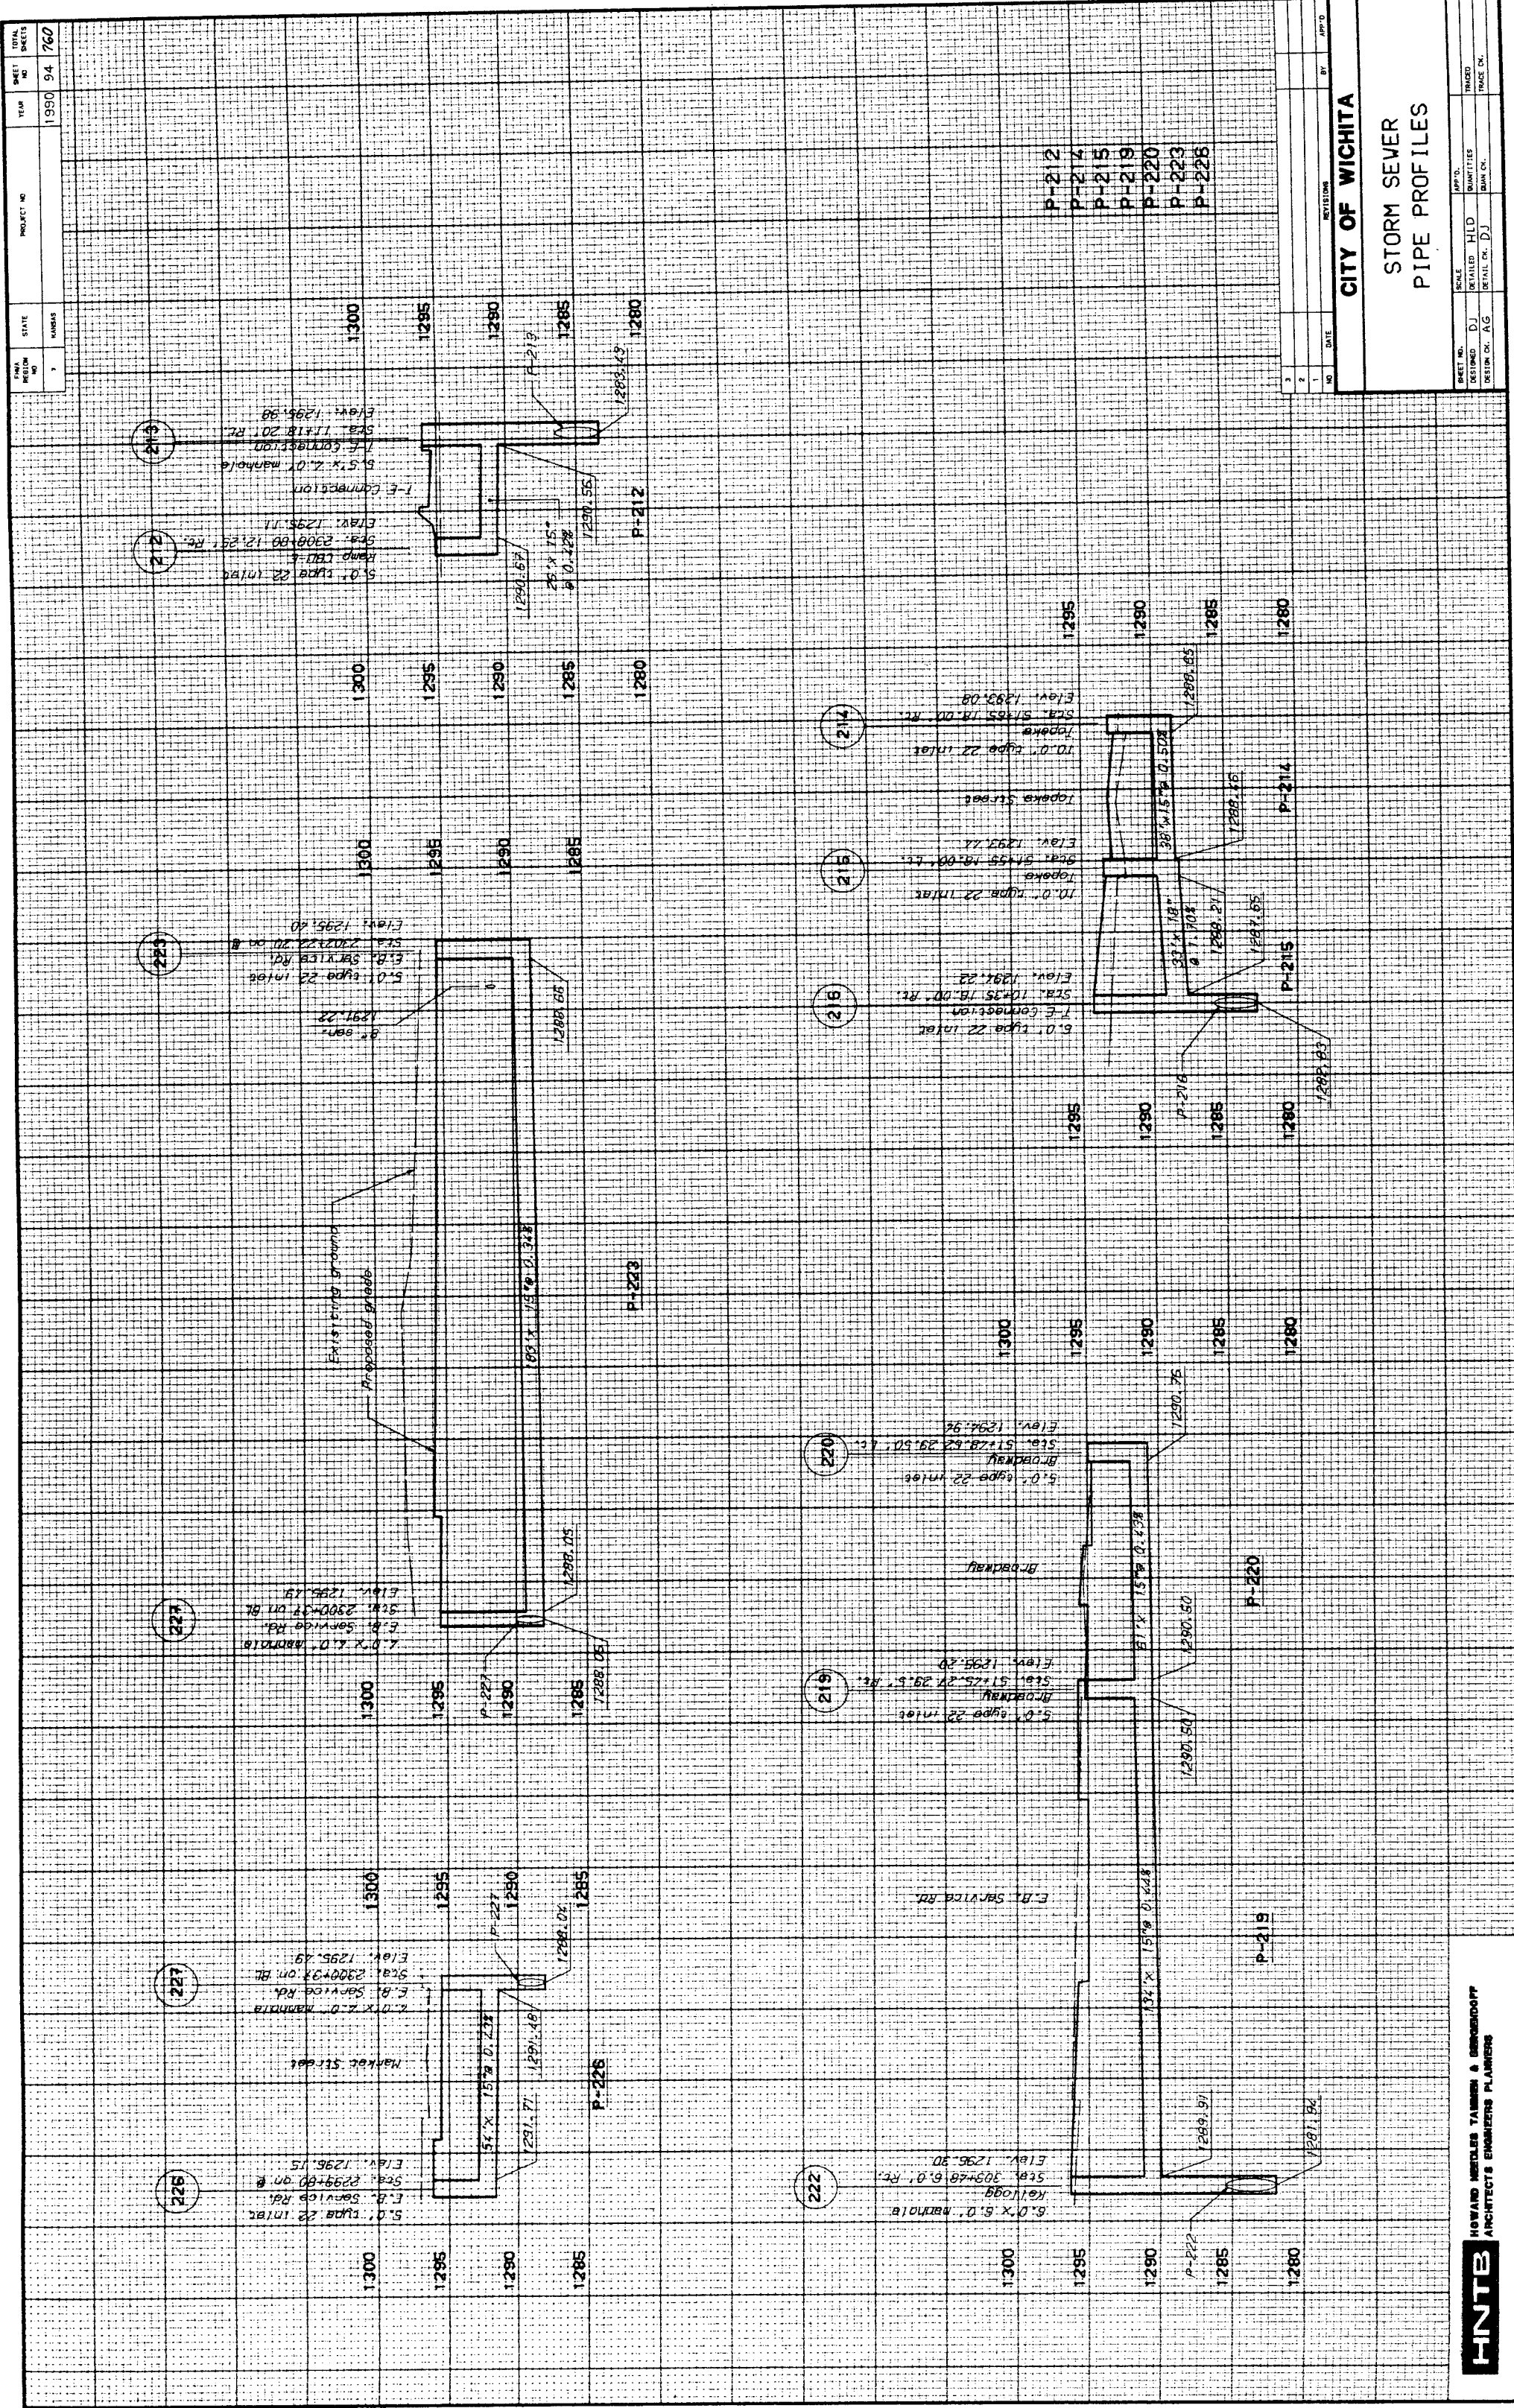


HNTB HOWARD MITCHELL TAYLOR & BERENSON
ARCHITECTS ENGINEERS PLANNERS

CITY OF WICHITA

**STORM SEWER
PIPE PROFILES**

DATE	SCALE	BY	CHECKED	DATE
10/1/00	AS SHOWN	DJ	HLD	10/1/00
10/1/00	AS SHOWN	DJ	DATE	10/1/00


DATE	SCALE	BY	CHECKED	DATE
10/1/00	AS SHOWN	DJ	HLD	10/1/00
10/1/00	AS SHOWN	DJ	DATE	10/1/00

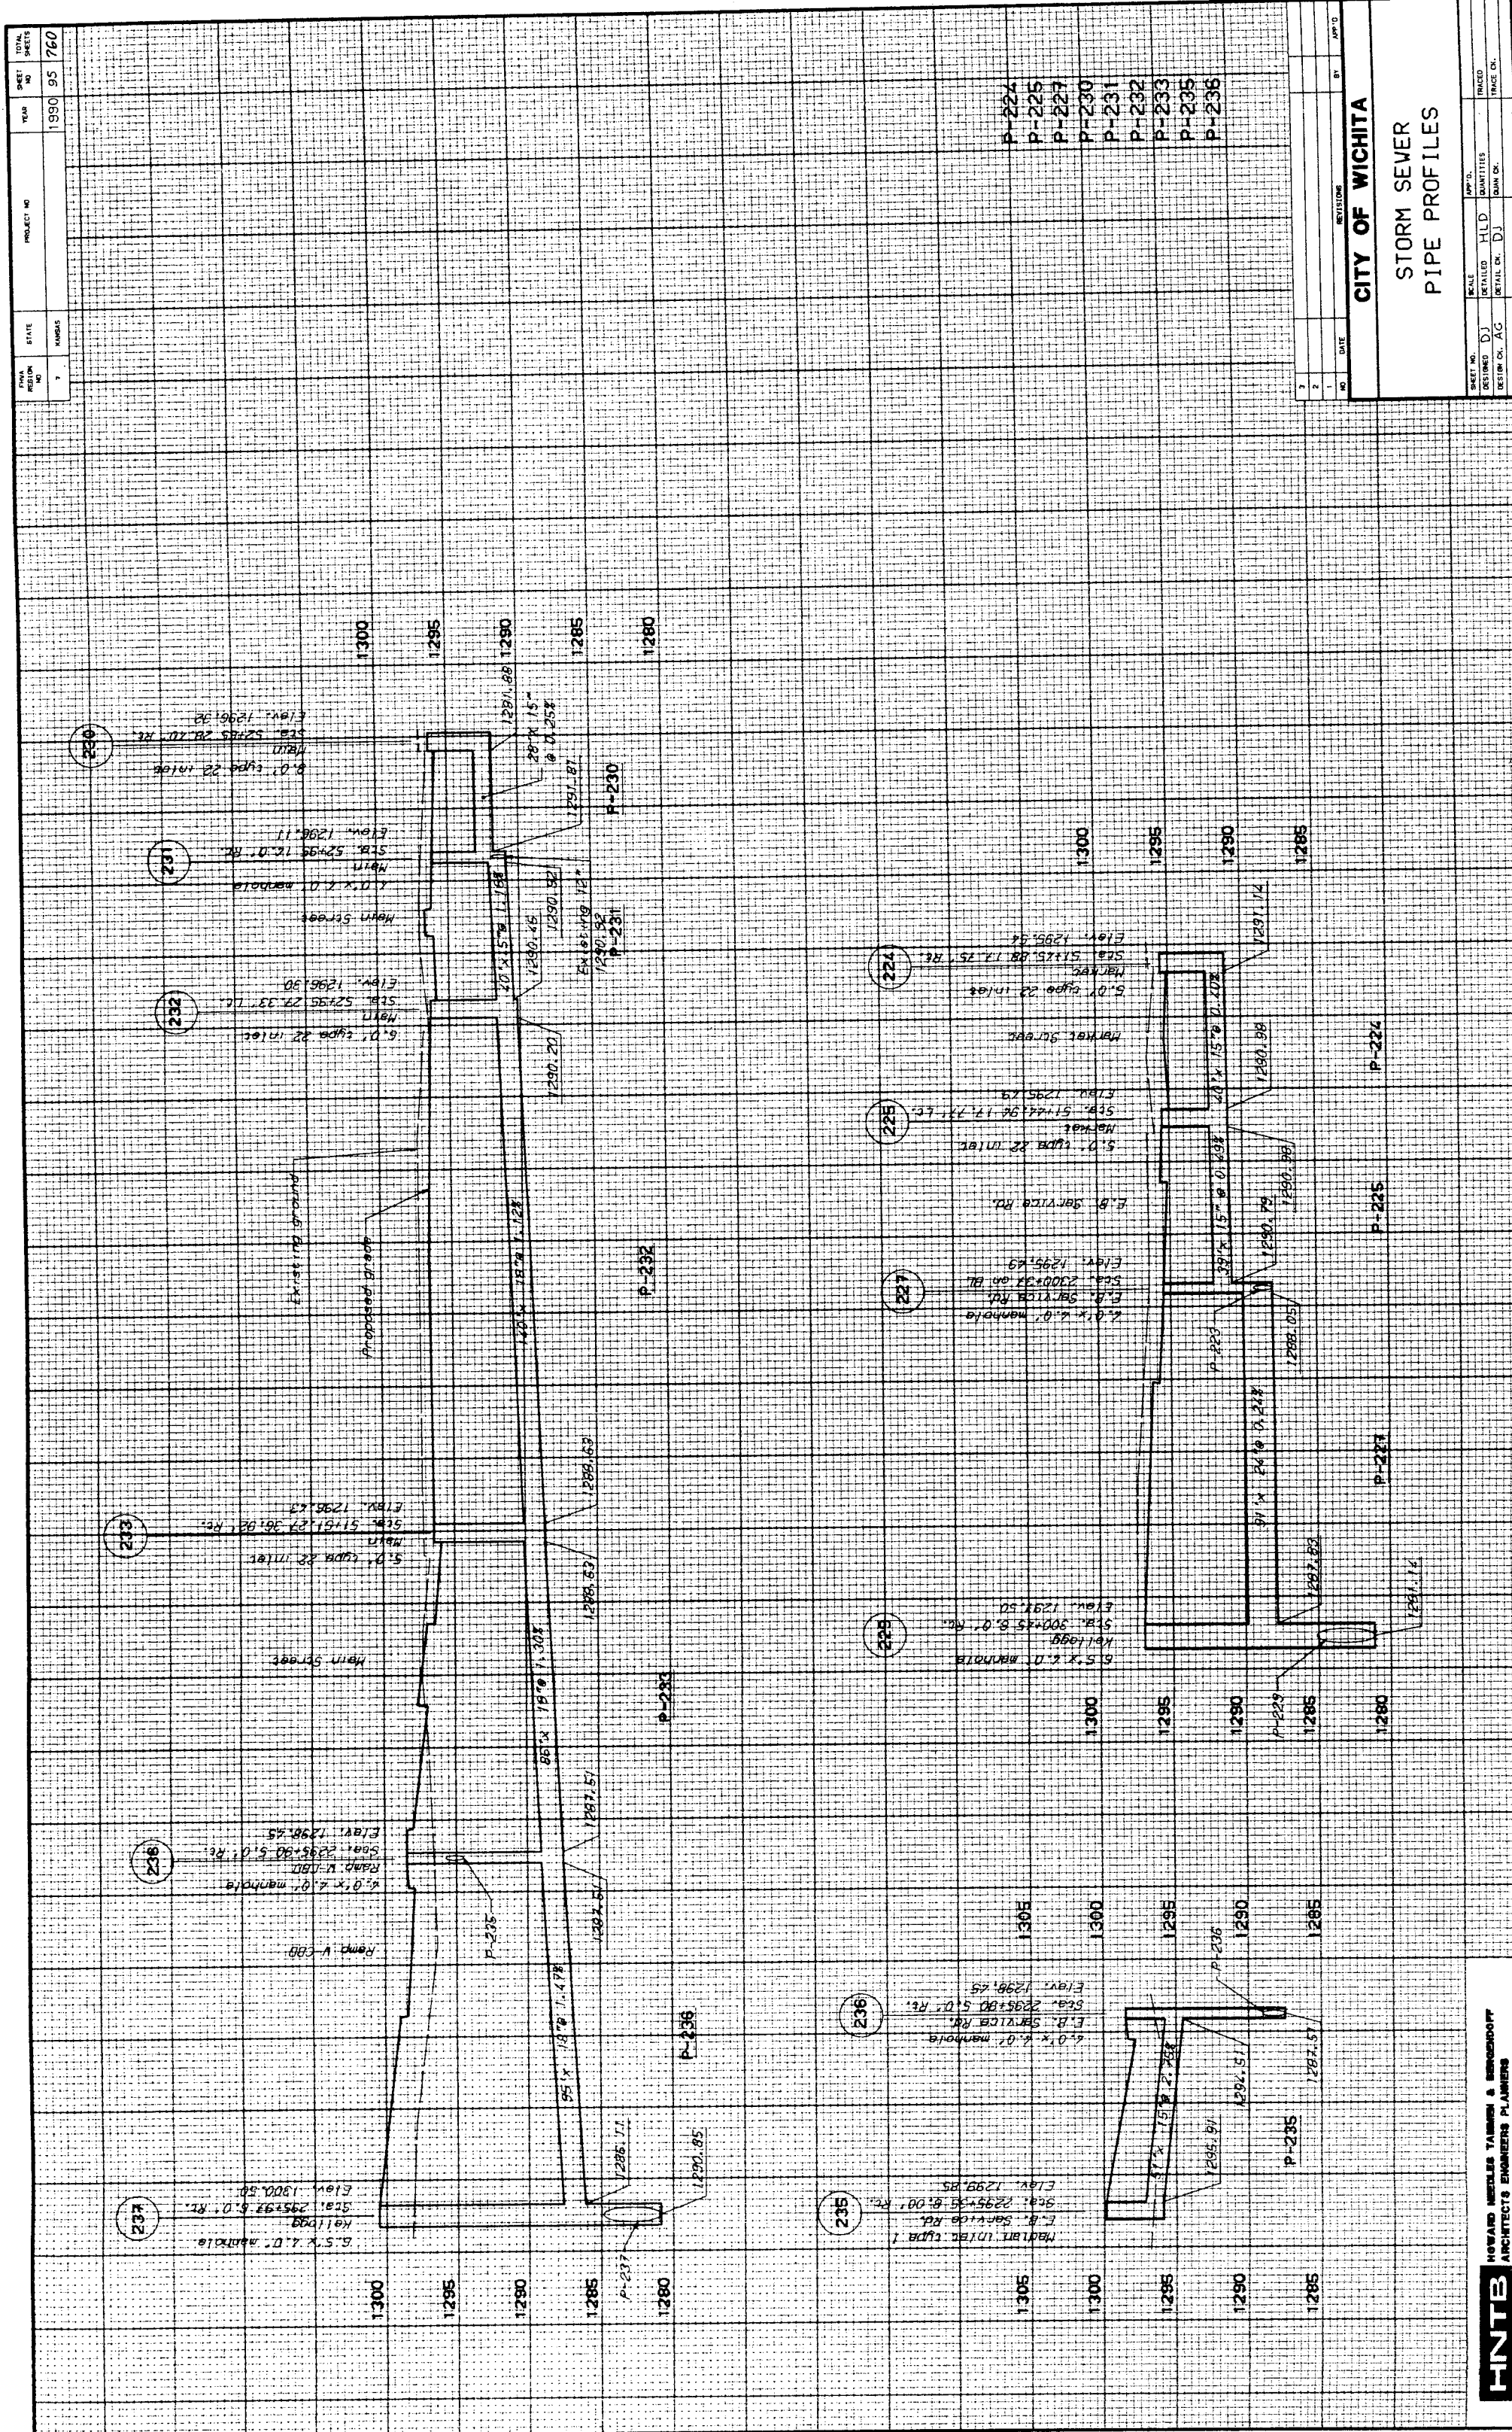


PROJECT NO.	1990 95 760
DATE	7/8/85
BY	Y
CHECKED	
DATE	
BY	

CITY OF WICHITA	
STORM SEWER PIPE PROFILES	
PROJECT NO.	1990 95 760
DATE	7/8/85
BY	Y
CHECKED	
DATE	
BY	

HNTB HOWARD NEEDLES TAMM & BERNDTSON
ARCHITECTS ENGINEERS PLANNERS

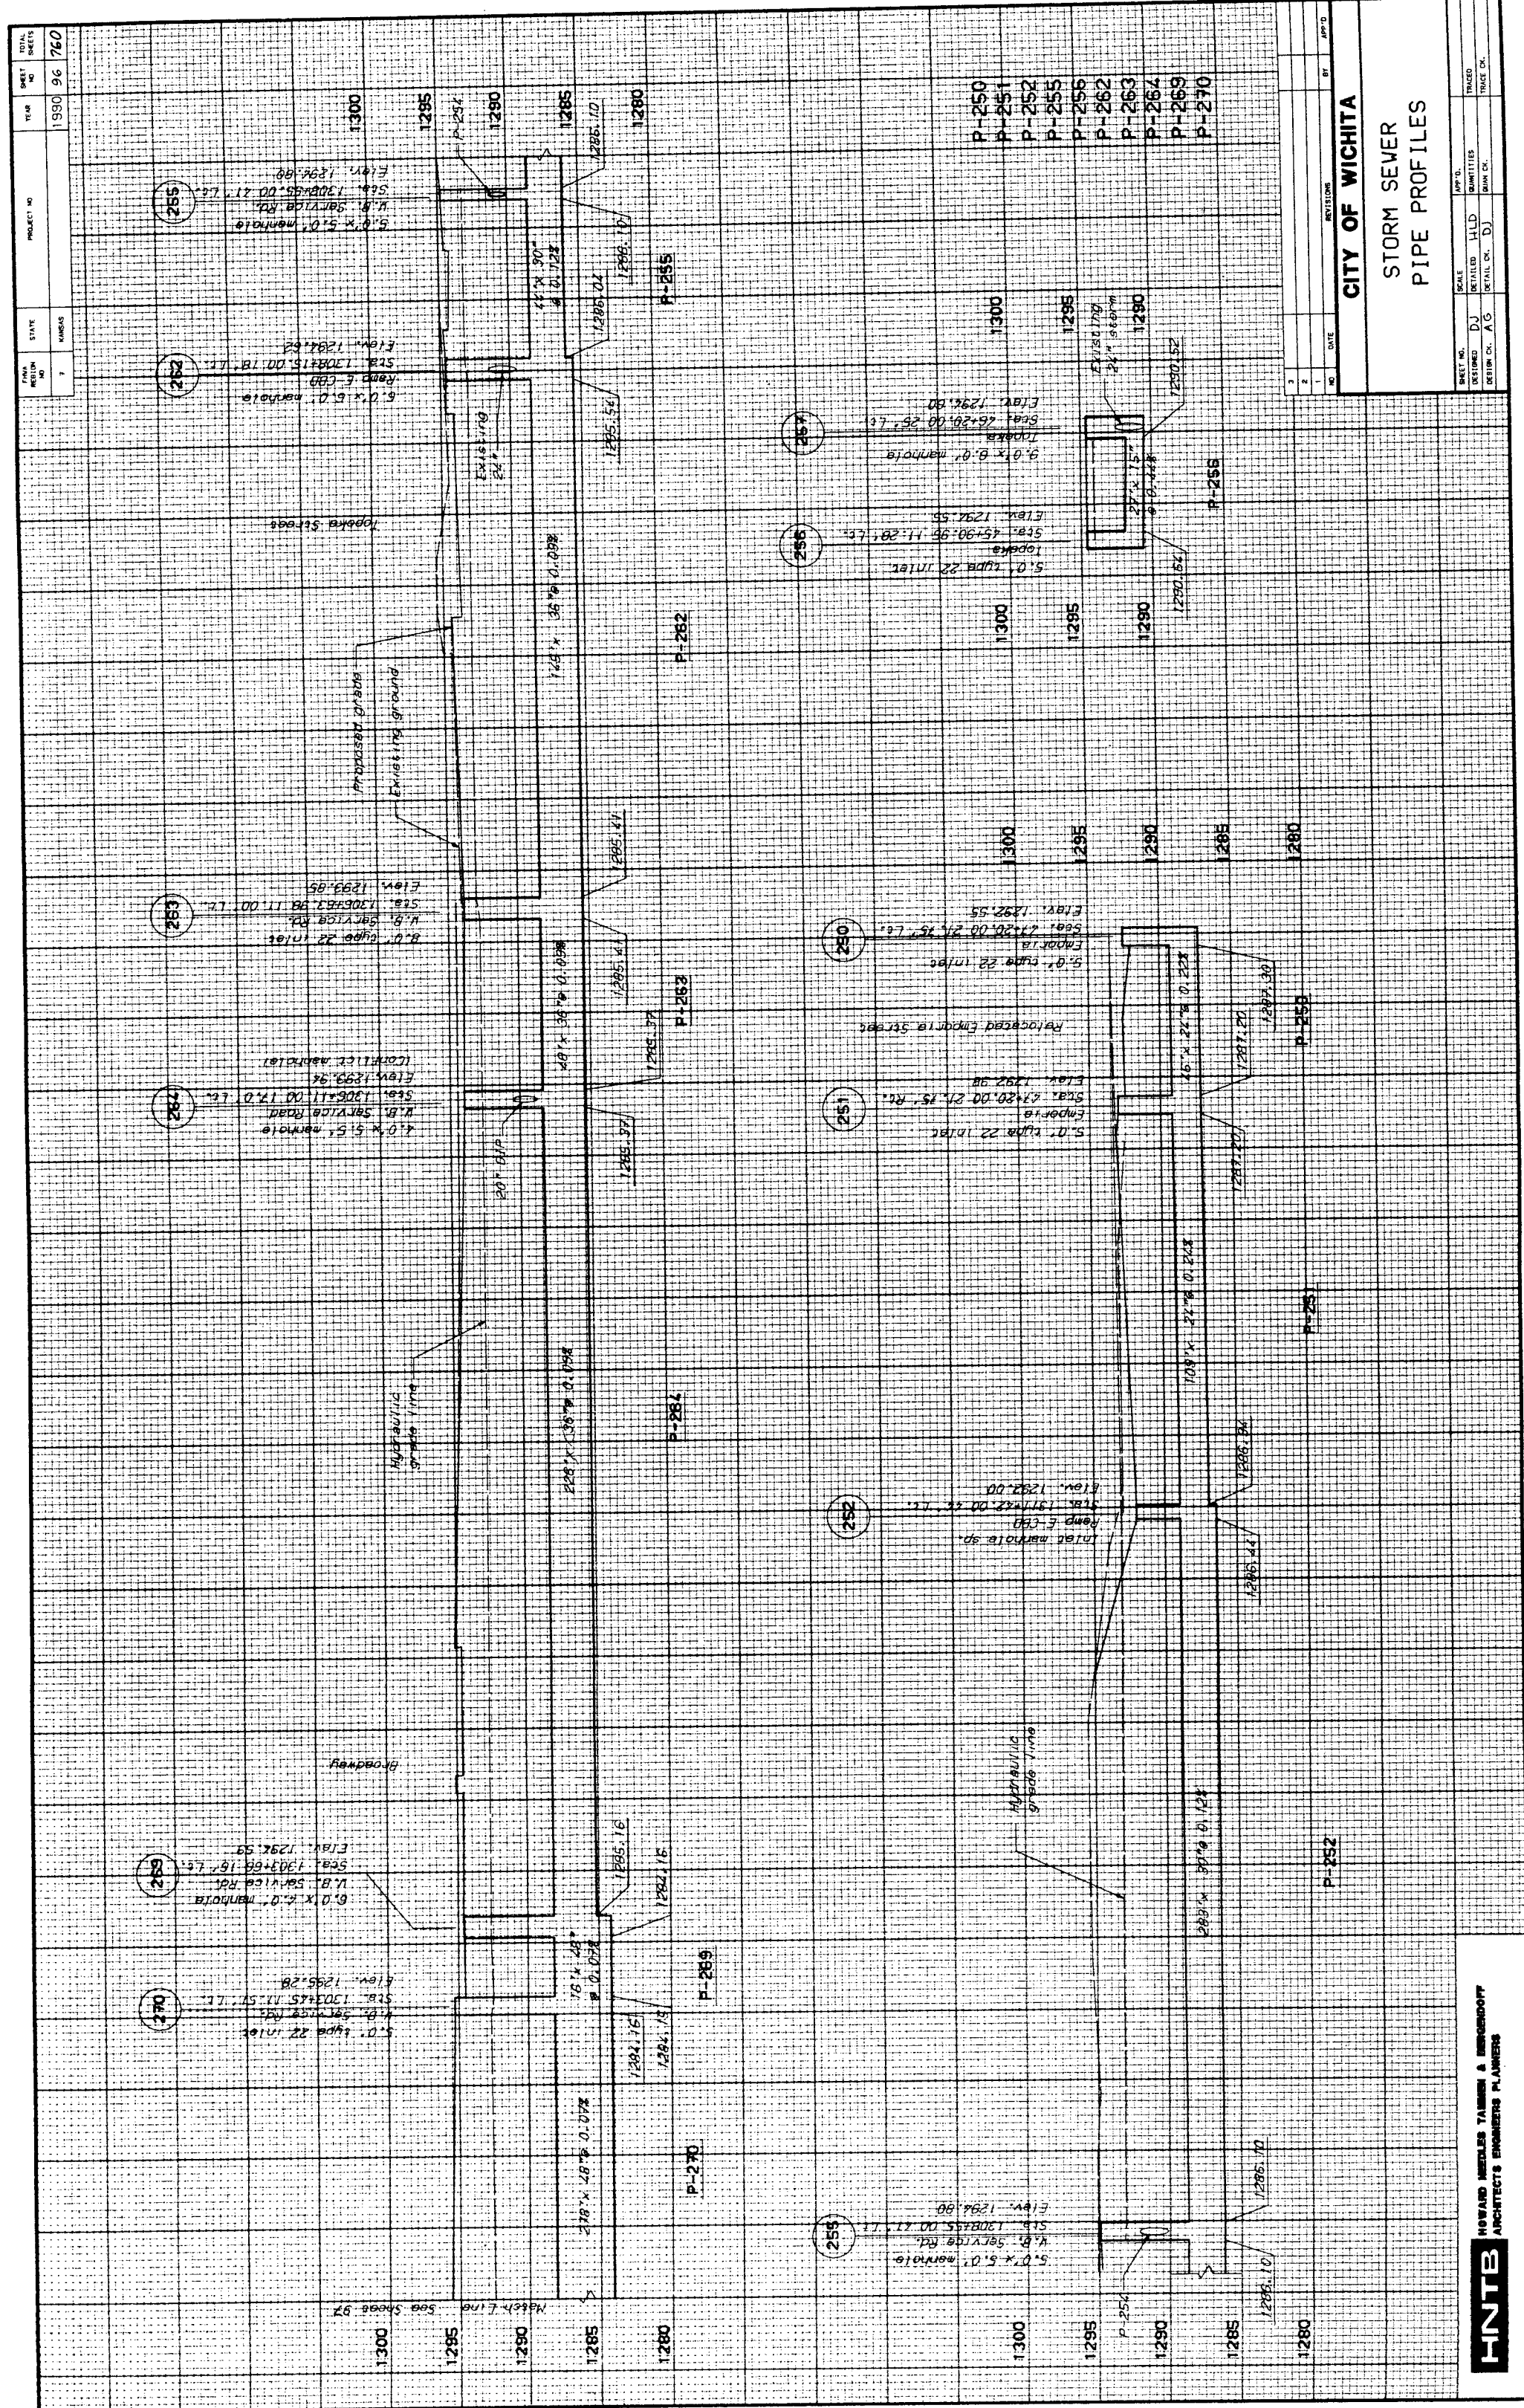

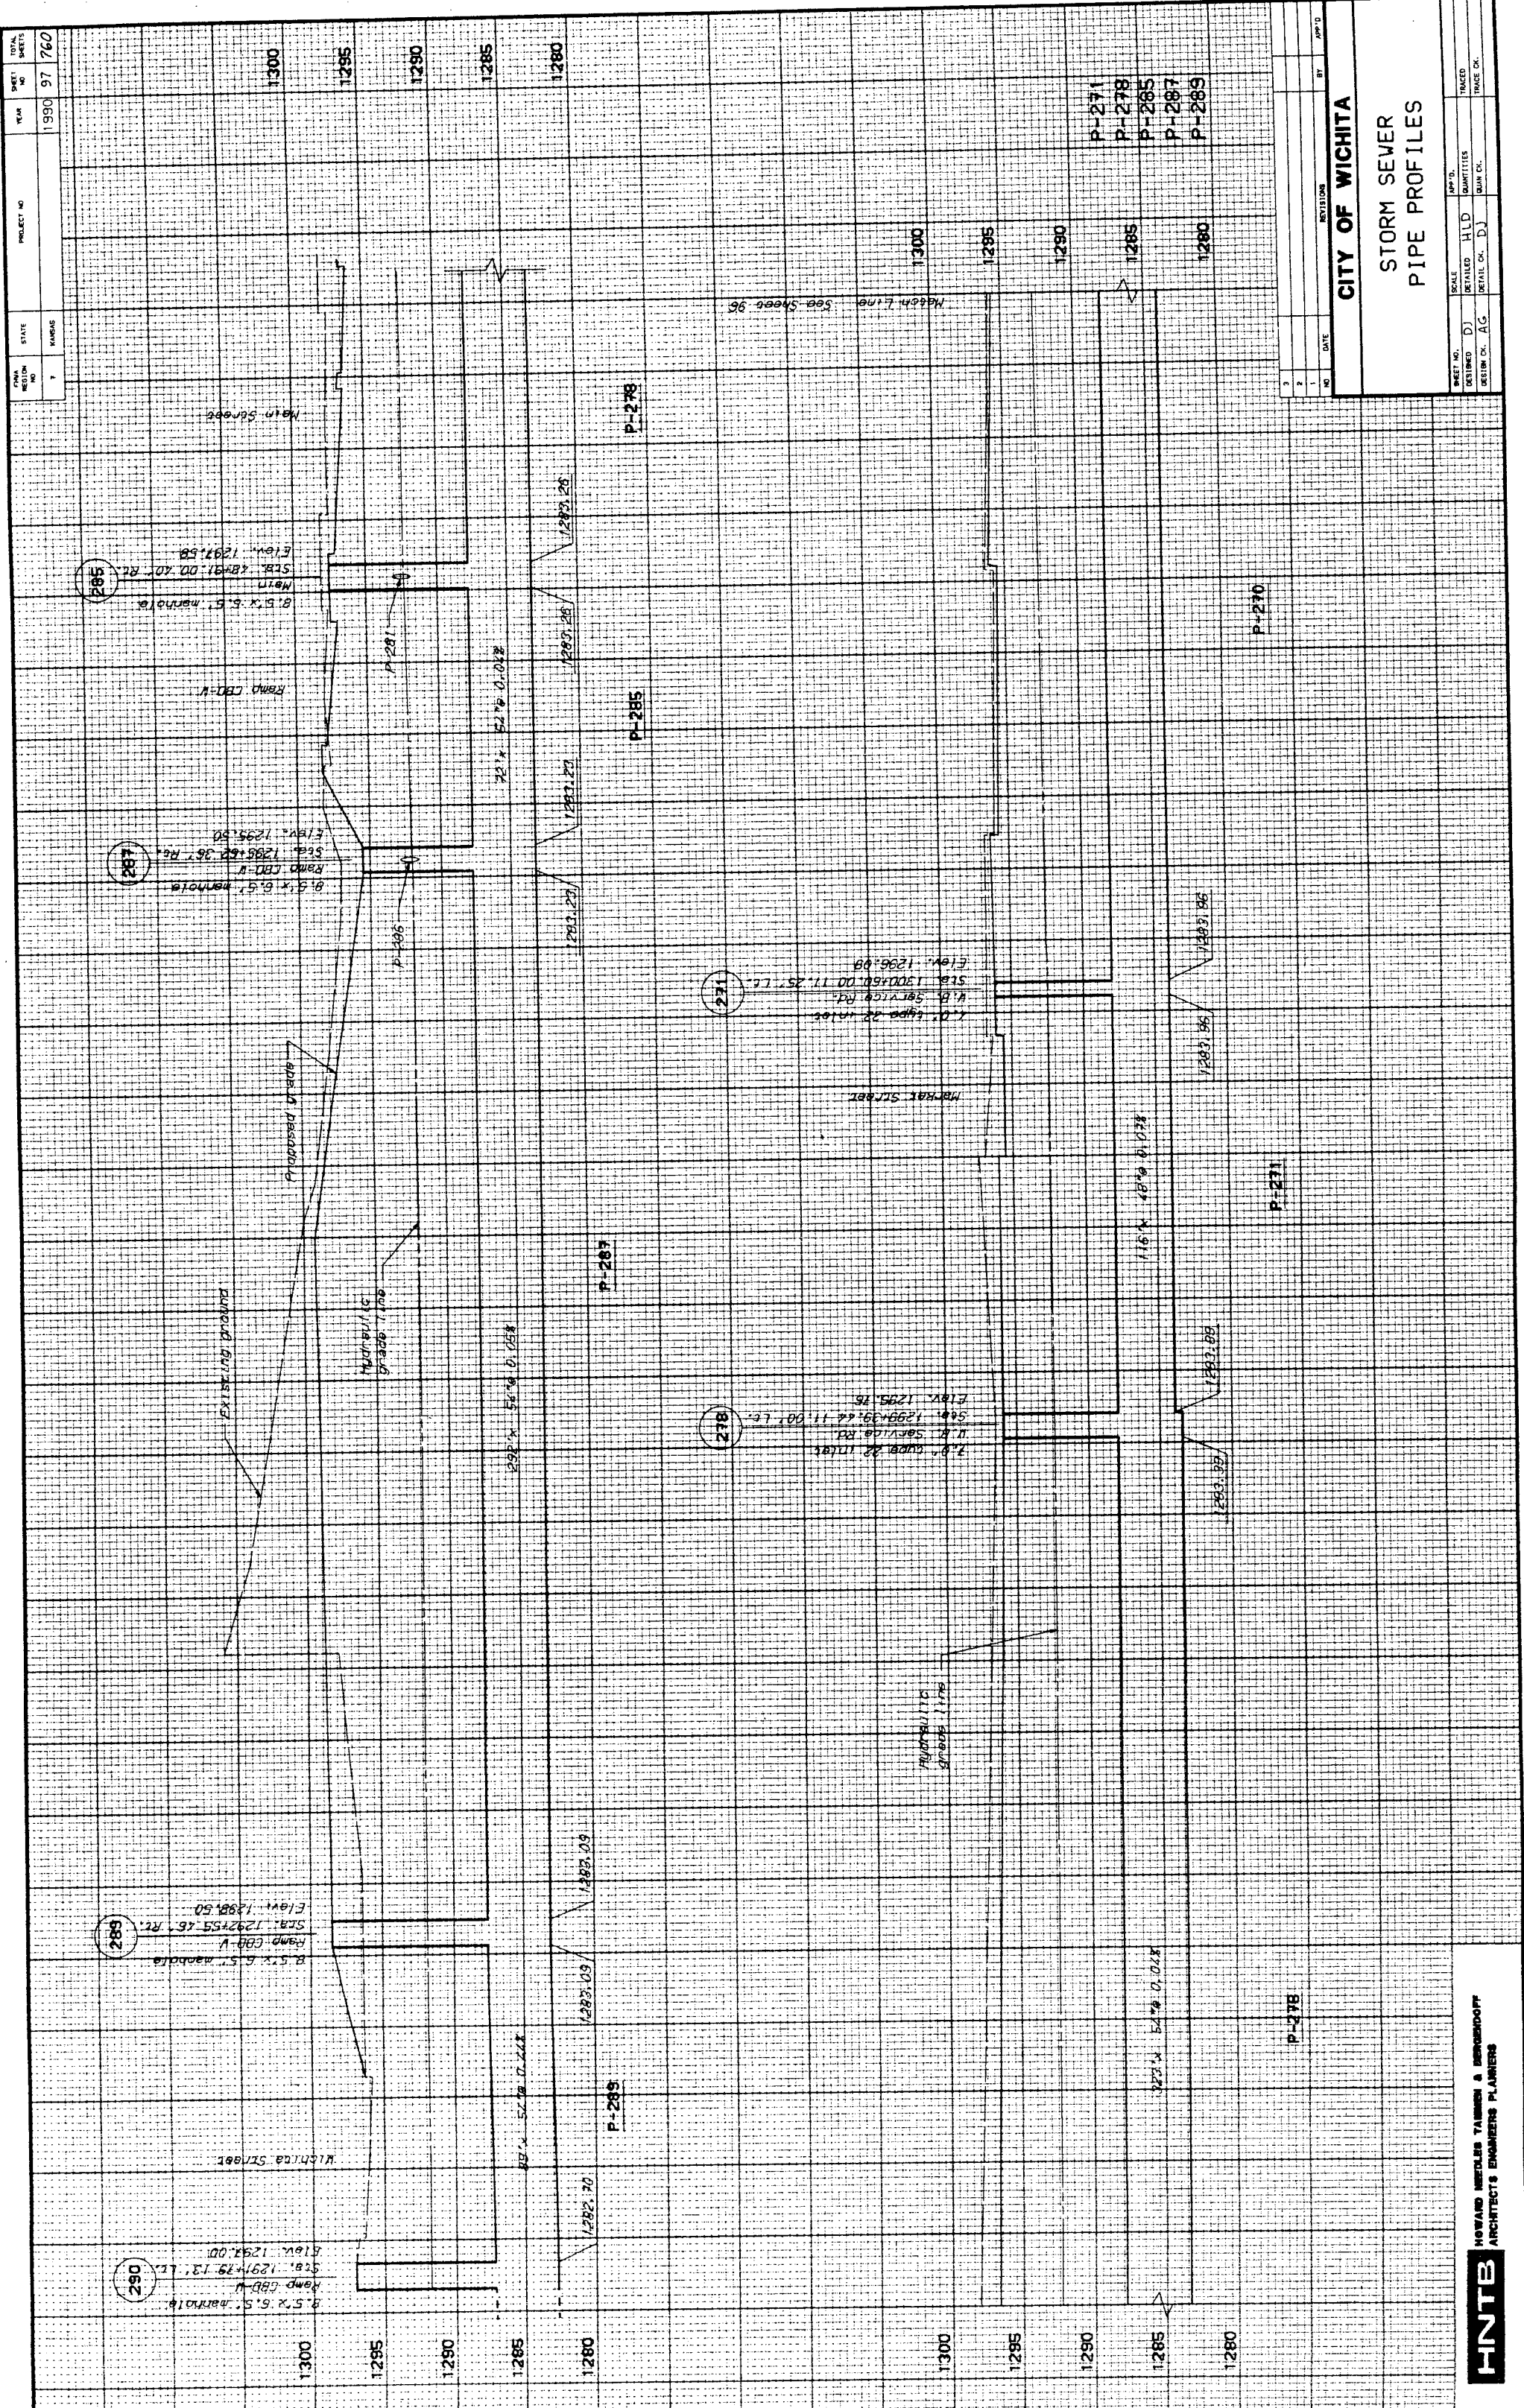

NO.	DATE	REVISION
1		
2		
3		
100		


CITY OF WICHITA
STORM SEWER
PIPE PROFILES


NO. DATE REVISION


1 2 3 100

NO. DATE REVISION

1 2 3 100

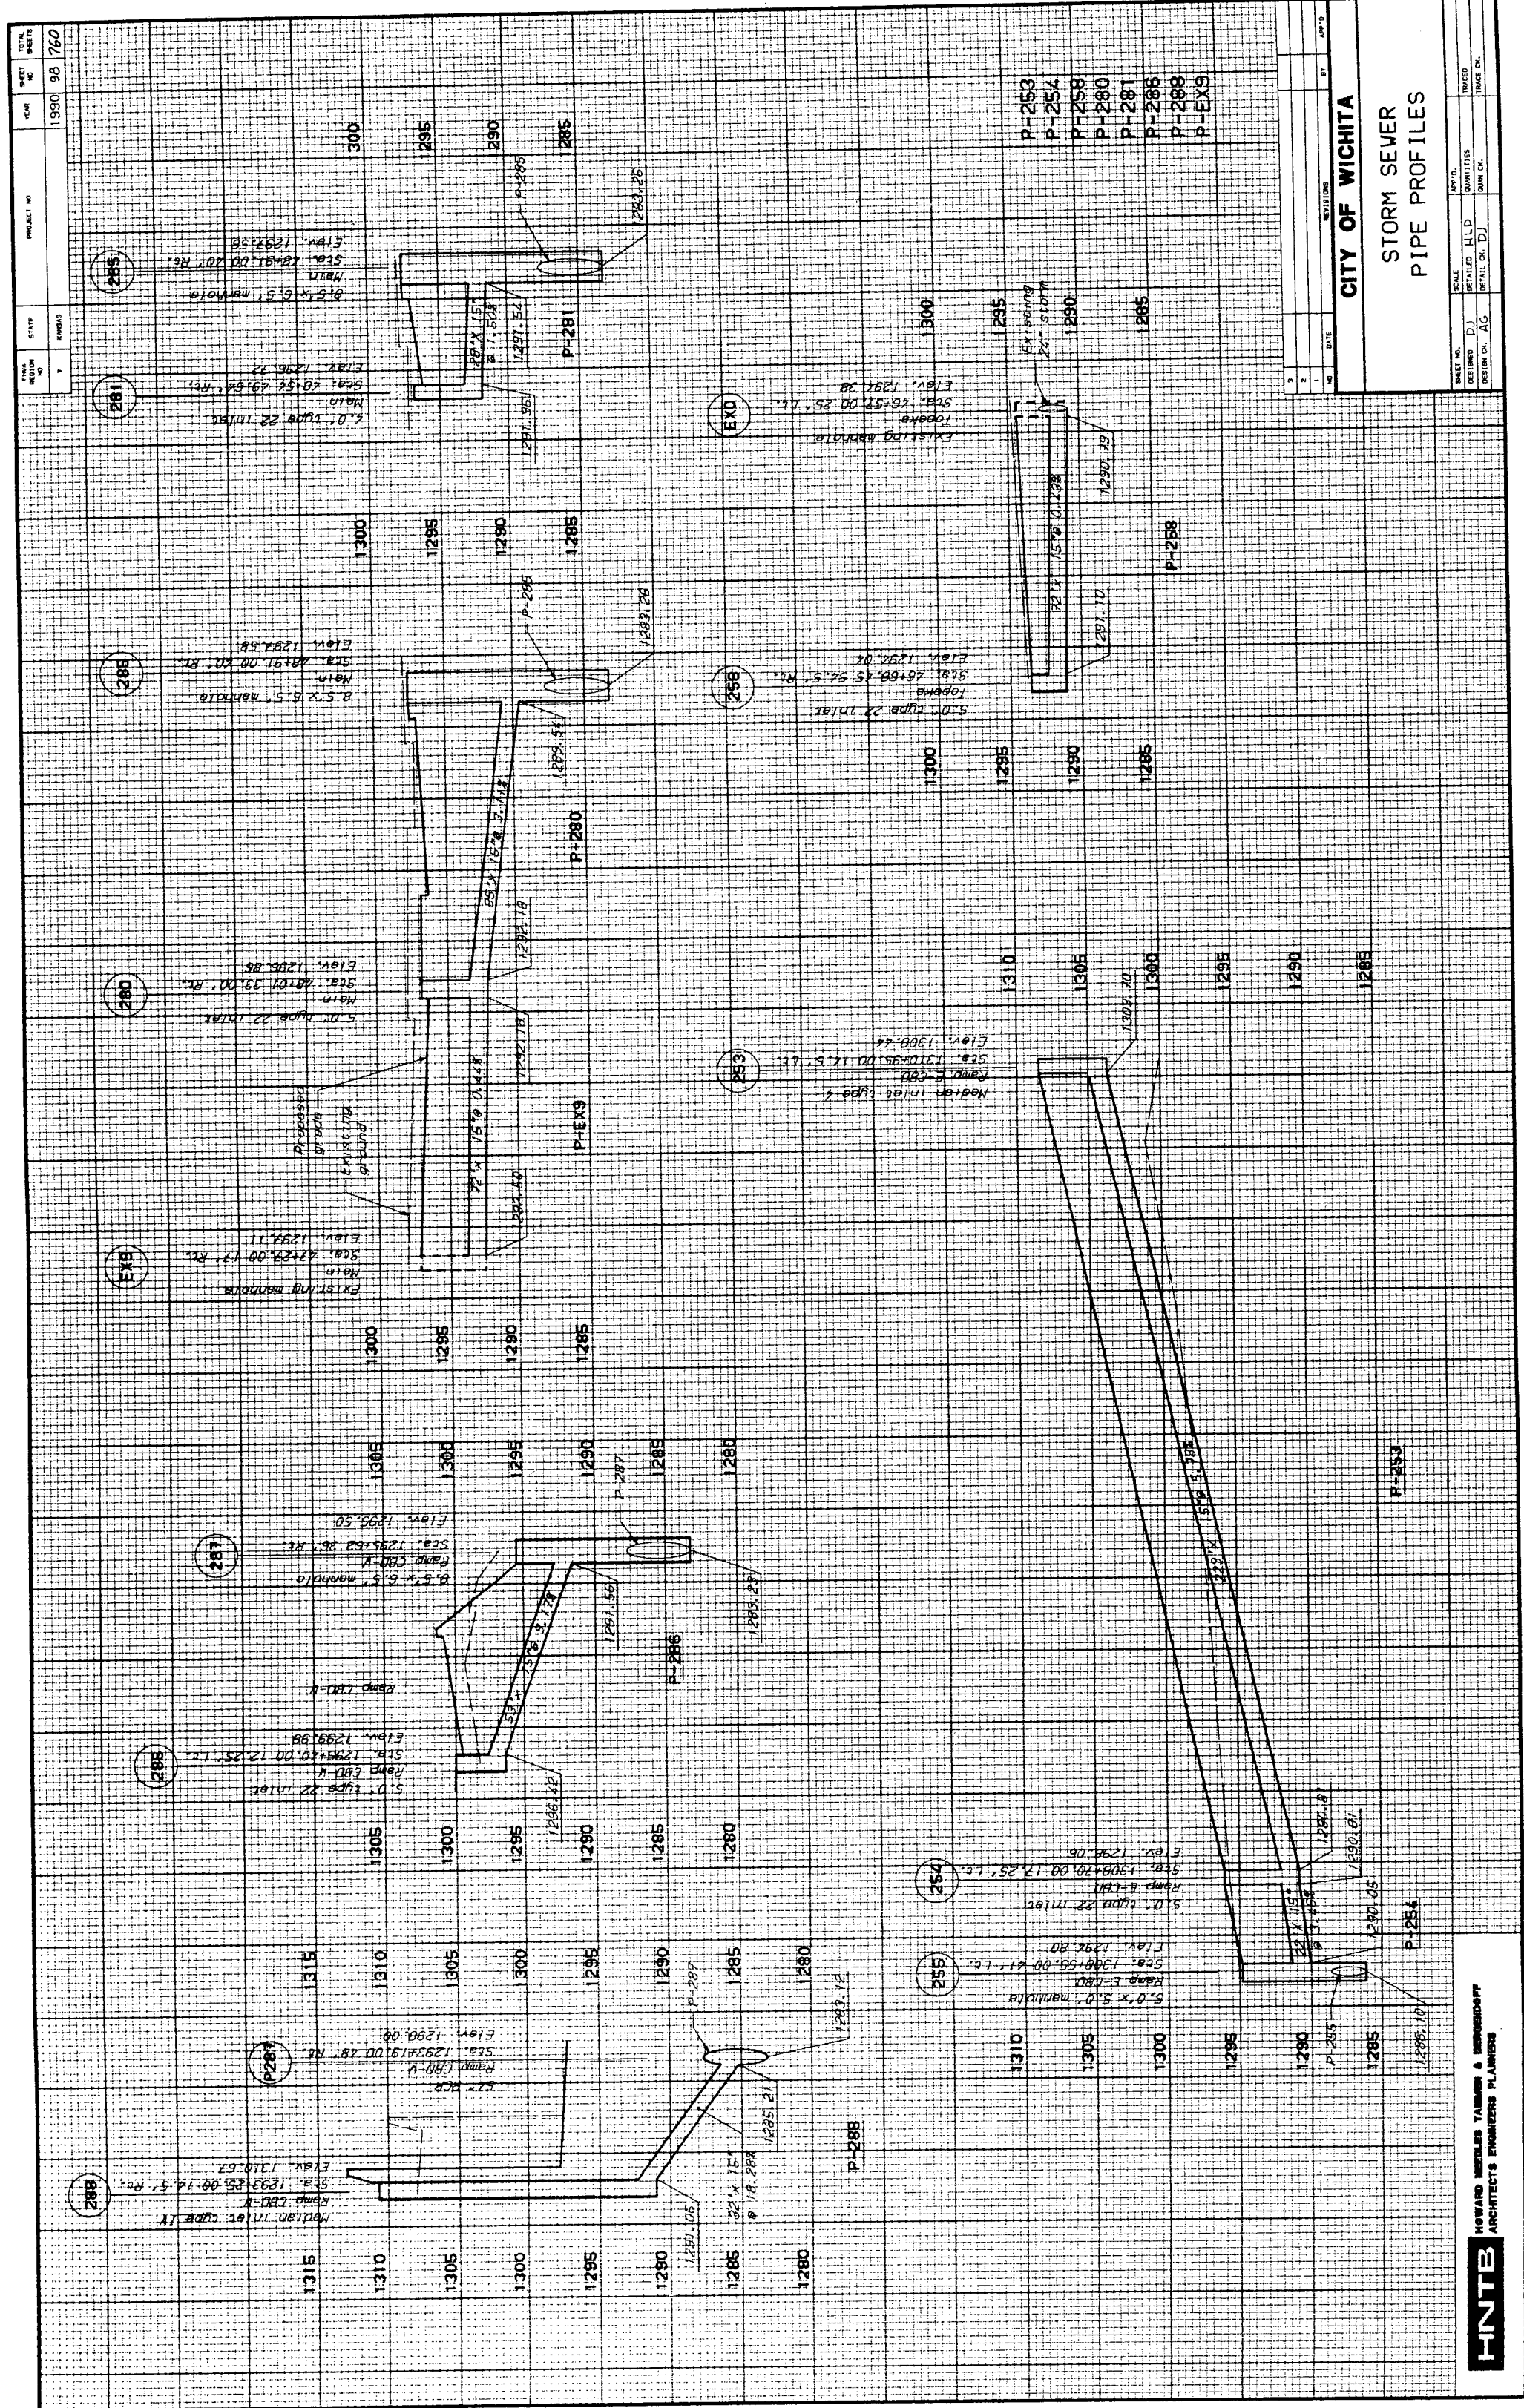

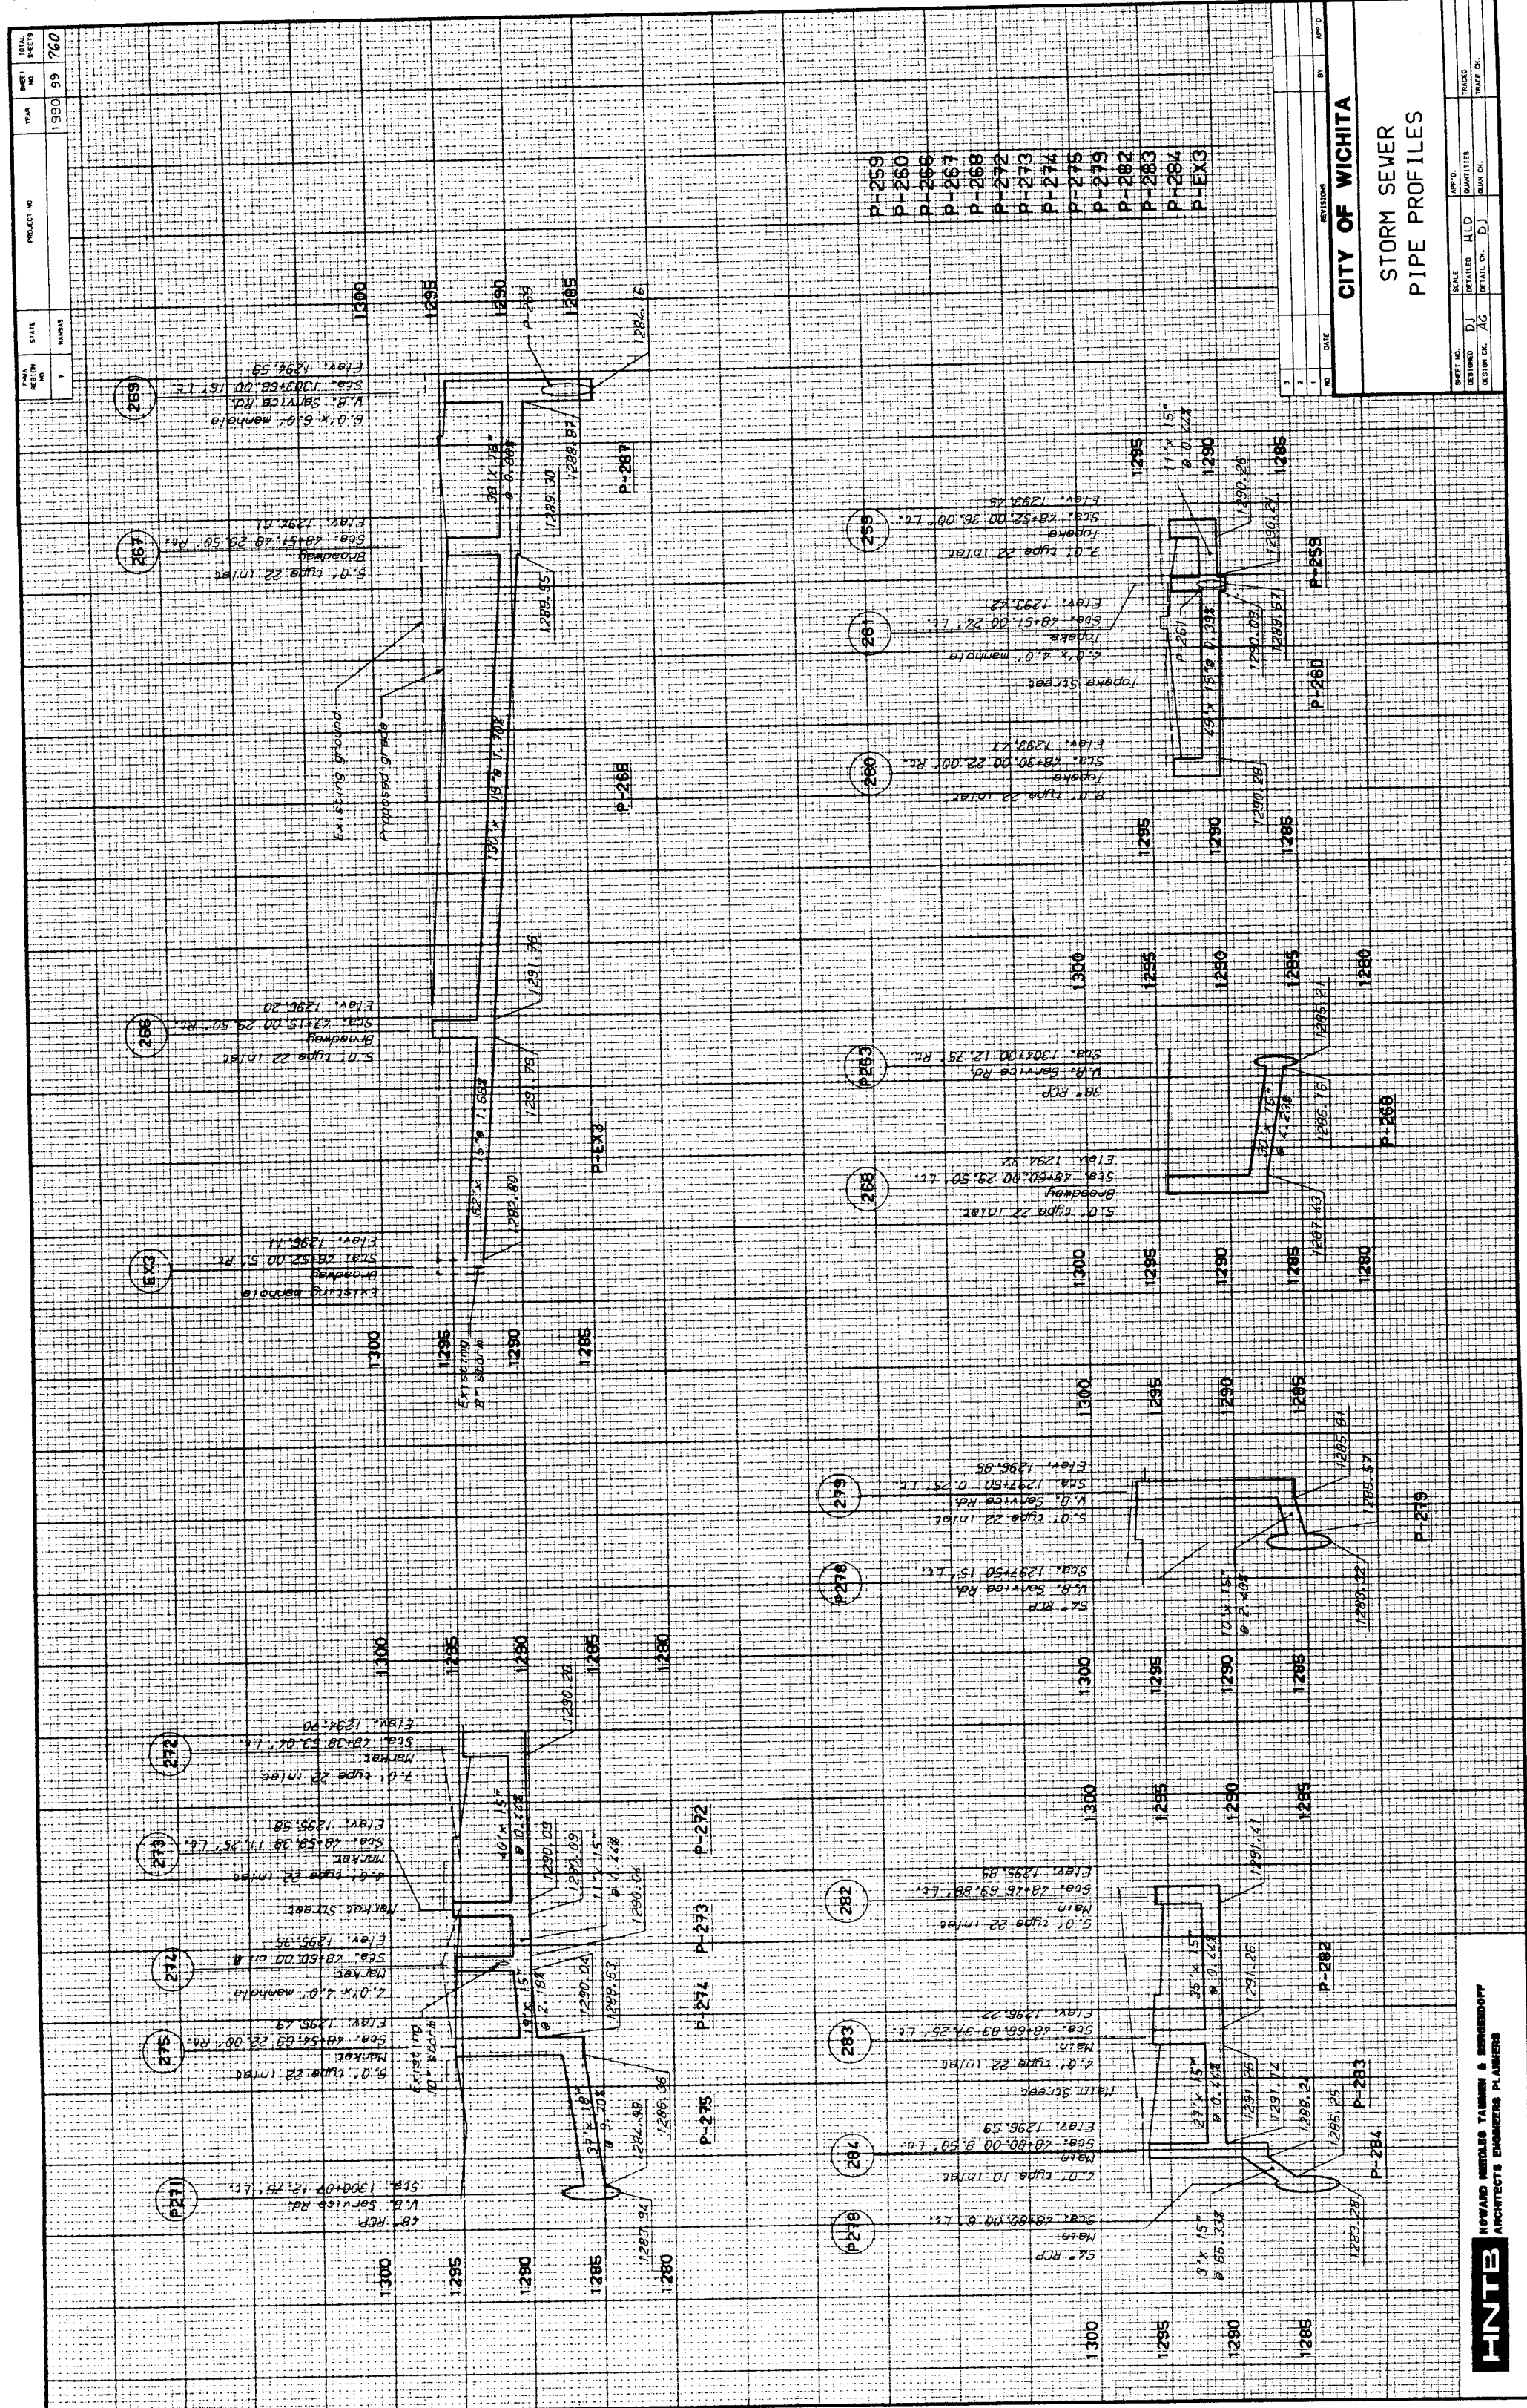

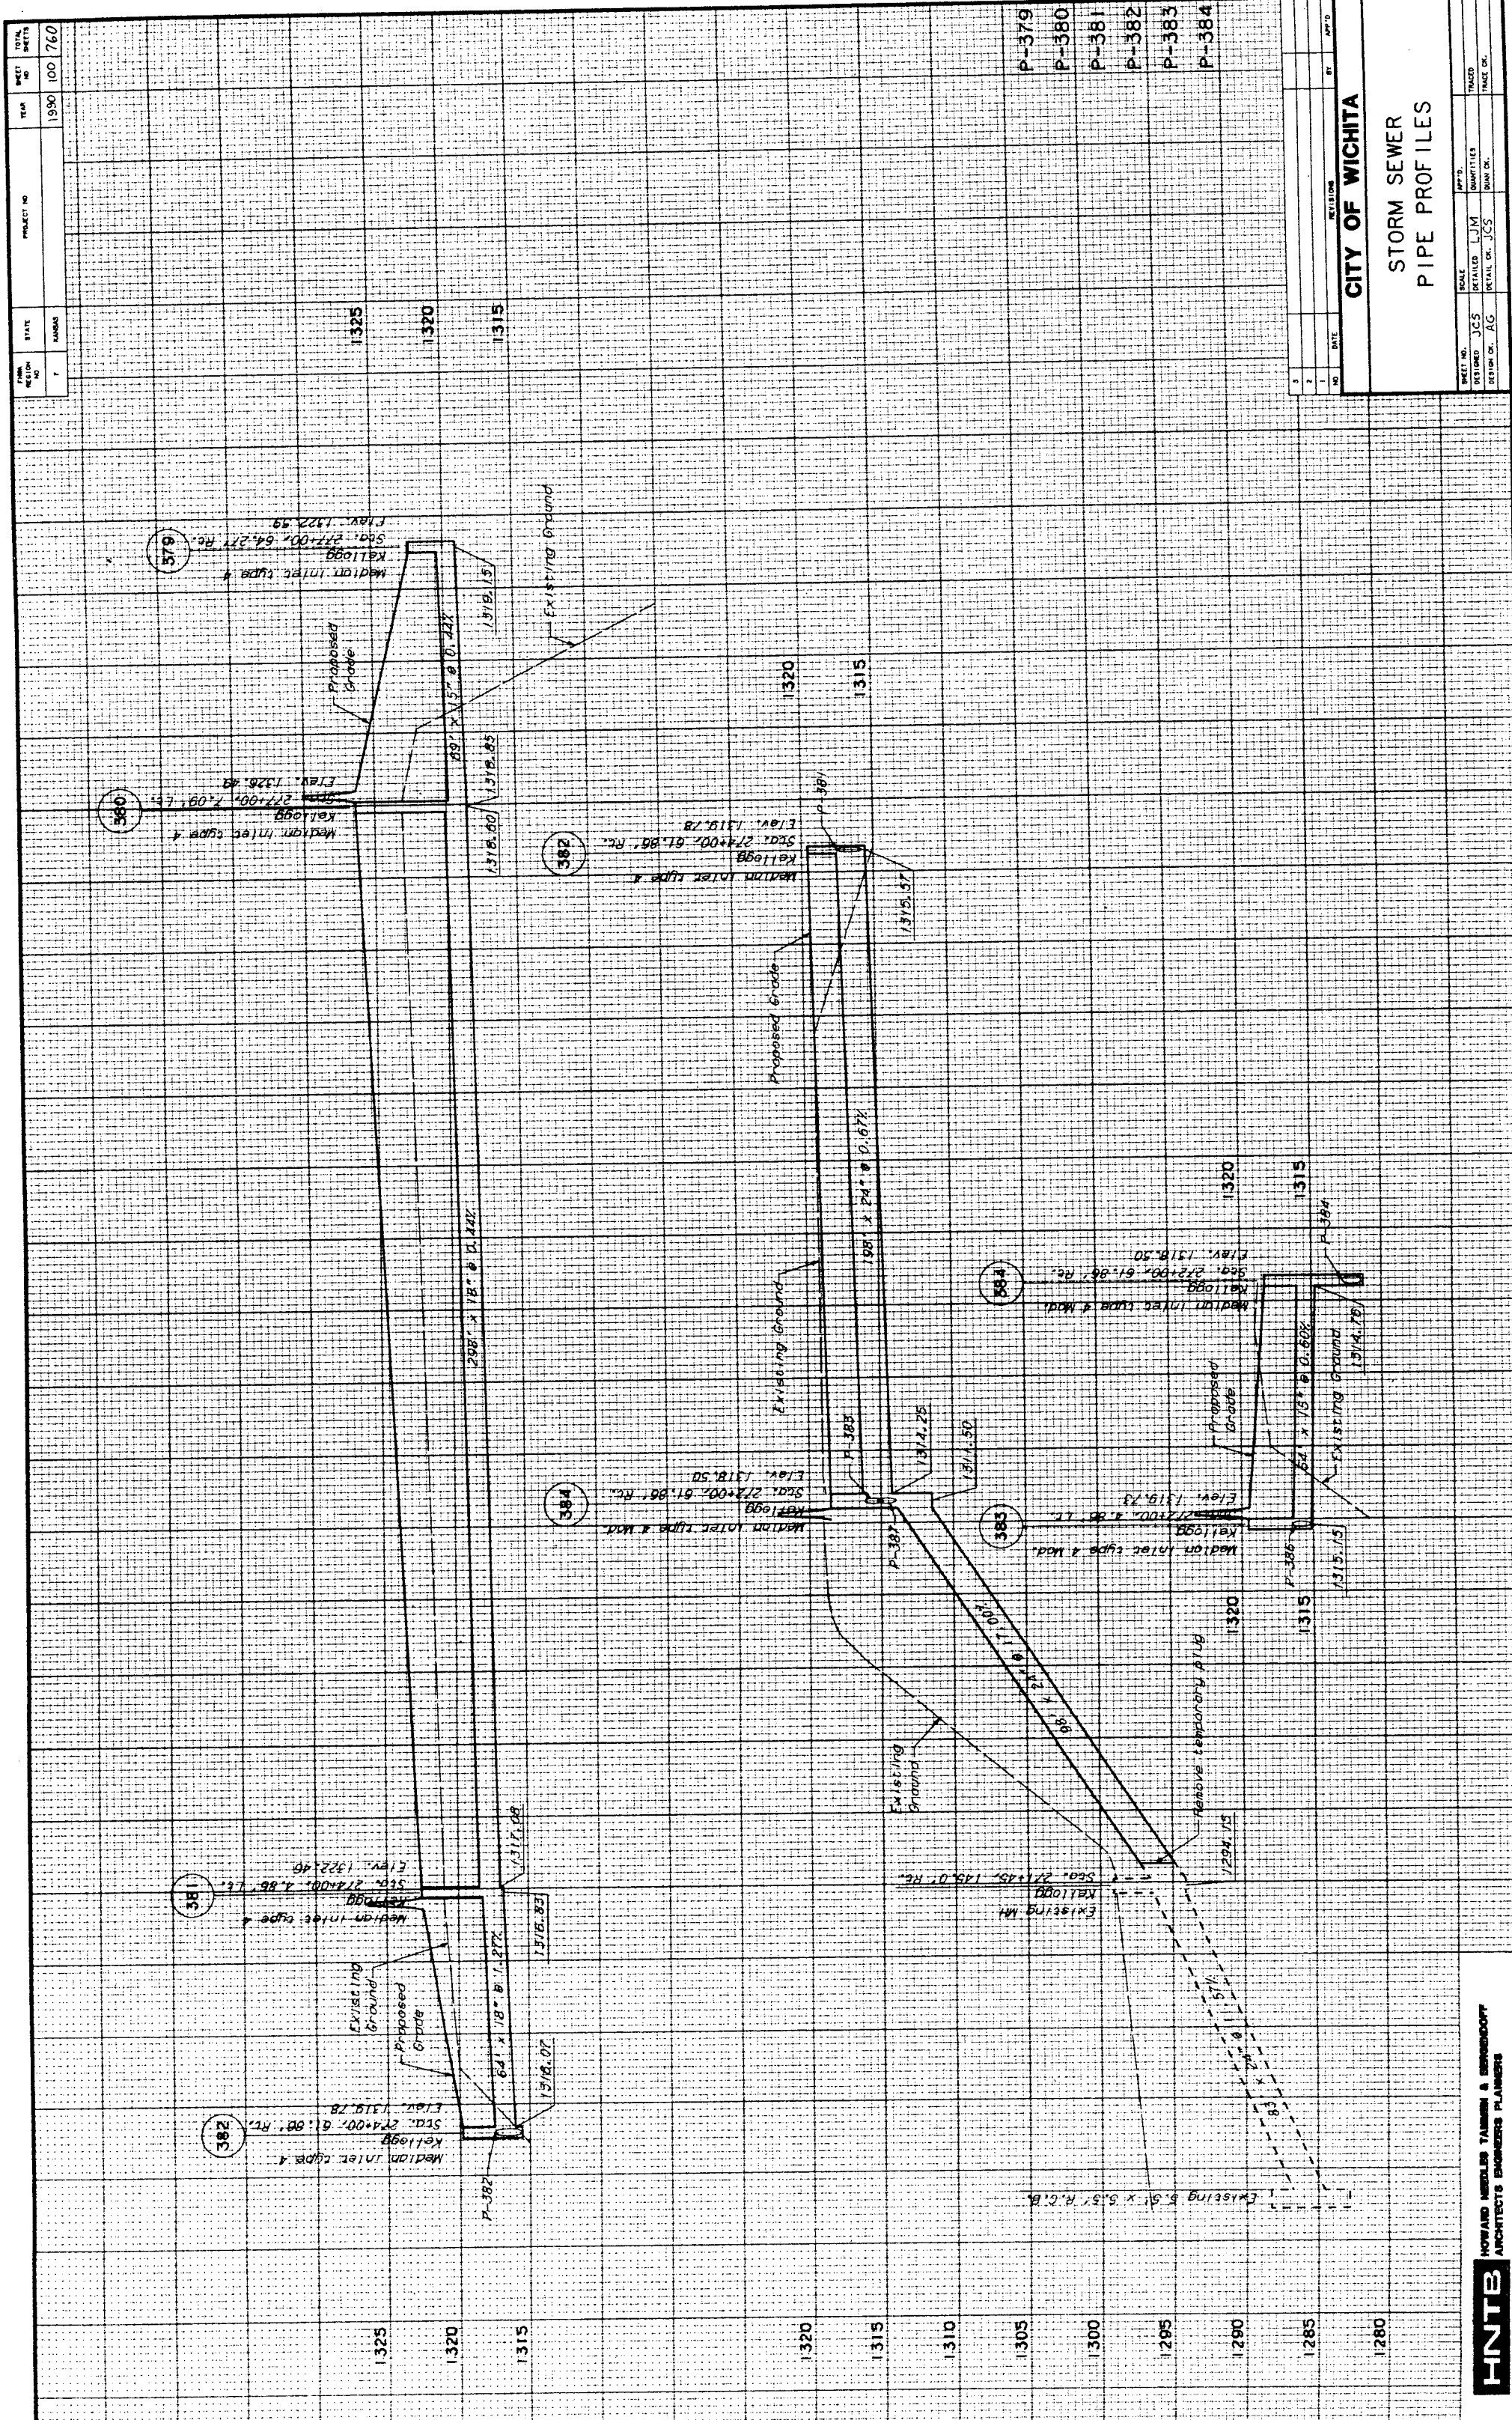

CITY OF WICHITA	
STORM SEWER	
PIPE PROFILES	
DATE: 10/15/10	SCALE: 1" = 40'
DRAWN BY: JCS	CHECKED BY: JCS
DESIGNED BY: JCS	APPROVED BY: JCS

HNTB
HOWARD NEEDLES TAMM & BERENSON
ARCHITECTS ENGINEERS PLANNERS