



BY	DATE


Plotted on: Tuesday, January 04, 2005 09:03
 dlutz Plot Queue: \\cbsw100\KC029049-PS
 Plot Scale: 1:0000000:1.000000 Pen Table: J:\29049\Library\Plotpen\1fg-fullsize.pen
 Design Filename: \\kcw30\elec\29049\Dwgs\cads Plan C Base\Light_details2.dgn

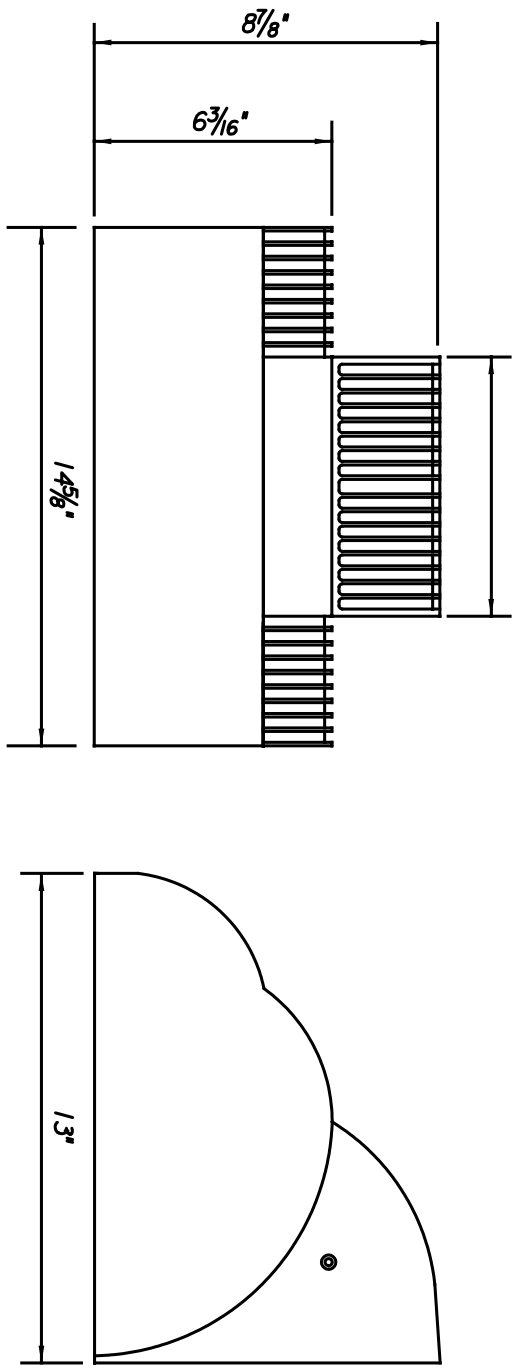


NOTE: FIXTURE APPLICABLE TO DOUGLAS AVE. ONLY
 WALL MOUNTED UNDERPASS LUMINAIRE
 Not To Scale

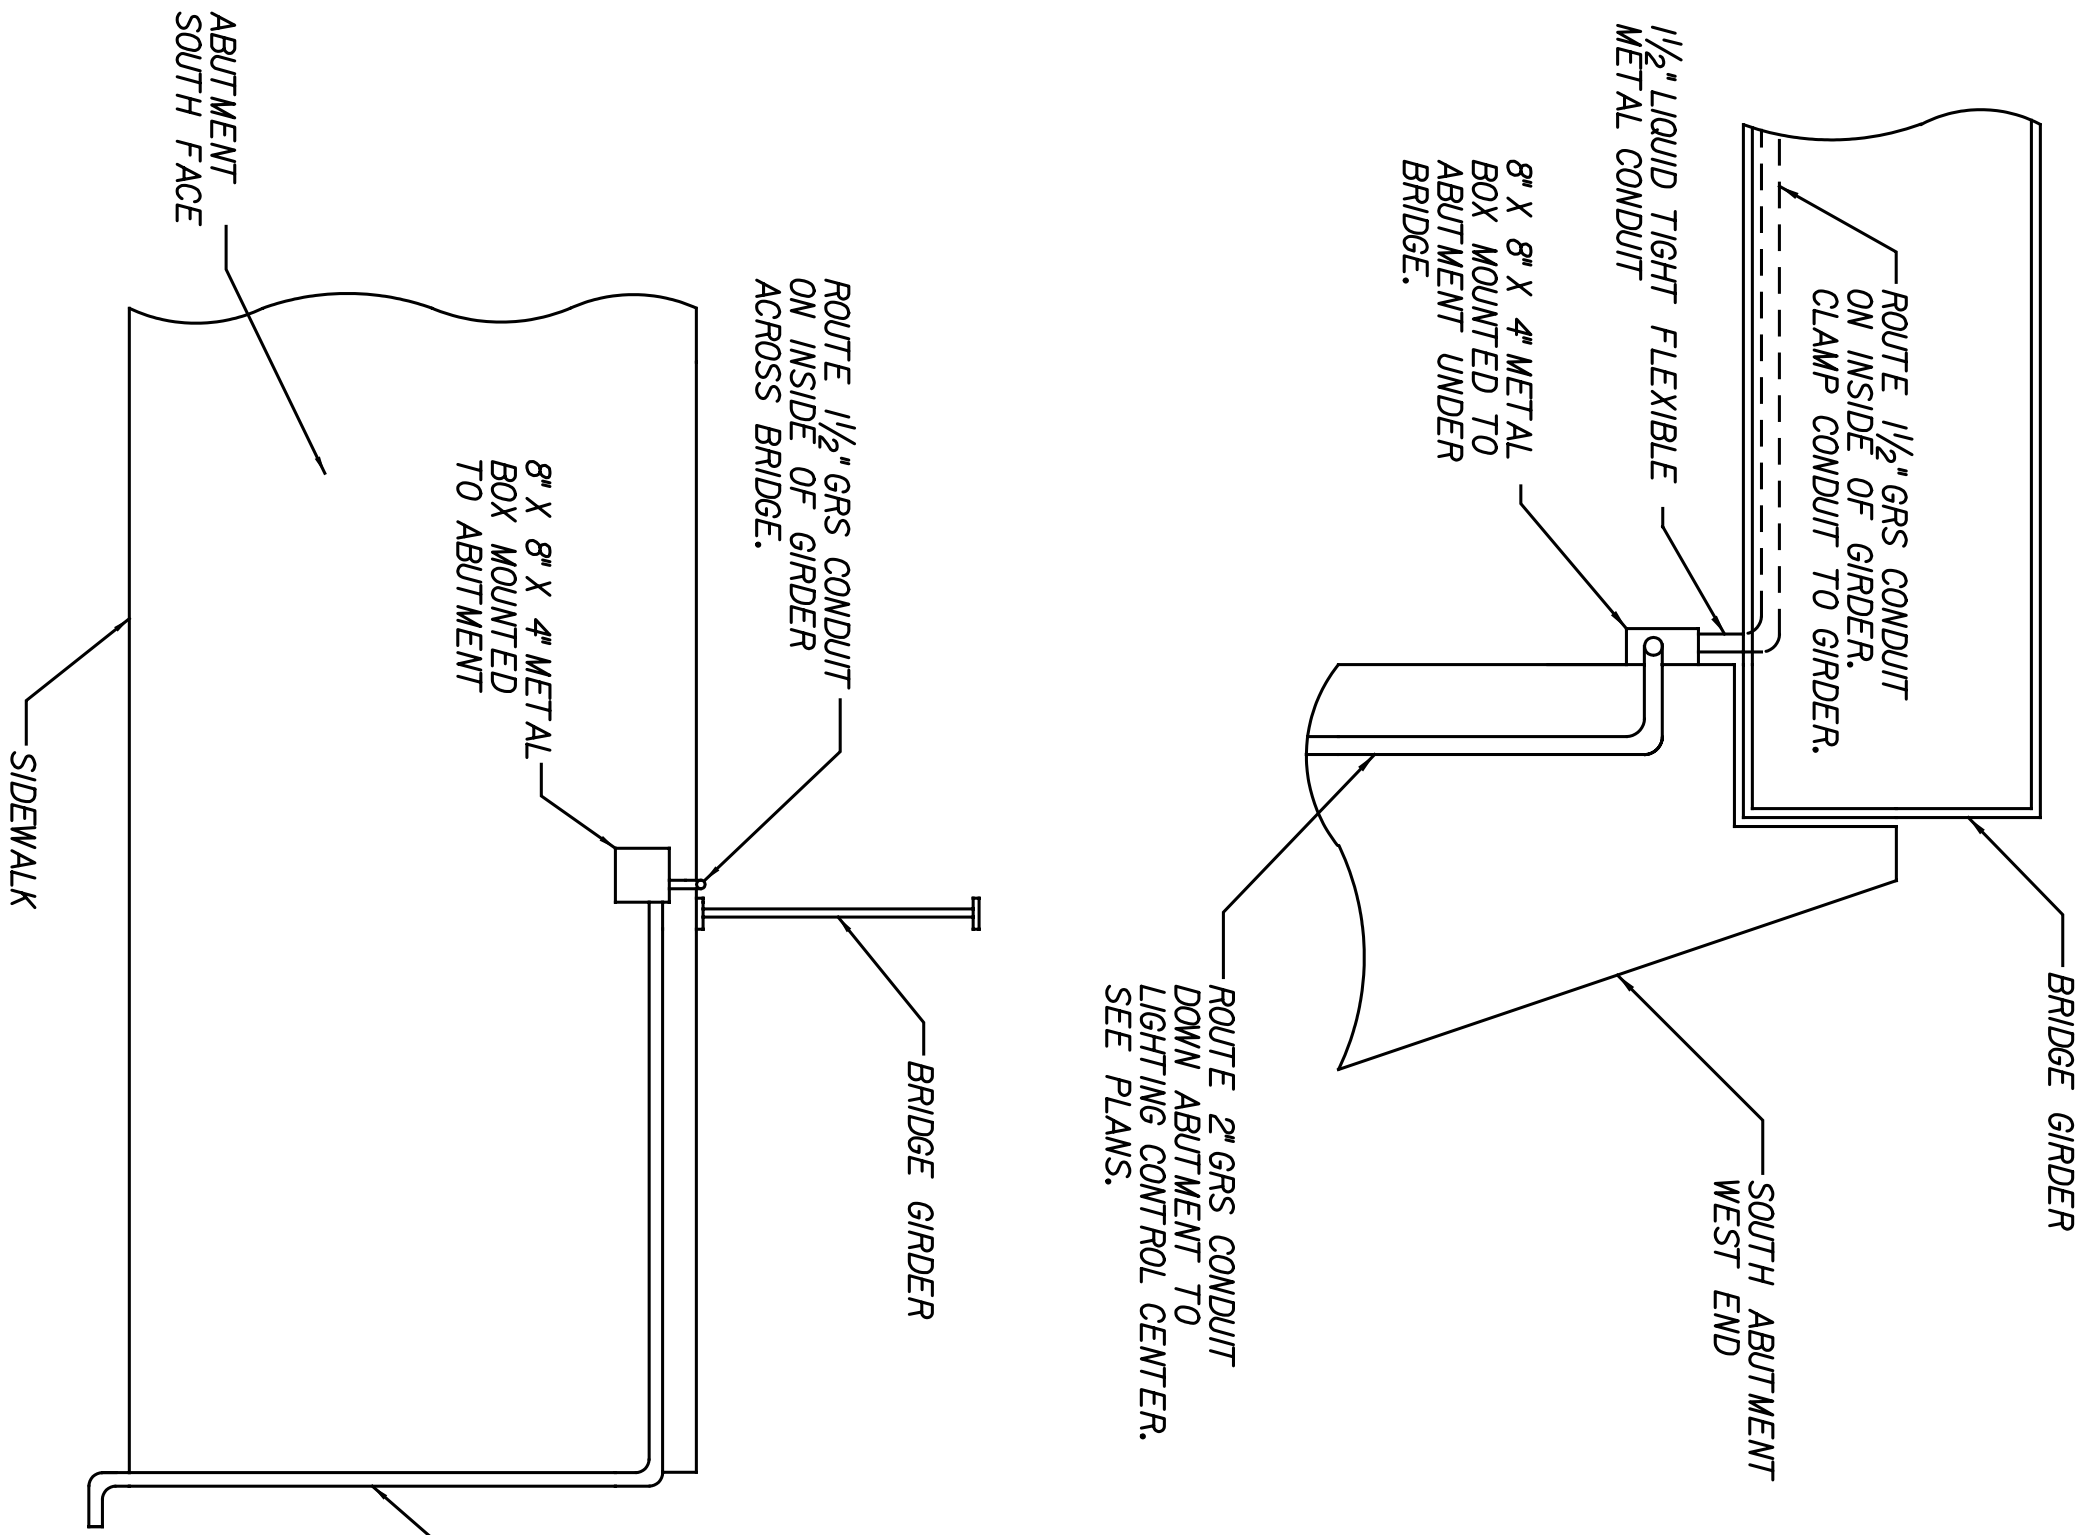

CONDUIT ROUTING
 DETAIL A

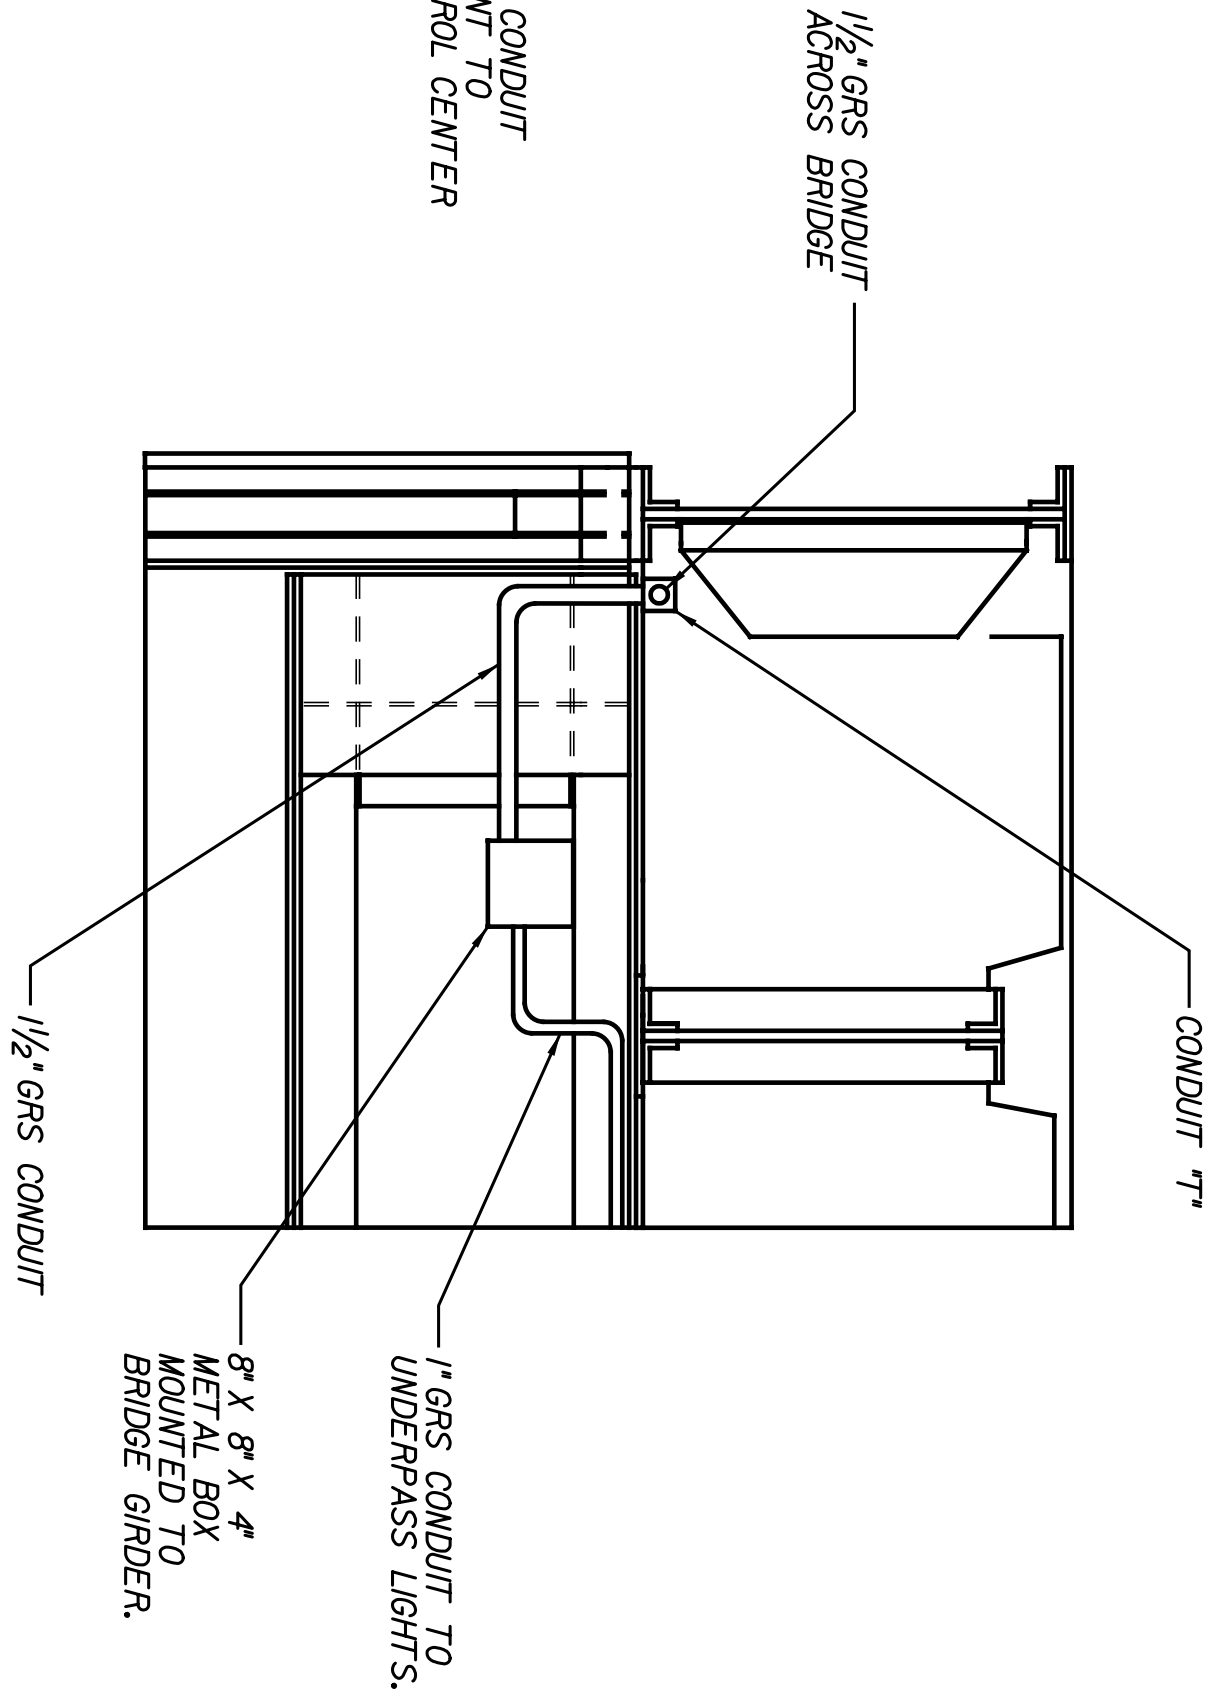


UNDERPASS LUMINAIRE ROUTING
 DETAIL B

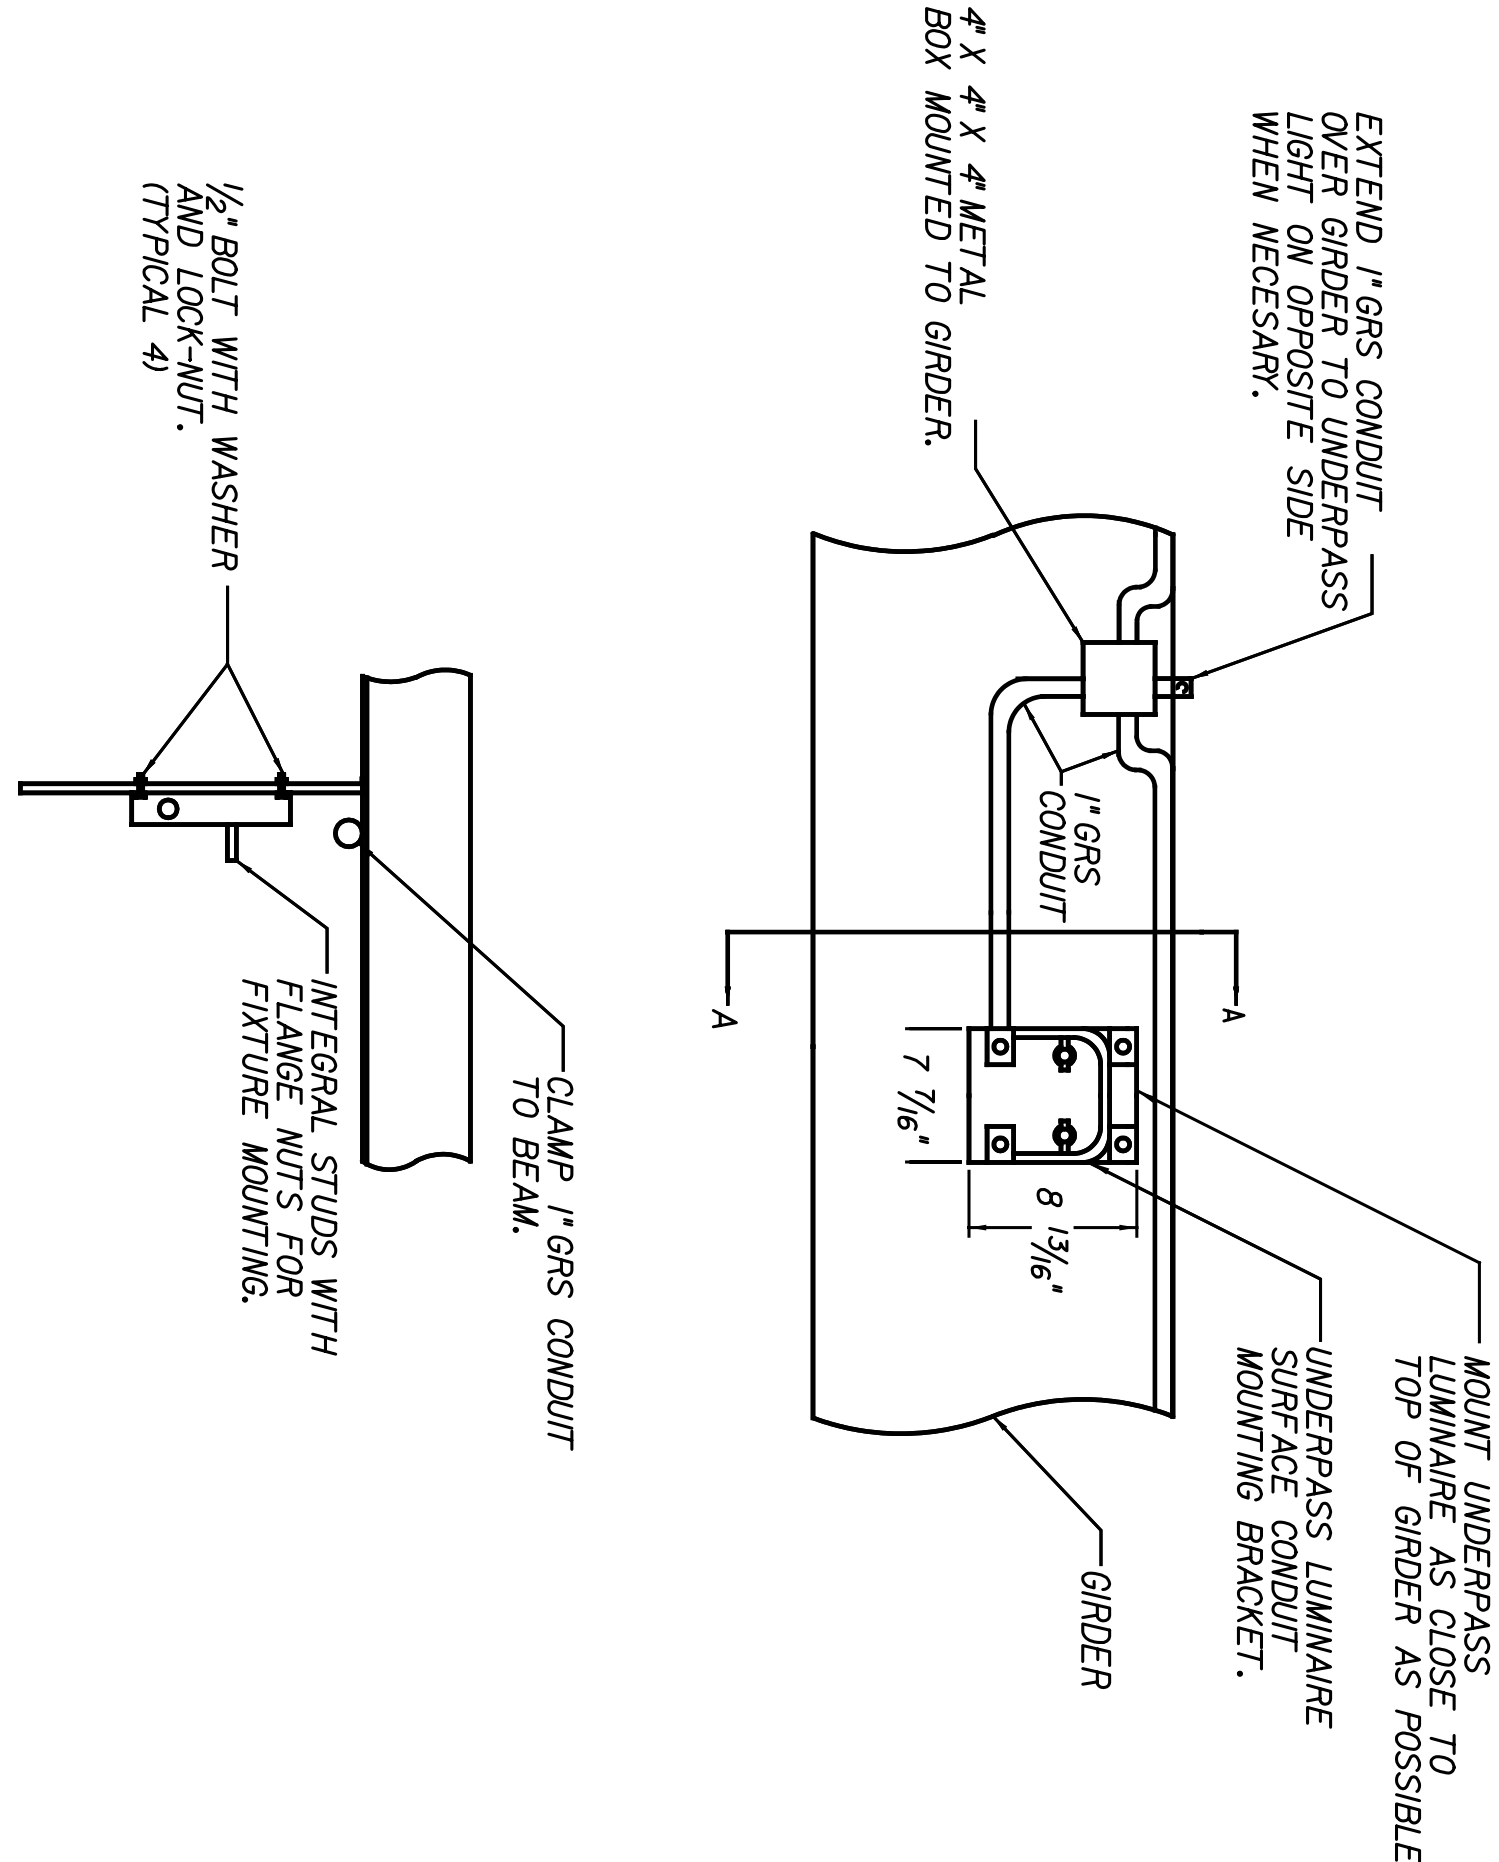

UNDERPASS LUMINAIRE MOUNTING
 DETAIL C

STATE	PROJECT NO.	YEAR	SHEET NO.	TOTAL SHEETS
KANSAS	472-94071	2005	14.07	

This sheet designed by:

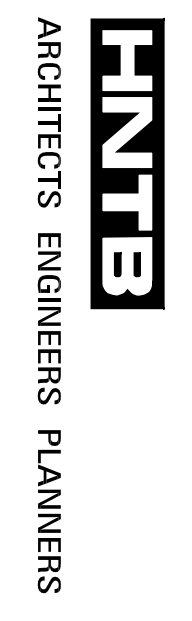

SHEET NO.	OF	SCALE AS NOTED	APP'D
3			
2			
1			

NO.	DATE	REVISIONS	BY	APP'D

DESIGNED: JGS		SCALE: AS NOTED		APP'D:	
DESIGN CR.: DBL		DETAILS: DJJ		TRADED:	
		QUANTITIES: GANAK		TRADE CR.:	

CITY OF WICHITA	
WICHITA CENTRAL CORRIDOR	
DOUGLAS AVENUE	
ELECTRICAL DETAILS	