


STATE	PROJECT NO.	YEAR	SHEET NO.	TOTAL SHEETS
KANSAS	472-84071	2005	LS3.15	


Alternate #4

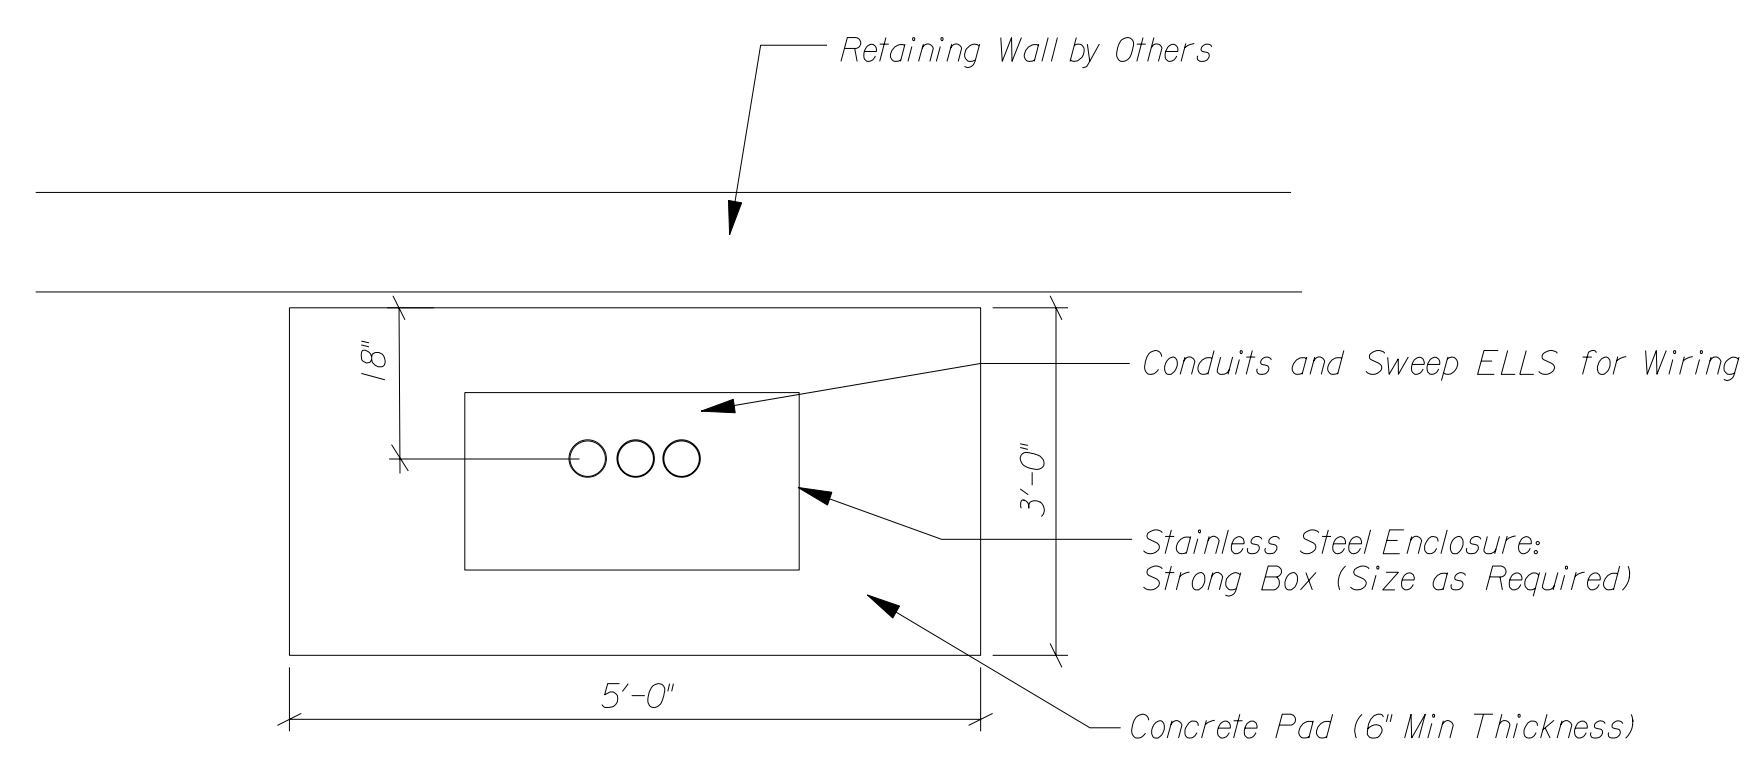


02 Front Elevation/Section
LS3.15

01 Controller Pad - Plan View
NTS

Point of Connection Notes:
 1. The Contractor shall coordinate sequencing with other trades.
 2. The Contractor shall install the copper service and meter prior to the installation of new pavement.

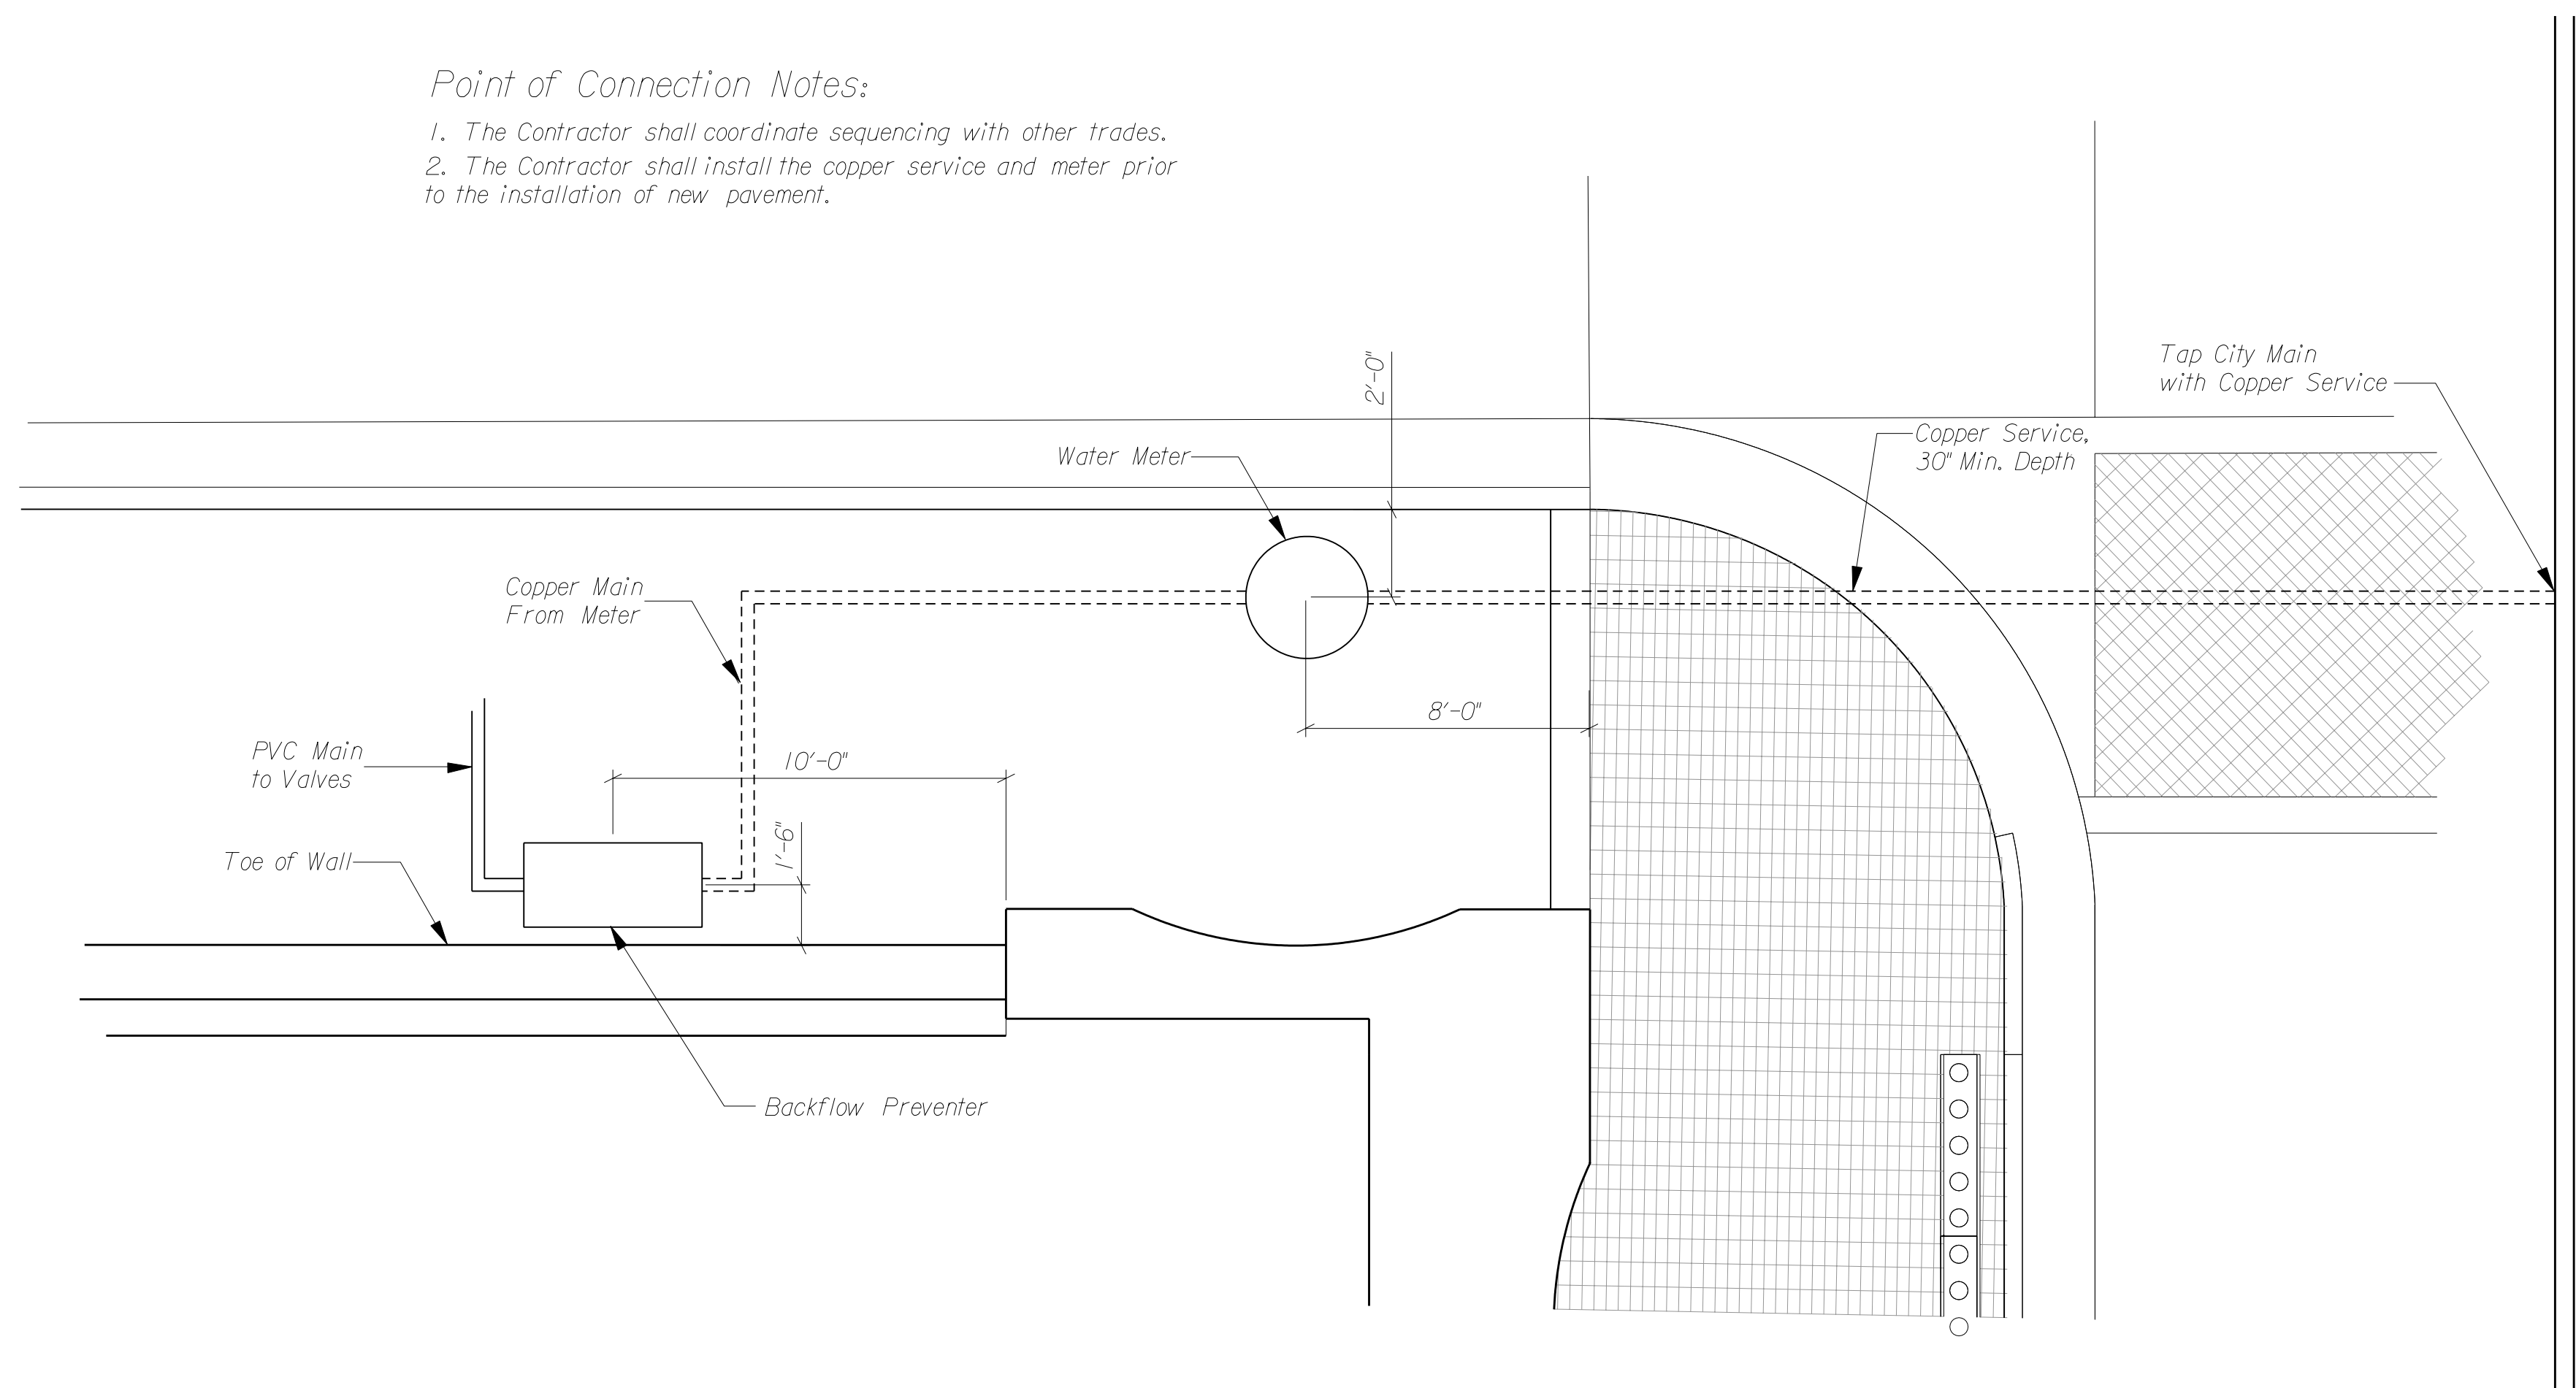


02 POINT OF CONNECTION SCHEMATIC
NTS

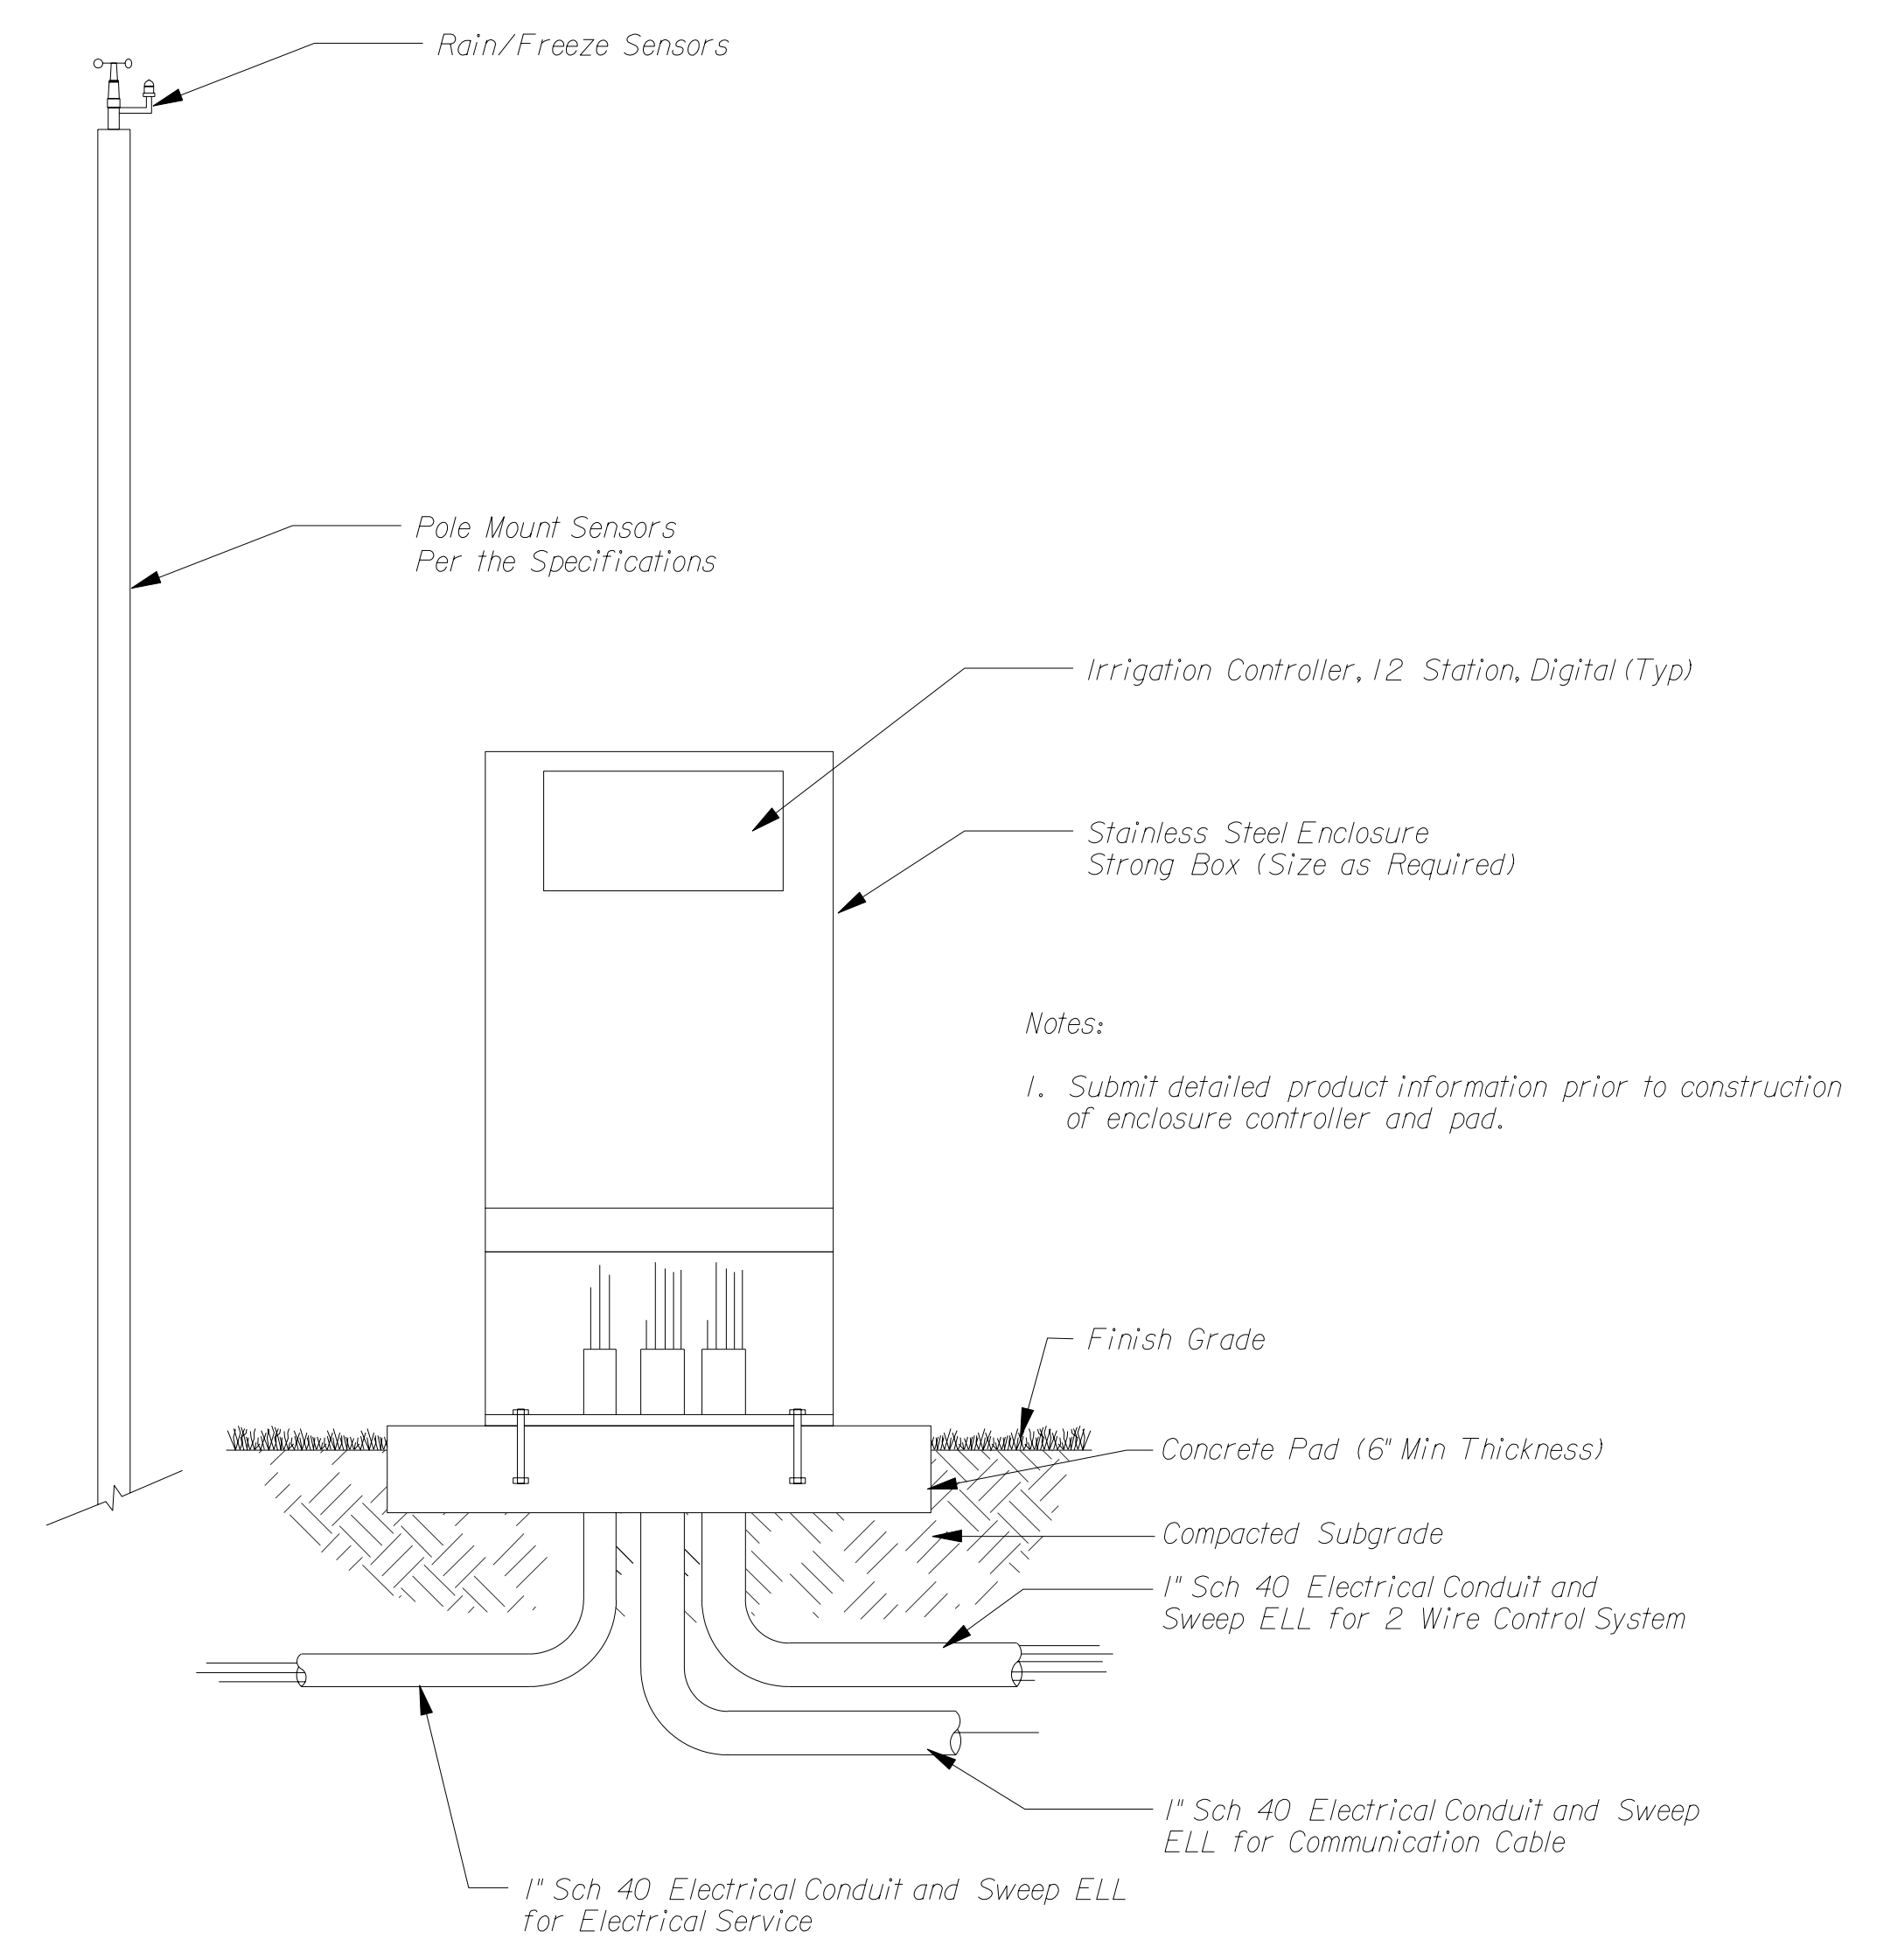

Notes:
 1. Submit detailed product information prior to construction of enclosure controller and pad.

02 Front Elevation/Section - Controller
NTS

This sheet designed by:

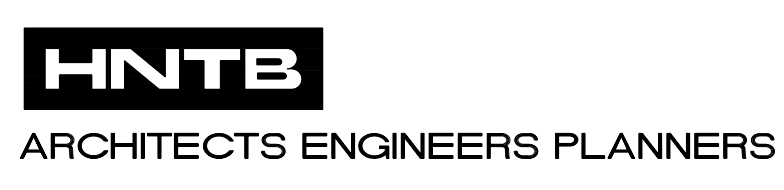

3					
2					
1					
NO.	DATE	REVISIONS	BY	APP'D	
CITY OF WICHITA					
WICHITA CENTRAL CORRIDOR					
IRRIGATION DETAILS					
SHEET NO.	OF	SCALE: VARIOUS	APP'D:		
DESIGNED:	JF	DETAILED: JRK, KA	QUANTITIES: JRK, KA	TRACED:	
DESIGN CK.:	WP	DETAIL CK.: WSN	QUAN. CK.: WP	TRACE CK.:	