
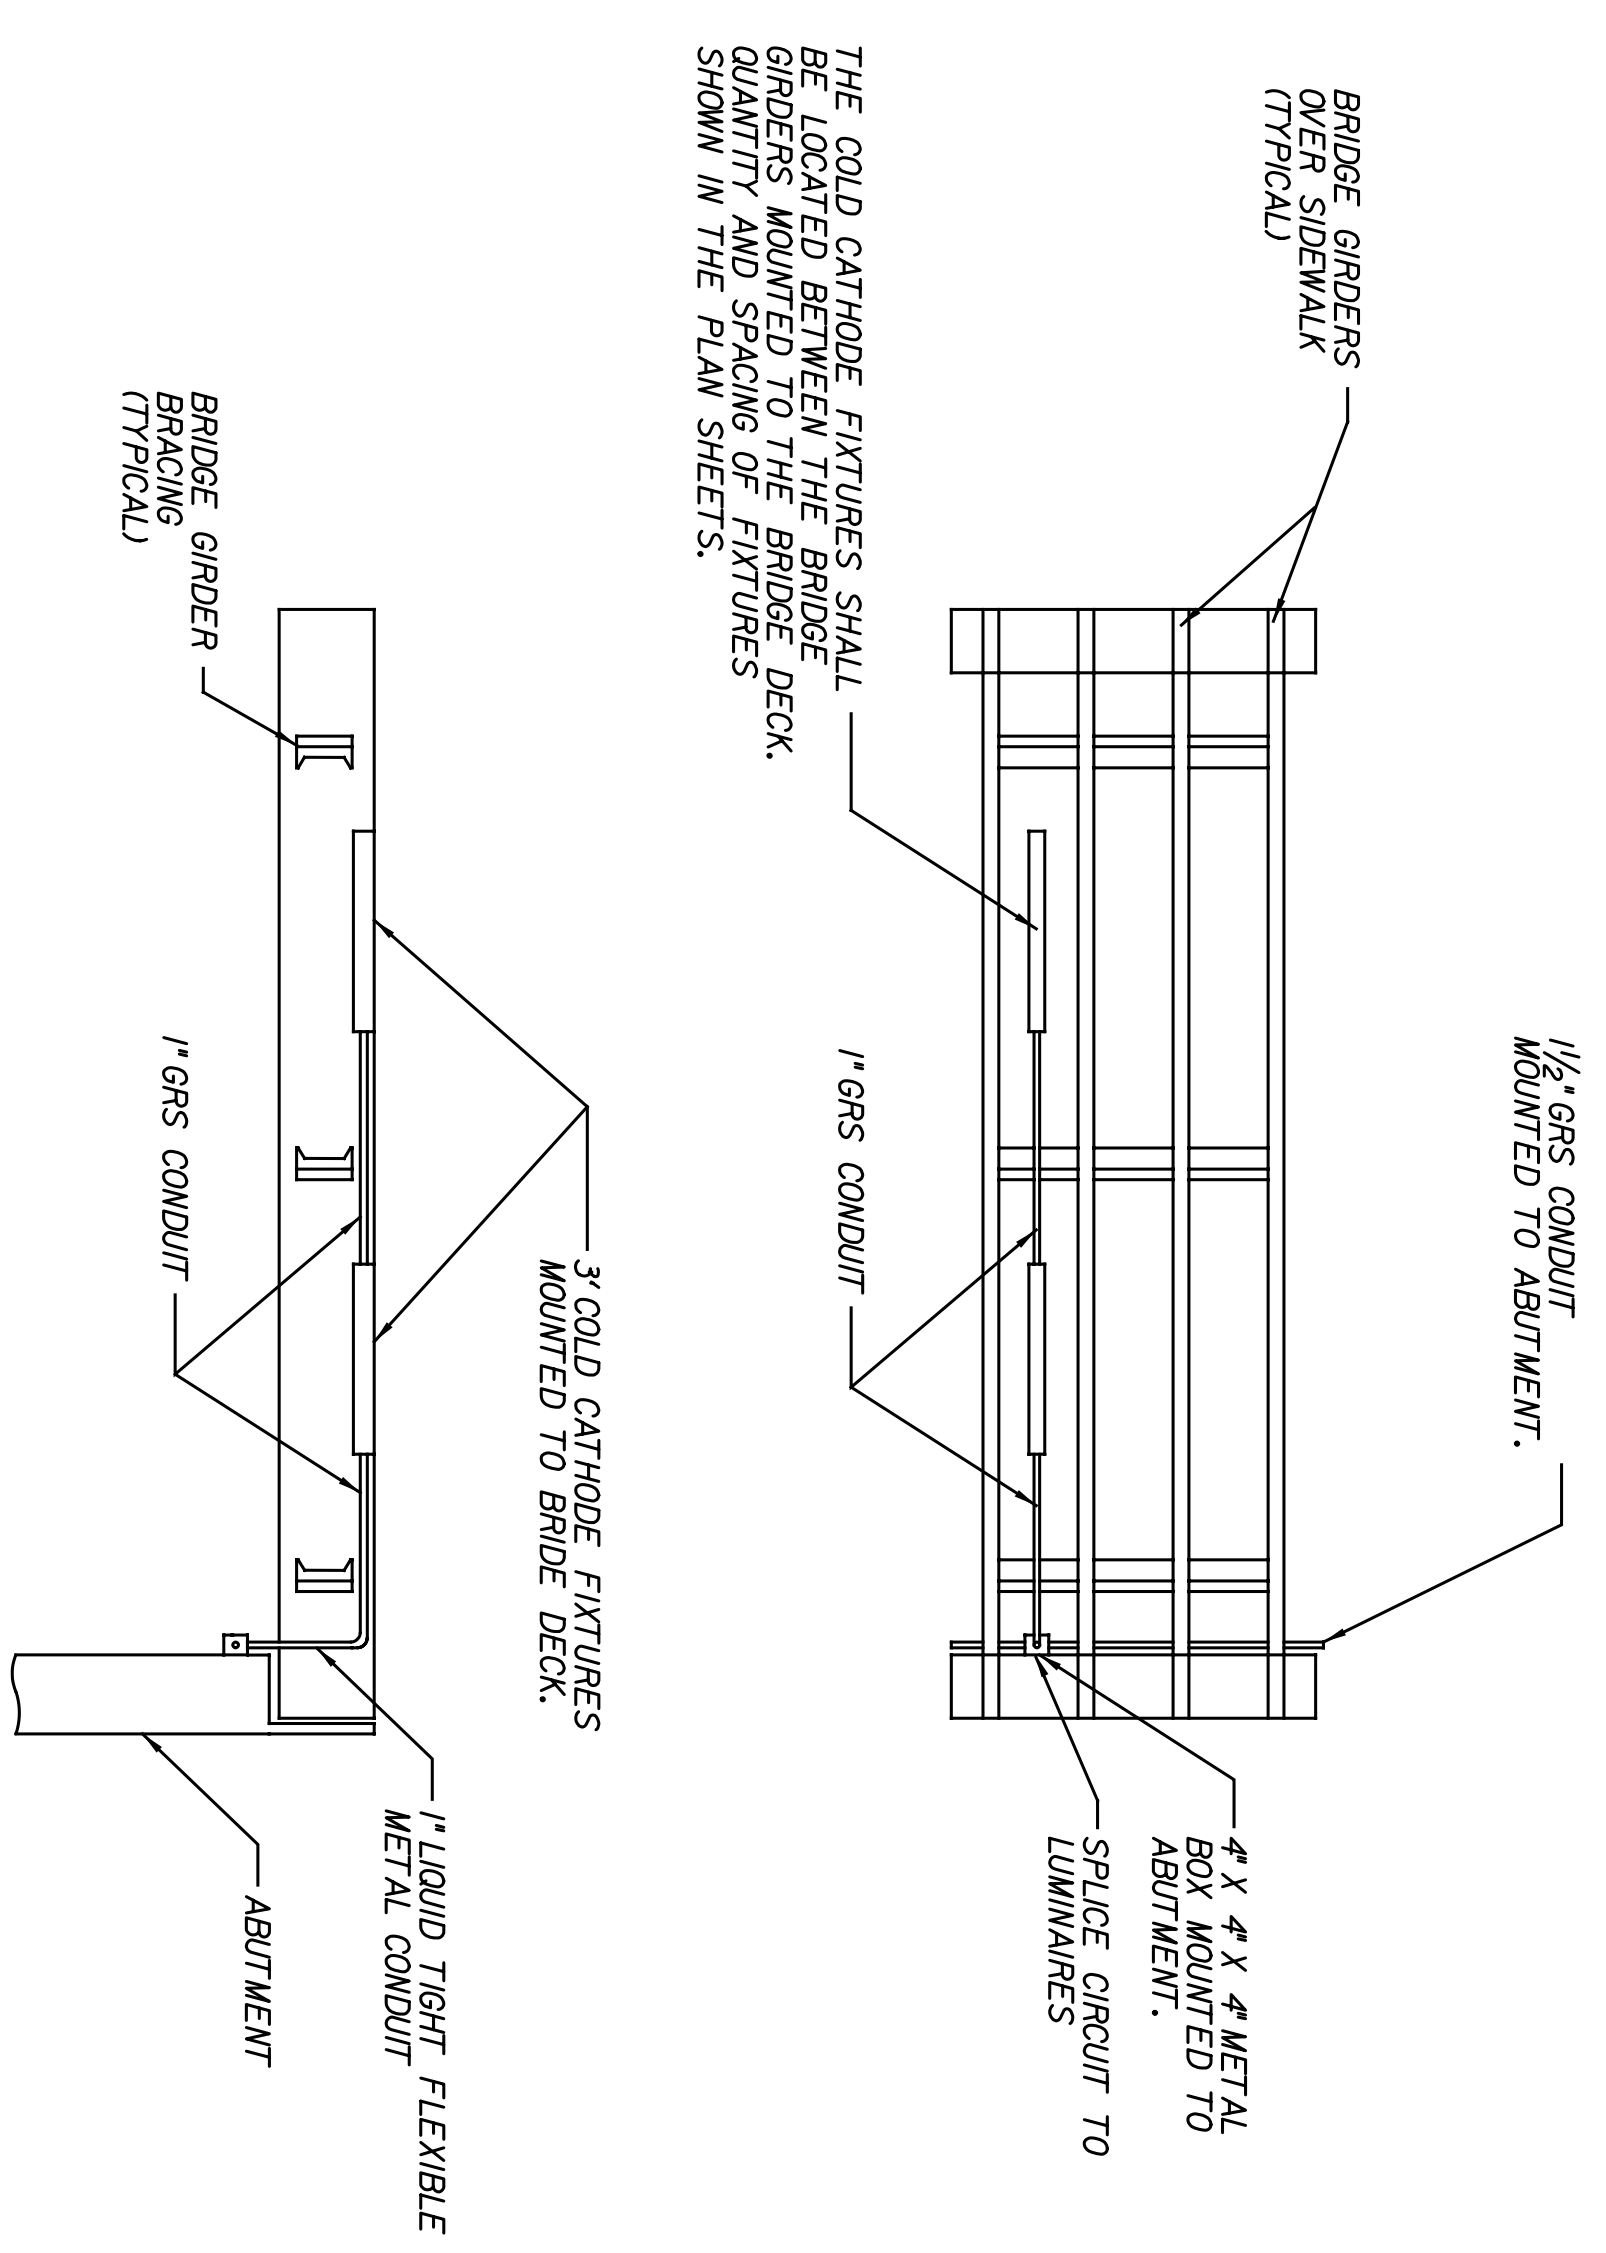


BY	DATE

Plotted on: Tuesday, January 04, 2005 09:57
 dlutz Plot Queue: \\cbsw100\KC029049-PS
 Plot Scale: 1:0000000:0.000000 Pen Table: J:\29049\Library\plotpen\1fg-fullsize.pen
 Design Filename: \\kcow30\elec\29049\Dwgs\cads Plan C Alt 7\light_details2.dgn

STATE	PROJECT NO.	YEAR	SHEET NO.	TOTAL SHEETS
KANSAS	472-94071	2005	CLL2	

Alternate # 7

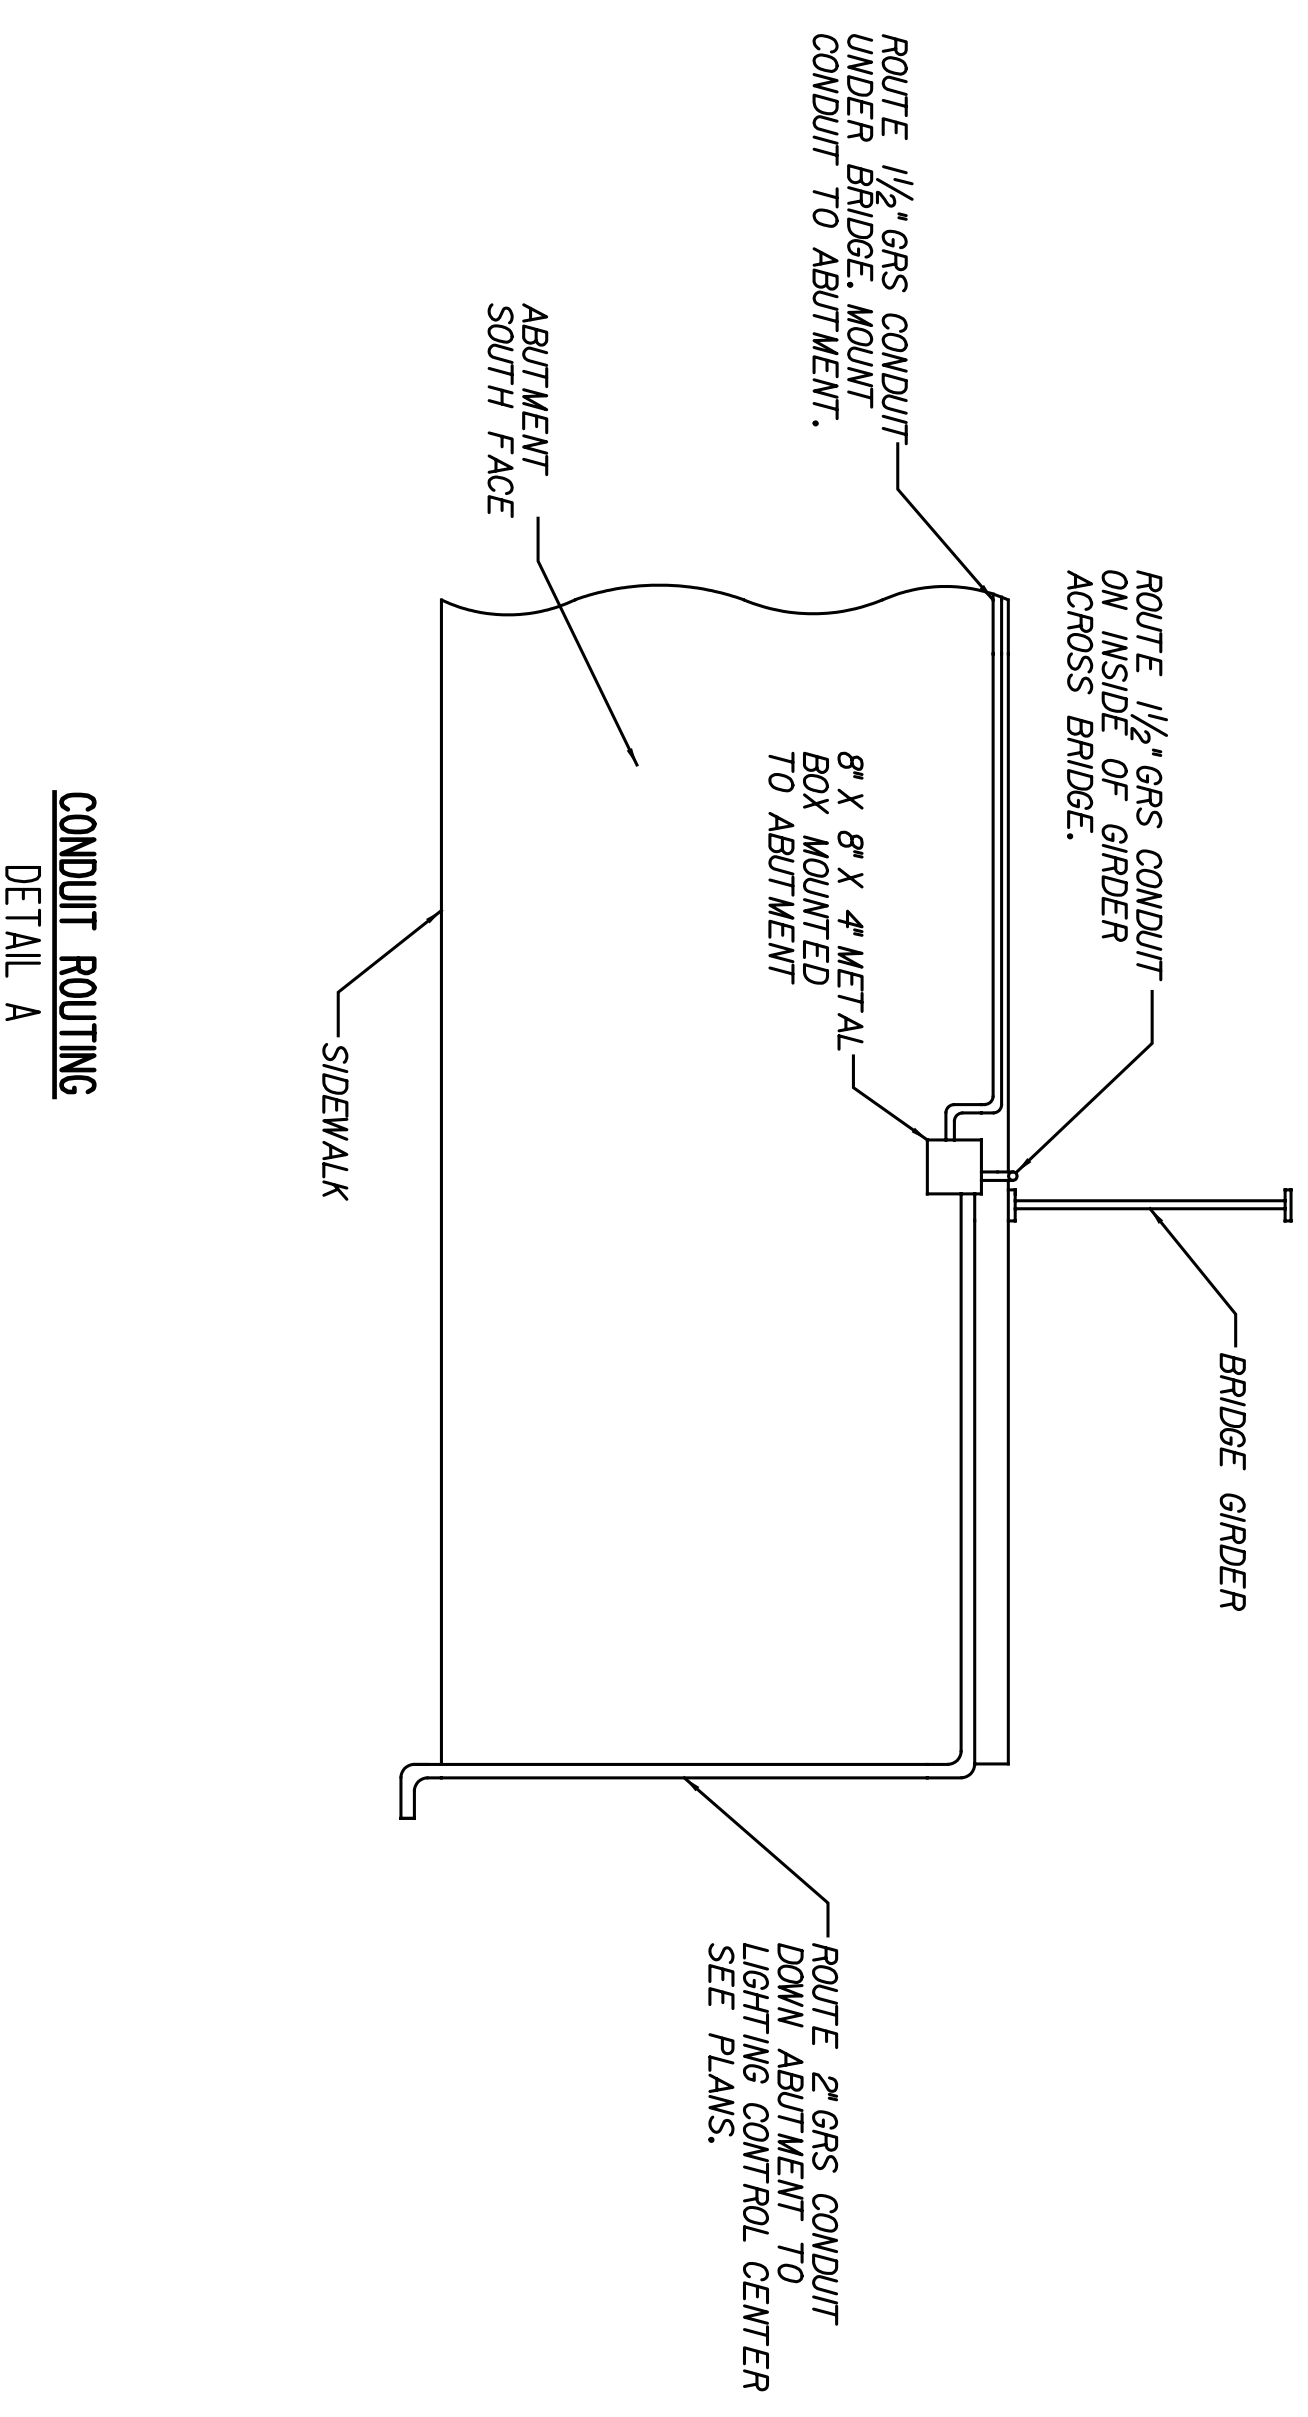

This sheet designed by:

HNTEB
 ARCHITECTS ENGINEERS PLANNERS

SHEET NO.	OF	SCALE AS NOTED	APP'D
1			
2			
3			

NO.	DATE	REVISIONS	BY	APP'D

CITY OF WICHITA
WICHITA CENTRAL CORRIDOR
 ALTERNATE 7
 DOUGLAS AVENUE
 ELECTRICAL DETAILS

DESIGNED	CHK'D	SCALE	AS NOTED	APP'D	TRACED
DLUTZ	DLUTZ	AS NOTED	AS NOTED	DLUTZ	DLUTZ