



FHWA REGION NO.	STATE	PROJECT NUMBER	FISCAL YEAR	SHEET NUMBER	TOTAL SHEETS
X	KANSAS	X	X		X

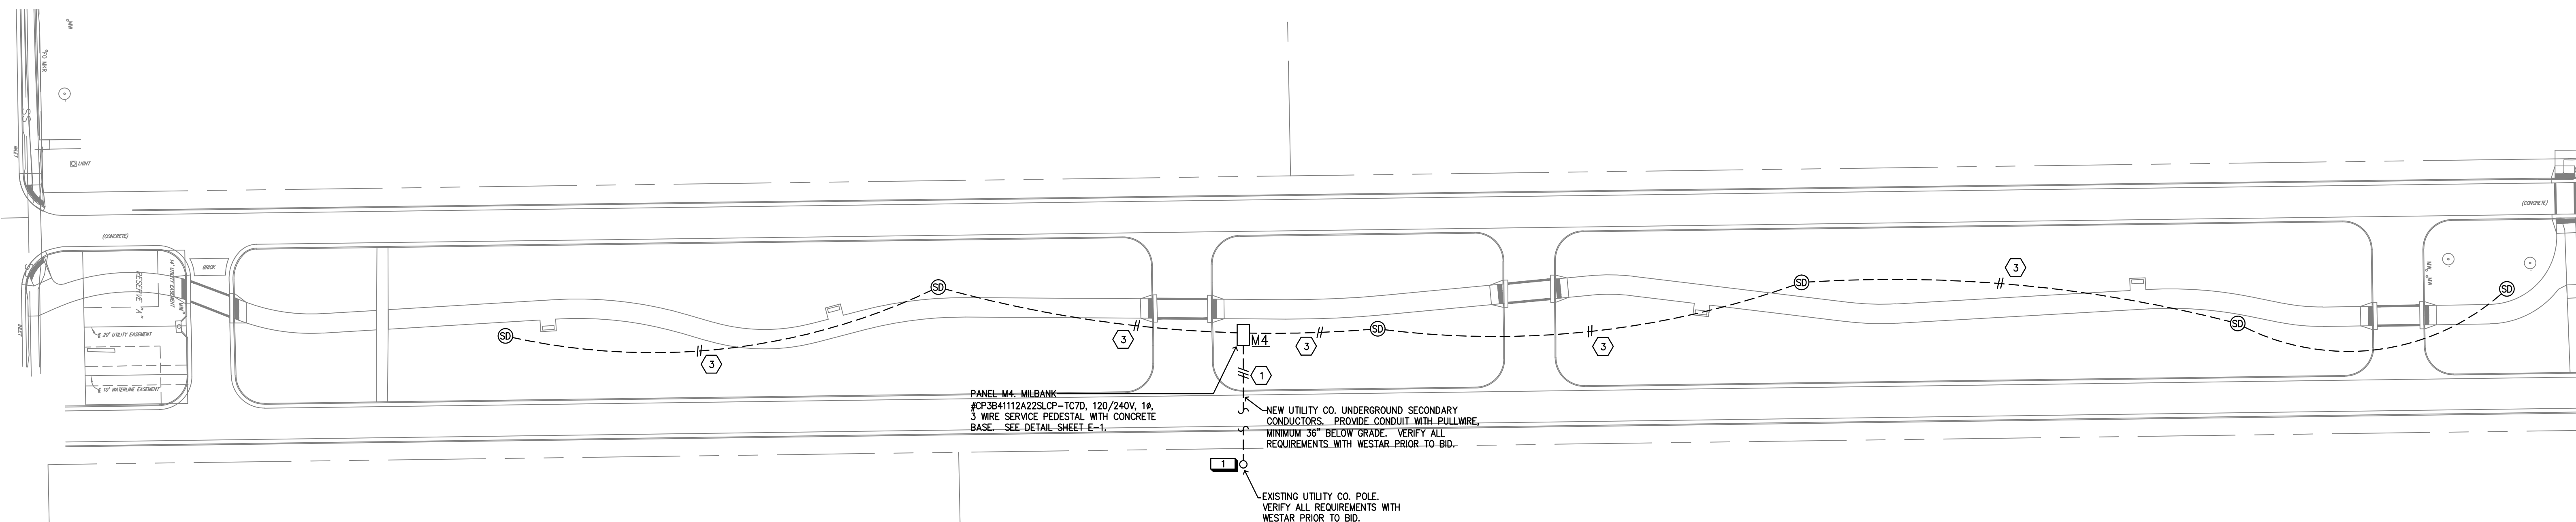

(B) ELECTRICAL LIGHTING PLAN- OPPORTUNITY DRIVE Scale 1"= 40'-0"

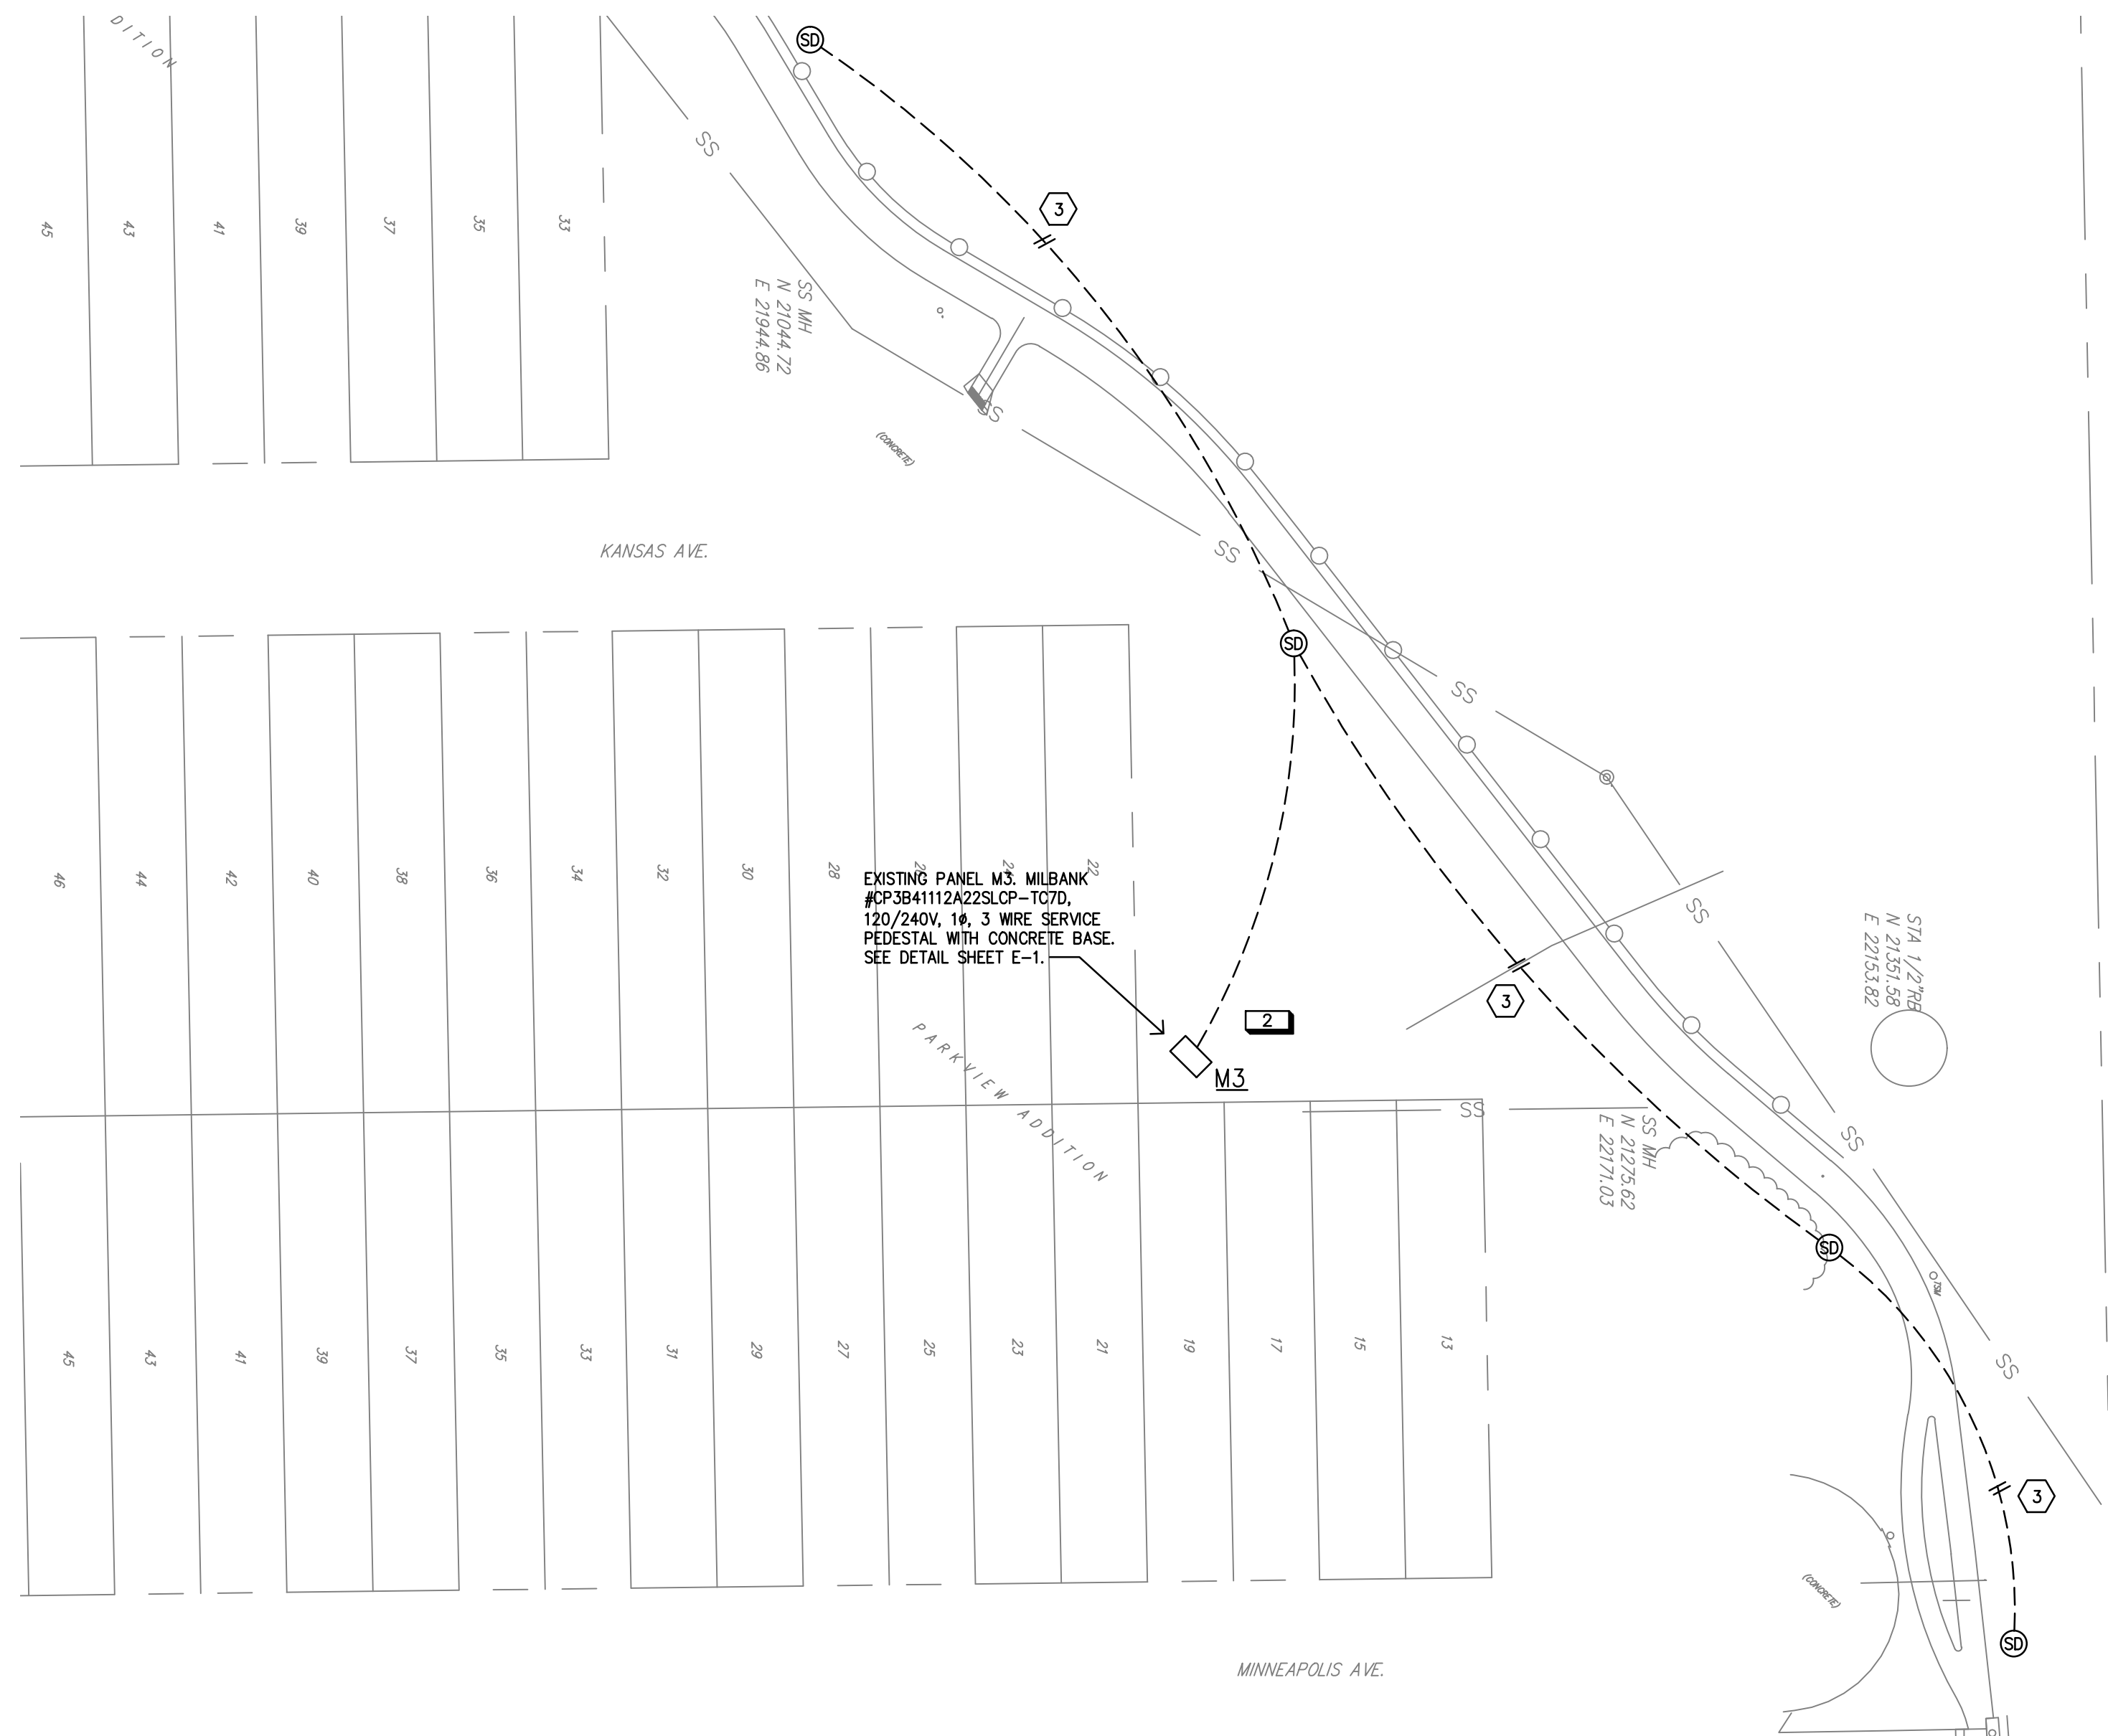

(A) ELECTRICAL LIGHTING PLAN - 21ST STREET Scale 1"= 40'-0"

PLAN NOTES	
SYMBOL	DESCRIPTION
1	PANEL M4. CAN BE ROUTED TO ONE OF TWO EXISTING POLE MOUNTED TRANSFORMER. E.C. TO VERIFY WHICH ONE WILL BE UTILIZED AND ALL OTHER REQUIREMENTS WITH WESTAR PRIOR TO BID.
2	EXISTING MILBANK PANEL M3 EXISTING IN FIELD AT APPROXIMATE LOCATION SHOWN ON PLAN. EC TO VERIFY LOCATION IN FIELD PRIOR TO ROUGH-IN.

FEEDER SCHEDULE						
FEEDER IDENT.	CONDUCTORS		GROUND SIZE PER SET	ISOLATED GRD. SIZE PER SET	CONDUIT SIZE PER SET	
	SETS	QUANT. PER SET				
1	1					2"
2	1	2	#6	#10		1"
3	1	2	#8	#10		1"



Integrated Consulting Engineers, Inc.
10058.00-041
2604 W 9th St • Ste. 100 • Wichita, KS 67203
316-264-3588 • 316-264-3948 • icengr@bohm.net

**ELECTRICAL CUT SHEETS
I-135 NORTH BIKE PATH
WICHITA, KANSAS**

Ruggles & Bohm, P.A.
Engineering, Surveying, Land Planning

924 North Main
Wichita, Kansas 67203
www.rbkansas.com

(316) 264-8008
(316) 264-4621 fax
E-mail: info@rbkansas.com

DESIGN	ICE	SHEET E-5 OF 6
DRAWN	ICE	
REVIEW		
UTILITY		
DRAWING FILE	PROJECT NUMBER	DATE OCT 13, 2010