

CIVIL SITE PLANS
MENARDS - WEST WICHITA, KS
STONEBRIDGE COMMERCIAL ADDITION


SWS PLAN & PROFILE

SHEET TITLE
08626
PROJECT NUMBER

DESIGN BY: **MKEC**
DRAWN BY: **MKEC**
CHECKED BY: **MAB**

ISSUED: **AS BUILT**
12-06-10


SHEET NO.
20 of 45

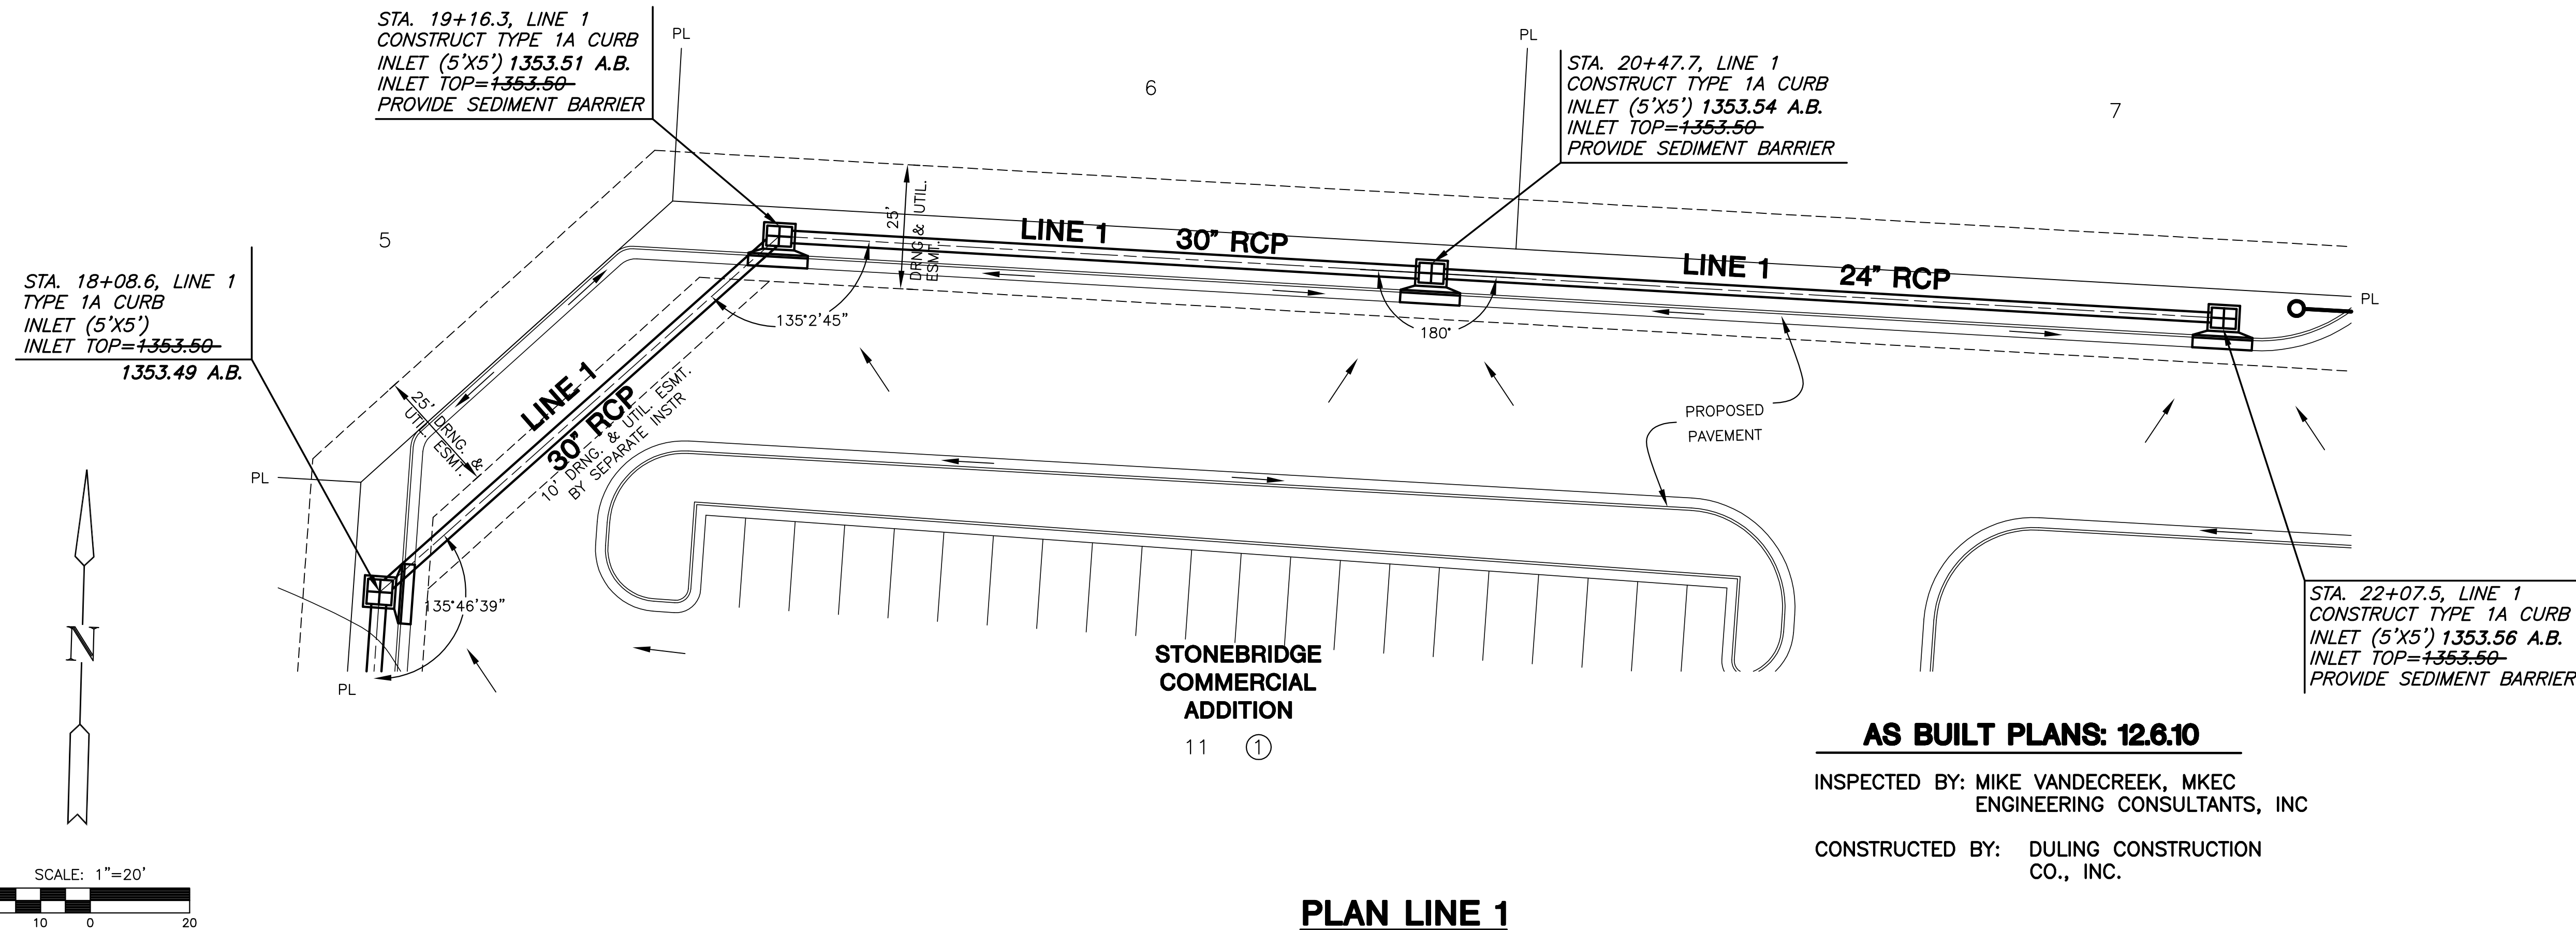

PLAN LINE 1

AS BUILT PLANS: 12.6.10
INSPECTED BY: MIKE VANDECREEK, MKEC
ENGINEERING CONSULTANTS, INC
CONSTRUCTED BY: DULING CONSTRUCTION
CO., INC.

PROFILE LINE 1

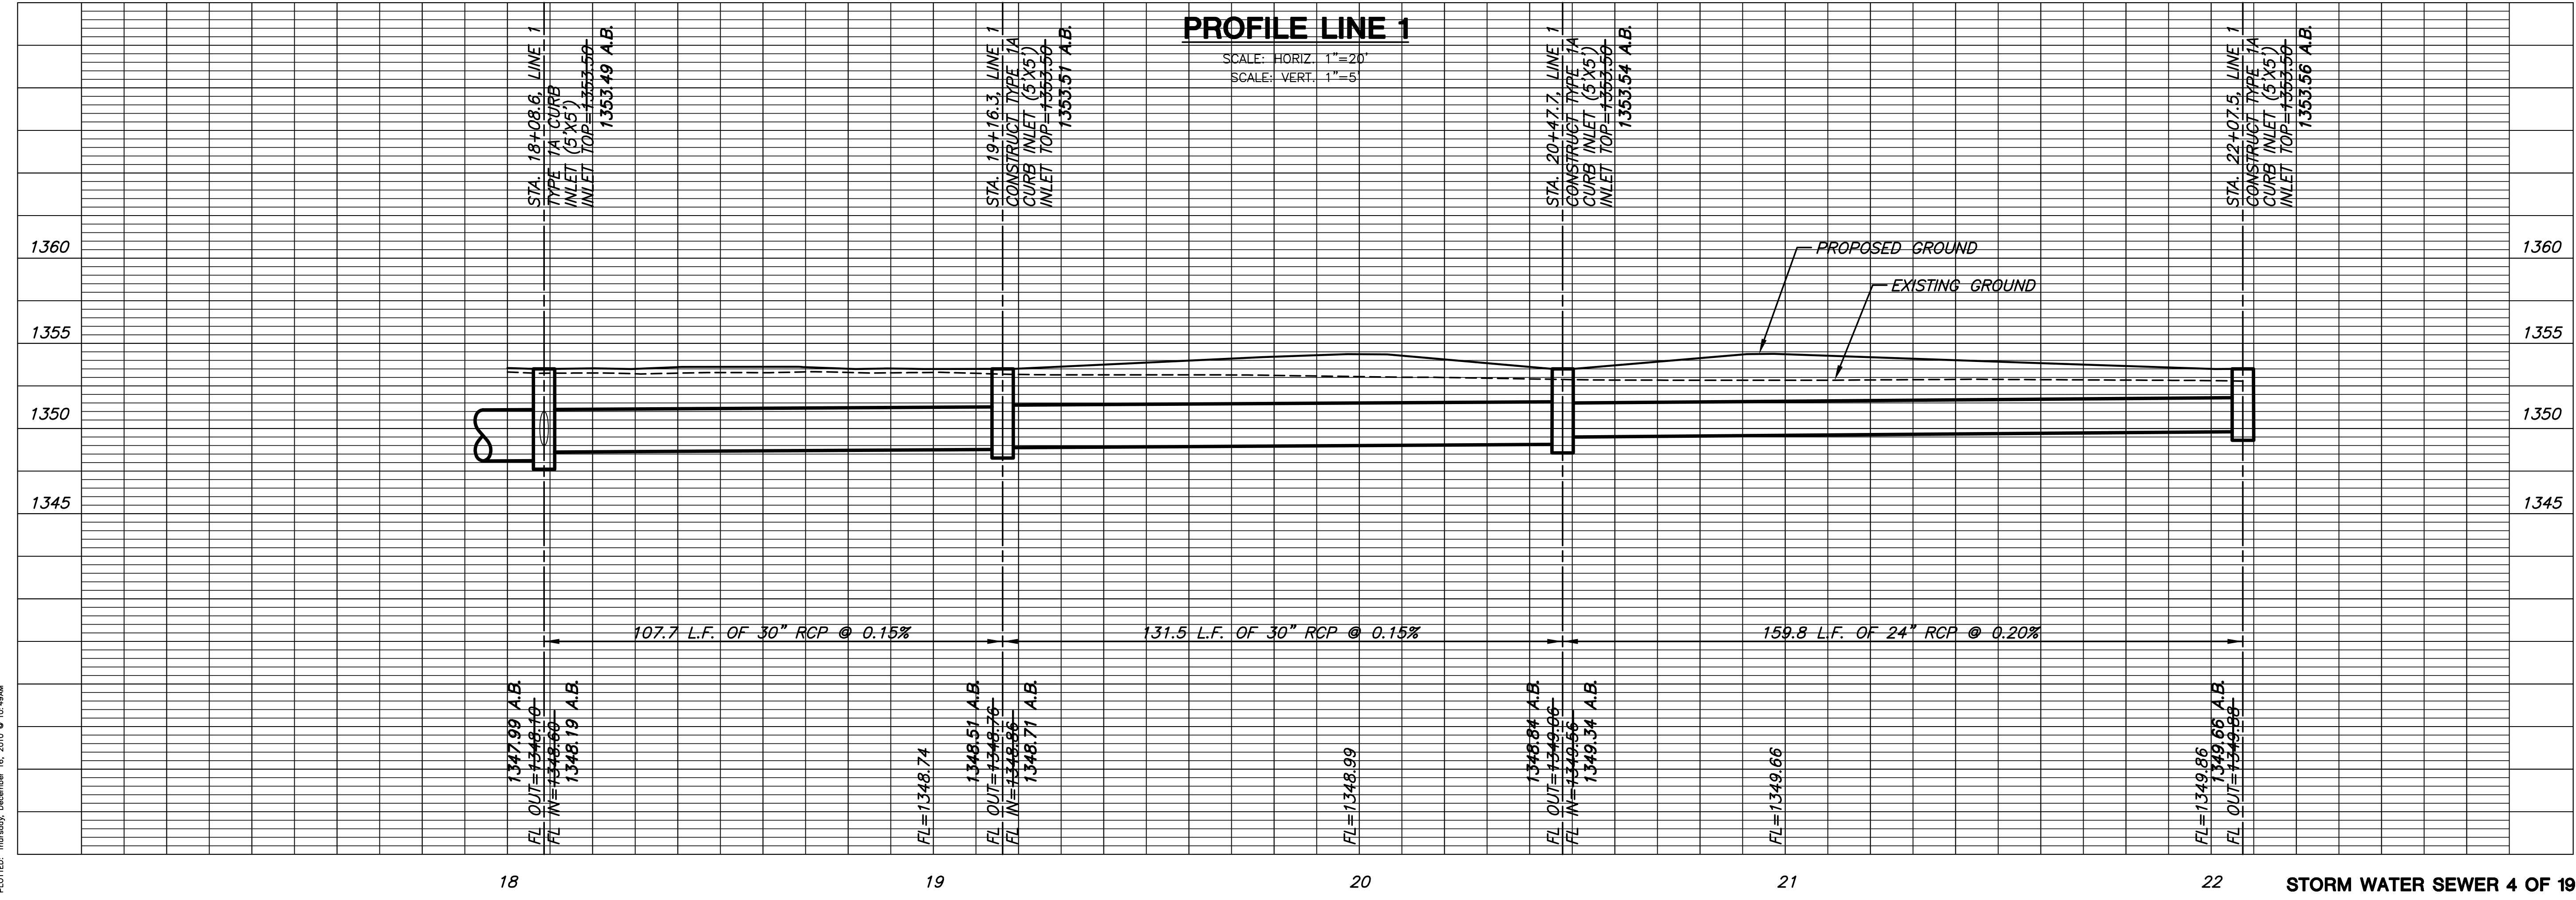

STORM WATER SEWER 4 OF 19

PLOTTED: Thursday, December 16, 2010 10:49AM
U:\CIVIL\05440\08626-MENARDS\SW\2010\AS_BUILT\08626_D3.DWG