


**STORM WATER SEWER PLANS TO SERVE
MENARDS - WEST WICHITA, KS
STONEBRIDGE COMMERCIAL ADDITION**

**STORM WATER
PLAN & PROFILE
LINES 4 & 5**
SHEET TITLE
PROJECT NUMBER
08626

DESIGN BY
MKEC
DRAWN BY
MKEC
CHECKED BY
MAB

ISSUED **CONSTRUCTION**
5-04-10
REVISED **AS BUILT**
12-06-10



SHEET NO.
26 of 45

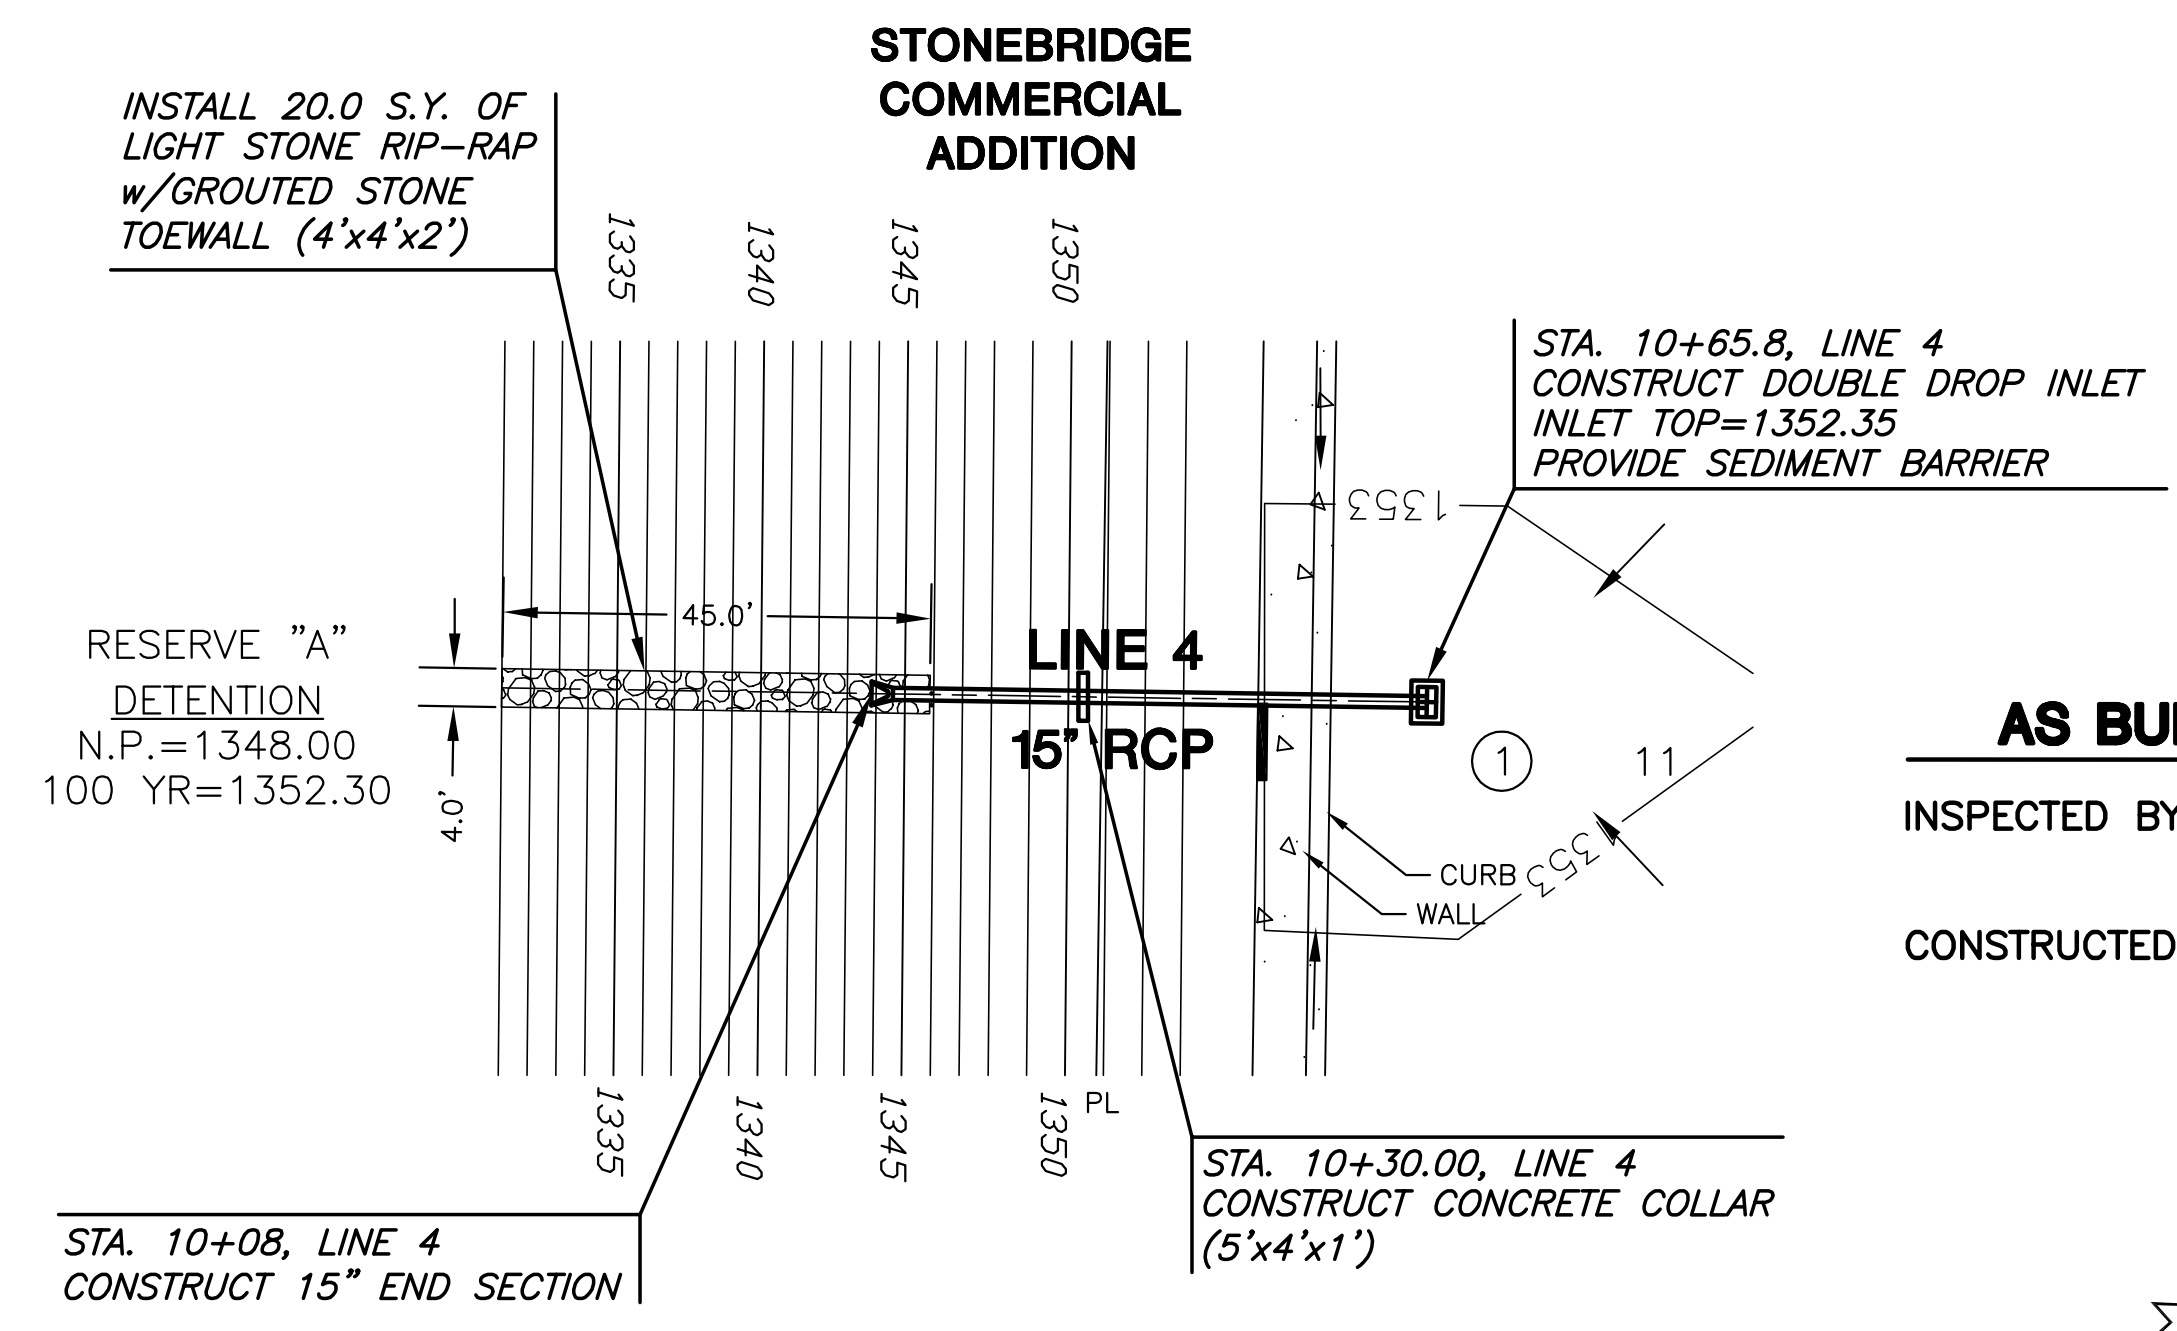

PLAN LINE 4
PROFILE LINE 4
SCALE: HORIZ. 1"=20'
SCALE: VERT. 1"=5'

NOTE:
EROSION CONTROL ADD ALT.
INSTALL SCOUR STOP INSTEAD
OF RIP-RAP SEE SHEET 29

AS BUILT PLANS: 12.6.10
INSPECTED BY: MIKE VANDECREEK, MKEC
ENGINEERING CONSULTANTS, INC
CONSTRUCTED BY: DULING CONSTRUCTION
CO., INC.

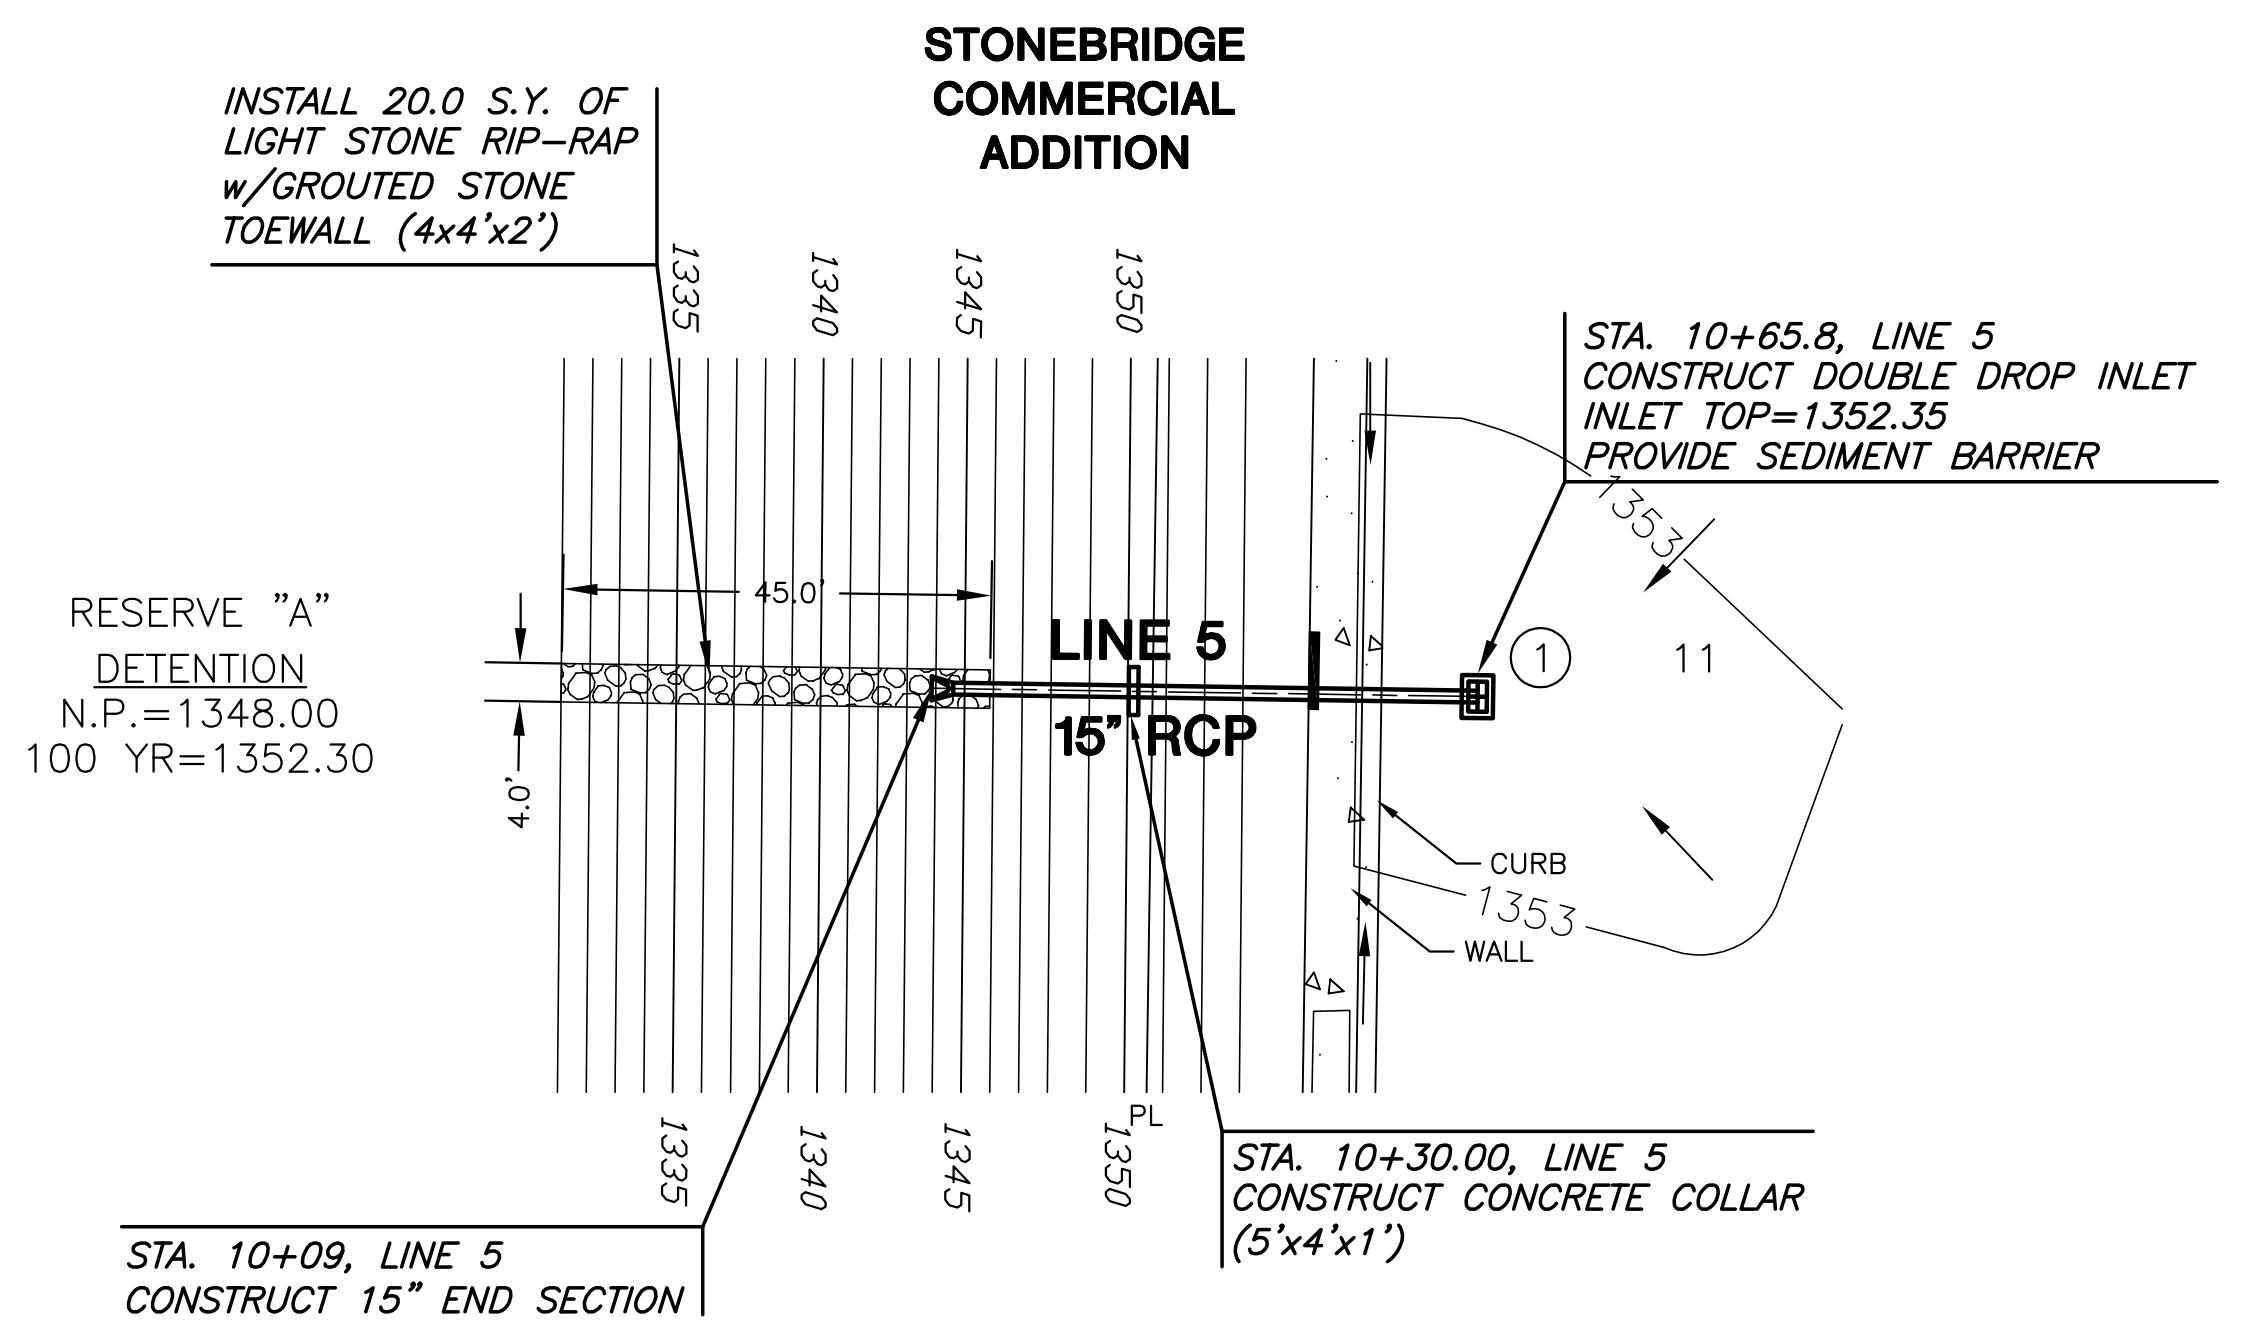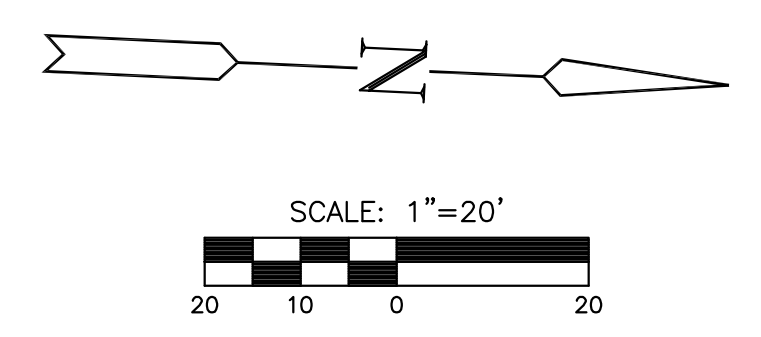

PLAN LINE 5
PROFILE LINE 5
SCALE: HORIZ. 1"=20'
SCALE: VERT. 1"=5'

