



1 MAIN LEVEL PLAN
1/2"=1'-0"

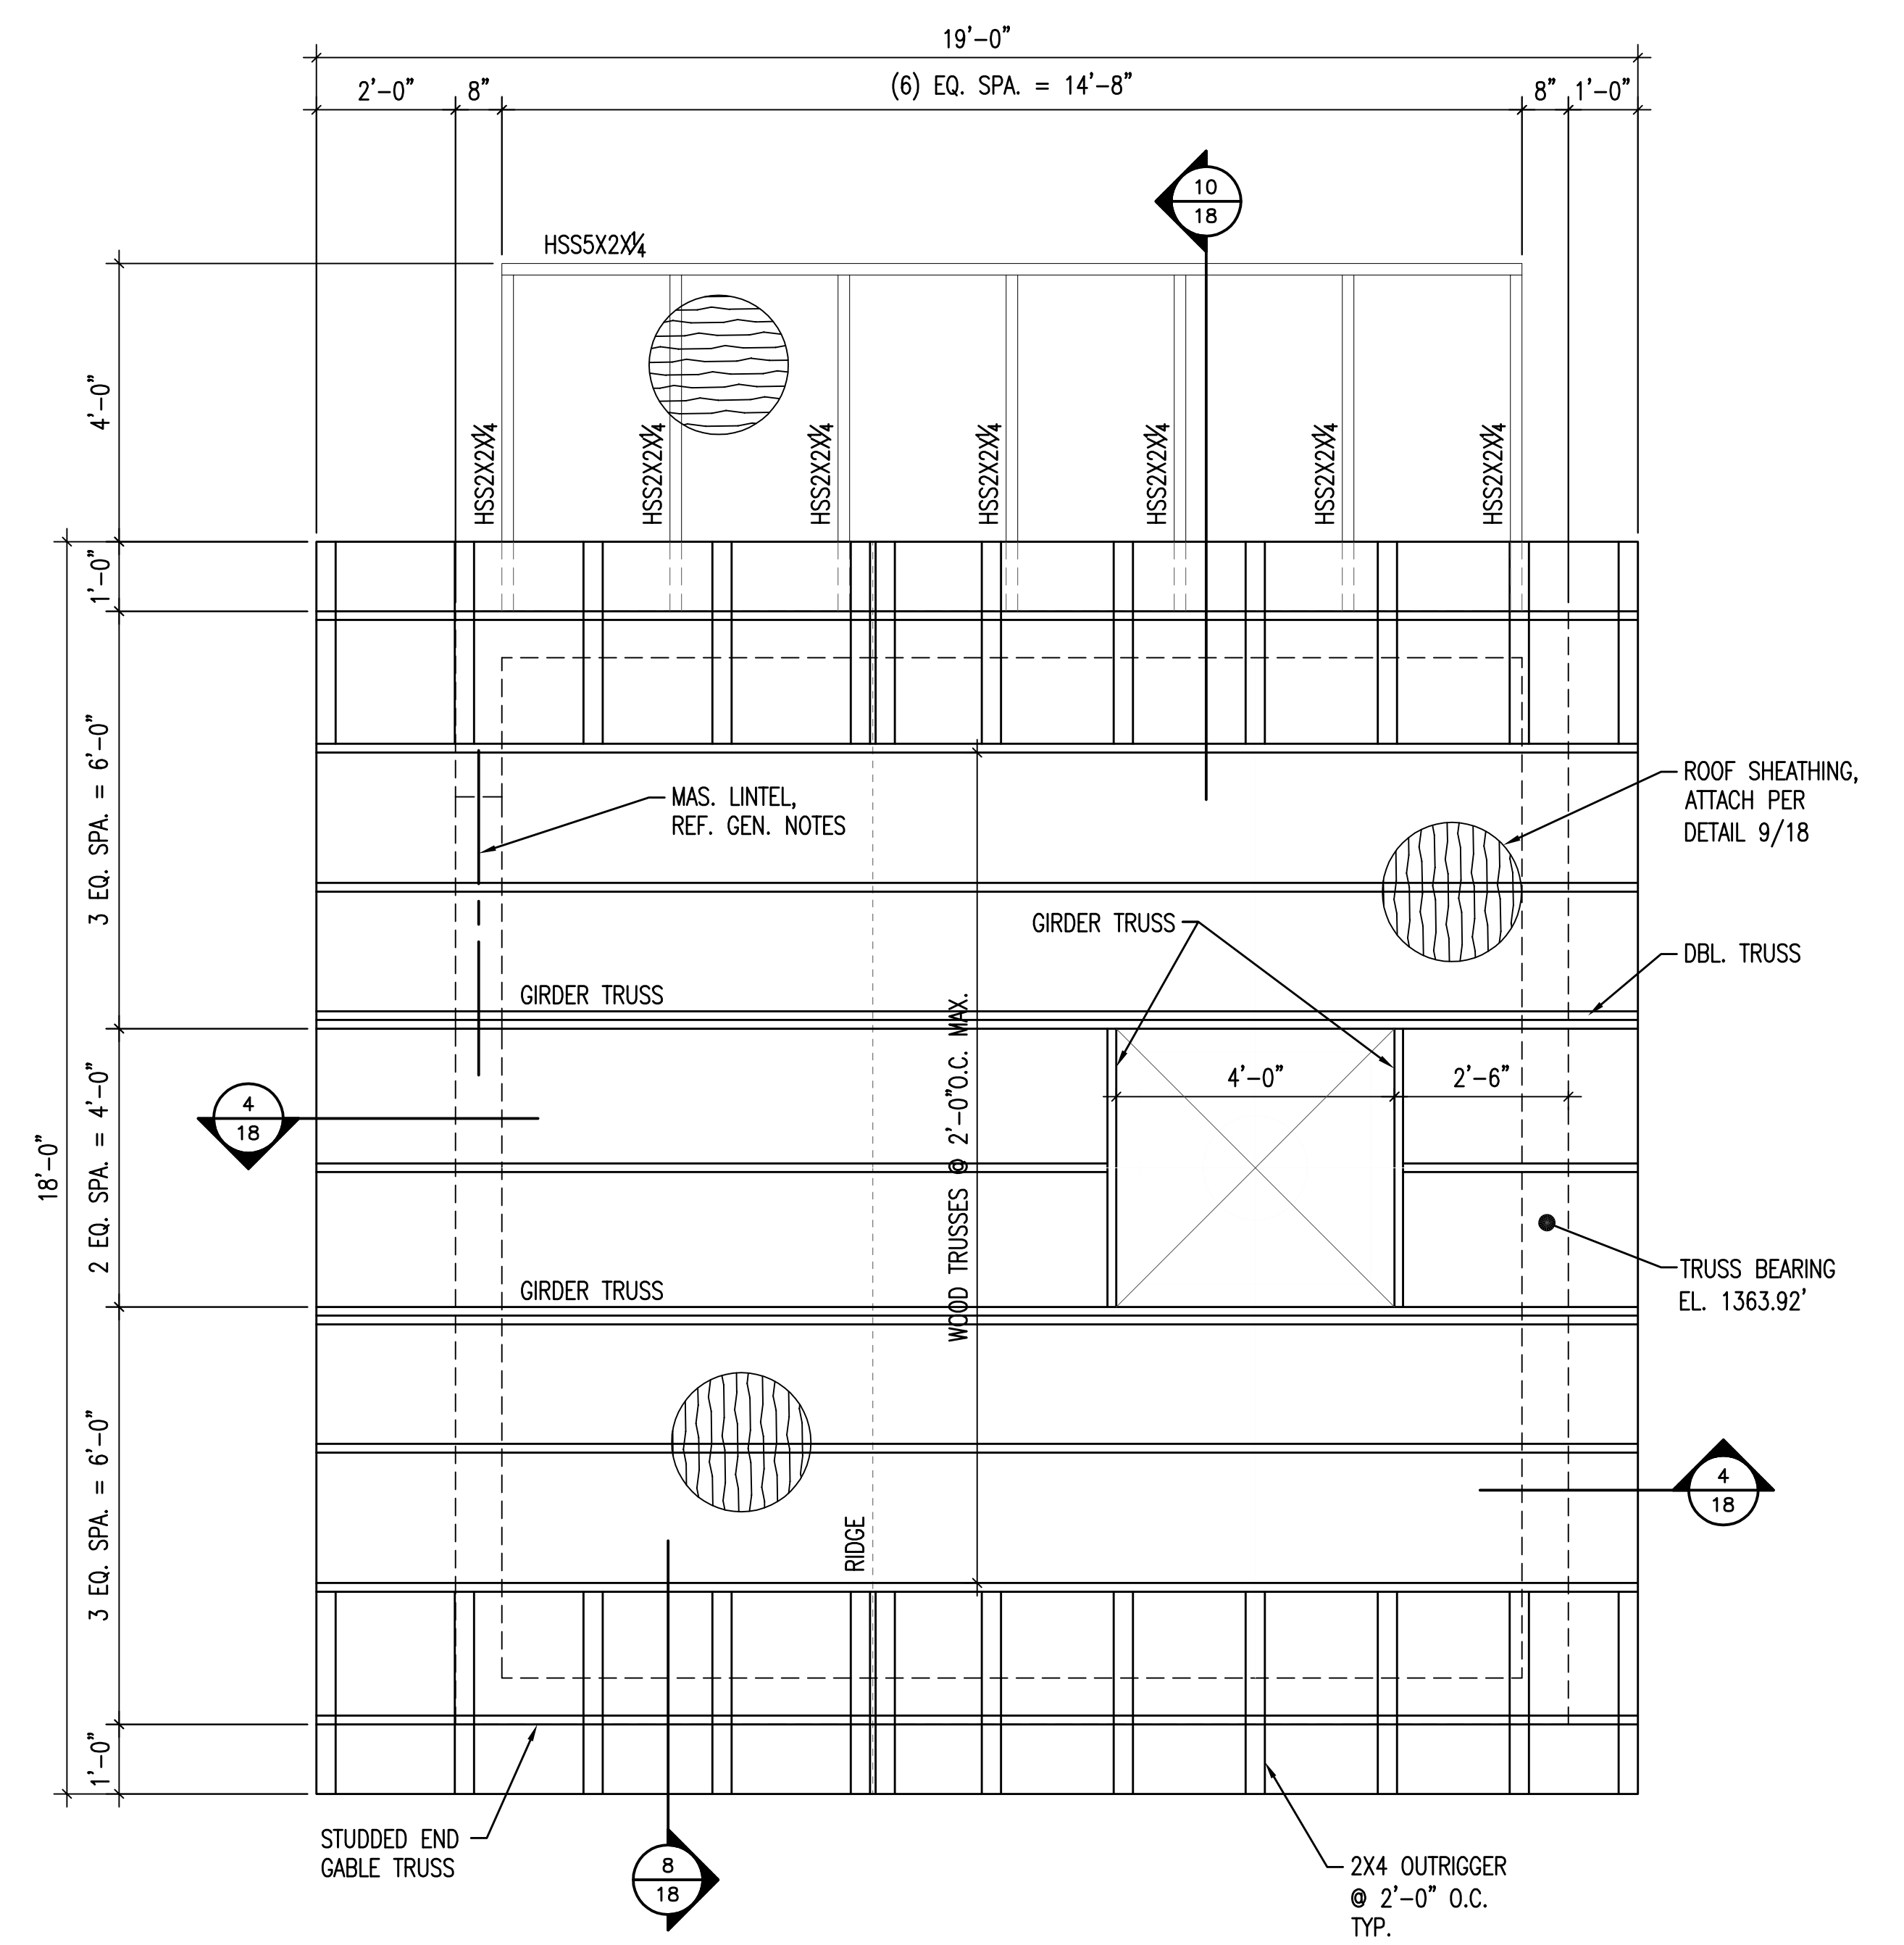

2 ROOF FRAMING PLAN
1/2"=1'-0"

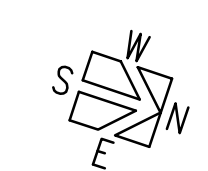

Saved: 09-29-2009 11:21:12 AM by DCC
 Plot Scale: 1/24 09-29-2009 11:21:32 AM
 S:\2009\04274\004\WEST\RE-BID\04274-17-PLAN by DCC

No.	Revision	By	Date
PHASE II - STORM WATER DRAIN #332 WEST PUMP STATION MAIN LEVEL & ROOF PLANS JAMES L. ARMOUR, P.E. - CITY ENGINEER CITY OF WICHITA PROJECT NO. 468-84396 Professional Engineering Consultants, P.A. 303 S. TOPEKA • WICHITA, KANSAS 67202 316-262-2691 • FAX 316-262-3003			
Designed by	GB	Job No.	35-04274-042
Drawn by	DC	Date	SEPTEMBER 2009
			Sht. 17 of 63