


Saved: 09-25-2009 10:07:02 AM by: NSM  
 Plot Scale: 1:120 09-29-2009 1:32:38 PM  
 \\net\_local\_is\osail\_data\drawings\Draw20\2004\0427A\004\Fee-Bid\44274-004 - 21A - WEST - ELECTRICAL SITE PLAN

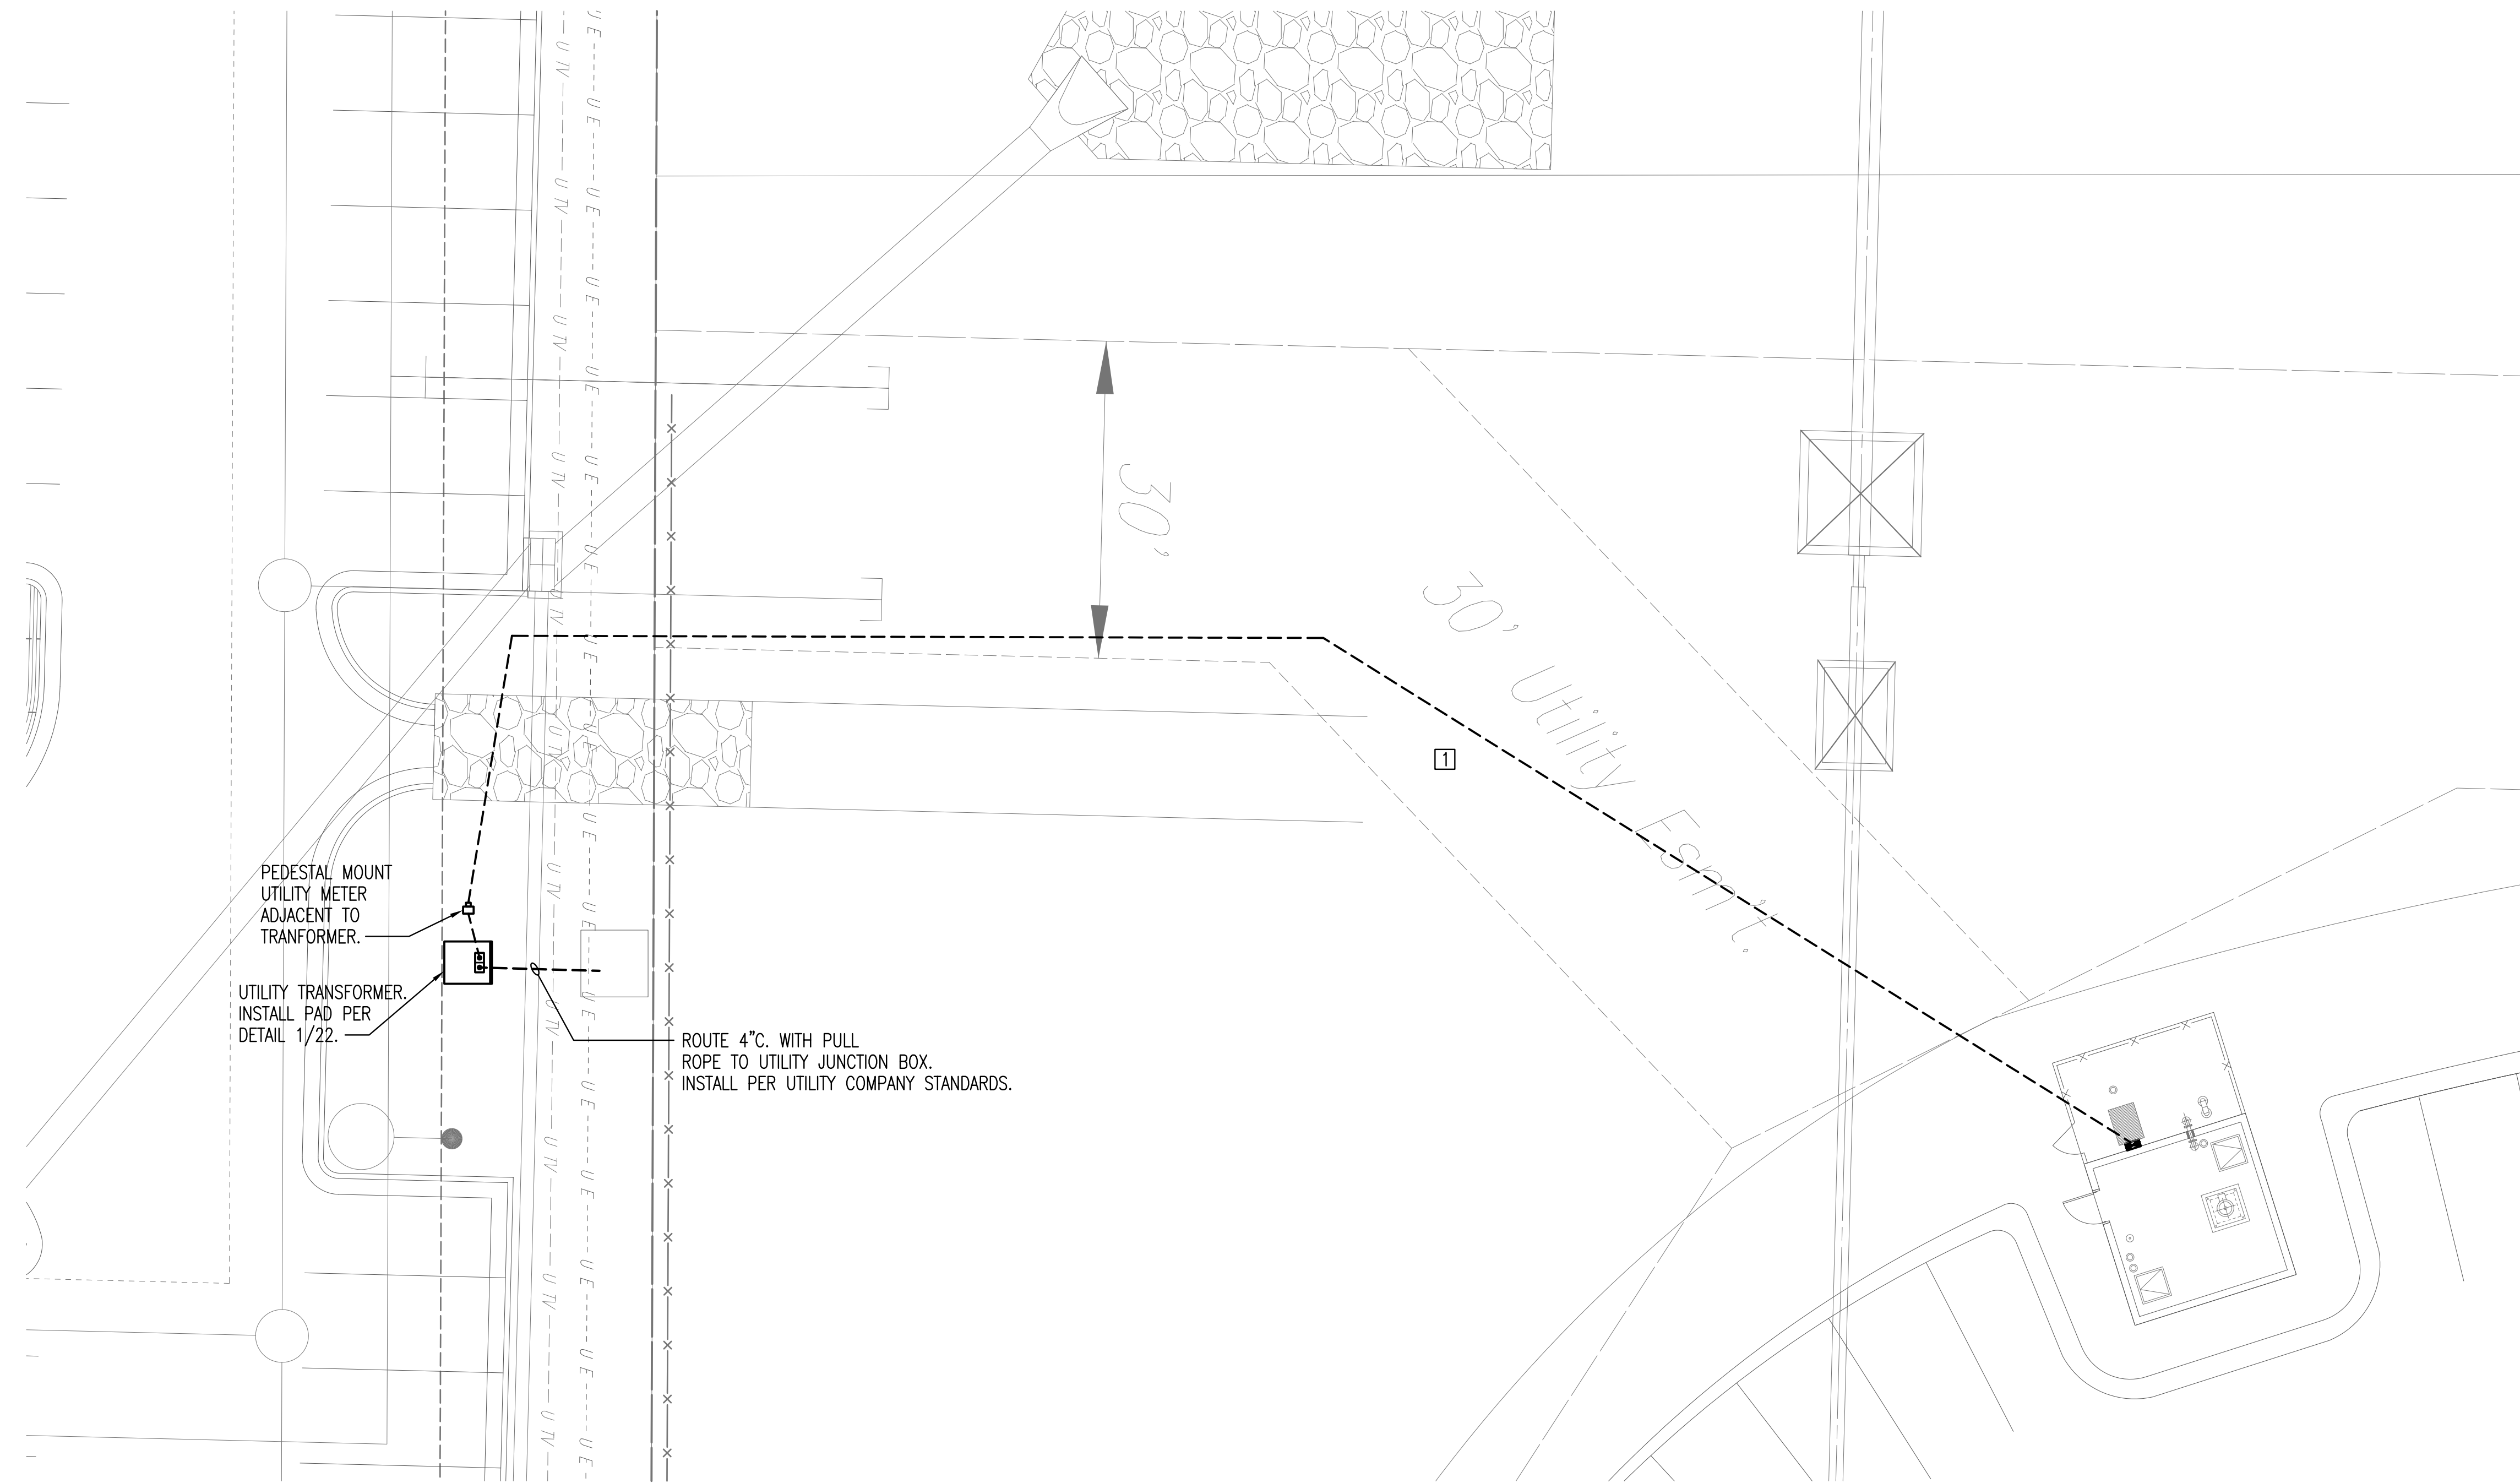

**A** **ELECTRICAL SITE PLAN**  
 1" = 10'-0"

|  |             |         |                |
|--|-------------|---------|----------------|
| 1  | ADDENDUM #2 | NSM     | 8/12/09        |
| No.  | Revision    | By      | Date           |
| <b>PHASE II - STORM WATER DRAIN #332</b><br><b>ELECTRICAL SITE PLAN</b><br><b>WEST PUMP STATION</b><br>JAMES L. ARMOUR, P.E. - CITY ENGINEER<br>CITY OF WICHITA PROJECT NO. 468-84396<br><b>Professional Engineering Consultants, P.A.</b><br>303 S. TOPEKA • WICHITA, KANSAS 67202<br>316-262-2691 • FAX 316-262-3003 |             |         |                |
| Designed by  | RDB         | Job No. | 35-04274-042   |
| Drawn by   | NSM         | Date    | SEPTEMBER 2009 |
|  |             |         | Sht. 21A of 63 |