



1 MAIN LEVEL PLAN
 49 1/2"=1'-0"
 N
 W E
 S

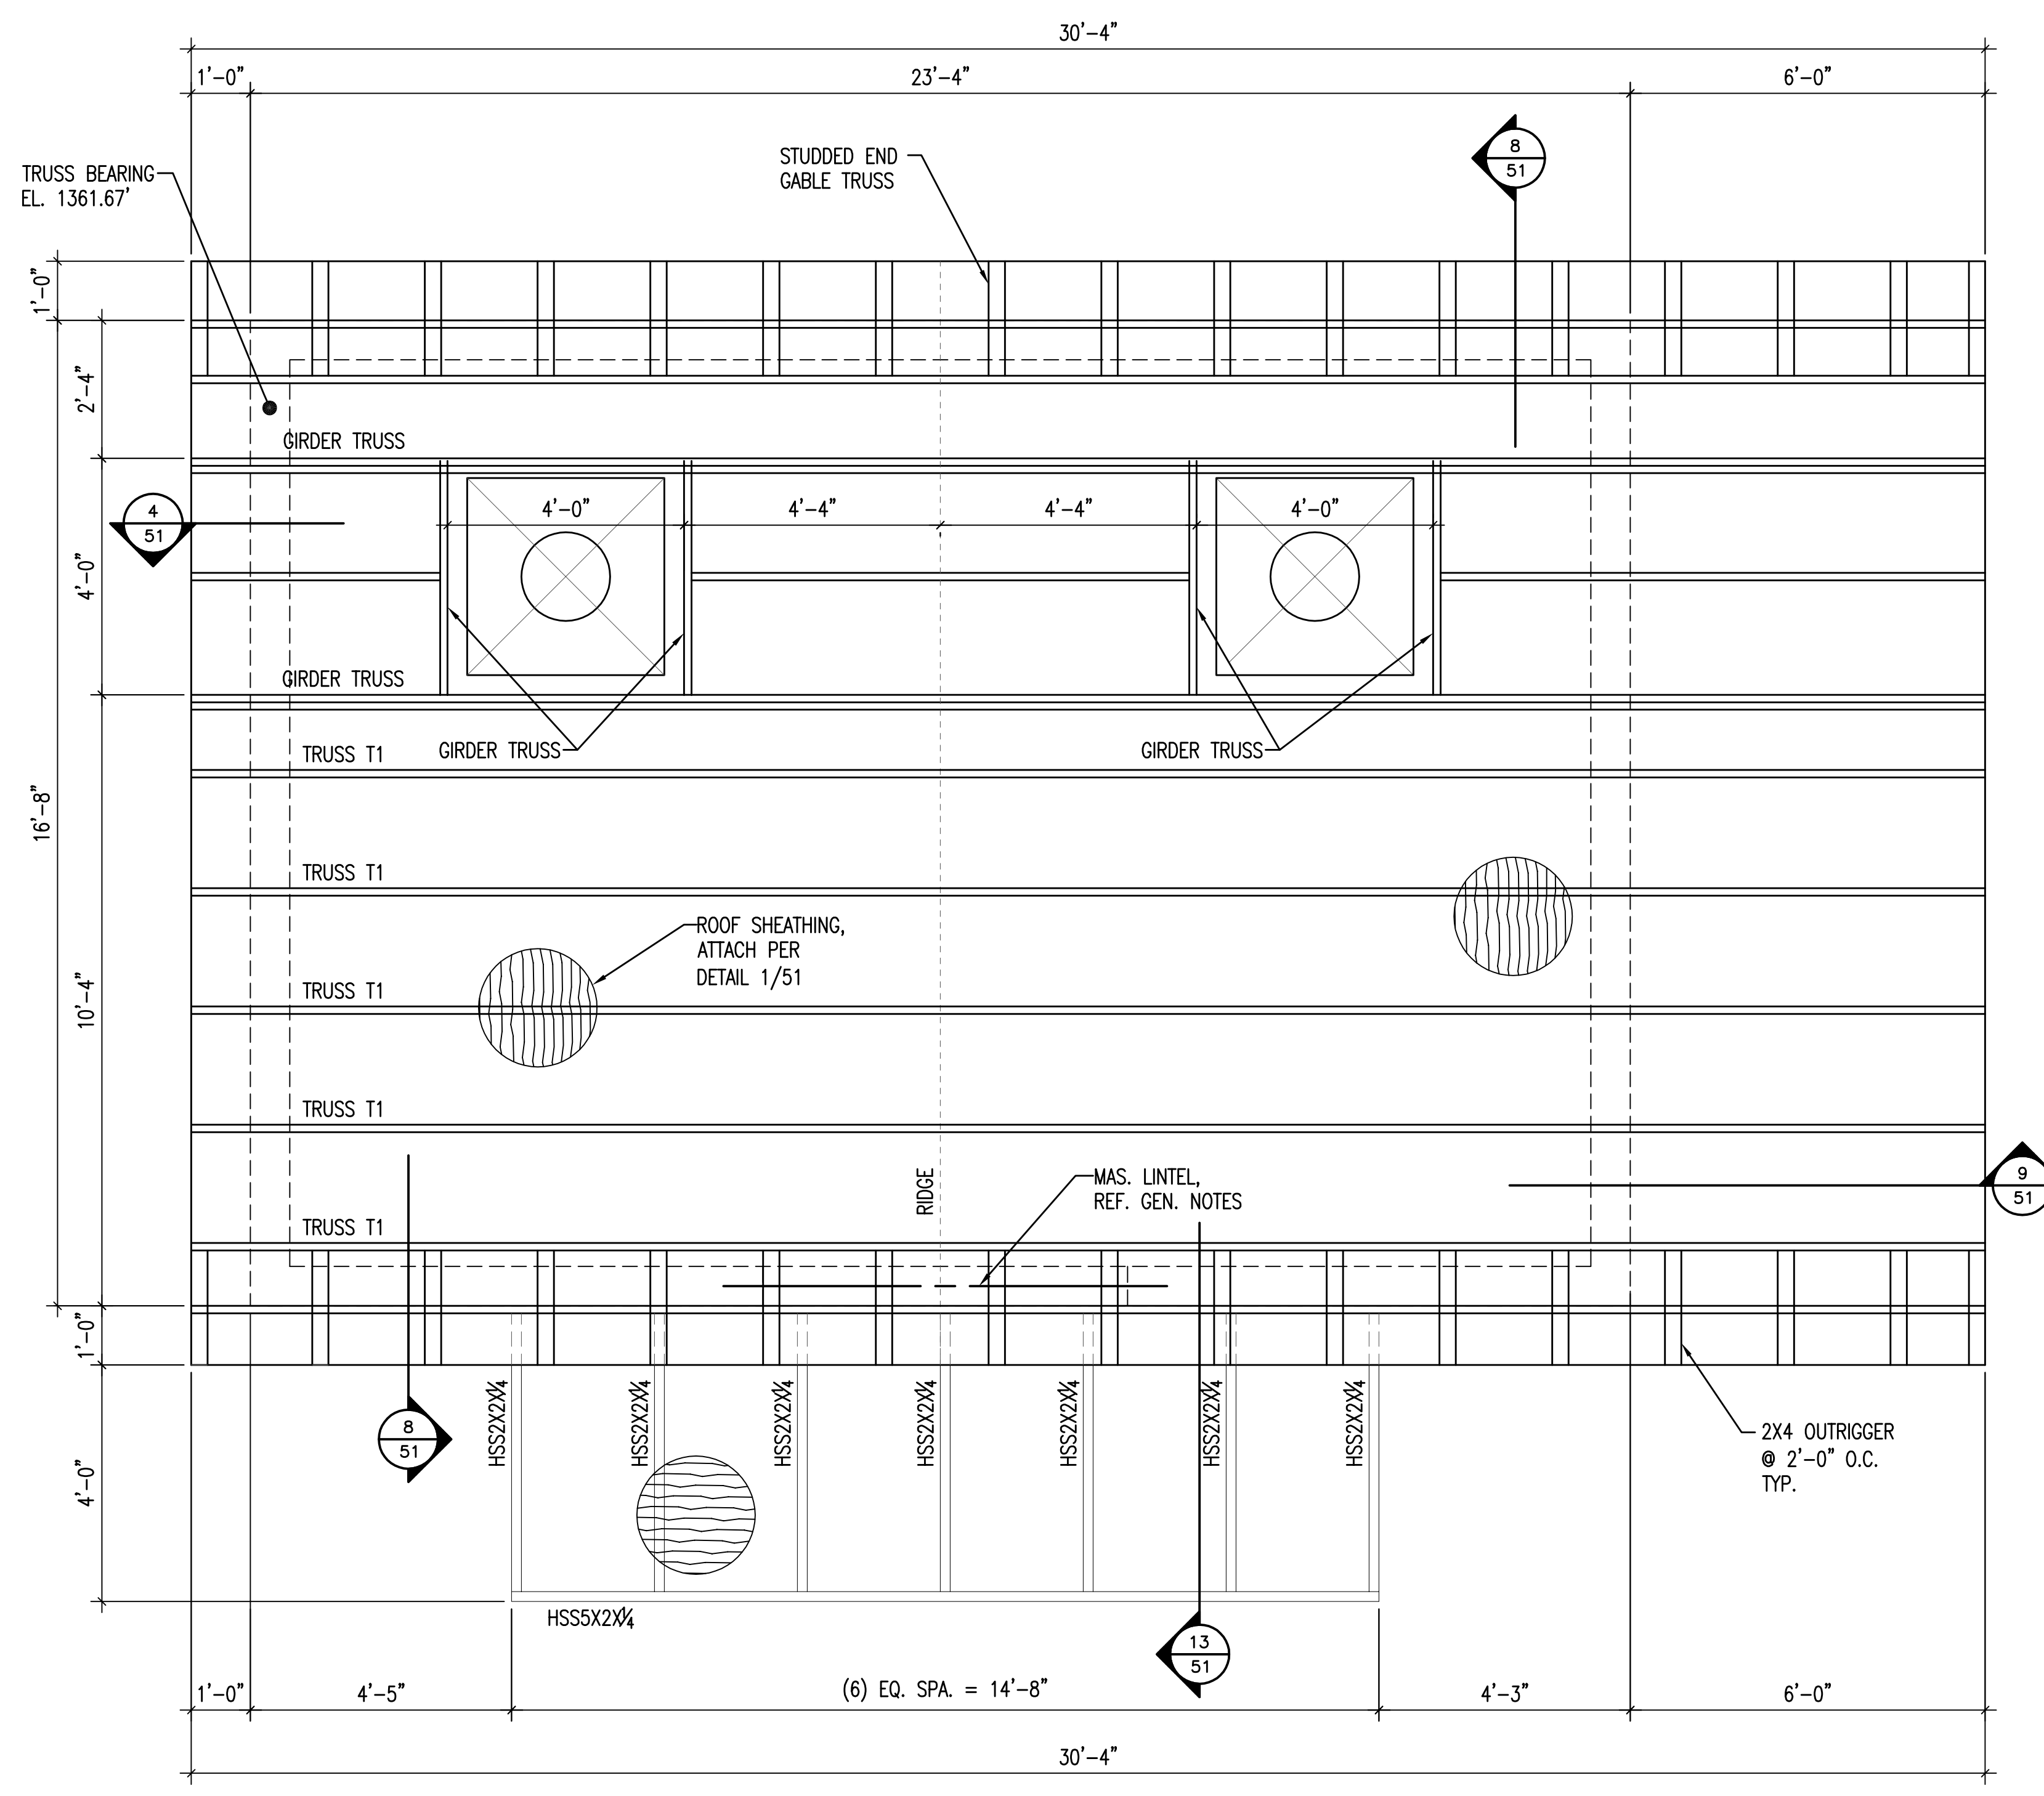

2 ROOF FRAMING PLAN
 49 1/2"=1'-0"
 N
 W E
 S

Saved: 09-29-2009 11:29:44 AM by DCC
 Plot Scale: 1/24 09-29-2009 11:30:15 AM
 S:\2009\04274\004\EAST\RE-BID\04274-49-PLAN

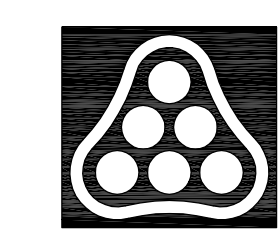

| No. | Revision | By | Date |
|---|----------|---------|----------------|
| PHASE II - STORM WATER DRAIN #332 EAST PUMP STATION MAIN LEVEL & ROOF PLANS JAMES L. ARMOUR, P.E. - CITY ENGINEER CITY OF WICHITA PROJECT NO. 468-84396 Professional Engineering Consultants, P.A. 303 S. TOPEKA • WICHITA, KANSAS 67202 316-262-2691 • FAX 316-262-3003 | | | |
| Designed by | GB | Job No. | 35-04274-042 |
| Drawn by | DC | Date | SEPTEMBER 2009 |