

q:\10-0998 city of wichita ks e maize and 29th st\dwg\final\10-0998 ssp.dwg - Plotted on 1/5/2011 2:39:02 PM @ a scale of 1:1 to pdf;xchange 4.0.pc3 by Scott Meigs



| UTILITY PROPOSED FEATURES | |
|---------------------------|-------------------------------------------------|
| | BOUNDARY LINE |
| | RIGHT OF WAY LINE |
| | EASEMENT LINE |
| | CONCRETE CURB AND GUTTER |
| | FENCE |
| | GUARD RAIL |
| | RETAINING WALL |
| | STORM DRAIN (SEE GRADING PLAN FOR SIZE) |
| | SANITARY SEWER SERVICE |
| | WATER SERVICE |
| | UNDERGROUND ELECTRIC SERVICE |
| | UNDERGROUND TELEPHONE SERVICE |
| | OVERHEAD ELECTRIC SERVICE |
| | OVERHEAD TELEPHONE SERVICE |
| | FIBER OPTIC CABLE SERVICE |
| | GAS SERVICE |
| | DRAINAGE STRUCTURES (SEE GRADING PLAN FOR TYPE) |
| | SANITARY SEWER MANHOLE |
| | FIRE HYDRANT WITH GUARD POSTS |
| | UTILITY POLE |
| | WATER LINE TEE, BEND, VALVE, AND PLUG |

UTILITY GENERAL NOTES

ALL SANITARY SEWER LINES SHALL HAVE A MINIMUM COVER OF 3'-0" COVER ABOVE TOP OF PIPE. PROPOSED UTILITIES TO BE BURIED IN THE SAME TRENCH INSTALLATION SHALL BE COORDINATED AND APPROVED BY LOCAL UTILITY COMPANIES.

VERIFY LOCATION AND DEPTH OF EXISTING UTILITY BEFORE CONSTRUCTING PROPOSED UTILITY. CONTRACTOR SHALL COORDINATE ANY DISRUPTIONS TO EXISTING UTILITY SERVICES WITH ADJACENT PROPERTY OWNERS.

ALL ELECTRIC, TELEPHONE AND GAS EXTENSIONS INCLUDING SERVICE LINES SHALL BE CONSTRUCTED TO THE APPROPRIATE UTILITY COMPANY SPECIFICATIONS. ALL UTILITY DISCONNECTIONS SHALL BE COORDINATED WITH THE DESIGNATED UTILITY COMPANIES.

CONSTRUCTION SHALL NOT START ON ANY PUBLIC UTILITY SYSTEM UNTIL WRITTEN APPROVAL HAS BEEN RECEIVED BY THE ENGINEER FROM THE APPROPRIATE GOVERNING AUTHORITY AND CONTRACTOR HAS BEEN NOTIFIED BY THE ENGINEER.

THE MINIMUM HORIZONTAL SEPARATION BETWEEN THE CLOSEST TWO POINTS OF THE WATER AND SEWER LINE IS TEN FEET (10'). THE MINIMUM VERTICAL SEPARATION BETWEEN THE CLOSEST TWO POINTS OF THE WATER AND SEWER LINE IS EIGHTEEN INCHES (18").

PRIOR TO THE CONSTRUCTION OF OR CONNECTION TO ANY STORM DRAIN, SANITARY SEWER, WATER MAIN OR ANY OF THE ABOVE UTILITIES, THE CONTRACTOR SHALL LOCATE, VERIFY AND CALCULATE ALL POINTS OF CONNECTION AND ALL UTILITY CROSSINGS AND INFORM OZARK CIVIL ENGINEERING AND THE OWNER/OWNER OF ANY CONFLICTS OR REQUIRED REVISIONS FROM THE PLAN. NOTIFICATION SHALL BE MADE A MINIMUM OF 48 HOURS PRIOR TO CONSTRUCTION. OZARK CIVIL ENGINEERING AND ITS CLIENTS SHALL BE HELD HARMLESS IN THE EVENT THAT THE CONTRACTOR FAILS TO MAKE SUCH NOTIFICATION.

ALL WATER AND SEWER LINE PIPE BEDDING SHALL BE INSTALLED PER DETAIL. (D121) (SEE DETAIL SHEETS)

CONTRACTOR SHALL BE RESPONSIBLE FOR NOTIFYING THE CITY CONSTRUCTION DIVISION TO SCHEDULE A PRE-CONSTRUCTION MEETING AT LEAST 48 HOURS PRIOR TO STARTING ANY WORK ON THIS PROJECT. CONTRACTOR SHALL OBTAIN ALL NECESSARY PERMITS.

EXISTING UTILITIES ACROSS OR ALONG THE LINE OF THE PROPOSED WORK ARE SHOWN ONLY IN AN APPROXIMATE LOCATION ON THESE PLANS. CONTRACTOR SHALL CALL THE STATE ONE-CALL SYSTEM OR DESIGNATED UTILITY COMPANY PRIOR TO CONSTRUCTION. CONTRACTOR SHALL OBTAIN HIS OWN INITIATIVE AND AT NO ADDITIONAL COST, LOCATE ALL UNDERGROUND LINES AND STRUCTURES AS NECESSARY. CONTRACTOR SHALL BE RESPONSIBLE FOR ANY DAMAGE TO UNDERGROUND LINES OR STRUCTURES.

CONTRACTOR SHALL NOT TAP OR OTHERWISE PENETRATE EXISTING WATER AND SEWER MAIN LINES WITHOUT PRIOR APPROVAL FROM THE CITY'S INSPECTOR. CONTRACTOR IS RESPONSIBLE FOR AVOIDING SPILLAGE OF RAW SEWAGE. CONTRACTOR SHALL PROVIDE ALL SEWER PLUGGING AND PLUMBER EQUIPMENT NECESSARY TO AVOID SPILLAGE. CONTRACTOR SHALL NOT OPERATE VALVES ON EXISTING WATER MAINS.

THE EXISTING UTILITIES AND OBSTRUCTIONS SHOWN ARE FROM THE BEST AVAILABLE RECORDS AND SHALL BE VERIFIED BY THE CONTRACTOR TO HIS SATISFACTION PRIOR TO CONSTRUCTION. NECESSARY PRECAUTIONS SHALL BE TAKEN BY THE CONTRACTOR TO PROTECT EXISTING SERVICES AND MAINS AND ANY DAMAGE TO THEM SHALL BE REPAIRED IMMEDIATELY AT THE CONTRACTOR'S EXPENSE.

IT SHALL BE DISTINCTLY UNDERSTOOD THAT FAILURE TO SPECIFICALLY MENTION WORK WHICH IS REQUIRED TO COMPLETE THE PROJECT SHALL NOT RELIEVE THE CONTRACTOR OF HIS RESPONSIBILITY TO PERFORM SUCH WORK.

CONTRACTOR SHALL MATCH TOP OF PROPOSED SANITARY SEWER MANHOLE TO PROPOSED GRADES. IF A DISCREPANCY OCCURS BETWEEN PROPOSED GRADES AND PROPOSED STRUCTURE TOPS, THE GRADING SHALL GOVERN. IF THE DISCREPANCY IS MORE THAN 4 INCHES THE CONTRACTOR SHALL CONTACT THE ENGINEER OF RECORD.

ALL DIMENSIONS, UNLESS OTHERWISE NOTED, ARE MEASURED TO THE CENTERLINE OF PIPE OR FITTING, FACE OF CURB, THE EDGE OF PAVEMENT, THE EDGE OF SIDEWALK OR THE FACE/CORNER OF THE BUILDING(S).

ALL TRENCHING, PIPE LAYING, AND BACK FILLING PROCEDURES SHALL BE IN ACCORDANCE WITH FEDERAL OSHA REGULATIONS.

GENERAL CONTRACTOR SHALL HAVE APPROVAL OF ALL GOVERNING AGENCIES HAVING JURISDICTION OVER THIS SYSTEM PRIOR TO INSTALLATION.



ALL DISTURBED AREAS OF THE SITE WHERE CONSTRUCTION ACTIVITY HAS CEASED FOR MORE THAN 14 DAYS (OR MORE FREQUENT IF REQUIRED BY THE STATE) PERMITS SHALL BE TEMPORARILY SEEDED AND WATERED. AREAS OF FINAL GRADING SHALL BE TEMPORARILY OR PERMANENTLY SEEDED.

SITE BENCHMARK

SQUARE CUT ON TOP OF CURB AT NOSE OF ISLAND IN CENTER OF W. CENTRAL PARK STREET ON WEST SIDE OF N. MAIZE ROAD.

ELEVATION = 1351.84

| UTILITY DETAIL LIST | |
|---------------------|-----------------------------------------|
| | JACK & BORE DETAIL |
| | WATER AND SEWER TRENCH BACKFILL DETAILS |
| | SEWER APPURTENANCES DETAILS |

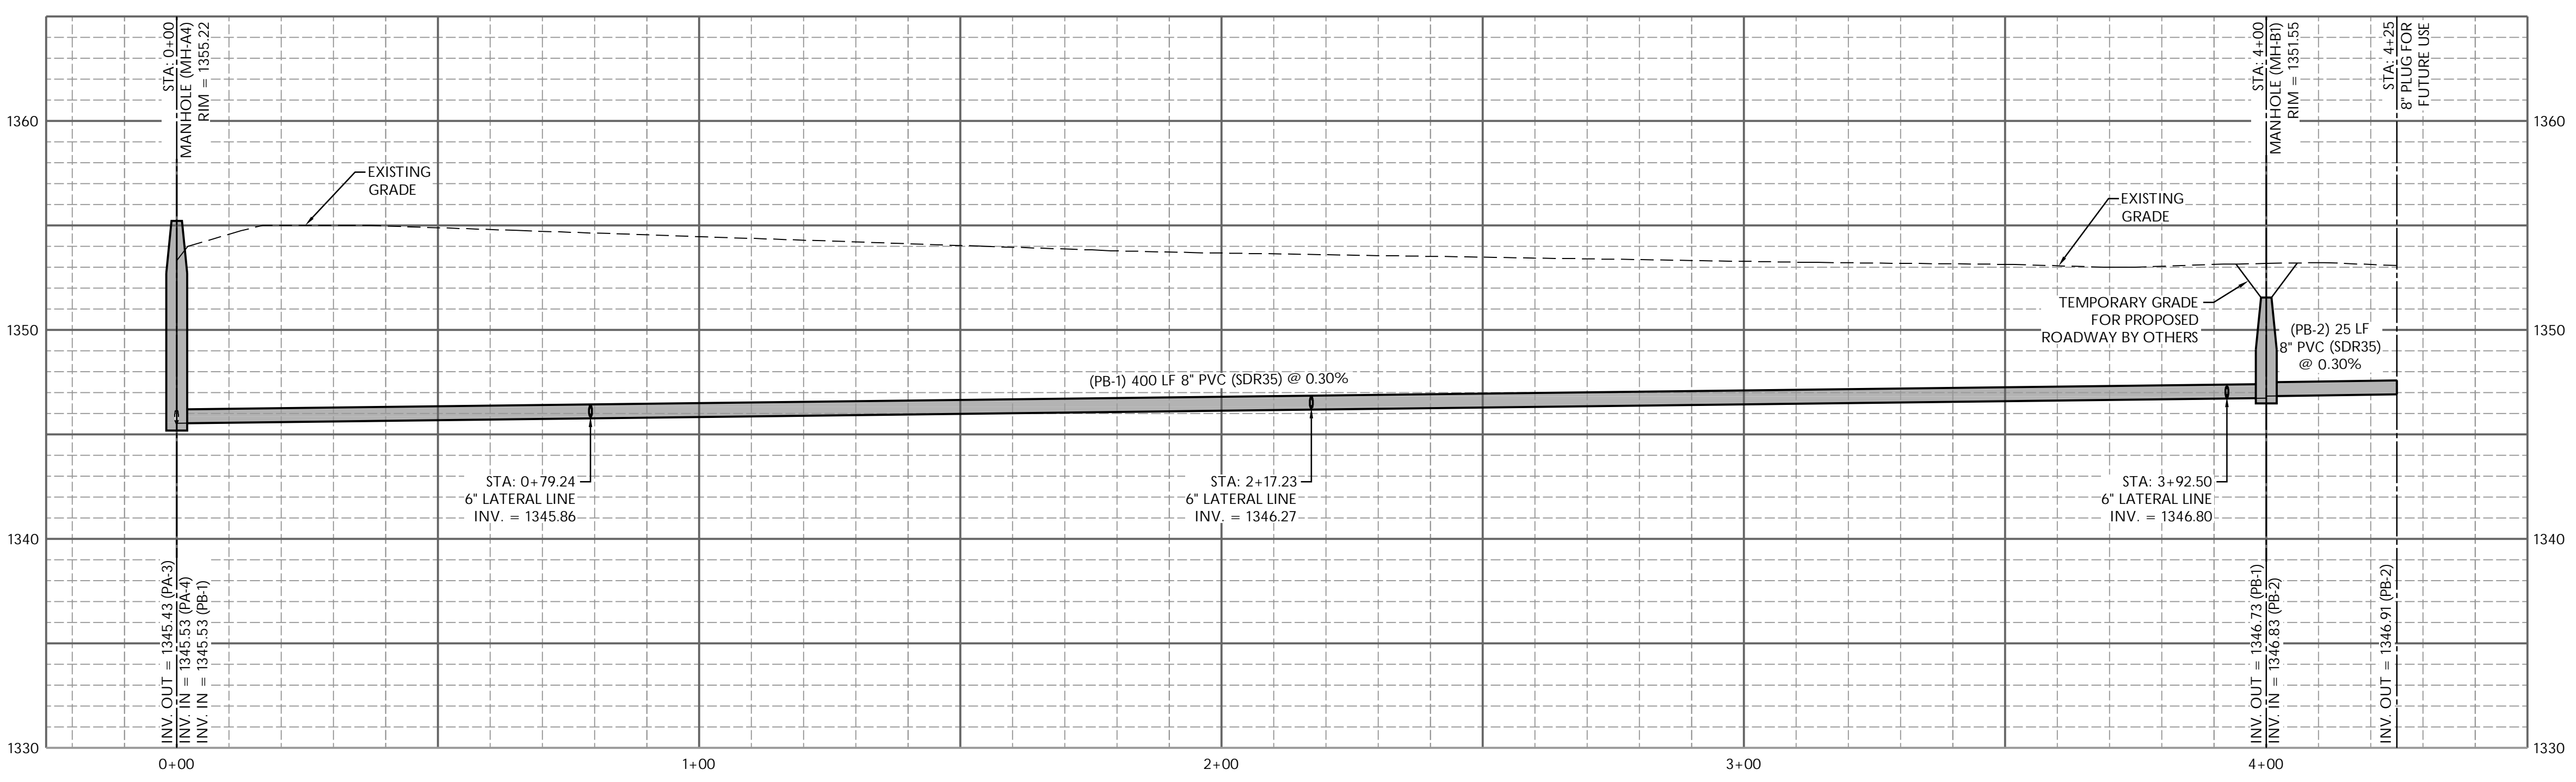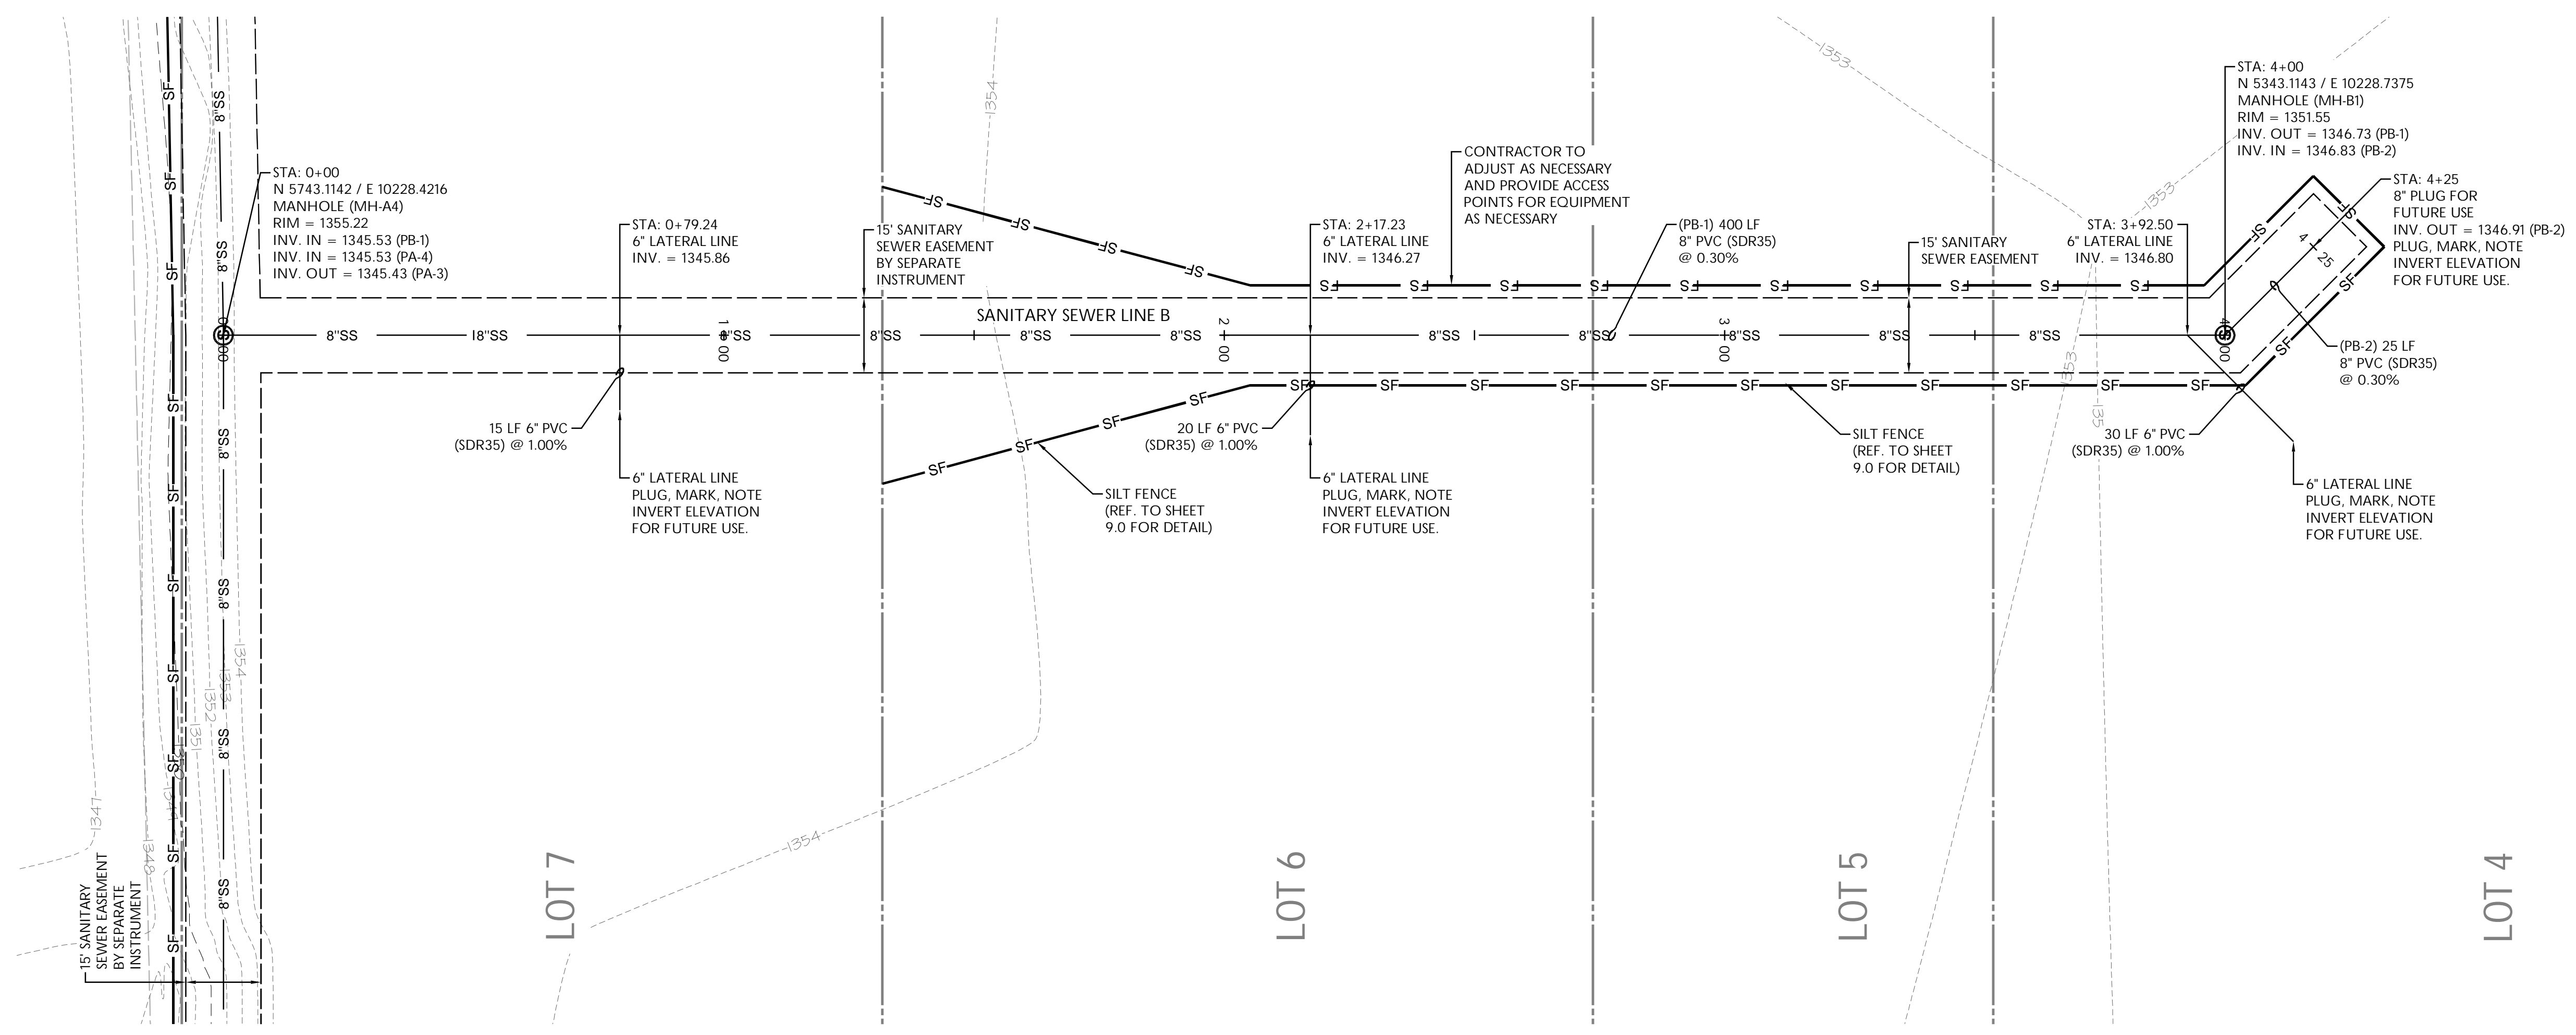

SANITARY SEWER LINE "B"
 HORZ. SCALE 1" = 20'
 VERT. SCALE 1" = 5'

| | |
|-------------------------------------------------------------------------------------------------------------------------------------------|-------------|
| BY | |
| DATE | |
| DESCRIPTION | |
| Ozark Civil Engineering Inc. Bentonville • Kansas City | |
| SANITARY SEWER LINE "B" SEWER IMPROVEMENT PLANS FOR THE CITY OF WICHITA EAST OF MAIZE RD AND SOUTH OF 29TH STT N WICHITA, KANSAS | |
| DRAWN BY: | JON |
| APPV. BY: | SM |
| DWG. NAME: | 10-0998 SPP |
| DATE: | 01/05/2011 |
| JOB NO.: | 10-0998 |
| SHEET NO.: | 4.0 |