 



STATE	PROJECT NO.	YEAR	SHEET NO.	TOTAL SHEETS
KANSAS	472 84614	-	158	534




Sta. 139+00.74 Line 2 =
 Sta. 752+84.37 136.10' Rt.
 1-16"x8" DIMJ Tee
 2-16" Anchor Valve Assy. (W&E)
 (MJ Butterfly Valve) Valve Box El.=
 1-8" Anchor Valve Assy. (S)
 (MJ Gate Valve) Valve Box El.=
 Connect To Exist. 8" (S)
 1-8" DIMJ Plug to Abandon (N)
 1-16" DIMJ Plug (E)

Install 84.37' of 16" Pipe

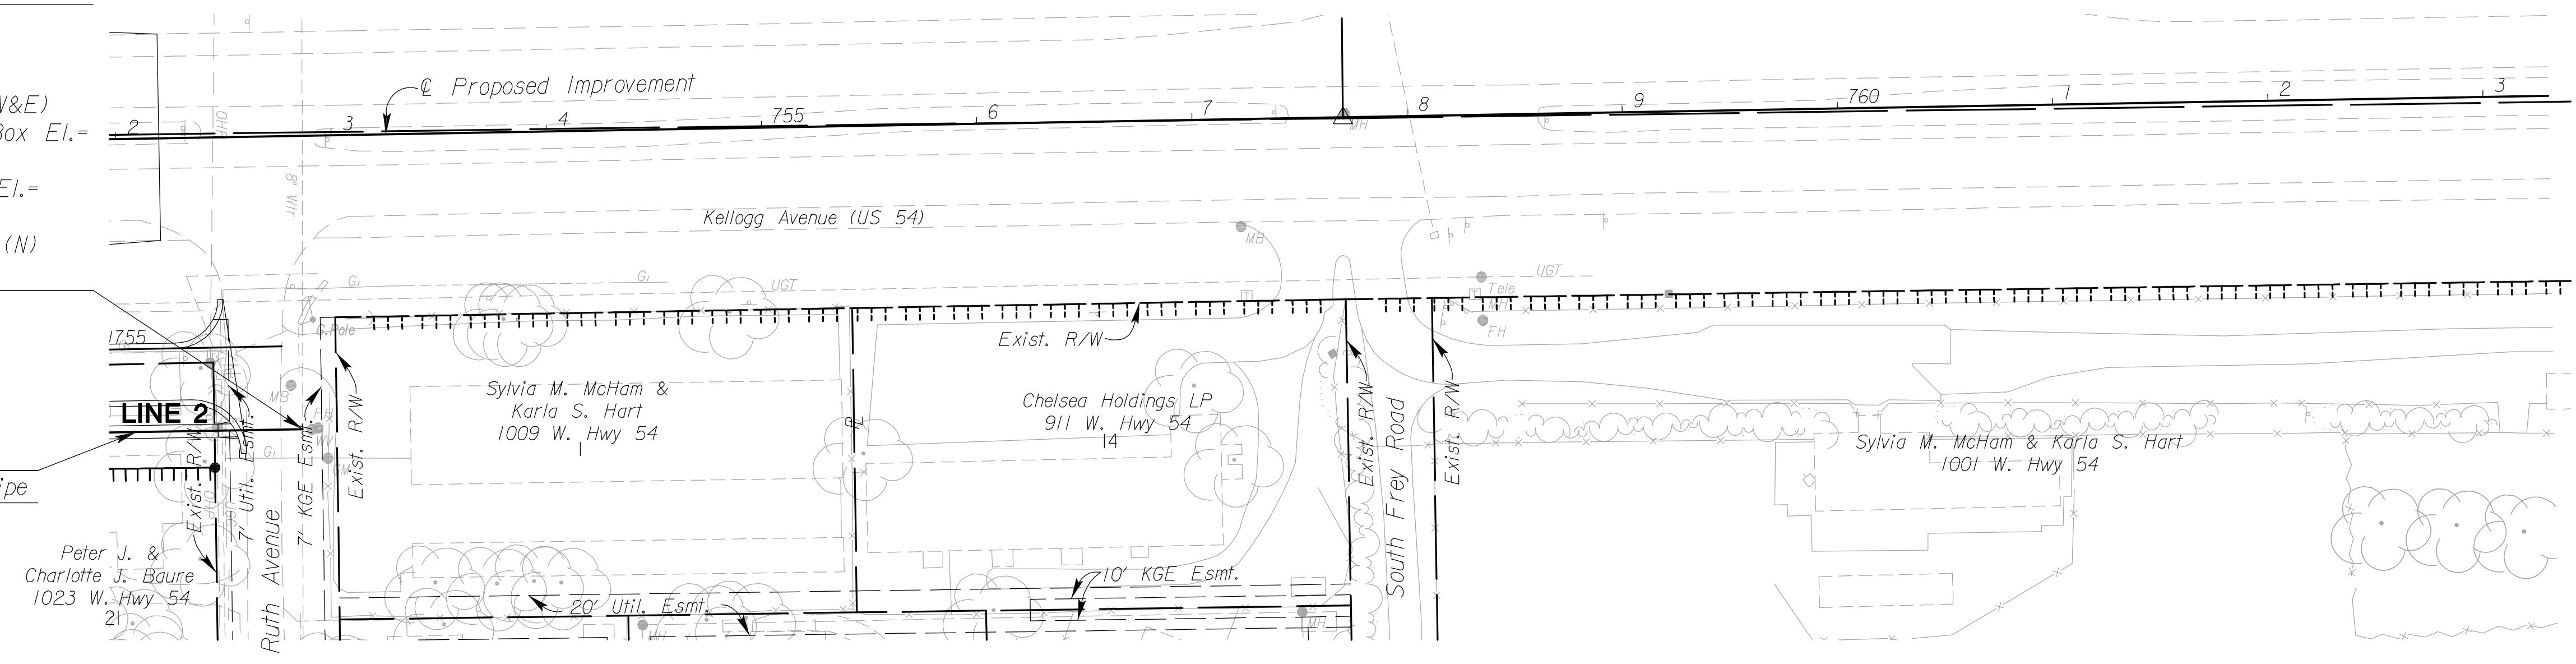

PLAN - LINE 2
 SCALE: 1" = 50'
 PROFILE - LINE 2
 HORIZ: 1" = 50'
 VERTICAL: 1" = 5'

See Sh. No's. 102-130 for SWS Plans.
 See Sh. No's. 136-139 for San. Sewer Plans.

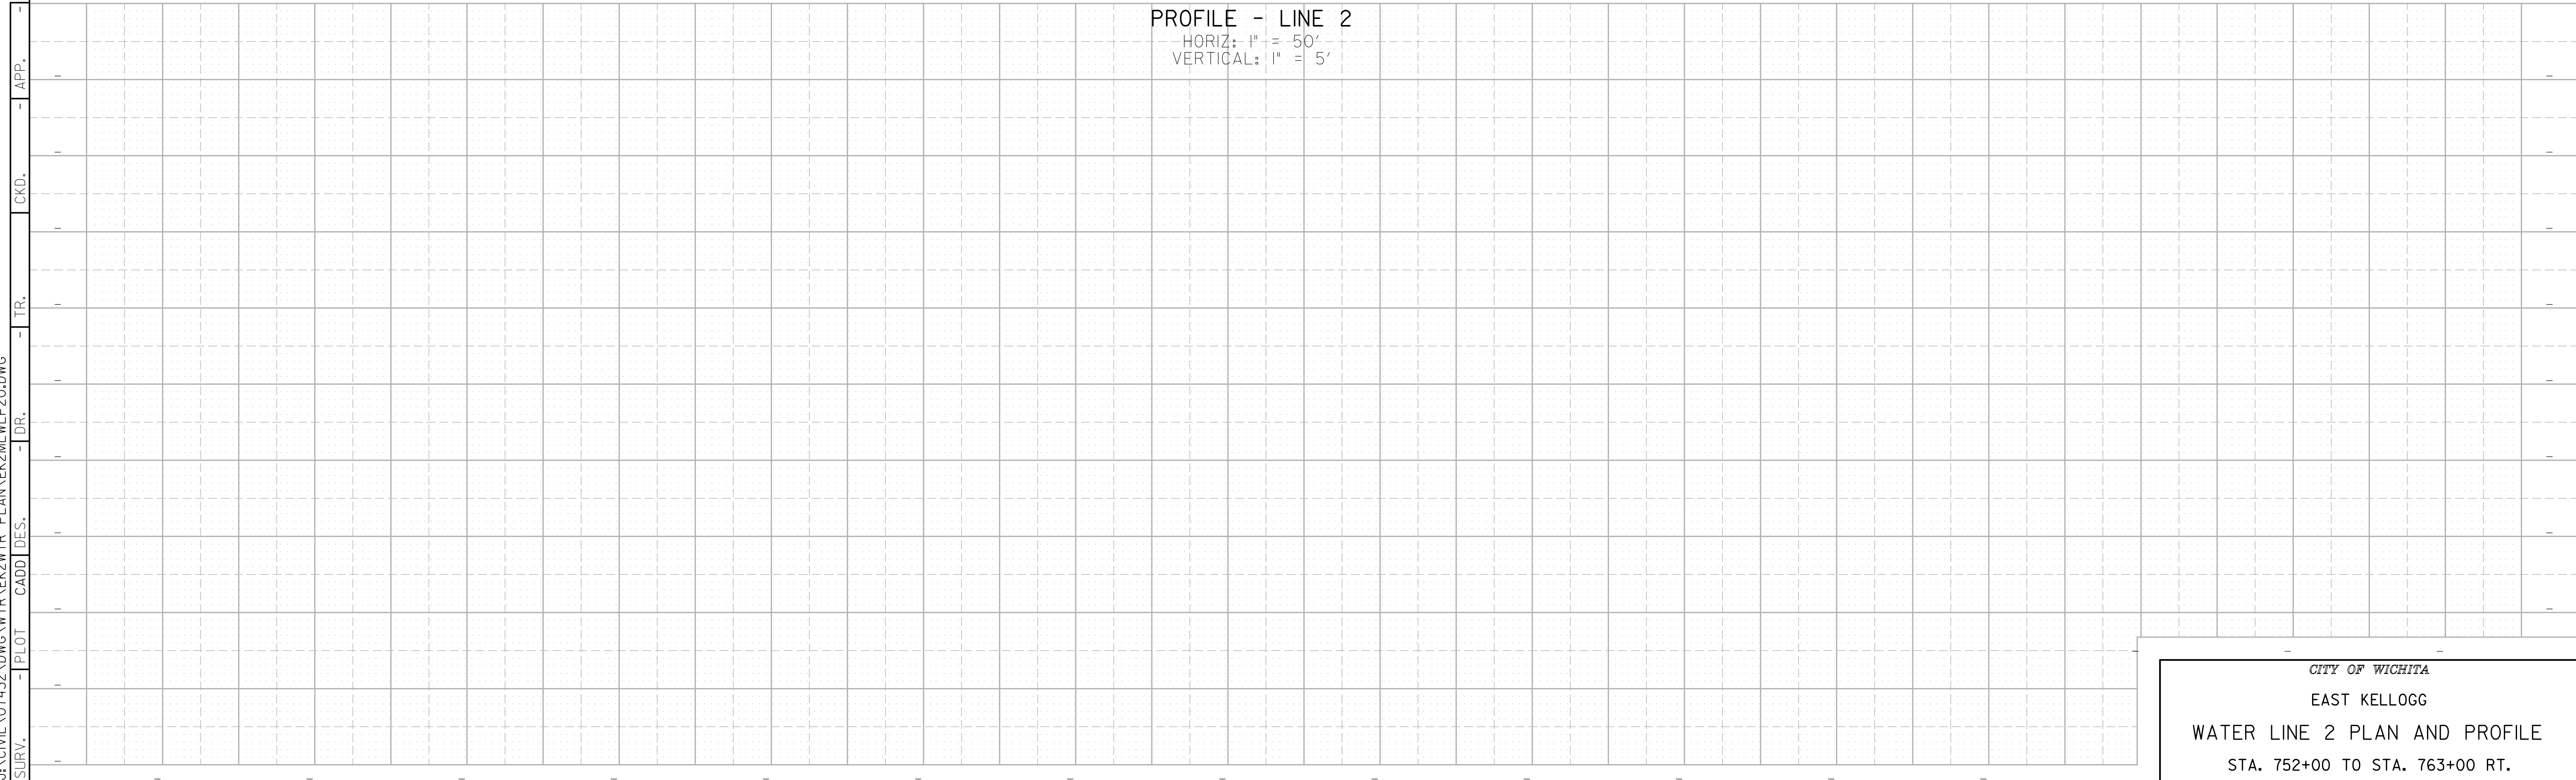

CITY OF WICHITA
 EAST KELLOGG
 WATER LINE 2 PLAN AND PROFILE
 STA. 752+00 TO STA. 763+00 RT.

10:21 AM
 2/22/2011
 J:\CIVIL\07432\DWG\WTR\K2WTR_PLAN\K2ML\LP20.DWG
 SURV. - PLOT CADD DES. - DR. - TR. - CKD. - APP.