

# CONSTRUCTION PLANS FOR WATER DISTRIBUTION SYSTEM IMPROVEMENTS

TO SERVE

## PART OF LOT 5, THE DUGAN CENTRE

(611 S. Dugan Road)



### THE CITY OF WICHITA, KANSAS

SEDGWICK COUNTY, KANSAS

JAMES L. ARMOUR, P.E. - CITY ENGINEER

#### INDEX OF SHEETS


SHEET NO. 1	TITLE SHEET
SHEET NO. 2	KEY MAP
SHEET NO. 3	STANDARD DETAILS
SHEET NO. 4	PLAN PROFILE
SHEET NO. 5-9	EROSION CONTROL DETAILS
SHEET NO. 10	PLAT

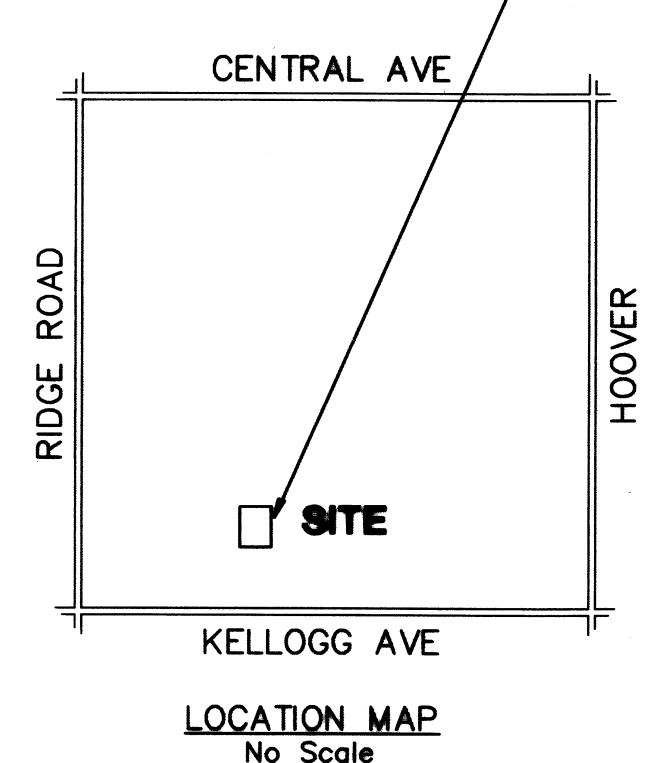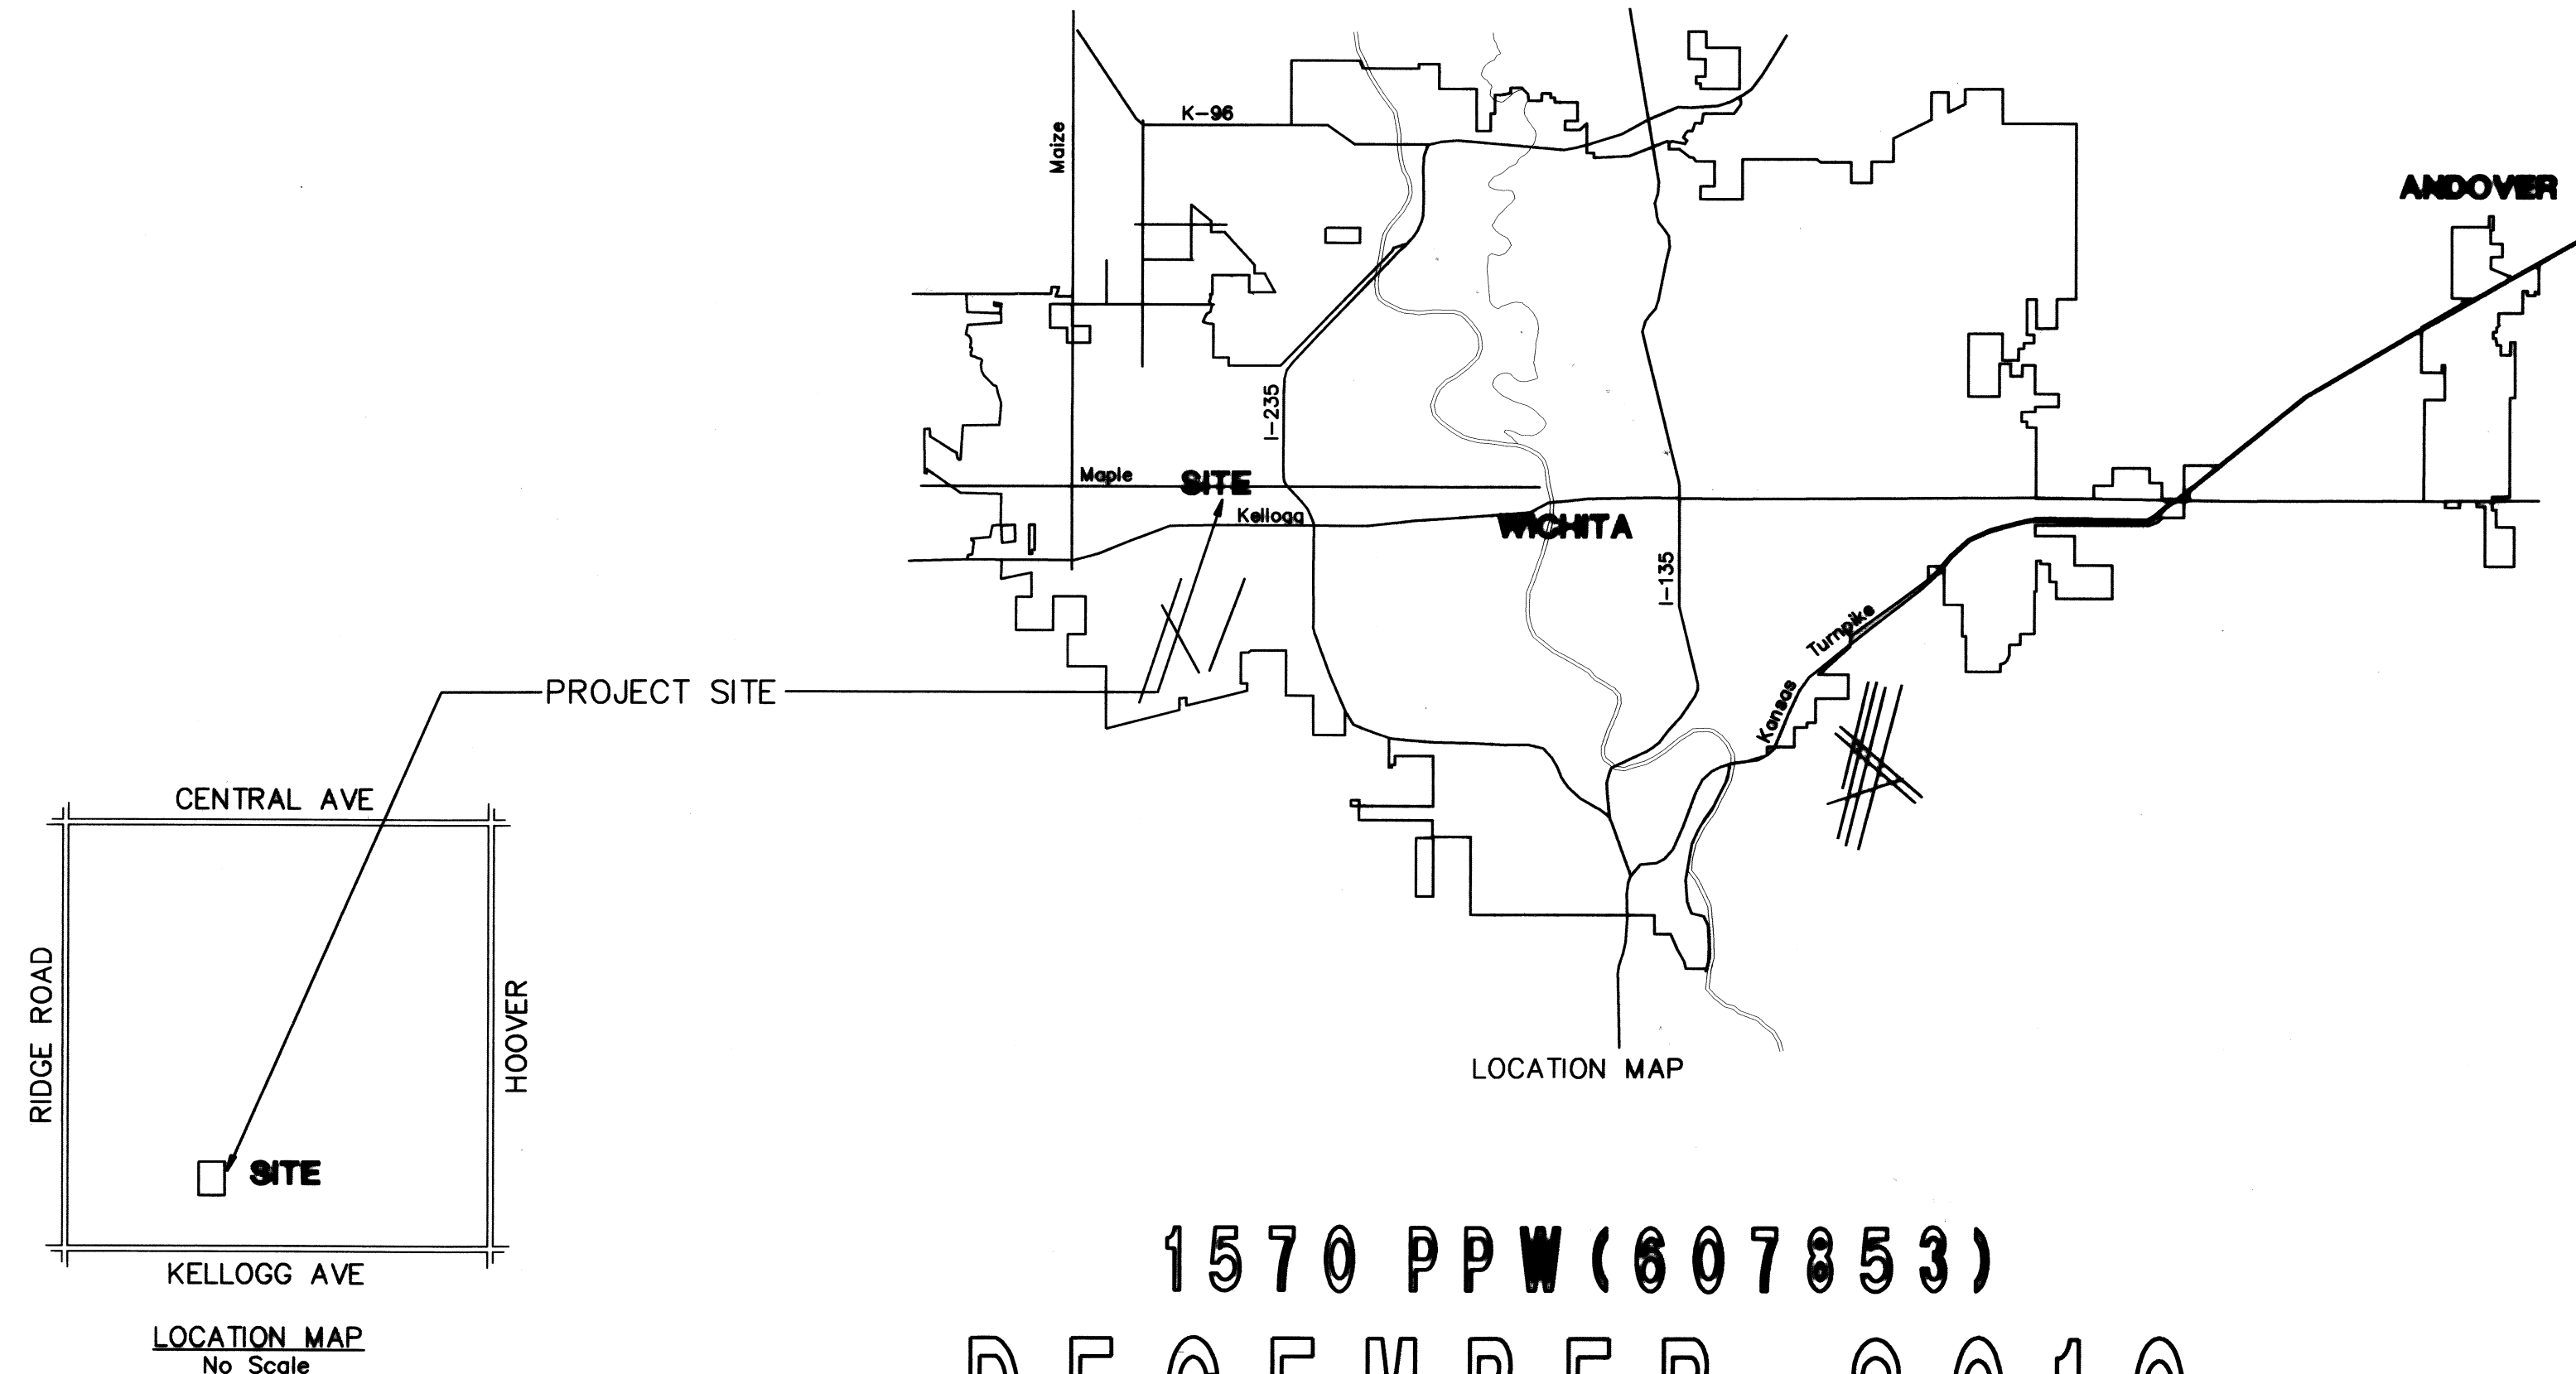

1570 PPW(607853)  
 DECEMBER 2010  
 PLANS PREPARED BY

AS BUILTS	
Contractor: Midwest Fire Protection Services 4/29/2011	Project Inspector: Larry Gann kemiller engineering 516 S. Market, Wichita, KS 67202 (316)264-0242

**PE** POE & ASSOCIATES, INC.  
 CIVIL & ENVIRONMENTAL ENGINEERING  
 5940 E. Central, Suite 200 ■ Wichita, KS 67208-4242  
 Phone 316/685-4114 ■ FAX 316/685-4444

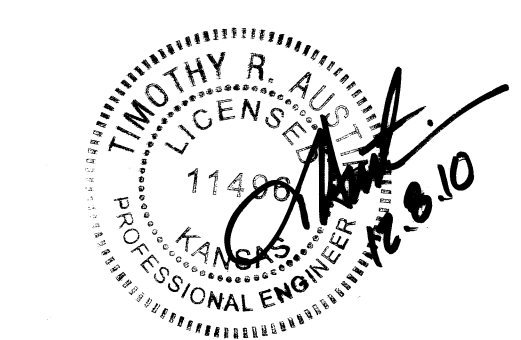

APPROVED AS NOTED  
 BY CITY ENGINEER OF WICHITA,  
 BY WICHITA WATER & SEWER DEPARTMENT,  
 & BY WICHITA FIRE DEPARTMENT

Public Works *[Signature]* 12/8/10  
 Water & Sewer *[Signature]* 12/08/2010  
 Fire *[Signature]* 12-14-2010

**NOTE TO CONTRACTORS**  
**Public Property:**  
 Inspection and testing for the waterline is to be provided by a Licensed Consulting Engineering Firm under contract with the Owner/Developer. Said inspection to be in accordance with the City of Wichita standard construction engineering practices and certified by a Professional Engineer Licensed in the state of Kansas. No work shall be performed in dedicated easements or public right-of-way by the Contractor without such inspection nor shall any work be commenced without written authorization by the City Engineer. All Construction and Materials shall comply with the City or Wichita Specifications and Standards (on file and available in the City Engineer's Office).

**Private Property:**  
 Installation and testing for the fire protection line is to be performed by a City of Wichita licensed fire protection contractor in accordance with the fire codes as adopted by the City of Wichita. All material and construction practices for the fire protection line shall comply with the fire codes as adopted by the City of Wichita (available from the City of Wichita Fire Department). The Contractor shall not commence work without notification and approval of the Wichita Fire Department. Inspection of the fire protection line is to be provided by a licensed Engineering Firm under contract with the Owner/Developer and the Fire Department. The contractor shall not start work until the project inspector is assigned to the project and present on the site. Any work done without inspection will be required to be uncovered for inspection.