


CONCRETE JOINT & PAVING LIMIT DETAIL OF SOUTH/NORTH ALLEY DRIVE
SCALE: 1"=10'

LEGEND

KV	LIGHT POLE AND FIXTURE TYPE (REF. SITE PLAN FOR DETAILS)	IRR	IRRIGATION WATER LINE
FV	FLOOD LIGHT	UGE	POWER UNDERGROUND BY CONTRACTOR
+	3 WAY FIRE HYDRANT	UGT	TELEPHONE UNDERGROUND (PER CITY STDS)
W.L. TEE	W.L. TEE	G	GAS LINE
W.L. GATE VALVE (G.V.)	W.L. GATE VALVE (G.V.)	CATV	CABLE TV
W.L. BENDS	W.L. BENDS	U/E	UTILITY EASEMENT
STORM SEWER INLET	STORM SEWER INLET	SS	SANITARY SEWER WATER LINE
STORM SEWER CURB INLET	STORM SEWER CURB INLET	W.L.	WATER LINE
STORM SEWER MANHOLE (SSMH)	STORM SEWER MANHOLE (SSMH)	DS	DOWNSPOUT
TYPE 2 (ROLL CURB)	TYPE 2 (ROLL CURB)	PP	POWER POLE
		M&M	MEET & MATCH
		TP	TOP OF PAVEMENT
		TC	TOP OF CURB

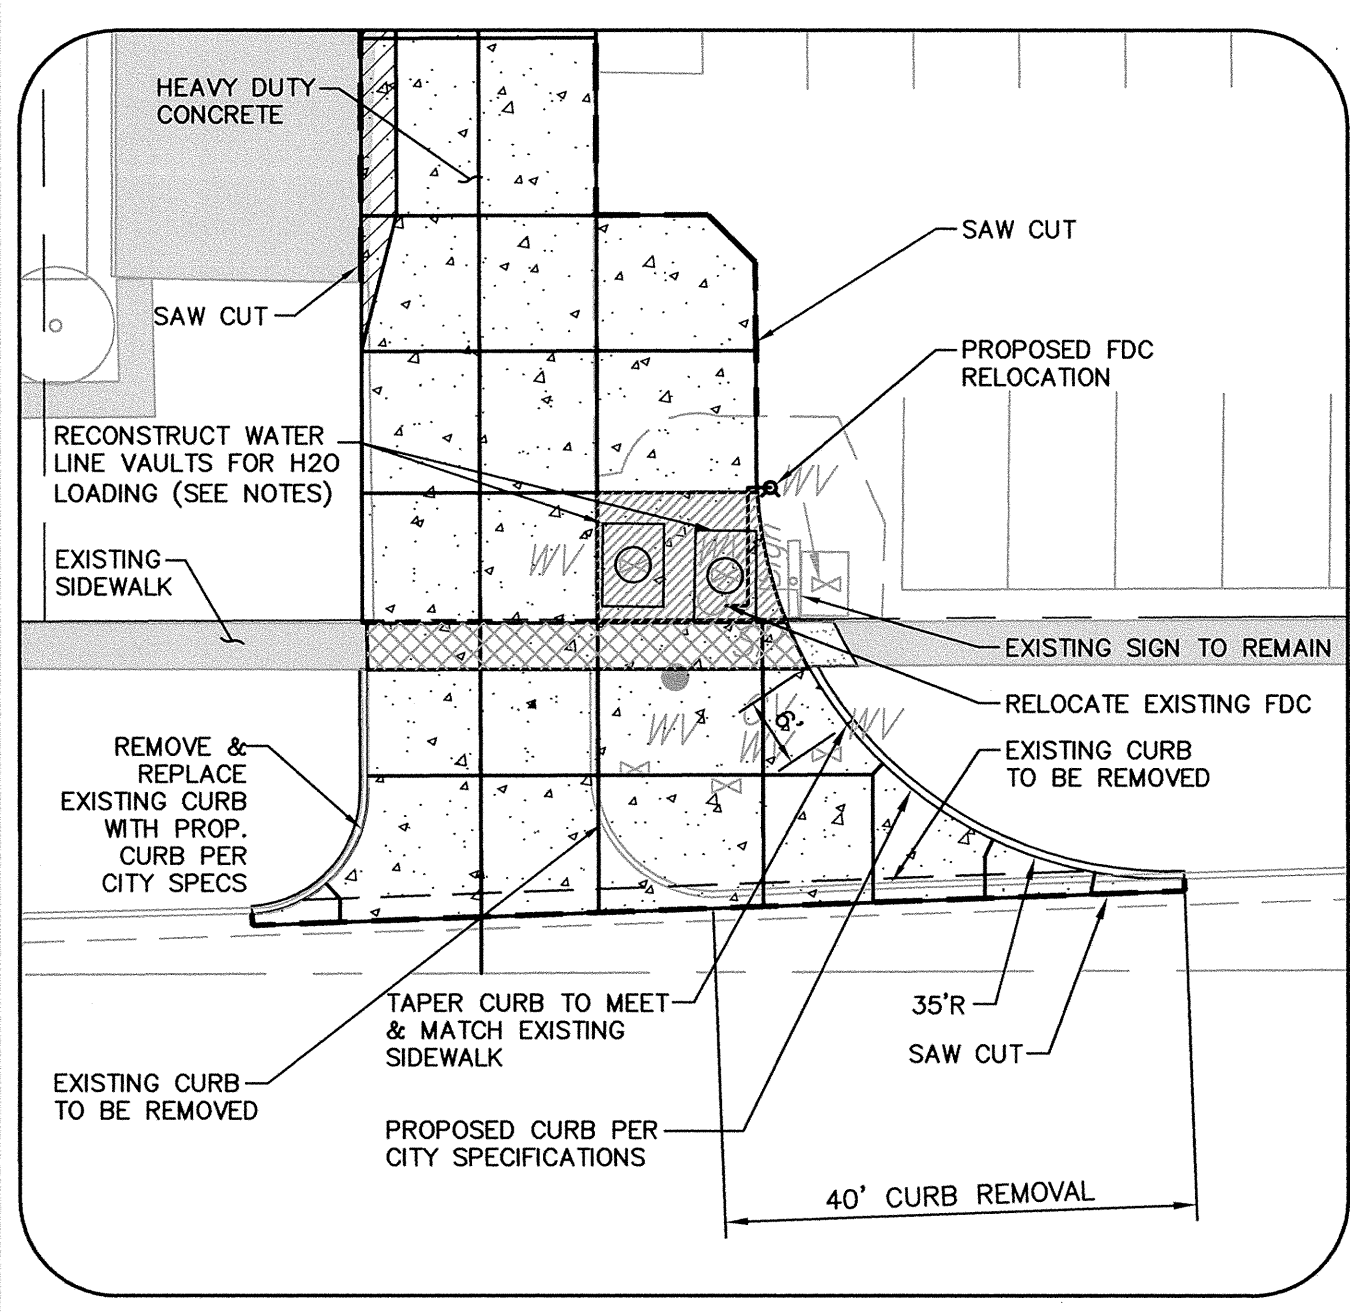

ALLEY DRIVE DETAIL
N.T.S.

- WATER VAULT NOTES:**
- #6 BARS AT 6"occcw (5" TO ϵ FROM TOP OF SLAB).
 - MINIMUM SLAB THICKNESS = 9" INCLUDING 1" CORRUGATED 22 GA. STEEL DECKING WITH MINIMUM BEARING OF 3" EACH SIDE.
 - CONCRETE f'_c = 4000PSI.
 - REINFORCEMENT TO BE GRADE 60.
 - (2) NEENAH R-6052-J MANHOLE FRAME LOCATED AT BOX MID-POINT, SOLID LID, US GOVERNMENT STANDARD.

ALLEY DRIVE DETAILS	
WALMART	
MARKET #5991-00	
31st STREET & S. SENECA STREET	
WICHITA, KANSAS	
SMC Consulting Engineers, P.C.	
815 West Main - Oklahoma City, OK 73106 PH: 405-232-7715 Fax: 405-232-7859	
KANSAS CERTIFICATE OF AUTHORIZATION NO. E-335 EXP. DEC. 31, 2011	
No.	Revision
1	City review comments
2	City & SMC review comments
DATE:	03/01/11
DRAWN BY:	MDS
PROJECT NO.:	4966.00
ENGINEER:	TERENCE L. HAYNES, P.E. #14583
SCALE:	AS SHOWN
SHEET NO.:	C-12.2

