



LANDSCAPE, LIGHTING, & IRRIGATION  
**BERKELEY SQUARE FIRST ADDITION**  
**HOME BANK & TRUST ADDITION**

**LIGHTING PLAN**


SHEET TITLE  
**472-85039**  
PROJECT NUMBER

MKEC / JJW / BWB  
DESIGNED / DRAWN / CHECKED

ISSUED  
**FEBRUARY 2012**


REVISED

SHEET NO.  
**4 of 8**

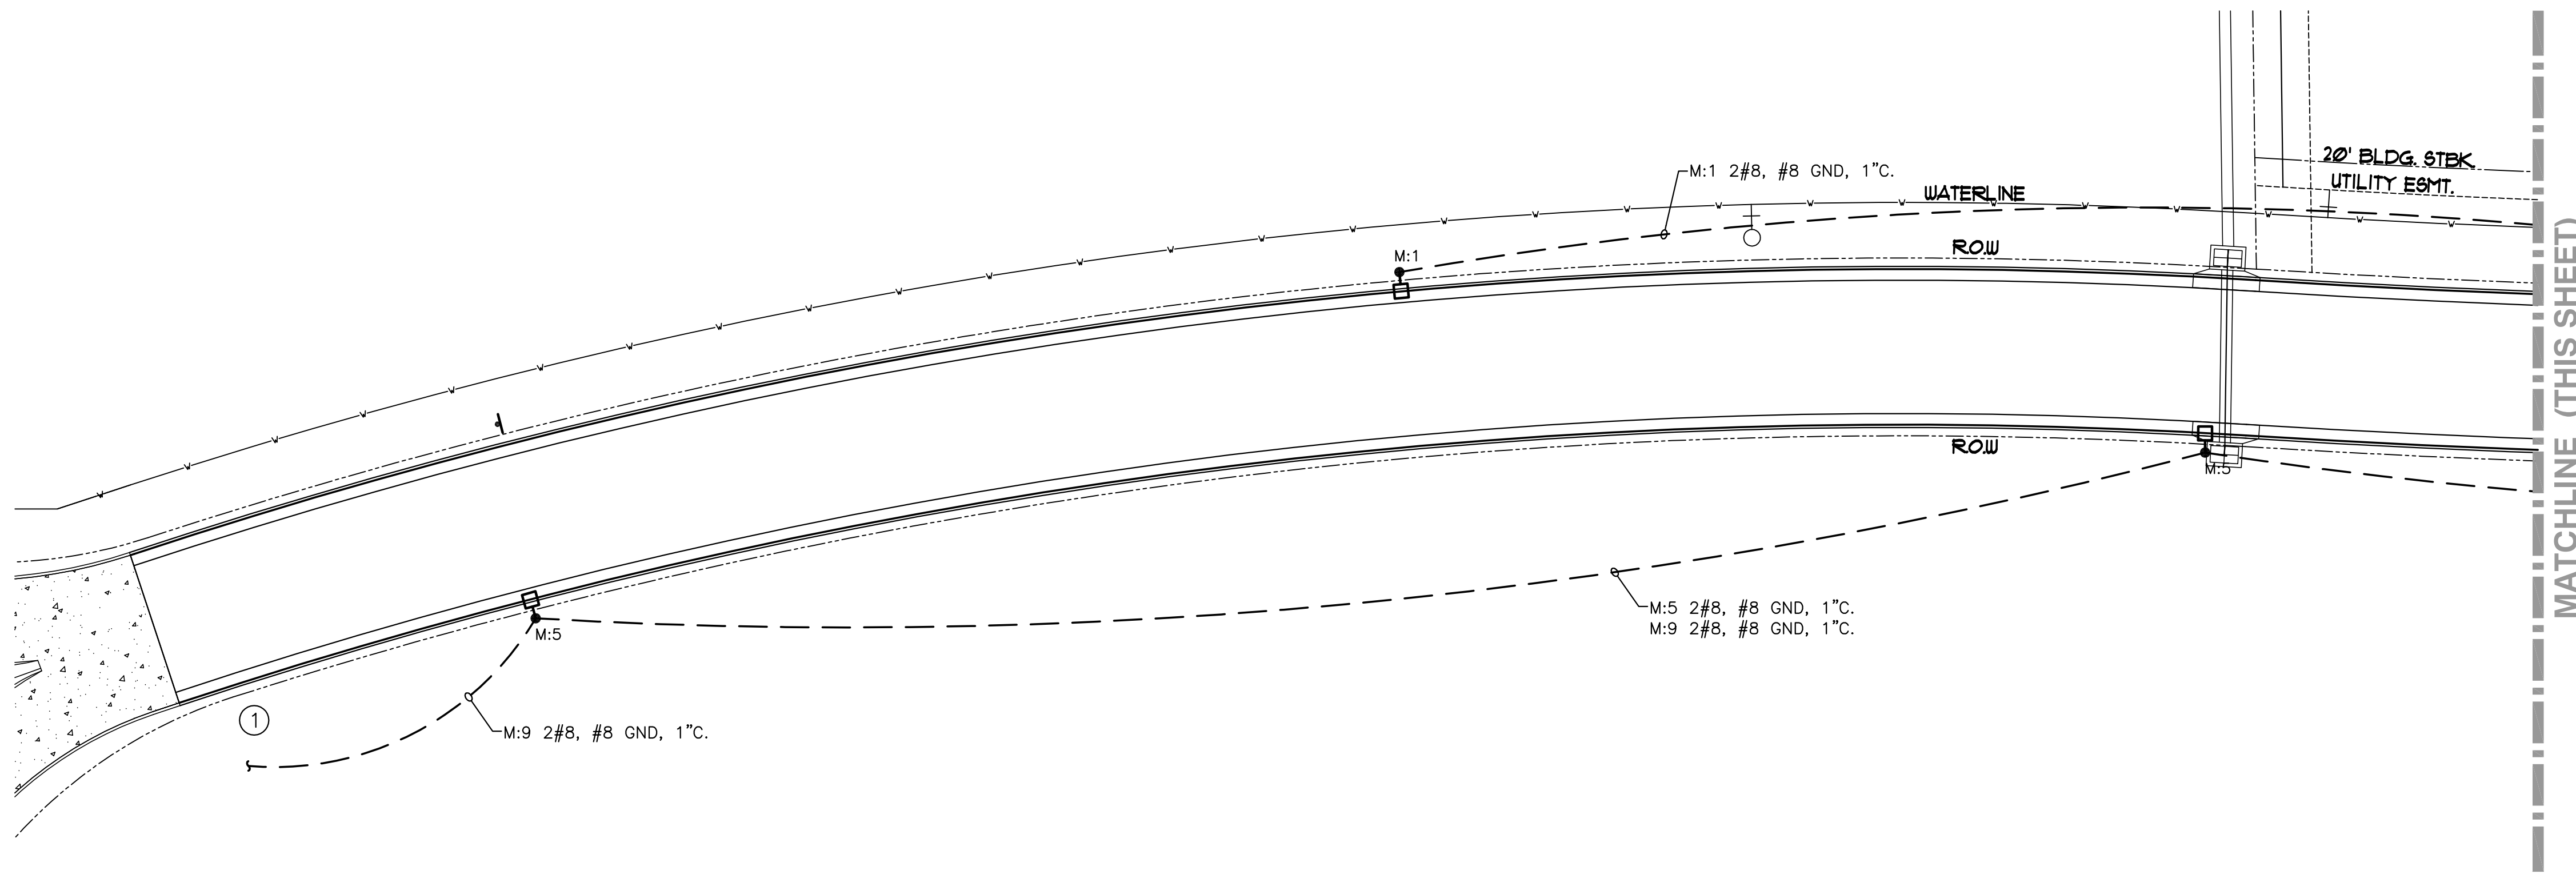

**ELECTRICAL PLAN**  
SCALE: 1" = 20'-0"

SCALE 1" = 20'-0"

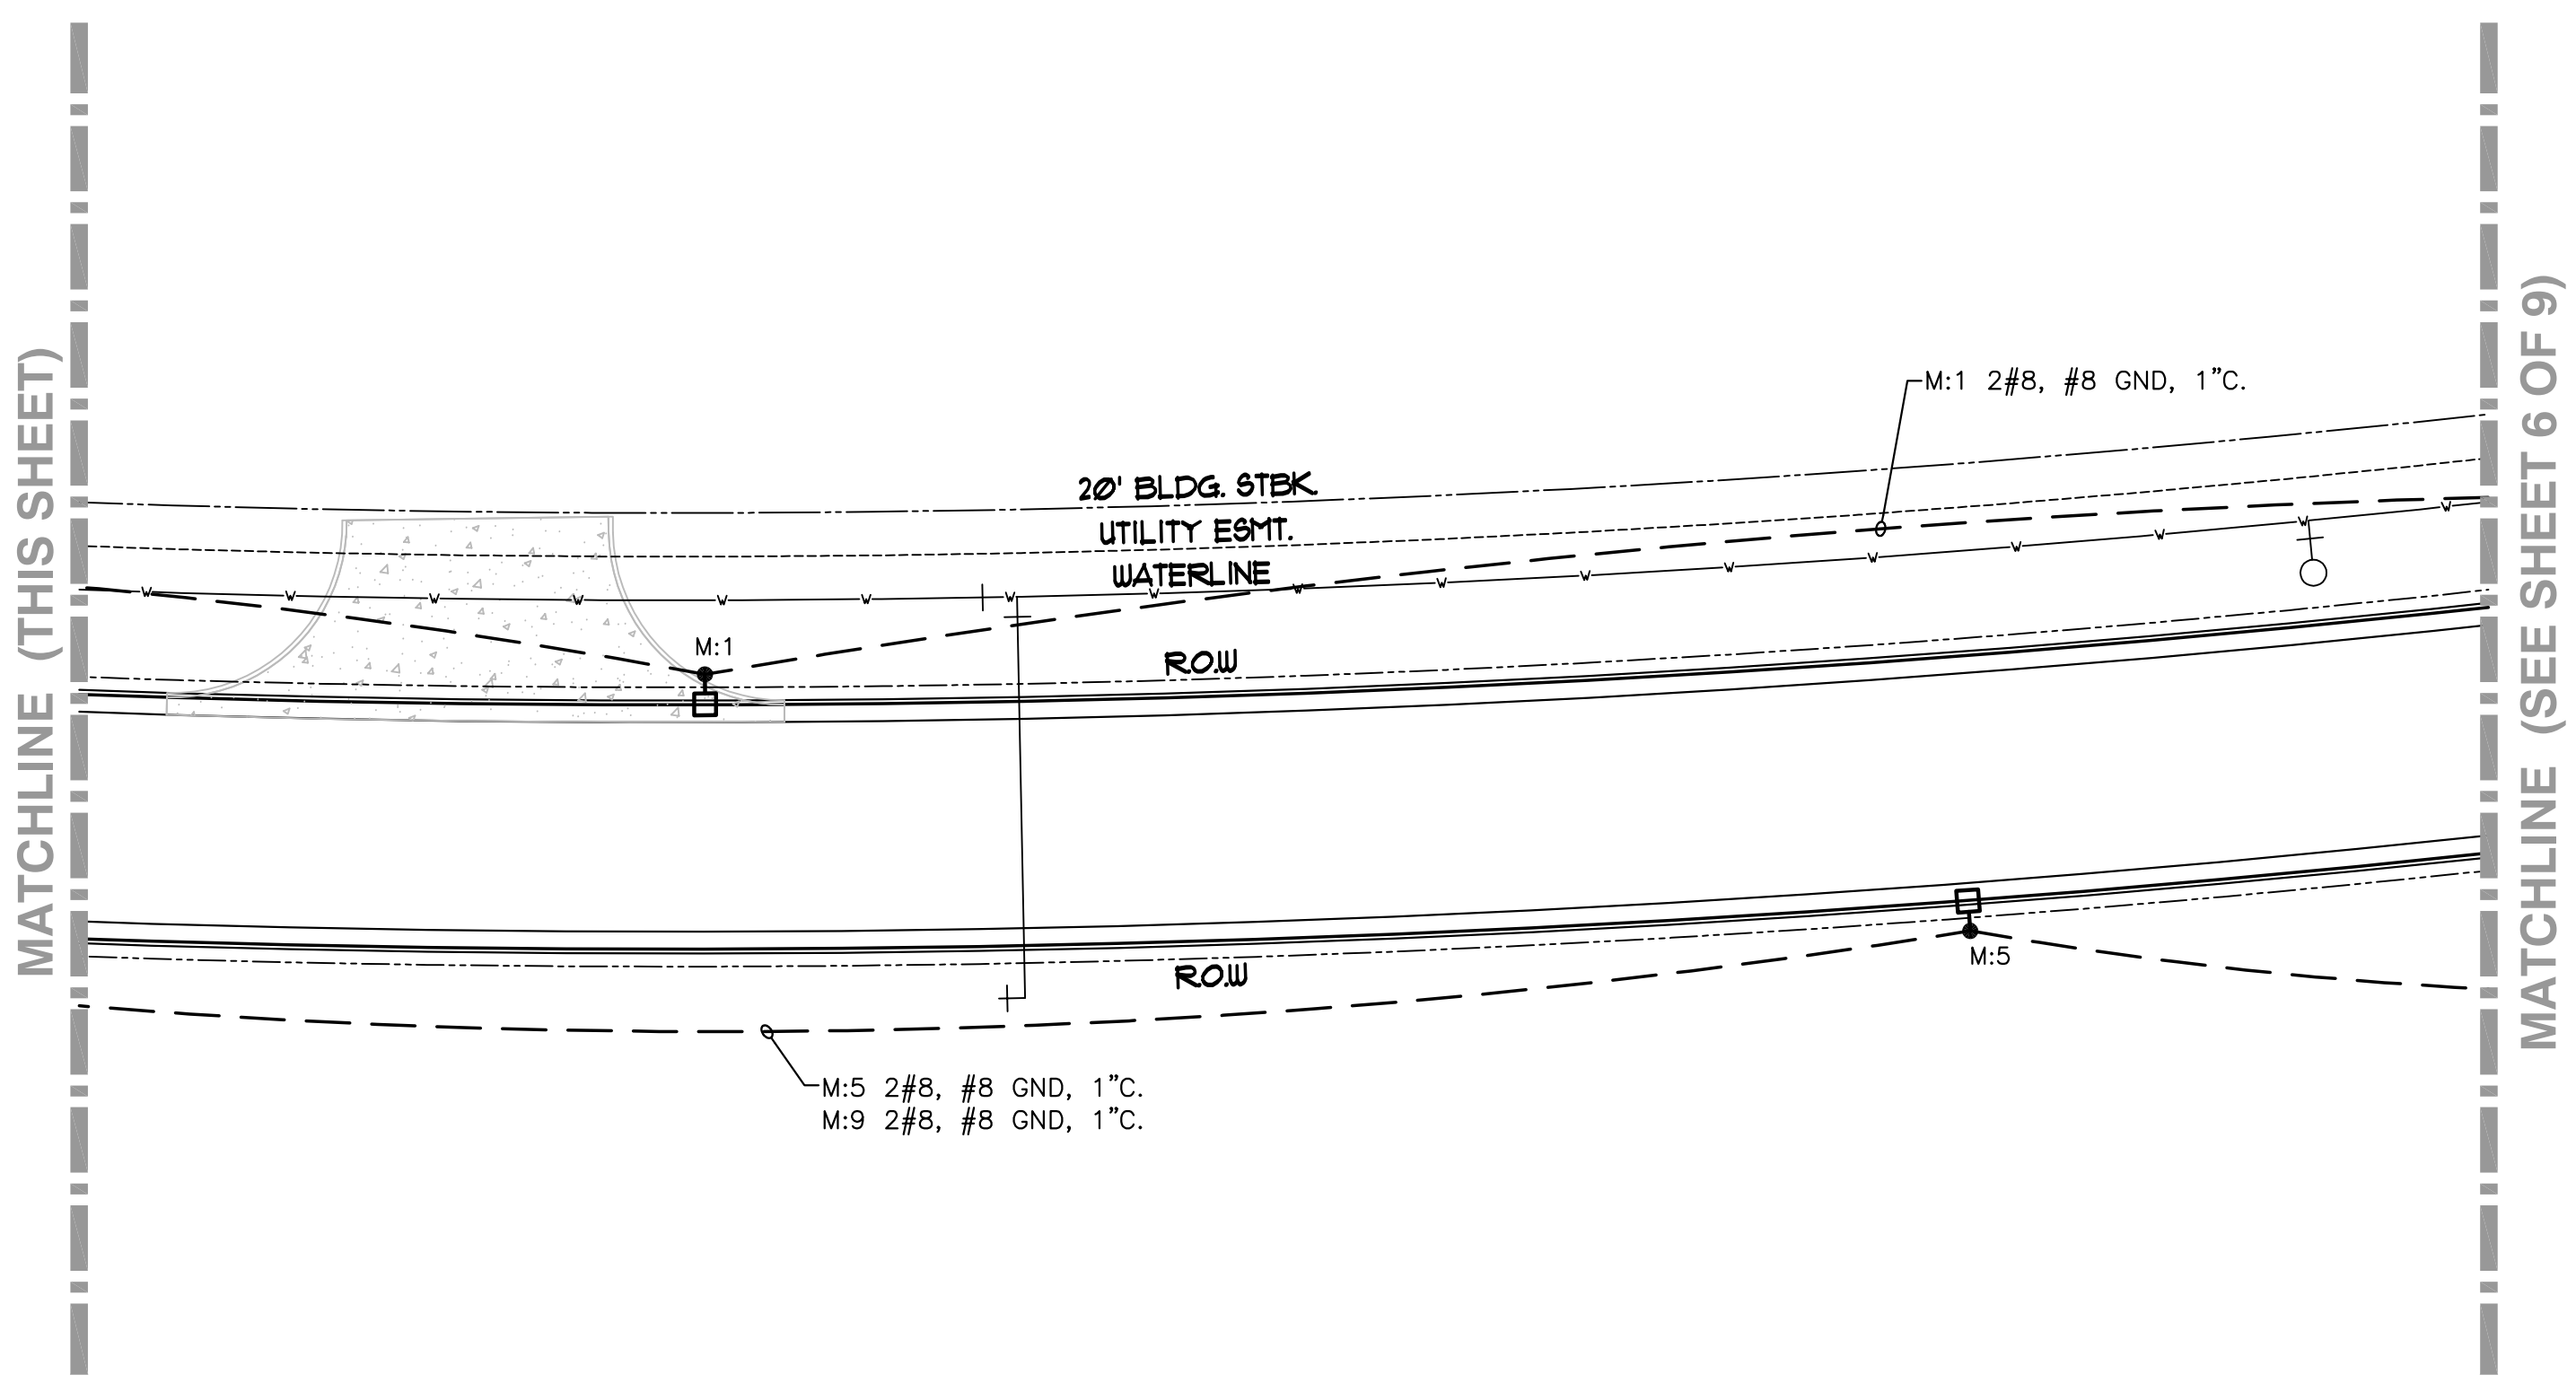

**ELECTRICAL PLAN**  
SCALE: 1" = 20'-0"

SCALE 1" = 20'-0"

- KEYED NOTES**
- CONTINUES ON TO SEPARATE PROJECT "GREENWICH OFFICE PARK SECOND".