



LANDSCAPE, LIGHTING, & IRRIGATION  
**BERKELEY SQUARE FIRST ADDITION**  
**HOME BANK & TRUST ADDITION**

**LIGHTING PLAN**

SHEET TITLE  
**472-85039**  
PROJECT NUMBER

MKEC / JJW / BWB  
DESIGNED DRAWN CHECKED

ISSUED  
**FEBRUARY 2012**


REVISED

SHEET NO.


**5 of 8**

**KEYED NOTES**

1. UTILITY COMPANY TRANSFORMER. DETERMINE AND MEET ALL UTILITY COMPANY REQUIREMENTS.
2. ELECTRICAL PEDESTAL PROVIDE POWER FROM PEDESTAL TO IRRIGATION CONTROLLER VIA UNDERGROUND CONDUIT. COORDINATE WITH IRRIGATION CONTRACTOR.
3. IRRIGATION CONTROLLER - APPROXIMATE LOCATION.
4. LIGHTING POINT CALCULATIONS ARE DEPENDANT ON LIGHTS ON ADJACENT PROJECT "GREENWICH OFFICE PARK SECOND".

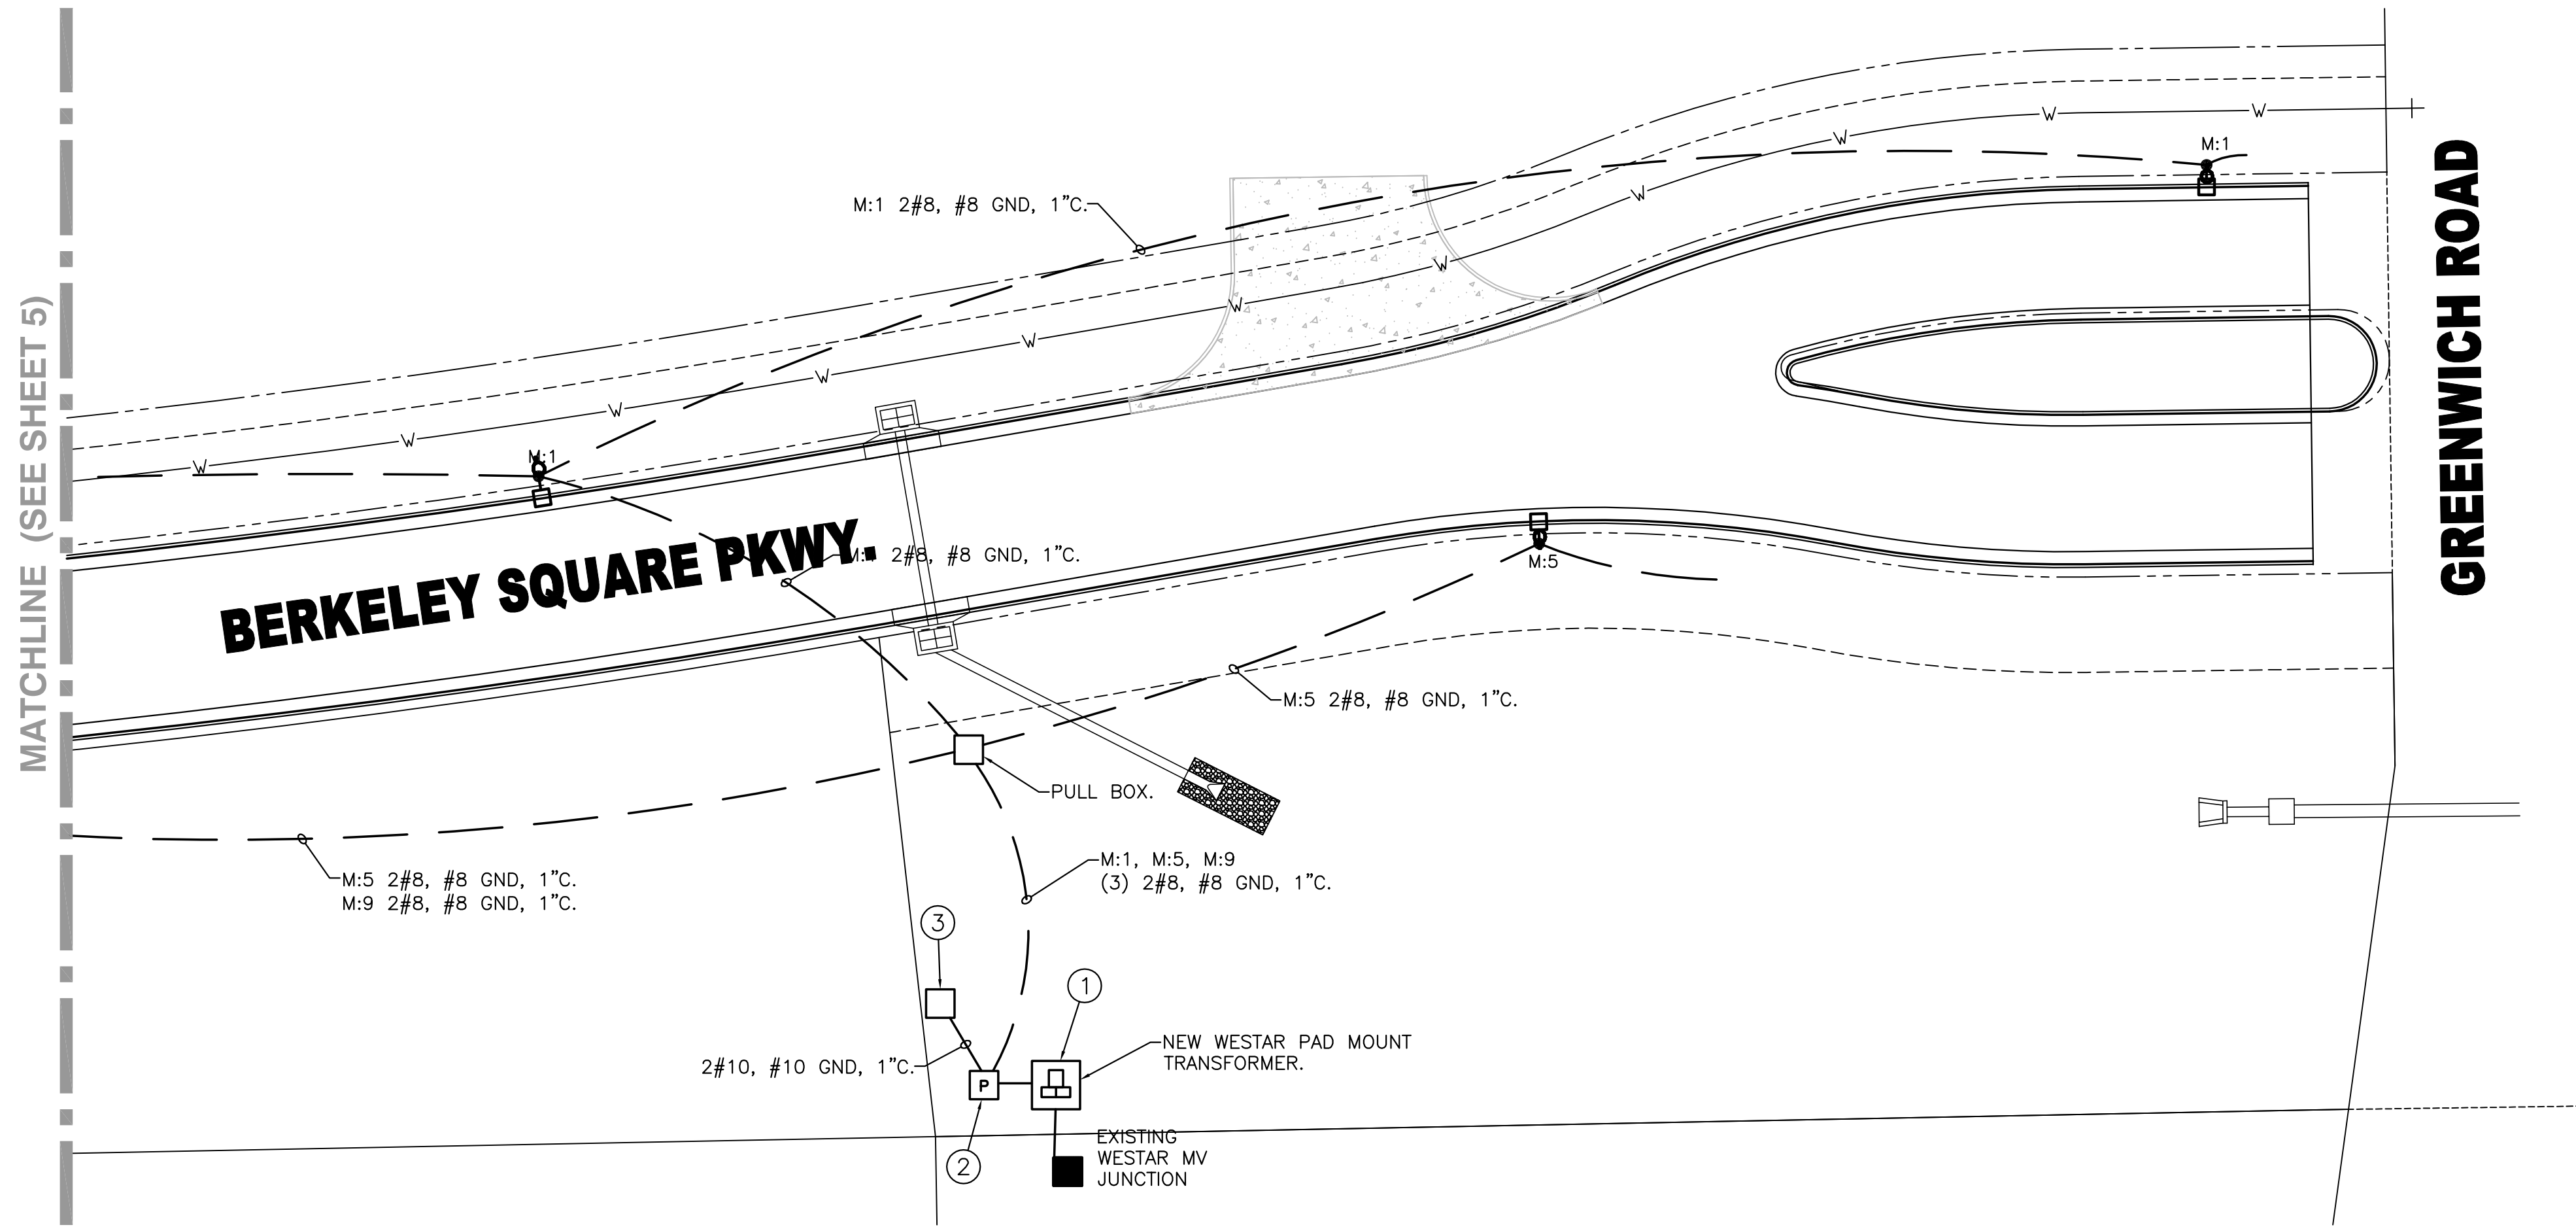

**ELECTRICAL PLAN**  
SCALE: 1" = 20'-0"

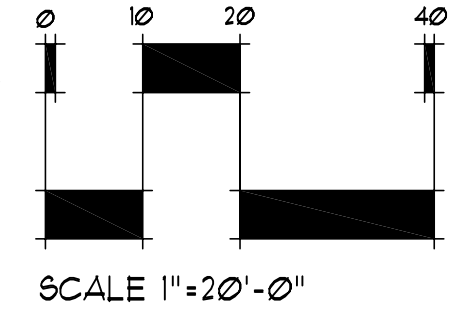

**PHOTOMETRIC PLAN**  
SCALE: 1" = 40'-0"