


WATER DISTRIBUTION SYSTEM IMPROVEMENTS

TO SERVE GLENVIEW

OCA NO. 735477
CITY OF WICHITA PROJECT NO. 448-90552

CITY OF WICHITA, KANSAS

GARY JANZEN, P.E. - INTERIM CITY ENGINEER

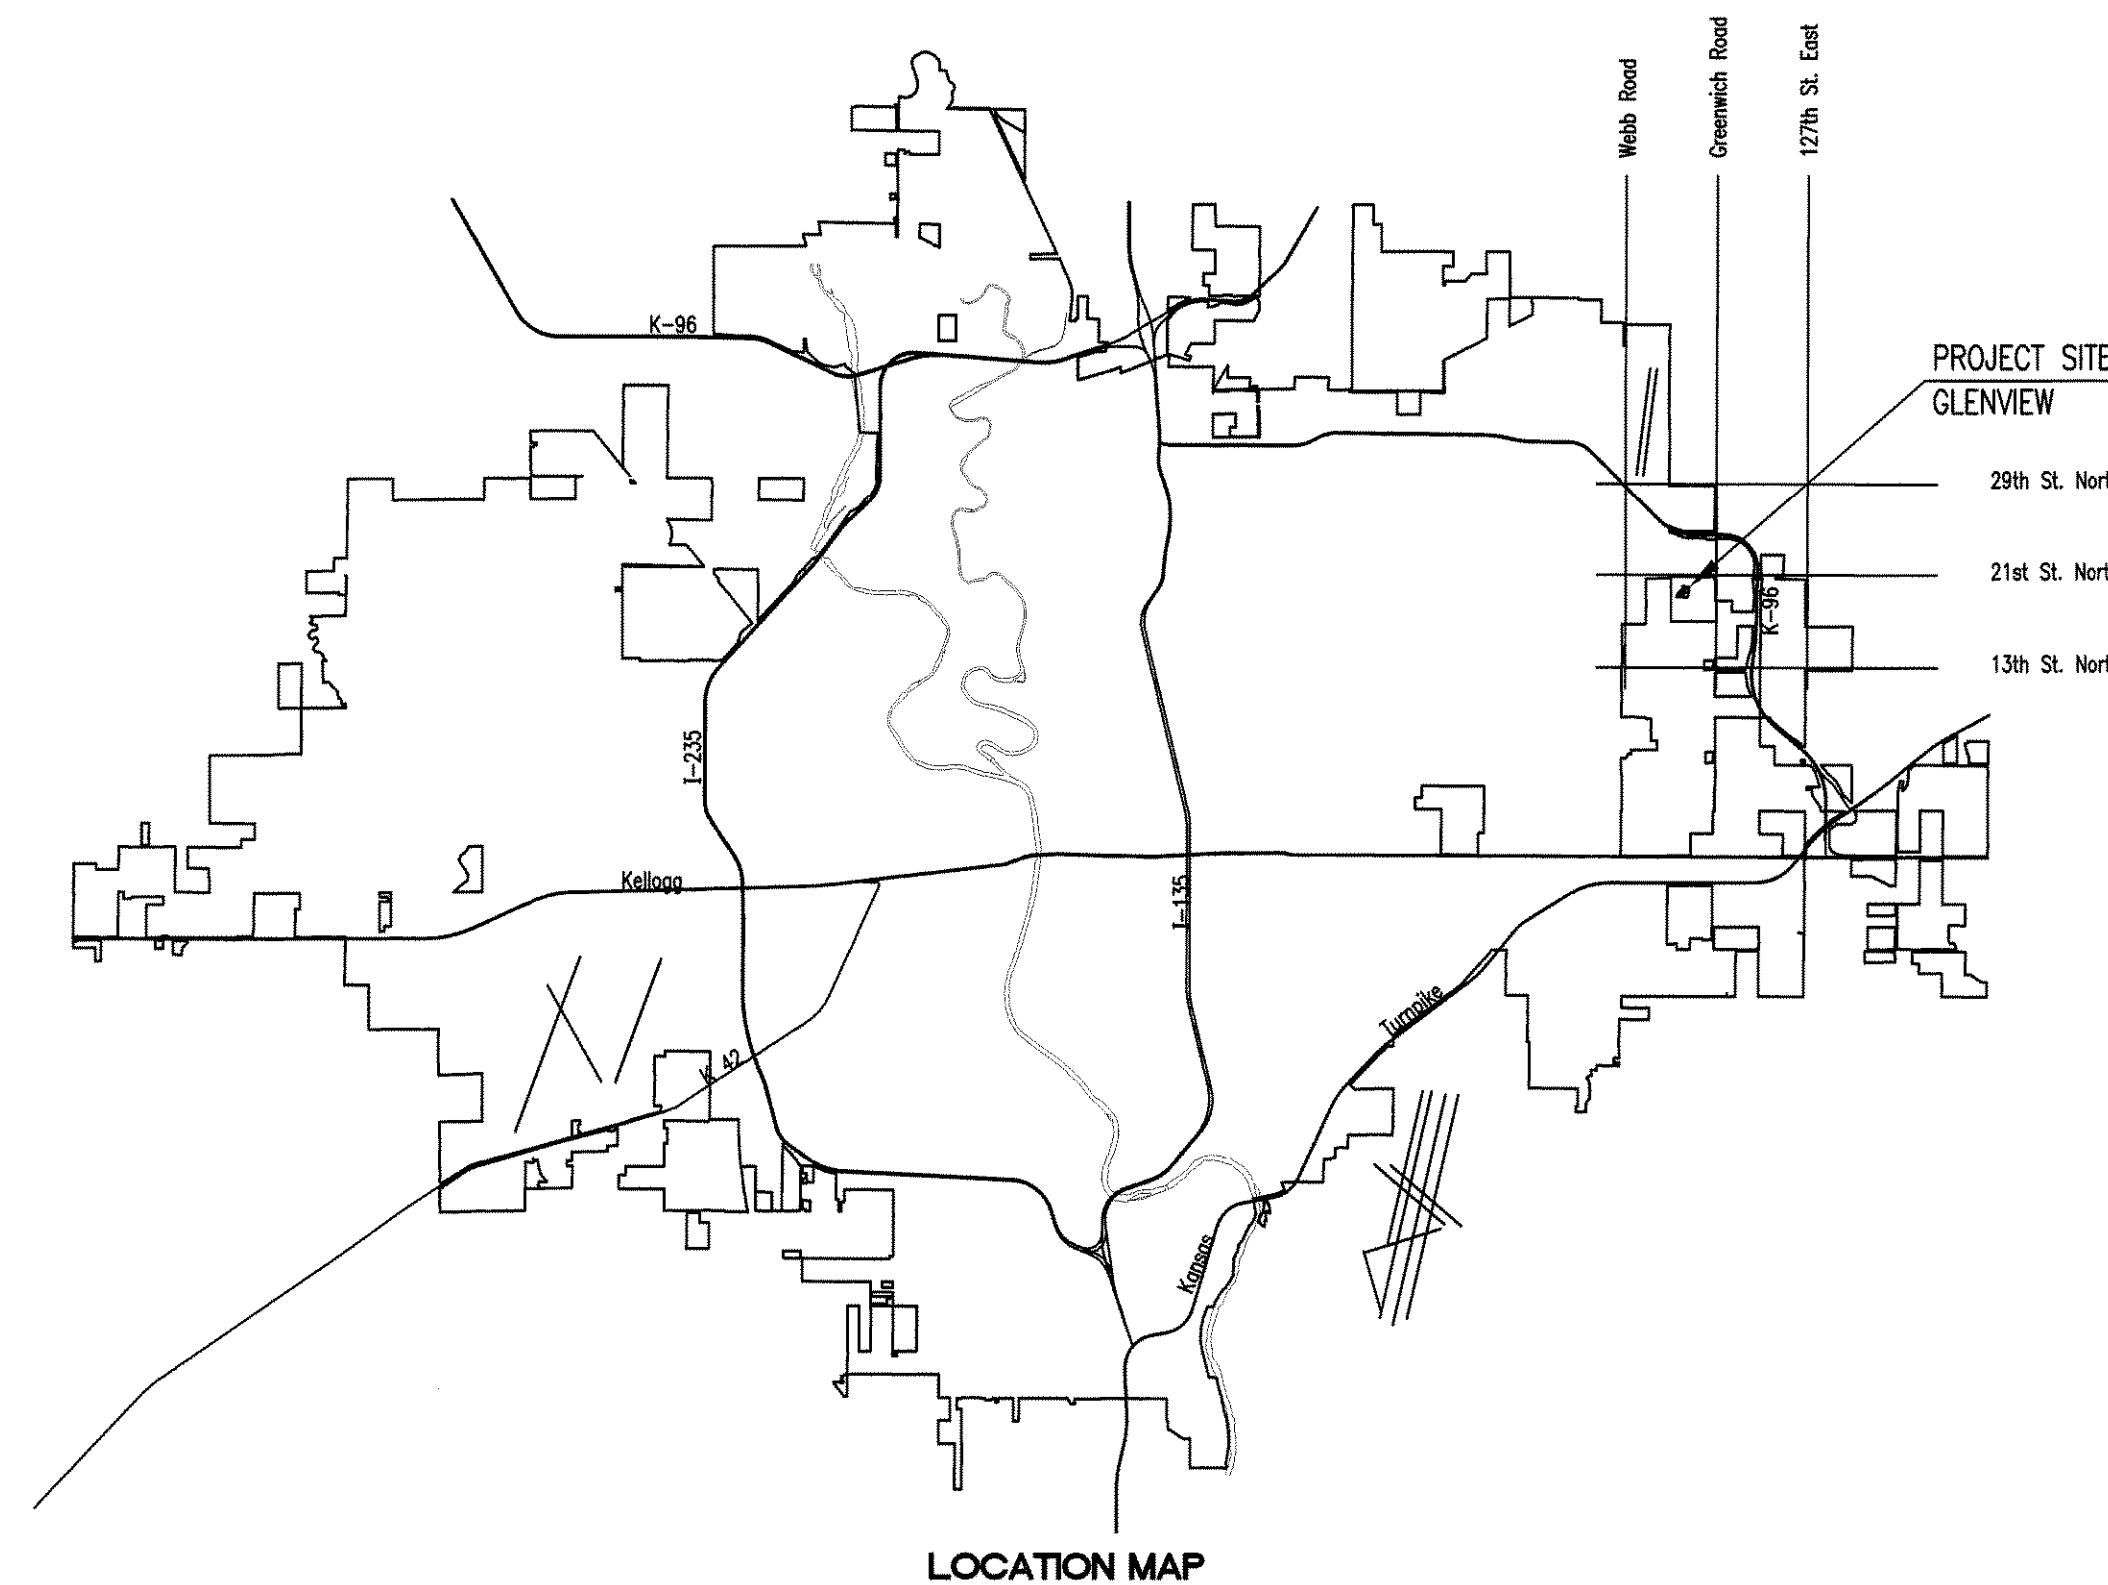

DEVELOPER CONTACT

MR. DAVID HAMBRICK
SLAWSON COMPANIES
727 N. WACO, SUITE 400
WICHITA, KANSAS 67203
(316) 263-3201

INDEX OF SHEETS

SHEET NO. 1	TITLE SHEET
SHEET NO. 2	KEY MAP AND GENERAL NOTES
SHEET NO. 3	STANDARD WATER ASSEMBLY DETAILS
SHEET NO. 4-5	PLAN/PROFILE
SHEET NO. 6	PLAT
SHEET NO. 7	EROSION CONTROL PLAN
SHEET NO. 8-11	EROSION CONTROL DETAILS

CONSTRUCTION SCHEDULE/COORDINATION

THE CONTRACTOR(S) FOR THE FOLLOWING PROJECTS SHALL COORDINATE THEIR EFFORTS SUCH THAT ANY NECESSARY SIMULTANEOUS CONSTRUCTION (INCLUDING PRIVATE PAVING IMPROVEMENTS) CAN PROCEED CONCURRENTLY WITHOUT CAUSING UNDUE DELAYS SO THAT CONSTRUCTION CAN BE COMPLETED WITHIN THE TIME FRAME AS NOTED. THE CONTRACTOR(S) SHALL COMPLETE THE FOLLOWING PUBLIC IMPROVEMENTS PROJECTS BY SEPTEMBER 10, 2012 UNLESS OTHERWISE INDICATED IN THE PROJECT SPECIAL PROVISIONS.

- 468-84818 LATERAL 13, MAIN 16 of the FOUR MILE CREEK SEWER
- 448-90552 WATER DISTRIBUTION SYSTEM
- 468-84819 STORM WATER DRAIN #663

JUNE 2012

PLANS PREPARED BY
PROFESSIONAL ENGINEERING CONSULTANTS, P.A.
ENGINEERS
WICHITA, KANSAS

