

**LEGEND**

PP	UTILITY POLE
LP	LIGHT POLE
DM	DEAD MAN
WM	WATER METER
WV	WATER VALVE
GV	GAS VALVE
SS MH	SANITARY SEWER MANHOLE
SWS MH	STORM SEWER MANHOLE

**FIRE HYDRANTS REQUIRED**


STATION	BURY LINE ELEVATION	TOP OF PIPE ELEVATION	FIRE HYDRANT BURY REQUIRED*
WL NO. 1, STA. 34+64.77	107.00	103.12	4.5'

(FOR FIRE HYDRANT ASSEMBLY, SEE DETAIL, SHEET 27)

- NOTES:**
- UNLESS OTHERWISE INDICATED, DIMENSIONS ARE MEASURED TO CENTERLINE OF FITTINGS IN PLAN VIEW AND TOP OF PIPE IN PROFILE VIEW.
  - WL NO. 1 BASELINE = CENTERLINE OF MCCORMICK AVENUE RIGHT-OF-WAY.
  - REFER TO SHEET 2, NOTE NO. 8, FOR DIRECTIONAL DRILLING REQUIREMENTS.

**AS-BUILT**  
WATER LINE NO. 1

REMOVE & REPLACE CONCRETE PAVEMENT IN KIND, THIS SHEET = 585 LF

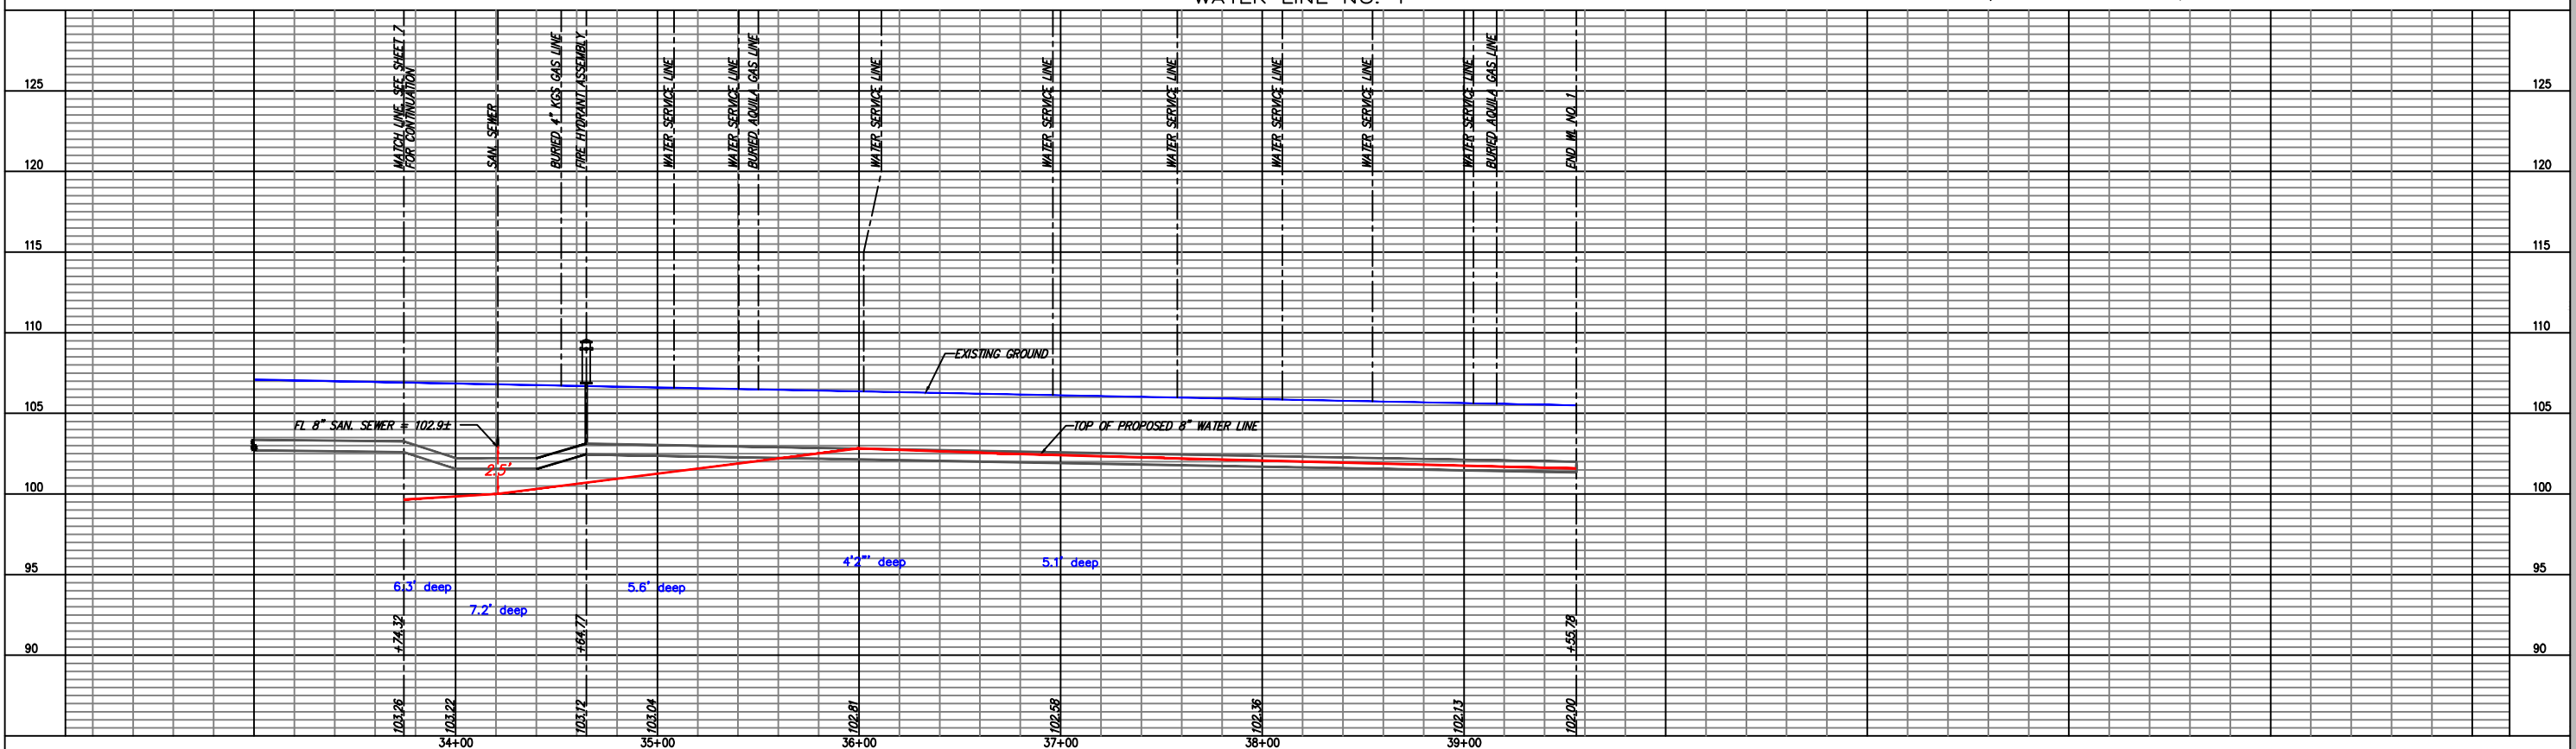

**YOUNG & ASSOCIATES, P.A.**  
Civil and Environmental Engineers  
100 S. Georgia, Derby, KS 67037  
tele: (316) 788-2552 fax: (316) 788-4408 email: young@yemah.com

Copyright 2006, by Young & Associates, P.A., all rights reserved. Prepared in the United States of America. This drawing is the property of Young & Associates, P.A. and may not be reproduced in any form without the specific written permission of Young & Associates, P.A. The accuracy of the information shown on this drawing is the responsibility of the engineer of record and does not constitute a warranty.

**WATER LINE NO. 1  
PLAN AND PROFILE**

McCormicks Water Main Replacement

City of Wichita, Sedgwick County, Kansas

PROJECT NO.: 06-228  
DATE: 2-15-07  
DRAWN: DMS  
DESIGNED: DAS  
CHECKED: GRY  
APPROVED:

REVISIONS

NO.	DATE	BY	APP.	COMMENTS

SHEET  
8  
of 37